


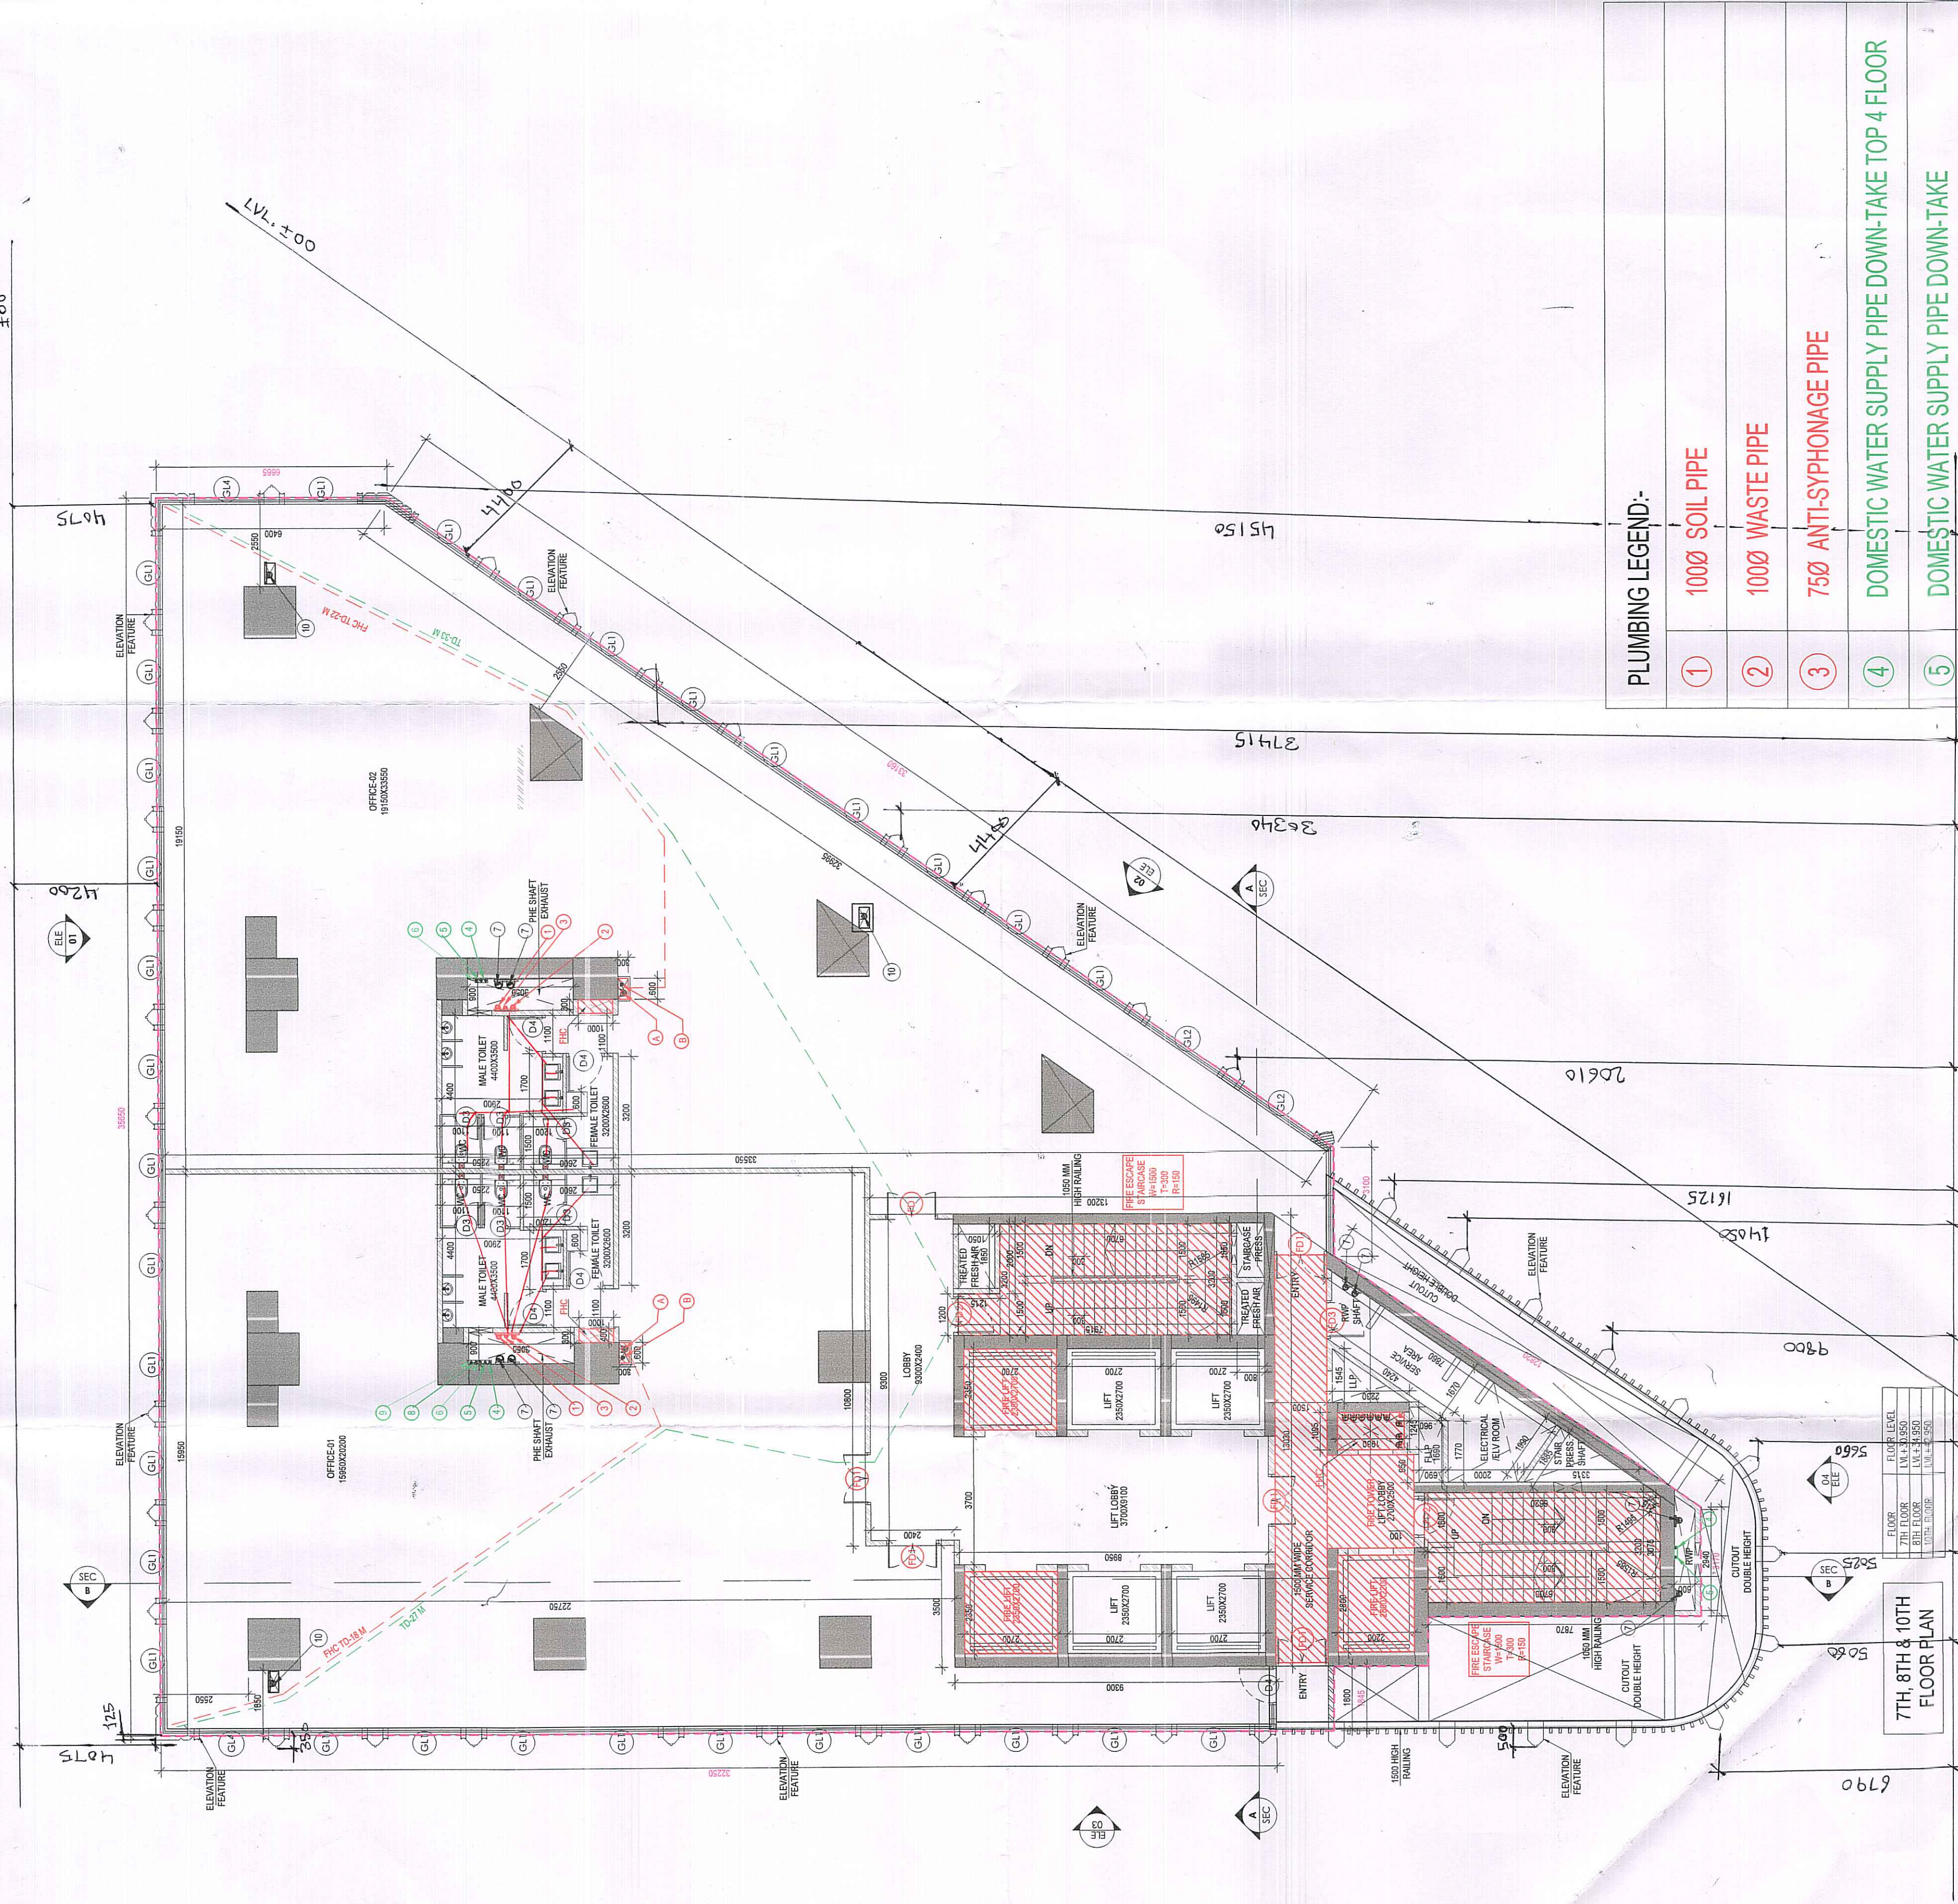

PLUMBING LEGEND:-	
1	1000 SOIL PIPE
2	1000 WASTE PIPE
3	750 ANTI-SYPHONAGE PIPE
4	DOMESTIC WATER SUPPLY PIPE DOWN-TAKE TOP 4 FLOOR
5	DOMESTIC WATER SUPPLY PIPE DOWN-TAKE
6	FLUSHING WATER SUPPLY PIPE DOWN-TAKE
7	1500 RAIN WATER PIPE
8	DOMESTIC WATER SUPPLY RISER
9	FLUSHING WATER SUPPLY RISER
10	1500 RAIN WATER PIPE FOR BALCONY
COP CLEAN OUT PLUG	
FT	FLOOR TRAP WITH (1500 SLEEVE OR 150X150MM CUTOUT)
FD	FLOOR DRAIN WITH (1250 SLEEVE OR 125X125MM CUTOUT)
WC	WC DROP WITH (1500 SLEEVE OR 150X150MM CUTOUT)

S.No.	FIRE FIGHTING LEGEND:-
A	1500 M.S FIRE UPRANT RISER
B	800 M.S DRAIN PIPE
C	1500 M.S SPRINKLER RISER
Ca	1500 M.S SPRINKLER RISER
FHC	FIRE HOSE CABINET

REQUIRED STAIRCASE WIDTH 7TH, 8TH, 10TH LEVEL CALCULATION:-
(OFFICE 814.90 SQM 1 Person/10)=81 persons
(CIRCULATION SPACE , TOILET , LOBBY 213.71 250M 1 Person/10)=21 persons
TOTAL= 102 persons
Required staircase width @ 10mm/person for 102 persons =1020 mm i.e. MINIMUM 1250 MM.
PROVIDED STAIRCASE WIDTH = 1500+1500 =3000MM

DOORS	
Door	Description
1	1500
2	1500
3	1500
100	1500

AREA CALCULATION OF 7TH, 8TH & 10TH FLOOR	
Sl. No.	Area (Sq. M)
1	1000
2	1000
3	1000
100	1000

Note:-
ALL FLOOR MECHANICAL VENTILATED LIGHTED & 100% POWER BACKUP PROVIDED TO POWER BACKUP IS BEING PROVIDED. TOILET ARE MECHANICAL VENTILATED. ALL LIFTS SHALL HAVE POWER BACK-UP. ALL ELECTRICAL INSTALLATION SHALL BE AS PER PROVISION OF RELEVANT CODE. FIRE FIGHTING SAFETY PROVISIONS WILL BE AS PER RELEVANT CODE PROVISIONS. BASEMENT AREA SHALL HAVE MECHANICALLY VENTILATED AS PER RELEVANT CODE. ALL TOILETS ARE VENTILATED AS PER HARYANA BUILDING CODE 2017. BUILDINGS HAS AUTOMATIC SPRINKLER SYSTEM WHEREVER REQUIRED BY RELEVANT CODE. BUILDINGS HAS AUTOMATIC FIRE RESISTANT STRUCTURES AS PER RELEVANT IS CODES FOR EARTHQUAKE RESISTANCE. SOLAR PANELS OF REQUIRED CAPACITY SHALL BE PROVIDED AS PER HARE DAZONING NORMS. ALL HANDICAP RAMPS WITH RAILING. ALL FIRE FIGHTING INSTALLATIONS SHALL BE AS PER PROVISION OF RELEVANT CODE. THE RAINWATER HARVESTING SYSTEM SHALL BE PROVIDED AS PER CENTRAL GROUND WATER AUTHORITY NORMS.

PROJECT:
PROPOSED BUILDING PLAN OF COMMERCIAL COMPLEX SITE AREA 1.98 ACRES
4943.0 SQM IN SECTOR 28, GURUGRAM

OWNER'S
ACQUISITIVE INFRADEVELOPERS PVT. LTD.
WITH LODHA DEVELOPERS LIMITED

OWNER'S SEAL & SIGNATURE
OWNER'S SEAL
OWNER'S SIGNATURE

ARCHITECT'S SEAL & SIGNATURE
ARCHITECT'S SEAL
ARCHITECT'S SIGNATURE

MAY - 2026
Scale : 1:100
Drawing No:-
Drawing Title:-
TOWER 01
7TH, 8TH & 10TH FLOOR PLAN
AREA CALCULATION
1:100