



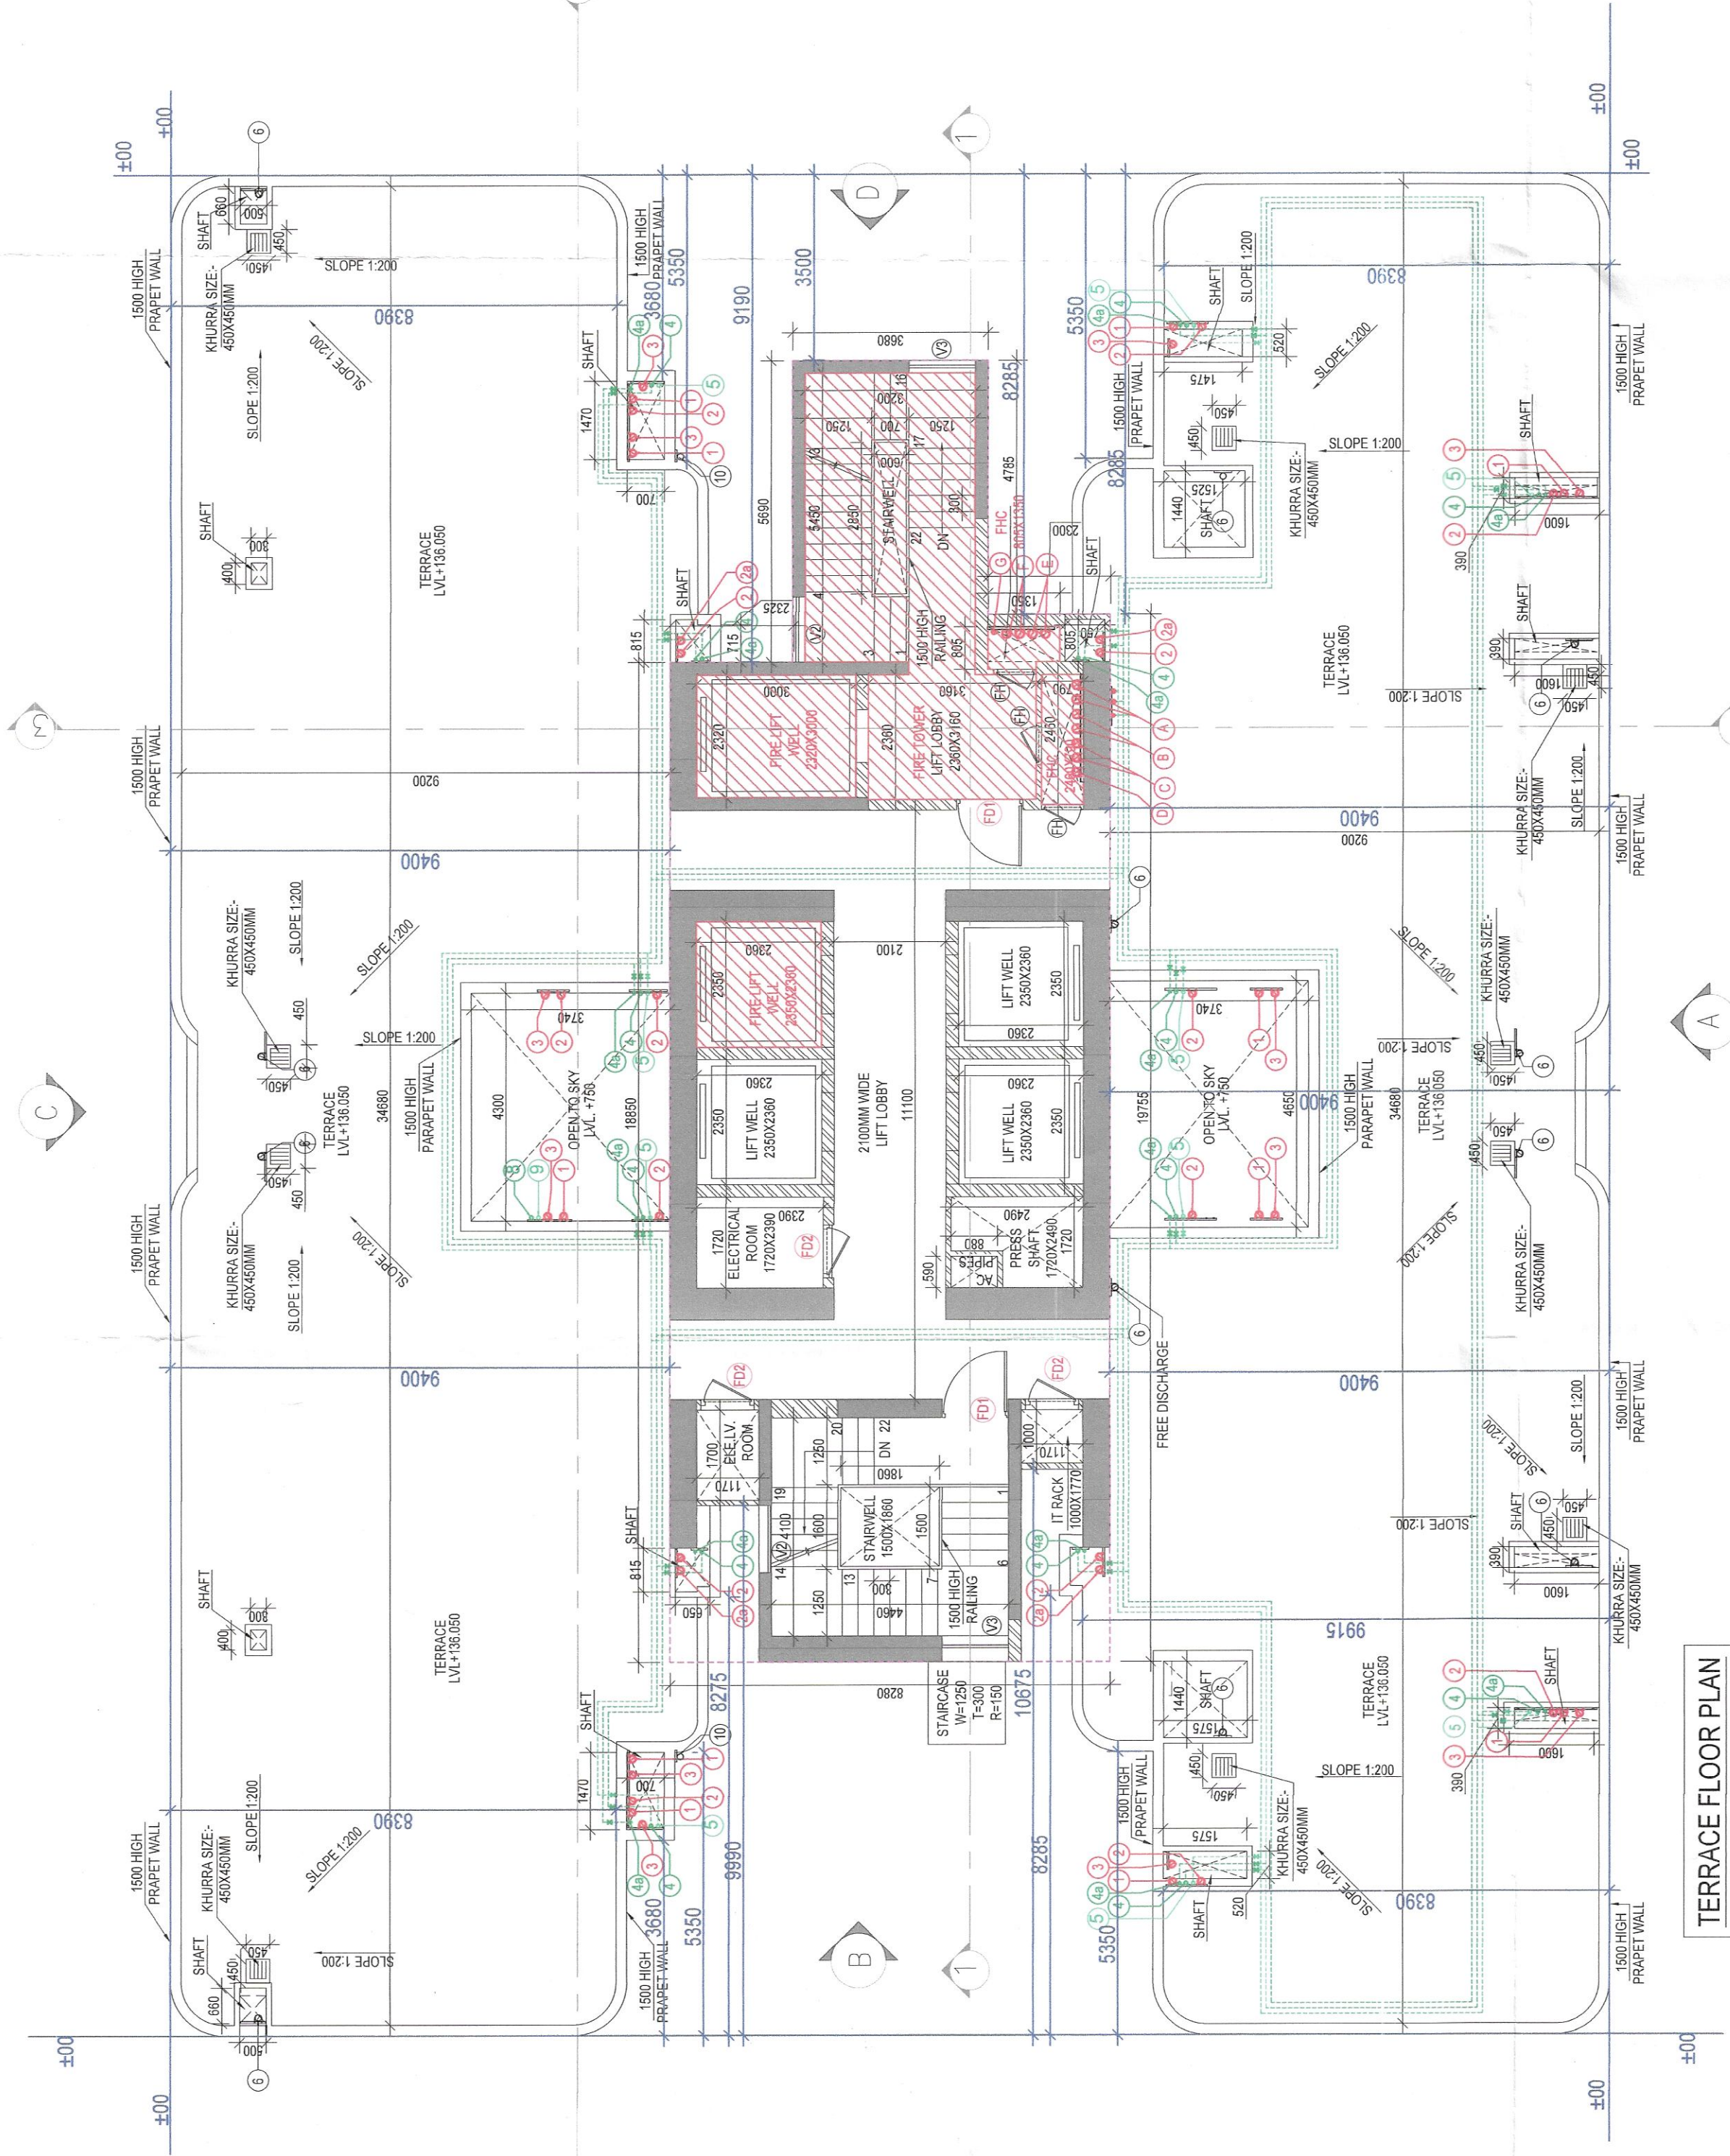


TERRACE FLOOR PLAN
LV=135.000
TOWER -1


COLUMN		DOOR		WINDOW		OPENING		STAIRCASE	
1	1.1	1.1	1.1	1.1	1.1	1.1	1.1	1.1	1.1
2	2.1	2.1	2.1	2.1	2.1	2.1	2.1	2.1	2.1
3	3.1	3.1	3.1	3.1	3.1	3.1	3.1	3.1	3.1
100	100.1	100.1	100.1	100.1	100.1	100.1	100.1	100.1	100.1

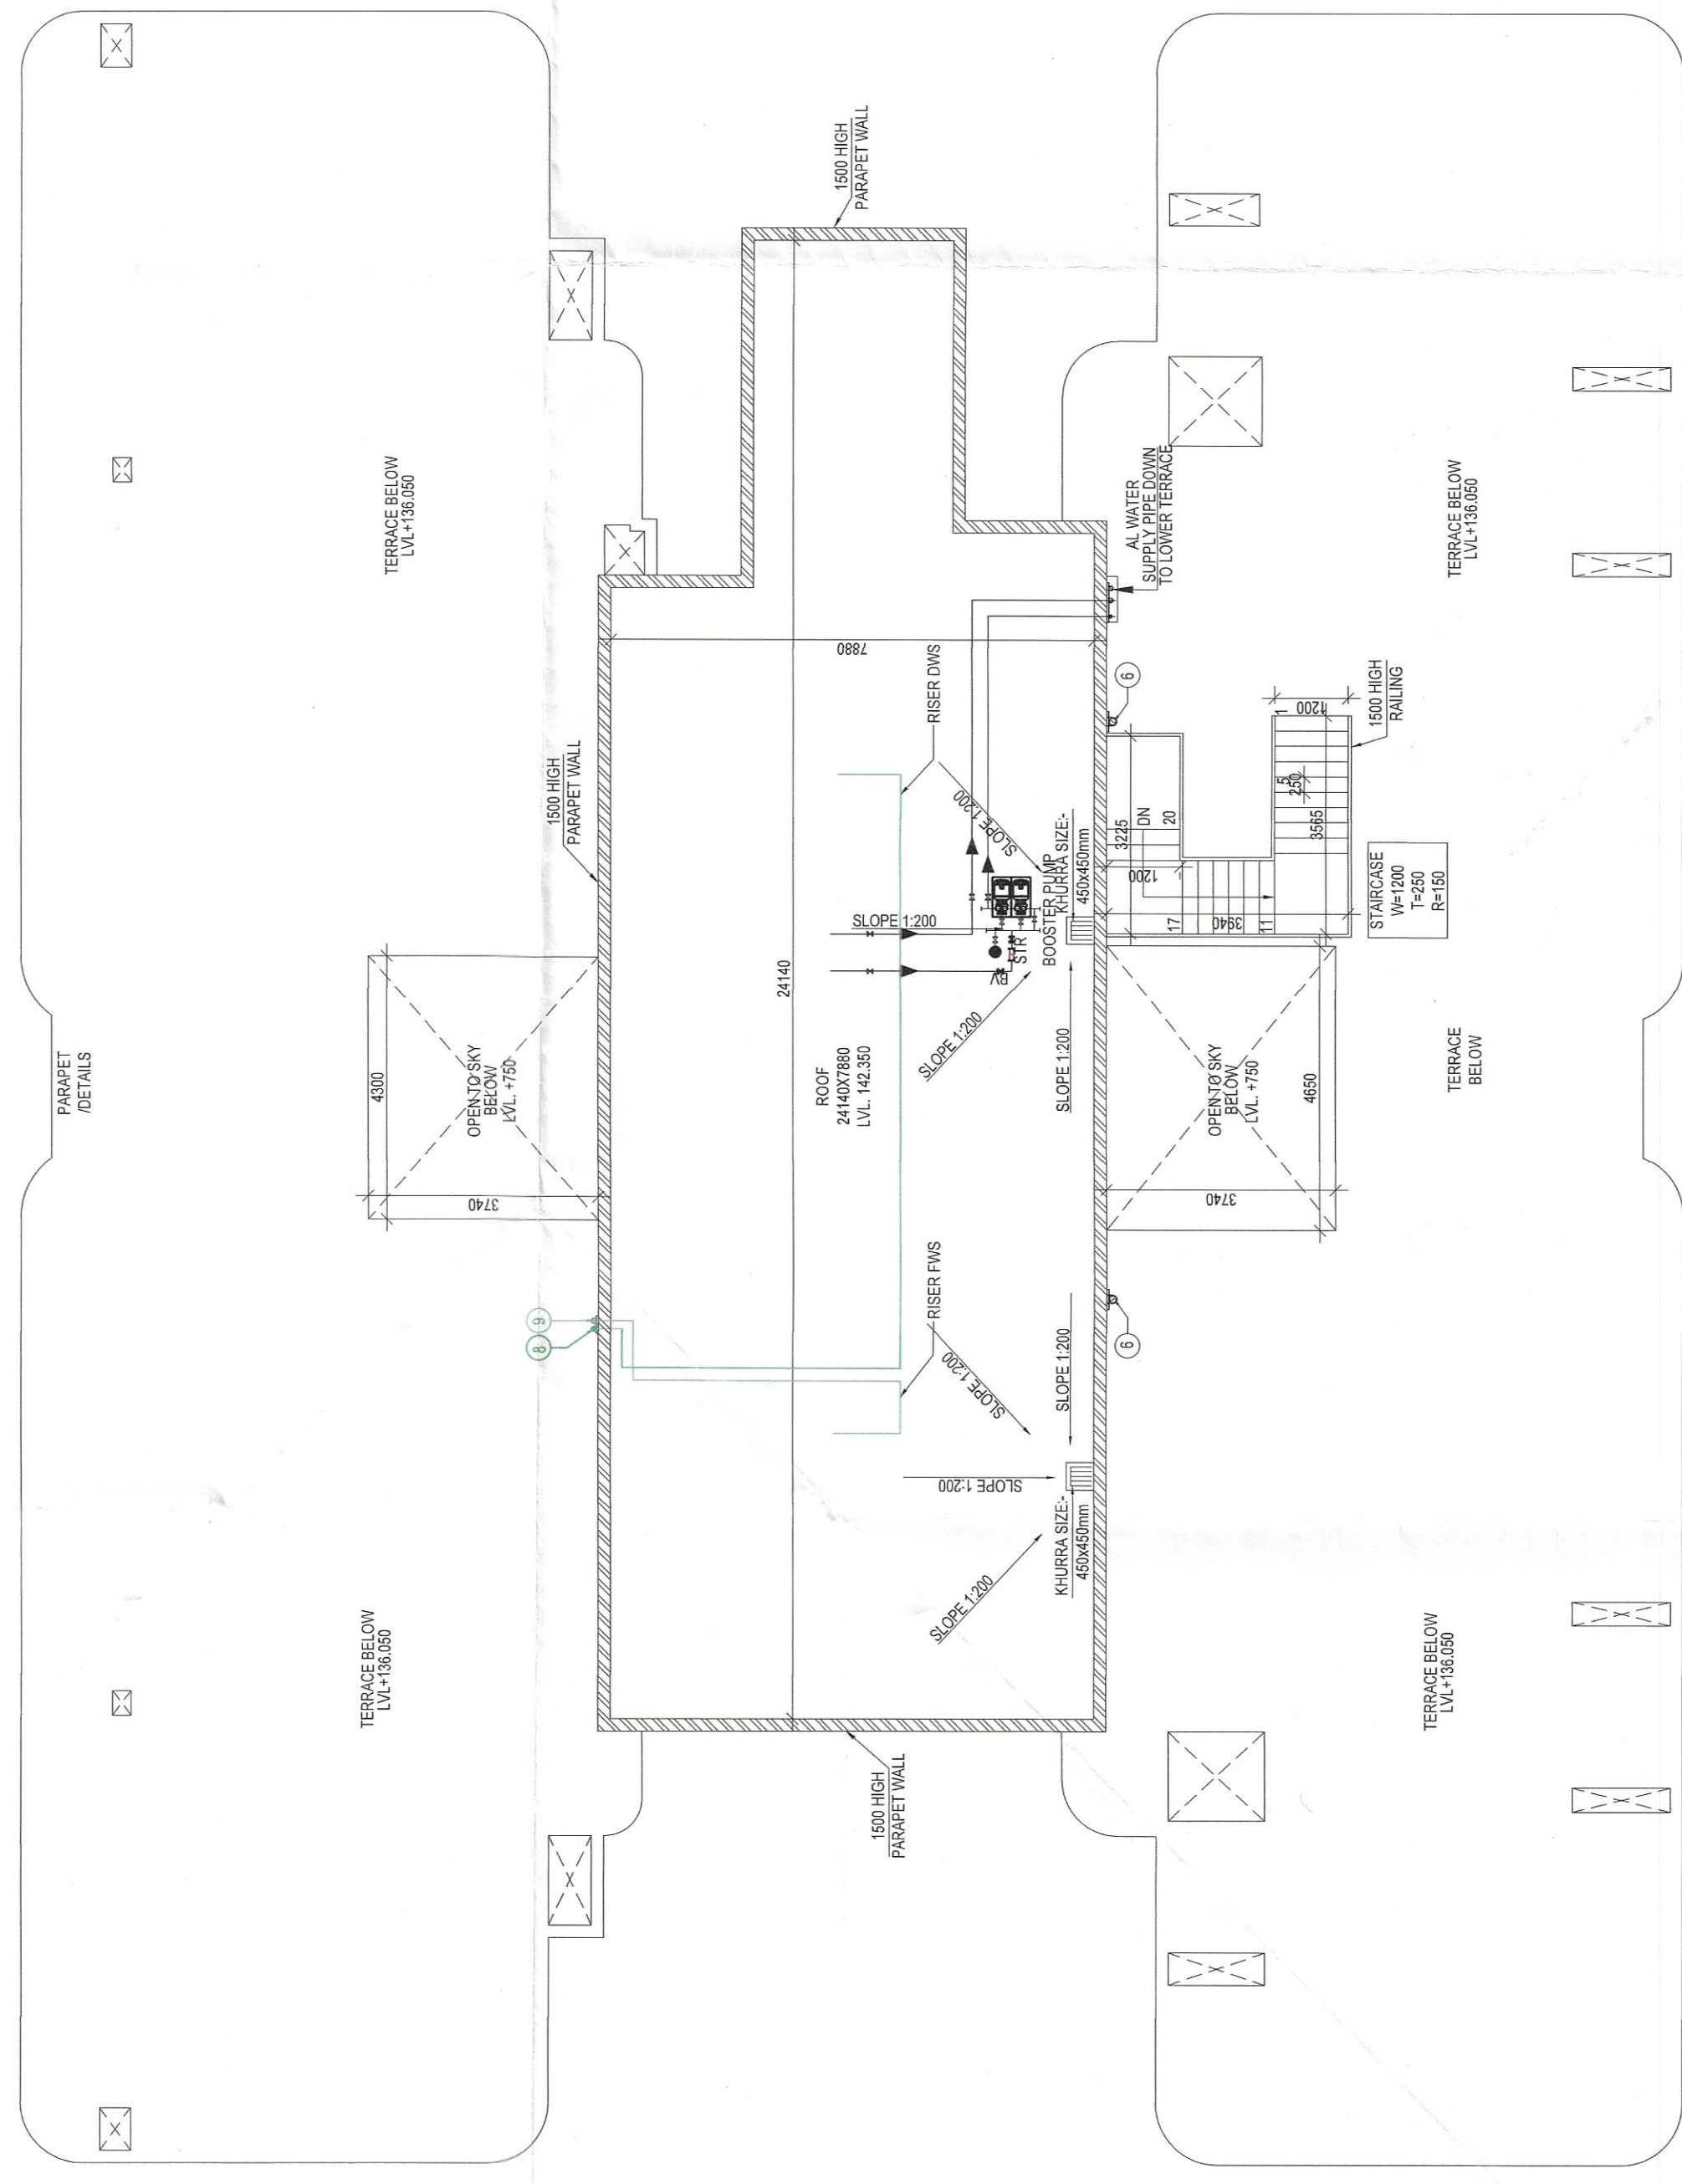

MACHINE ROOM
TERRACE PLAN
LV=142.350
TOWER -1

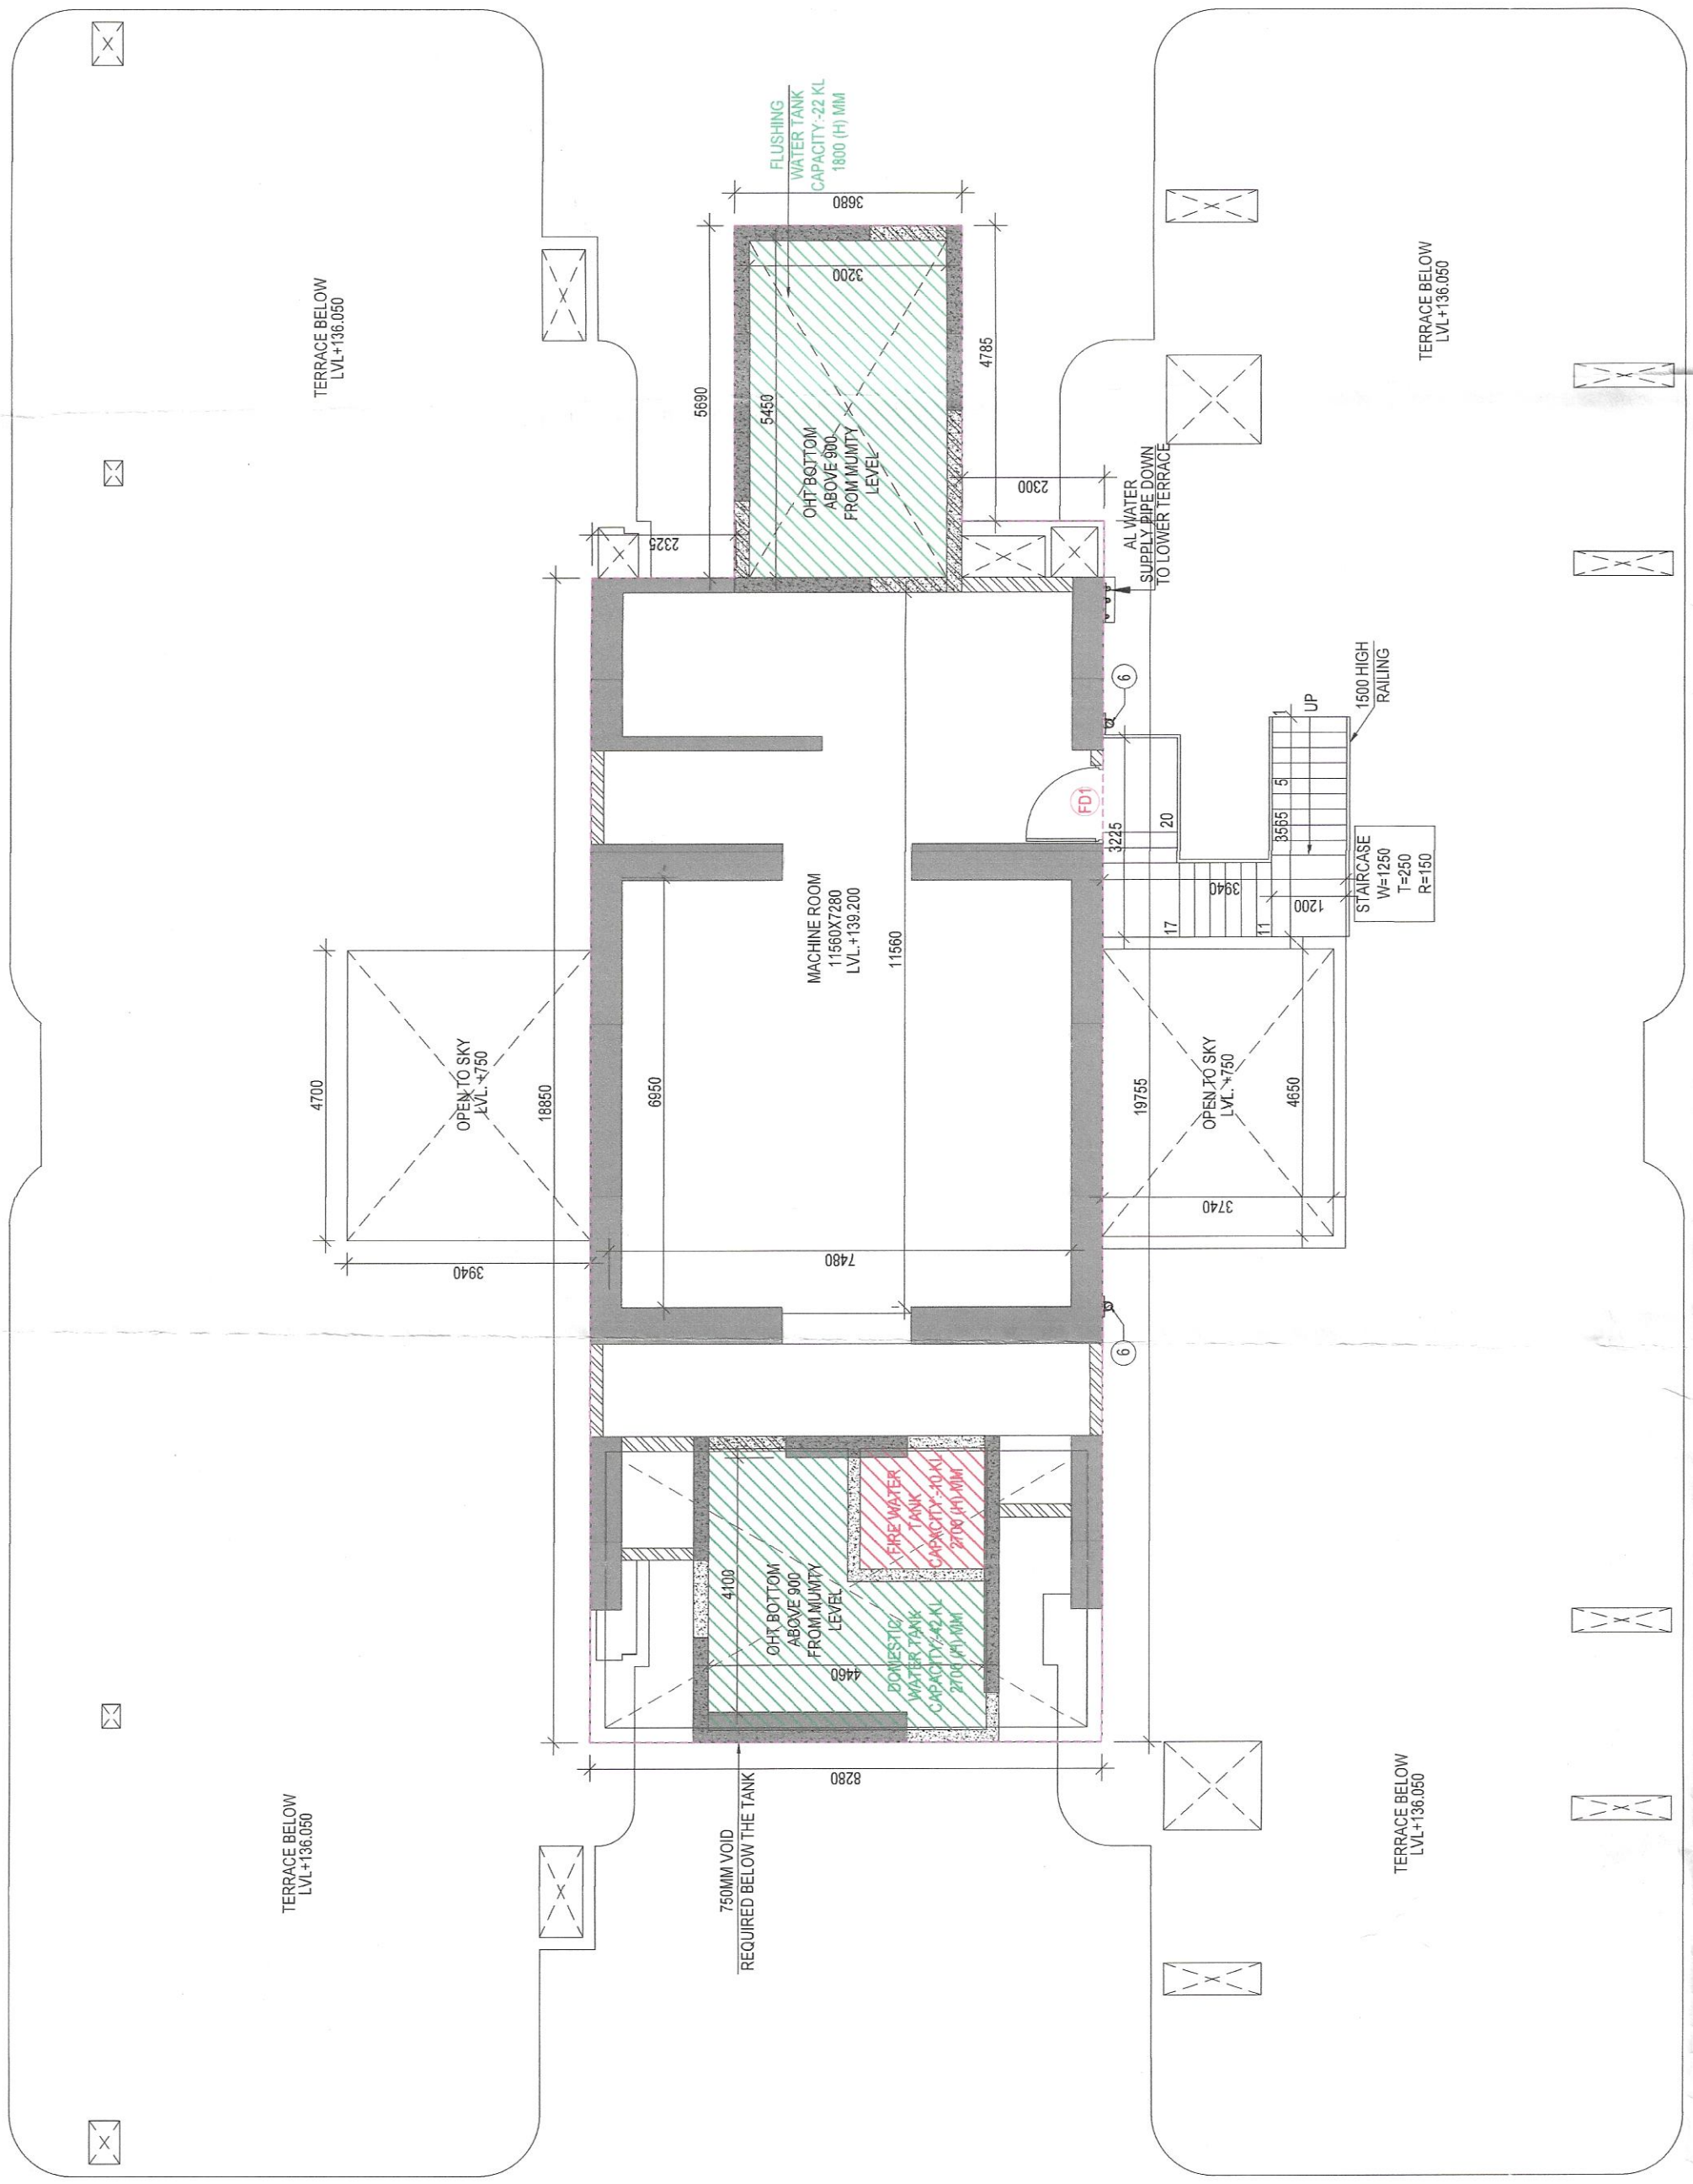

MACHINE ROOM LEVEL PLAN
LV=139.200
TOWER -1

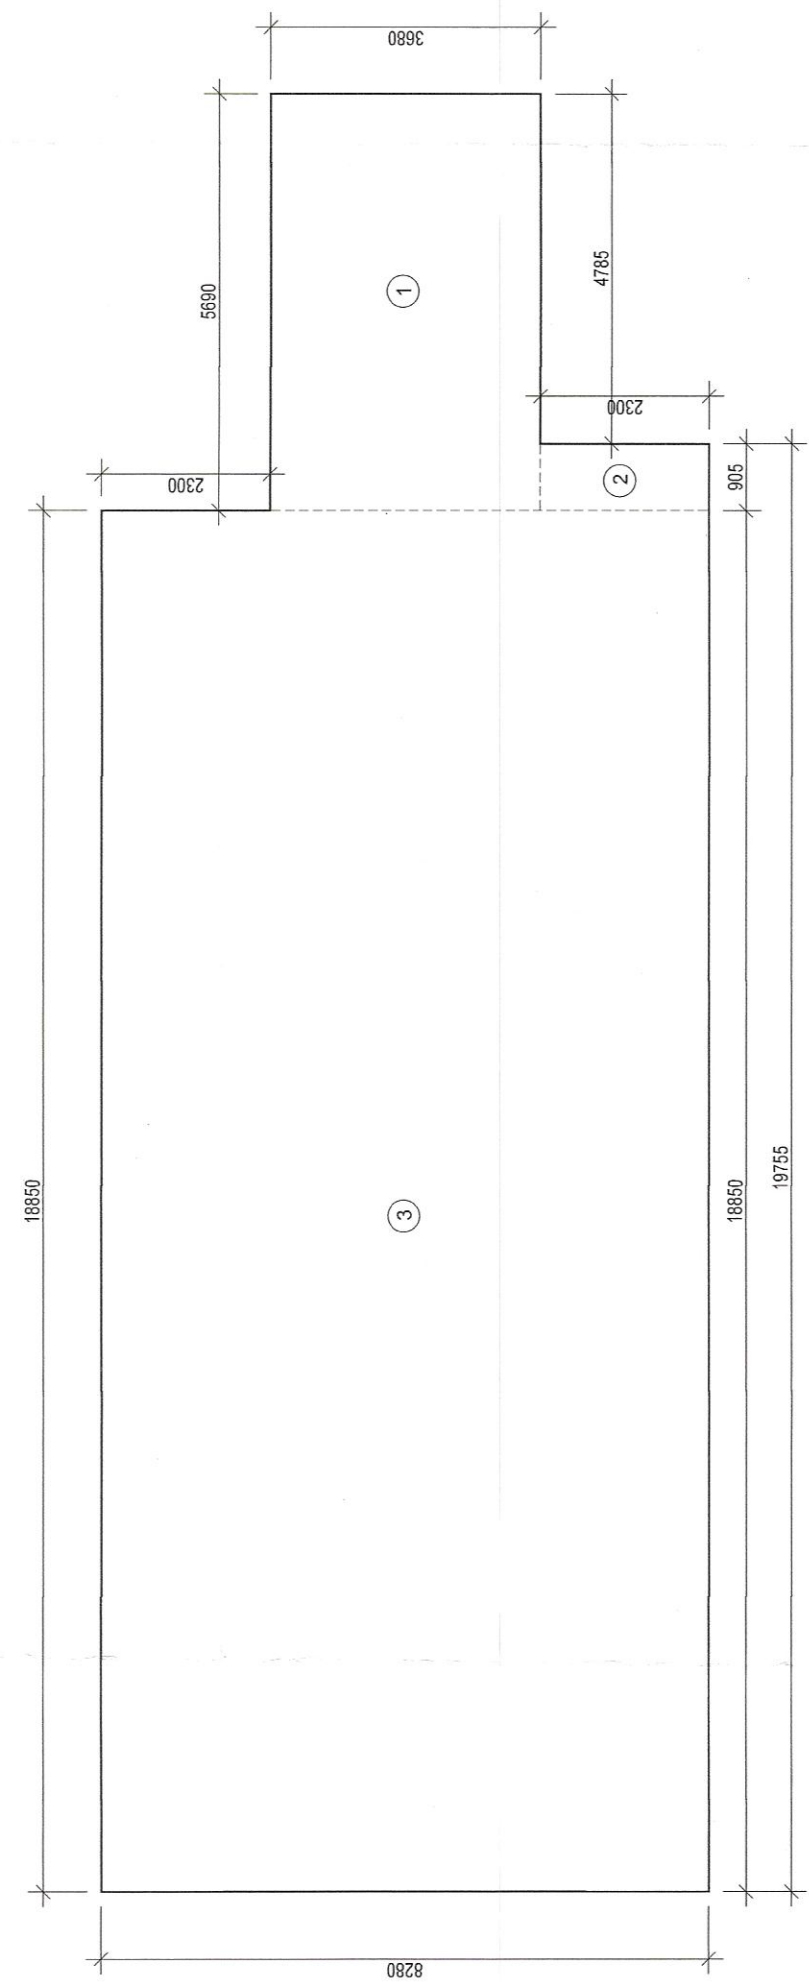

MACHINE ROOM LEVEL PLAN
AREA CALCULATION
TOWER -1

PLUMBING LEGEND:	
1	110 OD UPVC soil Pipe IS 13562 Type B
2	110 OD UPVC waste Pipe IS 13562 Type B
3	110 OD UPVC waste Pipe For Liner Borehole IS 13562 Type B
4	110 OD UPVC ANTISIPHONAGE PIPE IS 13562 Type A
5	DWS ON TAKE PIPE
6	DWS FROM BOOSTER PUMP FOR TOP THREE FLOORS
7	PWS ON TAKE PIPE
8	110 OD UPVC BACKSOL VALVE WATER PIPE IS 4885 6 KG/cm2
9	110 OD UPVC BACKSOL VALVE WASTE PIPE IS 4885 6 KG/cm2
10	DOMESTIC WATER SUPPLY RISER
11	FLUSHING WATER SUPPLY RISER
12	750 AC DRAIN PIPE
13	800 PWS PIPE
14	FLOOR TRAP 150x150 WITH 125x125mm WITH GRATING
15	FLOOR DRAIN 150x150 WITH 125x125mm WITH GRATING
16	BALCONY DRAIN 120x120 WITH 125x125mm WITH GRATING
17	STRIP SINK BY 600MM
18	4000D WASTE PIPE (IS 4885 6 KG/cm2)
19	5000D WASTE PIPE (IS 4885 6 KG/cm2)
20	URINAL TO UT 5000D SOIL PIPE (IS 4885 6 KG/cm2)
21	800X600MM STORM WATER CHAMBER
22	110 OD UPVC SOIL PIPE
23	110 OD UPVC WASTE PIPE

MUMTY MACHINE ROOM AREA CALCULATION (TOWER-1)					
(All Distances are in meter & area in Sqm.)					
ADDITIONS (A)					
ITEM	NO.S	WIDTH	LENGTH	X	AREA (SQ.MT)
1	1	5.680	3.680	X	20.939
2	1	0.905	2.300	X	2.082
3	1	18.550	8.280	X	156.078
TOTAL(A)					179.099

Note :-

ALL FLOOR MECHANICAL VENTILATED LIGHTED & 100% POWER BACKUP. AIR CONDITIONING SYSTEM IS BEING PROVIDED. DG POWER BACKUP IS BEING PROVIDED. TOILET ARE MECHANICAL VENTILATED. ALL LIFTS SHALL HAVE POWER BACK-UP. ALL ELECTRICAL INSTALLATION SHALL BE AS PER PROVISION OF RELEVANT CODE. FIRE/FIGHTING/SAFETY PROVISIONS WILL BE AS PER RELEVANT CODE PROVISIONS. BASEMENT AREA SHELL HAVE MECHANICALLY VENTILATED AS PER RELEVANT CODE. ALL TOILETS ARE VENTILATED AS PER HARYANA BUILDING CODE 2017. BUILDINGS HAS AUTOMATIC SPRINKLER SYSTEM WHERE RELEVANT CODE BUILDING WILL BE DESIGNED/STRUCTURES AS PER RELEVANT CODE. SOLAR PANELS OF REQUIRED CAPACITY SHALL BE PROVIDED AS PER HARYANA ZONING NORMS. ALL HANDICAP RAMP WITH RAILING. ALL FIRE FIGHTING INSTALLATIONS SHALL BE AS PER PROVISION OF RELEVANT CODE. THE PANWATER HARVESTING SYSTEM SHELL BE PROVIDED AS PER CENTRAL GROUND WATER AUTHORITY NORMS.

PROJECT

Proposed Building Plans for Residential Colony under NLP Policy 2022, Licence No. 129 of 2025 Dated 23.07.2025 over an area measuring 11.35625 Acres in the Revenue Estate of Village Ullawas, Sector-60 & 63 A, Gurugram being Developed by Godrej Properties Ltd.

ASSOCIATE ARCHITECT
APL DESIGN PVT. LTD.
E - 24, South Extension-1,
New Delhi, Delhi, India - 110049
OWNER'S SEAL & SIGNATURE

For Godrej Properties Ltd.
Authorized Signatory

ARCHITECT'S SEAL & SIGNATURE



MAY-2026 Scale : 1:100
Drawing Title -
TOWER 01
TERRACE FLOOR PLAN MACHINE ROOM PLAN
MUMTY AREA
Drawing No -
T1-03