

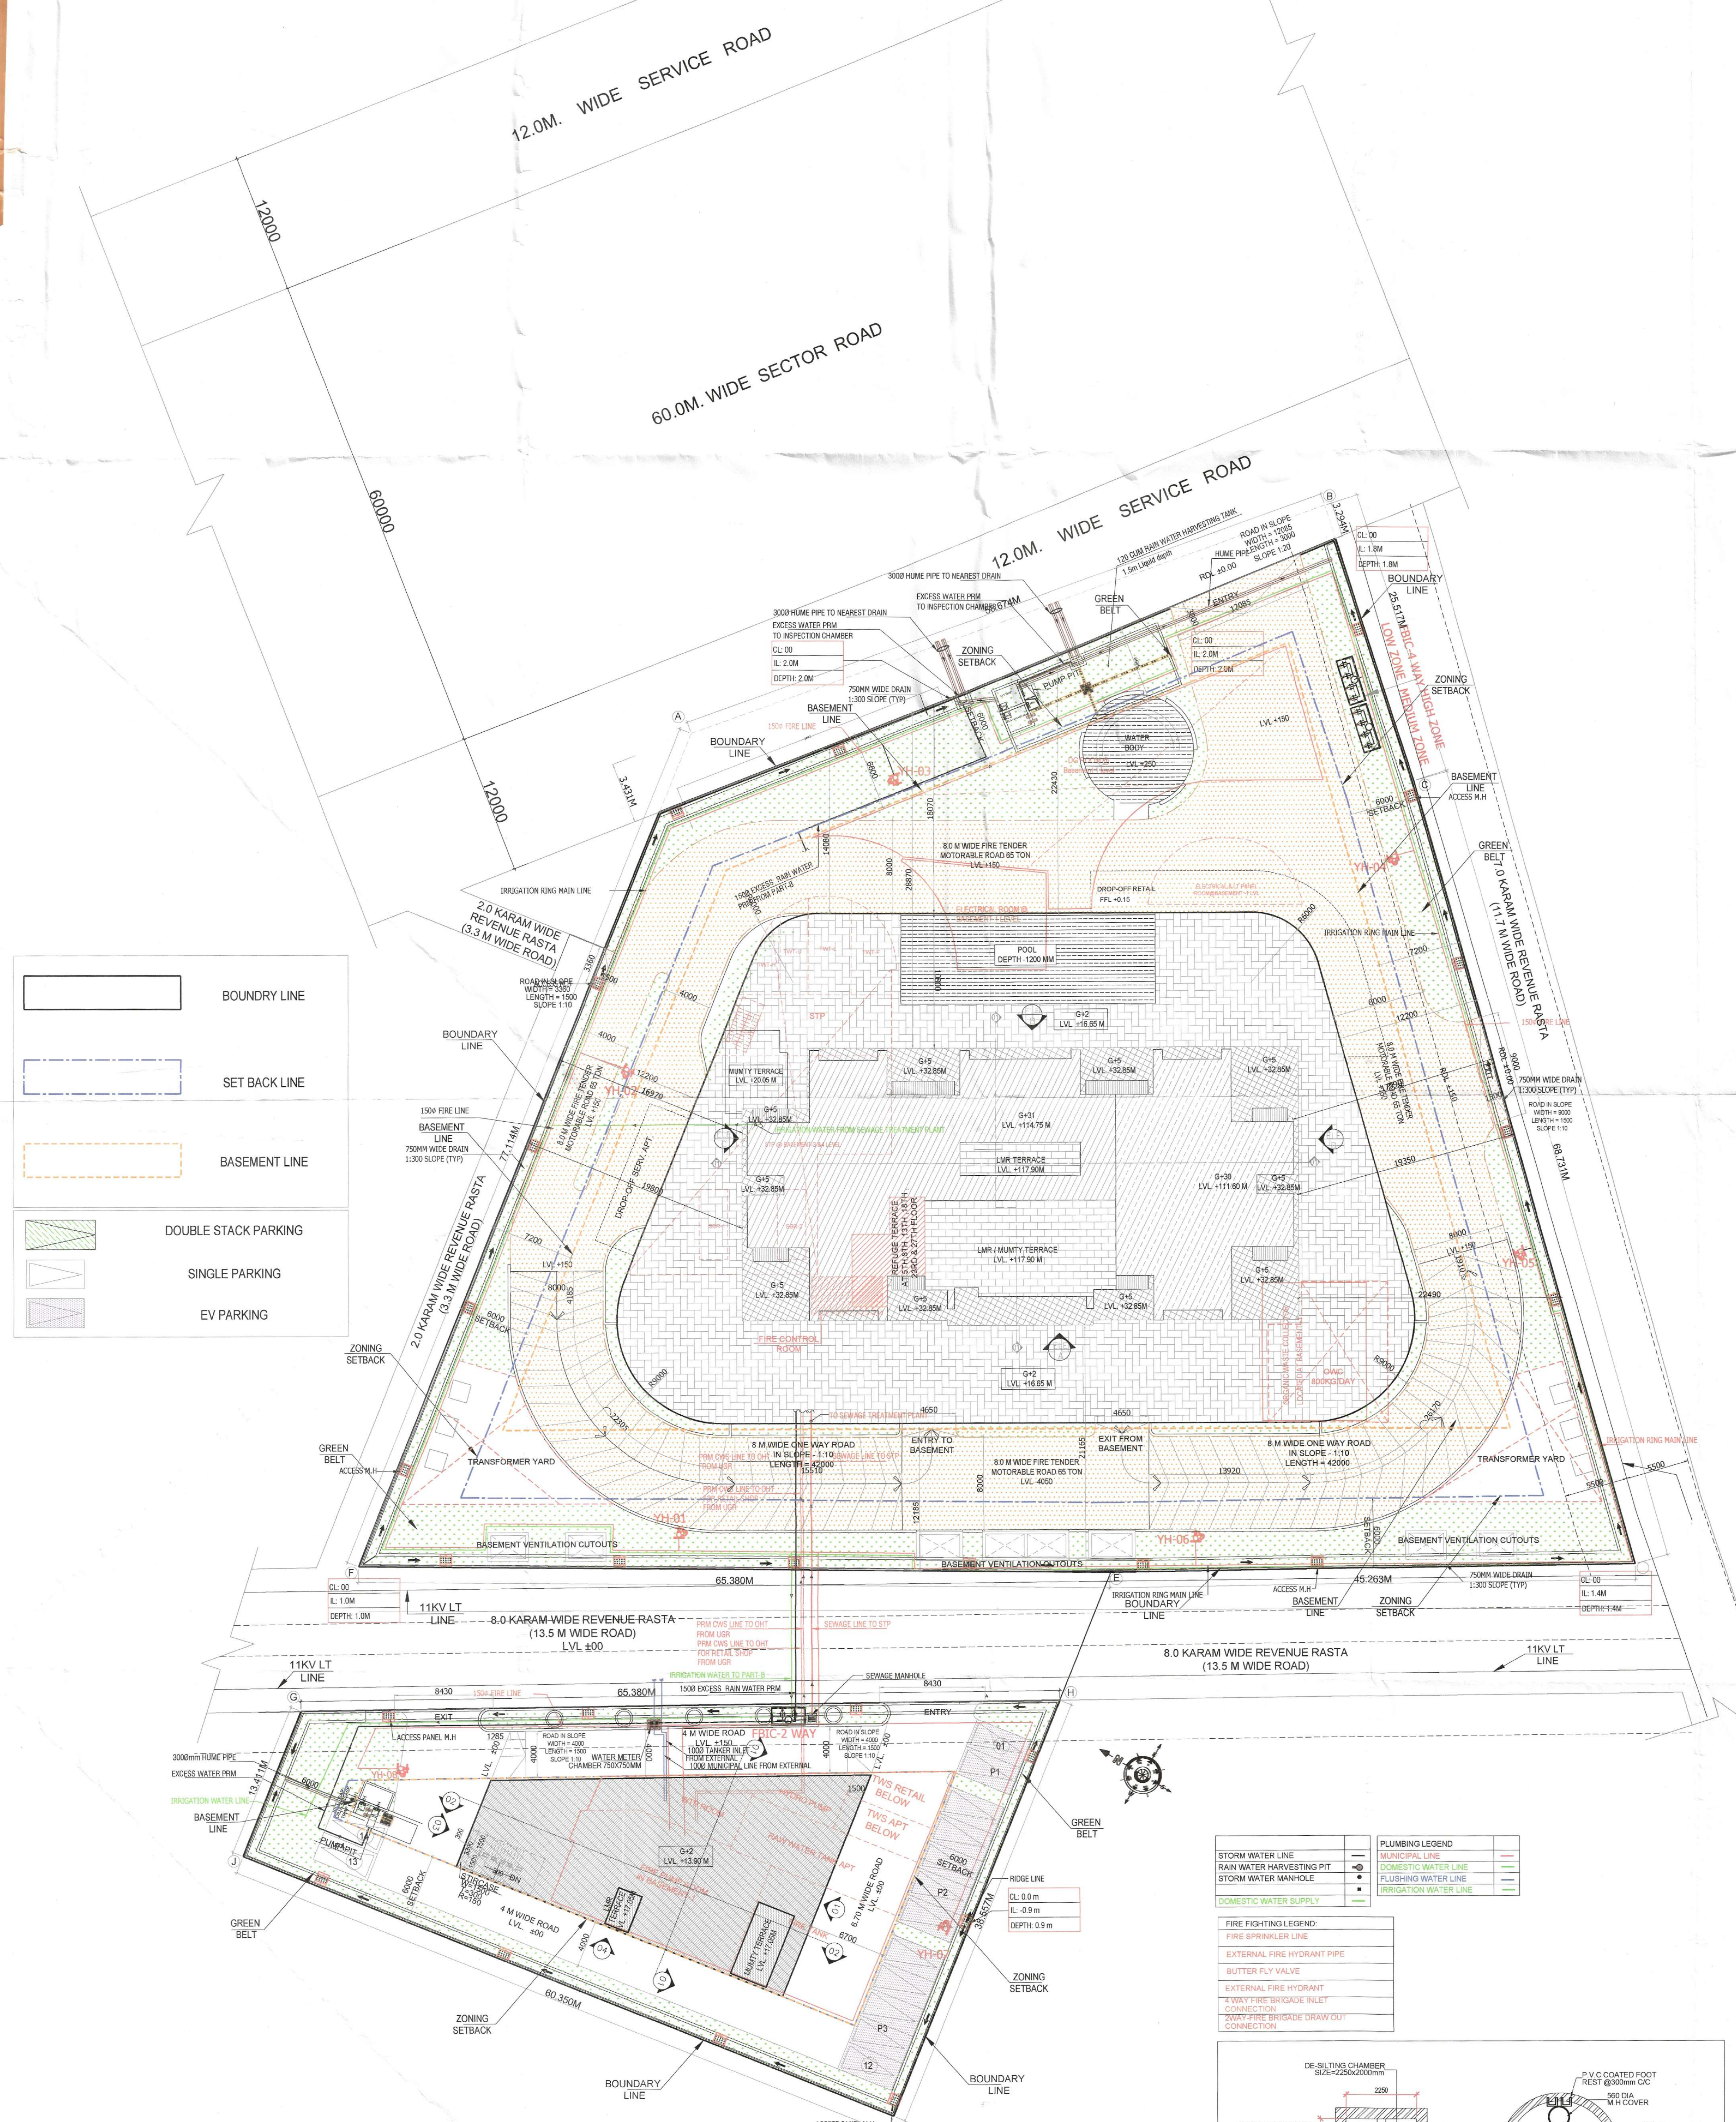


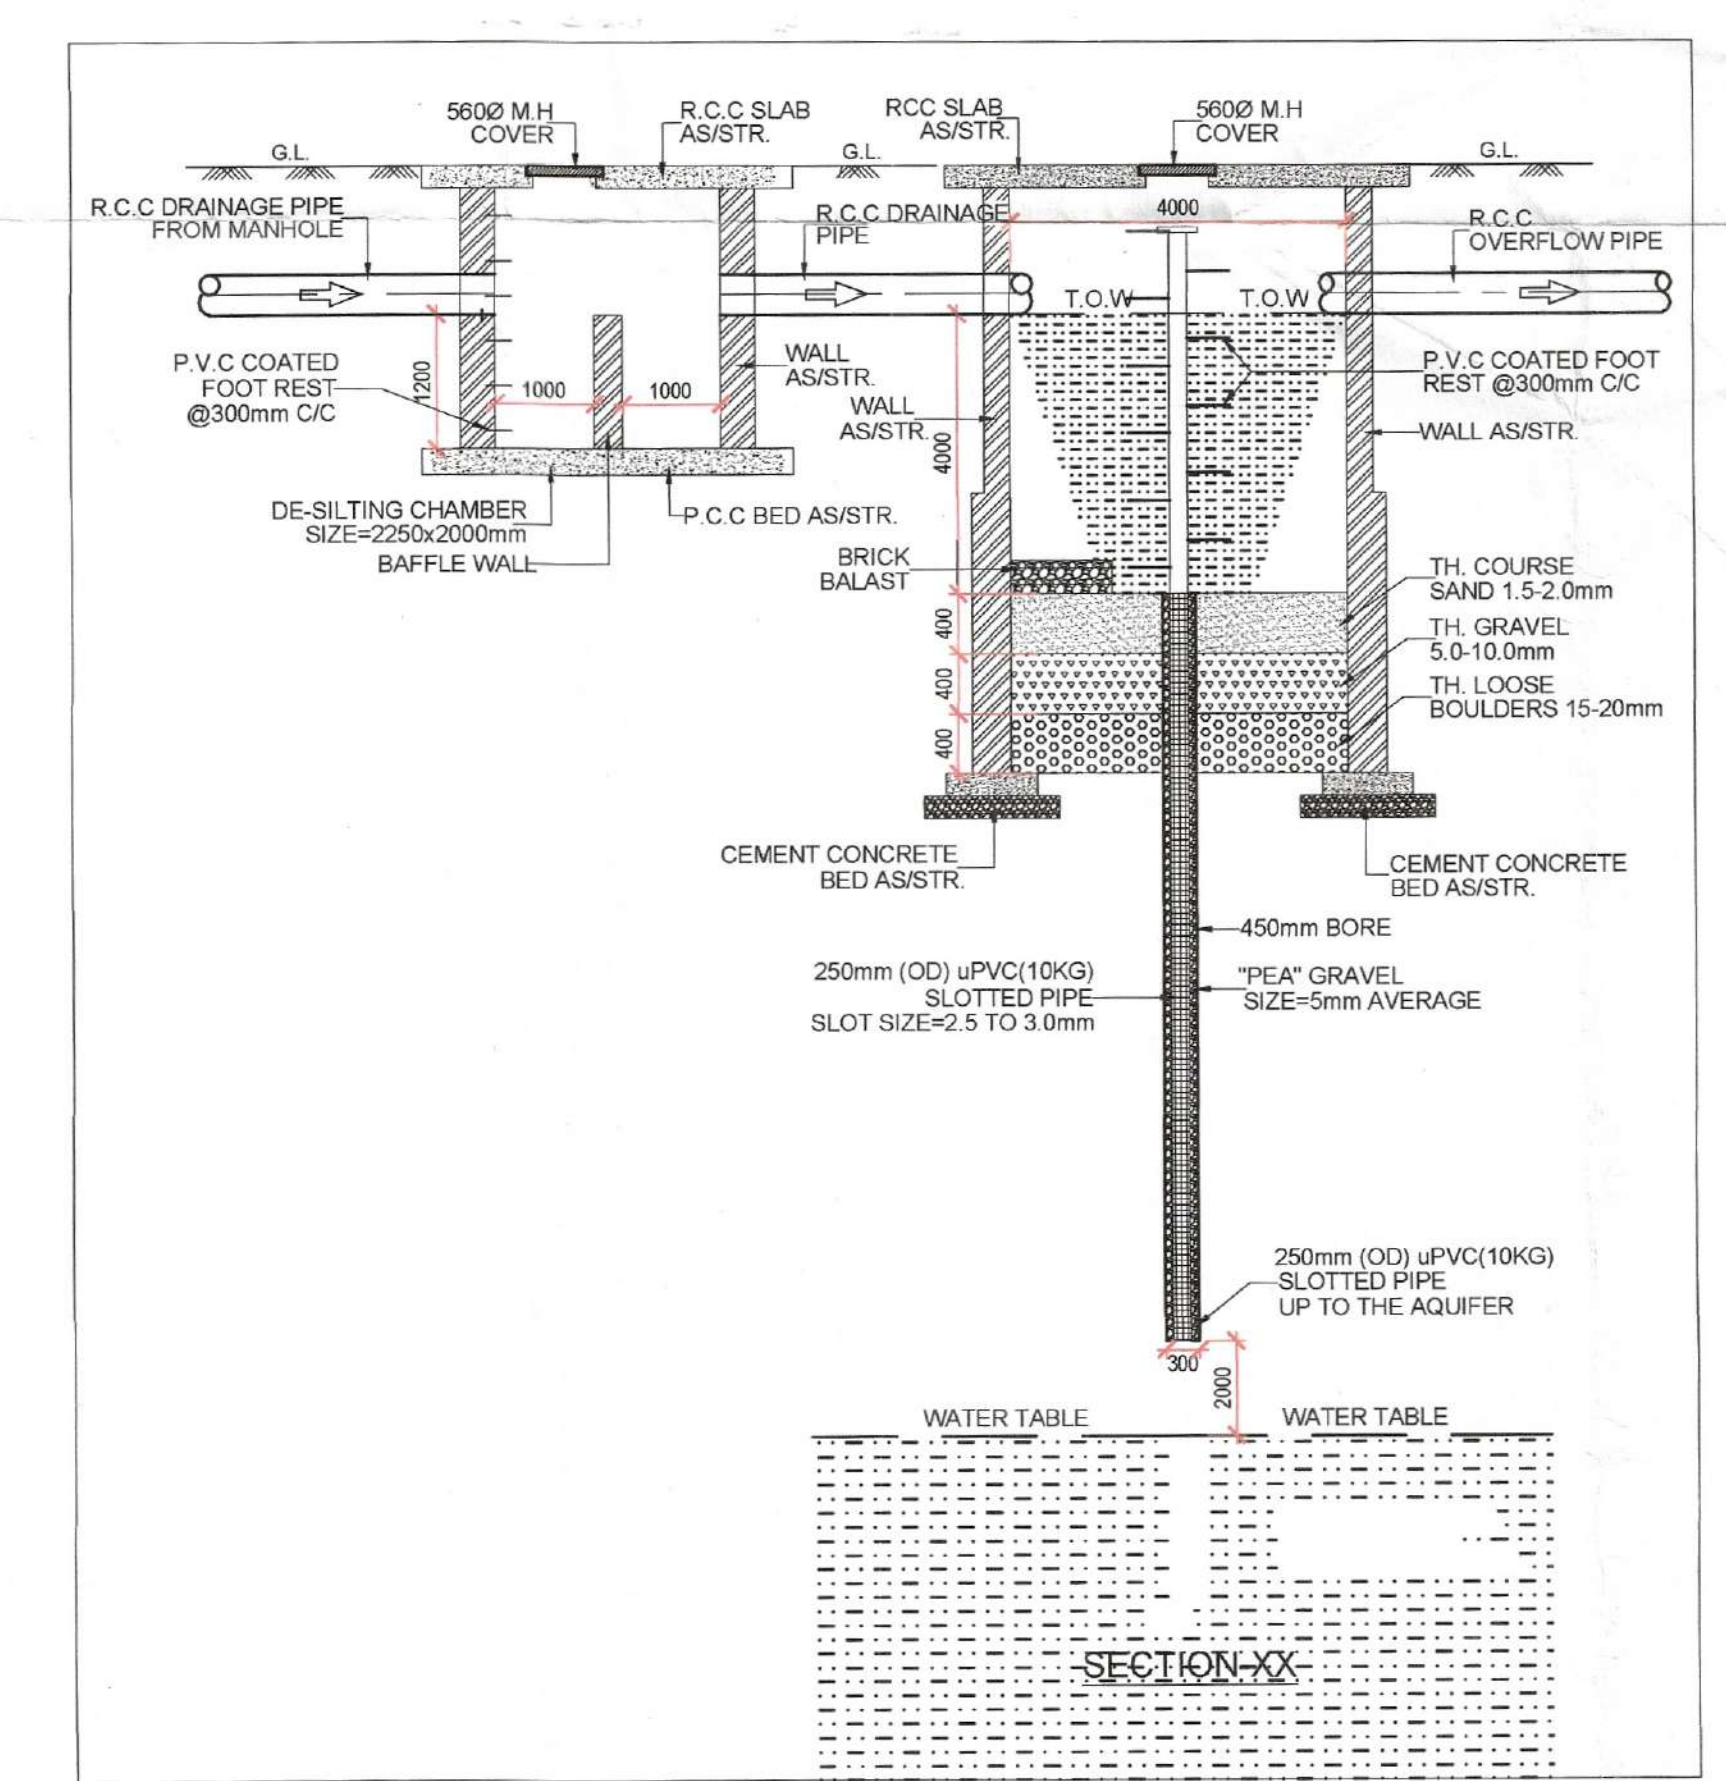

STORM WATER LINE	PLUMBING LEGEND
RAIN WATER HARVESTING PIT	MUNICIPAL LINE
STORM WATER MANHOLE	DOMESTIC WATER LINE
DOMESTIC WATER SUPPLY	FLUSHING WATER LINE
	IRRIGATION WATER LINE

FIRE FIGHTING LEGEND
FIRE SPRINKLER LINE
EXTERNAL FIRE HYDRANT PIPE
BUTTER FLY VALVE
EXTERNAL FIRE HYDRANT
ENTRY FIRE BRIGADE SILENT CONNECTION
ENTRY FIRE BRIGADE DRAWDOWN CONNECTION

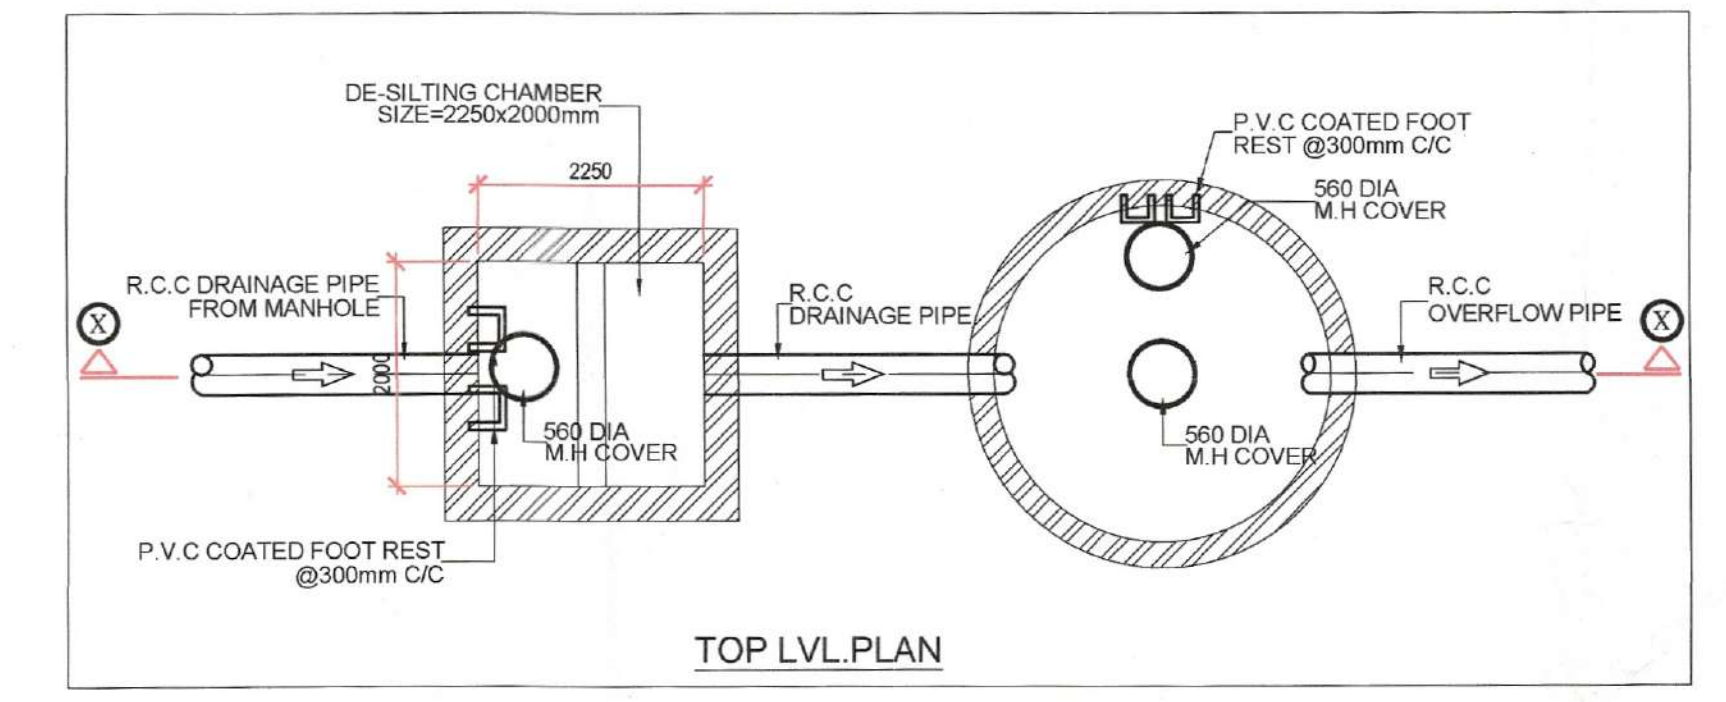

NOTES:- MECHANICAL VENTILATED & 100% POWER BACKUP. AIR CONDITIONING SYSTEM IS BEING PROVIDED. DG POWER BACKUP IS BEING PROVIDED. TOILET ARE MECHANICAL VENTILATED. ALL LIFTS SHALL HAVE POWER BACK-UP. ALL ELECTRICAL INSTALLATION SHALL BE AS PER PROVISION OF RELEVANT CODE. FIRE FIGHTING/SAFETY PROVISIONS WILL BE AS PER RELEVANT CODE PROVISIONS. BASEMENT AREA SHALL HAVE MECHANICALLY VENTILATED AS PER RELEVANT CODE. ALL TOILETS ARE VENTILATED AS PER HARYANA BUILDING CODE 2017. BUILDINGS HAS AUTOMATIC SPRINKLER SYSTEM WHEREVER REQUIRED BY RELEVANT CODE. BUILDING WILL BE DESIGNED/STRUCTURES AS PER RELEVANT I.S.CODES FOR EARTHQUAKE RESISTANCE. SOLAR PANELS OF REQUIRED CAPACITY SHALL BE PROVIDED AS PER HARE DA/ZONING NORMS. ALL HANDICAP STAIRS WITH RAILING. ALL FIRE FIGHTING INSTALLATIONS SHALL BE AS PER PROVISION OF RELEVANT CODE. THE RAINWATER HARVESTING SYSTEM SHALL BE PROVIDED AS PER CENTRAL GROUND WATER AUTHORITY NORMS.

PROJECT:-

PROPOSED BUILDING PLAN OF COMMERCIAL COLONY AN AREA MEASURING 2.03 ACRES (LICENCE NO.162 OF 2022 DATED 6/10/2022) IN SECTOR-106, GURUGRAM MANESAR URBAN COMPLEX BEING DEVELOPED BY SOBHA COMMERCIAL PRIVATE LTD (FORMERLY KNOWN AS BNB BUILDERS PVT. LTD.) IN COLLABORATION WITH SH. AMIT YADAV & OTHERS

ASSOCIATE ARCHITECTS

ASSOCIATES

PLOT NO-408 SEC-37C GURGAON (PH-9560794794)

OWNER'S SEAL & SIGNATURE

ARCHITECT'S SEAL & SIGNATURE

AC. AJAY KUMAR BAWA
CHAIRMAN, HOD, GURUGRAM
SOBHA LIMITED
6th Floor, 6th Floor, Plot No. 138 P,
Sector-106, Gurugram-122001, Haryana
Phone: 9126-4815550

MARCH-2025 Scale: 1:200

Drawing Title: SITE PLAN(SERVICES)

Drawing No: ST-02