




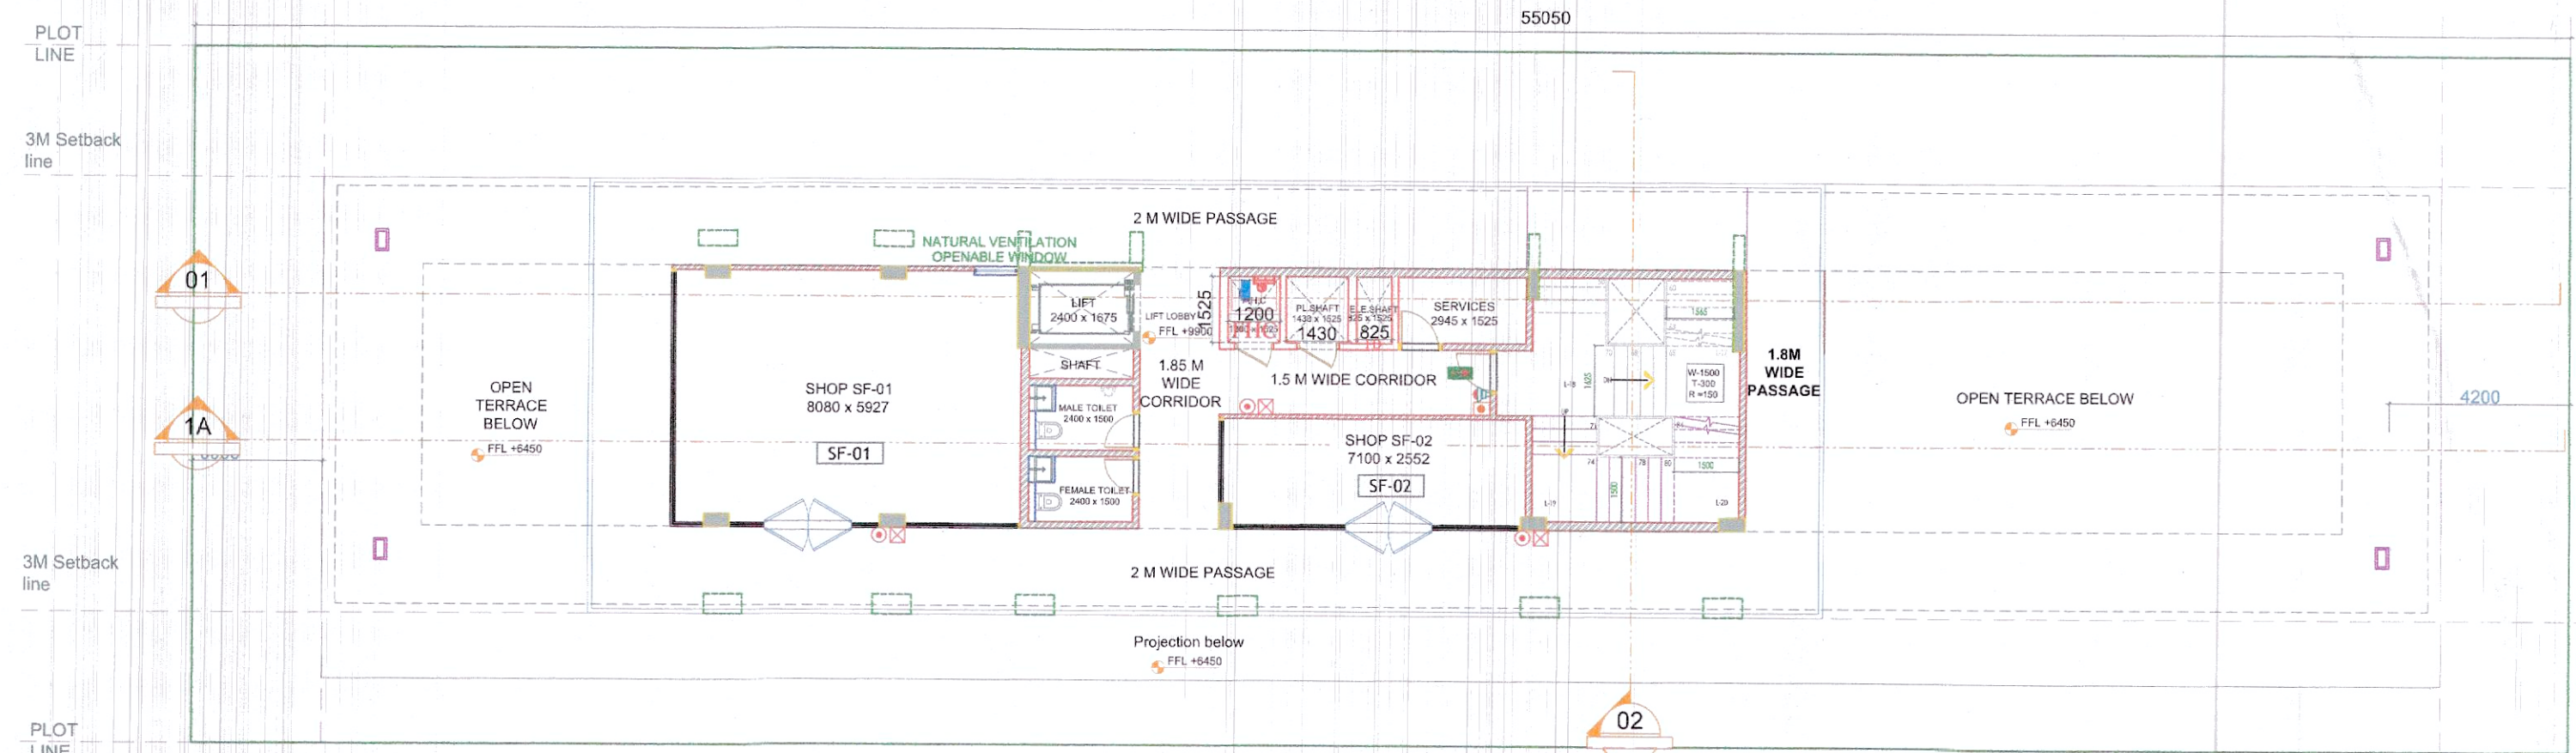


SECOND FLOOR PLAN
SCALE: 1:100
FLOOR LEVEL: +990

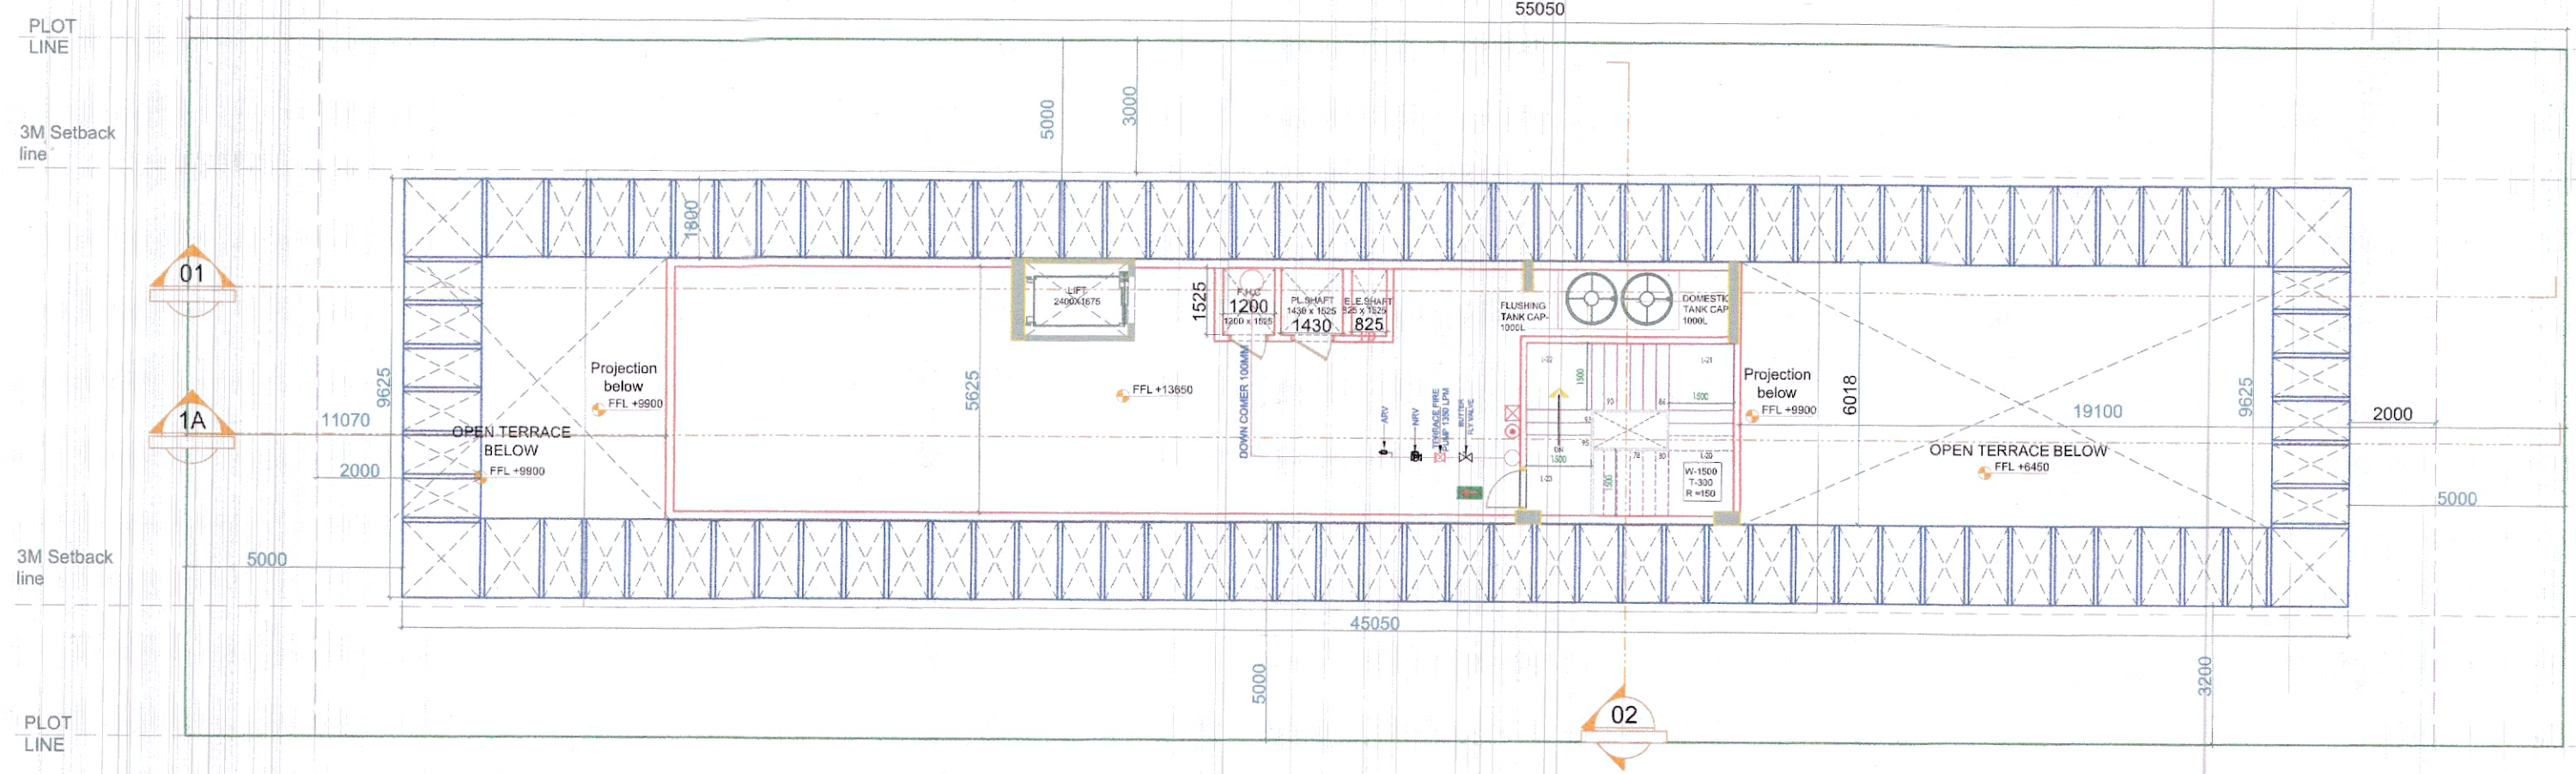

TERRACE FLOOR PLAN
FLOOR ELEVATION: +990

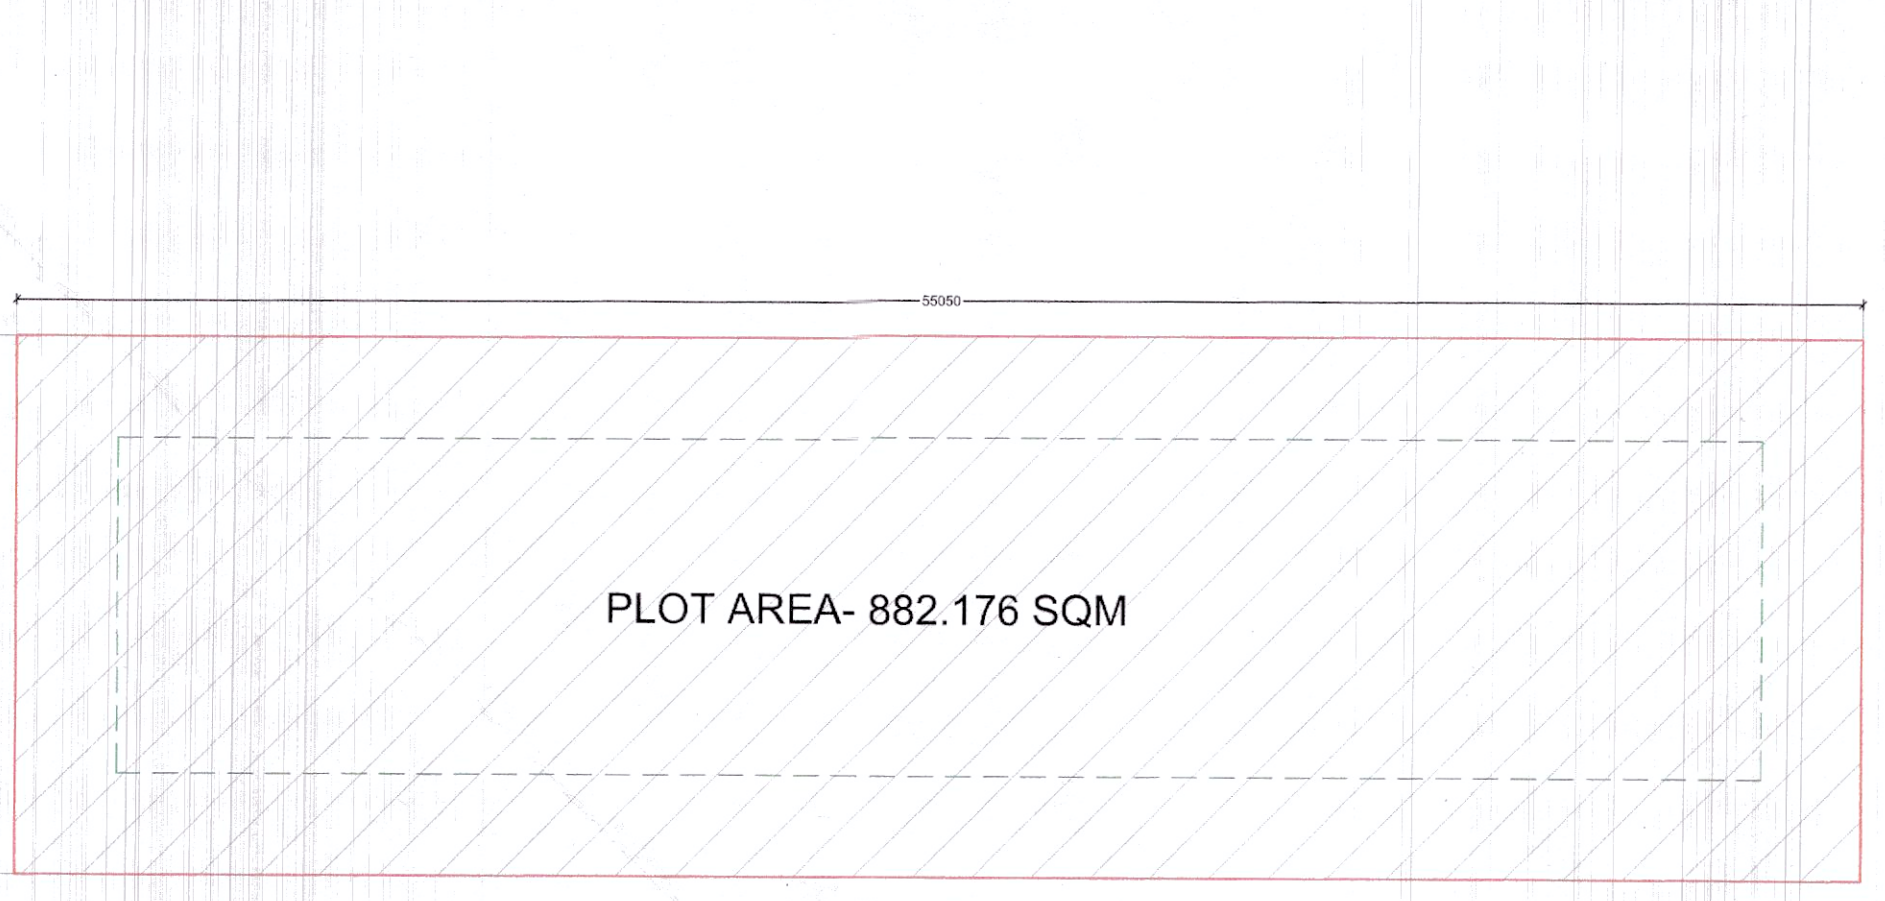

SITE AREA DIAGRAM
SCALE: 1:150

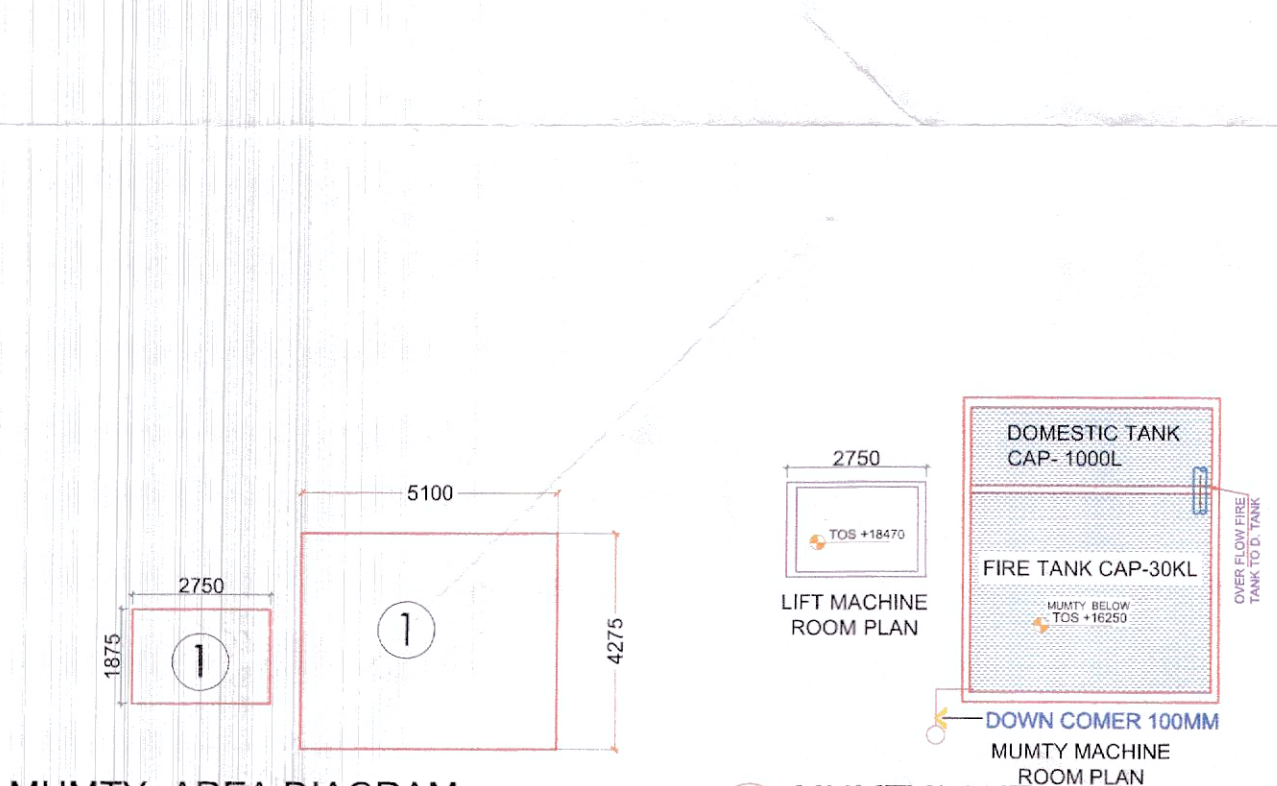

MUMTY- AREA DIAGRAM
SCALE: 1:150

MUMTY/ OHT PLAN
SCALE: 1:100

DOOR WINDOW SCHEDULE

TYPE	WIDTH	HEIGHT	NO.	AREA	PERIMETER	LEVEL
1	1000	2100	100	2100	2100	2100
2	900	2100	100	2100	2100	2100
3	1000	2100	100	2100	2100	2100
4	900	2100	100	2100	2100	2100
5	1000	2100	100	2100	2100	2100
6	900	2100	100	2100	2100	2100
7	1000	2100	100	2100	2100	2100
8	900	2100	100	2100	2100	2100
9	1000	2100	100	2100	2100	2100
10	900	2100	100	2100	2100	2100
11	1000	2100	100	2100	2100	2100
12	900	2100	100	2100	2100	2100
13	1000	2100	100	2100	2100	2100
14	900	2100	100	2100	2100	2100
15	1000	2100	100	2100	2100	2100
16	900	2100	100	2100	2100	2100
17	1000	2100	100	2100	2100	2100
18	900	2100	100	2100	2100	2100
19	1000	2100	100	2100	2100	2100
20	900	2100	100	2100	2100	2100
21	1000	2100	100	2100	2100	2100
22	900	2100	100	2100	2100	2100
23	1000	2100	100	2100	2100	2100
24	900	2100	100	2100	2100	2100
25	1000	2100	100	2100	2100	2100
26	900	2100	100	2100	2100	2100
27	1000	2100	100	2100	2100	2100
28	900	2100	100	2100	2100	2100
29	1000	2100	100	2100	2100	2100
30	900	2100	100	2100	2100	2100
31	1000	2100	100	2100	2100	2100
32	900	2100	100	2100	2100	2100
33	1000	2100	100	2100	2100	2100
34	900	2100	100	2100	2100	2100
35	1000	2100	100	2100	2100	2100
36	900	2100	100	2100	2100	2100
37	1000	2100	100	2100	2100	2100
38	900	2100	100	2100	2100	2100
39	1000	2100	100	2100	2100	2100
40	900	2100	100	2100	2100	2100
41	1000	2100	100	2100	2100	2100
42	900	2100	100	2100	2100	2100
43	1000	2100	100	2100	2100	2100
44	900	2100	100	2100	2100	2100
45	1000	2100	100	2100	2100	2100
46	900	2100	100	2100	2100	2100
47	1000	2100	100	2100	2100	2100
48	900	2100	100	2100	2100	2100
49	1000	2100	100	2100	2100	2100
50	900	2100	100	2100	2100	2100
51	1000	2100	100	2100	2100	2100
52	900	2100	100	2100	2100	2100
53	1000	2100	100	2100	2100	2100
54	900	2100	100	2100	2100	2100
55	1000	2100	100	2100	2100	2100
56	900	2100	100	2100	2100	2100
57	1000	2100	100	2100	2100	2100
58	900	2100	100	2100	2100	2100
59	1000	2100	100	2100	2100	2100
60	900	2100	100	2100	2100	2100
61	1000	2100	100	2100	2100	2100
62	900	2100	100	2100	2100	2100
63	1000	2100	100	2100	2100	2100
64	900	2100	100	2100	2100	2100
65	1000	2100	100	2100	2100	2100
66	900	2100	100	2100	2100	2100
67	1000	2100	100	2100	2100	2100
68	900	2100	100	2100	2100	2100
69	1000	2100	100	2100	2100	2100
70	900	2100	100	2100	2100	2100
71	1000	2100	100	2100	2100	2100
72	900	2100	100	2100	2100	2100
73	1000	2100	100	2100	2100	2100
74	900	2100	100	2100	2100	2100
75	1000	2100	100	2100	2100	2100
76	900	2100	100	2100	2100	2100
77	1000	2100	100	2100	2100	2100
78	900	2100	100	2100	2100	2100
79	1000	2100	100	2100	2100	2100
80	900	2100	100	2100	2100	2100
81	1000	2100	100	2100	2100	2100
82	900	2100	100	2100	2100	2100
83	1000	2100	100	2100	2100	2100
84	900	2100	100	2100	2100	2100
85	1000	2100	100	2100	2100	2100
86	900	2100	100	2100	2100	2100
87	1000	2100	100	2100	2100	2100
88	900	2100	100	2100	2100	2100
89	1000	2100	100	2100	2100	2100
90	900	2100	100	2100	2100	2100
91	1000	2100	100	2100	2100	2100
92	900	2100	100	2100	2100	2100
93	1000	2100	100	2100	2100	2100
94	900	2100	100	2100	2100	2100
95	1000	2100	100	2100	2100	2100
96	900	2100	100	2100	2100	2100
97	1000	2100	100	2100	2100	2100
98	900	2100	100	2100	2100	2100
99	1000	2100	100	2100	2100	2100
100	900	2100	100	2100	2100	2100

SECTION 1A
SCALE: 1:100

SECOND FLOOR AREA DIAGRAM
SCALE: 1:100

BASEMENT AREA DIAGRAM
SCALE: 1:100

BASEMENT PARKING AREA DIAGRAM
SCALE: 1:100

For Planning Scheme Under 15 Mtr. Height
Approved by the Fire Station Officer
Date: 02/09/2026
Fire Station, Gurugram

FIRE LEGEND

Symbol	Description
1	CO2 4.5 KG CAP. FIRE EXTINGUISHER
2	ABC TYPE FIRE EXTINGUISHER CAP. 4.5 KG
3	TERRACE FIRE WATER TANK 30KL
4	TERRACE DOMESTIC WATER TANK 10L
5	BUTTERFLY VALVE
6	AIR VESSEL
7	TERRACE FIRE PUMP 350LPM
8	DOWNCOMER 100MM
9	OVER FLOW FIRE TANK TO TANK ROOM
10	NRV (NON RETURN VALVE)
11	FIRE HOSE CABINET (FHC)
12	FIRE EXIT SYMBOL
13	NATURAL VENTILATION OPENABLE WINDOW
14	MCP (MANUAL CALL POINT)
15	HOOTER
16	SPRINKLER HEAD PENDENT TYPE 3MM LEACH
17	SMOKE DETECTOR BIRM EACH
18	FLOW SWITCH
19	BUTTERFLY VALVE

NOTES
1. ALL DIMENSIONS ARE IN MM UNLESS OTHERWISE SPECIFIED
2. A FULLY MECHANICAL VENTILATION SYSTEM IS PROVIDED IN THE BUILDING.

ARCHITECT
VVA Design Studio Pvt.Ltd.
B-120, Ground Floor, Green Field Colony, Sector-43, Faridkot-151010, Haryana
Ph: +91 7042 024650
E-Mail: connect@vvaestudio.in

OWNER'S SIGNATURE
[Signature]
[Name]
[Designation]

ARCHITECT'S SIGNATURE
[Signature]
[Name]
[Designation]

PROJECT
Commercial-4 over an area measuring (82.28 Sq m) falling in industrial plotted colony area measuring 118.15 Acres bearing License no. 136 of 2022 falling in sectors-M9, M10, M13 and M14 of Mansarovar in Revenue estate of village base haryana and base khwila subail haryana district Gurugram, Haryana being developed by M/S Worldwide Resorts and entertainment Pvt. Ltd.

DRAWING TITLE
FLOOR PLANS & AREA STATEMENT

SHEET NO.
03

It is Certified that These Drawings Are As Per Approved Drawing Approved By Competent Authority Vide:-
Letter No.:-
Date :-
Except Two no. Staircase Added And Minor Changing As Per Fire Requirement.

SIGN. OF OWNER
[Signature]
[Name]
[Designation]

SIGN. OF ARCHITECT
[Signature]
[Name]
[Designation]