

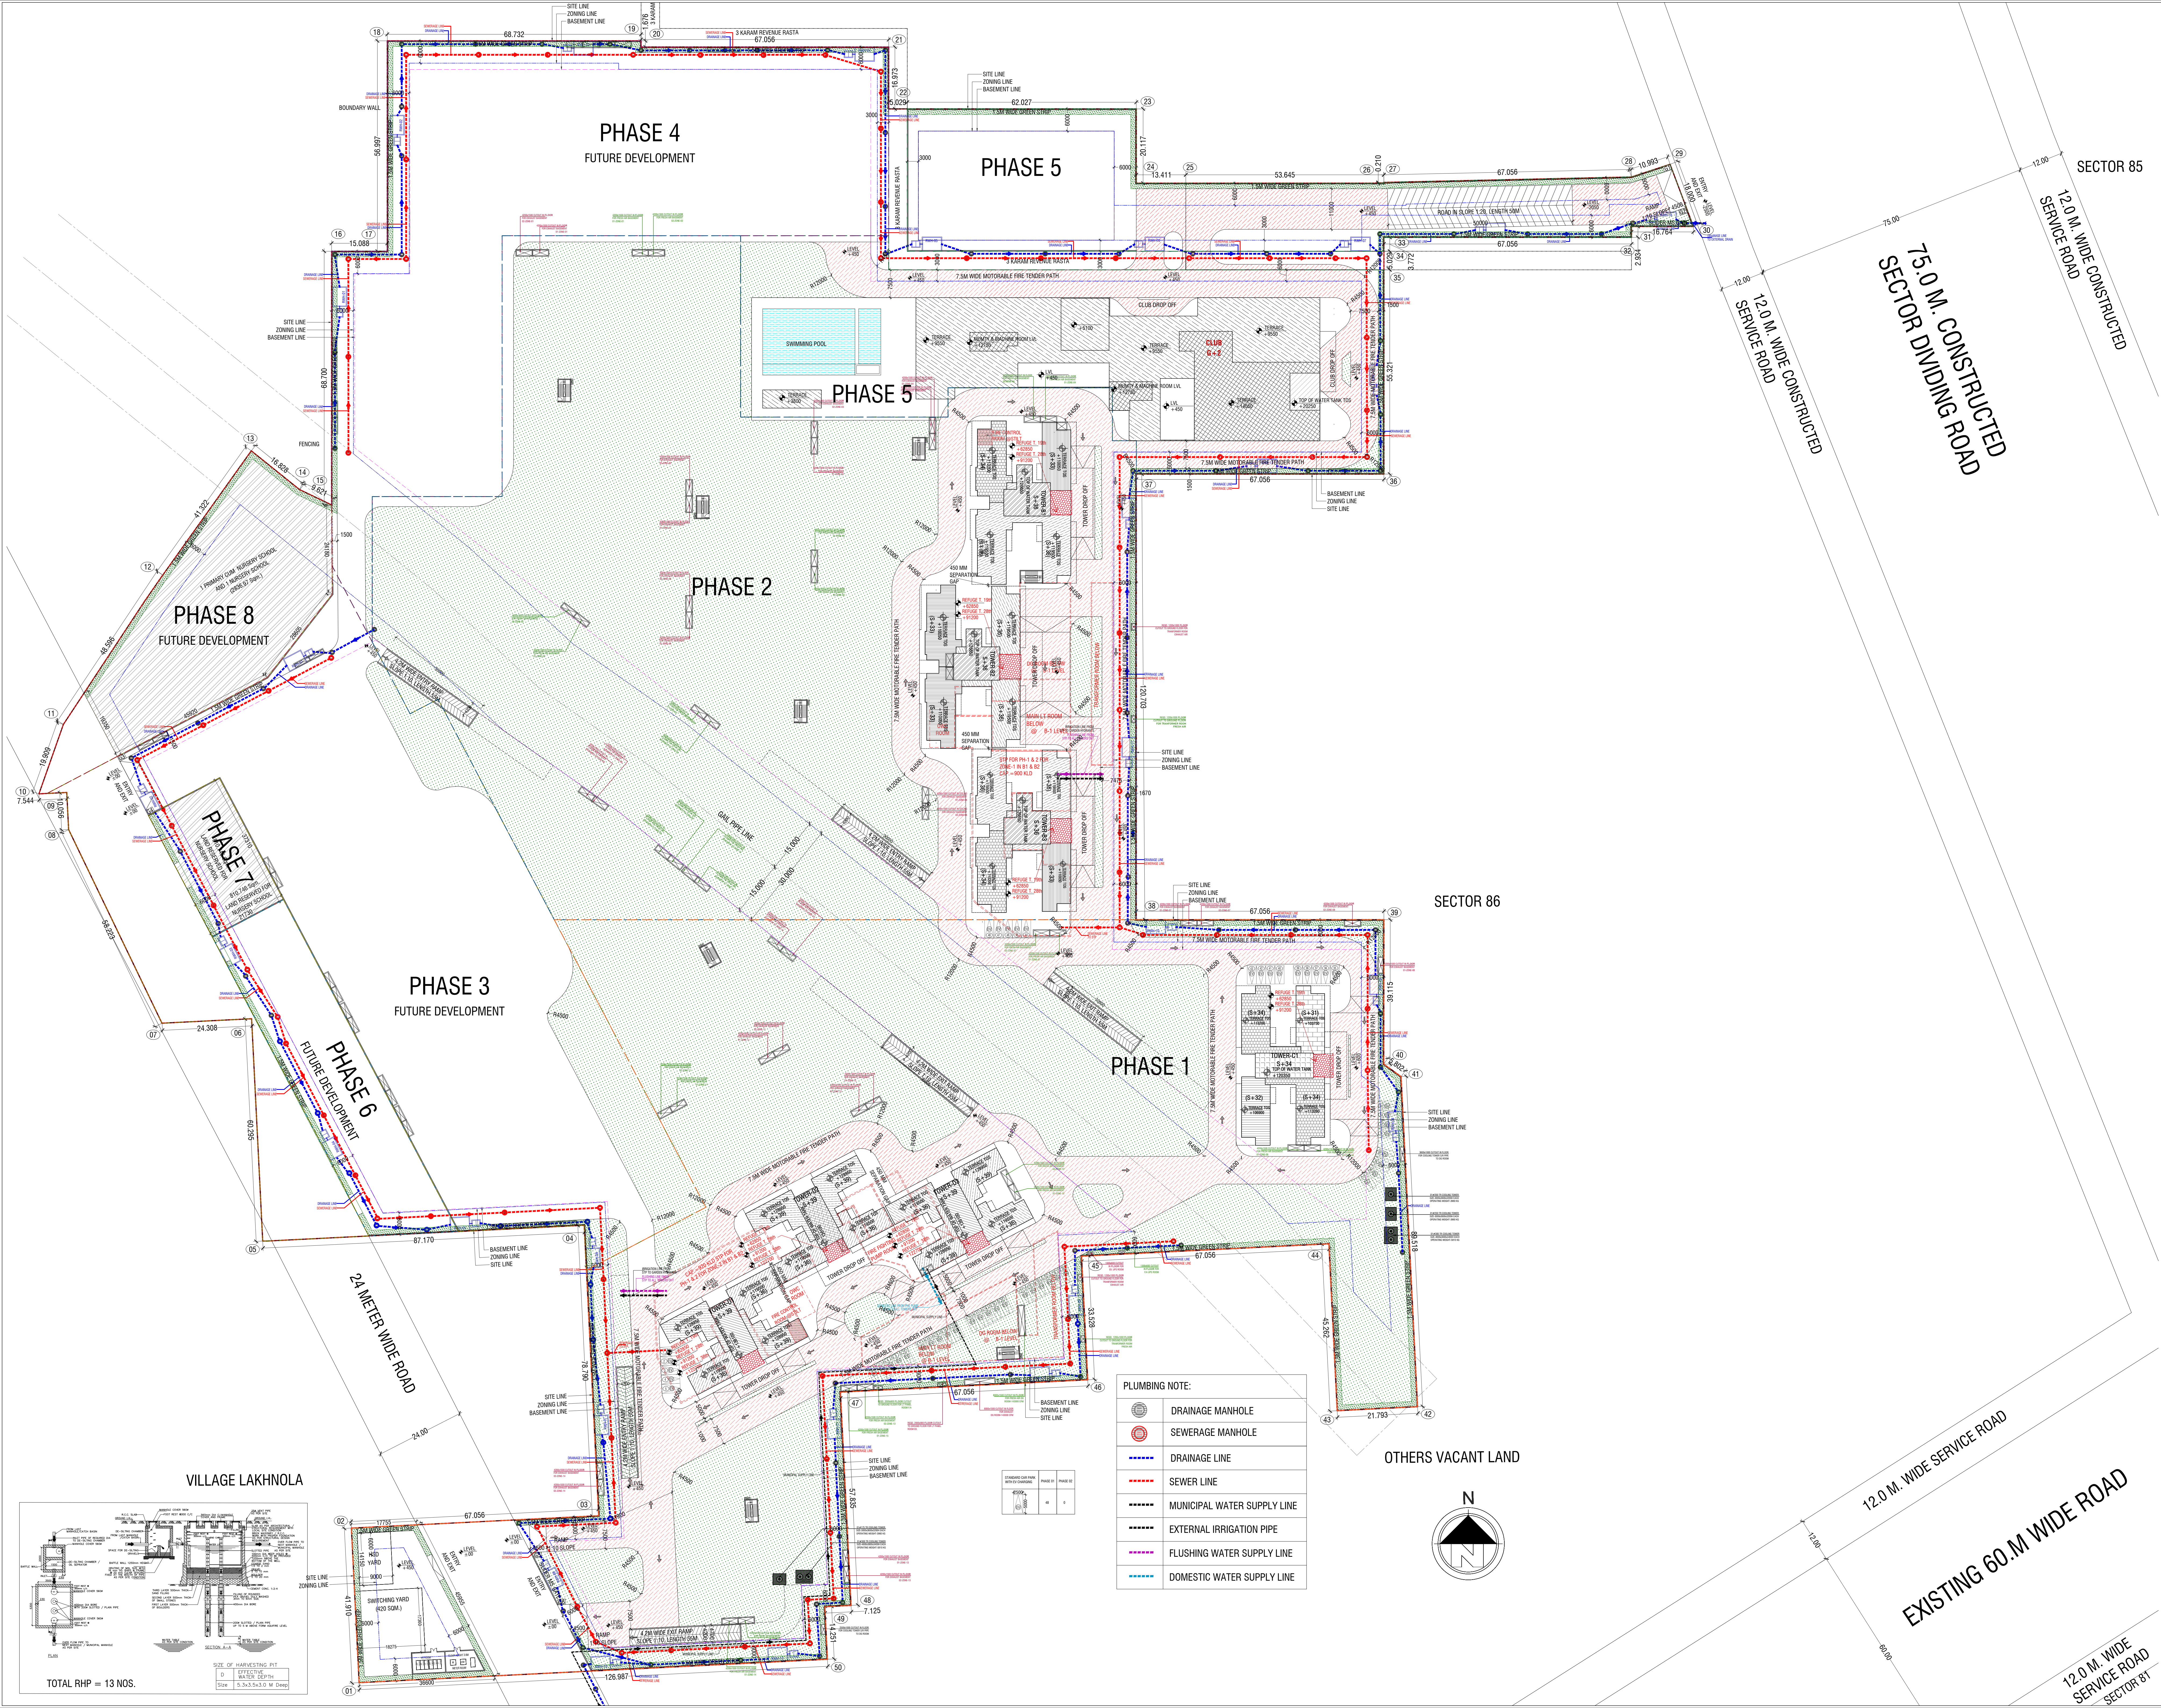


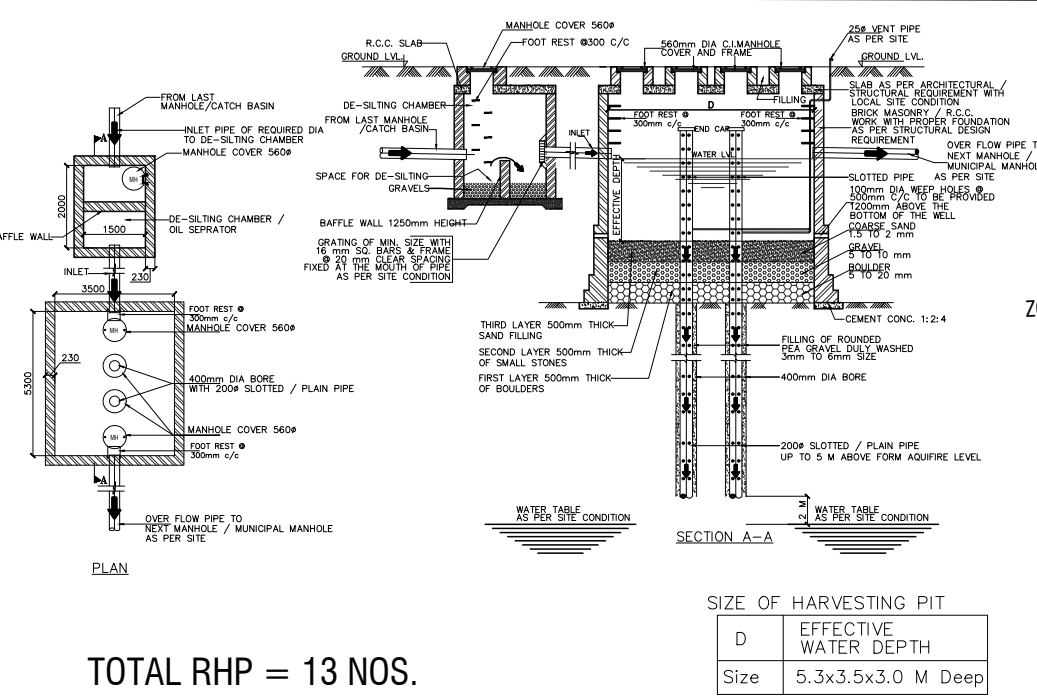

PLUMBING NOTE:

	DRAINAGE MANHOLE
	SEWERAGE MANHOLE
	DRAINAGE LINE
	SEWER LINE
	MUNICIPAL WATER SUPPLY LINE
	EXTERNAL IRRIGATION PIPE
	FLUSHING WATER SUPPLY LINE
	DOMESTIC WATER SUPPLY LINE

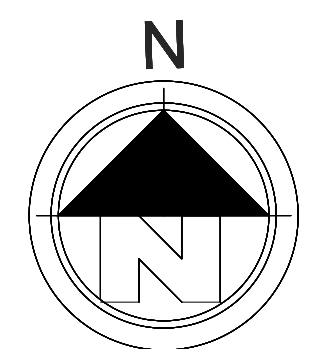

KEY PLAN

PRINCIPAL ARCHITECT

ACPL Ltd.

ACPL Design Ltd. 150 9001-2015

CLIENT

EMAAR INDIA LTD.

PROJECT

PROPOSED RESIDENTIAL COLONY (UNDER NILP POLICY DATED 11.05.2022) ON THE ADDITIONAL AREA MEASURING 1.4625 ACRES (LICENCE NO. 75 OF 2025 DATED 22.05.2025) ADJOINING TO ALREADY LICENSE GRANTED AREA MEASURING 24.4375 ACRES (LICENCE NO. 10 OF 2025 DATED 16.01.2025) THEREBY MAKING TOTAL AREA MEASURING 25.90 ACRES, SECTOR-86, GURUGRAM BEING DEVELOPED BY EMAAR INDIA LTD.

OWNER/AUTH. SIGNATURE

ARCHITECT'S SIGNATURE

DRAWING TITLE

SITE PLAN WITH EXTERNAL SERVICES COMMUNITY BUILDING (CLUB)

DRAWING NO.

A-02

SCALE:

1:600