


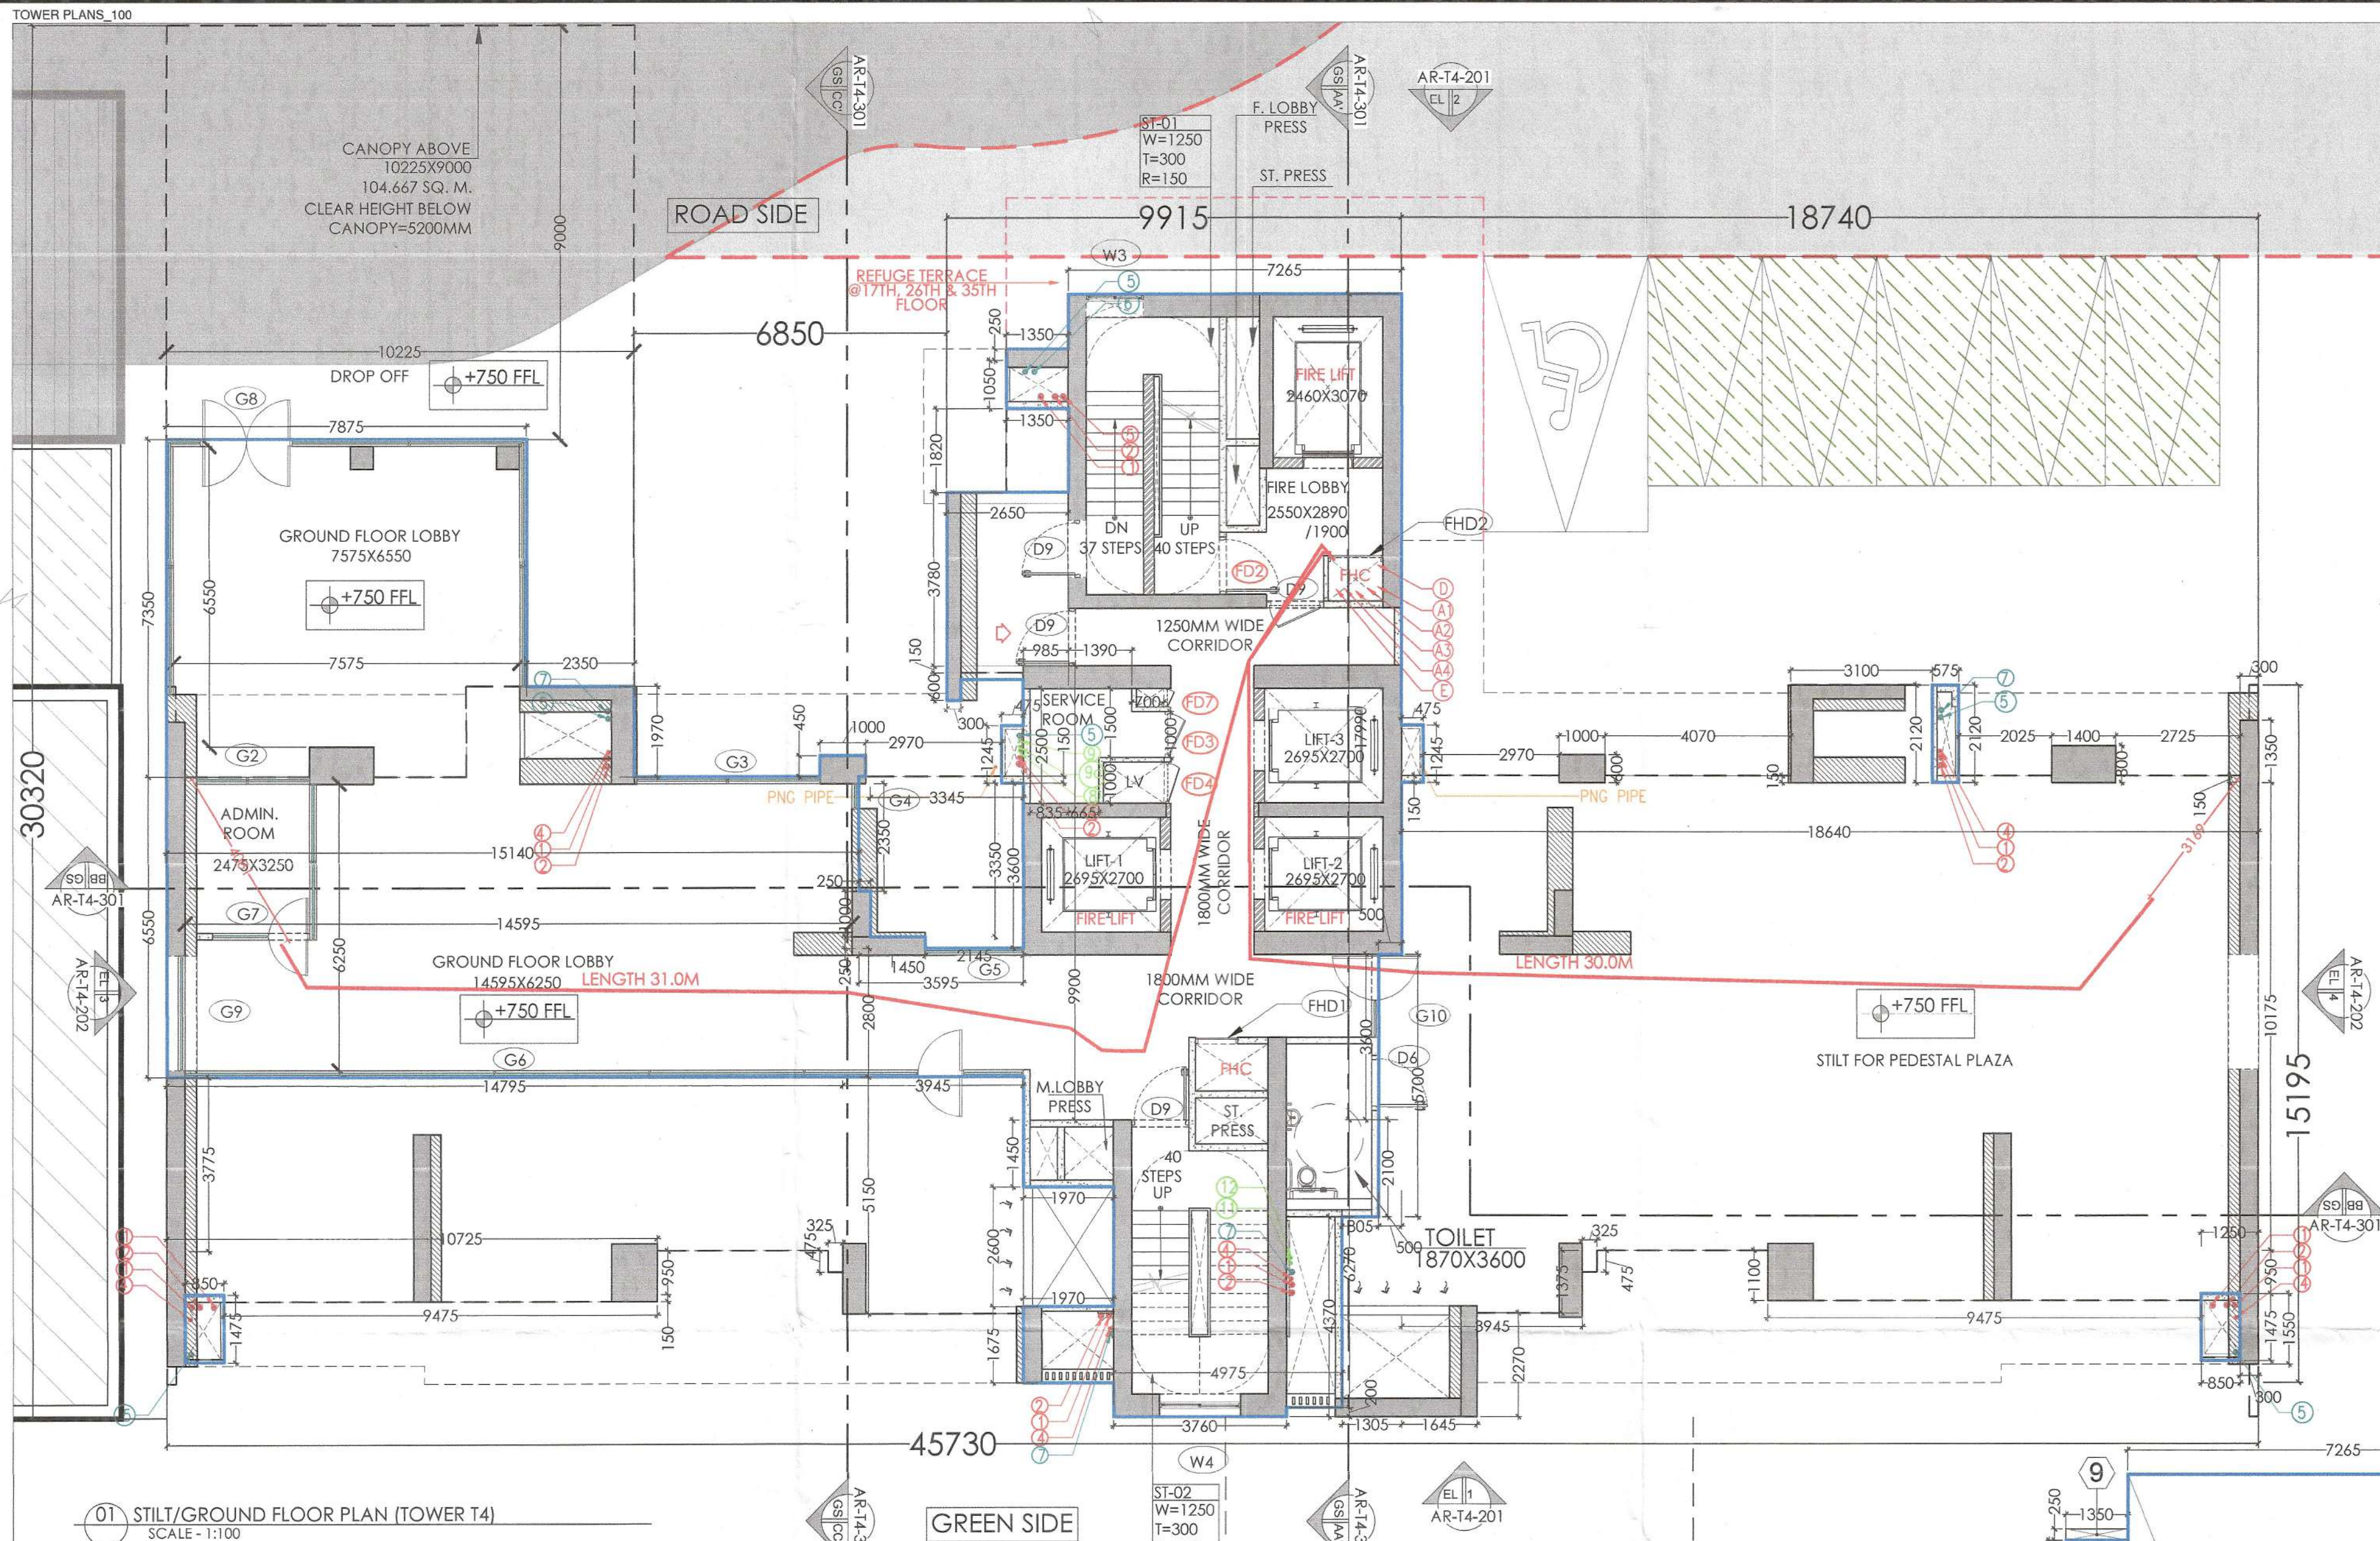

PLUMBING LEGEND:-

DWS	DOMESTIC WATER SUPPLY
FWS	FLUSHING WATER SUPPLY
MFT	MULTI FLOOR TRAP
UT	URINAL TRAP
FD	FLOOR DRAIN
FCO	FLOOR CLEAN OUT PLUG
COP	CLEAN OUT PLUG
BD	BALCONY DRAIN
DP	DRAIN POINT

PLUMBING LEGEND:-

1	1000/1100 SOIL PIPE
2	1000/1100 WASTE PIPE
2a	1000/1100 WASHING MACHINE WASTE WATER PIPE
3	1000/1100 KITCHEN WASTE WATER PIPE
4	150 VENT PIPE
5	1000/1100 RAIN WATER PIPE FOR BALCONY
6	1000/1100 RAIN WATER PIPE FOR REFUGE TERRACE
7	1500/1600 RAIN WATER PIPE FOR TERRACE
8	DOMESTIC WATER SUPPLY (BOOSTER) (TOP SIX FLOORS)
9	DOMESTIC HIGH ZONE WATER SUPPLY (BY GRAVITY)
10	DOMESTIC WATER SUPPLY (BY GRAVITY) EXPRESS D/H
10a	FLUSHING WATER SUPPLY (BY GRAVITY)
11	DOMESTIC WATER SUPPLY RISER FOR C.H. TANK
12	FLUSHING WATER SUPPLY RISER FOR C.H. TANK
13	750 HVAC DRAIN PIPE

NOTES :-

- VRV System is being provided.
- Full DG power back up is being provided.
- Toilets are mechanical ventilated.
- All lifts shall have 100% power back-up.
- All electrical installations shall be as per provision of nbc.
- Fire-fighting/safety provisions will be as per relevant nbc provisions.
- Basement area shall have mechanically ventilated as per relevant code.
- All toilets are ventilated as per haryana building code 2017.
- Building has automatic sprinkler system wherever required by nbc.
- Building will be designed (structures) as per relevant i.s. codes for earthquake resistance.
- Solar panels of required capacity shall be provided on roof top as per haryana/zoning norms.
- All handicap ramps with railing.
- All fire fighting installations shall be as per provision of nbc.
- The rainwater harvesting system shall be provided as per central ground water Authority norms.

STILT/GROUND FLOOR (F.A.R.) - TOWER T4

S.NO. WIDTH (M) LENGTH (M) NOS. AREA (SqM)

ADDITIONS				
A	0.850	1.475	1	1.254
B	0.575	2.120	1	1.219
C	1.350	1.050	1	1.418
D	7.265	17.990	1	130.697
E	0.475	1.245	2	1.183
F	0.985	9.900	1	9.752
G	1.970	1.450	1	2.857
H	4.975	6.270	1	31.193
I	1.970	1.675	1	3.300
J	3.760	0.200	1	0.752
K	0.805	2.100	1	1.691
M	3.595	2.800	1	10.066
N	2.350	1.970	1	4.630
O	15.140	6.550	1	99.167
P	0.850	1.475	1	1.254
Q	7.875	7.350	1	57.881
R	1.000	0.450	1	0.450
S	1.450	0.250	1	0.363
T	0.250	1.000	1	0.250
U	2.650	3.780	1	10.017
V	1.665	0.150	1	0.250
W	0.300	0.600	1	0.180
TOTAL ADDITIONS				369.821

SUBTRACTIONS

1	0.835	2.500	1	2.088
2	0.665	1.000	1	0.665
3	1.390	1.500	1	2.085
4	0.700	1.000	1	0.700
5	0.500	3.600	1	1.800
TOTAL SUBTRACTIONS				7.338
TOTAL F.A.R.				362.483

FIRE FIGHTING PIPE LEGEND:-

A1	1500 FIRE HYDRANT PIPE FOR ZONE-1
A2	1500 FIRE HYDRANT PIPE FOR ZONE-2
A3	1500 FIRE HYDRANT PIPE FOR ZONE-3
A4	1500 FIRE HYDRANT PIPE FOR ZONE-4
B1	1500 SPRINKLER PIPE FOR ZONE-1
B2	1500 SPRINKLER PIPE FOR ZONE-2
B3	1500 SPRINKLER PIPE FOR ZONE-3
B4	1500 SPRINKLER PIPE FOR ZONE-4
C1	1500 SPRINKLER PIPE FOR ZONE-1 (STAND BY)
C2	1500 SPRINKLER PIPE FOR ZONE-2 (STAND BY)
C3	1500 SPRINKLER PIPE FOR ZONE-3 (STAND BY)
C4	1500 SPRINKLER PIPE FOR ZONE-4 (STAND BY)
D	800 DRAIN PIPE
E	1500 FIRE DOWN COMER
FHC	FIRE HOSE CABINET

NOTES:-

- REFER DRAWING NO. AR-T4-201 & 202 FOR ELEVATIONS
- REFER DRAWING NO. AR-T4-301 FOR SECTIONS

TOWER-T4 F.A.R. SUMMARY (SqM)

FLOOR NO.	AREA (SqM)
TOTAL F.A.R. AT STILT/GROUND FLOOR	362.483
TOTAL F.A.R. AT 1ST FLOOR	555.086
TOTAL F.A.R. AT SECOND FLOOR	555.086
TOTAL F.A.R. AT THIRD FLOOR	555.086
TOTAL F.A.R. AT FOURTH FLOOR	555.086
TOTAL F.A.R. AT FIFTH FLOOR	555.086
TOTAL F.A.R. AT SIXTH FLOOR	555.086
TOTAL F.A.R. AT SEVENTH FLOOR	555.086
TOTAL F.A.R. AT EIGHTH FLOOR	555.086
TOTAL F.A.R. AT NINTH FLOOR	555.086
TOTAL F.A.R. AT TENTH FLOOR	555.086
TOTAL F.A.R. AT ELEVENTH FLOOR	555.086
TOTAL F.A.R. AT TWELFTH FLOOR	555.086
TOTAL F.A.R. AT THIRTEENTH FLOOR	555.086
TOTAL F.A.R. AT FOURTEENTH FLOOR	555.086
TOTAL F.A.R. AT FIFTEENTH FLOOR	555.086
TOTAL F.A.R. AT SIXTEENTH FLOOR	555.086
TOTAL F.A.R. AT REFUGEE-01 FLOOR	555.086
TOTAL F.A.R. AT EIGHTEENTH FLOOR	555.086
TOTAL F.A.R. AT NINETEENTH FLOOR	555.086
TOTAL F.A.R. AT TWENTIETH FLOOR	555.086
TOTAL F.A.R. AT TWENTY FIRST FLOOR	555.086
TOTAL F.A.R. AT TWENTY SECOND FLOOR	555.086
TOTAL F.A.R. AT TWENTY THIRD FLOOR	555.086
TOTAL F.A.R. AT TWENTY FOURTH FLOOR	555.086
TOTAL F.A.R. AT TWENTY FIFTH FLOOR	555.086
TOTAL F.A.R. AT REFUGEE-02 FLOOR	555.086
TOTAL F.A.R. AT TWENTY SEVENTH FLOOR	555.086
TOTAL F.A.R. AT TWENTY EIGHTH FLOOR	555.086
TOTAL F.A.R. AT TWENTY NINTH FLOOR	555.086
TOTAL F.A.R. AT THIRTIETH FLOOR	555.086
TOTAL F.A.R. AT THIRTY FIRST FLOOR	555.086
TOTAL F.A.R. AT THIRTY SECOND FLOOR	555.086
TOTAL F.A.R. AT THIRTY THIRD FLOOR	555.086
TOTAL F.A.R. AT THIRTY FOURTH FLOOR	555.086
TOTAL F.A.R. AT REFUGEE-03 FLOOR	555.086
TOTAL F.A.R. AT THIRTY SIXTH FLOOR	555.086
TOTAL F.A.R. AT THIRTY SEVENTH FLOOR	555.086
TOTAL F.A.R. AT THIRTY EIGHTH FLOOR	555.086
TOTAL F.A.R. AT THIRTY NINTH FLOOR	555.086
TOTAL F.A.R. AT FORTIETH FLOOR	555.086
TOTAL ADDITIONS	22565.933

TOWER-T4 FLOOR LEVELS

FLOOR NO.	DU	SERVICE PERSONNEL UNIT	LEVEL (MM)
STILT/GROUND FLOOR LEVEL	LOBBY		750
FIRST FLOOR LEVEL	2	1	6750
SECOND FLOOR LEVEL	2	1	10150
THIRD FLOOR LEVEL	2	1	13550
FOURTH FLOOR LEVEL	2	1	16950
FIFTH FLOOR LEVEL	2	1	20350
SIXTH FLOOR LEVEL	2	1	23750
SEVENTH FLOOR LEVEL	2	1	27150
EIGHTH FLOOR LEVEL	2	1	30550
NINTH FLOOR LEVEL	2	1	33950
TENTH FLOOR LEVEL	2	1	37350
ELEVENTH FLOOR LEVEL	2	1	40750
TWELFTH FLOOR LEVEL	2	1	44150
THIRTEENTH FLOOR LEVEL	2	1	47550
FOURTEENTH FLOOR LEVEL	2	1	50950
FIFTEENTH FLOOR LEVEL	2	1	54350
SIXTEENTH FLOOR LEVEL	2	1	57750
REFUGEE-01 FLOOR LEVEL	2	1	61150
EIGHTEENTH FLOOR LEVEL	2	1	64550
NINETEENTH FLOOR LEVEL	2	1	67950
TWENTIETH FLOOR LEVEL	2	1	71350
TWENTY FIRST FLOOR LEVEL	2	1	74750
TWENTY SECOND FLOOR LEVEL	2	1	78150
TWENTY THIRD FLOOR LEVEL	2	1	81550
TWENTY FOURTH FLOOR LEVEL	2	1	84950
TWENTY FIFTH FLOOR LEVEL	2	1	88350
REFUGEE-02 FLOOR LEVEL	2	1	91750
TWENTY SEVENTH FLOOR LEVEL	2	1	95150
TWENTY EIGHTH FLOOR LEVEL	2	1	98550
TWENTY NINTH FLOOR LEVEL	2	1	101950
THIRTIETH FLOOR LEVEL	2	1	105350
THIRTY FIRST FLOOR LEVEL	2	1	108750
THIRTY SECOND FLOOR LEVEL	2	1	112150
THIRTY THIRD FLOOR LEVEL	2	1	115550
THIRTY FOURTH FLOOR LEVEL	2	1	118950
REFUGEE-03 FLOOR LEVEL	2	1	122350
THIRTY SIXTH FLOOR LEVEL	2	1	125750
THIRTY SEVENTH FLOOR LEVEL	2	1	129150
THIRTY EIGHTH FLOOR LEVEL	2	1	132550
THIRTY NINTH FLOOR LEVEL	2	1	135950
FORTIETH FLOOR LEVEL	2	1	139350
TOTAL UNITS	80	40	

This is a "PROVISIONAL BUILDING PLAN" approved only for the purpose of inviting objections from the general public.


S.T.P. (HQ) Member Secretary B.P.A.C.

S.T.P. (G) Member B.P.A.C.

C.T.P. (H) Chairman B.P.A.C.

TO BE READ WITH THIS OFFICE MEMO NO. DATED:

KEY: D.T.P. (HQ) P.A. A.T.P. J.D.T. (HQ) MEMBER

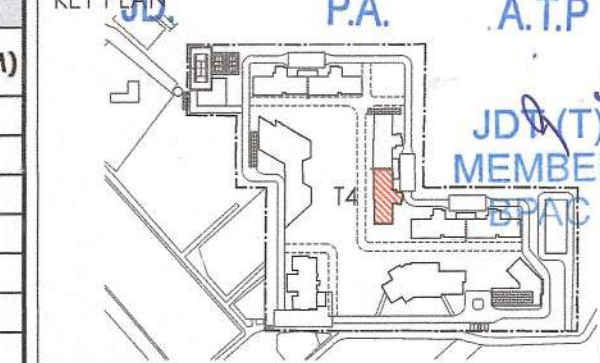

NOTES

DOOR/WINDOW SCHEDULE (TOWERS)

S. NO.	DOOR NO.	WIDTH	UNIT	CILL	LOCATION	FIRE RATINGS
1	D2	1050	2400	0	Bedroom	
2	D3	900	2400	0	Kitchen	
3	D4	800	2400	0	Toilet	
4	D4	200	2400	0	GF - H.S. Shaft	
5	D9	1250	2400	0	Staircase	
EXTERNAL DOORS						
6	S01	2400	2400	0	M. Bedroom	
7	S02	2700	2400	0	Bedroom	
8	S03	1800	2400	0	Bedroom	
9	S04	2750	2400	0	Bedroom	
10	S05	3970	2400	0	Living/Dining	
11	S06	3970	2400	0	Living/Dining	
12	S07	4700	2400	0	M. Bedroom	
13	S08	3475	2400	0	M. Bedroom	
14	S09	3200	2400	0	M. Bedroom	
15	D5	1000	2400	0	WC	
16	D7	800	2400	0	WC	
17	D8	900	2400	0	Utility	
18	DW1	2875	2400	0	101200/Kitchen	
WINDOWS						
19	W1	600	2400	1200	Toilet	
20	W1	3075	2400	1200	M. Toilet	
21	W2	900	2400	1200	Utility/Bedroom	
22	W3	1250	2400	1200	Staircase	
23	W4	1740	2400	1200	Staircase	
24	W4	2400	2400	1200	M. Toilet	
25	W7	700	2400	1200	Bedroom	
26	W8	1550	2400	1200	Staircase	
27	A01	750	2400	1200	Toilet	
28	G01	800	2400	0	GF Lift Lobby	
29	G1	3380/16750/3380	5200	0	GF Lobby	
30	G2	2725	5200	0	GF Lobby	
31	G3	4070	5200	0	GF Lobby	
32	G4	350	5200	0	GF Lobby	
33	G5	2145	5200	0	GF Lobby	
34	G6	18940	5200	0	GF Lobby	
35	G7	2279/4400	5200	0	GF Lobby	
36	G8	5380/7075/6250	5200	0	GF Lobby	
37	G9	2500	5200	0	GF Lobby	
38	G10	800	2400	0	M. Bedroom	
39	G11	6575/12200/10880	5200	0	GF Lobby	
40	G12	500	5200	0	GF Lobby	
41	G13	4000/1050	5200	0	GF Lobby	
42	G14	2695	5200	0	GF Lobby	
43	G15	6472/9260	5200	0	GF Lobby	
FIRE DOORS AND WINDOW						
44	F01	1500	2400	0	Entrance	1hr
45	F02	1250	2400	0	Staircase/Fire Lobby	2hrs
46	F03	1000	2400	75	M.V. Shaft	2hrs
47	F04	900	2400	75	LV Shaft	2hrs
48	F05	900	2400	0	Utility/Service	1hr
49	F06	1000	2400	0	Utility	1hr
50	F07	600	2400	75	AC. Ret. Shaft	2hrs
51	F08	900	2400	1200	Staircase	2hrs
52	F09	1250	2400	1200	Staircase	2hrs
53	F10	1740	2400	1200	Staircase	2hrs
54	F11	700	2400	1200	Staircase	2hrs
55	F12	900	2400	75	FHC Shaft	2hrs
56	F13	1200	2400	75	FHC Shaft	2hrs

CLIENT

Birla Estates Pvt. Ltd. in collaboration with Barmalt India Pvt. Ltd.

PROOF CHECK CONSULTANT

Skeeton Consultants Pvt. Ltd.

2nd Floor, A-75, Sector 5, Noida, Uttar Pradesh-201301

GEO TECHNICAL CONSULTANT

Cengra Geotechnica Pvt. Ltd.

A-100, Sector 63, Noida, Uttar Pradesh-201309

STRUCTURES

WHITBY WOOD PRITAMDASANI, MUMBAI

Unit 1101 | Lodha Supremus | Powai, Andheri (East) | Mumbai-400072 | Maharashtra | India

T: +91-9820-186879

m.pritamdasani@whitbywood.com

MEP

SNC. SUNIL NAYYAR CONSULTING ENGINEERS LLP

206-206A & 305A-305B, 2nd & 3rd Floor

Sector 54 | Gurgaon-122002 | Haryana | India

T: +91-124-4803800

Email: sncgurgaon@snc.co.in

LANDSCAPE

SWA, LAGUNA BEACH

570 | Glenneyre Street | Laguna

Beach | California-92651 | USA

(Internal) +91-99-54711111 | T: +91-99-54711111

in forw: www.swagroup.com

ARCHITECTS

Arcop Associates Pvt. Ltd.

Plot: 46, Sector-32, Gurgaon-122001

Ph: 24242050, 26242169

Mumbai, Toronto, New Delhi, Boston

PROFESSIONAL ENGINEER (H)