



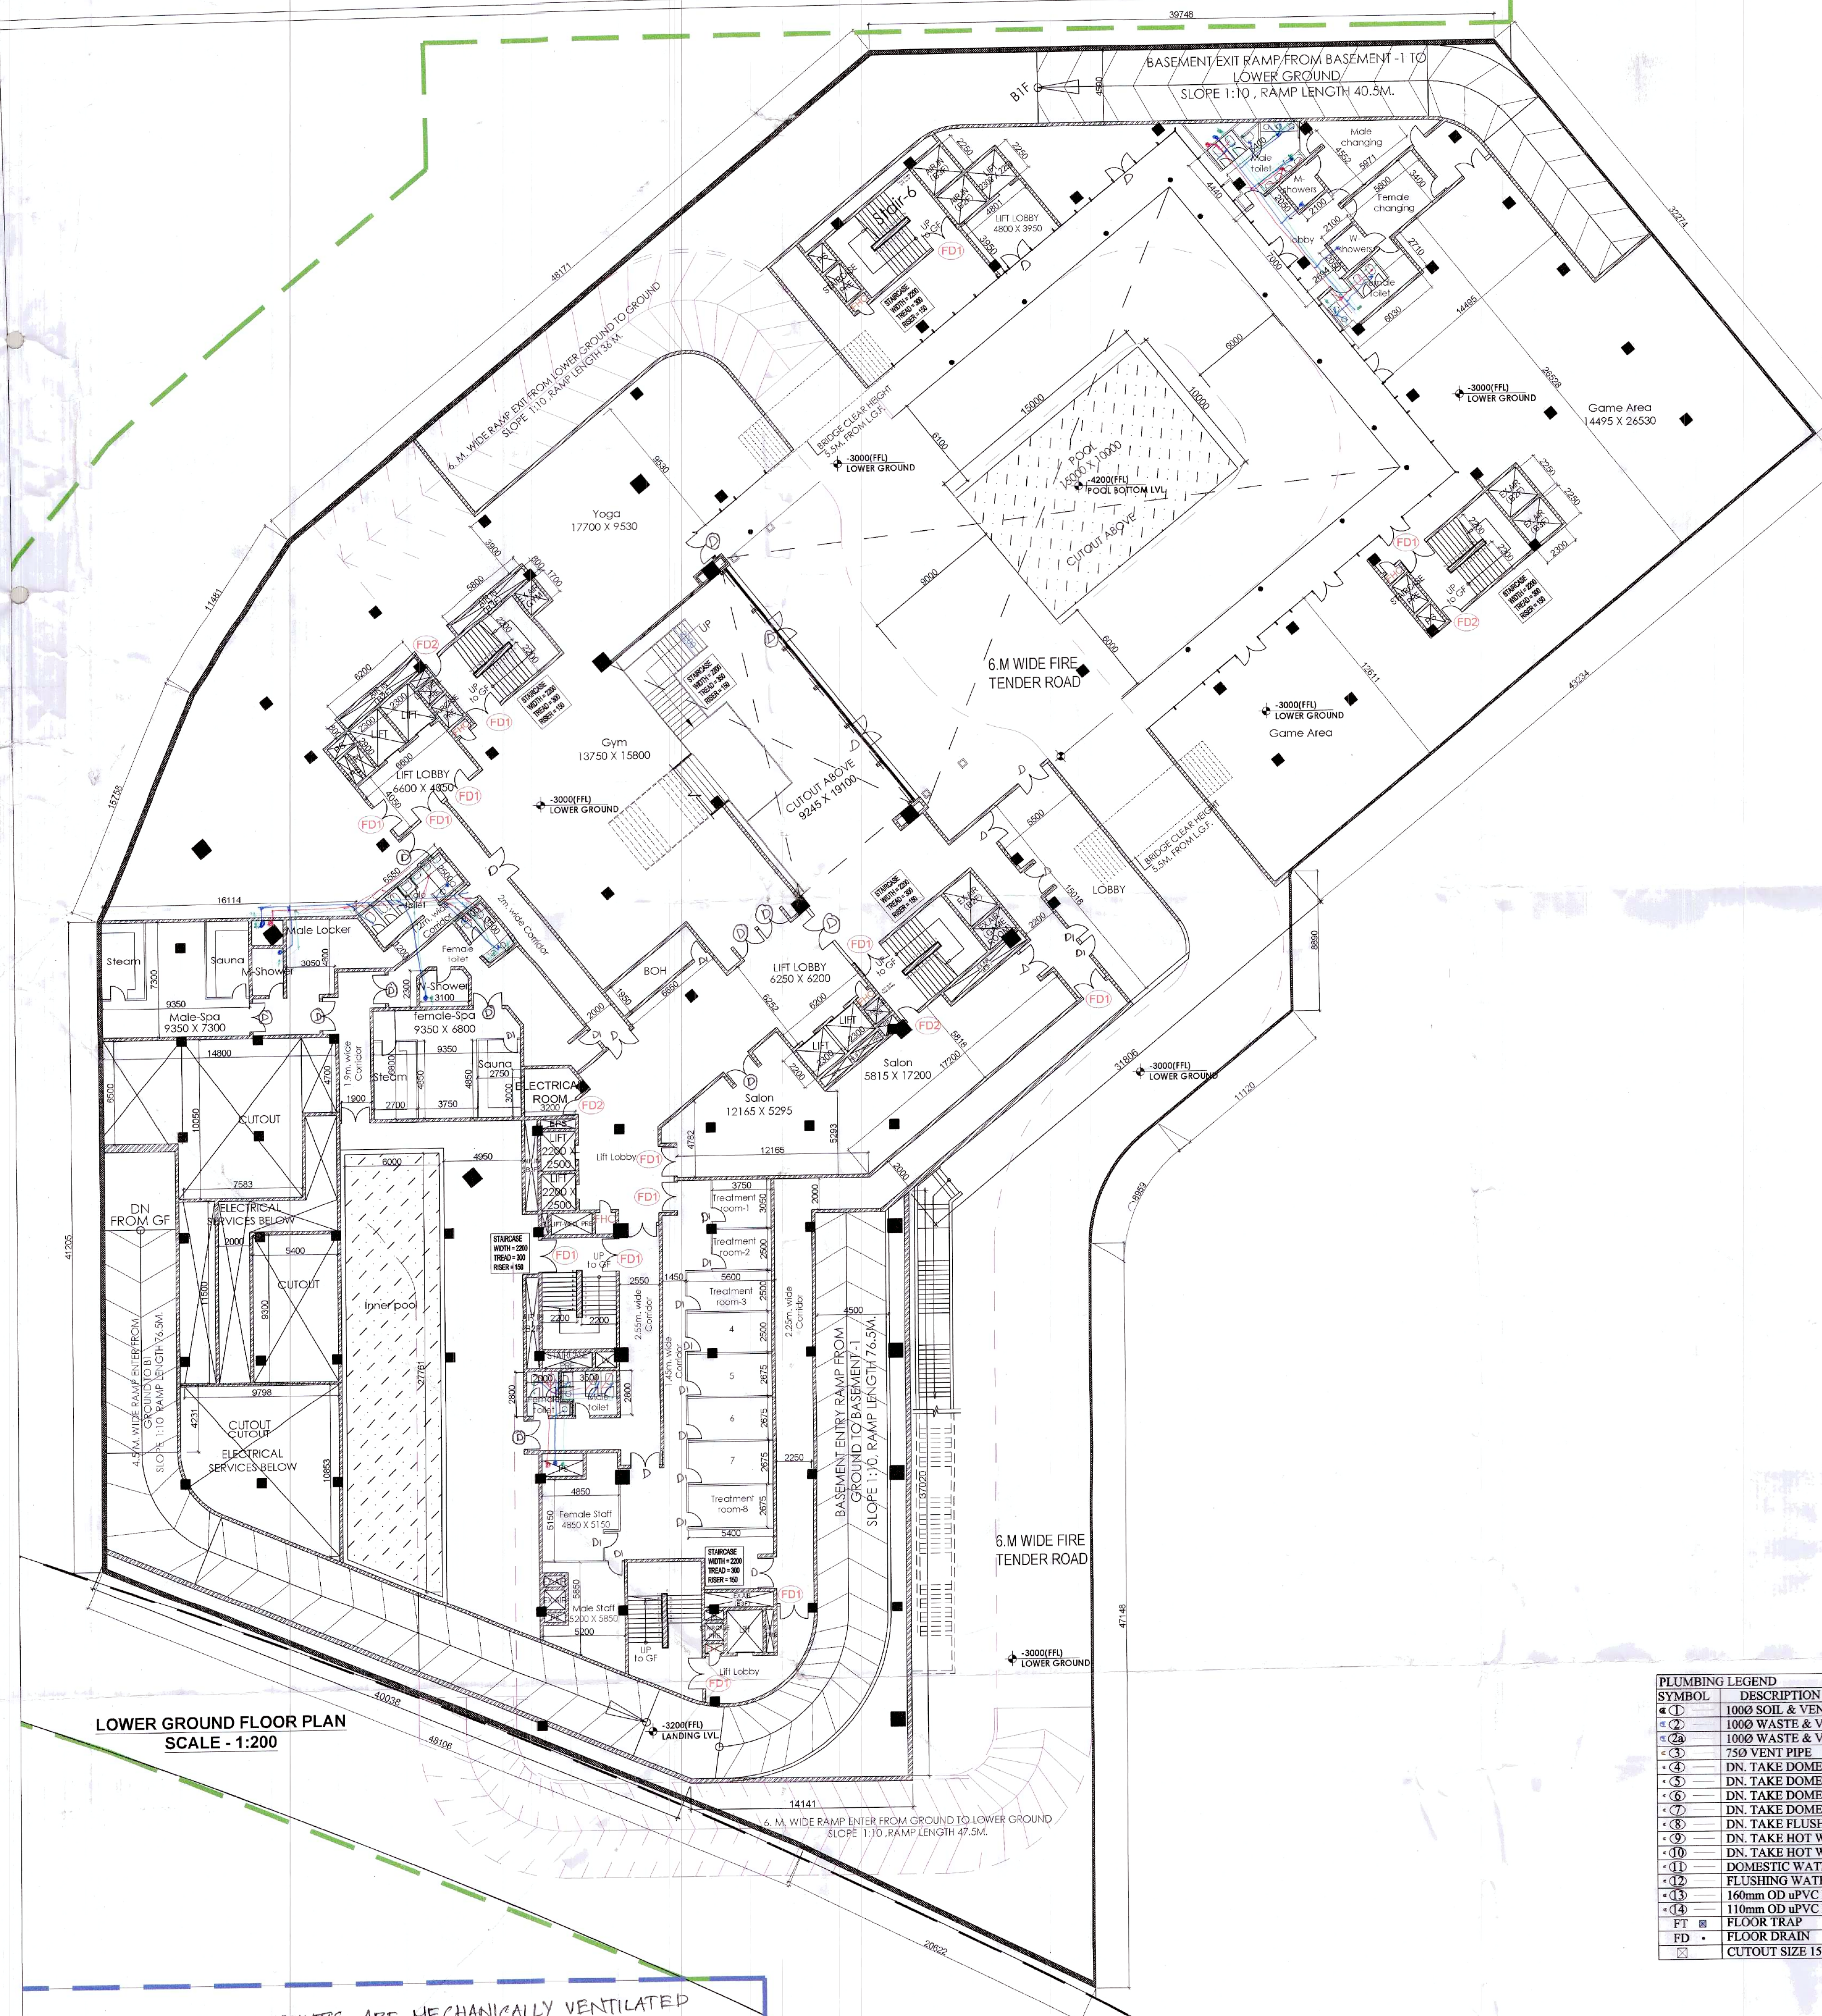

SYMBOL	DESCRIPTION
1	1000 SOIL & VENT PIPE
2	1000 WASTE & VENT PIPE
3	1000 WASTE & VENT PIPE FOR KITCHEN
4	750 VENT PIPE
5	DN. TAKE DOMESTIC WATER SUPPLY FOR TOP THREE FLOOR
6	DN. TAKE DOMESTIC WATER SUPPLY
7	DN. TAKE DOMESTIC WATER SUPPLY
8	DN. TAKE DOMESTIC WATER SUPPLY
9	DN. TAKE DOMESTIC WATER SUPPLY
10	DN. TAKE HOT WATER SUPPLY
11	DN. TAKE HOT WATER RETURN
12	DOMESTIC WATER SUPPLY RISER
13	FLUSHING WATER SUPPLY RISER
14	160mm OD uPVC RAIN WATER PIPE FOR TERRACE
15	110mm OD uPVC RAIN WATER PIPE FOR BALCONY
16	FLOOR TRAP
17	FLOOR DRAIN
18	CUTOUT SIZE 150x150mm

LEGEND	LENGTH (m)	WIDTH (m)	Nos.	AREA (sqm)
ADDITIONS				
A	13.850	18.836	1	260.879
B	9.150	7.320	0.5	33.489
C	9.150	11.516	1	105.371
D	21.850	17.480	0.5	190.959
E	21.850	17.036	1	372.237
F	44.850	15.268	1	684.770
G	24.070	15.268	1	367.501
H	35.134	35.536	1	1248.522
I	7.851	12.536	1	98.420
K	10.262	6.300	1	64.651
L	14.796	6.300	0.5	46.607
M	4.405	10.457	0.5	9.420
N	4.405	17.799	1	78.405
Q	22.605	28.296	0.5	319.363
R	19.085	15.268	0.5	145.695
S	37.309	22.112	1	824.977
T	37.309	15.400	0.5	287.279
U	14.141	37.512	1	530.457
TOTAL ADDITIONS				5692.043
SUBTRACTIONS OF CUTOUT AREA				
1	4.790	6.477	1	31.025
2	7.810	10.047	1	78.467
3	1.789	10.281	1	18.357
4	5.388	2.000	1	10.776
5	2.211	11.500	1	25.427
6	2.000	11.500	1	23.000
7	5.189	9.300	1	48.258
8	9.800	7.045	1	69.041
9	9.800	4.045	0.5	19.821
TOTAL SUBTRACTIONS OF CUTOUT AREA				324.171
SUBTRACTIONS OF SERVICE AREA				
Z1	13.707	6.000	1	82.242
Z2	3.980	4.500	0.5	9.955
Z3	33.540	4.500	1	150.996
Z4	2.163	4.500	0.5	4.867
Z5	2.141	4.500	0.5	4.817
Z6	13.521	4.500	1	60.845
Z7	24.800	1.800	2	89.280
Z8	23.000	1.800	1	41.400
Z9	4.500	22.156	1	99.702
Z10	4.500	2.947	0.5	6.531
Z11	3.035	4.441	0.5	6.739
Z12	34.943	4.441	1	155.182
Z13	2.123	4.441	0.5	4.714
Z14	8.021	4.482	1	35.790
Z15			1	7.720
Z16	5.761	35.778	1	206.117
TOTAL SUBTRACTIONS OF SERVICE AREA				965.966
TOTAL SUBTRACTIONS				1290.137
COMMUNITY BUILDING LOWER GROUND FLOOR PLAN (F.A.R. AREA)				4401.906
COMMUNITY BUILDING LOWER GROUND FLOOR PLAN (BUILDUP AREA)				5367.872

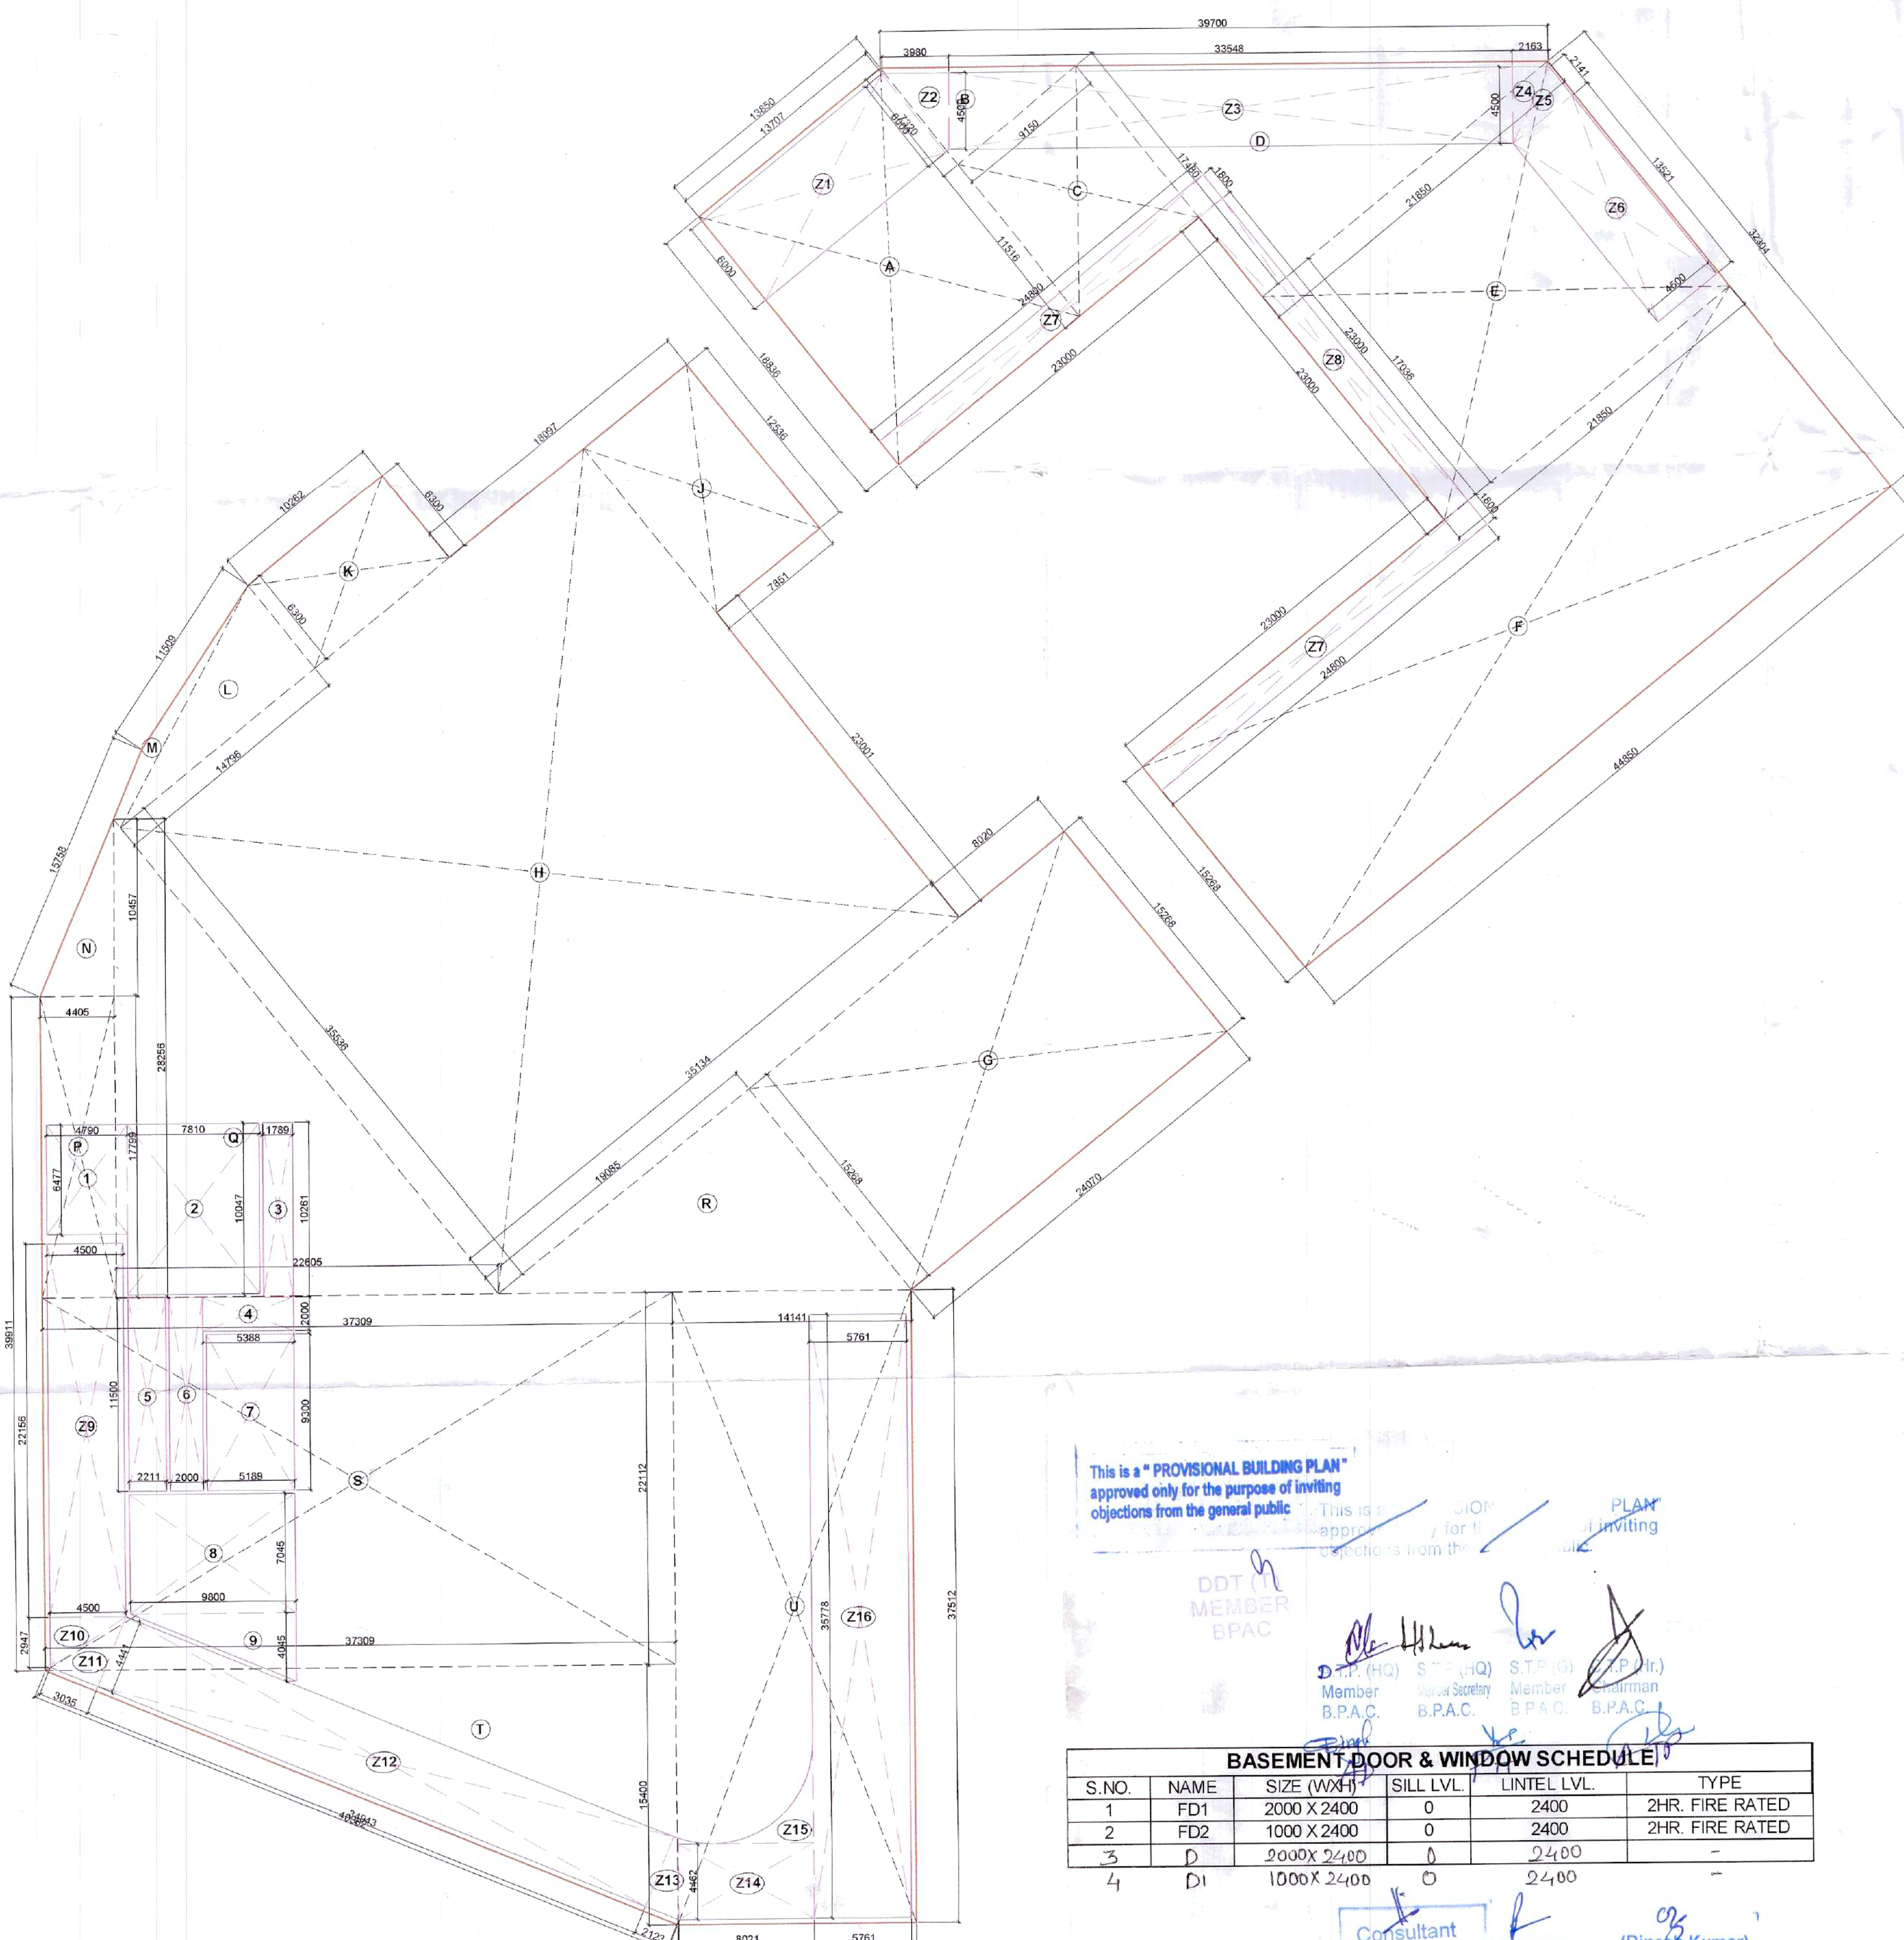

This is a "PROVISIONAL BUILDING PLAN" approved only for the purpose of inviting objections from the general public.


Sanctioned
Read with this office
10.

S.NO.	NAME	SIZE (WxH)	SILL LVL	LINTEL LVL	TYPE
1	FD1	2000 X 2400	0	2400	2HR. FIRE RATED
2	FD2	1000 X 2400	0	2400	2HR. FIRE RATED
3	D	2000 X 2400	0	2400	-
4	D1	1000 X 2400	0	2400	-

Sanctioned
Read with this office
10.

AUTHORITY STAMP:
This is a "PROVISIONAL BUILDING PLAN" approved only for the purpose of inviting objections from the general public.

A.T.P. (H.Q.) S.T.P. (H.Q.) S.T.P. (G) C.T.P. (H.)
Member Secretary Member Chairman
B.P.A.C. B.P.A.C. B.P.A.C. B.P.A.C.

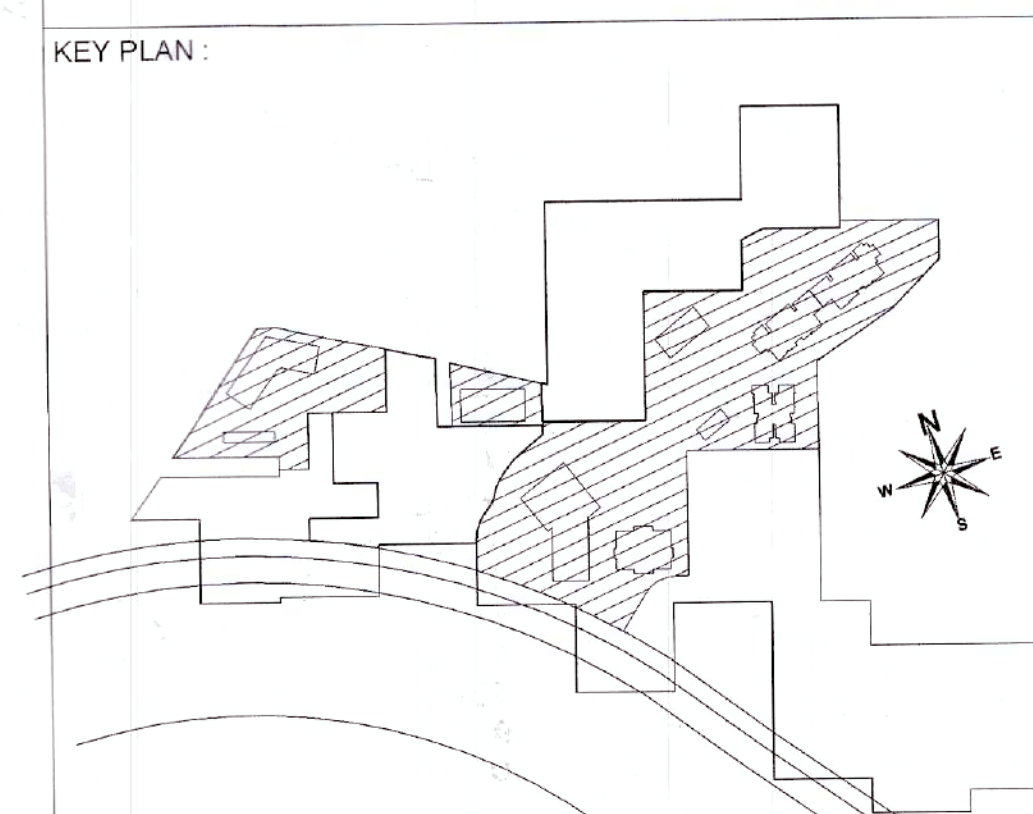

PROJECT ARCHITECT:
rajeev agarwal architects
J-1965, chittaranjan park
new delhi - 110019
tel: 011-40526848
website: www.rajeevagarwal.com

STRUCTURE
NNC DESIGN INTERNATIONAL
NNC CONSULTING STRUCTURAL ENGINEERS
270, 2nd Floor, ANANTY PLAZA, Near BHEL KPO
MAHARASHTRA, PUNE-411 004, INDIA. NEW DELHI-110025
PHONE NO. : +91-11-2640742/4/7/8 FAX: 2640708
E-Mail : nnc_consultants@yahoo.co.uk
Web : www.nncdesigninternational.com

MEP Consultants
PDA
190, 2nd Floor, F.I.E. Patparganj
Industrial Area, Delhi-110029
M: 917071532 Tel/Fax:
+91-11-4240301-2

PROJECT LANDSCAPE CONSULTANTS
Greenbox Designs
P-123, DLF City Phase 2
Gurgaon
Haryana, India

PROJECT TITLE
REVISED BUILDING PLANS OF GROUP HOUSING COLONY
UNDER TOD POLICY DATED 09.02.2016 FOR THE AREA
MEASURING 30.38125 ACRES (LICENCE NO.39 OF 2013 DATED
04-05-2013) GRANTED FOR 25.10 ACRES & LICENCE NO. 85 OF
2014 DATED 08.08.2014 GRANTED FOR 2.38125 ACRES AND
ADDITIONAL AREA MEASURING 2.90 ACRES (LICENCE NO. 166
OF 2023 DATED 18.08.2023) IN SECTOR-36-A
GURGAON MANESAR URBAN COMPLEX BEING
DEVELOPED BY KRISUMI CORPORATION PVT. LTD.

ARCHITECT'S SIGNATURE / STAMP:
RAJEEV KUMAR AGARWAL
ARCHITECT CA/881/015

STRUCTURE CONSULTANT SIGNATURE / STAMP:

Checked and found ok for Public Health
(Urban) Service only subject to comments in
the forwarding letter to Sany on 26/11/23

OWNER SIGNATURE / STAMP:
For KRISUMI CORPORATION PVT.LTD.
Authorized Signatory

DRAWING TITLE :
**COMMUNITY BUILDING
LOWER GROUND FLOOR PLAN**

SCALE
1:200 (A0)
DATE
04-SEPTEMBER-2023
DRAWING NO.
PH3 - CM-01

RELEASED FOR -
☐ INFORMATION
☐ EIA
☐ TENDER
☐ ADVANCE COPY
☒ SUBMISSION DRG
☐ GFC