


Building Plans Approved by  
 Director of Urban Planning & Development  
 City of Gurgaon, Haryana No. 1216/6  
 Date: 24/10/2025, To: 23/10/2025  
 Call: 01299-420000  
 www.gurgaon.com  
 H. Dhillon  
 Recommended by Station  
 ATP - S.A.E.  
 H. Dhillon

**PLUMBING LEGEND**

S. NO.	SYMBOL	DESCRIPTION
1	1000	1000mm DIA. PIPE
2	1500	1500mm DIA. PIPE
3	2000	2000mm DIA. PIPE
4	2500	2500mm DIA. PIPE
5	3000	3000mm DIA. PIPE
6	4000	4000mm DIA. PIPE
7	5000	5000mm DIA. PIPE
8	6000	6000mm DIA. PIPE
9	8000	8000mm DIA. PIPE
10	10000	10000mm DIA. PIPE
11	12000	12000mm DIA. PIPE
12	15000	15000mm DIA. PIPE
13	20000	20000mm DIA. PIPE
14	25000	25000mm DIA. PIPE
15	30000	30000mm DIA. PIPE
16	40000	40000mm DIA. PIPE
17	50000	50000mm DIA. PIPE
18	60000	60000mm DIA. PIPE
19	80000	80000mm DIA. PIPE
20	100000	100000mm DIA. PIPE
21	120000	120000mm DIA. PIPE
22	150000	150000mm DIA. PIPE
23	200000	200000mm DIA. PIPE
24	250000	250000mm DIA. PIPE
25	300000	300000mm DIA. PIPE
26	400000	400000mm DIA. PIPE
27	500000	500000mm DIA. PIPE
28	600000	600000mm DIA. PIPE
29	800000	800000mm DIA. PIPE
30	1000000	1000000mm DIA. PIPE
31	1200000	1200000mm DIA. PIPE
32	1500000	1500000mm DIA. PIPE
33	2000000	2000000mm DIA. PIPE
34	2500000	2500000mm DIA. PIPE
35	3000000	3000000mm DIA. PIPE
36	4000000	4000000mm DIA. PIPE
37	5000000	5000000mm DIA. PIPE
38	6000000	6000000mm DIA. PIPE
39	8000000	8000000mm DIA. PIPE
40	10000000	10000000mm DIA. PIPE
41	12000000	12000000mm DIA. PIPE
42	15000000	15000000mm DIA. PIPE
43	20000000	20000000mm DIA. PIPE
44	25000000	25000000mm DIA. PIPE
45	30000000	30000000mm DIA. PIPE
46	40000000	40000000mm DIA. PIPE
47	50000000	50000000mm DIA. PIPE
48	60000000	60000000mm DIA. PIPE
49	80000000	80000000mm DIA. PIPE
50	100000000	100000000mm DIA. PIPE
51	120000000	120000000mm DIA. PIPE
52	150000000	150000000mm DIA. PIPE
53	200000000	200000000mm DIA. PIPE
54	250000000	250000000mm DIA. PIPE
55	300000000	300000000mm DIA. PIPE
56	400000000	400000000mm DIA. PIPE
57	500000000	500000000mm DIA. PIPE
58	600000000	600000000mm DIA. PIPE
59	800000000	800000000mm DIA. PIPE
60	1000000000	1000000000mm DIA. PIPE
61	1200000000	1200000000mm DIA. PIPE
62	1500000000	1500000000mm DIA. PIPE
63	2000000000	2000000000mm DIA. PIPE
64	2500000000	2500000000mm DIA. PIPE
65	3000000000	3000000000mm DIA. PIPE
66	4000000000	4000000000mm DIA. PIPE
67	5000000000	5000000000mm DIA. PIPE
68	6000000000	6000000000mm DIA. PIPE
69	8000000000	8000000000mm DIA. PIPE
70	10000000000	10000000000mm DIA. PIPE
71	12000000000	12000000000mm DIA. PIPE
72	15000000000	15000000000mm DIA. PIPE
73	20000000000	20000000000mm DIA. PIPE
74	25000000000	25000000000mm DIA. PIPE
75	30000000000	30000000000mm DIA. PIPE
76	40000000000	40000000000mm DIA. PIPE
77	50000000000	50000000000mm DIA. PIPE
78	60000000000	60000000000mm DIA. PIPE
79	80000000000	80000000000mm DIA. PIPE
80	100000000000	100000000000mm DIA. PIPE
81	120000000000	120000000000mm DIA. PIPE
82	150000000000	150000000000mm DIA. PIPE
83	200000000000	200000000000mm DIA. PIPE
84	250000000000	250000000000mm DIA. PIPE
85	300000000000	300000000000mm DIA. PIPE
86	400000000000	400000000000mm DIA. PIPE
87	500000000000	500000000000mm DIA. PIPE
88	600000000000	600000000000mm DIA. PIPE
89	800000000000	800000000000mm DIA. PIPE
90	1000000000000	1000000000000mm DIA. PIPE
91	1200000000000	1200000000000mm DIA. PIPE
92	1500000000000	1500000000000mm DIA. PIPE
93	2000000000000	2000000000000mm DIA. PIPE
94	2500000000000	2500000000000mm DIA. PIPE
95	3000000000000	3000000000000mm DIA. PIPE
96	4000000000000	4000000000000mm DIA. PIPE
97	5000000000000	5000000000000mm DIA. PIPE
98	6000000000000	6000000000000mm DIA. PIPE
99	8000000000000	8000000000000mm DIA. PIPE
100	10000000000000	10000000000000mm DIA. PIPE

**SCHEDULE OF OPENINGS - CURB**

DOOR NO.	LOCATION	DESCRIPTION
001	STAIRCASE	1000x2000
002	ELECTRICAL SHED	1500x2000
003	PLUMBING SHED	1500x2000
004	PLUMBING SHED	1500x2000
005	PLUMBING SHED	1500x2000
100	PLUMBING SHED	1500x2000

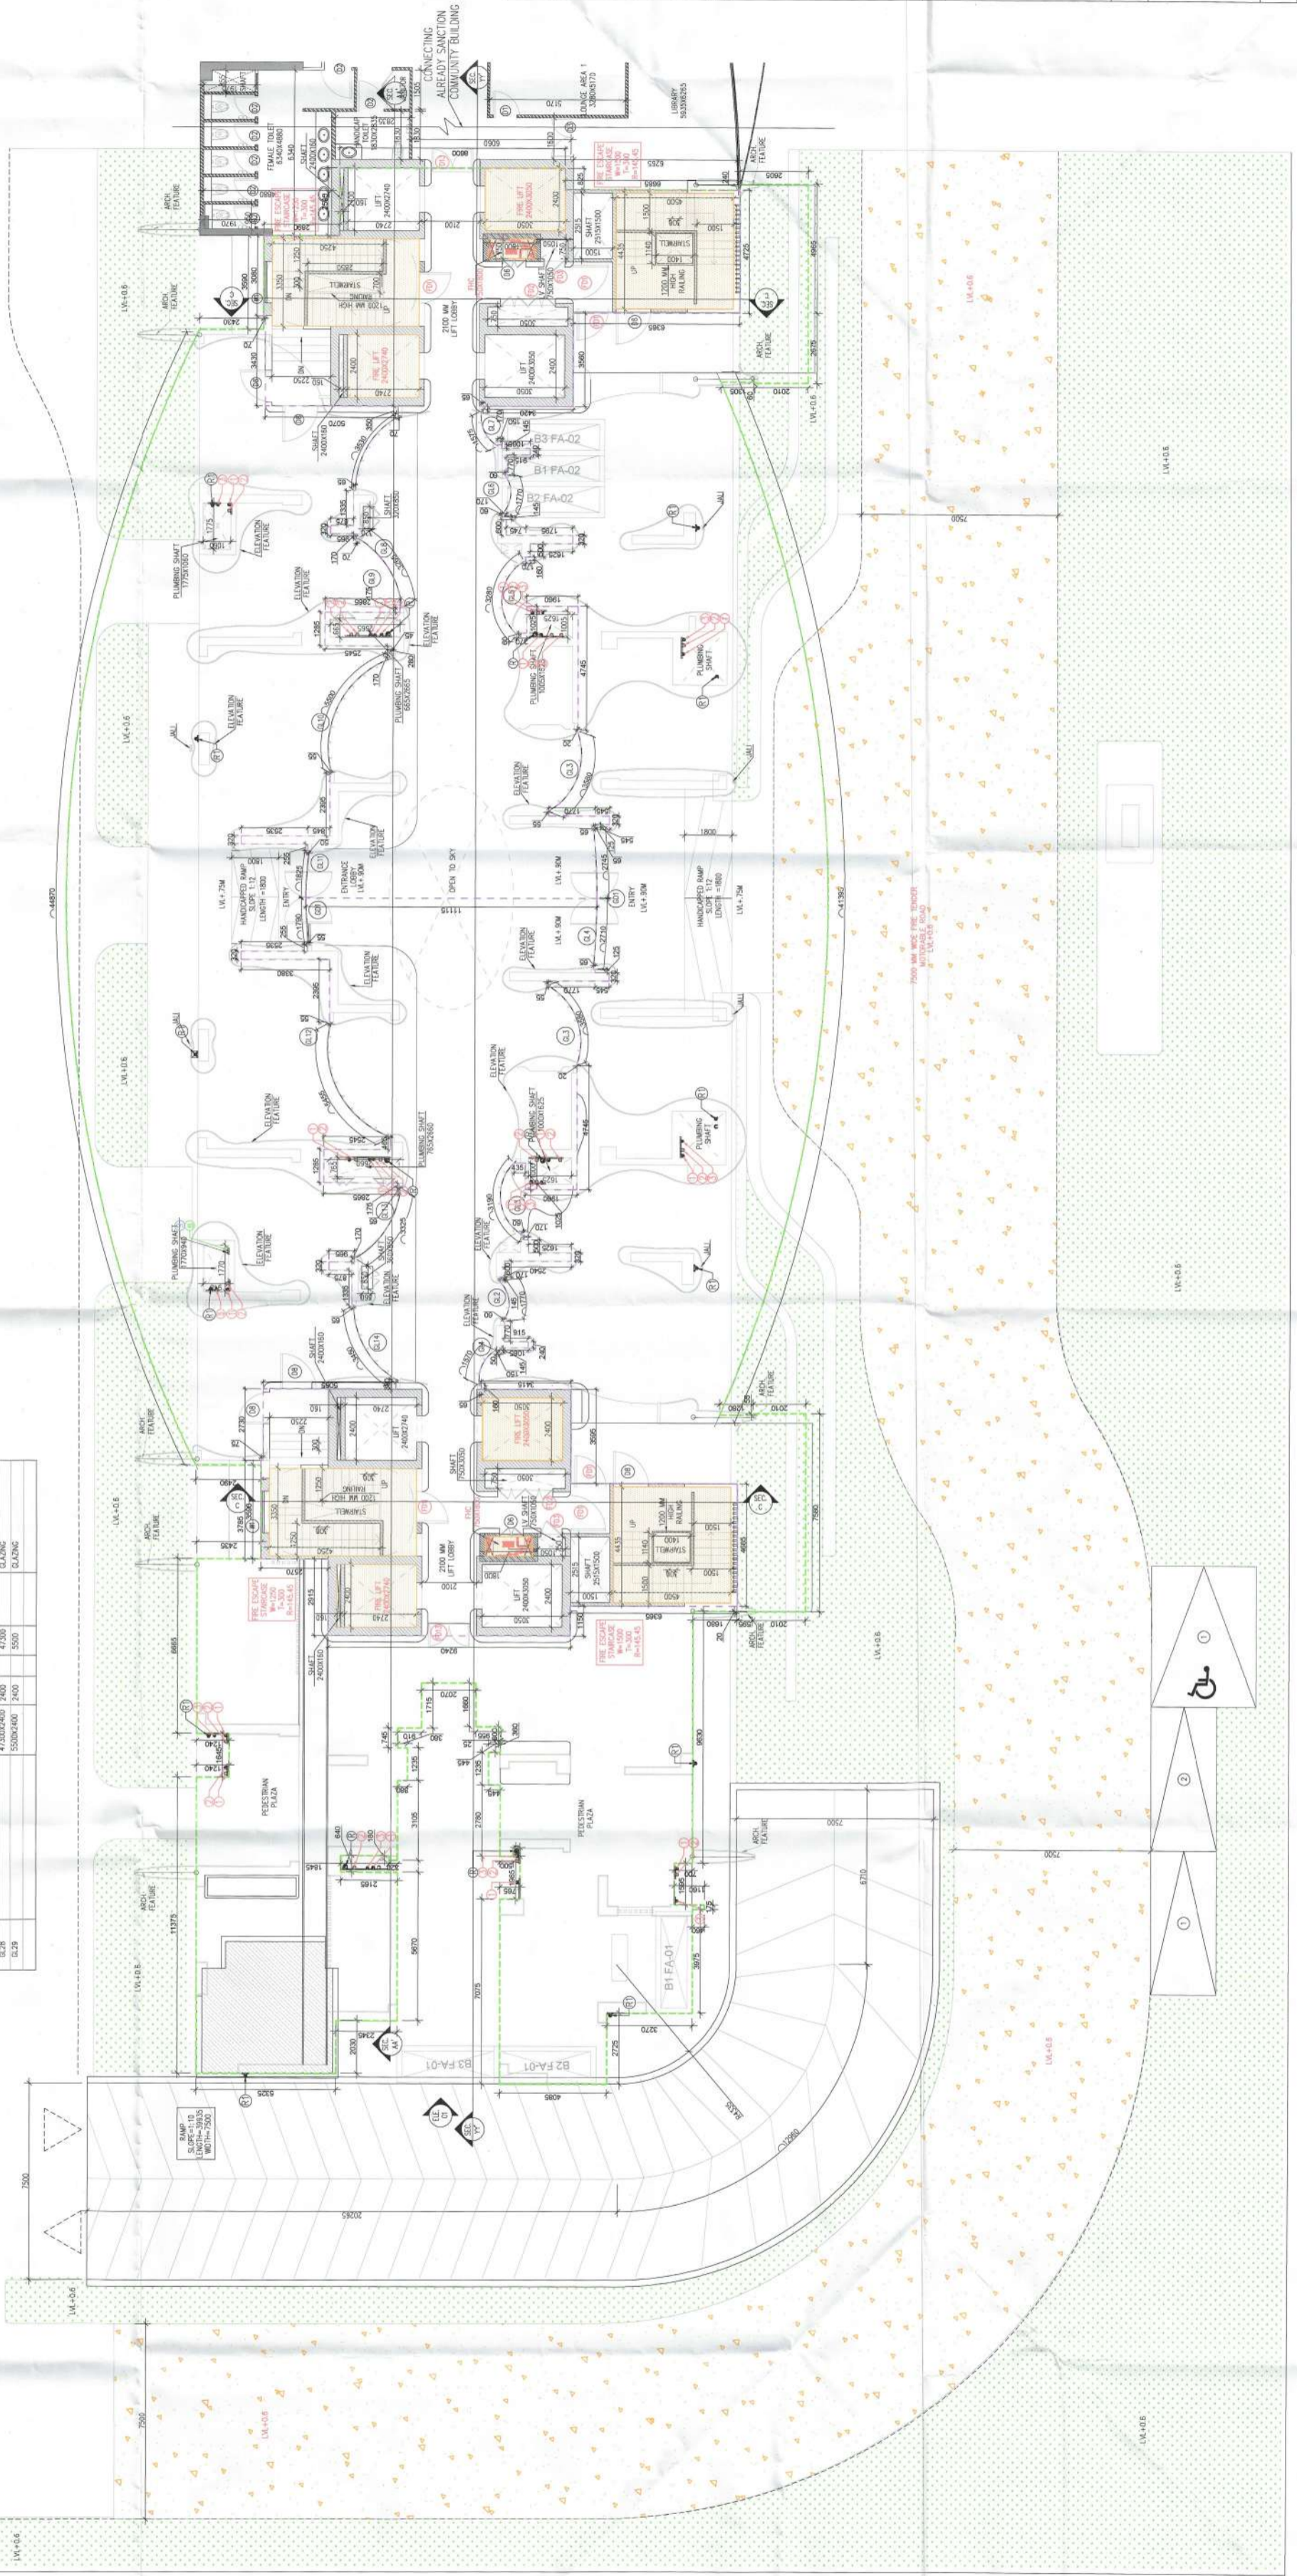

GROUND FLOOR PLAN  
 LVL=+0.90M  
 TOTAL CAR PARKING=3

**NOTE**

- BUILDING HAS AUTOMATIC SPRINKLER SYSTEM WHEREVER REQUIRED BY NBC.
- BUILDING WILL BE DESIGNED (STRUCTURES) AS PER RELEVANT IS CODES FOR EARTH QUAKE RESISTANCE.
- POWER BACKUP/ MECHANICAL VENTILATED SHAFTS.

**PROJECT:**  
 PROPOSED BUILDING PLAN FOR PHASE-2 & 2A OF GROUP HOUSING SITE PLOT NO. GH-03 SITUATED AT SECTOR-80, MANESAR AREA-ADMEASURING 22501 SQM.TS BEING DEVELOPED BY CONSCIENT INFRASTRUCTURE PVT. LTD.

ASSOCIATE ARCHITECTS

**ASSOCIATES**

PLOT NO-408 SEC-37C GURGAON (PH-956094794)

OWNER'S SEAL & SIGNATURE

ARCHITECT'S SEAL & SIGNATURE

Ar. Anshul Kumar  
 CA2012386011  
 REGD. NO. 1010473

Scale - 1:100

Drawing No. - GF-01

GROUND FLOOR PLAN