

Note :-
1. BUILDING WILL BE DESIGNED (STRUCTURES) AS PER RELEVANT IS CODES FOR EARTH QUAKE RESISTANCE.

PROJECT
REVISED BUILDING PLANS OF COMMERCIAL COLONY (TD) MEASURING 17.4875 ACRES (LICENSE NO. 241 OF 2007 DATED 25.10.2007 & LICENSE NO. 241 OF 2007 DATED 25.10.2007 & LICENSE NO. 199 OF 2008 DATED 12.2008) TALLING 24.7772 ACRES IN 199 BEING DEVELOPED BY PIONEER URBAN LAND & INFRASTRUCTURE LTD.

CLIENT
PIONEER URBAN LAND & INFRASTRUCTURE LTD.
Pioneer Urban
Ground Floor
Course Extension Road,
Sector-62,
Gurgaon - 122001, Haryana

DESIGN ARCHITECT
RSP
RSP Design consultants
103, First Floor, Bhandari Business Tower, Sector-48, Sarina Road
Gurgaon, 122018, India. TEL: 47626618 FAX: 4762618
HEAD OFFICE: 103/A, MUSEUM ROAD, BANGALORE-560 001
TEL: 25668888 FAX: 2566888
EMAIL: rsp@rspindia.com, www.rspindia.net

ASSOCIATE ARCHITECT
RISIMIS ARCHITECTS
RSMS ARCHITECTS PVT. LTD.
69, Nara Nivas Bhawani Kunj
(Behind D2), Vasant Kunj,
New Delhi-110070.
Tel: 011-26889816, 26889817
www.rsms-arch.com


MEP CONSULTANT:
SUNIL MAYAR CONSULTING ENGINEERS LLP
205-206A, 2ND FLOOR, TIME CENTRE, DLF GOLF COURSE ROAD, SECTOR-54, GURGAON-122002, HARYANA (INDIA)
URL: WWW.SMECC.COM

FIRE SUBMISSION

File Printing Scheme
Date: 16/04/2025
Scale: 1:100
Job No: 2025/01/01

IT IS CERTIFIED THAT THESE DRAWINGS ARE AS PER APPROVED Dwg BY SFP (COMMERCIAL) (INDIAN NATIONAL COMMITTEE) ARCHITECTURE NO. 20-338-IP/CP/2025/1457 DATED: 13-08-2025
VIDE MEMO NO. 20-338-IP/CP/2025/1457 DATED: 13-08-2025
ARCHITECT'S SEAL & SIGNATURE
OWNER'S SEAL & SIGNATURE

APRIL - 2025 Scale : 1:100 Drawing No. -
10th (LOWER DUPLEX) FLOOR PLAN & FIRE SUBMISSION TOWER EAST
SNC-FE-2A-06
28/08/2024-13

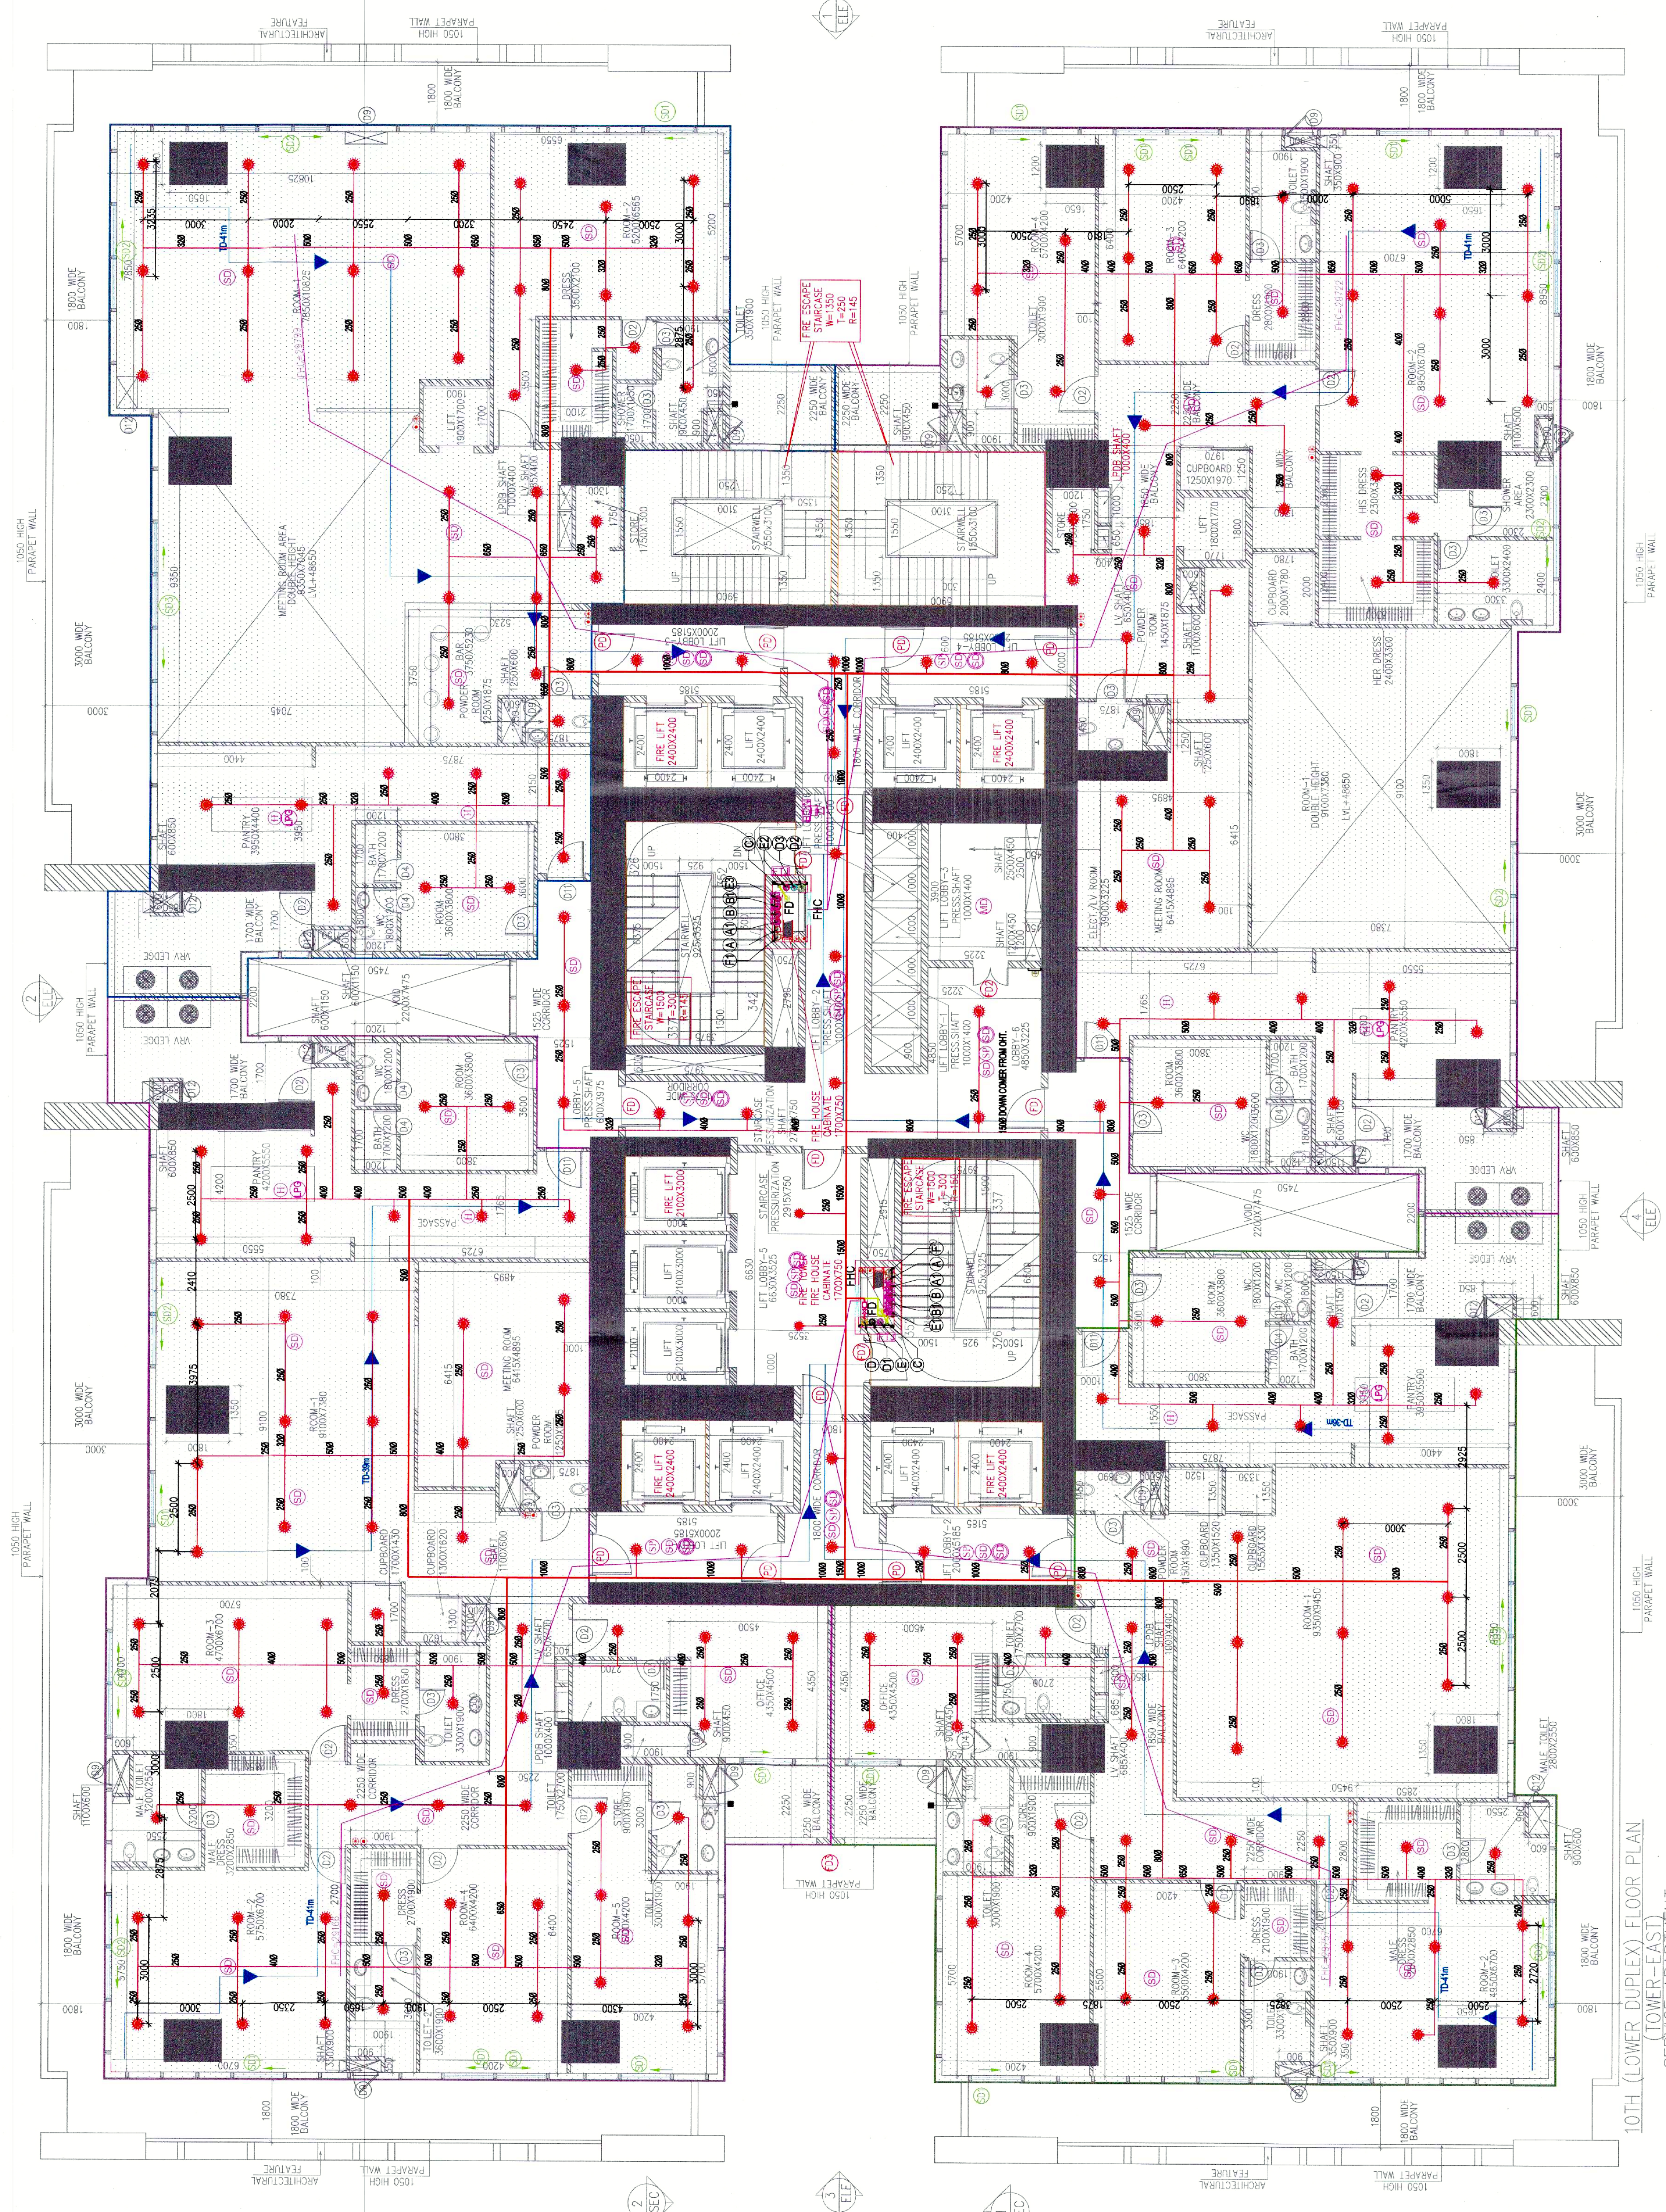

SCHEDULE OF JOINTERY

ITEM NO.	TAG	DETAILS	LOCATION
1	10	100 WIRE BALCONY FIRE ALARM DEVICE	100 WIRE BALCONY
2	11	100 WIRE BALCONY FIRE ALARM DEVICE	100 WIRE BALCONY
3	12	100 WIRE BALCONY FIRE ALARM DEVICE	100 WIRE BALCONY
100	109	100 WIRE BALCONY FIRE ALARM DEVICE	100 WIRE BALCONY

LEGEND

SYMBOL	DESCRIPTION
(A)	SMOKE DETECTOR
(B)	MANUAL CALL POINT
(C)	FIRE EXTINGUISHER
(D)	FIRE ALARM CONTROL PANEL
(E)	FIRE ALARM DEVICE
(F)	FIRE ALARM DEVICE
(G)	FIRE ALARM DEVICE
(H)	FIRE ALARM DEVICE
(I)	FIRE ALARM DEVICE
(J)	FIRE ALARM DEVICE
(K)	FIRE ALARM DEVICE
(L)	FIRE ALARM DEVICE
(M)	FIRE ALARM DEVICE
(N)	FIRE ALARM DEVICE
(O)	FIRE ALARM DEVICE
(P)	FIRE ALARM DEVICE
(Q)	FIRE ALARM DEVICE
(R)	FIRE ALARM DEVICE
(S)	FIRE ALARM DEVICE
(T)	FIRE ALARM DEVICE
(U)	FIRE ALARM DEVICE
(V)	FIRE ALARM DEVICE
(W)	FIRE ALARM DEVICE
(X)	FIRE ALARM DEVICE
(Y)	FIRE ALARM DEVICE
(Z)	FIRE ALARM DEVICE
(AA)	FIRE ALARM DEVICE
(AB)	FIRE ALARM DEVICE
(AC)	FIRE ALARM DEVICE
(AD)	FIRE ALARM DEVICE
(AE)	FIRE ALARM DEVICE
(AF)	FIRE ALARM DEVICE
(AG)	FIRE ALARM DEVICE
(AH)	FIRE ALARM DEVICE
(AI)	FIRE ALARM DEVICE
(AJ)	FIRE ALARM DEVICE
(AK)	FIRE ALARM DEVICE
(AL)	FIRE ALARM DEVICE
(AM)	FIRE ALARM DEVICE
(AN)	FIRE ALARM DEVICE
(AO)	FIRE ALARM DEVICE
(AP)	FIRE ALARM DEVICE
(AQ)	FIRE ALARM DEVICE
(AR)	FIRE ALARM DEVICE
(AS)	FIRE ALARM DEVICE
(AT)	FIRE ALARM DEVICE
(AU)	FIRE ALARM DEVICE
(AV)	FIRE ALARM DEVICE
(AW)	FIRE ALARM DEVICE
(AX)	FIRE ALARM DEVICE
(AY)	FIRE ALARM DEVICE
(AZ)	FIRE ALARM DEVICE
(BA)	FIRE ALARM DEVICE
(BB)	FIRE ALARM DEVICE
(BC)	FIRE ALARM DEVICE
(BD)	FIRE ALARM DEVICE
(BE)	FIRE ALARM DEVICE
(BF)	FIRE ALARM DEVICE
(BG)	FIRE ALARM DEVICE
(BH)	FIRE ALARM DEVICE
(BI)	FIRE ALARM DEVICE
(BJ)	FIRE ALARM DEVICE
(BK)	FIRE ALARM DEVICE
(BL)	FIRE ALARM DEVICE
(BM)	FIRE ALARM DEVICE
(BN)	FIRE ALARM DEVICE
(BO)	FIRE ALARM DEVICE
(BP)	FIRE ALARM DEVICE
(BQ)	FIRE ALARM DEVICE
(BR)	FIRE ALARM DEVICE
(BS)	FIRE ALARM DEVICE
(BT)	FIRE ALARM DEVICE
(BU)	FIRE ALARM DEVICE
(BV)	FIRE ALARM DEVICE
(BW)	FIRE ALARM DEVICE
(BX)	FIRE ALARM DEVICE
(BY)	FIRE ALARM DEVICE
(BZ)	FIRE ALARM DEVICE
(CA)	FIRE ALARM DEVICE
(CB)	FIRE ALARM DEVICE
(CC)	FIRE ALARM DEVICE
(CD)	FIRE ALARM DEVICE
(CE)	FIRE ALARM DEVICE
(CF)	FIRE ALARM DEVICE
(CG)	FIRE ALARM DEVICE
(CH)	FIRE ALARM DEVICE
(CI)	FIRE ALARM DEVICE
(CJ)	FIRE ALARM DEVICE
(CK)	FIRE ALARM DEVICE
(CL)	FIRE ALARM DEVICE
(CM)	FIRE ALARM DEVICE
(CN)	FIRE ALARM DEVICE
(CO)	FIRE ALARM DEVICE
(CP)	FIRE ALARM DEVICE
(CQ)	FIRE ALARM DEVICE
(CR)	FIRE ALARM DEVICE
(CS)	FIRE ALARM DEVICE
(CT)	FIRE ALARM DEVICE
(CU)	FIRE ALARM DEVICE
(CV)	FIRE ALARM DEVICE
(CW)	FIRE ALARM DEVICE
(CX)	FIRE ALARM DEVICE
(CY)	FIRE ALARM DEVICE
(CZ)	FIRE ALARM DEVICE
(DA)	FIRE ALARM DEVICE
(DB)	FIRE ALARM DEVICE
(DC)	FIRE ALARM DEVICE
(DD)	FIRE ALARM DEVICE
(DE)	FIRE ALARM DEVICE
(DF)	FIRE ALARM DEVICE
(DG)	FIRE ALARM DEVICE
(DH)	FIRE ALARM DEVICE
(DI)	FIRE ALARM DEVICE
(DJ)	FIRE ALARM DEVICE
(DK)	FIRE ALARM DEVICE
(DL)	FIRE ALARM DEVICE
(DM)	FIRE ALARM DEVICE
(DN)	FIRE ALARM DEVICE
(DO)	FIRE ALARM DEVICE
(DP)	FIRE ALARM DEVICE
(DQ)	FIRE ALARM DEVICE
(DR)	FIRE ALARM DEVICE
(DS)	FIRE ALARM DEVICE
(DT)	FIRE ALARM DEVICE
(DU)	FIRE ALARM DEVICE
(DV)	FIRE ALARM DEVICE
(DW)	FIRE ALARM DEVICE
(DX)	FIRE ALARM DEVICE
(DY)	FIRE ALARM DEVICE
(DZ)	FIRE ALARM DEVICE
(EA)	FIRE ALARM DEVICE
(EB)	FIRE ALARM DEVICE
(EC)	FIRE ALARM DEVICE
(ED)	FIRE ALARM DEVICE
(EE)	FIRE ALARM DEVICE
(EF)	FIRE ALARM DEVICE
(EG)	FIRE ALARM DEVICE
(EH)	FIRE ALARM DEVICE
(EI)	FIRE ALARM DEVICE
(EJ)	FIRE ALARM DEVICE
(EK)	FIRE ALARM DEVICE
(EL)	FIRE ALARM DEVICE
(EM)	FIRE ALARM DEVICE
(EN)	FIRE ALARM DEVICE
(EO)	FIRE ALARM DEVICE
(EP)	FIRE ALARM DEVICE
(EQ)	FIRE ALARM DEVICE
(ER)	FIRE ALARM DEVICE
(ES)	FIRE ALARM DEVICE
(ET)	FIRE ALARM DEVICE
(EU)	FIRE ALARM DEVICE
(EV)	FIRE ALARM DEVICE
(EW)	FIRE ALARM DEVICE
(EX)	FIRE ALARM DEVICE
(EY)	FIRE ALARM DEVICE
(EZ)	FIRE ALARM DEVICE
(FA)	FIRE ALARM DEVICE
(FB)	FIRE ALARM DEVICE
(FC)	FIRE ALARM DEVICE
(FD)	FIRE ALARM DEVICE
(FE)	FIRE ALARM DEVICE
(FF)	FIRE ALARM DEVICE
(FG)	FIRE ALARM DEVICE
(FH)	FIRE ALARM DEVICE
(FI)	FIRE ALARM DEVICE
(FJ)	FIRE ALARM DEVICE
(FK)	FIRE ALARM DEVICE
(FL)	FIRE ALARM DEVICE
(FM)	FIRE ALARM DEVICE
(FN)	FIRE ALARM DEVICE
(FO)	FIRE ALARM DEVICE
(FP)	FIRE ALARM DEVICE
(FQ)	FIRE ALARM DEVICE
(FR)	FIRE ALARM DEVICE
(FS)	FIRE ALARM DEVICE
(FT)	FIRE ALARM DEVICE
(FU)	FIRE ALARM DEVICE
(FV)	FIRE ALARM DEVICE
(FW)	FIRE ALARM DEVICE
(FX)	FIRE ALARM DEVICE
(FY)	FIRE ALARM DEVICE
(FZ)	FIRE ALARM DEVICE
(GA)	FIRE ALARM DEVICE
(GB)	FIRE ALARM DEVICE
(GC)	FIRE ALARM DEVICE
(GD)	FIRE ALARM DEVICE
(GE)	FIRE ALARM DEVICE
(GF)	FIRE ALARM DEVICE
(GG)	FIRE ALARM DEVICE
(GH)	FIRE ALARM DEVICE
(GI)	FIRE ALARM DEVICE
(GJ)	FIRE ALARM DEVICE
(GK)	FIRE ALARM DEVICE
(GL)	FIRE ALARM DEVICE
(GM)	FIRE ALARM DEVICE
(GN)	FIRE ALARM DEVICE
(GO)	FIRE ALARM DEVICE
(GP)	FIRE ALARM DEVICE
(GQ)	FIRE ALARM DEVICE
(GR)	FIRE ALARM DEVICE
(GS)	FIRE ALARM DEVICE
(GT)	FIRE ALARM DEVICE
(GU)	FIRE ALARM DEVICE
(GV)	FIRE ALARM DEVICE
(GW)	FIRE ALARM DEVICE
(GX)	FIRE ALARM DEVICE
(GY)	FIRE ALARM DEVICE
(GZ)	FIRE ALARM DEVICE
(HA)	FIRE ALARM DEVICE
(HB)	FIRE ALARM DEVICE
(HC)	FIRE ALARM DEVICE
(HD)	FIRE ALARM DEVICE
(HE)	FIRE ALARM DEVICE
(HF)	FIRE ALARM DEVICE
(HG)	FIRE ALARM DEVICE
(HH)	FIRE ALARM DEVICE
(HI)	FIRE ALARM DEVICE
(HJ)	FIRE ALARM DEVICE
(HK)	FIRE ALARM DEVICE
(HL)	FIRE ALARM DEVICE
(HM)	FIRE AL