




TYPICAL FLOOR PLAN
(1ST TO 13TH FLOOR PLAN)

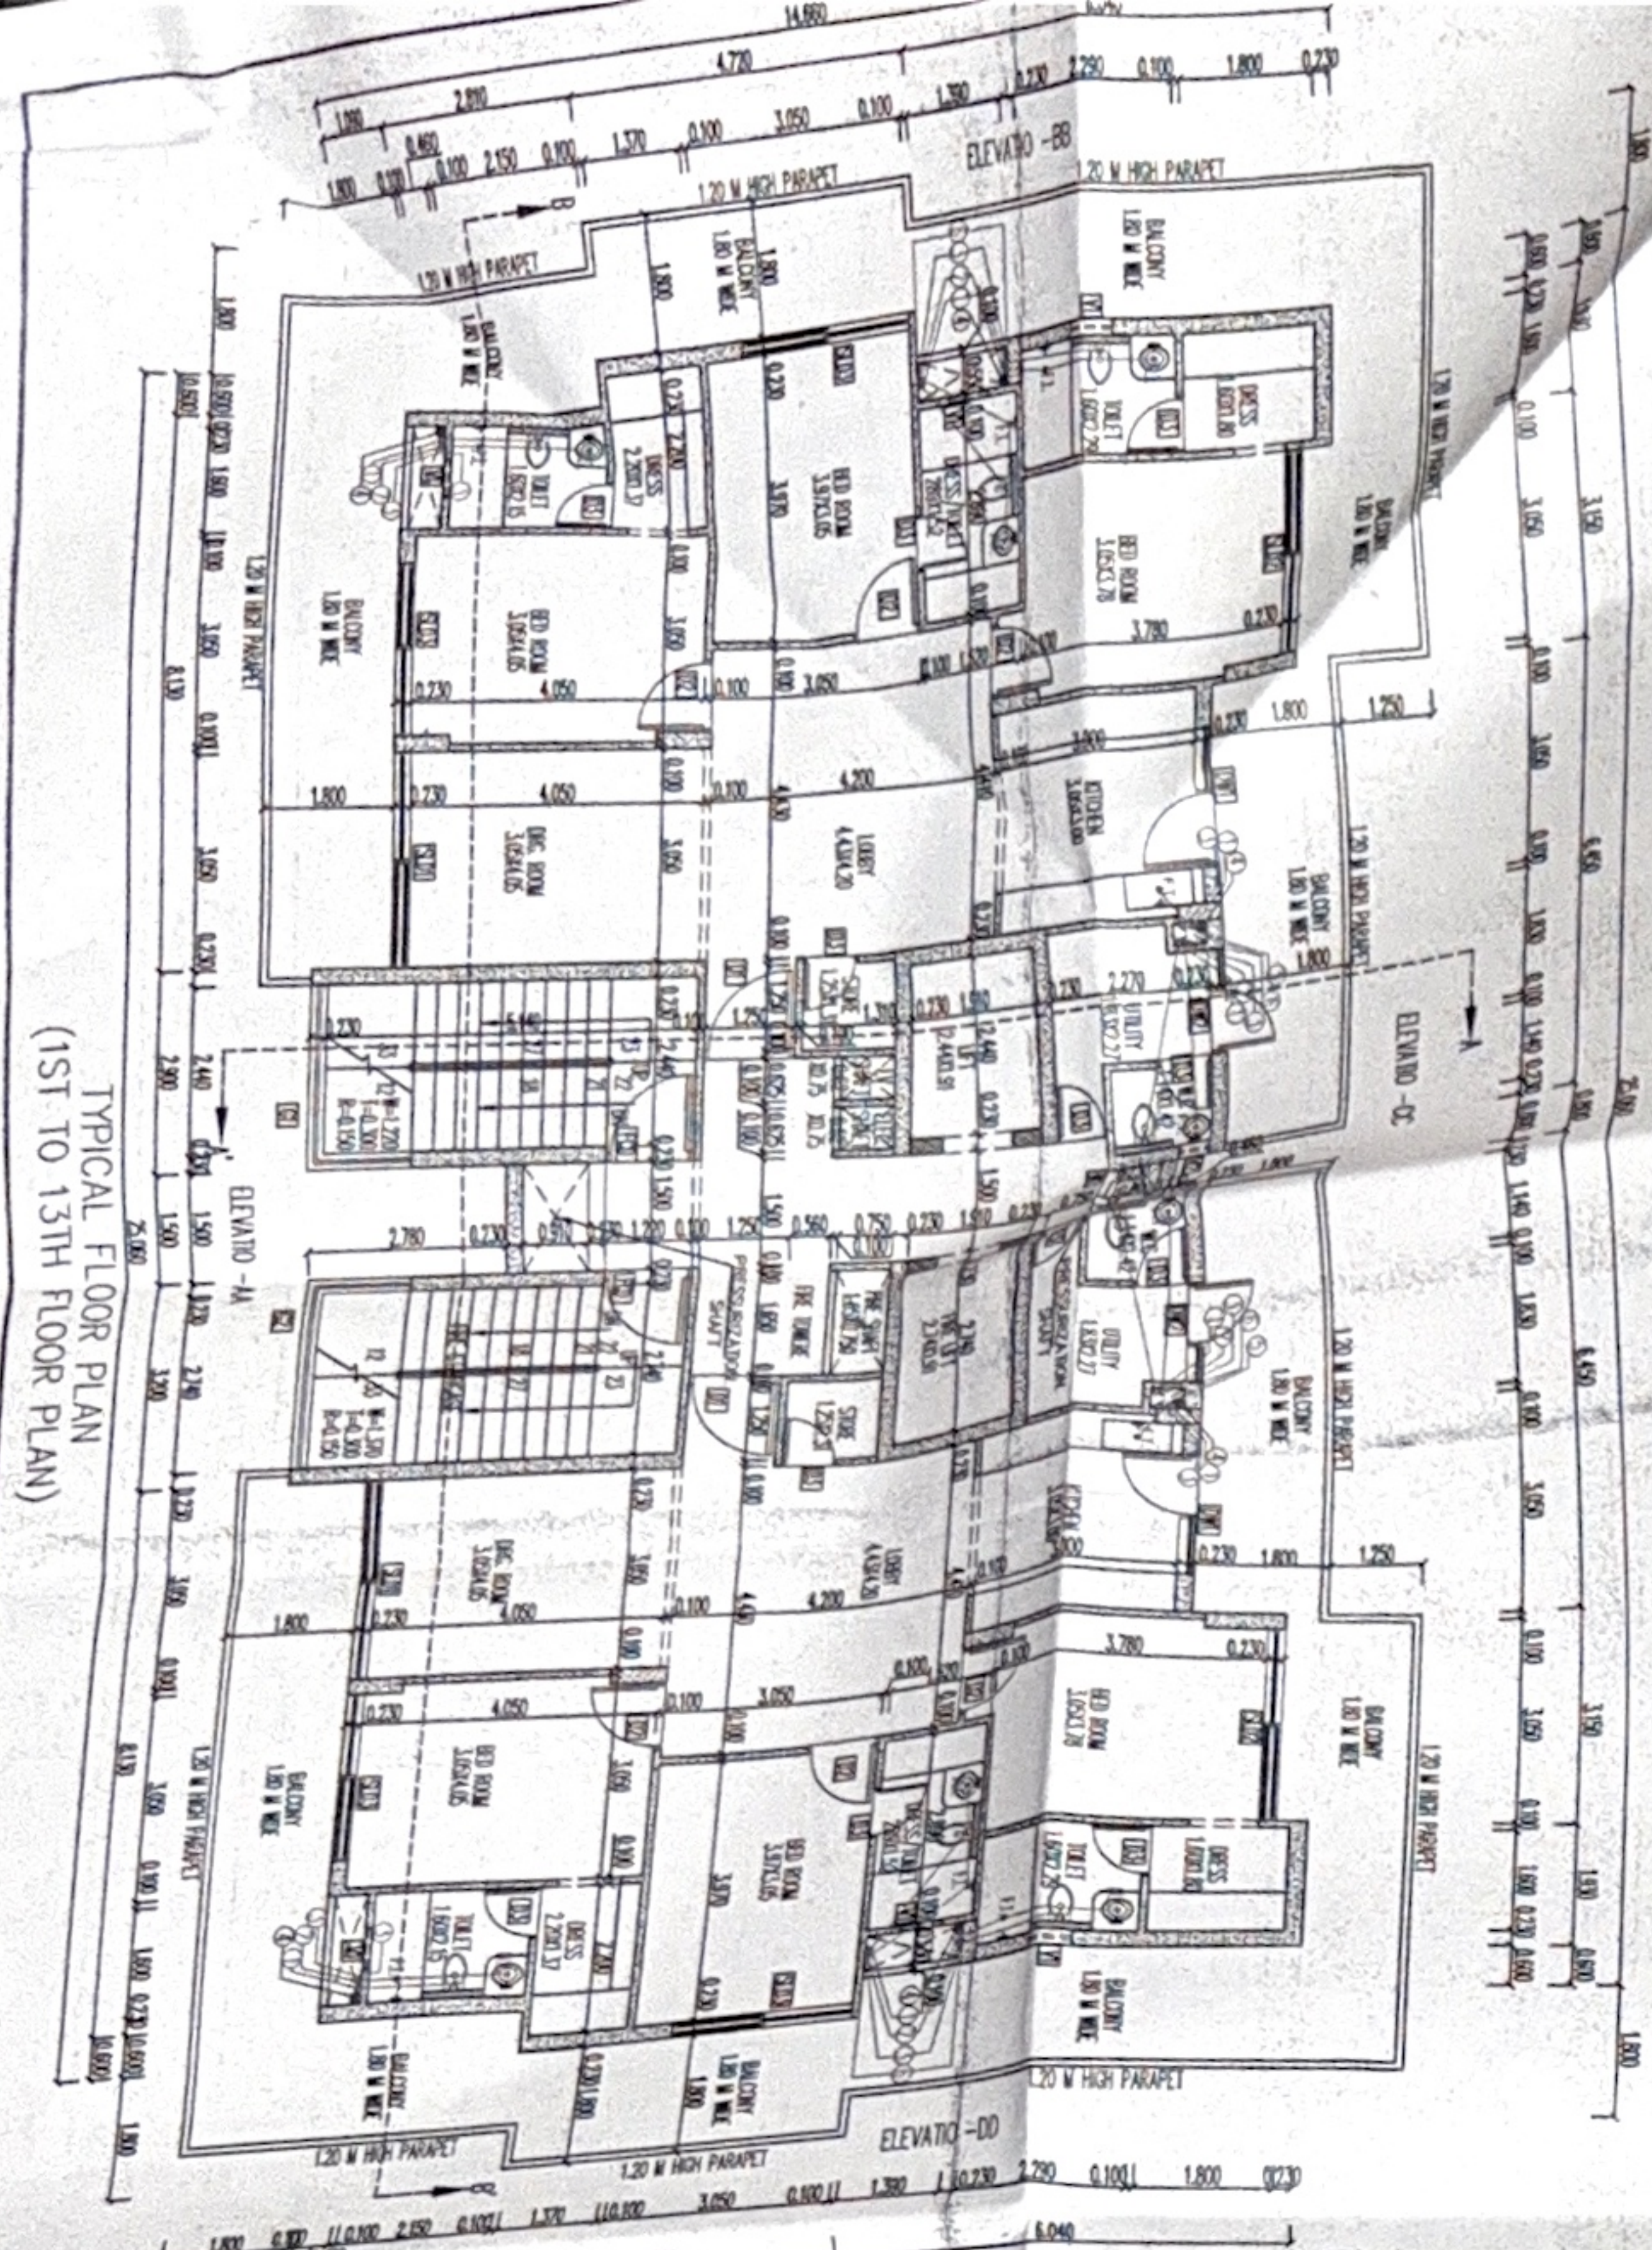


(TERRACE PLAN)

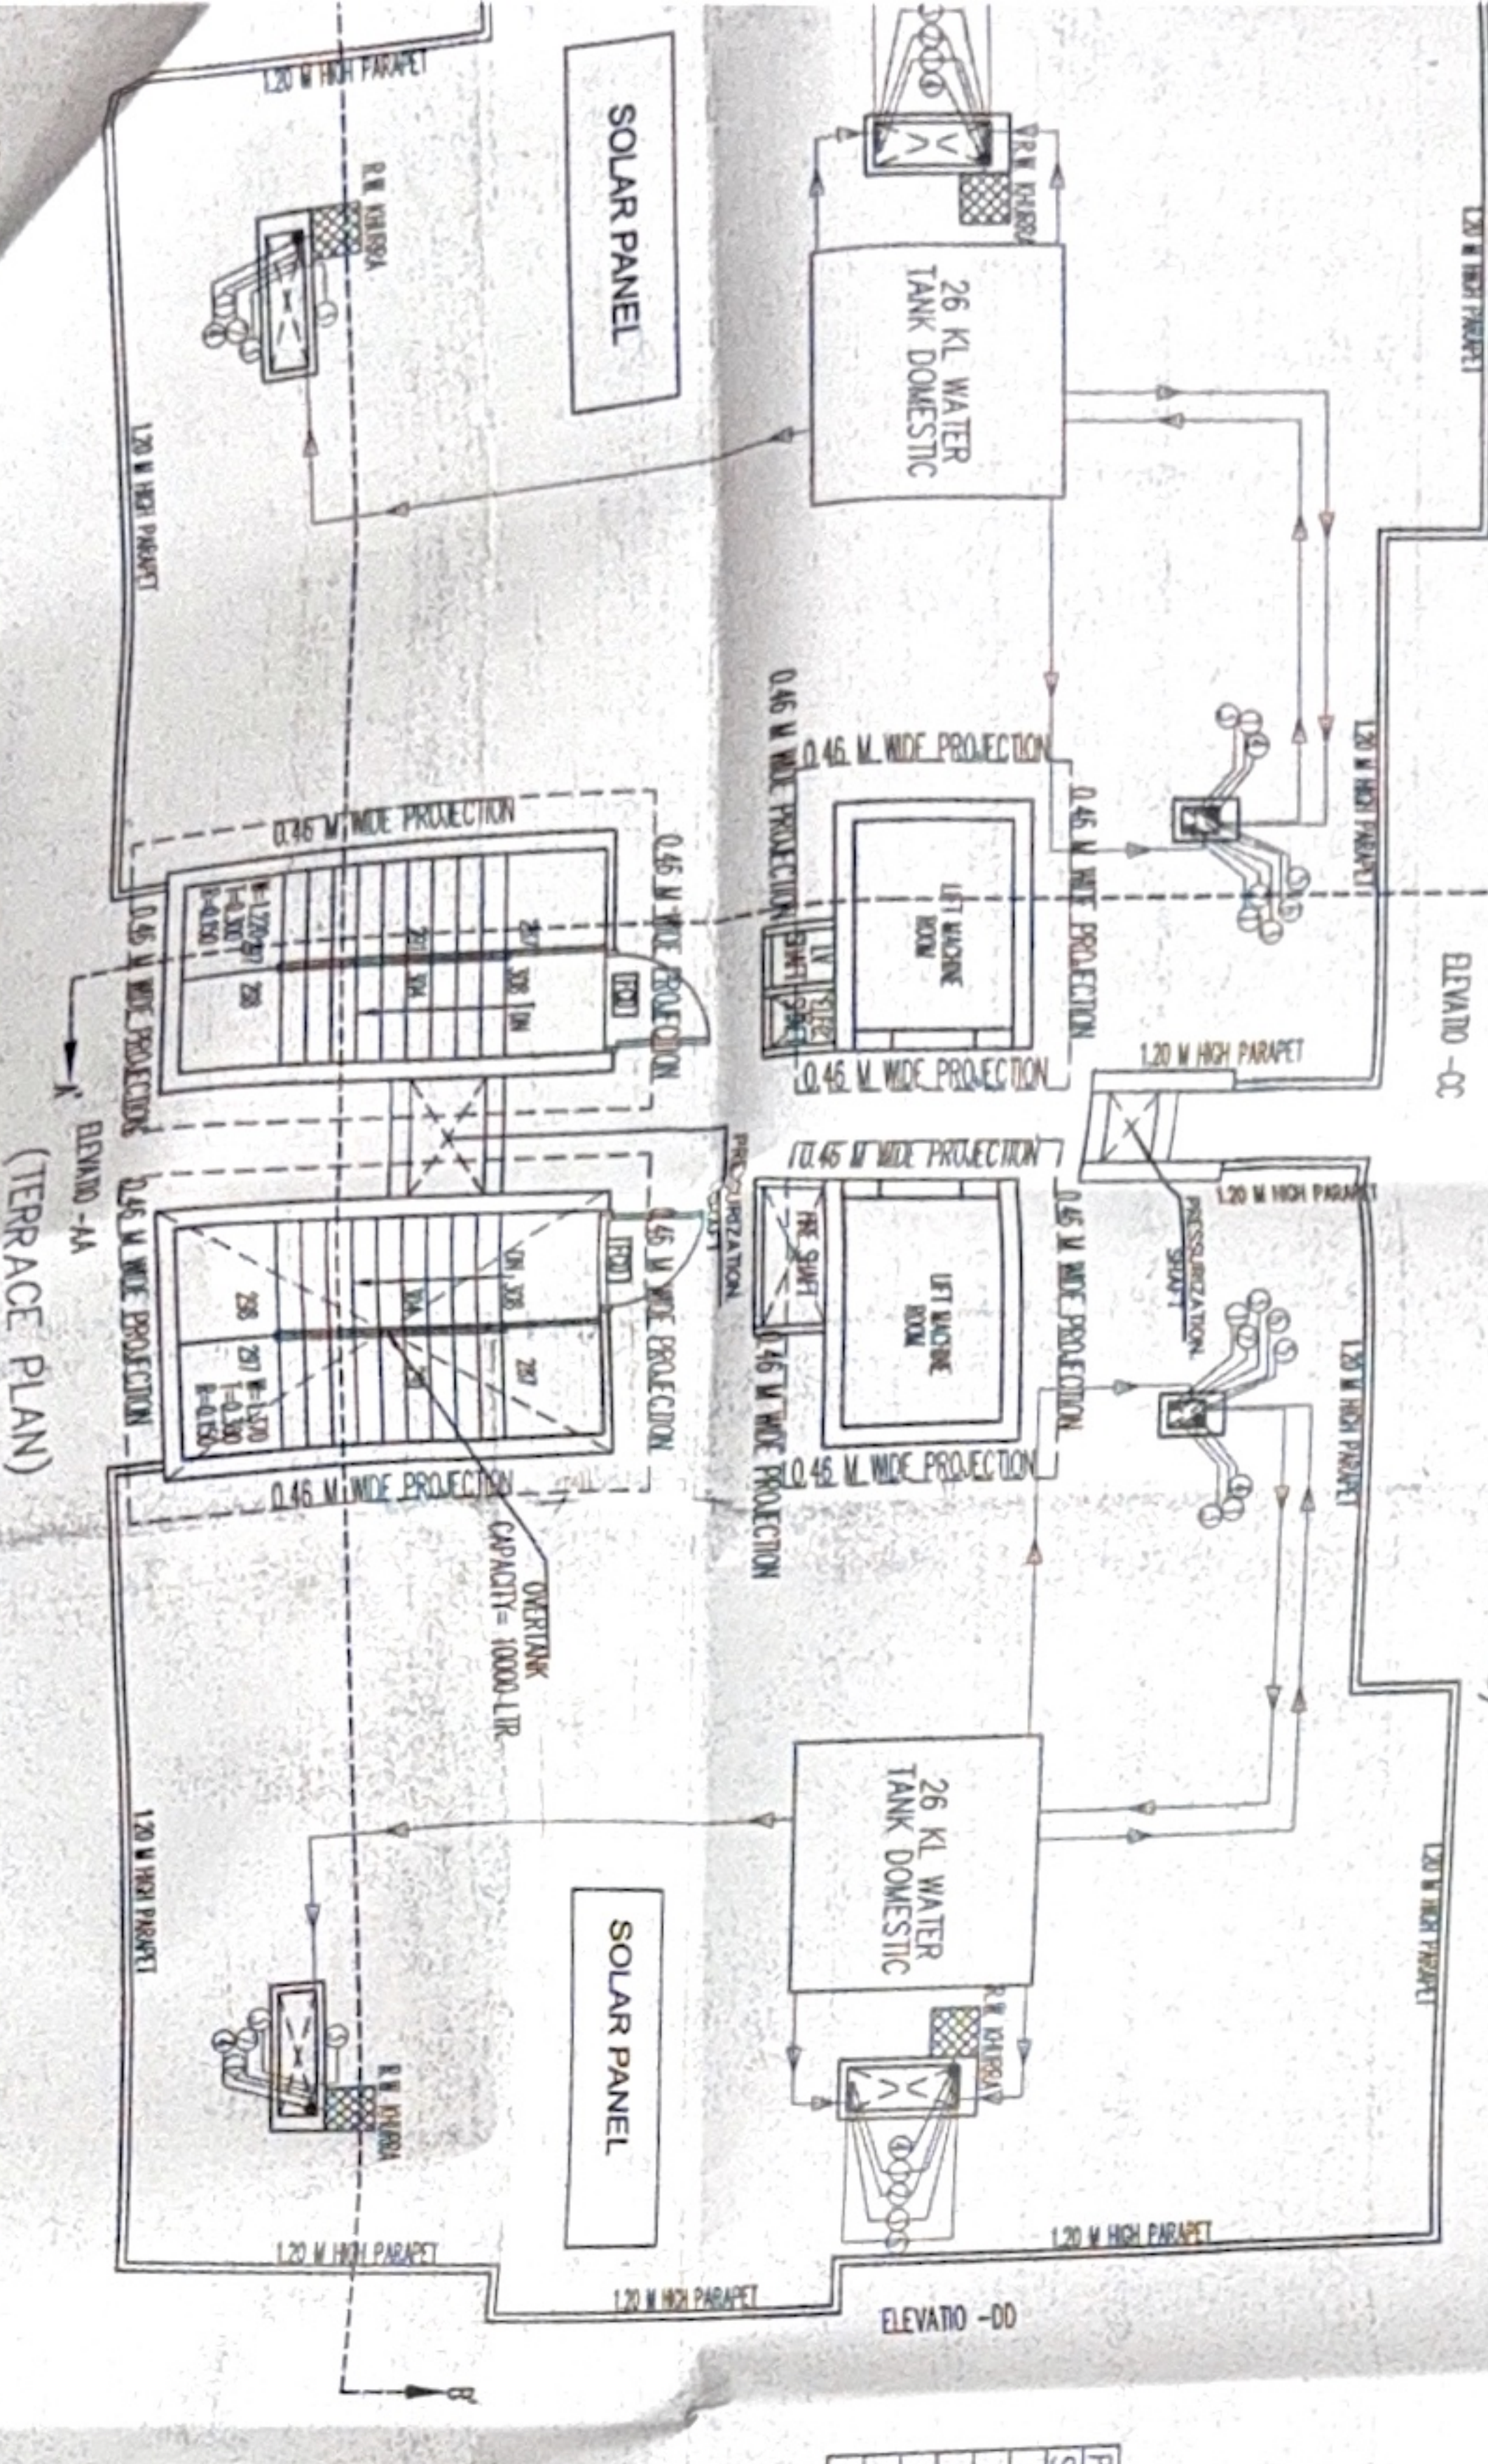

(SILT / GROUND AREA DETAIL)


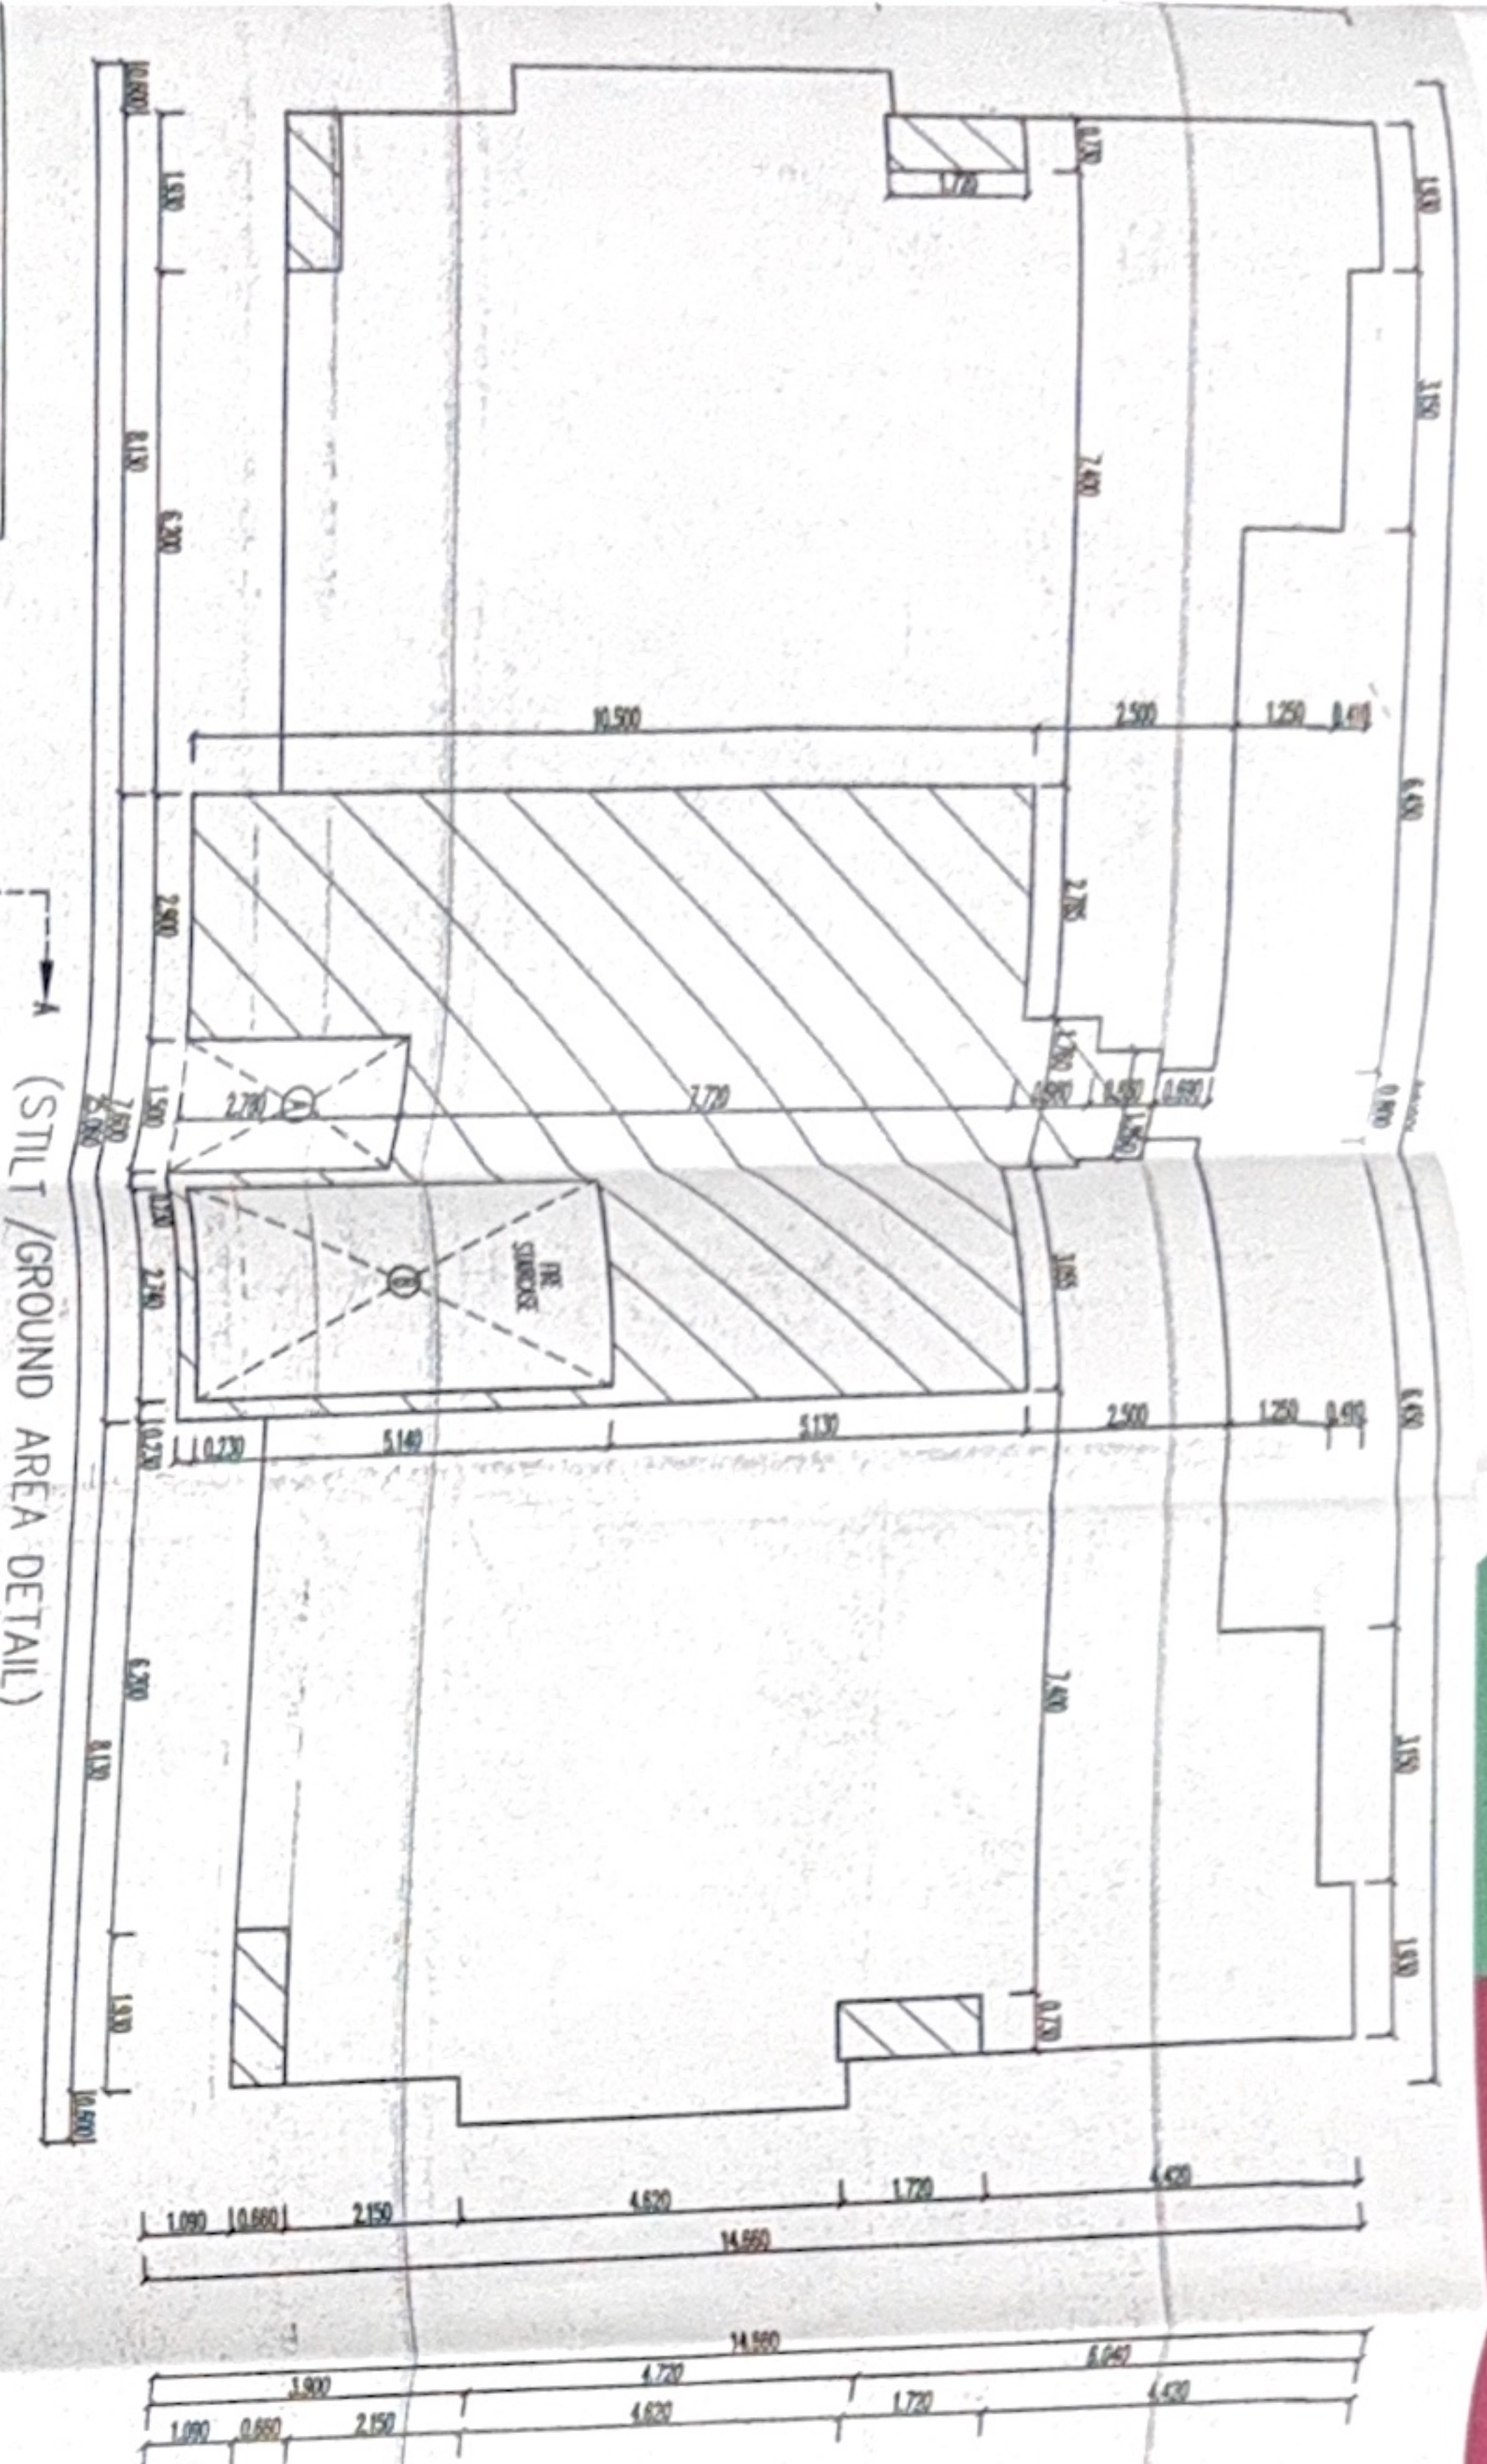


SITE PLAN SCALE: 1:200
SHOWING SURFACE PARKING AND OTHER

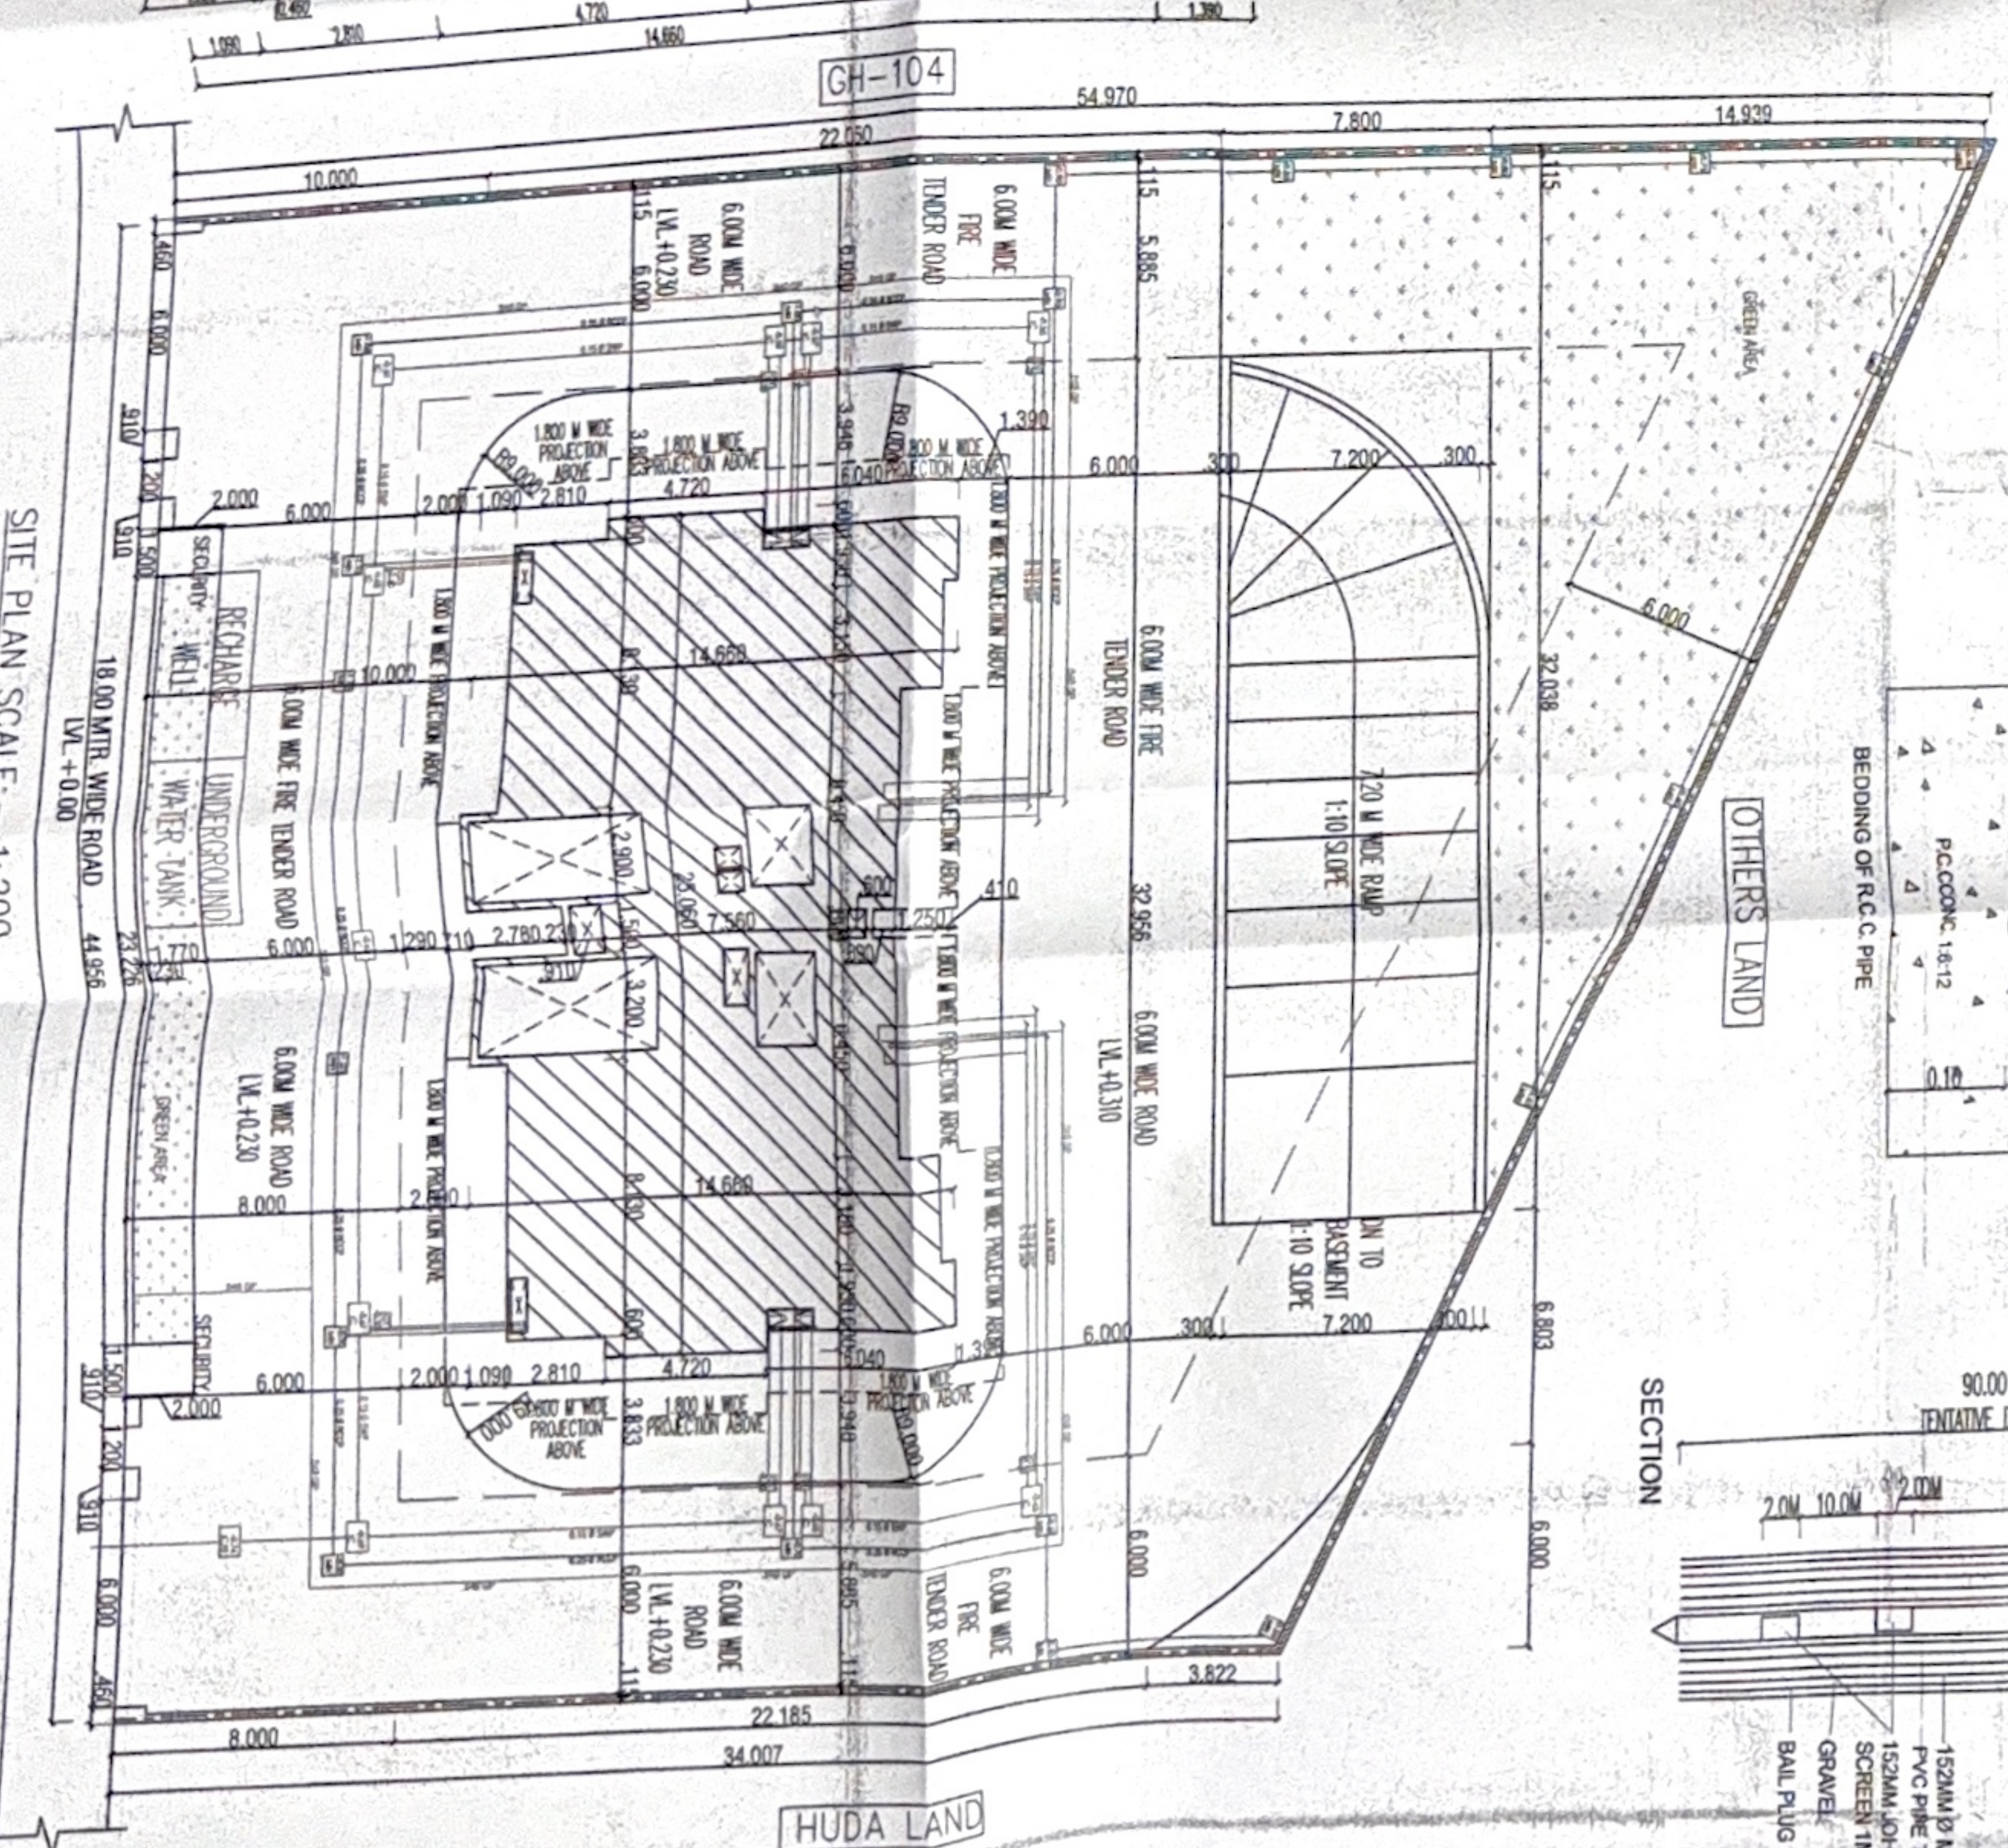


PLUMBING LEGEND


SYMBOL	DESCRIPTION
1	100 MM Ø WASTE & VENT PIPE
2	100 MM Ø WASTE & VENT PIPE
3	75 MM Ø WASTE & VENT PIPE
4	RAIN WATER PIPE ON ROOF
5	DOMESTIC WATER SUPPLY ON FLOOR

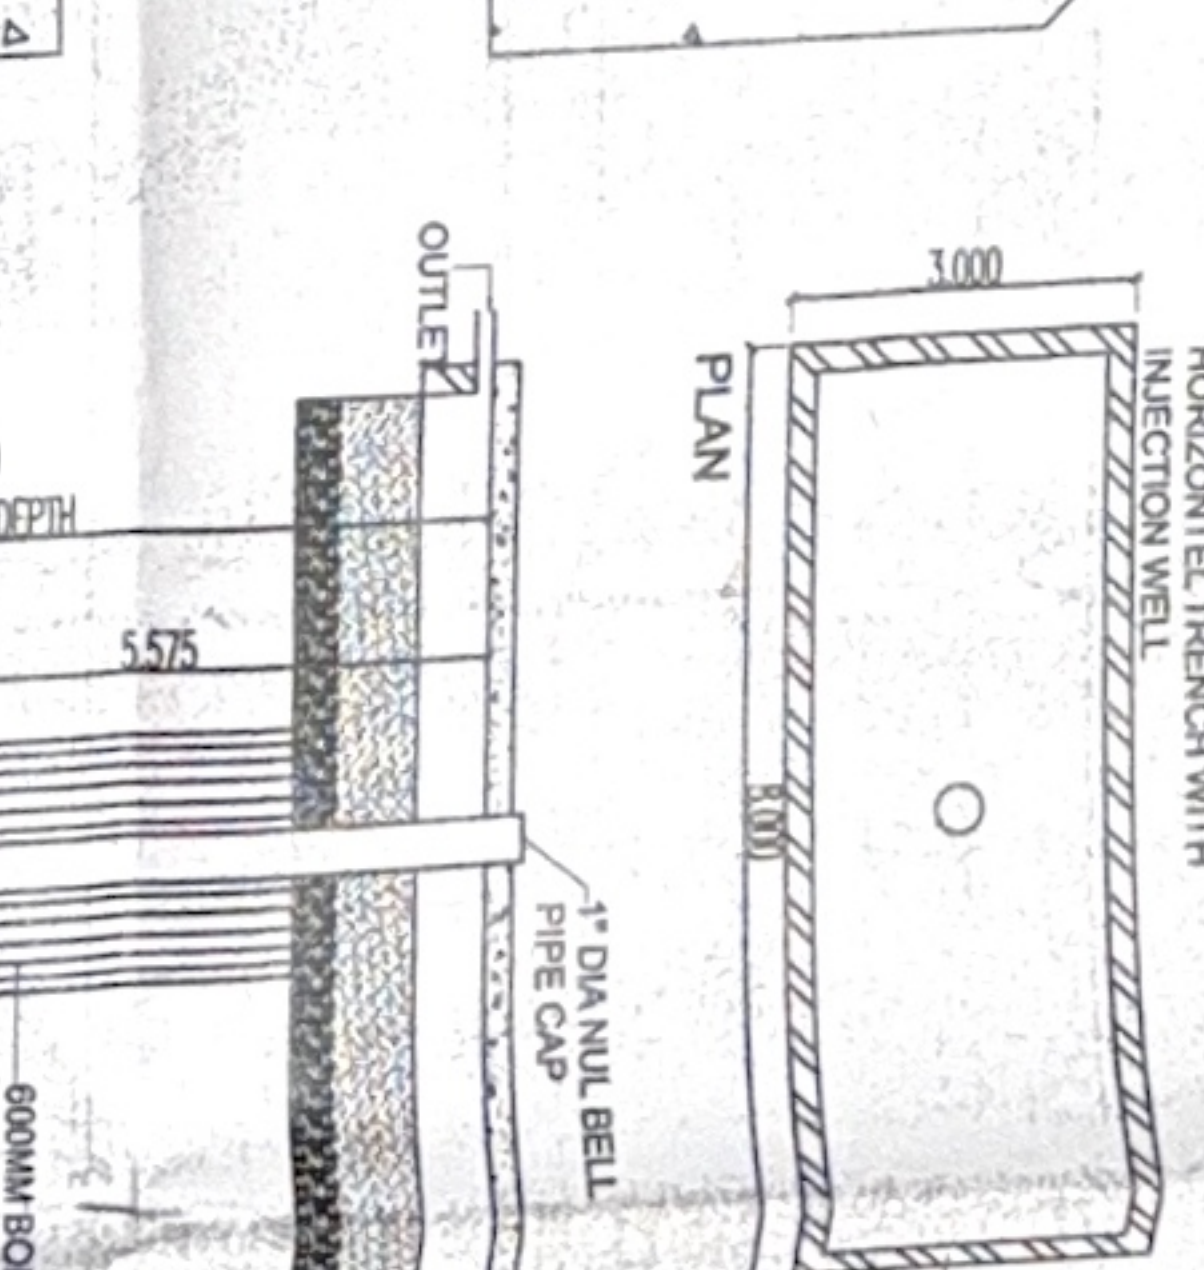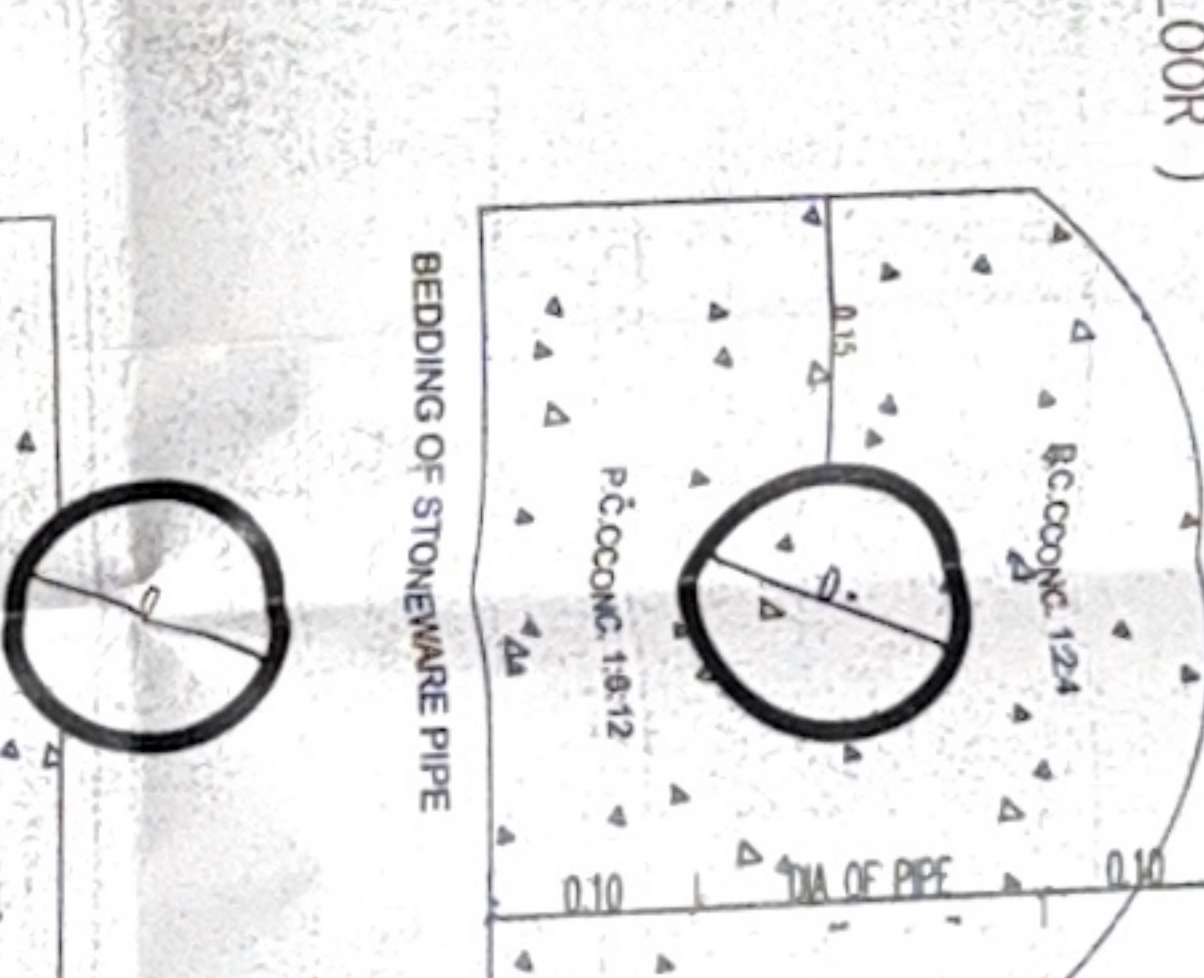


TYPICAL FLOOR AREA DETAIL
(1ST FLOOR TO 13TH FLOOR)

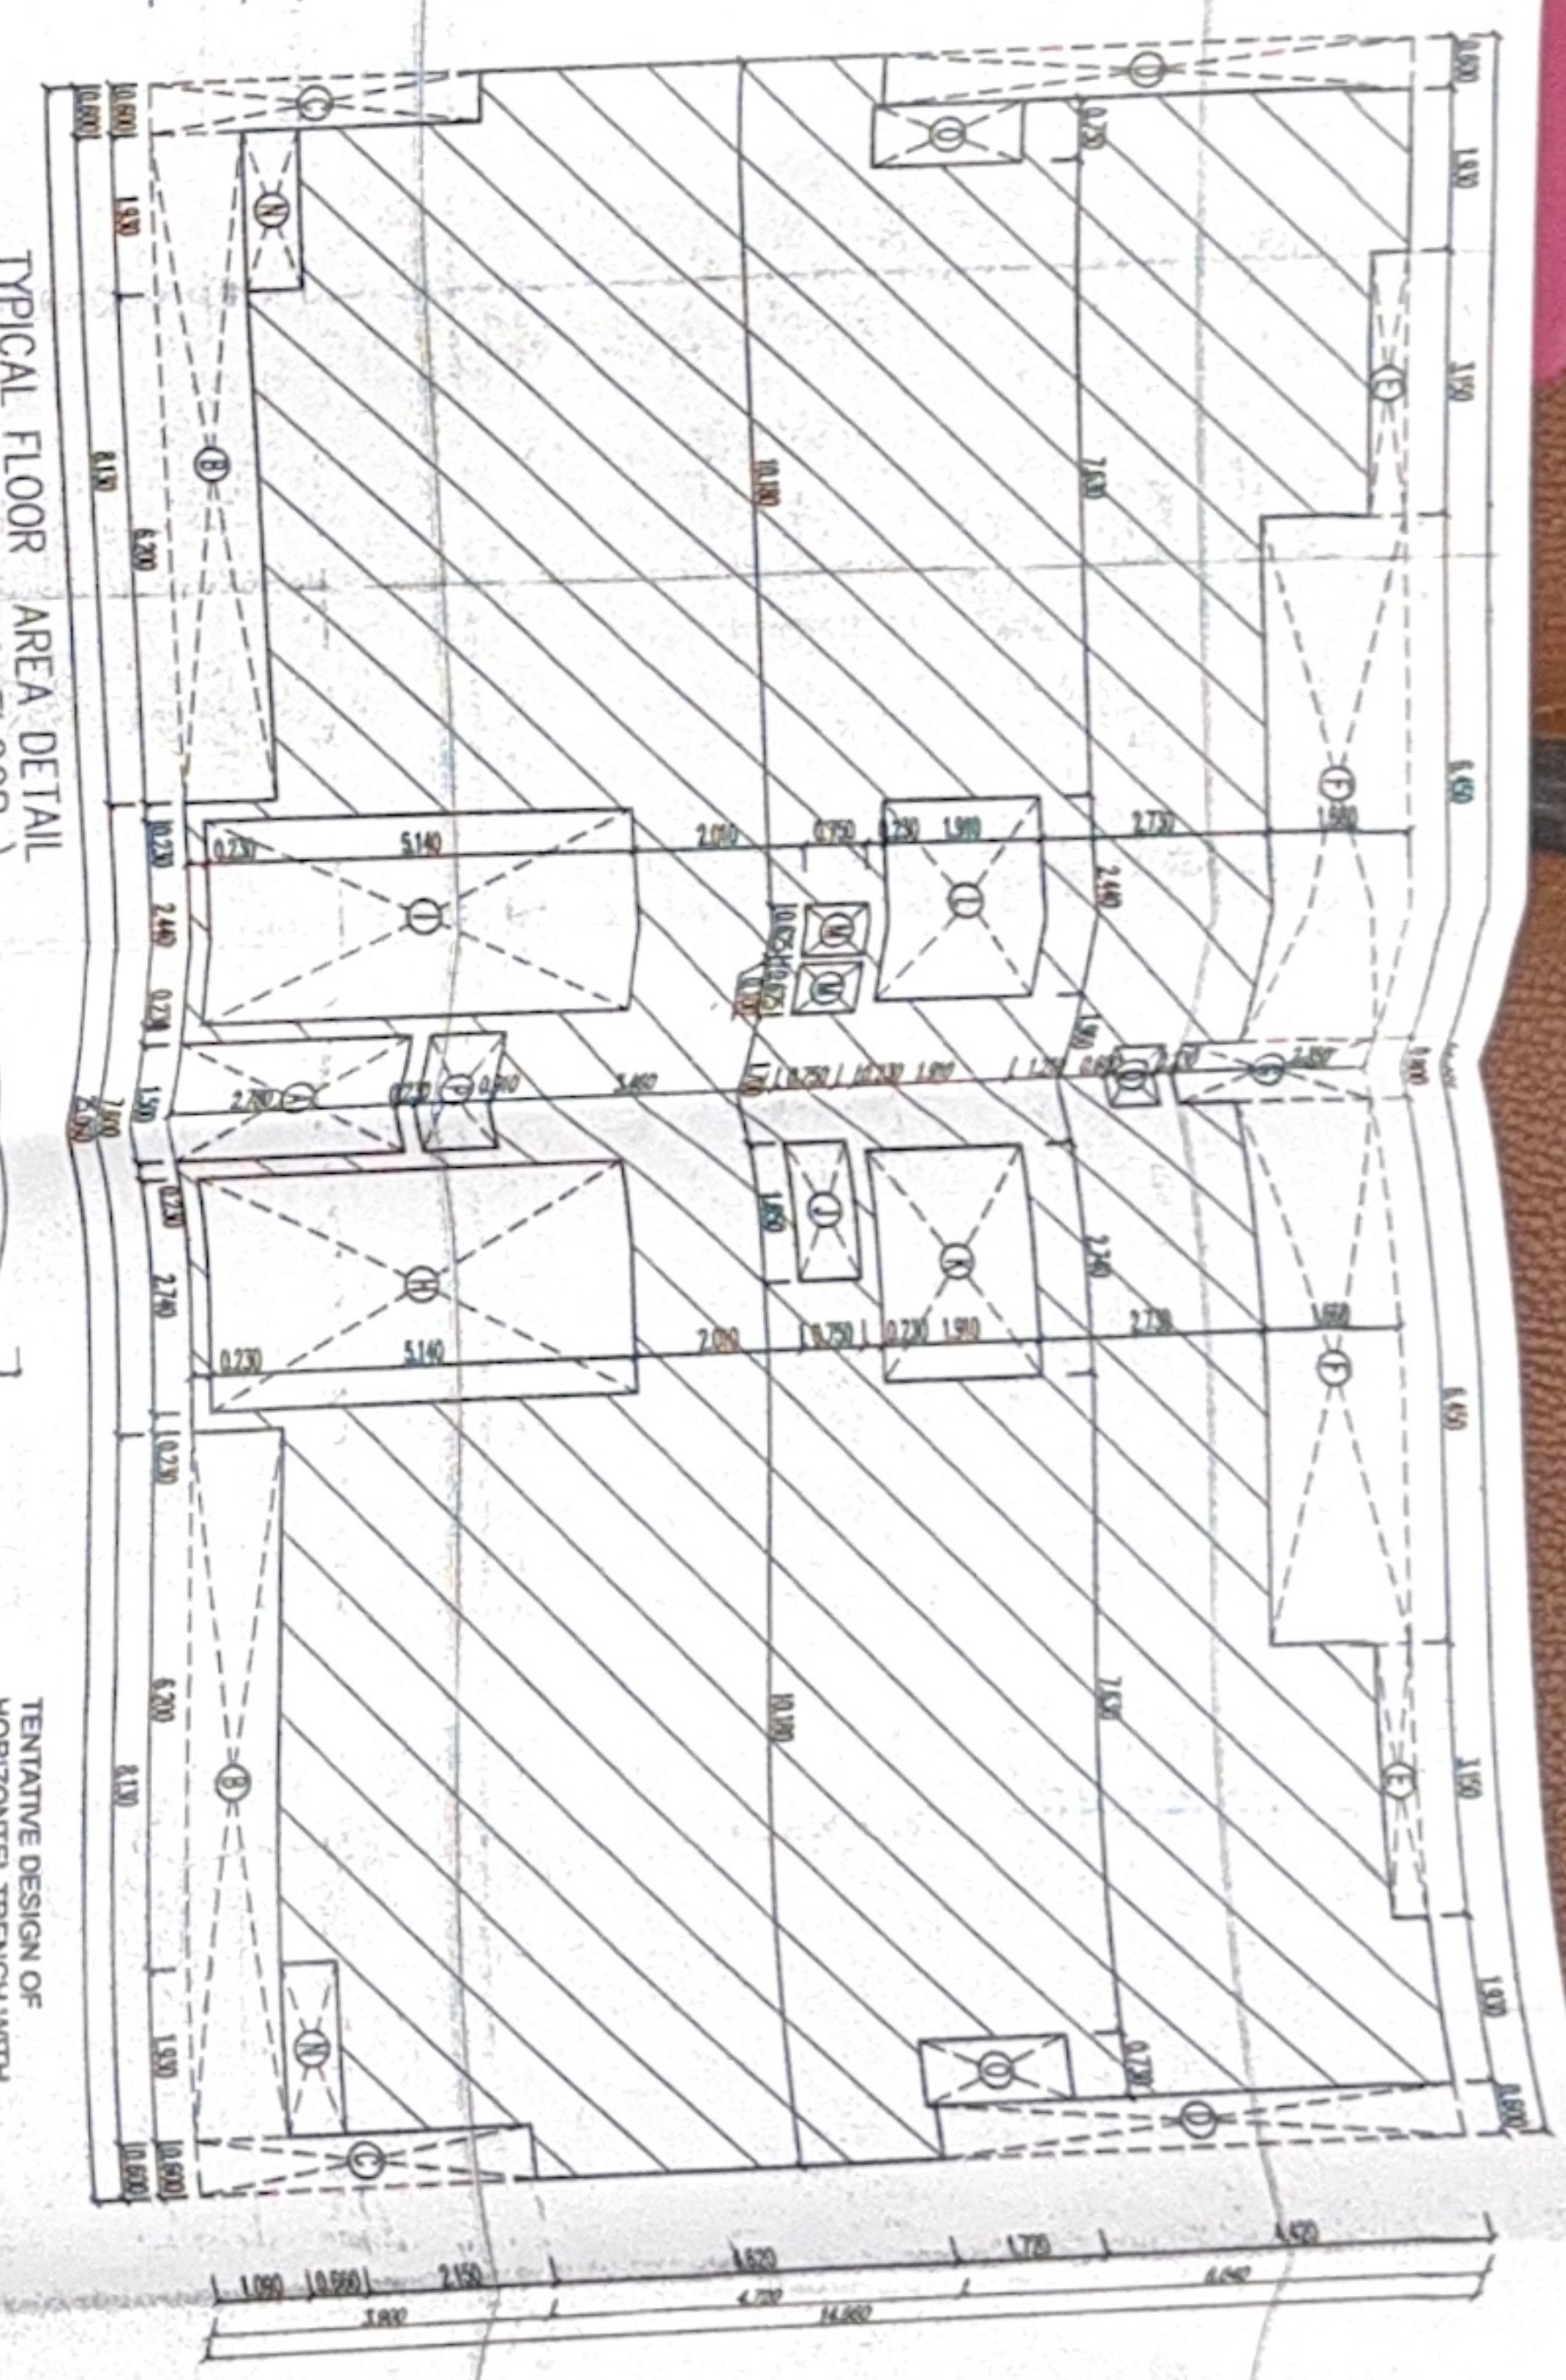

ORGANISED GREEN SPACE

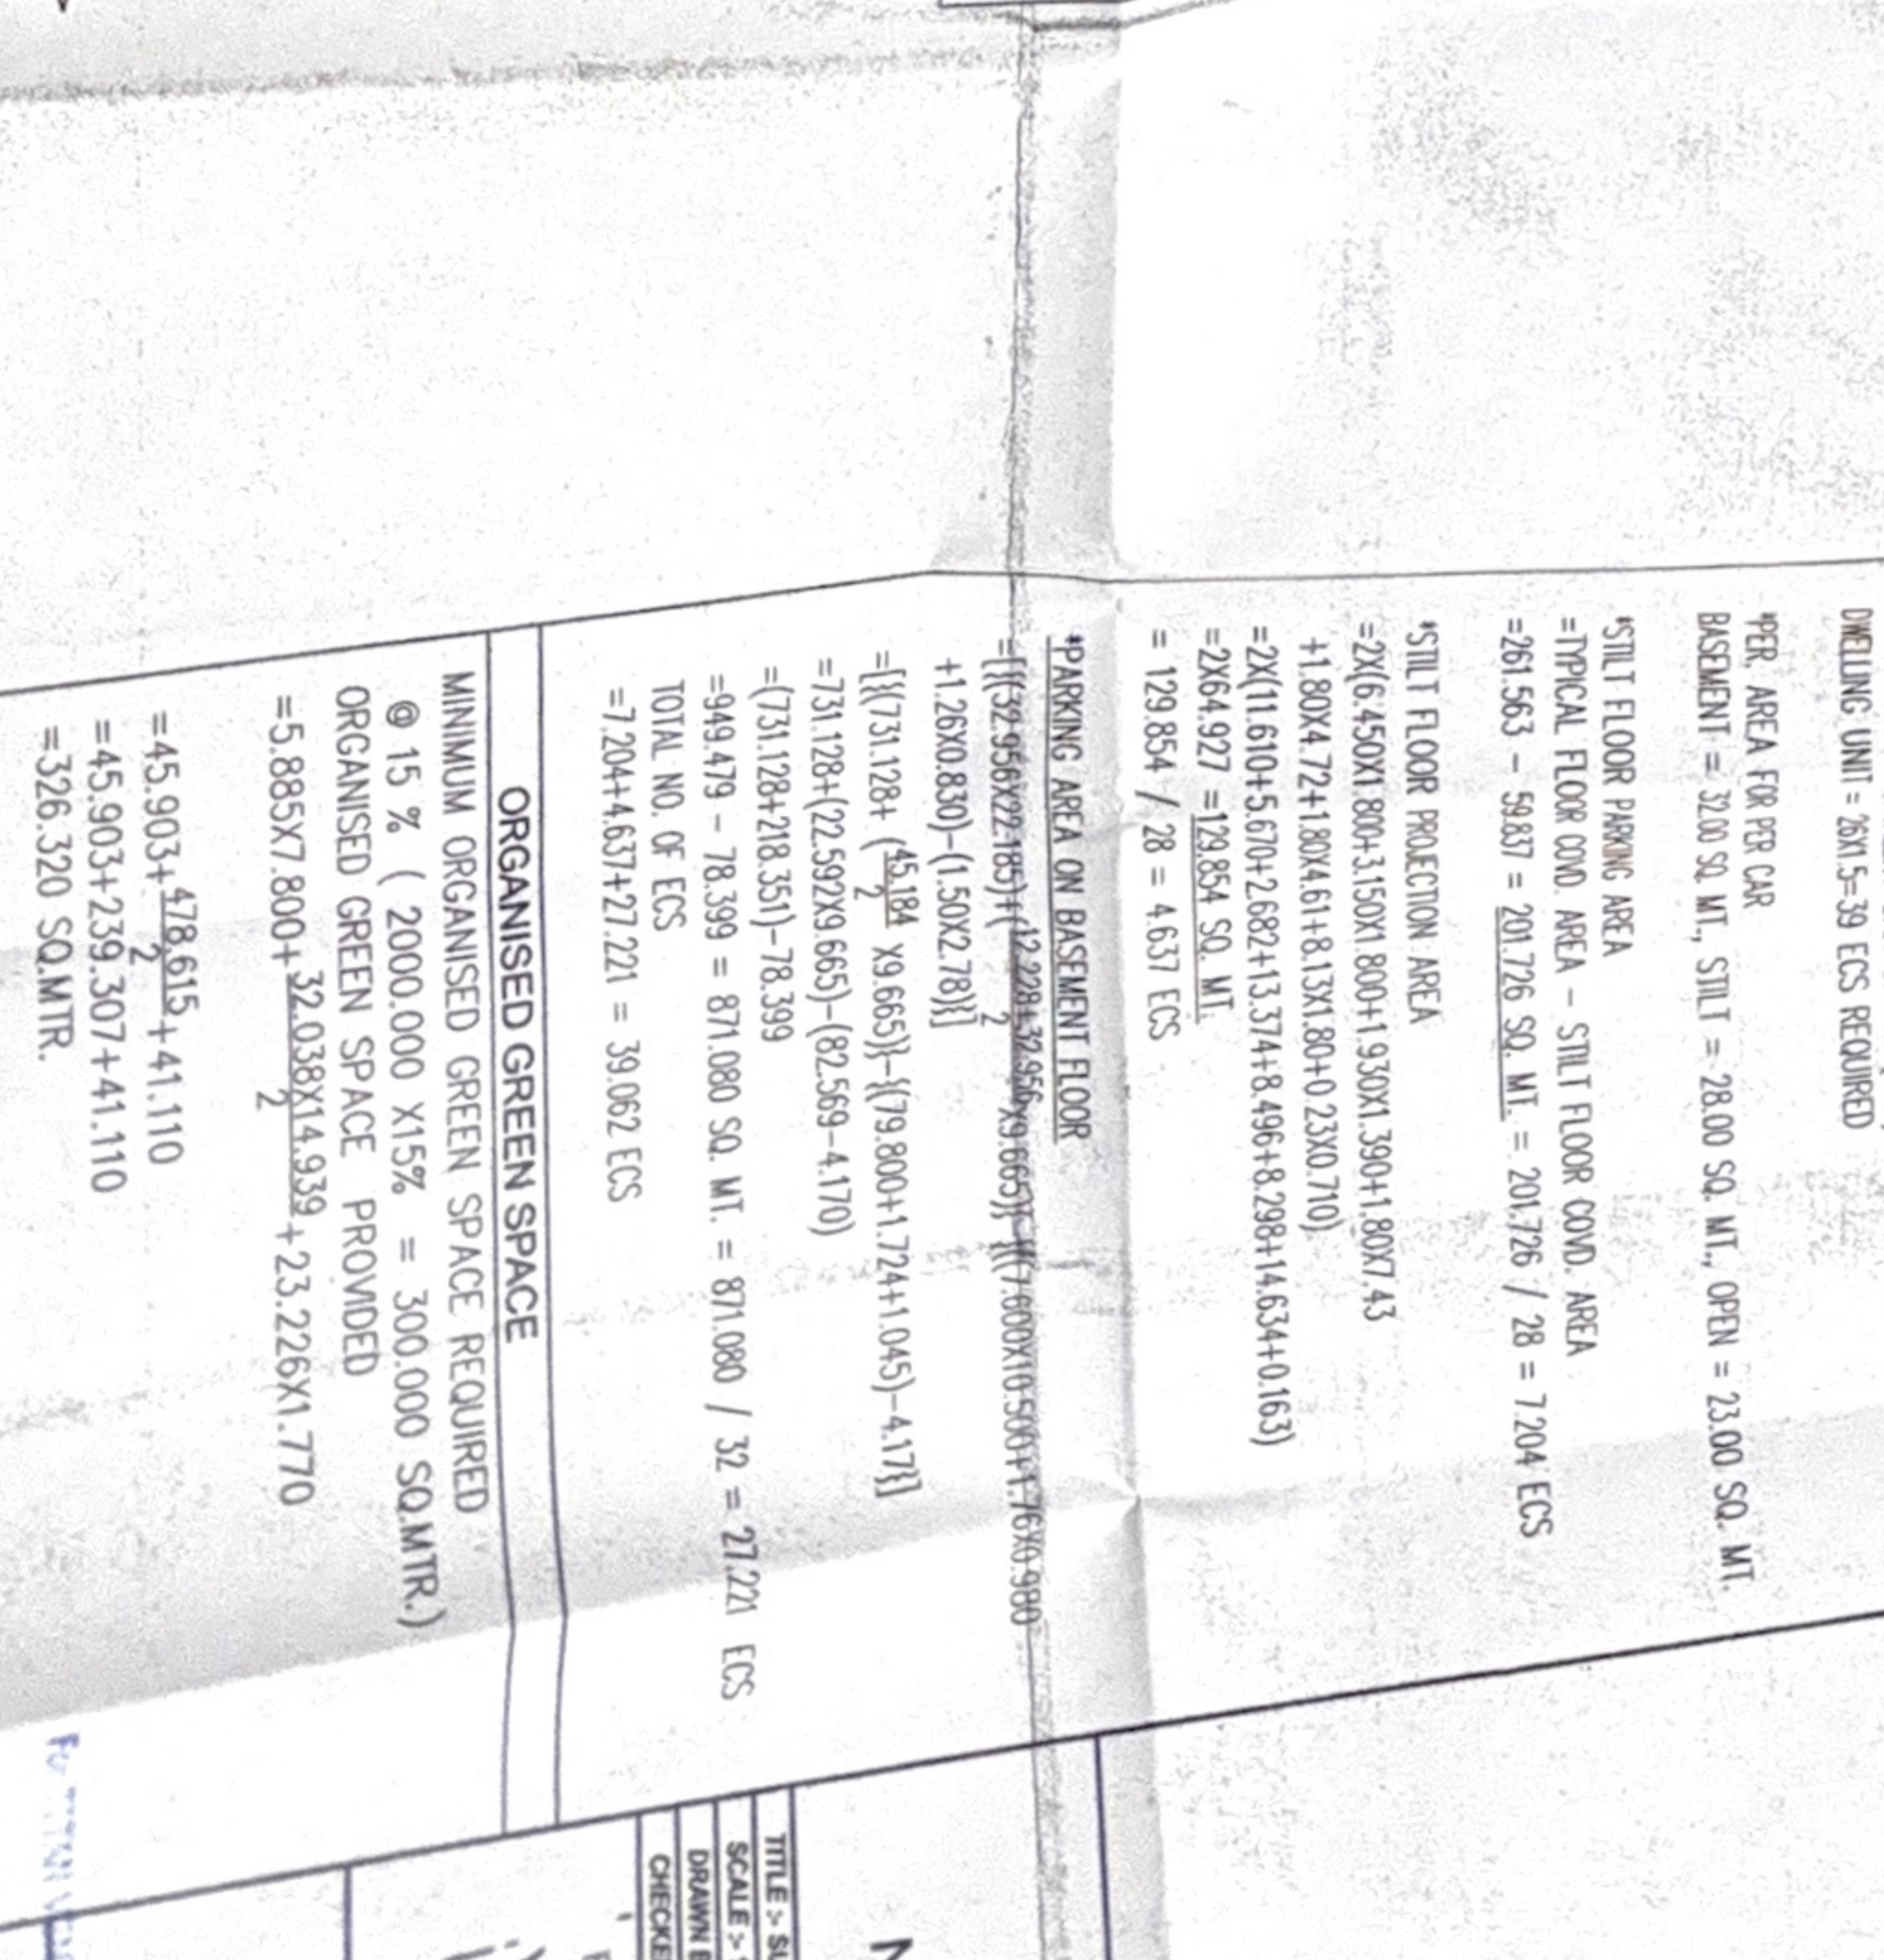

MINIMUM ORGANISED GREEN SPACE REQUIRED

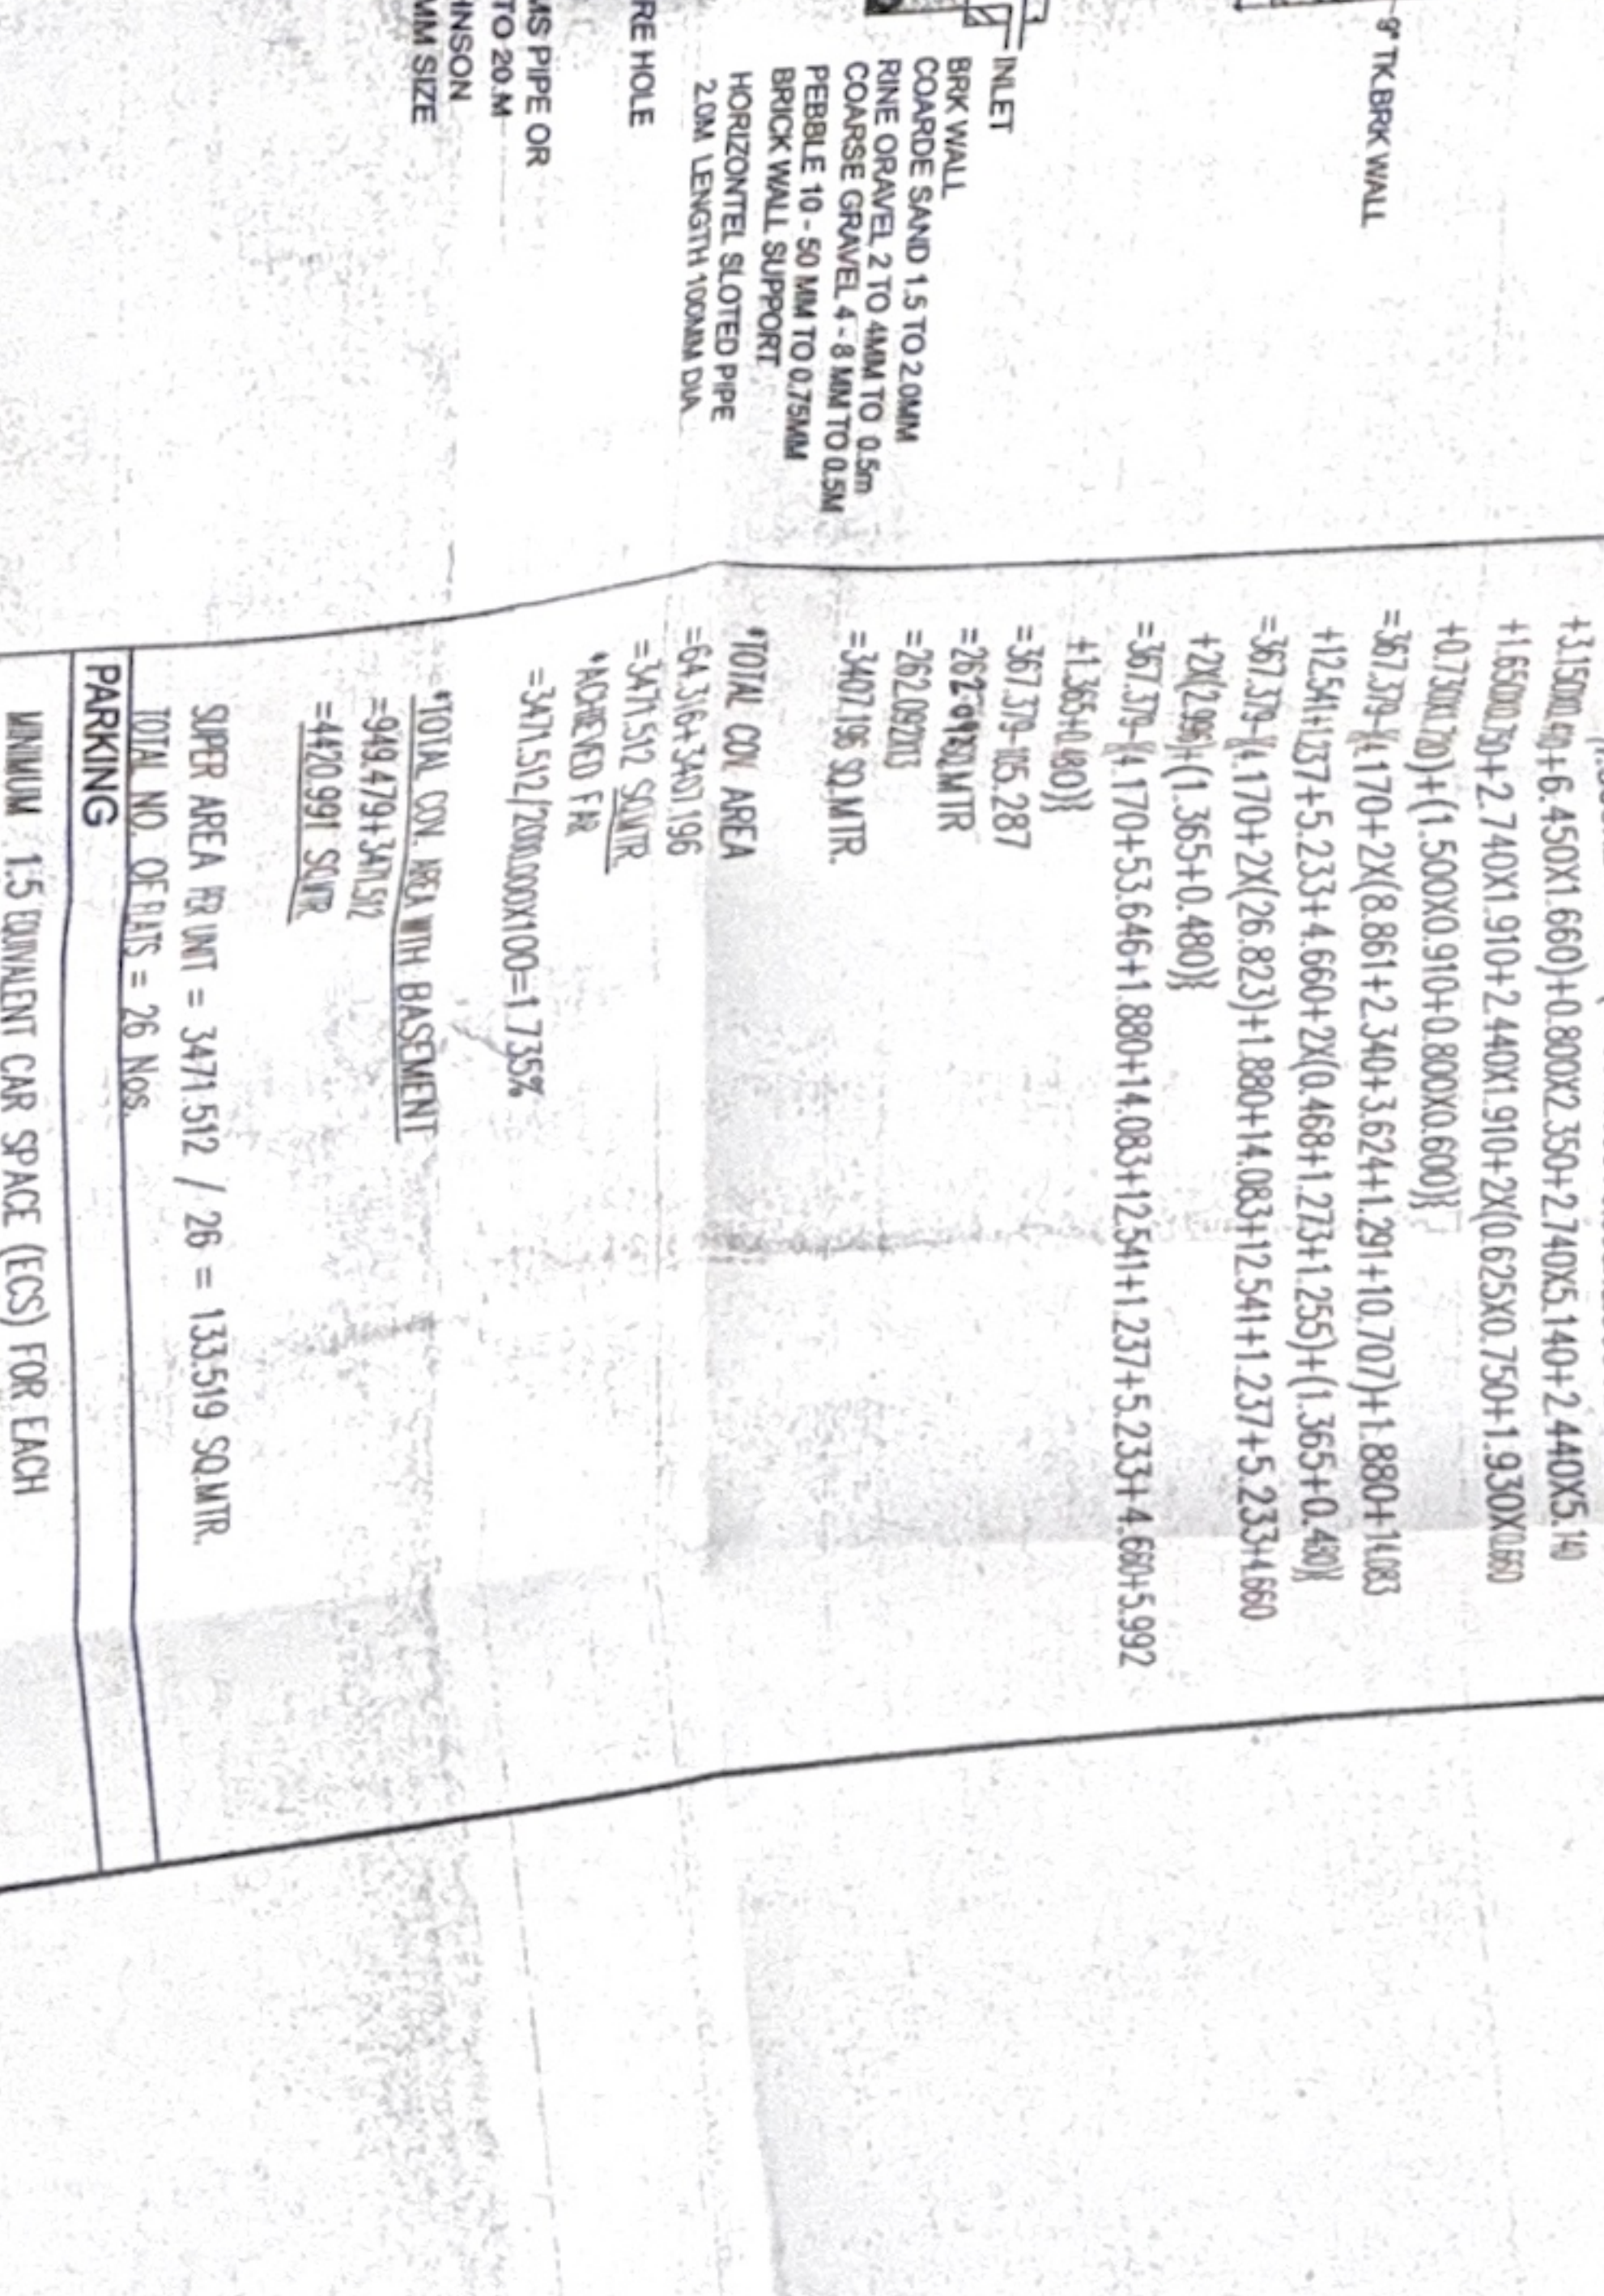

DOOR WINDOW SCHEDULE

NO.	TYPE	WIDTH	CALL	UNIT
1	SLD	2.00	-	2450
2	SLD	2.00	-	2450
3	SLD	2.00	-	2450
4	DWT	1.50	-	2450
5	DWT	1.50	-	2450
6	D1	1.20	-	2450
7	D2	1.00	-	2450
8	D3	0.75	-	2450
9	F.C.D	1.20	-	2450
10	F.C.D	1.20	-	2450
11	V1	0.60	-	2450
12	V2	0.40	-	2450
13	G1	4.50	-	2450
14	G2	4.50	-	2450

PROPOSED BUILDING PLAN FOR TITAN VENTURES LLP THROUGH ITS PARTNER MANISH SINGAL AT PLOT NO.-104A

