
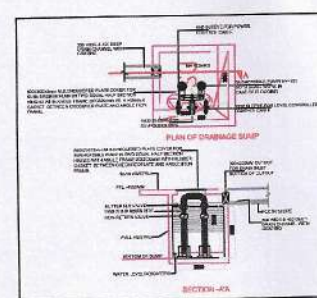
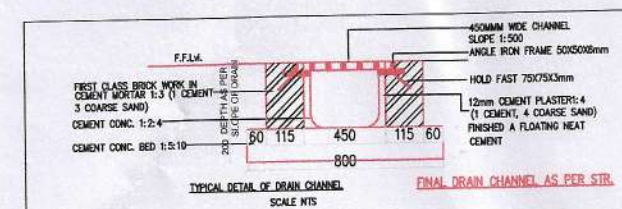


OTHER'S VACANT LAND

S.N.	LEGENDS:-	
01	STORM PIPE LINE	---
02	SEWER PIPE LINE	---
03	STP BYPASS PIPE LINE	---
04	TANKER SUPPLY TO UGT	---
05	MUNICIPAL SUPPLY TO UGT	---
06	IRRIGATION RING MAIN	---
07	GARDEN HYDRANT	---
08	STORM MANHOLE	---
09	SEWER MANHOLE	---

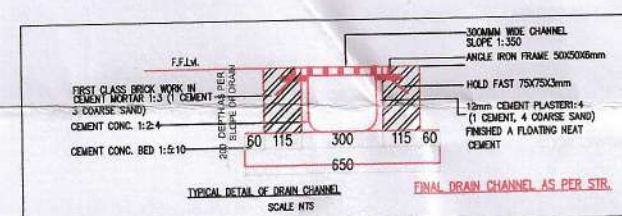

SANCTIONED
TO BE READ WITH THIS OFFICE
MEMO NO.:-
DATED :-

Rajesh Dutt
SD(HQ)

Note :-

1. BUILDING HAS AUTOMATIC SPRINKLER SYSTEM WHEREVER REQUIRED BY NBC.
2. BUILDING WILL BE DESIGNED (STRUCTURES) AS PER RELEVANT IS CODES FOR EARTH QUAKE RESISTANCE.
3. ALL TOILET & KITCHEN HAVE PERMANENT VENTILATION /EXHAUST
4. ALL BUILDINGS ARE NATURALLY VENTILATED AND WHERE EVER REQUIRED MECHANICAL VENTILATION IS PROPOSED WITH 100% POWER BACKUP.

Project

PROPOSED BUILDING PLAN OF RESIDENTIAL GROUP HOUSING COLONY OVER AN AREA MEASURING 5.10625 ACRE (LICENSE NO. 01 OF 2028 DATED 01-05-2028) IN SECTOR 103, GURUGRAM BEING DEVELOPED BY SUN INTERNATIONAL LTD. & OTHERS IN COLLABORATION WITH FLORAESSENCE PROJECTS PRIVATE LIMITED.

Client

Floraesence Projects Pvt. Ltd.
A/P Business Club, 5th Floor, Sector 62,
Gurgaon 122 002, Haryana,
Phone: +91 92111 60000 Ext: 7794

Architects:

Morphogenesis
Plot No. 41, Industrial Estate,
Okhla Phase-III,
New Delhi 110020, India
TEL: +91 11 41828070
FAX: 91 11 26490351
E Mail: studio@morphogenesis.org

Associate Architects:



SBA Design N Code LLP
Architecture Codes Interiors

(Formerly known as S.M.S.)
69, Nora Niwas, Bhawani Kunj
(Behind D2), Vasant Kunj,
New Delhi-110070.
Mob.: 9810791652, 9811077209

OWNER'S SEAL
& SIGNATURE



ARCHITECT'S SEAL
& SIGNATURE

Checked and approved by:
(Internal) Service only to be used for comments in
in forwarding letter to the client.
Signature: [Signature]
Date: 01/07/2025
Scale: 1:1000
Site Plan
FOR SERVICES

JDT(HQ)
Member
BPAC

Drawing No:-
ST-02

31-OCT-25