


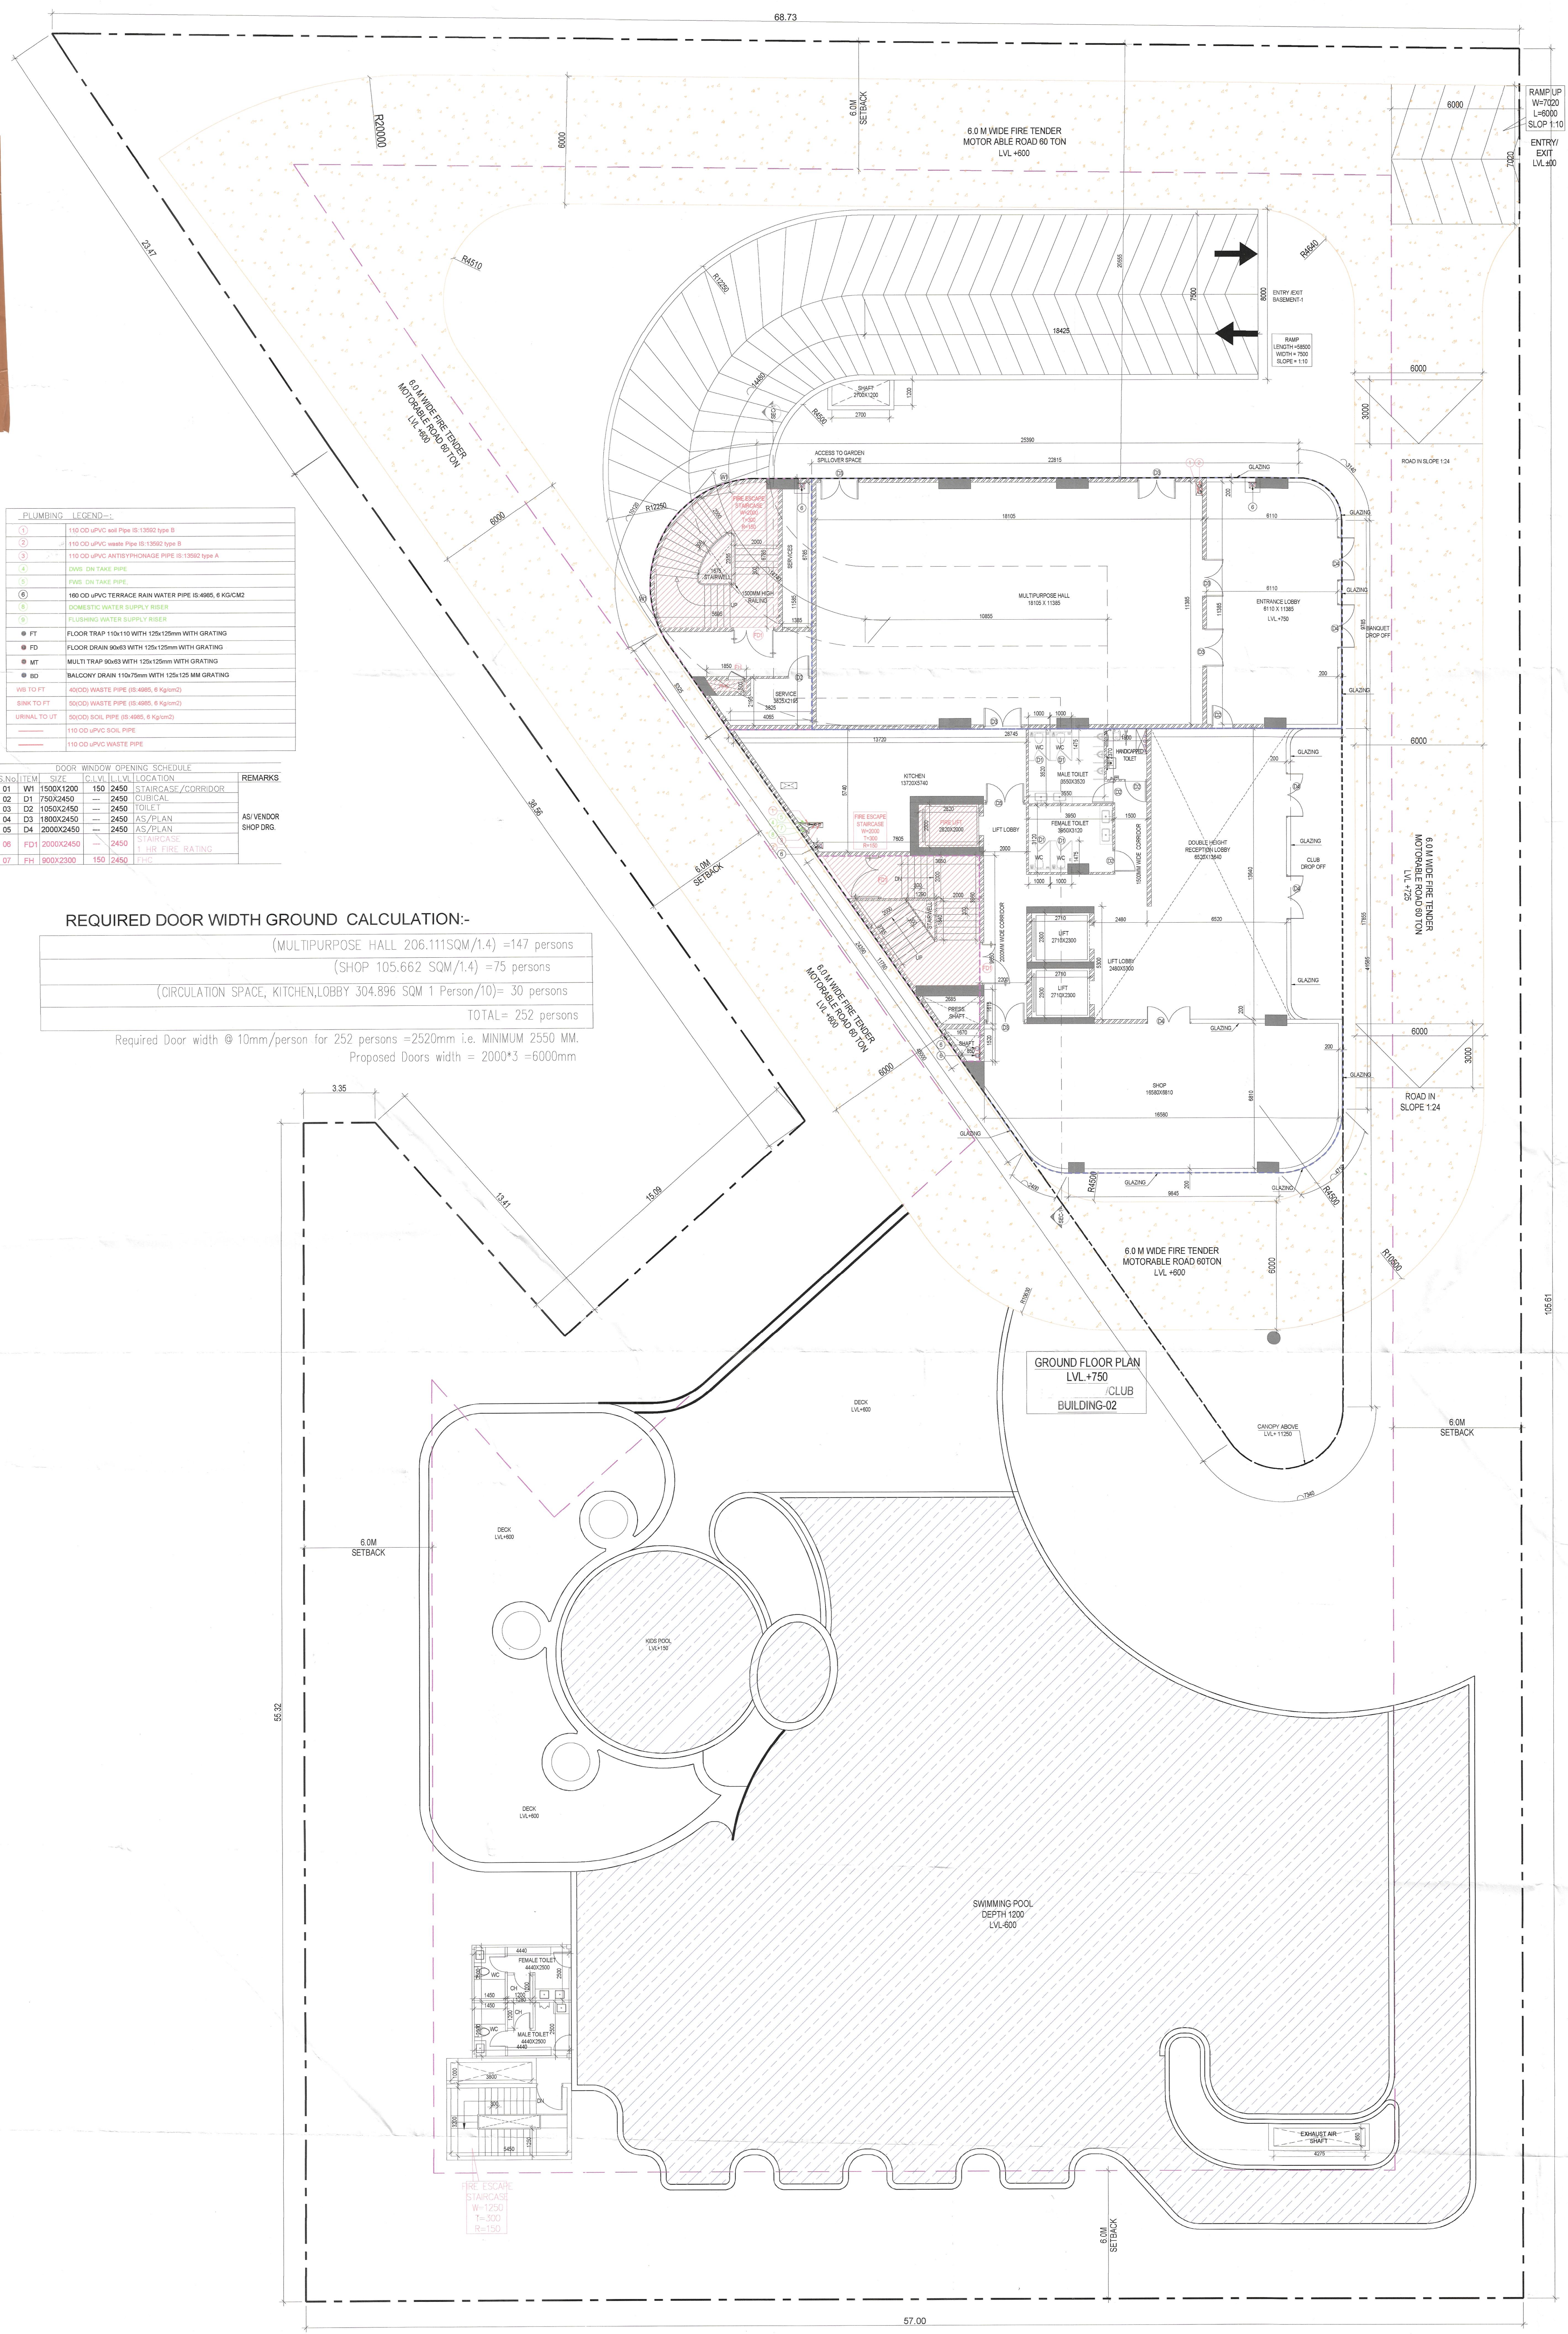

| PLUMBING LEGEND:- |                                                                                   |
|-------------------|-----------------------------------------------------------------------------------|
| ①                 | 110 OD UPVC Soil Pipe IS-1592 type B                                              |
| ②                 | 110 OD UPVC Waste Pipe IS-1592 type B                                             |
| ③                 | 110 OD UPVC Antisiphonage Pipe IS-1592 type A                                     |
| ④                 | DWS IN TAKE PIPE                                                                  |
| ⑤                 | FWS IN TAKE PIPE                                                                  |
| ⑥                 | 180 OD UPVC Terrace Rain Water Pipe IS-4885, 6 KG/CM2 DOMESTIC WATER SUPPLY RISER |
| ⑦                 | FLUISING WATER SUPPLY RISER                                                       |
| ⑧                 | FT FLOOR TRAP 110x110 WITH 125x125mm WITH GRATING                                 |
| ⑨                 | FD FLOOR DRAIN 90x63 WITH 125x125mm WITH GRATING                                  |
| ⑩                 | MT MULTI TRAP 90x63 WITH 125x125mm WITH GRATING                                   |
| ⑪                 | BD BALCONY DRAIN 110x75mm WITH 125x125 MM GRATING                                 |
| ⑫                 | WS TO FT 40/60 WASTE PIPE (IS-4885, 6 Kg/cm2)                                     |
| ⑬                 | BSK TO FT 50/60 WASTE PIPE (IS-4885, 6 Kg/cm2)                                    |
| ⑭                 | UNNAL TO UT 50/60 SOIL PIPE (IS-4885, 6 Kg/cm2)                                   |
| ⑮                 | 110 OD UPVC SOIL PIPE                                                             |
| ⑯                 | 110 OD UPVC WASTE PIPE                                                            |

| DOOR WINDOW OPENING SCHEDULE |               | REMARKS                      |
|------------------------------|---------------|------------------------------|
| S.No                         | ITEM          |                              |
| 01                           | W1 1500X1200  | 150 2450 STAIRCASE /CORRIDOR |
| 02                           | D1 750X2450   | 2450 CUBICAL                 |
| 03                           | D2 1050X2450  | 2450 TOILET                  |
| 04                           | D3 1800X2450  | 2450 AS/PLAN                 |
| 05                           | D4 2000X2450  | 2450 AS/PLAN                 |
| 06                           | FD1 2000X2450 | 2450 STAIRCASE               |
| 07                           | FH 1800X2300  | 150 2450 F.H.                |

REQUIRED DOOR WIDTH GROUND CALCULATION:-

|                                                                                 |
|---------------------------------------------------------------------------------|
| (MULTIPURPOSE HALL 206.111SQM/1.4) =147 persons                                 |
| (SHOP 105.662 SQM/1.4) =75 persons                                              |
| (CIRCULATION SPACE, KITCHEN,LOBBY 304.896 SQM 1 Person/10)= 30 persons          |
| TOTAL= 252 persons                                                              |
| Required Door width @ 10mm/person for 252 persons =2520mm i.e. MINIMUM 2550 MM. |
| Proposed Doors width = 2000*3 =6000mm                                           |

NOTES:-  
ALL FLOOR MECHANICAL VENTILATED LIGHTED & 100% POWER BACKUP.  
AIR CONDITIONING SYSTEM IS BEING PROVIDED.  
DG POWER BACKUP IS BEING PROVIDED.  
TOILET ARE MECHANICAL VENTILATED.  
ALL LIFTS SHALL HAVE POWER BACK-UP.  
ALL ELECTRICAL INSTALLATION SHELL BE AS PER PROVISION OF RELEVANT CODE.  
FIRE/FIGHTING (SAFE) PROVISIONS WILL BE AS PER RELEVANT CODE PROVISIONS.  
BASEMENT AREA SHELL HAVE MECHANICALLY VENTILATED AS PER RELEVANT CODE.  
ALL TOILETS ARE VENTILATED AS PER HARYANA BUILDING CODE 2017.  
BUILDINGS HAS AUTOMATIC SPRINKLER SYSTEM WHEREVER REQUIRED BY RELEVANT CODE.  
BUILDING WILL BE DESIGNED(STRUCTURES) AS PER RELEVANT I.S.CODES FOR EARTHQUAKE RESISTANCE.  
SOLAR PANELS OF REQUIRED CAPACITY SHELL BE PROVIDED.  
AS PER HARE DA/ZONING NORMS.  
ALL HANDICAP RAMPS WITH RAILING.  
ALL FIRE FIGHTING INSTALLATIONS SHELL BE AS PER PROVISION OF RELEVANT CODE.  
THE RAINWATER HARVESTING SYSTEM SHELL BE PROVIDED AS PER CENTRAL GROUND WATER AUTHORITY NORMS.

PROJECT:  
Proposed Building Plans for Phase-1 of Residential Colony under NILP Policy 2022, Licence No. 129 of 2025 Dated 23.07.2025 over an area measuring 11.35625 Acres in the Revenue Estate of Village Ullawas, Sector-60 & 63 A, Gurugram being Developed by Godrej Properties Ltd.

ASSOCIATE ARCHITECTS  
ACPL DESIGN PVT. LTD.  
E - 24, South Extension Part -1, New Delhi, Delhi, India - 110049.

OWNER'S SEAL & SIGNATURE

For Godrej Properties Ltd.  
Authorised Signatory

ARCHITECT'S SEAL & SIGNATURE

Stamp: 607040871, 20251205

MAY-2026 Scale: 1:100  
Drawing Title:-  
Drawing No:-

CLUB BUILDING-02  
GROUND FLOOR PLAN  
C82-01