


This is a "PROVISIONAL BUILDING PLAN" approved only for the purpose of inviting objections from the public.

Ushaan Jha
S.T.P. (H)
Member Secretary
B.P.A.C.

S.T.P. (G)
Member
B.P.A.C.

C.T.P. (H)
Chairman
B.P.A.C.

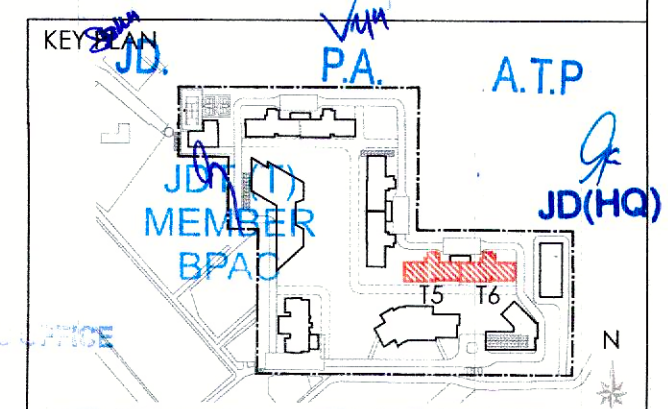

NOTES

DOOR/WINDOW SCHEDULE (TOWERS)

S. DOOR NO. TAGS WIDTH LINTEL CELL LOCATION FIRE RATINGS

1 D2 1050 2400 0 Bedroom

2 D3 900 2400 0 Kitchen

3 D4 800 2400 0 Toilet

4 D4 1200 2400 0 GF Lobby

5 D9 1250 2400 0 Staircase

EXTERNAL DOORS

6 SD1 2400 2400 0 M. Bedroom

7 SD2 2025 2400 0 Bedroom

8 SD3 1800 2400 0 Bedroom

9 SD4 2750 2400 0 Bedroom

10 SD5 3770 2400 0 Living/Dining

11 SD4 3370 2400 0 Living/Dining

12 SD4 4700 2400 0 M. Bedroom

13 SD8 3475 2400 0 M. Bedroom

14 SD9 3300 2400 0 Bedroom

15 D5 1000 2400 0 W.C.

16 D7 800 2400 0 W.C.

17 D8 900 2400 0 Utility

18 DW1 2475 2400 0 Kitchen

WINDOWS

19 V1 600 2400 1200 Toilet

20 W1 3075 2400 1200 M. Toilet

21 W2 900 2400 1200 Utility/Bedroom

22 W3 1250 2400 1200 Staircase

23 W4 1750 2400 1200 Staircase

24 W4 2425 2400 1200 M. Toilet

25 W7 700 2400 1200 Bedroom

26 W8 1550 2400 1200 Staircase

27 AD1 750 2400 1200 Toilet

28 GD1 1800 2400 0 GF Lobby

29 G1 3300/1675/5390 5200 0 GF Lobby

30 G2 2725 5200 0 GF Lobby

31 G3 4070 5200 0 GF Lobby

32 G4 350 5200 0 GF Lobby

33 G5 2145 5200 0 GF Lobby

34 G6 16940 5200 0 GF Lobby

35 G7 2275/3400 5200 0 GF Lobby

36 G8 5380/7875/6250 5200 0 GF Lobby

37 G9 2500 5200 0 GF Lobby

38 G10 1800 2400 0 M. Bedroom

39 G11 1675/1200/1080 5200 0 GF Lobby

40 G12 600 5200 0 GF Lobby

41 G13 4000/1050 5200 0 GF Lobby

42 G14 4695 5200 0 GF Lobby

43 G15 6472/2470 5200 0 GF Lobby

RIDDERS AND WINDOW

44 FD1 1500 2400 0 Entrance

45 FD2 1250 2400 0 Staircase

46 FD3 1000 2400 75 M.V. Shaft

47 FD4 900 2400 75 L.V. Shaft

48 FD5 900 2400 0 Utility/Service

49 FD6 1000 2400 0 Lift

50 FD7 400 2400 75 AC Ref. Shaft

51 FD8 900 2400 1200 Staircase

52 FD9 1250 2400 1200 Staircase

53 FD10 1750 2400 1200 Staircase

54 FD11 900 2400 75 FHC Shaft

55 HD1 900 2400 75 FHC Shaft

56 HD2 1200 2400 75 FHC Shaft

CLIENT

Birla Estates Pvt. Ltd. in collaboration with Barmalt

India Pvt. Ltd.

PROOF CHECK CONSULTANT

Skeleton Consultants Pvt. Ltd.

2nd Floor, A-75, Sector 5, Noida, Uttar Pradesh-201301

GEO TECHNICAL CONSULTANT

Cengs Geotechnica Pvt. Ltd.

A-100, Sector 63, Noida, Uttar Pradesh-201309

STRUCTURES

WHITBY WOOD PRITAMDASANI, MUMBAI

Unit 1101 | Lodha Supremus | Powai, Andheri

(East) | Mumbai-400072 | Maharashtra | India

T: +91-9820-186879

m.pritamdasani@whitbywood.com

MEP

SNC, SUNIL NAYYAR CONSULTING ENGINEERS LLP

206-206A & 305A-305B, 2nd & 3rd Floor

Sector 54 | Gurgaon-122002 | Haryana | India

T: +91-124-4803800

Email: sncgurgaon@snc.co.in

LANDSCAPE

SWA, LAGUNA BEACH

570 | Glenneyre Street | Laguna

Beach | California-92651 | USA

T: +1-714-477-5471 | D: +1-949-607-0174 |

F: +1-714-477-5471 | E: info@swagroup.com

Checked and Approved by: [Signature]

Internal Use Only - For Comments In

Architect's Signature

OWNER'S SIGNATURE

for BIRLA ESTATES PVT. LTD.

Authorized Signatory

DRAWING TITLE

GROUP HOUSING COLONY

(TOWER-T5&T6)

FIRST FLOOR PLAN

AR-15T6-102

PLUMBING LEGEND:

DWS DOMESTIC WATER SUPPLY

FWS FLUSHING WATER SUPPLY

MFT MULTI FLOOR TRAP

FT FLOOR TRAP

UT URINAL TRAP

FD FLOOR DRAIN

PCO FLOOR CLEAN OUT PLUG

COP CLEAN OUT PLUG

BD BALCONY DRAIN

DP DRAIN POINT

PLUMBING LEGEND:

1 1000/1100 SOIL PIPE

2 1000/1100 WASTE PIPE

3 1000/1100 WASHING MACHINE WASTE WATER PIPE

4 1000/1100 KITCHEN WASTE PIPE

5 750 VENT PIPE

6 1000/1100 RAIN WATER PIPE FOR BALCONY

7 1000/1100 RAIN WATER PIPE FOR REFUGE TERRACE

8 1000/1600 RAIN WATER PIPE FOR TERRACE

9 DOMESTIC WATER SUPPLY (BOOZER) (TOP SIX FLOORS)

10 DOMESTIC WASH-DISK WATER SUPPLY (BY GRAVITY)

11 DOMESTIC WATER SUPPLY (BY GRAVITY) EXPRESS DWN

12 FLUSHING WATER SUPPLY (BY GRAVITY)

13 FLUSHING WATER SUPPLY (BY GRAVITY) EXPRESS DWN

14 DOMESTIC WATER SUPPLY RISER FOR C.H. TANK

15 FLUSHING WATER SUPPLY RISER FOR C.H. TANK

16 750 HYVAC DRAIN PIPE

SN FIRE FIGHTING PIPE LEGEND:-

A1 1500 FIRE HYDRANT PIPE FOR ZONE-1

A2 1500 FIRE HYDRANT PIPE FOR ZONE-2

A3 1500 FIRE HYDRANT PIPE FOR ZONE-3

A4 1500 FIRE HYDRANT PIPE FOR ZONE-4

B1 1500 SPRINKLER PIPE FOR ZONE-1

B2 1500 SPRINKLER PIPE FOR ZONE-2

B3 1500 SPRINKLER PIPE FOR ZONE-3

B4 1500 SPRINKLER PIPE FOR ZONE-4

C1 1500 SPRINKLER PIPE FOR ZONE-1 (STAND BY)

C2 1500 SPRINKLER PIPE FOR ZONE-2 (STAND BY)

C3 1500 SPRINKLER PIPE FOR ZONE-3 (STAND BY)


C4 1500 SPRINKLER PIPE FOR ZONE-4 (STAND BY)

D 800 DRAIN PIPE

E 1500 FIRE DOWN COMER

FHC FIRE HOSE CABINET

01 FIRST FLOOR PLAN (TOWER T5 & T6)
(LVL +6750) SCALE 1:150

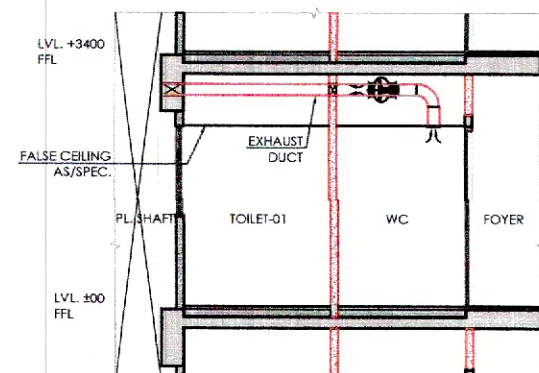

TYPICAL MECHANICAL VENTILATION/IRCULATION FOR PDR

S.NO.	LOCATION	AREA (SQ. FT.)	HEIGHT (FT.)	VOLUME (CU. FT.)	DESIGN CFM	SELECTED EXHAUST FAN	FAN SIZE	EXHAUST DUCT SIZE
1	PDR TOILET	32.00	10.00	320	100	INLINE FAN	3250	200x150

NOTES :-

- VRV System is being provided.
- Full DG power back up is being provided.
- Toilets are mechanical ventilated.
- All lifts shall have 100% power back-up.
- All electrical installations shall be as per provision of nbc.
- Fire-fighting/safety provisions will be as per relevant nbc provisions.
- Basement area shall have mechanically ventilated as per relevant code.
- All toilets are ventilated as per haryana building code 2017.
- Building has automatic sprinkler system wherever required by nbc.
- Building will be designed (structures) as per relevant i.s. codes for earthquake resistance.
- Solar panels of required capacity shall be provided on roof top as per hareda/zoning norms.
- All handicap ramps with railing.
- All fire fighting installations shall be as per provision of nbc.
- The rainwater harvesting system shall be provided as per central ground water Authority norms.

NOTES:-

- REFER DRAWING NO. AR-15T6-201, 202 & 203 FOR ELEVATIONS
- REFER DRAWING NO. AR-15T6-301 FOR SECTIONS
- T5 IS SIMILAR TO T6

NOTES:-

- REFER TYPICAL FLOOR FOR AREA DIAGRAM (DRAWING NO. AR-15T6-103).