




STILT FLOOR PLAN
TOWER - I
LVL +300

STILT FLOOR F.A.R. (T+H)						
ADDITIONS		PREFIX		LENGTH	BREATH	AREA
S.N.O.	NO.					
A	1	1	3.300	4.750	15.675	
B	1	1	3.450	5.700	19.640	
C	1	1	2.500	3.500	8.750	
D	1	1	6.975	4.050	28.348	
E	1	1	0.775	1.050	0.814	
F	1	1	3.300	4.750	15.675	
G	2	1	3.300	3.175	10.485	
H	1	1	0.775	1.200	0.930	
J	1	1	0.700	0.150	0.105	
TOTAL ADDITION						111.397
SUBTRACTIONS						
1	2	1	2.840	2.715	15.421	
2	1	1	3.075	5.190	15.959	
TOTAL SUBTRACTION						31.380
TOTAL STILT FLOOR F.A.R.						80.016

AREA UNDER SERVICES						
ADDITIONS		PREFIX		LENGTH	BREATH	AREA
S.N.O.	NO.					
1	2	1	2.840	2.715	15.421	
2	1	1	3.075	5.190	15.959	
TOTAL ADDITION						31.380
TOTAL AREA						31.380

GROUND COVERAGE						
ADDITIONS		PREFIX		LENGTH	BREATH	AREA
S.N.O.	NO.					
A	1	1	26.055	28.625	745.824	
TOTAL ADDITION						745.824
SUBTRACTIONS						
1	1	1	0.000	0.000	0.000	
TOTAL SUBTRACTION						0.000
TOTAL GROUND COVERAGE						745.824

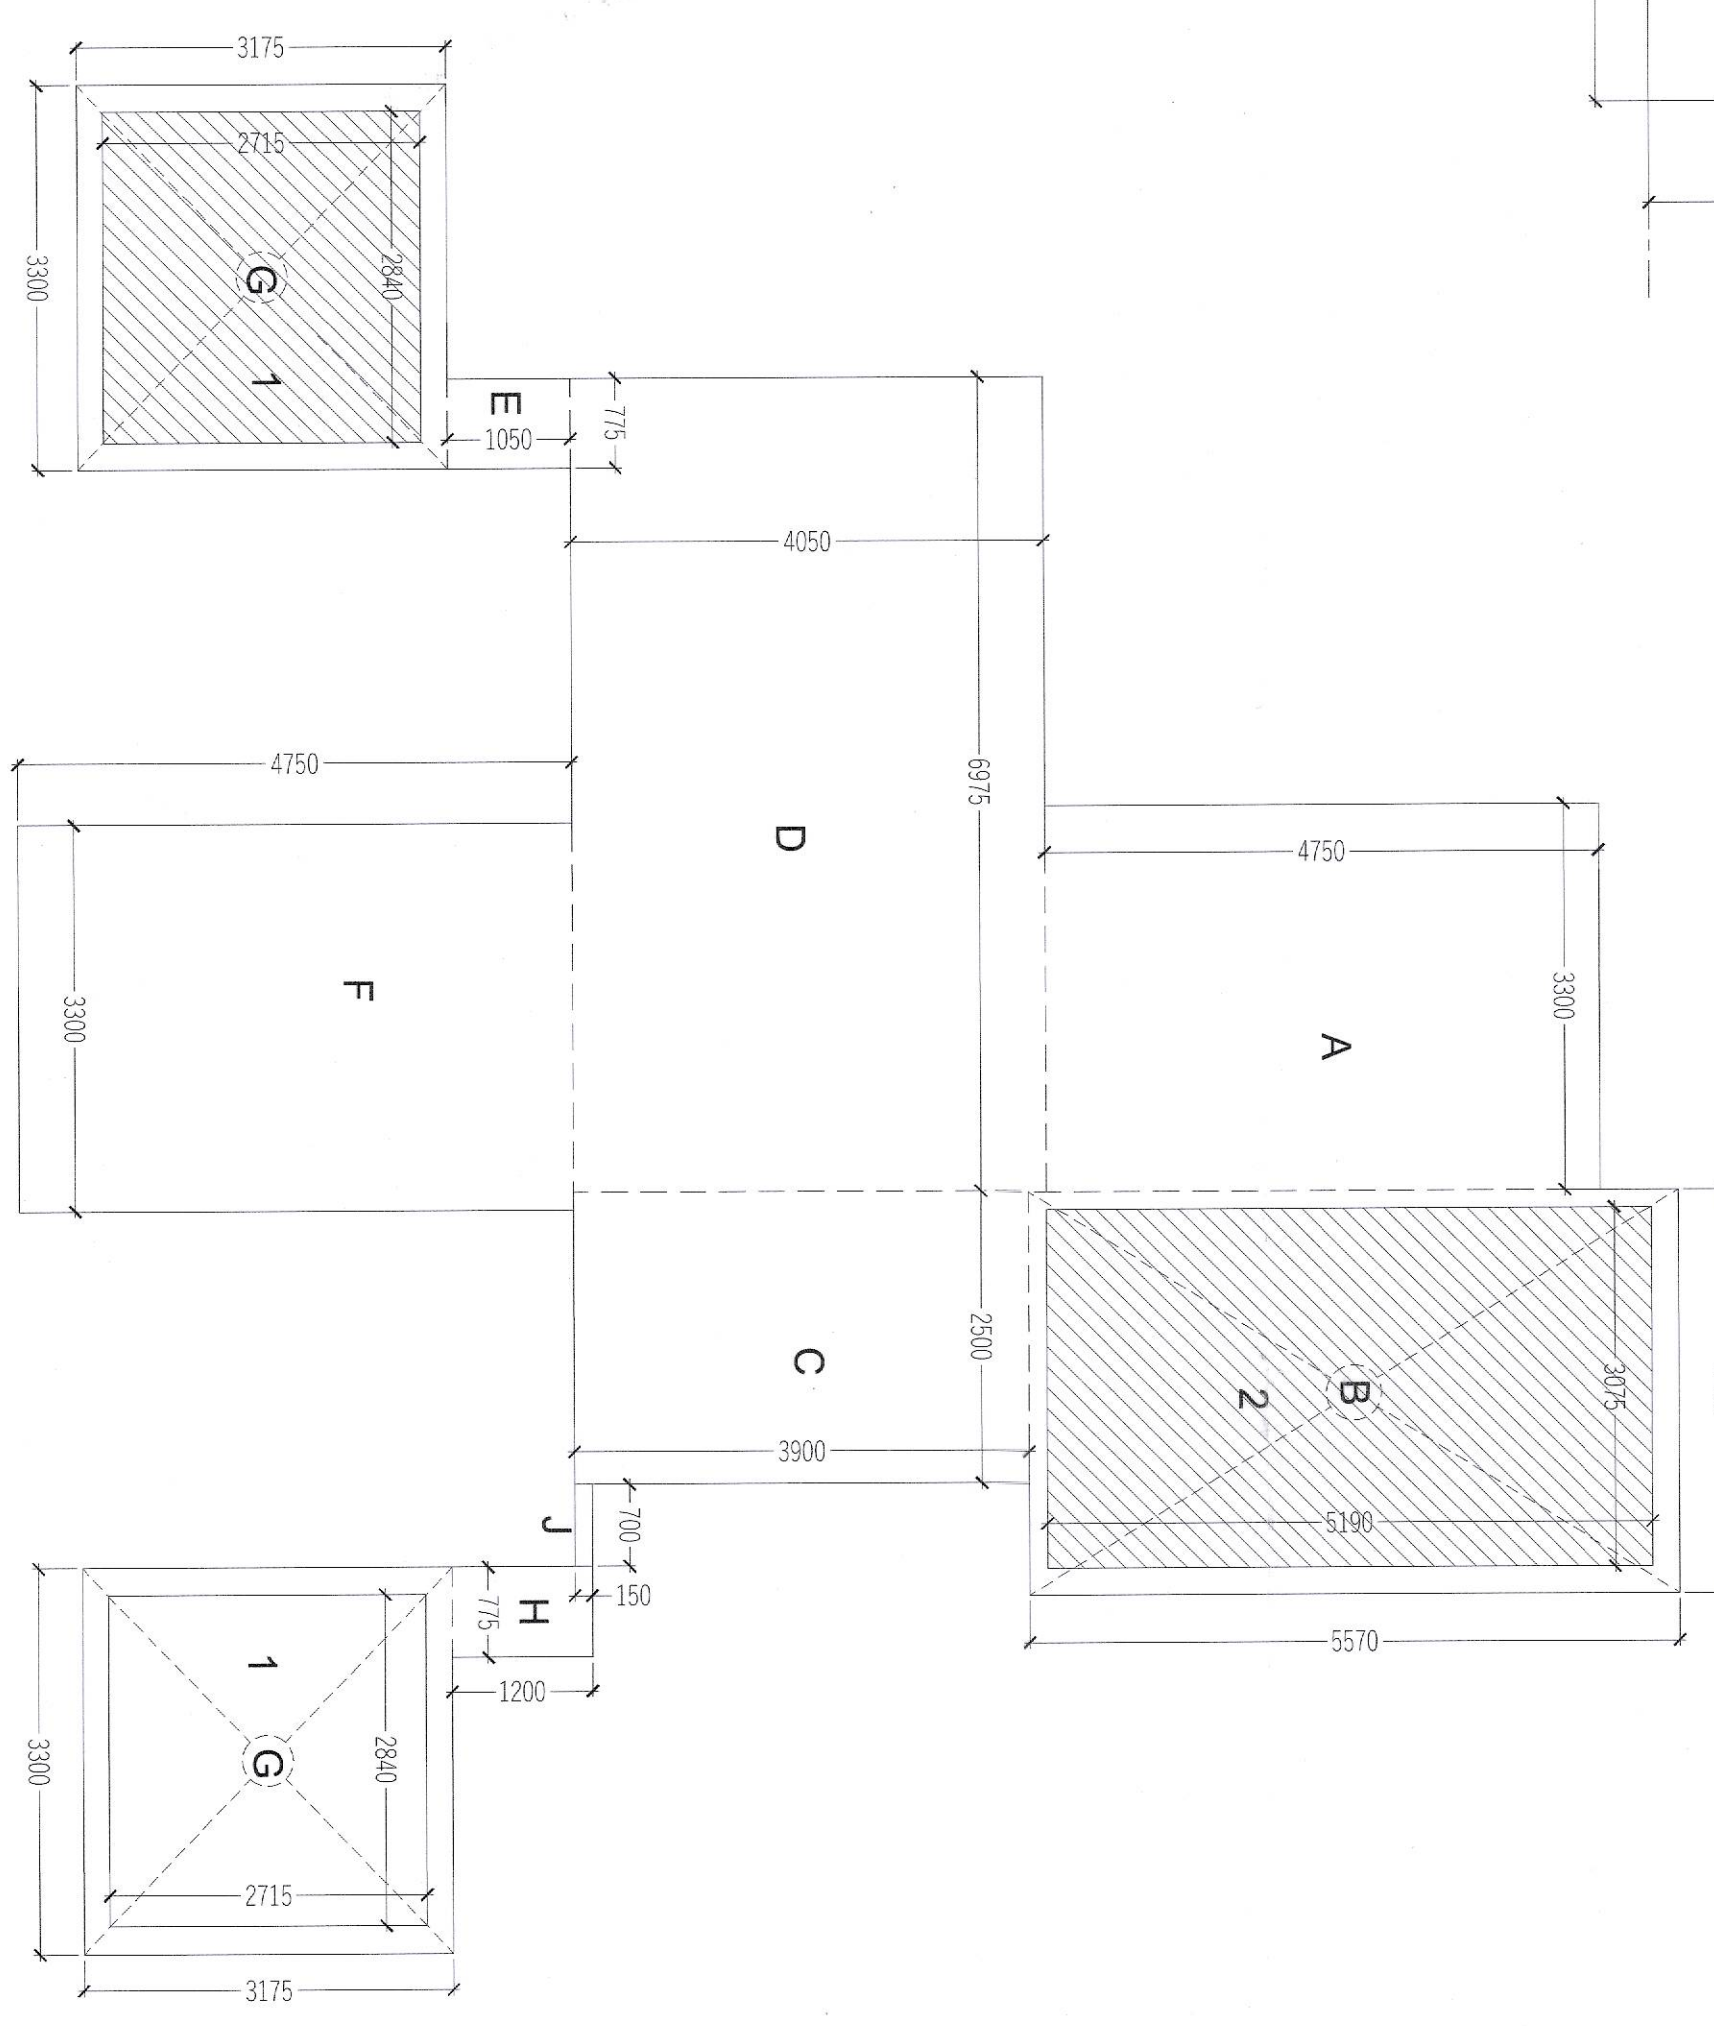

GROUND FL. F.A.R. AREA DIAGRAM
TOWER - I

GROUND COVERAGE AREA DIAGRAM
TOWER - I

NAME	WIDTH	HEIGHT	COL	UNIT
DW1	750	2450	600	2450
DW2	2000	2450	600	2450
DW3	1450	2450	600	2450
DW4	1450	2450	600	2450
DW5	1000	2450	1050	2450
DW6	1000	2450	600	2450
DW7	2275	2450	600	2450
DW8	2670	2450	600	2450
DW9	2670	2450	600	2450
DW10	2670	2450	600	2450
DW100	2670	2450	600	2450

FIRE FIGHTING LEGEND:-			
1	1500 SPRINKLER PIPE		
2	1500 DRAIN PIPE		
3	1500 FIRE EXTINGUISHER		
4	4.5 KG CO2 FIRE EXTINGUISHER		
5	WATER CO2 FIRE EXTINGUISHER		
6	WATER CO2 FIRE EXTINGUISHER		
7	WATER CO2 FIRE EXTINGUISHER		
100	WATER CO2 FIRE EXTINGUISHER		

DATE: SEP-2023

SCALE: 1:50 (A1)

SHEET NO. T-41

DRAWING TITLE: TOWER - I STILT FLOOR PLAN & AREA CALCULATION

OWNERS SIGNATURE: For S. Development Pvt. Ltd.

ARCHITECT SIGNATURE: ARCHITECT SIGNATURE

PROJECT: TOWER - I STILT FLOOR PLAN & AREA CALCULATION

APPROVAL OF REVISED BUILDING PLANS OF PHASE-II FALLING IN AFFORDABLE GROUP HOUSING COLONY OVER AN AREA MEASURING 9.684 ACRES (LICENSE NO.236 OF 2023 DATED 02.11.2023 AND LICENSE NO.269 OF 2023 DATED 28.12.2023) IN SECTOR-36 SOHNA BEING DEVELOPED BY AS DEVELOPERS PVT.LTD.

LEGEND:-

- STRUCTURAL WALL/COLUMN
- 150mm R.C.C. NON STRUCTURAL WALL
- 75mm R.C.C. NON STRUCTURAL WALL
- 100mm R.C.C. NON STRUCTURAL WALL

NOTES:

- ALL DIMENSIONS IN MM.
- ALL INTERNAL WALLS ARE 75MM AND EXTERNAL WALLS ARE 100MM.
- DOOR SHALL BE WITH 100% POWER BACKUP.
- DOOR IS SHOWN IN RED.

PROJECT: TOWER - I STILT FLOOR PLAN & AREA CALCULATION

DATE: SEP-2023

SCALE: 1:50 (A1)

SHEET NO. T-41