


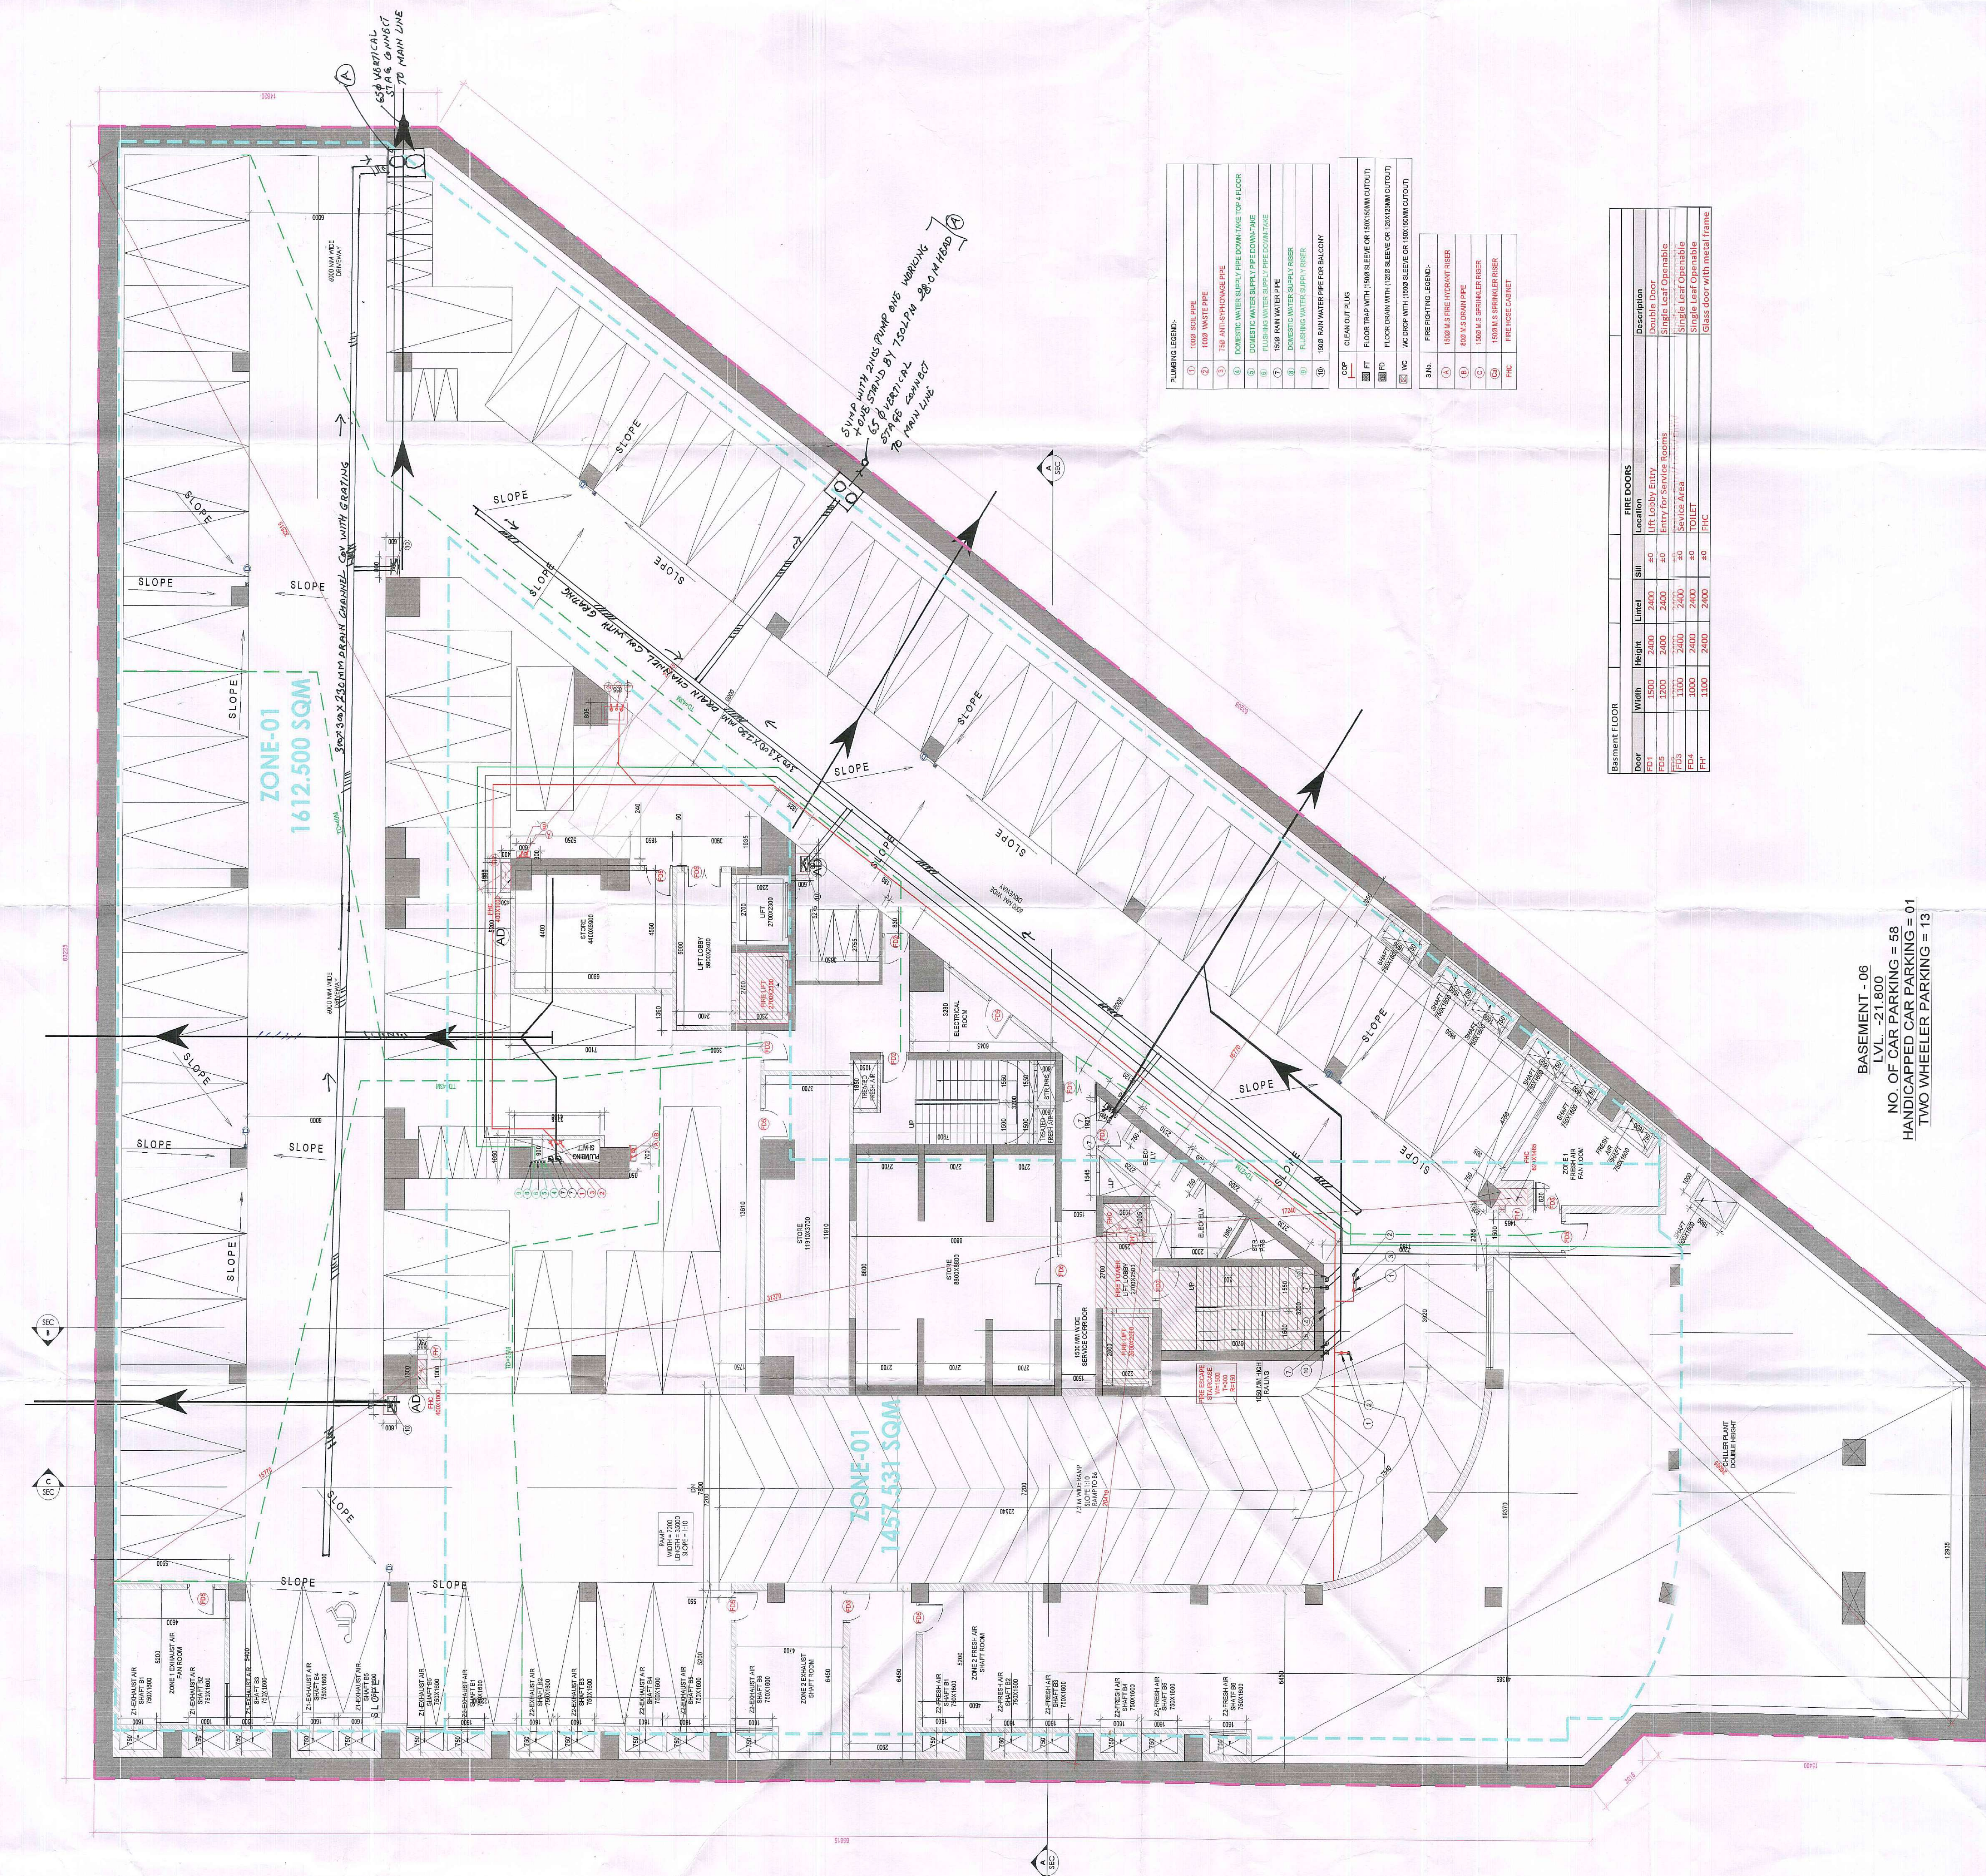

BASEMENT - 06
LVL. -21.500
NO. OF CAR PARKING = 58
HANDICAPPED PARKING 01
TWO WHEELER PARKING 13

PLUMBING LEGEND	
1. WATER SUPPLY PIPE	2. WATER SUPPLY PIPE
3. WATER SUPPLY PIPE	4. WATER SUPPLY PIPE
5. WATER SUPPLY PIPE	6. WATER SUPPLY PIPE
7. WATER SUPPLY PIPE	8. WATER SUPPLY PIPE
9. WATER SUPPLY PIPE	10. WATER SUPPLY PIPE
11. WATER SUPPLY PIPE	12. WATER SUPPLY PIPE
13. WATER SUPPLY PIPE	14. WATER SUPPLY PIPE
15. WATER SUPPLY PIPE	16. WATER SUPPLY PIPE
17. WATER SUPPLY PIPE	18. WATER SUPPLY PIPE
19. WATER SUPPLY PIPE	20. WATER SUPPLY PIPE
21. WATER SUPPLY PIPE	22. WATER SUPPLY PIPE
23. WATER SUPPLY PIPE	24. WATER SUPPLY PIPE
25. WATER SUPPLY PIPE	26. WATER SUPPLY PIPE
27. WATER SUPPLY PIPE	28. WATER SUPPLY PIPE
29. WATER SUPPLY PIPE	30. WATER SUPPLY PIPE
31. WATER SUPPLY PIPE	32. WATER SUPPLY PIPE
33. WATER SUPPLY PIPE	34. WATER SUPPLY PIPE
35. WATER SUPPLY PIPE	36. WATER SUPPLY PIPE
37. WATER SUPPLY PIPE	38. WATER SUPPLY PIPE
39. WATER SUPPLY PIPE	40. WATER SUPPLY PIPE
41. WATER SUPPLY PIPE	42. WATER SUPPLY PIPE
43. WATER SUPPLY PIPE	44. WATER SUPPLY PIPE
45. WATER SUPPLY PIPE	46. WATER SUPPLY PIPE
47. WATER SUPPLY PIPE	48. WATER SUPPLY PIPE
49. WATER SUPPLY PIPE	50. WATER SUPPLY PIPE
51. WATER SUPPLY PIPE	52. WATER SUPPLY PIPE
53. WATER SUPPLY PIPE	54. WATER SUPPLY PIPE
55. WATER SUPPLY PIPE	56. WATER SUPPLY PIPE
57. WATER SUPPLY PIPE	58. WATER SUPPLY PIPE
59. WATER SUPPLY PIPE	60. WATER SUPPLY PIPE
61. WATER SUPPLY PIPE	62. WATER SUPPLY PIPE
63. WATER SUPPLY PIPE	64. WATER SUPPLY PIPE
65. WATER SUPPLY PIPE	66. WATER SUPPLY PIPE
67. WATER SUPPLY PIPE	68. WATER SUPPLY PIPE
69. WATER SUPPLY PIPE	70. WATER SUPPLY PIPE
71. WATER SUPPLY PIPE	72. WATER SUPPLY PIPE
73. WATER SUPPLY PIPE	74. WATER SUPPLY PIPE
75. WATER SUPPLY PIPE	76. WATER SUPPLY PIPE
77. WATER SUPPLY PIPE	78. WATER SUPPLY PIPE
79. WATER SUPPLY PIPE	80. WATER SUPPLY PIPE
81. WATER SUPPLY PIPE	82. WATER SUPPLY PIPE
83. WATER SUPPLY PIPE	84. WATER SUPPLY PIPE
85. WATER SUPPLY PIPE	86. WATER SUPPLY PIPE
87. WATER SUPPLY PIPE	88. WATER SUPPLY PIPE
89. WATER SUPPLY PIPE	90. WATER SUPPLY PIPE
91. WATER SUPPLY PIPE	92. WATER SUPPLY PIPE
93. WATER SUPPLY PIPE	94. WATER SUPPLY PIPE
95. WATER SUPPLY PIPE	96. WATER SUPPLY PIPE
97. WATER SUPPLY PIPE	98. WATER SUPPLY PIPE
99. WATER SUPPLY PIPE	100. WATER SUPPLY PIPE

FIRE DOORS	
NO.	DESCRIPTION
1	Fire Door
2	Fire Door
3	Fire Door
100	Fire Door

AREA CALCULATION OF BASEMENT - 06	
NO.	DESCRIPTION
1	Area
2	Area
3	Area
100	Area

Note :-
ALL FLOOR MECHANICAL VENTILATED
LIFT SHAFTS SHALL BE PROVIDED
WITH MECHANICAL VENTILATION
SYSTEMS AS BEING PROVIDED.
TOILET ARE MECHANICAL VENTILATED.
ALL LIFTS SHALL HAVE POWER BACK-UP.
ALL ELECTRICAL INSTALLATION SHALL BE AS
PER PROVISION OF RELEVANT CODE.
FIRE FIGHTING SAFETY PROVISIONS WILL BE
AS PER PROVISION OF RELEVANT CODE.
BASEMENT AREA SHALL HAVE MECHANICAL
VENTILATED AS PER RELEVANT CODE.
ALL TOILETS ARE VENTILATED AS PER
HARYANA BUILDING CODE 2017.
BUILDINGS HAS AUTOMATIC SPRINKLER
SYSTEM WHEREVER REQUIRED BY RELEVANT
CODE.
ALL ELECTRICAL INSTALLATION SHALL BE
AS PER PROVISION OF RELEVANT
CODE.
SOLAR PANELS OF REQUIRED CAPACITY SHALL
BE PROVIDED AS PER HARE DAZONING
NORMS.
ALL HANDICAP RAMP WITH RAILING
ALL FIRE FIGHTING INSTALLATIONS SHALL BE
AS PER PROVISION OF RELEVANT CODE.
THE RAINWATER HARVESTING SYSTEM SHALL
BE PROVIDED AS PER CENTRAL GROUND
WATER AUTHORITY NORMS.

PROJECT:
PROPOSED BUILDING PLAN OF COMMERCIAL
COMPLEX SITE AREA 1000 SQM IN
4043.03 SQM IN SECTOR 28, GURUGRAM

OWNER'S
ACQUISITIVE INFRADEVELOPERS PVT. LTD.
WITH LODHA DEVELOPERS LIMITED.

OWNER'S SEAL
& SIGNATURE

ARCHITECT'S SEAL
& SIGNATURE

MAY - 2025 Scale : 1:100
Drawing No.:
BASMENT OF PLAN &
AREA CALCULATION
BSPF Particular

B5-06