
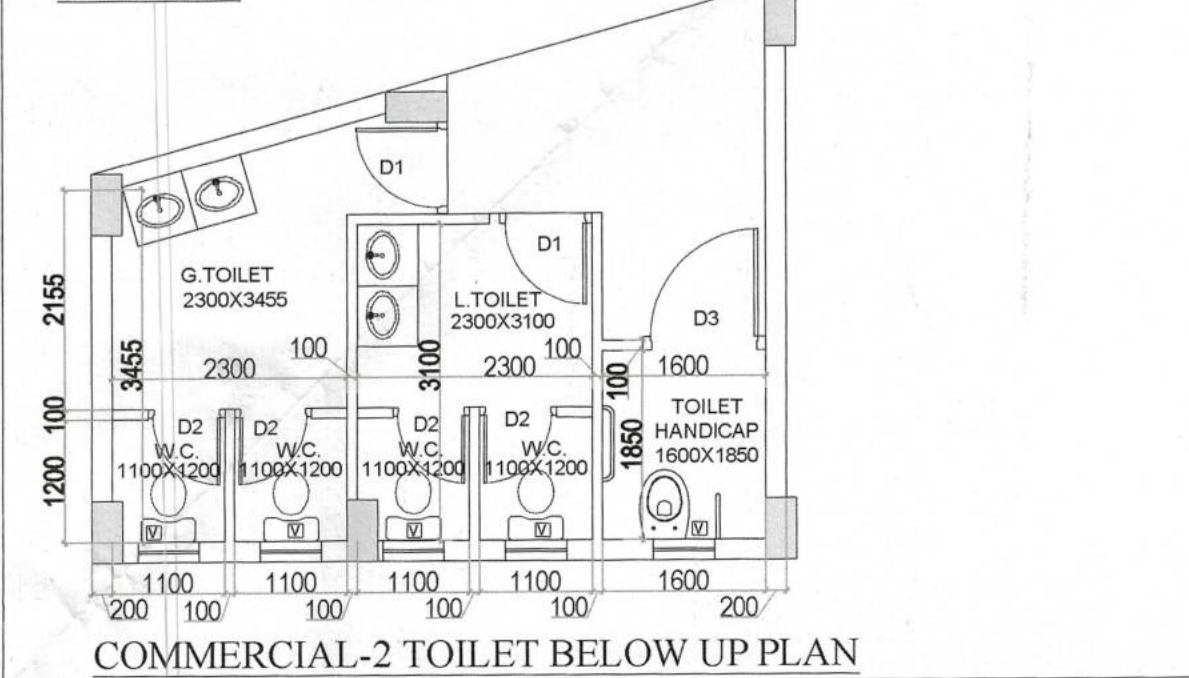
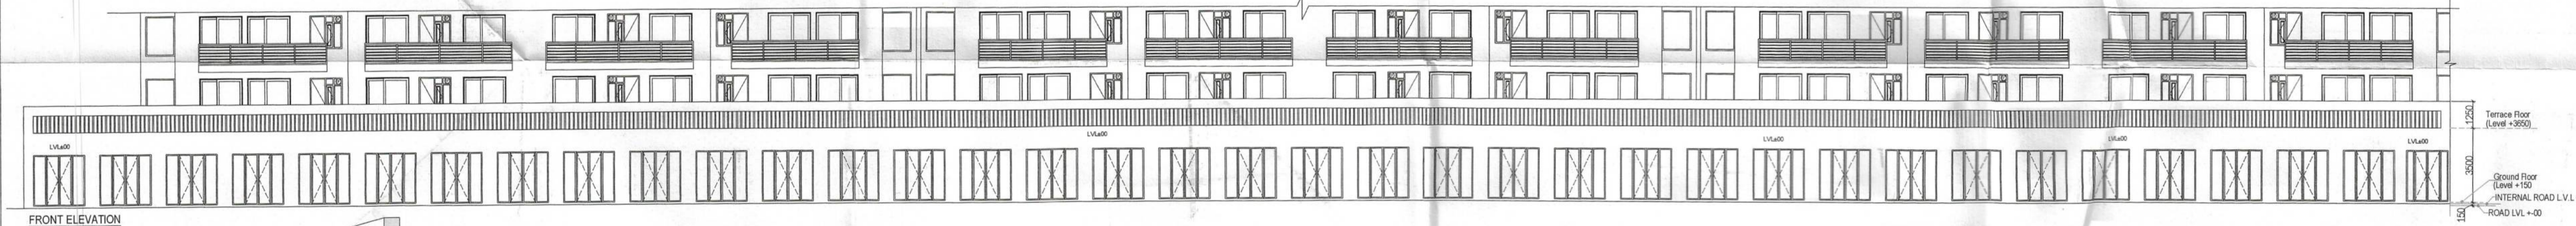
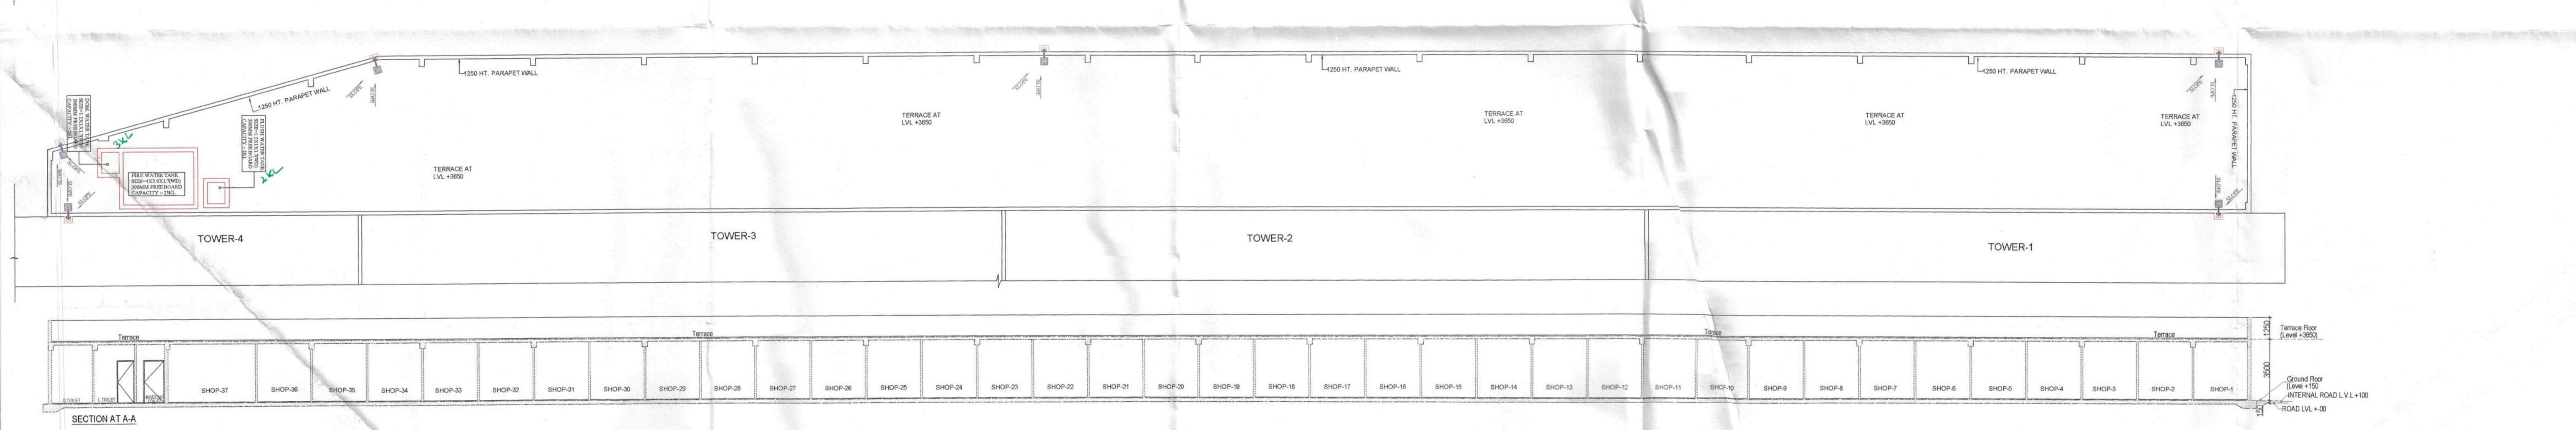
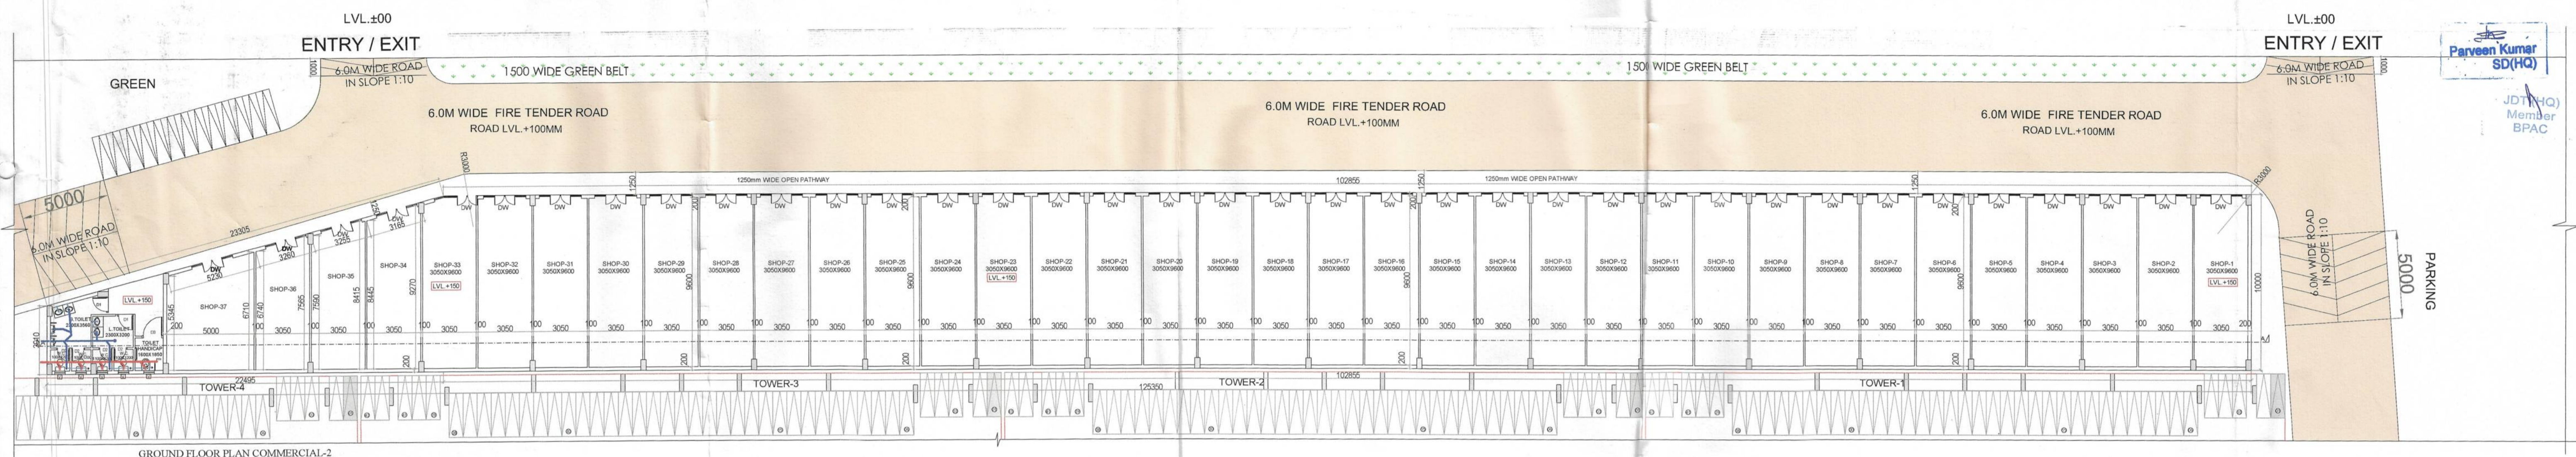


SANCTIONED  
TO BE READ WITH THIS OFFICE  
MEMO NO.:  
DATED:

S.T.P. (HQ) Member Secretary B.P.A.C.  
S.T.P. (G) Member B.P.A.C.  
S.T.P. (HR) Chairman B.P.A.C.  
AD  
PA  
ATP

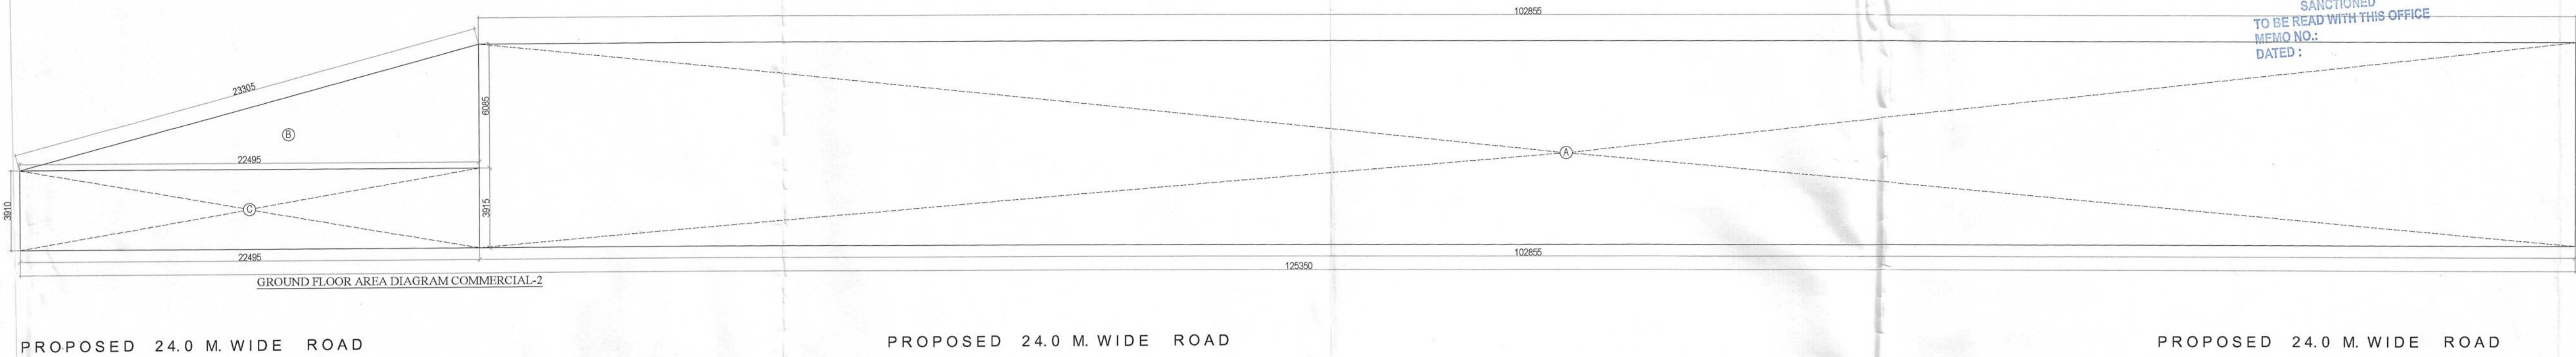

PLUMBING LEGEND

SYMBOL	DESCRIPTION
1	11500mm VERTICAL PIPE
2	11500mm HORIZONTAL PIPE
3	11500mm WASTE PIPE
4	11500mm WASTE WATER VERTICAL PIPE
5	11500mm WASTE WATER HORIZONTAL PIPE
6	11500mm HOT WATER VERTICAL PIPE
7	11500mm HOT WATER HORIZONTAL PIPE
8	11500mm COLD WATER VERTICAL PIPE
9	11500mm COLD WATER HORIZONTAL PIPE
10	11500mm GAS VERTICAL PIPE
11	11500mm GAS HORIZONTAL PIPE
12	11500mm CONDENSATE VERTICAL PIPE
13	11500mm CONDENSATE HORIZONTAL PIPE
14	11500mm RAIN WATER VERTICAL PIPE
15	11500mm RAIN WATER HORIZONTAL PIPE
16	11500mm S.W. VERTICAL PIPE
17	11500mm S.W. HORIZONTAL PIPE
18	11500mm S.W. VERTICAL PIPE
19	11500mm S.W. HORIZONTAL PIPE
20	11500mm S.W. VERTICAL PIPE
21	11500mm S.W. HORIZONTAL PIPE

COMMERCIAL-2 GROUND FLOOR AREA CHART

NO.	TYPE	AREA (SQ. M)	TOTAL AREA (SQ. M)
A	1 X	102.855 X 10.000	= 1028.55
B	0.5 X	22.495 X 6.085	= 68.44
C	1 X	22.495 X 3.915	= 88.07
<b>FAR AREA / BUILTUP AREA</b>			<b>1185.06</b>

DOOR WINDOW SCHEDULE

	SIZE	CILL LEVEL	LINTEL LEVEL
DW	2400 X 2400	00MM	2400MM
D1	900 X 2400	00MM	2400MM
D2	750 X 2400	00MM	2400MM
D3	1200 X 2400	00MM	2400MM
V	600 X 1200	1200MM	2400MM

CLIENT:-  
M/S NOWARA REALTY LLP  
PROJECT :-  
PROPOSED BUILDING PLAN OF AFFORDABLE GROUP HOUSING COLONY FOR AN AREA MEASURING 8.84375 ACRE (LICENCE NO.73 DATED 22.05.2025) FALLING IN THE REVENUE ESTATE OF VILLAGE FARUKHAGAR, SECTOR-3, FARUKHAGAR, DISTT. GURUGRAM BEING DEVELOPED BY SH. ANIL KUMAR JAIN S/O SH MAHENDER KUMAR JAIN SMT. SUDESH W/O SH. RAJENDER IN COLLABORATION WITH NOWARA REALTY LLP

ARCHITECTS  
Pratishtha Architects Pvt. Ltd. (Member of Engineering Council of India)  
838, SECTOR 14, GURGAON (HARYANA)  
HSPV, Patna  
DRAWING NO. SUB-19

For NOWARA REALTY LLP  
Authorised Signatory  
VIMAL BAJAJ  
Architect CA/96/1979/1  
938, Sector-14, Gurgaon

APPLICANT'S SIGN. ARCHITECT'S SIGN