



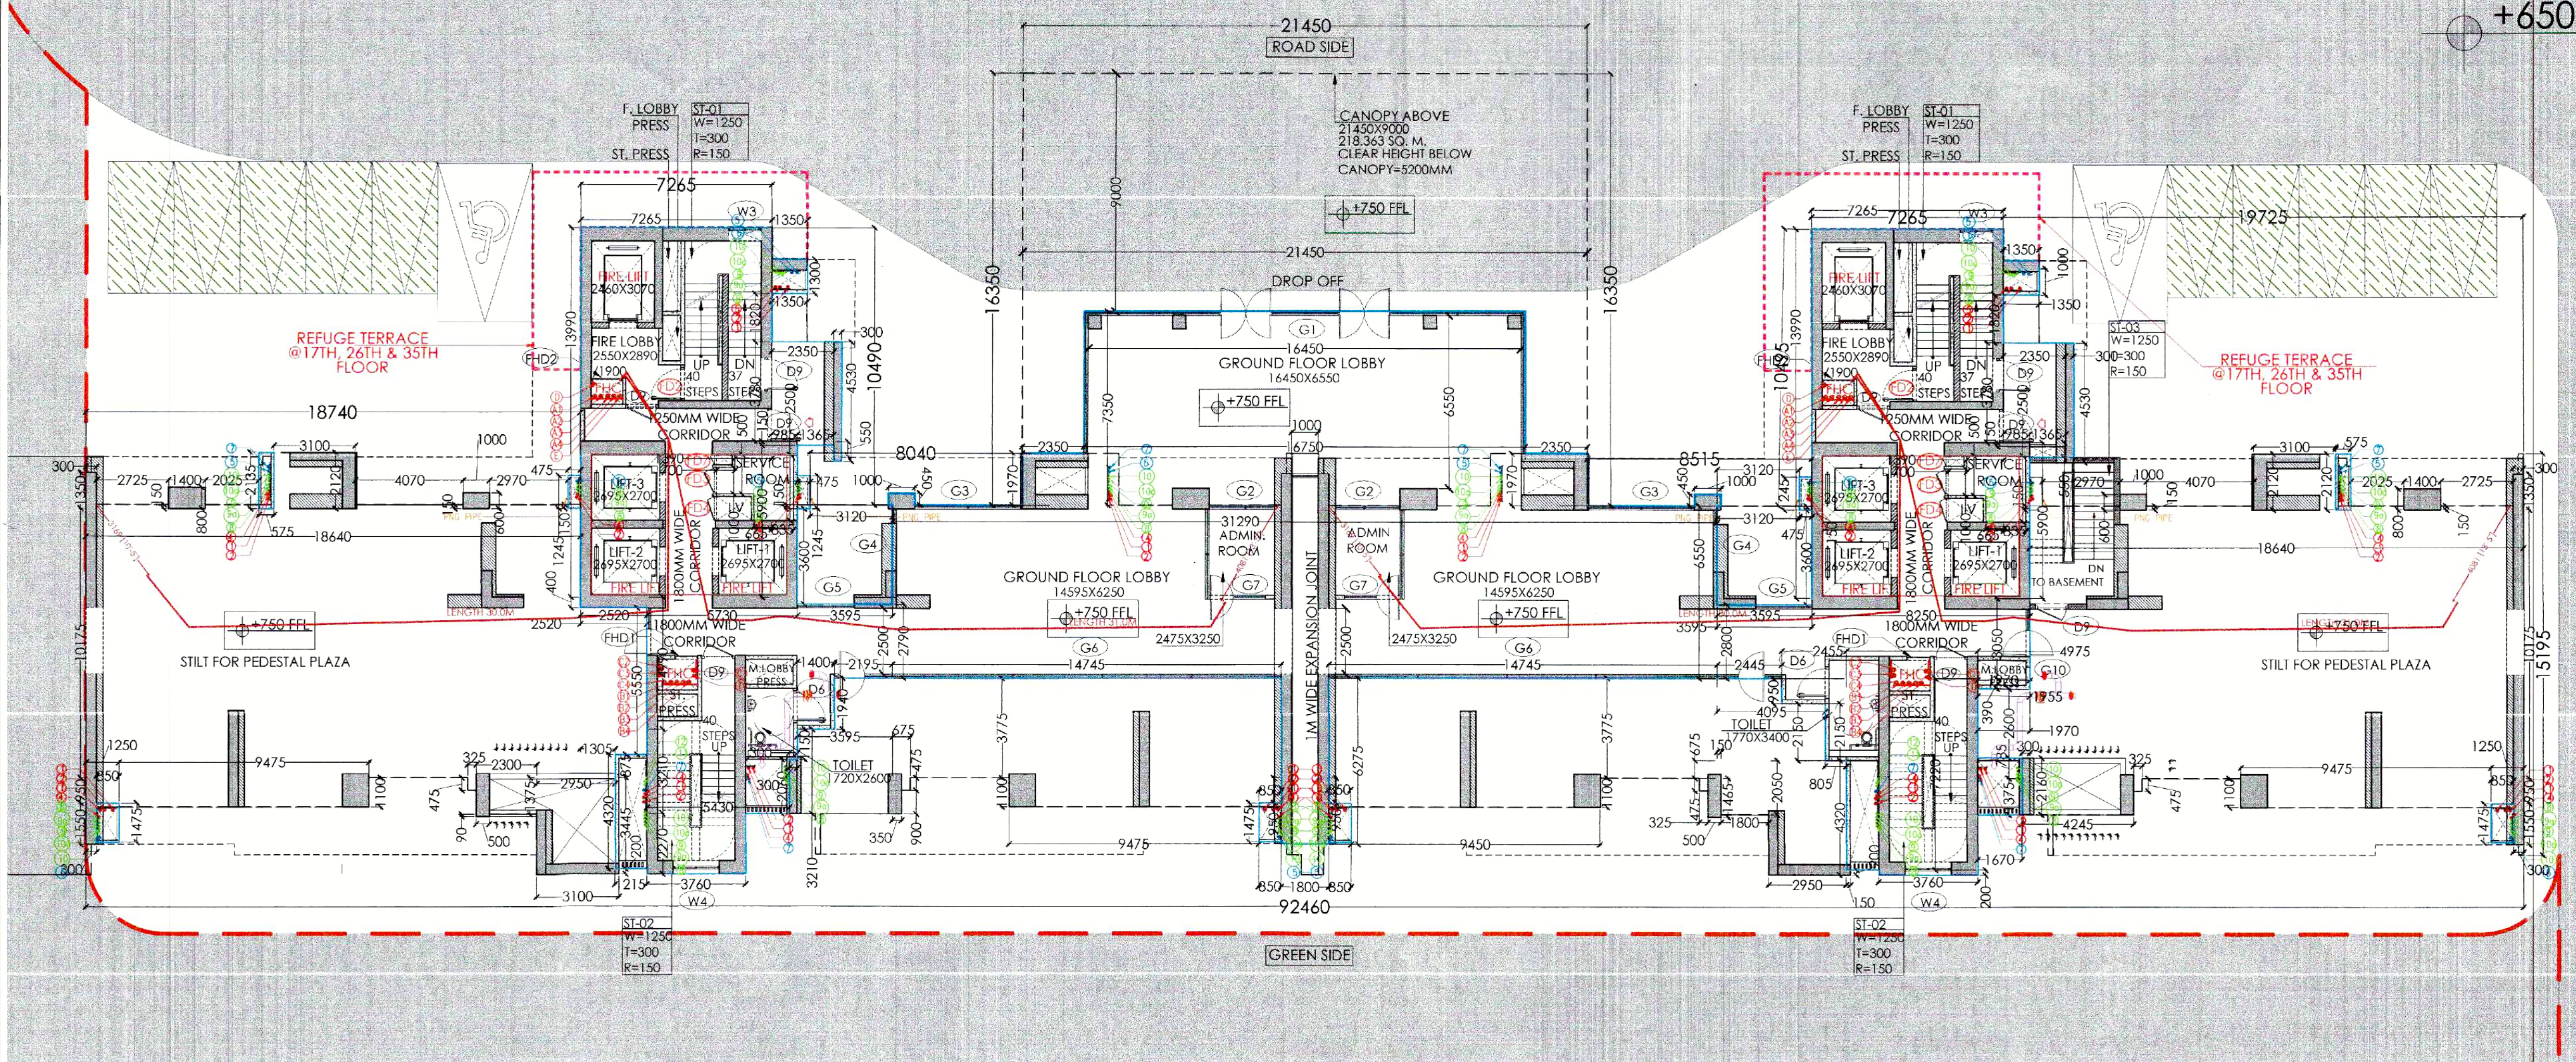

01) STILT/GROUND FLOOR PLAN (TOWER T5&T6)

SCALE - 1:150

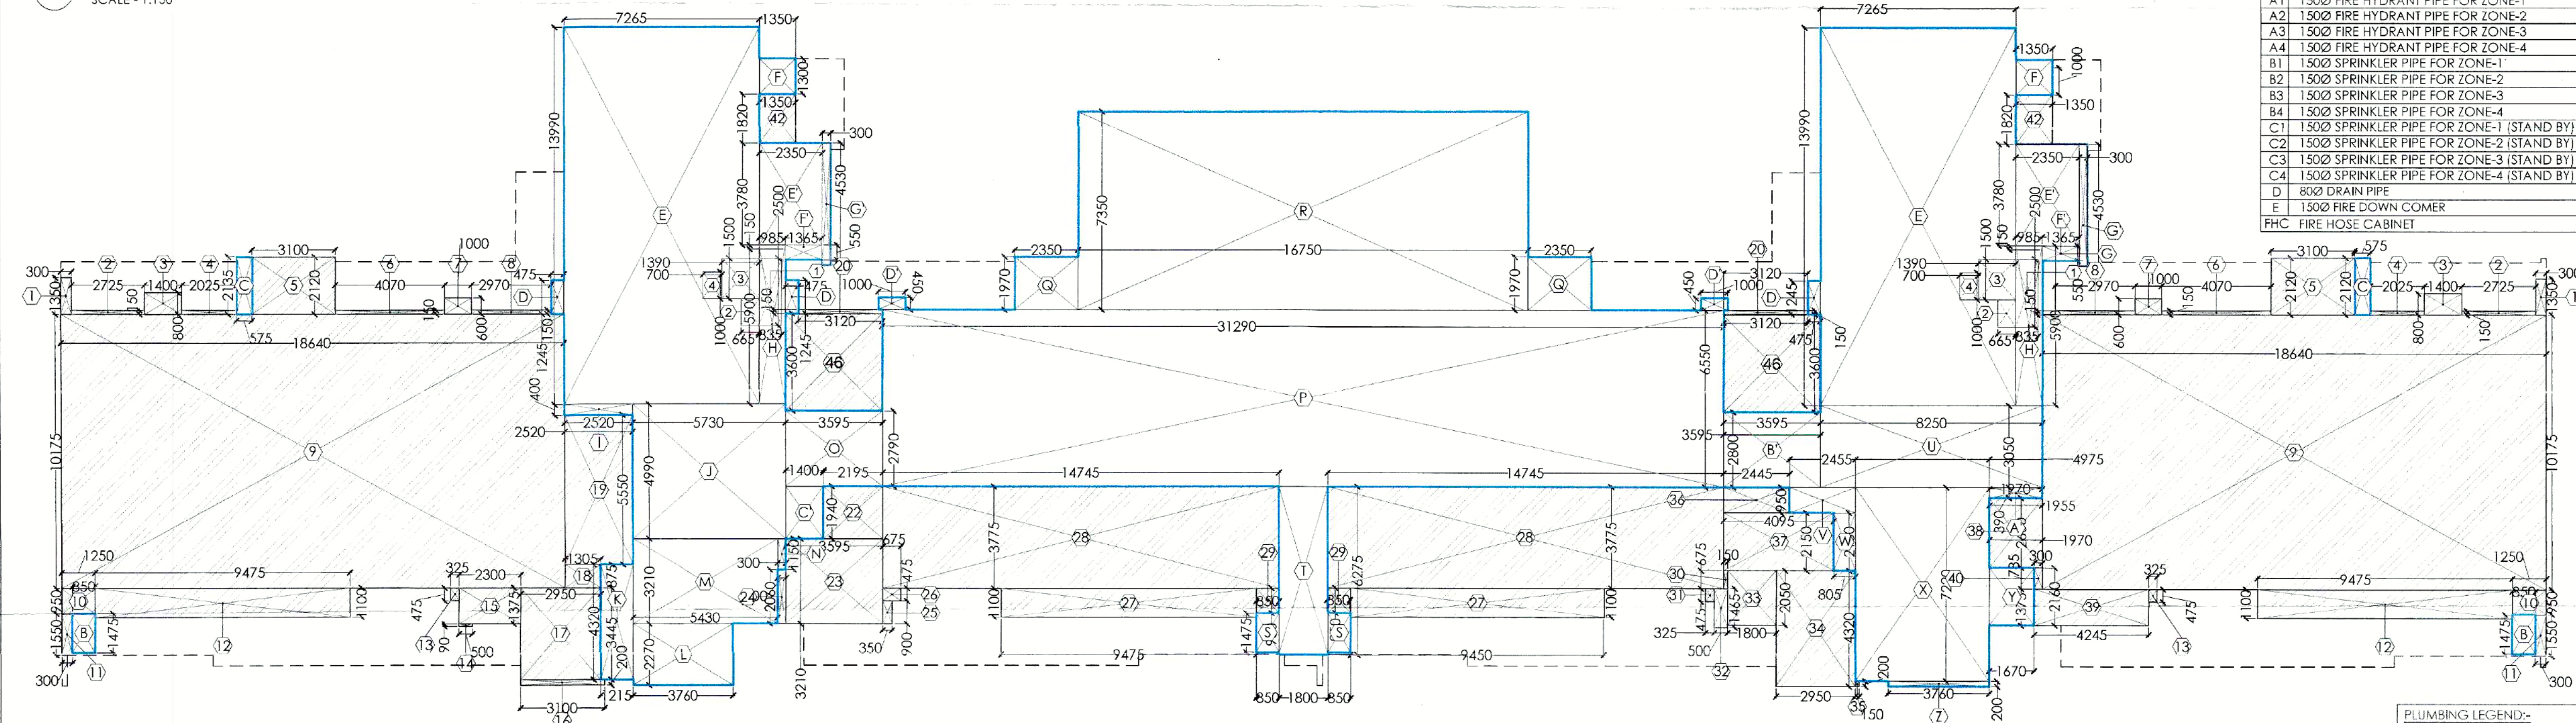

02) STILT/GROUND FLOOR F.A.R. AREA DIAGRAM (TOWER T5 & T6)

SCALE - 1:150

NOTES :-

- VRV System is being provided.
- Full DG power back up is being provided.
- Toilets are mechanical ventilated.
- All lifts shall have 100% power back-up.
- All electrical installations shall be as per provision of nbc.
- Fire-fighting/safety provisions will be as per relevant nbc provisions.
- Basement area shall have mechanically ventilated as per relevant code.
- All toilets are ventilated as per haryana building code 2017.
- Building has automatic sprinkler system wherever required by nbc.
- Building will be designed (structures) as per relevant i.s. codes for earthquake resistance.
- Solar panels of required capacity shall be provided on roof top as per hareda/zoning norms.
- All handicap ramps with railing.
- All fire fighting installations shall be as per provision of nbc.
- The rainwater harvesting system shall be provided as per central ground water Authority norms.

PLUMBING LEGEND:-	
1	1000/1100 SOIL PIPE
2	1000/1100 WASTE PIPE
3	1000/1100 WASHING MACHINE WASTE WATER PIPE
4	1000/1100 KITCHEN WASTE PIPE
5	750 VENT PIPE
6	1000/1100 RAIN WATER PIPE FOR BALCONY
7	1000/1100 RAIN WATER PIPE FOR REFUGE TERRACE
8	DOMESTIC WATER SUPPLY (BOOSTER) (FOR 3RD FLOOR)
9	DOMESTIC HIGH ZONE WATER SUPPLY (BY GRAVITY)
10	DOMESTIC WATER SUPPLY (BY GRAVITY) EXPRESS D/W
11	FLUSHING WATER SUPPLY (BY GRAVITY)
12	FLUSHING WATER SUPPLY (BY GRAVITY) EXPRESS D/W
13	DOMESTIC WATER SUPPLY (BY GRAVITY) FOR G.I. TANK
14	FLUSHING WATER SUPPLY (BY GRAVITY) FOR G.I. TANK
15	750 HVAC DRAIN PIPE

NOTES:-

- REFER DRAWING NO. AR-15T6-201, 202 & 203 FOR ELEVATIONS
- REFER DRAWING NO. AR-15T6-301 FOR SECTIONS
- T5 IS SIMILAR TO T6

TOWER-T5 & T6 FLOOR LEVELS		
FLOOR NO.	DU	LEVEL (MM)
STILT/GROUND FLOOR LEVEL	LOBBY	750
FIRST FLOOR LEVEL		6750
SECOND FLOOR LEVEL		10150
THIRD FLOOR LEVEL		13550
FOURTH FLOOR LEVEL		16950
FIFTH FLOOR LEVEL		20350
SIXTH FLOOR LEVEL		23750
SEVENTH FLOOR LEVEL		27150
EIGHTH FLOOR LEVEL		30550
NINTH FLOOR LEVEL		33950
TENTH FLOOR LEVEL		37350
ELEVENTH FLOOR LEVEL		40750
TWELFTH FLOOR LEVEL		44150
THIRTEENTH FLOOR LEVEL		47550
FOURTEENTH FLOOR LEVEL		50950
FIFTEENTH FLOOR LEVEL		54350
SIXTEENTH FLOOR LEVEL		57750
REFUGE-01 FLOOR LEVEL		61150


TOWER-T5 & T6 FLOOR LEVELS		
FLOOR NO.	DU	LEVEL (MM)
EIGHTEENTH FLOOR LEVEL		64550
NINETEENTH FLOOR LEVEL		67950
TWENTIETH FLOOR LEVEL		71350
TWENTY FIRST FLOOR LEVEL		74750
TWENTY SECOND FLOOR LEVEL		78150
TWENTY THIRD FLOOR LEVEL		81550
TWENTY FOURTH FLOOR LEVEL		84950
TWENTY FIFTH FLOOR LEVEL		88350
REFUGE-02 FLOOR LEVEL		91750
TWENTY SEVENTH FLOOR LEVEL		95150
TWENTY EIGHTH FLOOR LEVEL		98550
TWENTY NINTH FLOOR LEVEL		101950
THIRTIETH FLOOR LEVEL		105350
THIRTY FIRST FLOOR LEVEL		108750

TOWER-T5 & T6 FLOOR LEVELS		
FLOOR NO.	DU	LEVEL (MM)
THIRTY SECOND FLOOR LEVEL		112150
THIRTY THIRD FLOOR LEVEL		115550
THIRTY FOURTH FLOOR LEVEL		118950
REFUGE-03 FLOOR LEVEL		122350
THIRTY SIXTH FLOOR LEVEL		125750
THIRTY SEVENTH FLOOR LEVEL		129150
THIRTY EIGHTH FLOOR LEVEL		132550
TOTAL DWELLING UNITS OF T5	76	
THIRTY NINTH FLOOR LEVEL		135950
TOTAL DWELLING UNITS OF T6	78	
TOTAL DWELLING UNITS OF T5+T6	154	

PLUMBING LEGEND:-

- SWR DOMESTIC WATER SUPPLY
- PHS PLUMBING WATER SUPPLY
- MFT MULTI FLOOR TRAP
- FT FLOOR TRAP
- UTR UTRAP
- FD FLOOR DRAIN
- FO FLOOR CLEAN OUT PLUG
- FC FLOOR CLEAN OUT PLUG
- BC BALCONY DRAIN
- DP DRAIN POINT

This is a "PROVISION" BUILDING PLAN approved only for the purpose of inviting objections from the project public.

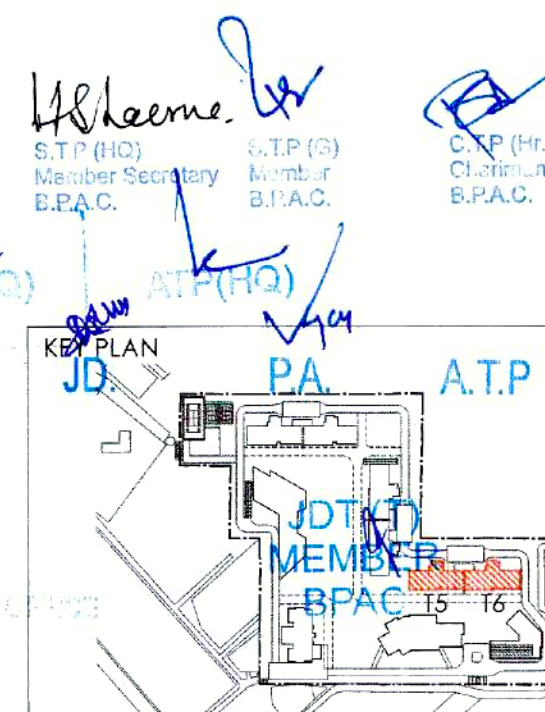

NOTES

DOOR / WINDOW SCHEDULE (TOWERS)	
S. NO.	DOOR / WINDOW
1	D2 1050 2400 0 M. Bedroom
2	D3 900 2400 0 Kitchen
3	D4 800 2400 0 Toilet
4	D5 1250 2400 0 Staircase

S		D9	1250	2400	0	staircase
EXTERNAL DOORS						
6	S11	2400	2600	0	M, Bedroom	
7	S12	2025	2600	0	Bedroom	
8	S13	1800	2600	0	Bedroom	
9	S14	2750	2600	0	Bedroom	
10	S15	3770	2600	0	Living/Dining	
11	S16	3370	2600	0	Living/Dining	
12	S17	4700	2600	0	M, Bedroom	
13	S18	3475	2600	0	M, Bedroom	
14	S19	3200	2600	0	M, Bedroom	
15	D5	1000	2400	0	WC	
16	D7	800	2400	0	WC	
17	D8	900	2400	0	Utility	