




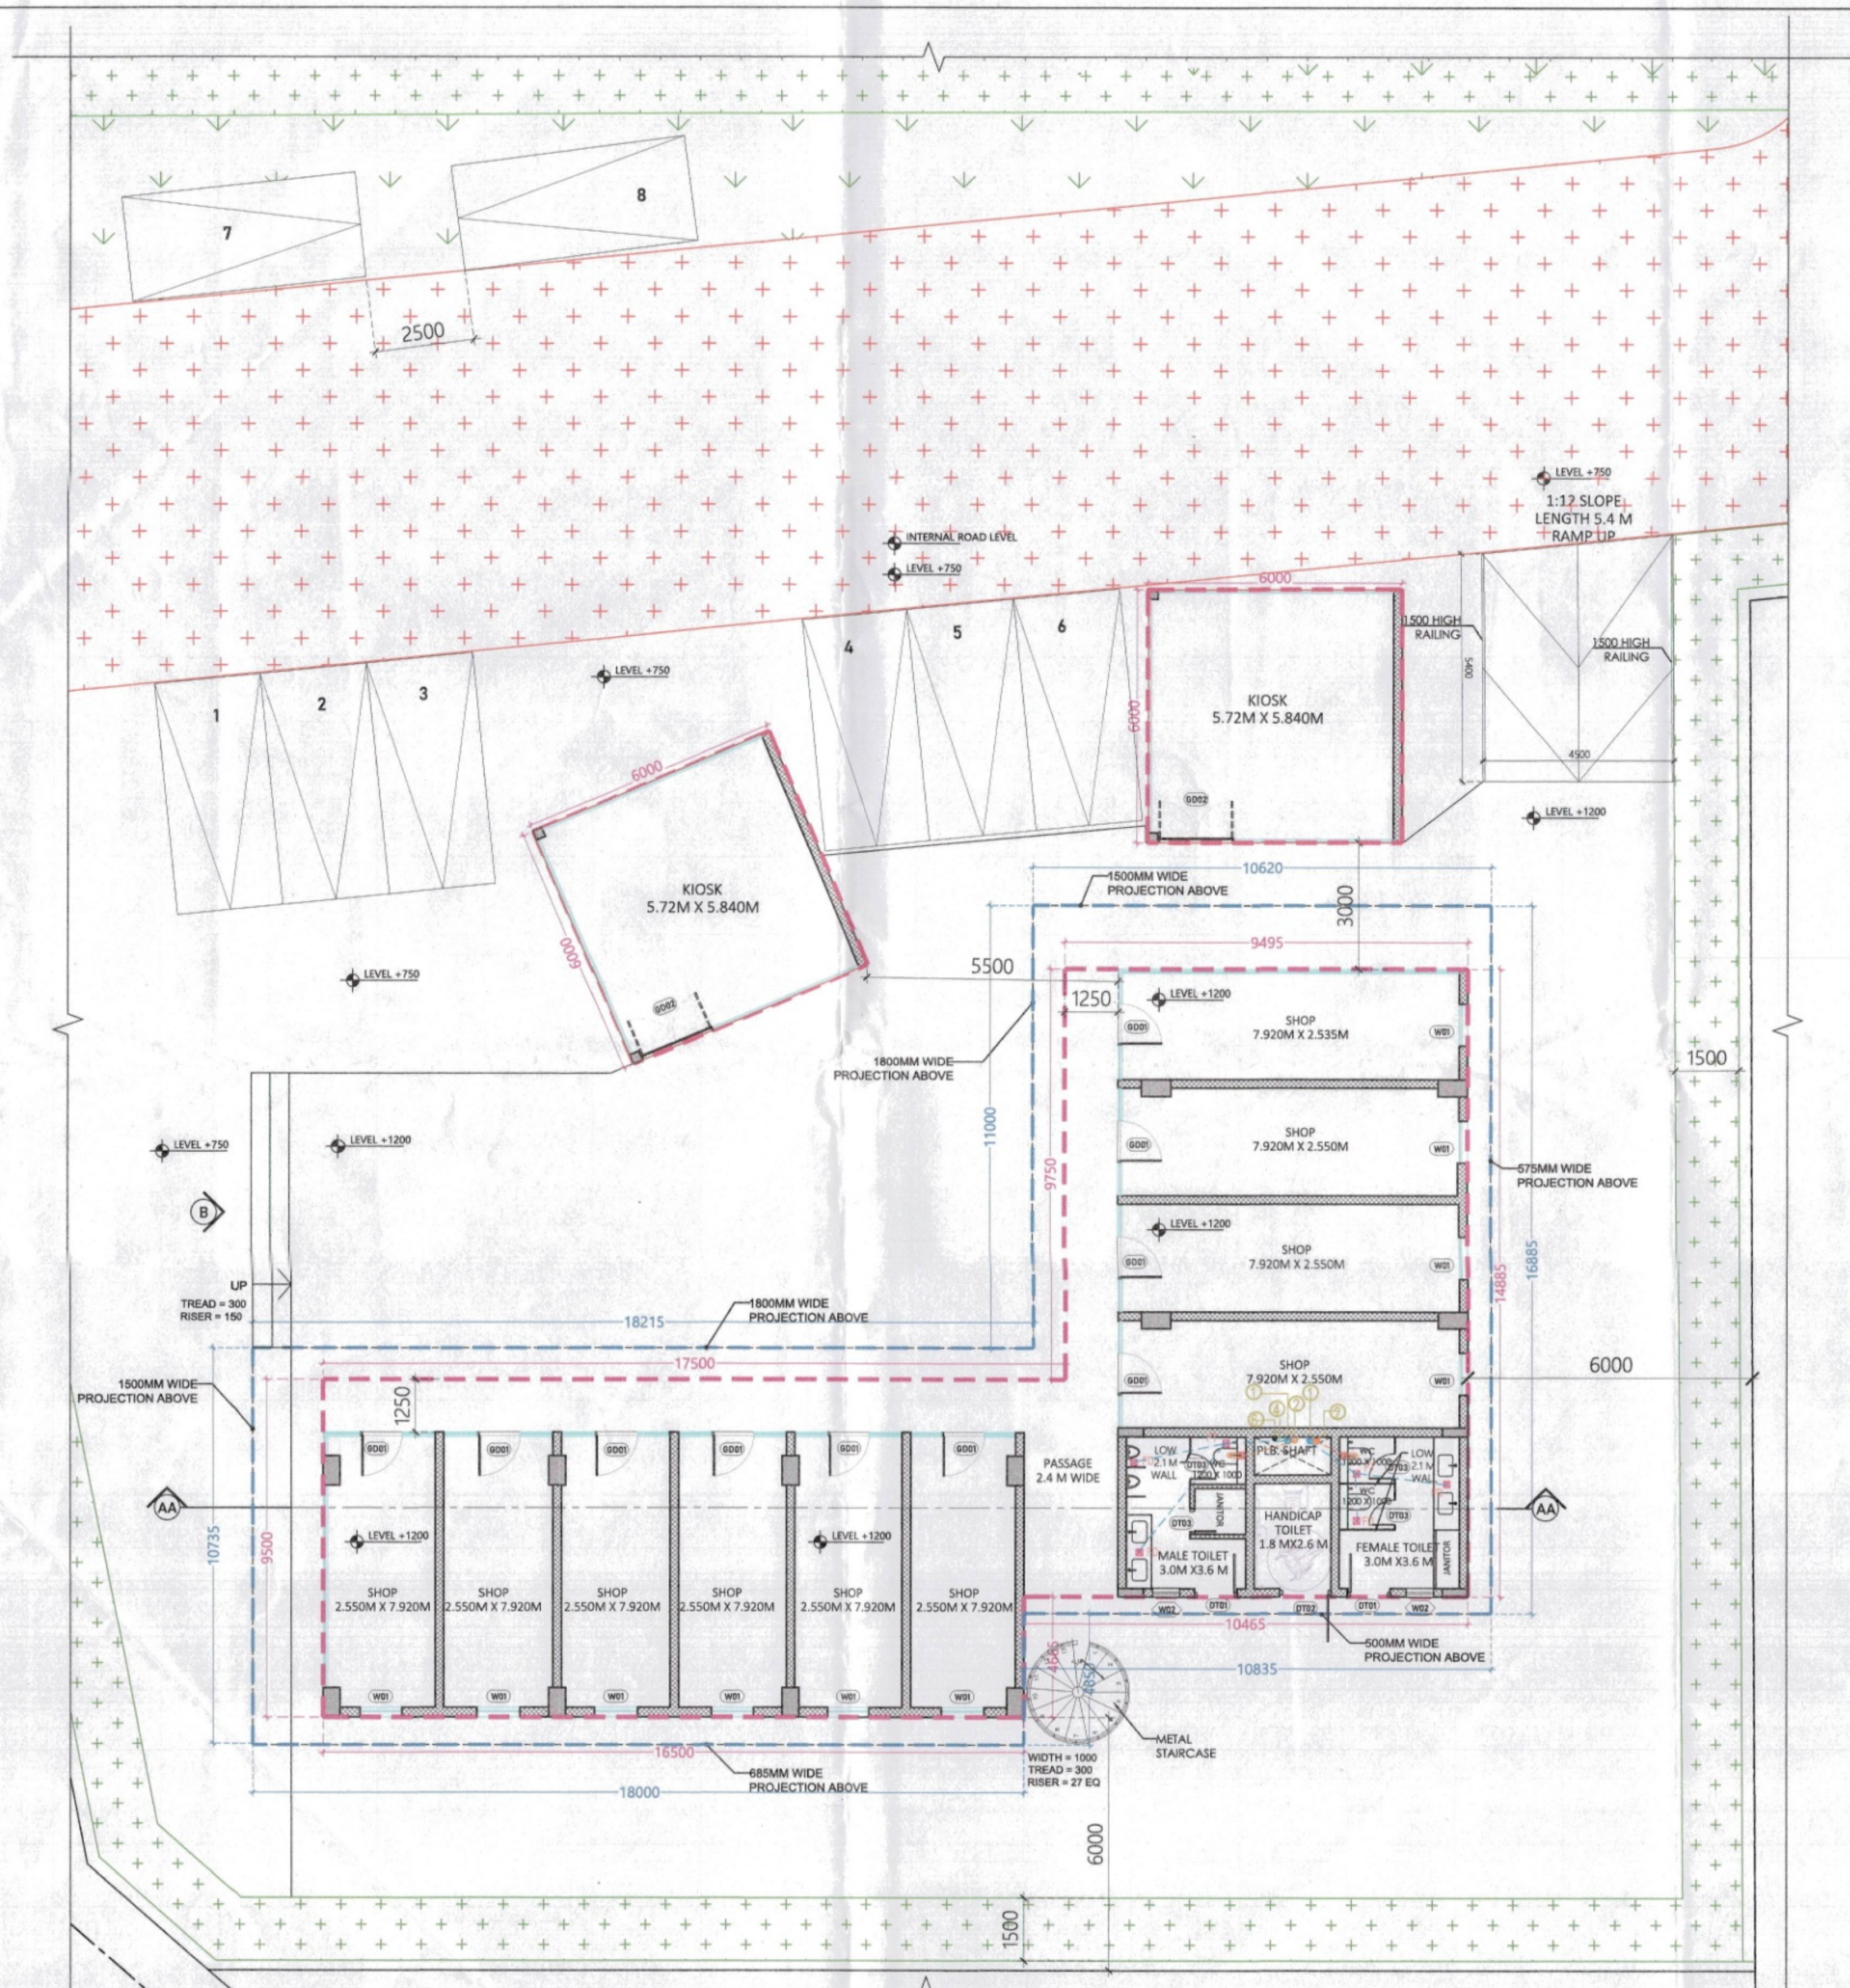


GROUND FLOOR PLAN

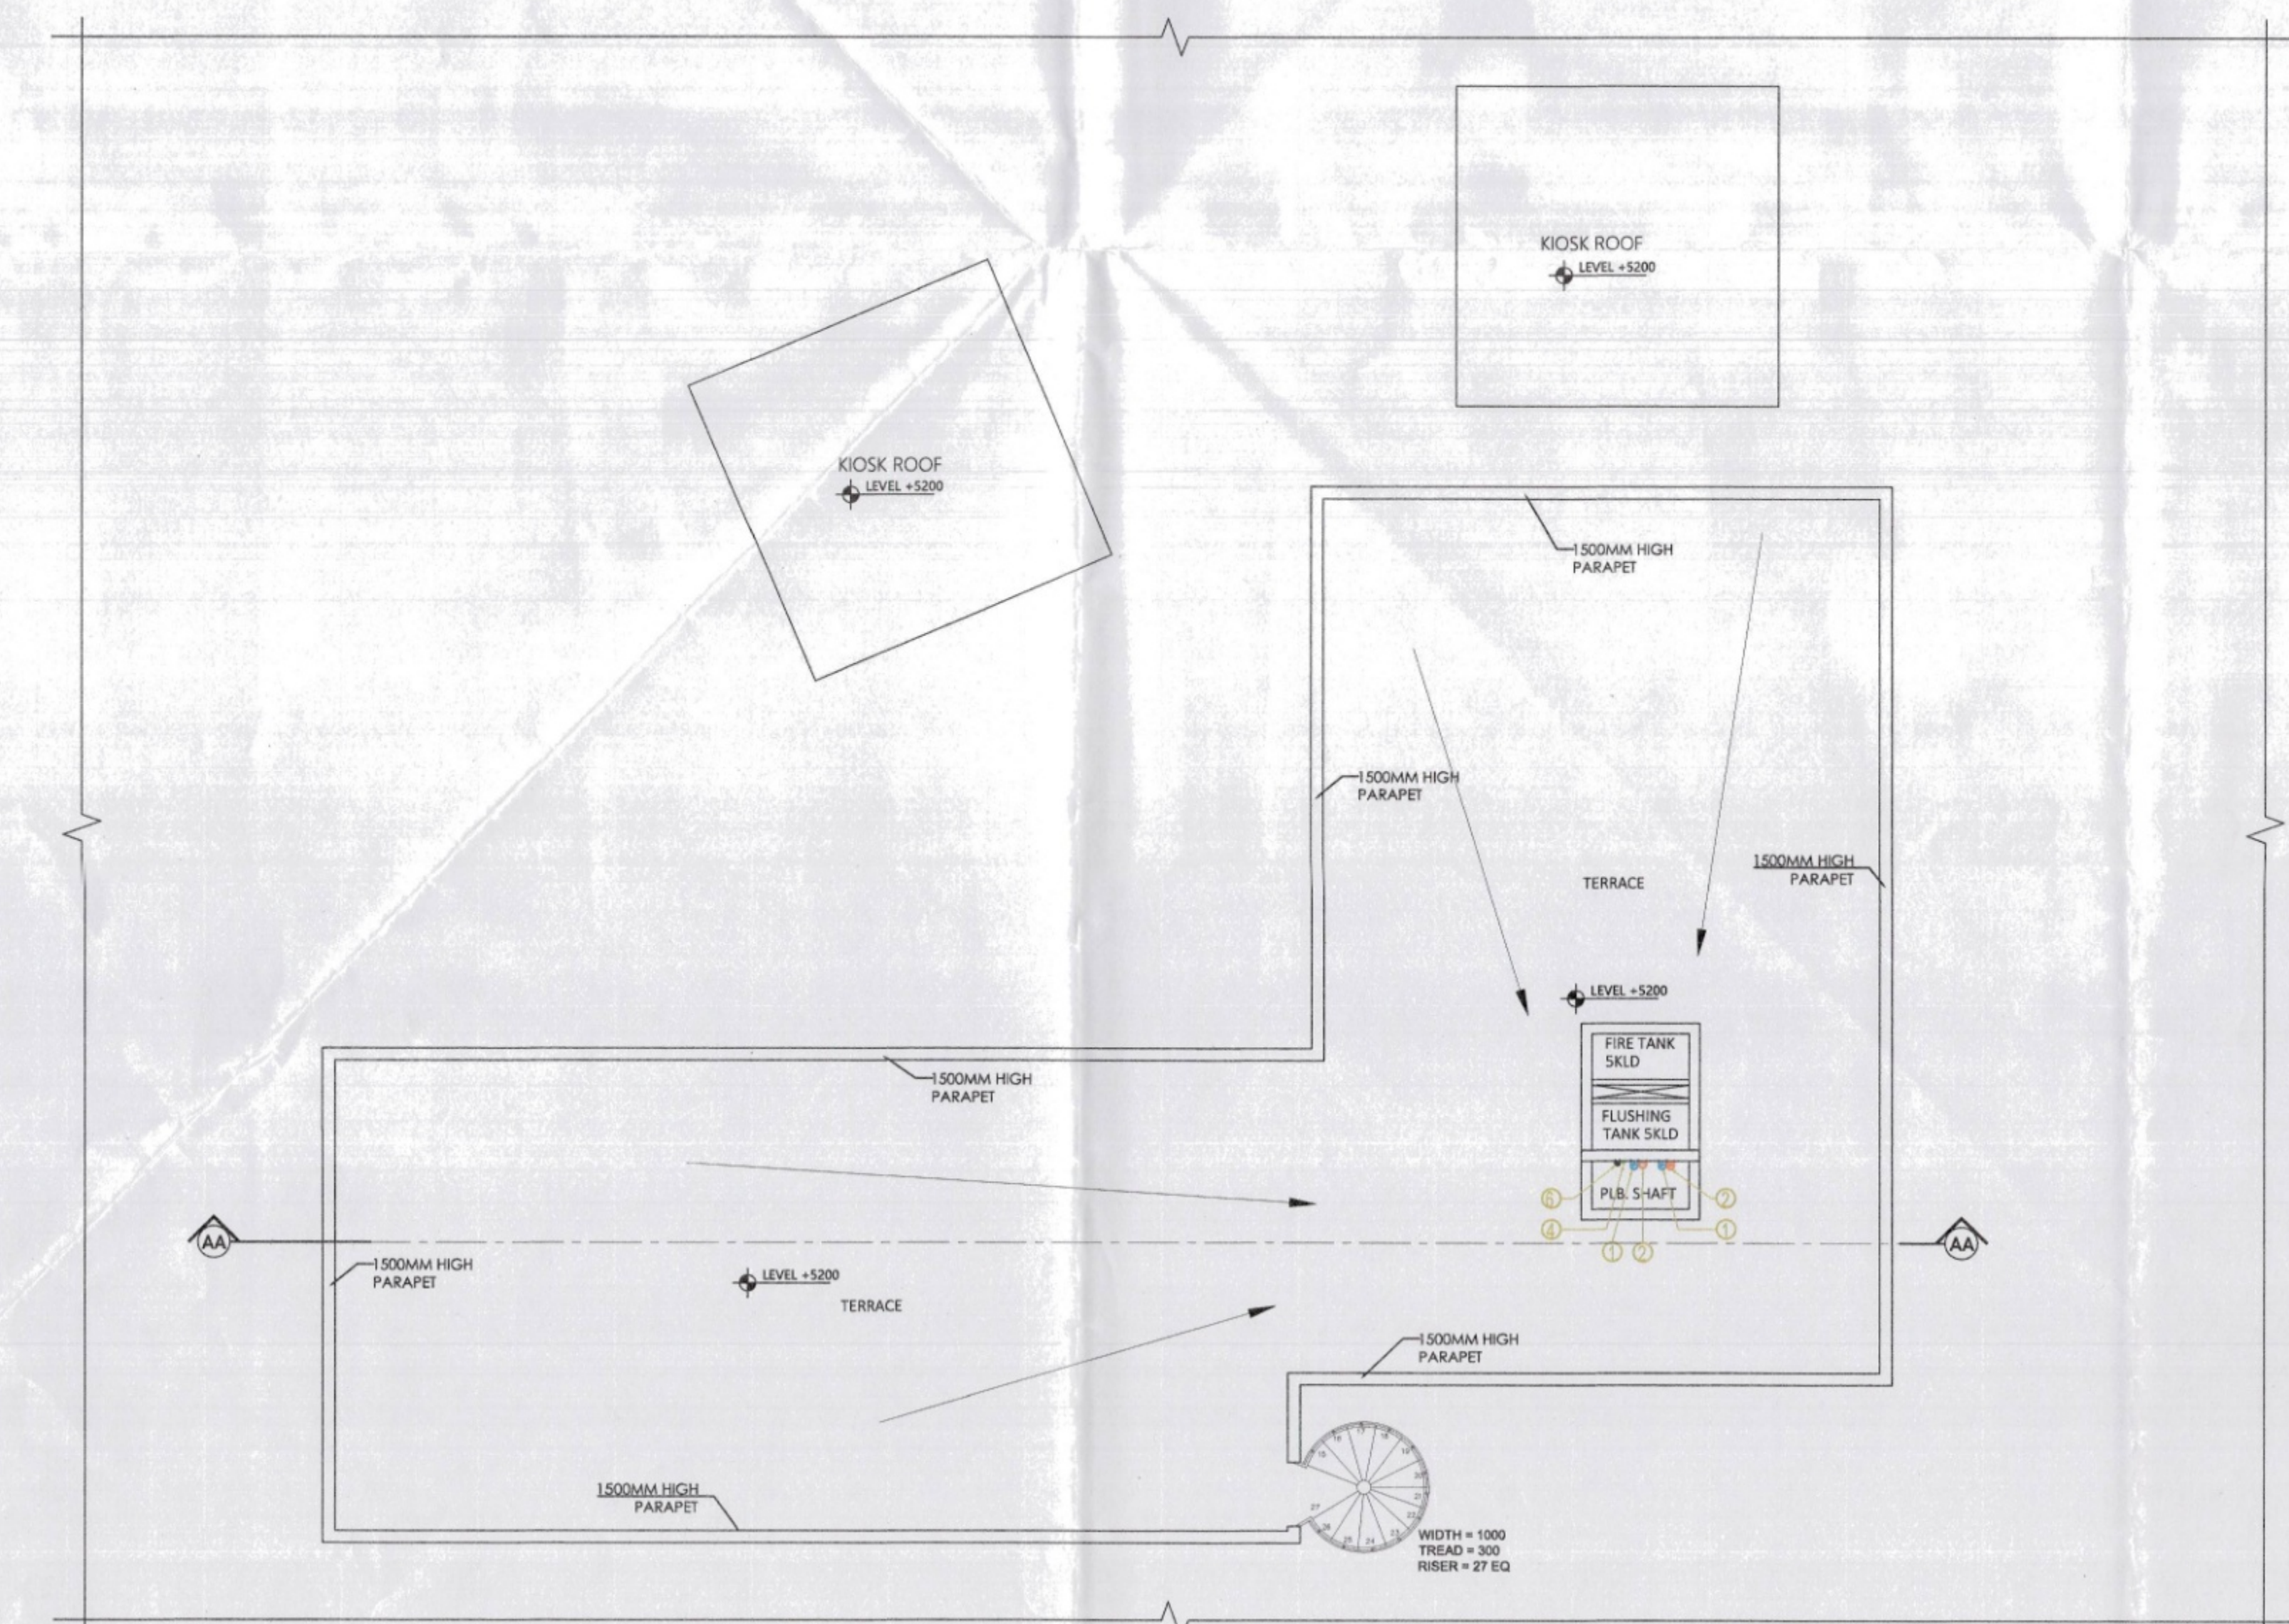


TERRACE PLAN

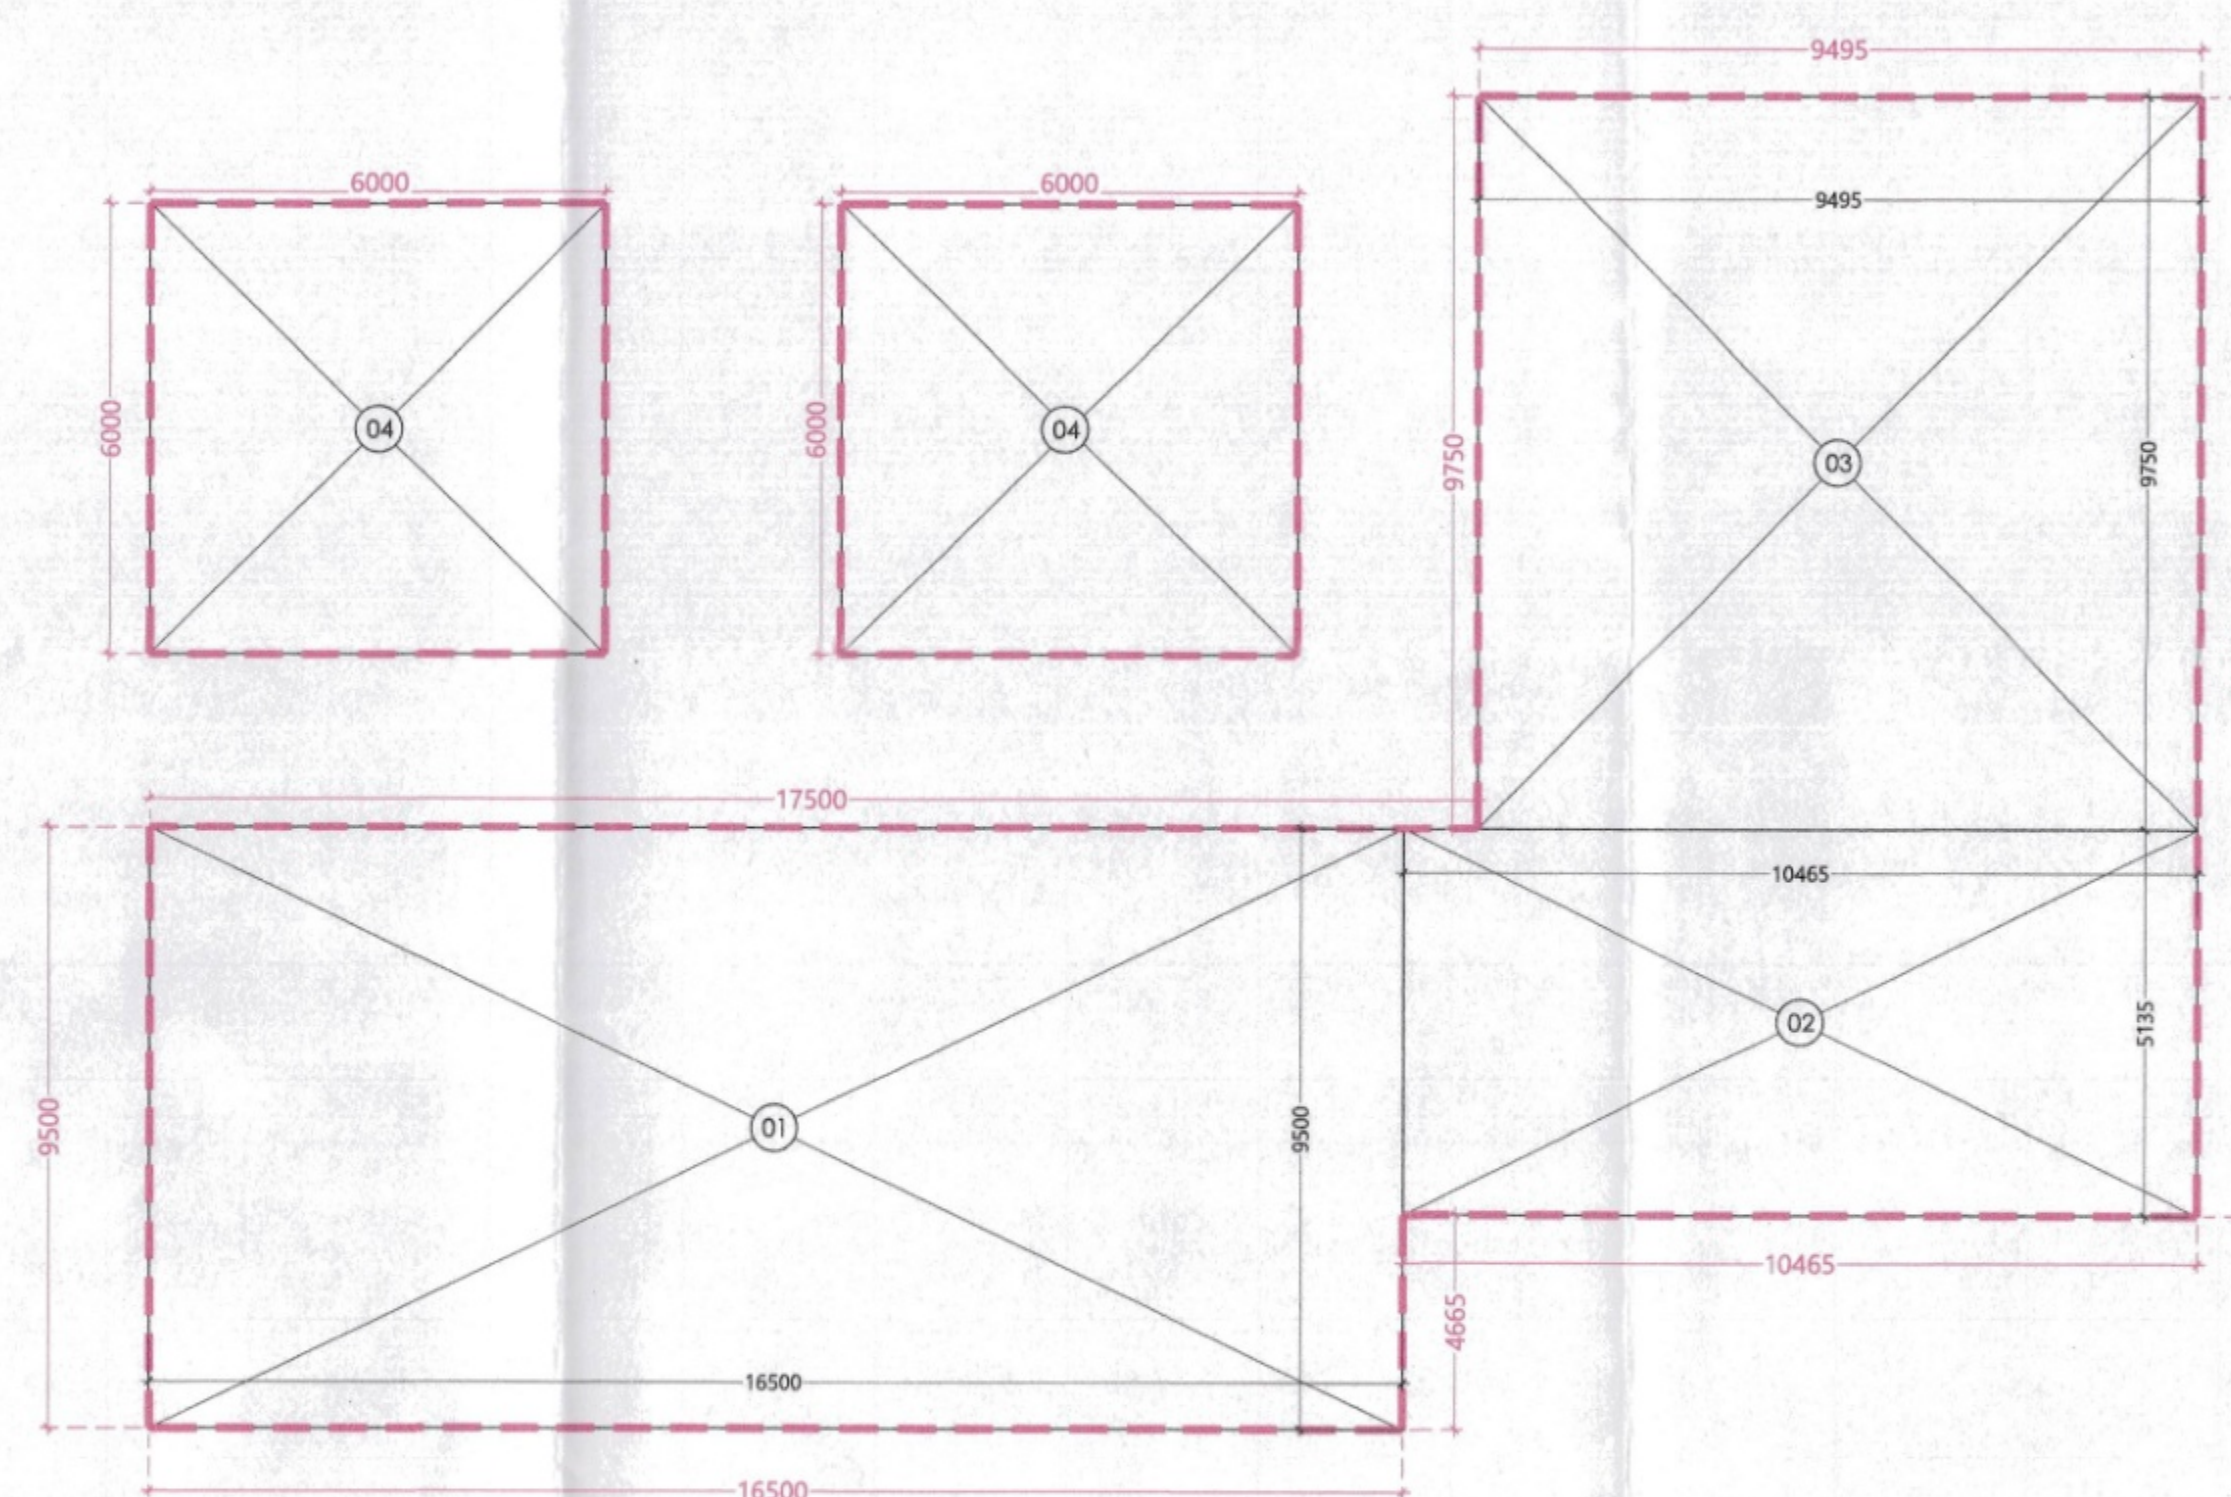


GROUND FLOOR FAR CALCULATION PLAN

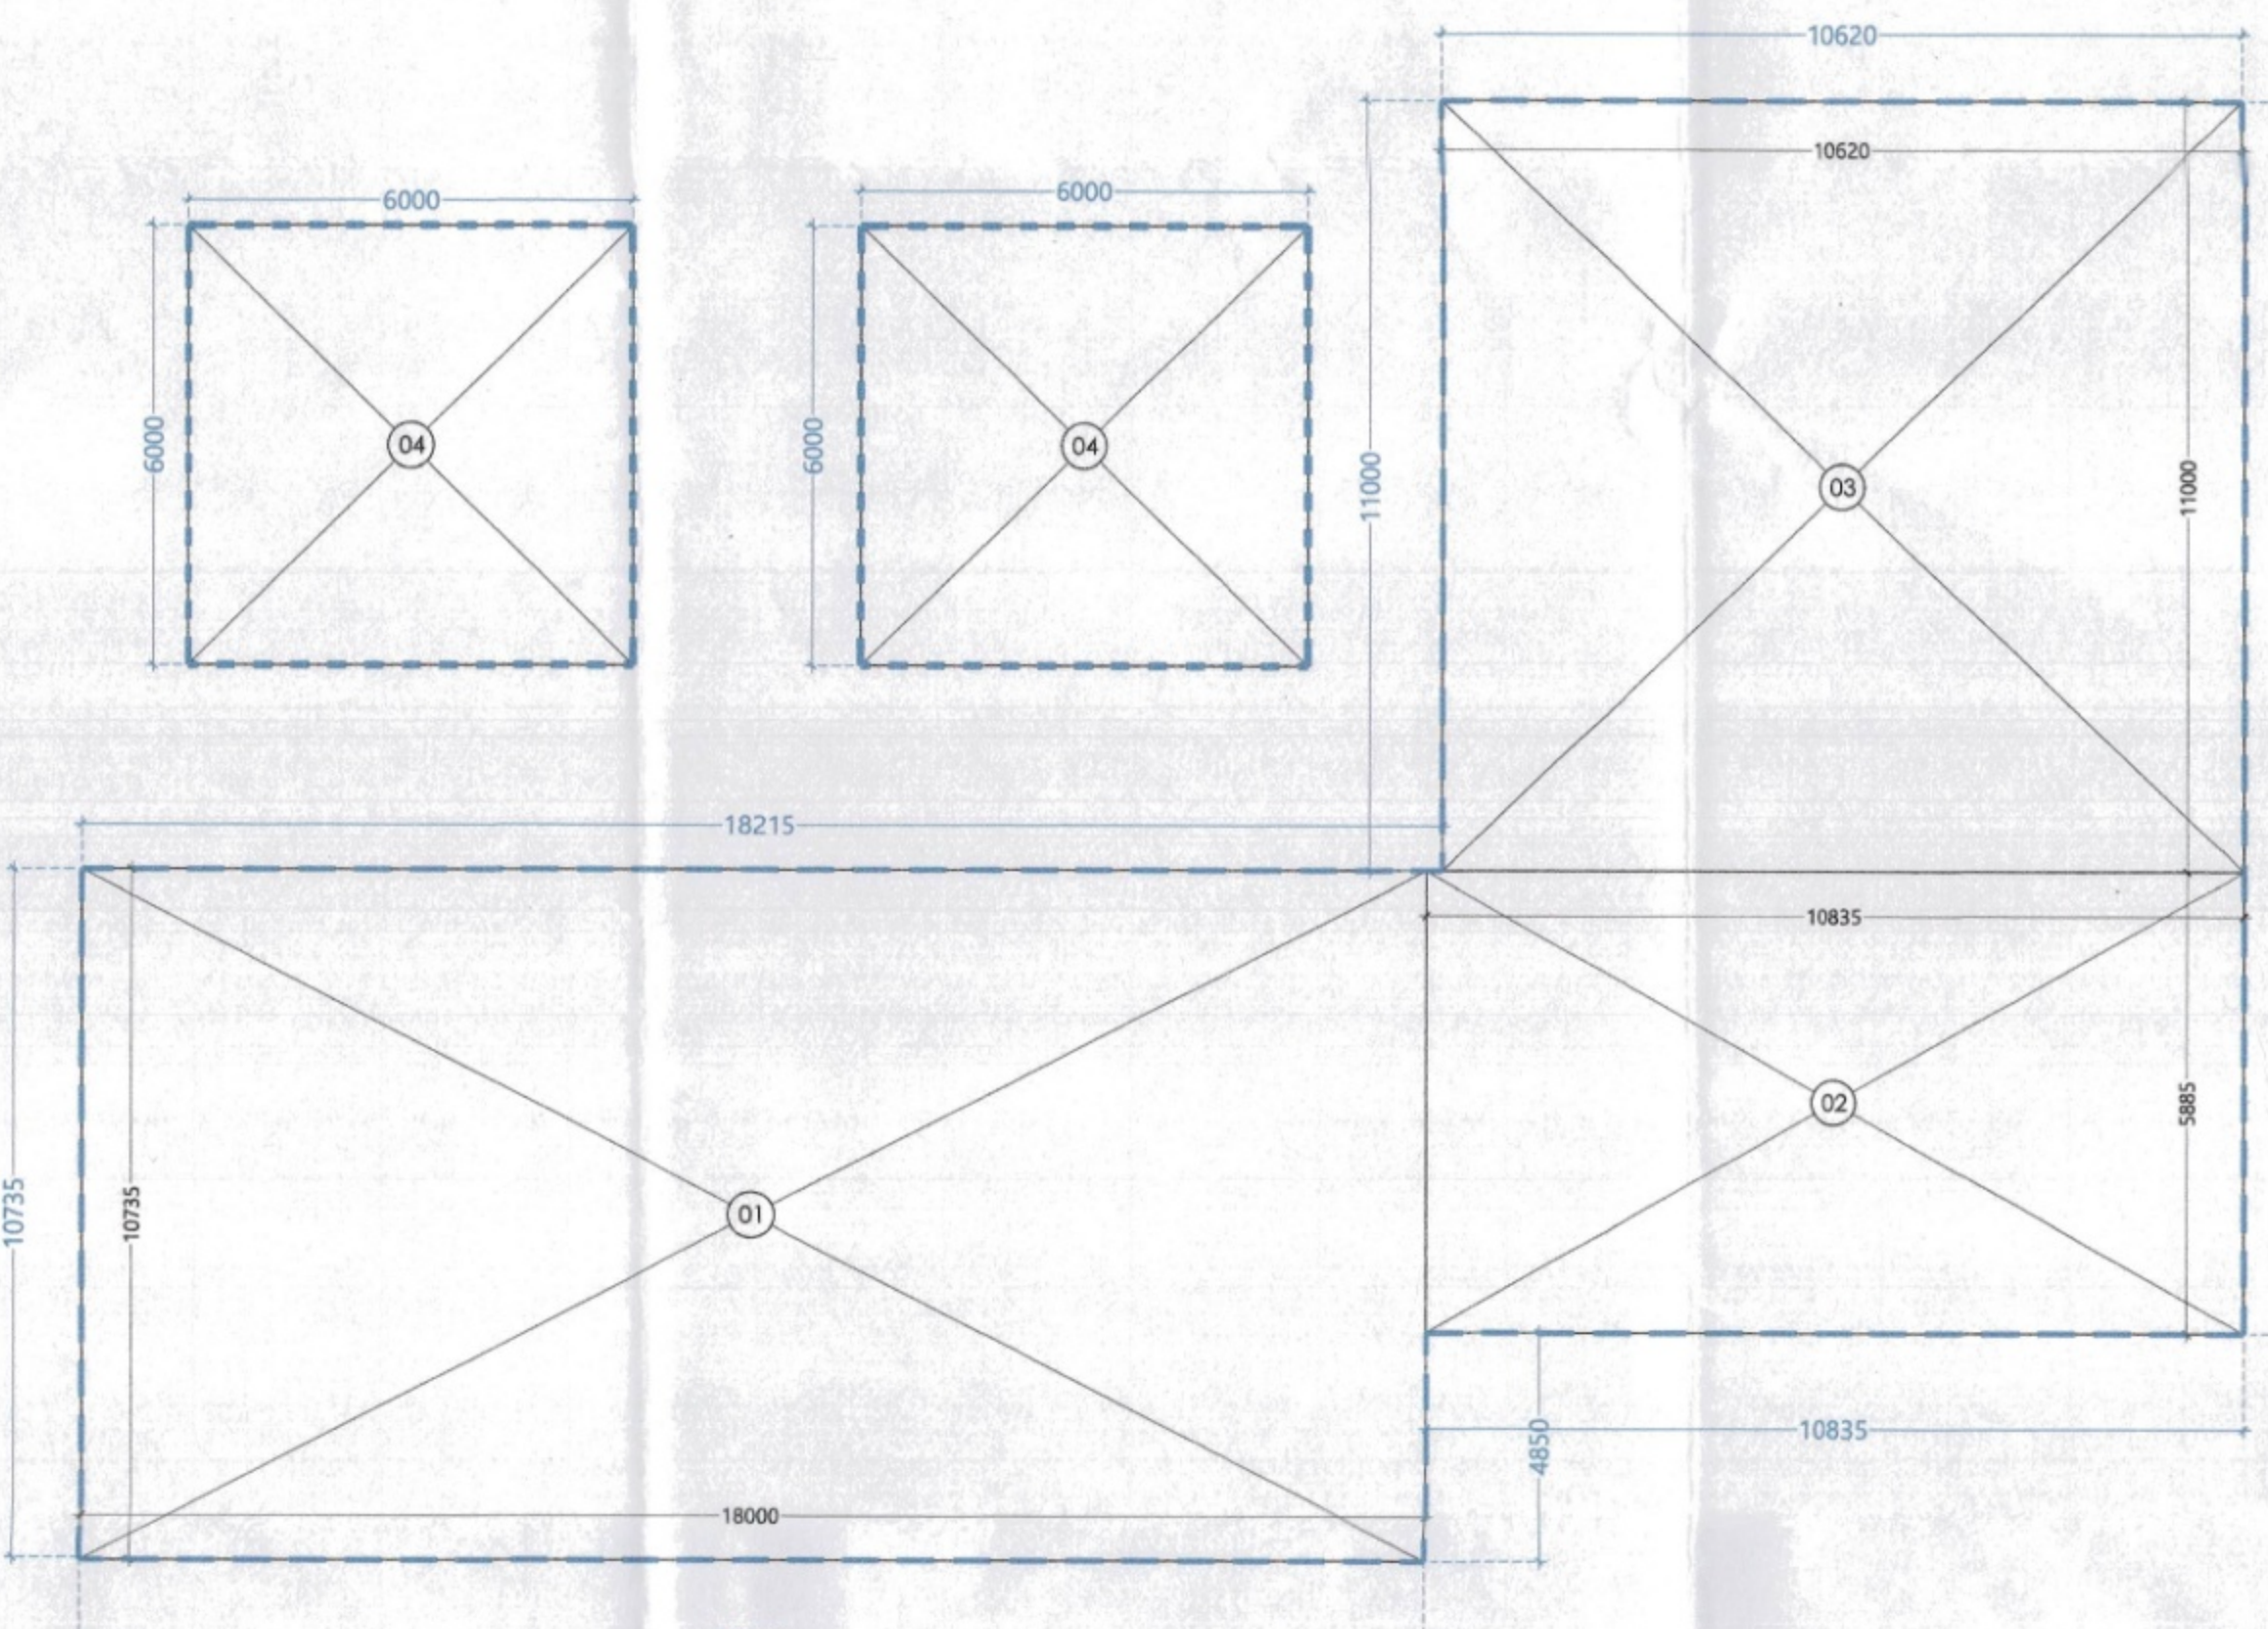

GROUND COVERAGE AREA CALCULATION PLAN

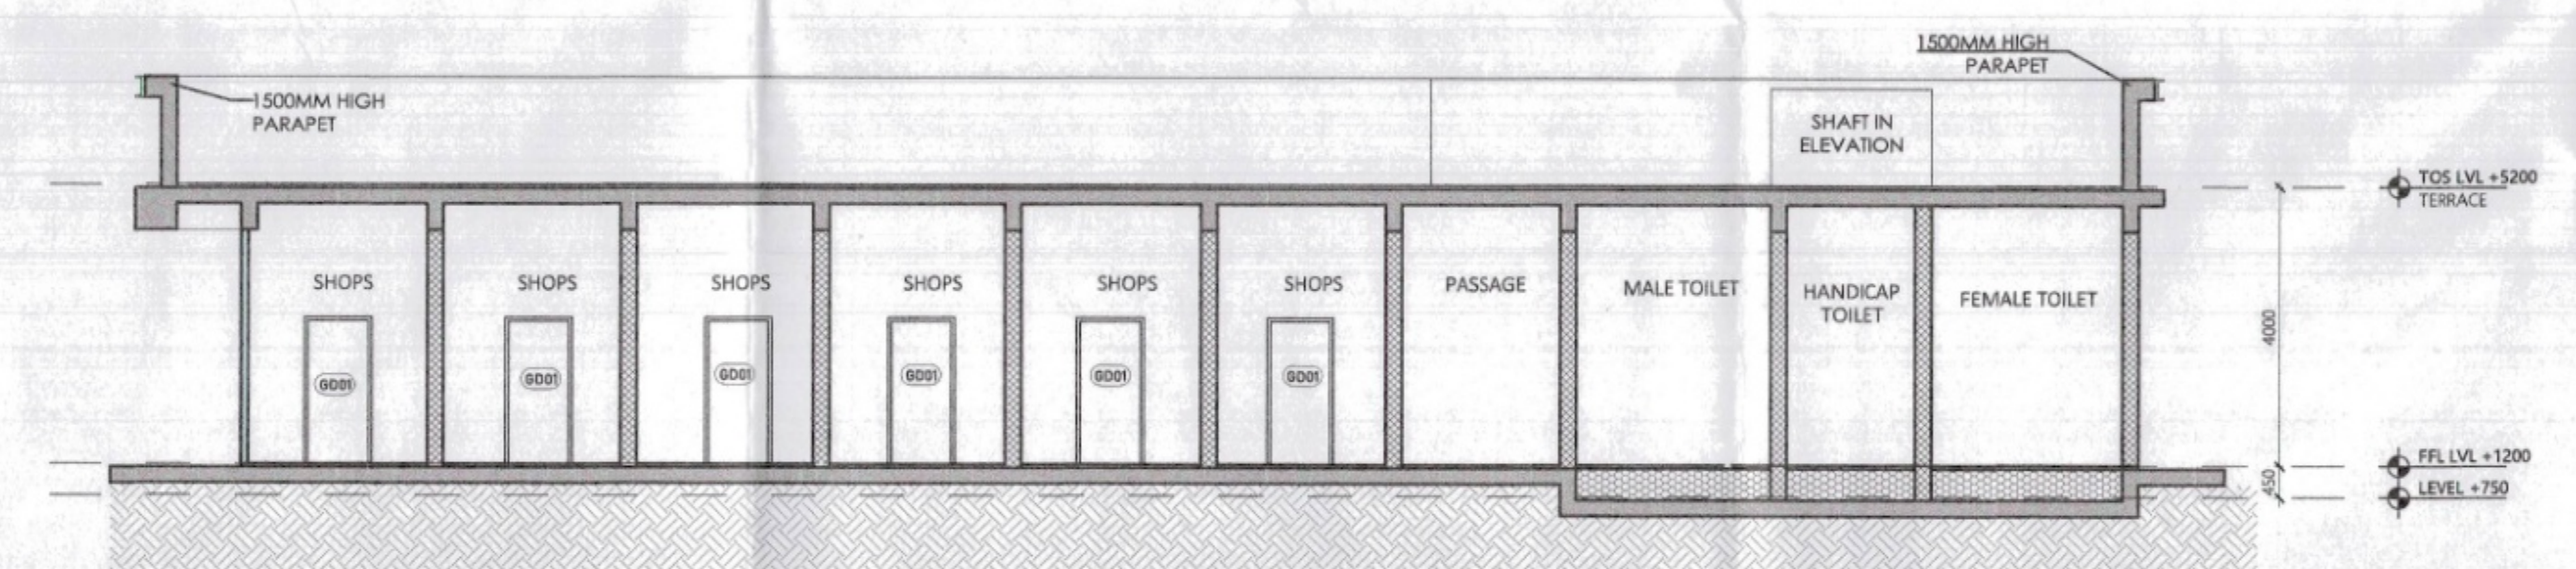

SECTION - AA'

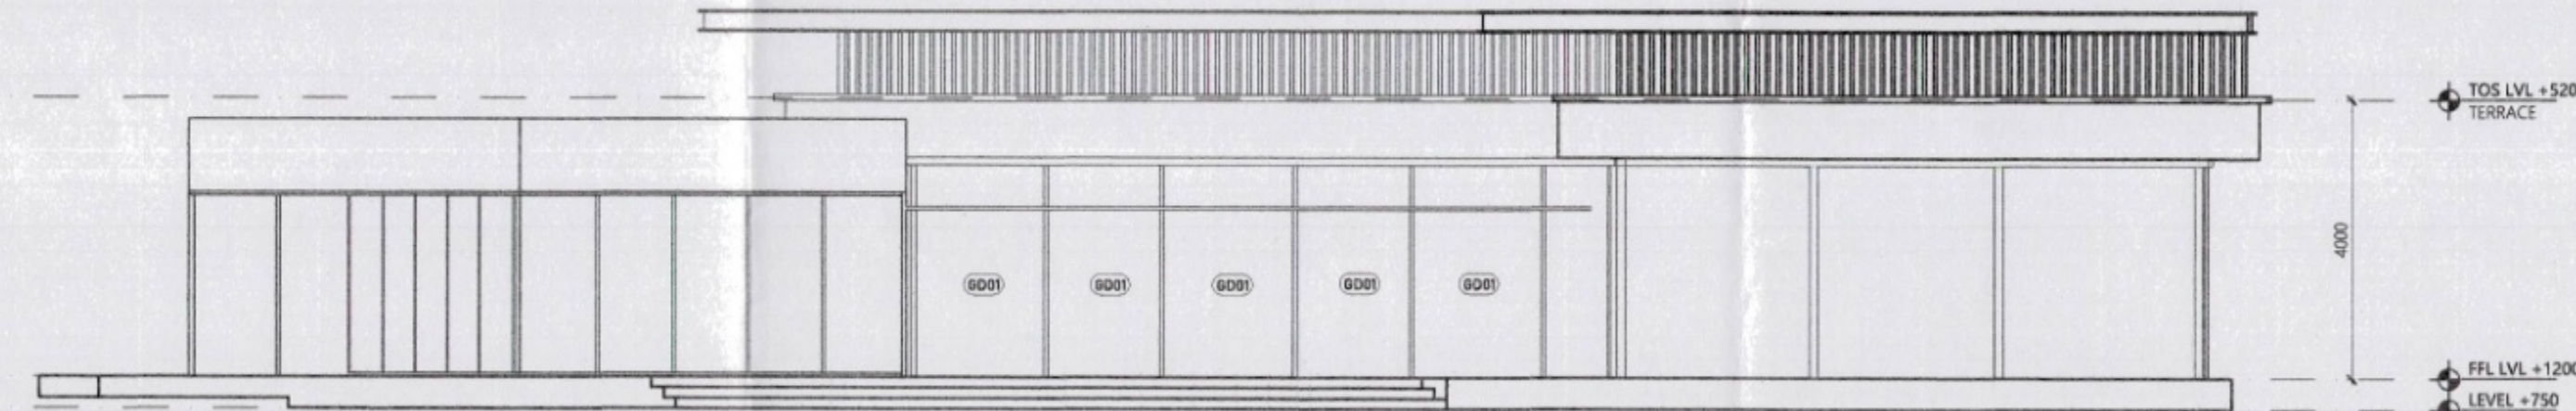

ELEVATION - B

GROUND FLOOR FAR AREA CALCULATION				
S.No.	Length	Breadth	Number	Area (sqm)
1	16500	9500	1.000	156.750
2	10445	5135	1.000	53.738
3	9495	9750	1.000	92.576
4	6000	6000	2.000	72.000
TOTAL FAR				375.064

GROUND COVERAGE AREA CALCULATION				
S.No.	Length	Breadth	Number	Area (sqm)
1	18000	10735	1.000	193.230
2	10835	5885	1.000	63.764
3	10620	11000	1.000	116.820
4	6000	6000	2.000	72.000
TOTAL GROUND COVERAGE				445.814

As a "PROVISIONAL BUILDING PLAN" approved only for the purpose of inviting objections from the general public.

S.T.P. (H) Member Secretary B.P.A.C.
 S.T.P. (S) Member Secretary B.P.A.C.
 C.T.P. (H) Chairman B.P.A.C.
 C.T.P. (S) Chairman B.P.A.C.

P.S.D. (H) Member B.P.A.C.
 P.S.D. (S) Member B.P.A.C.

AD
 RAJESH DUTT
 S.D.(H)

TO BE READ WITH THIS OFFICE MEMO NO. _____ DATED: _____


This drawing is a "COPYRIGHT" contents of this drawing or part thereof may not be used or reproduced without the permission of the Architect.

OWNER SIGN ARCHITECT SIGN



D/WID	FINISHED FRAME				LOCATION
	WIDTH	CILL	LINE	HEIGHT	
	mm	mm	mm	mm	
GD01	1200	0	3600	3600	SHOPS
GD02	5540	0	3600	3600	KIOSK
DT01	1000	0	2400	2400	TOILET
DT02	1200	0	2400	2400	TOILET
DT03	600	0	2400	2400	TOILET
W01	1000	900	2400	1500	SHOPS
W02	600	2100	2400	300	TOILET

PLUMBING LEGEND	
1	110 OD SANI PVC SOIL & VENT PIPE
2	110 OD SANI PVC WASTE & VENT PIPE
3	90 OD UPVC SANI SUPPLYING PIPE
4	90 OD UPVC SANI SUPPLYING PIPE
5	90 OD UPVC SANI SUPPLYING PIPE
6	90 OD UPVC SANI SUPPLYING PIPE
7	90 OD UPVC SANI SUPPLYING PIPE
8	90 OD UPVC SANI SUPPLYING PIPE
9	90 OD UPVC SANI SUPPLYING PIPE
10	90 OD UPVC SANI SUPPLYING PIPE
11	90 OD UPVC SANI SUPPLYING PIPE
12	90 OD UPVC SANI SUPPLYING PIPE
13	90 OD UPVC SANI SUPPLYING PIPE
14	90 OD UPVC SANI SUPPLYING PIPE
15	90 OD UPVC SANI SUPPLYING PIPE
16	90 OD UPVC SANI SUPPLYING PIPE
17	90 OD UPVC SANI SUPPLYING PIPE
18	90 OD UPVC SANI SUPPLYING PIPE
19	90 OD UPVC SANI SUPPLYING PIPE
20	90 OD UPVC SANI SUPPLYING PIPE

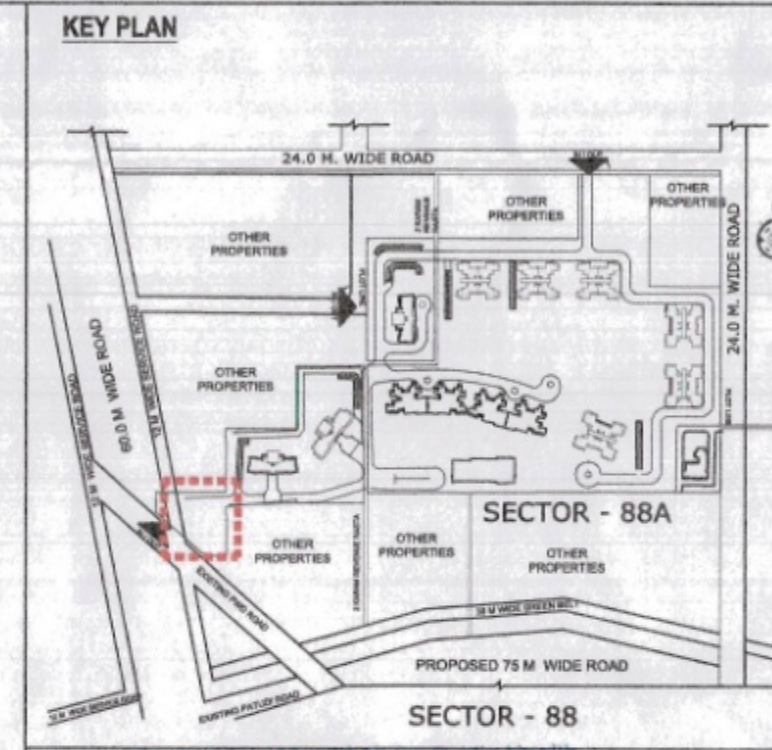

KEY PLAN

SUBMISSION DRAWING

OWNER
M/S ASHIANA LANDSCAPE REALTY Pvt. Ltd.

PROJECT
REVISED BUILDING PLAN FOR GROUP HOUSING COLONY OVER AN AREA MEASURING 24.125 ACRES (LICENCE NO.42 OF 2013 DATED 06.06.2013 & LICENCE NO.46 OF 2013 DATED 08.06.2013) IN THE REVENUE ESTATE OF VILLAGE HARSARU, SECTOR - 88A, GURUGRAM

SCALE
1:100

DATE
12.09.2025

DRAWING TITLE
FLOOR PLANS, SECTION & ELEVATIONS

CONVENIENT SHOPPING

ARCHITECTS
Confluence
CONFLUENCE CONSULTANCY SERVICES
P-1, First Floor, Main Corporate Building, Sector 18, Gurgaon, Haryana
www.confluenceindia.com | 01244660000 | 01244660001
Member of IBCI (1951 - 1951) 2008

architecture urban design hospitality interiors
DRAWING NO. S-CS-101