




ELEVATION A
SCALE 1:200


ELEVATION B
SCALE 1:200

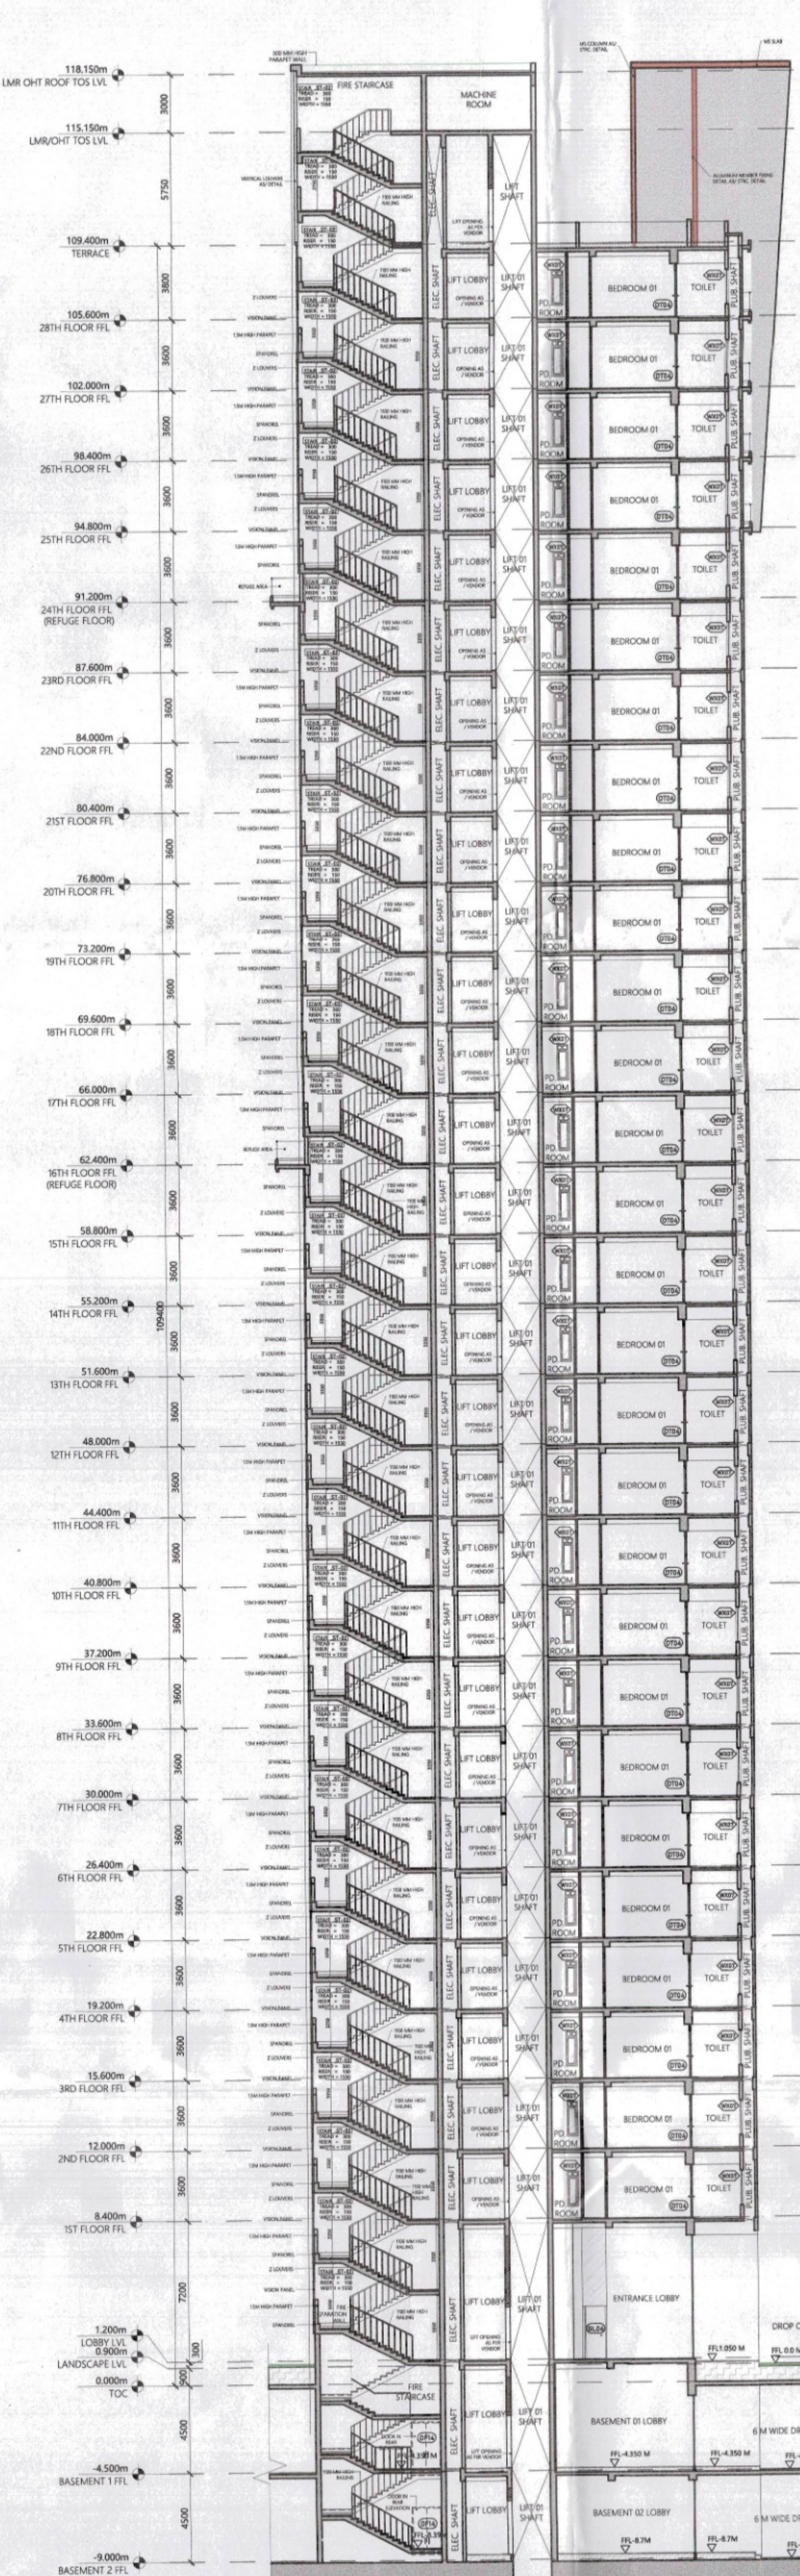

SECTION AA'
SCALE 1:200



SECTION B-B'
SCALE 1:200

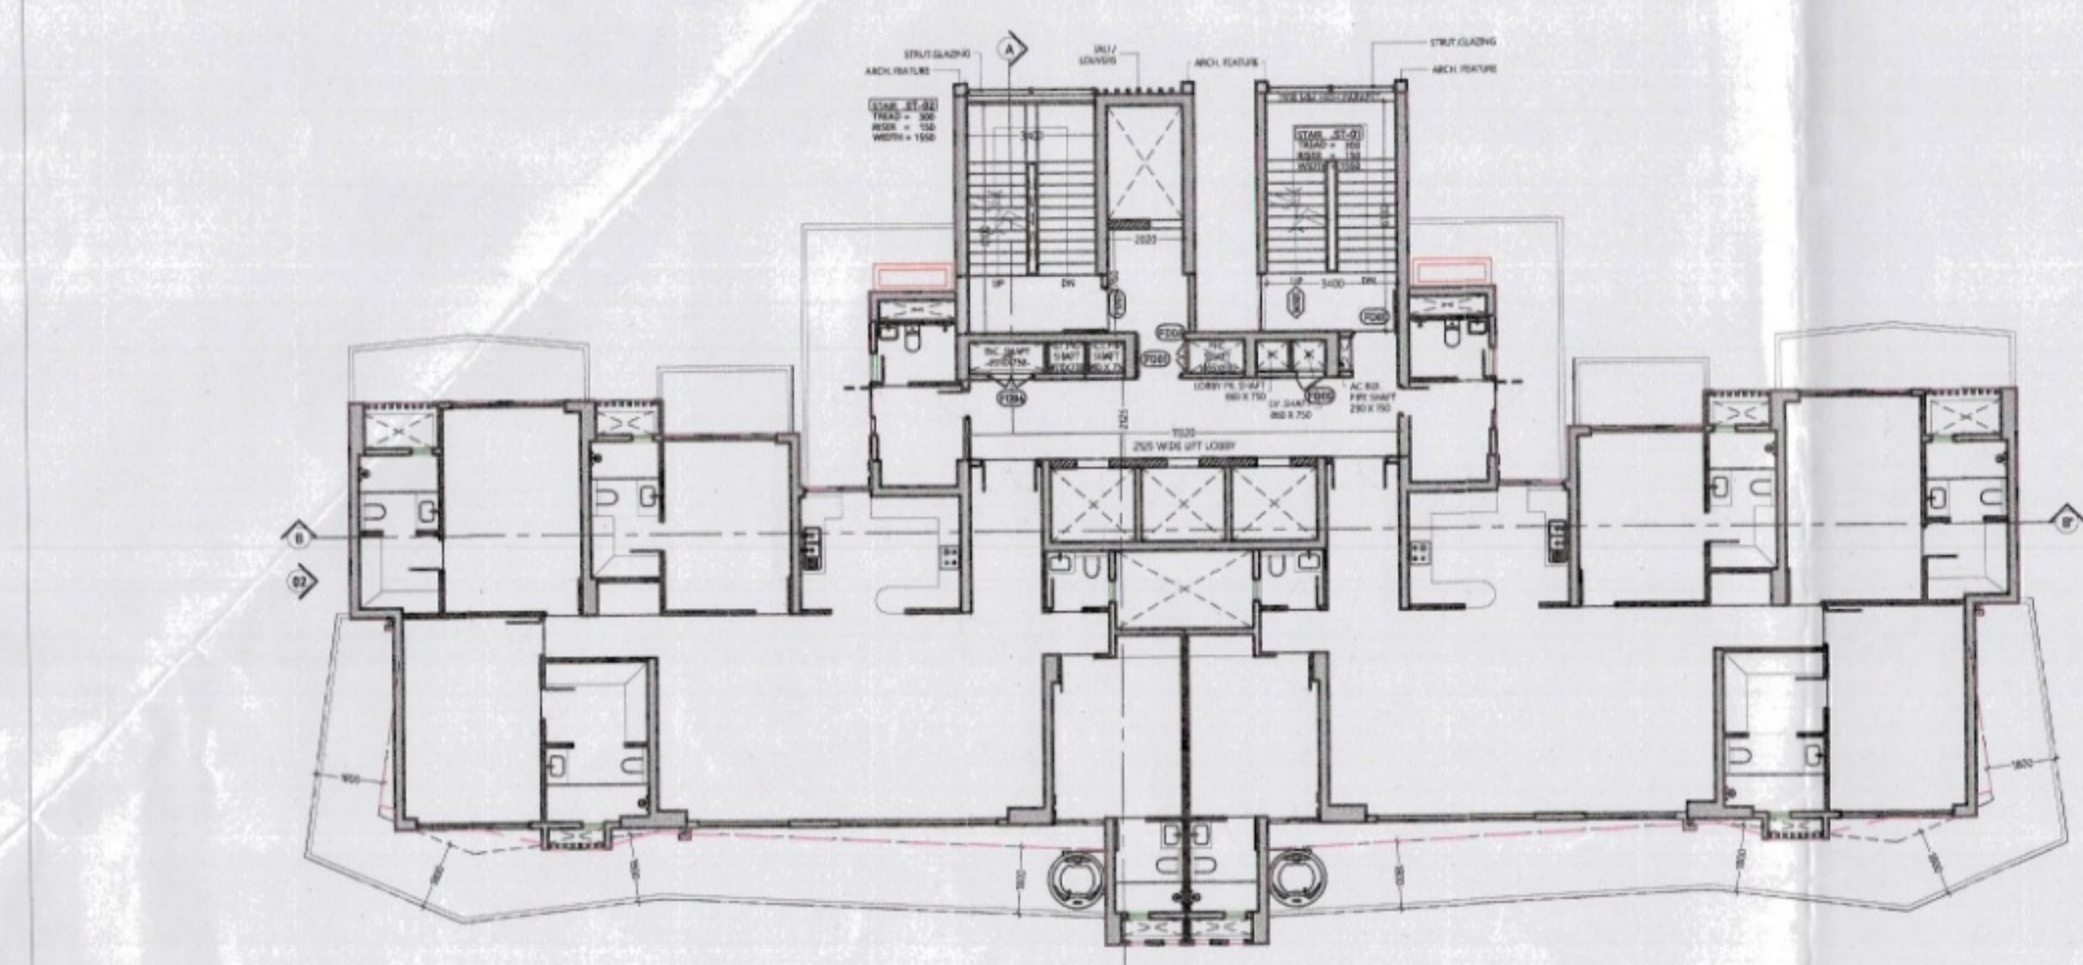

KEY PLAN TYPICAL FLOOR
SCALE 1:200

This is a "PROVISIONAL BUILDING PLAN" approved only for the purpose of inviting objections from the general public.

APPROVED BY:
S.P. (H) Member Secretary
S.P. (H) Member
C.P. (H) Member
B.P.A.C.

TO BE READ WITH THIS NOTICE
NOTING NO. 1
RAJESH DUTT
S.O.(H)
Member
B.P.A.C.

OWNER SIGN
For Ashiana Landcraft Realty Pvt. Ltd.

ARCHITECT SIGN
RAJESH DUTT
ARCHITECT
C-8822081
10/05/2013
NEW DELHI

PLUMBING LEGEND

- 1. 1/2" OD SWP PVC SOL & VENT PIPE
- 2. 1/2" OD SWP PVC WASTE & VENT PIPE
- 3. 80 OD UPVC AIR/STORAGE PIPE
- 4. DOMESTIC WATER SUPPLY ON LINE PIPE
- 5. DOMESTIC WATER SUPPLY ON LINE PIPE FOR UPPER 3/FLOOR
- 6. PLUMBING WATER SUPPLY ON LINE PIPE
- 7. DOMESTIC WATER SUPPLY RISER PIPE FOR G/LT. FLOOR
- 8. PLUMBING WATER SUPPLY RISER PIPE FOR G/LT. FLOOR
- 9. 1/2" OD UPVC RAIN WATER PIPE RACQUET
- 10. 1/2" OD UPVC RAIN WATER PIPE FOR TERRACE

KEY PLAN

SECTOR - 88A
SECTOR - 88

SUBMISSION DRAWING

OWNER
M/S ASHIANA LANDSCAPE REALTY Pvt. Ltd.

PROJECT
REVISED BUILDING PLAN FOR GROUP HOUSING COLONY OVER AN AREA MEASURING 24.125 ACRES (LICENCE NO.42 OF 2013 DATED 06.06.2013 & LICENCE NO.46 OF 2013 DATED 08.06.2013) IN THE REVENUE ESTATE OF VILLAGE HARSARU, SECTOR - 88A, GURUGRAM

SCALE
1:100

DATE
12.07.2025

DRAWING TITLE
ELEVATION & SECTION

TOWER B2

ARCHITECTS
Confluence
CONFERENCE CONSULTANCY SERVICES
P-1, First Floor, 30th Corporate Station, Ashok Nagar, New Delhi-45
www.confluenceindia.com
Ph: 011-43423281-11-43423282
Member of IIA (C) - 1982-2010
architecture urban design hospitality interiors

DRAWING NO.
S-TB2-EL-SEC-109

REVISION
R0