

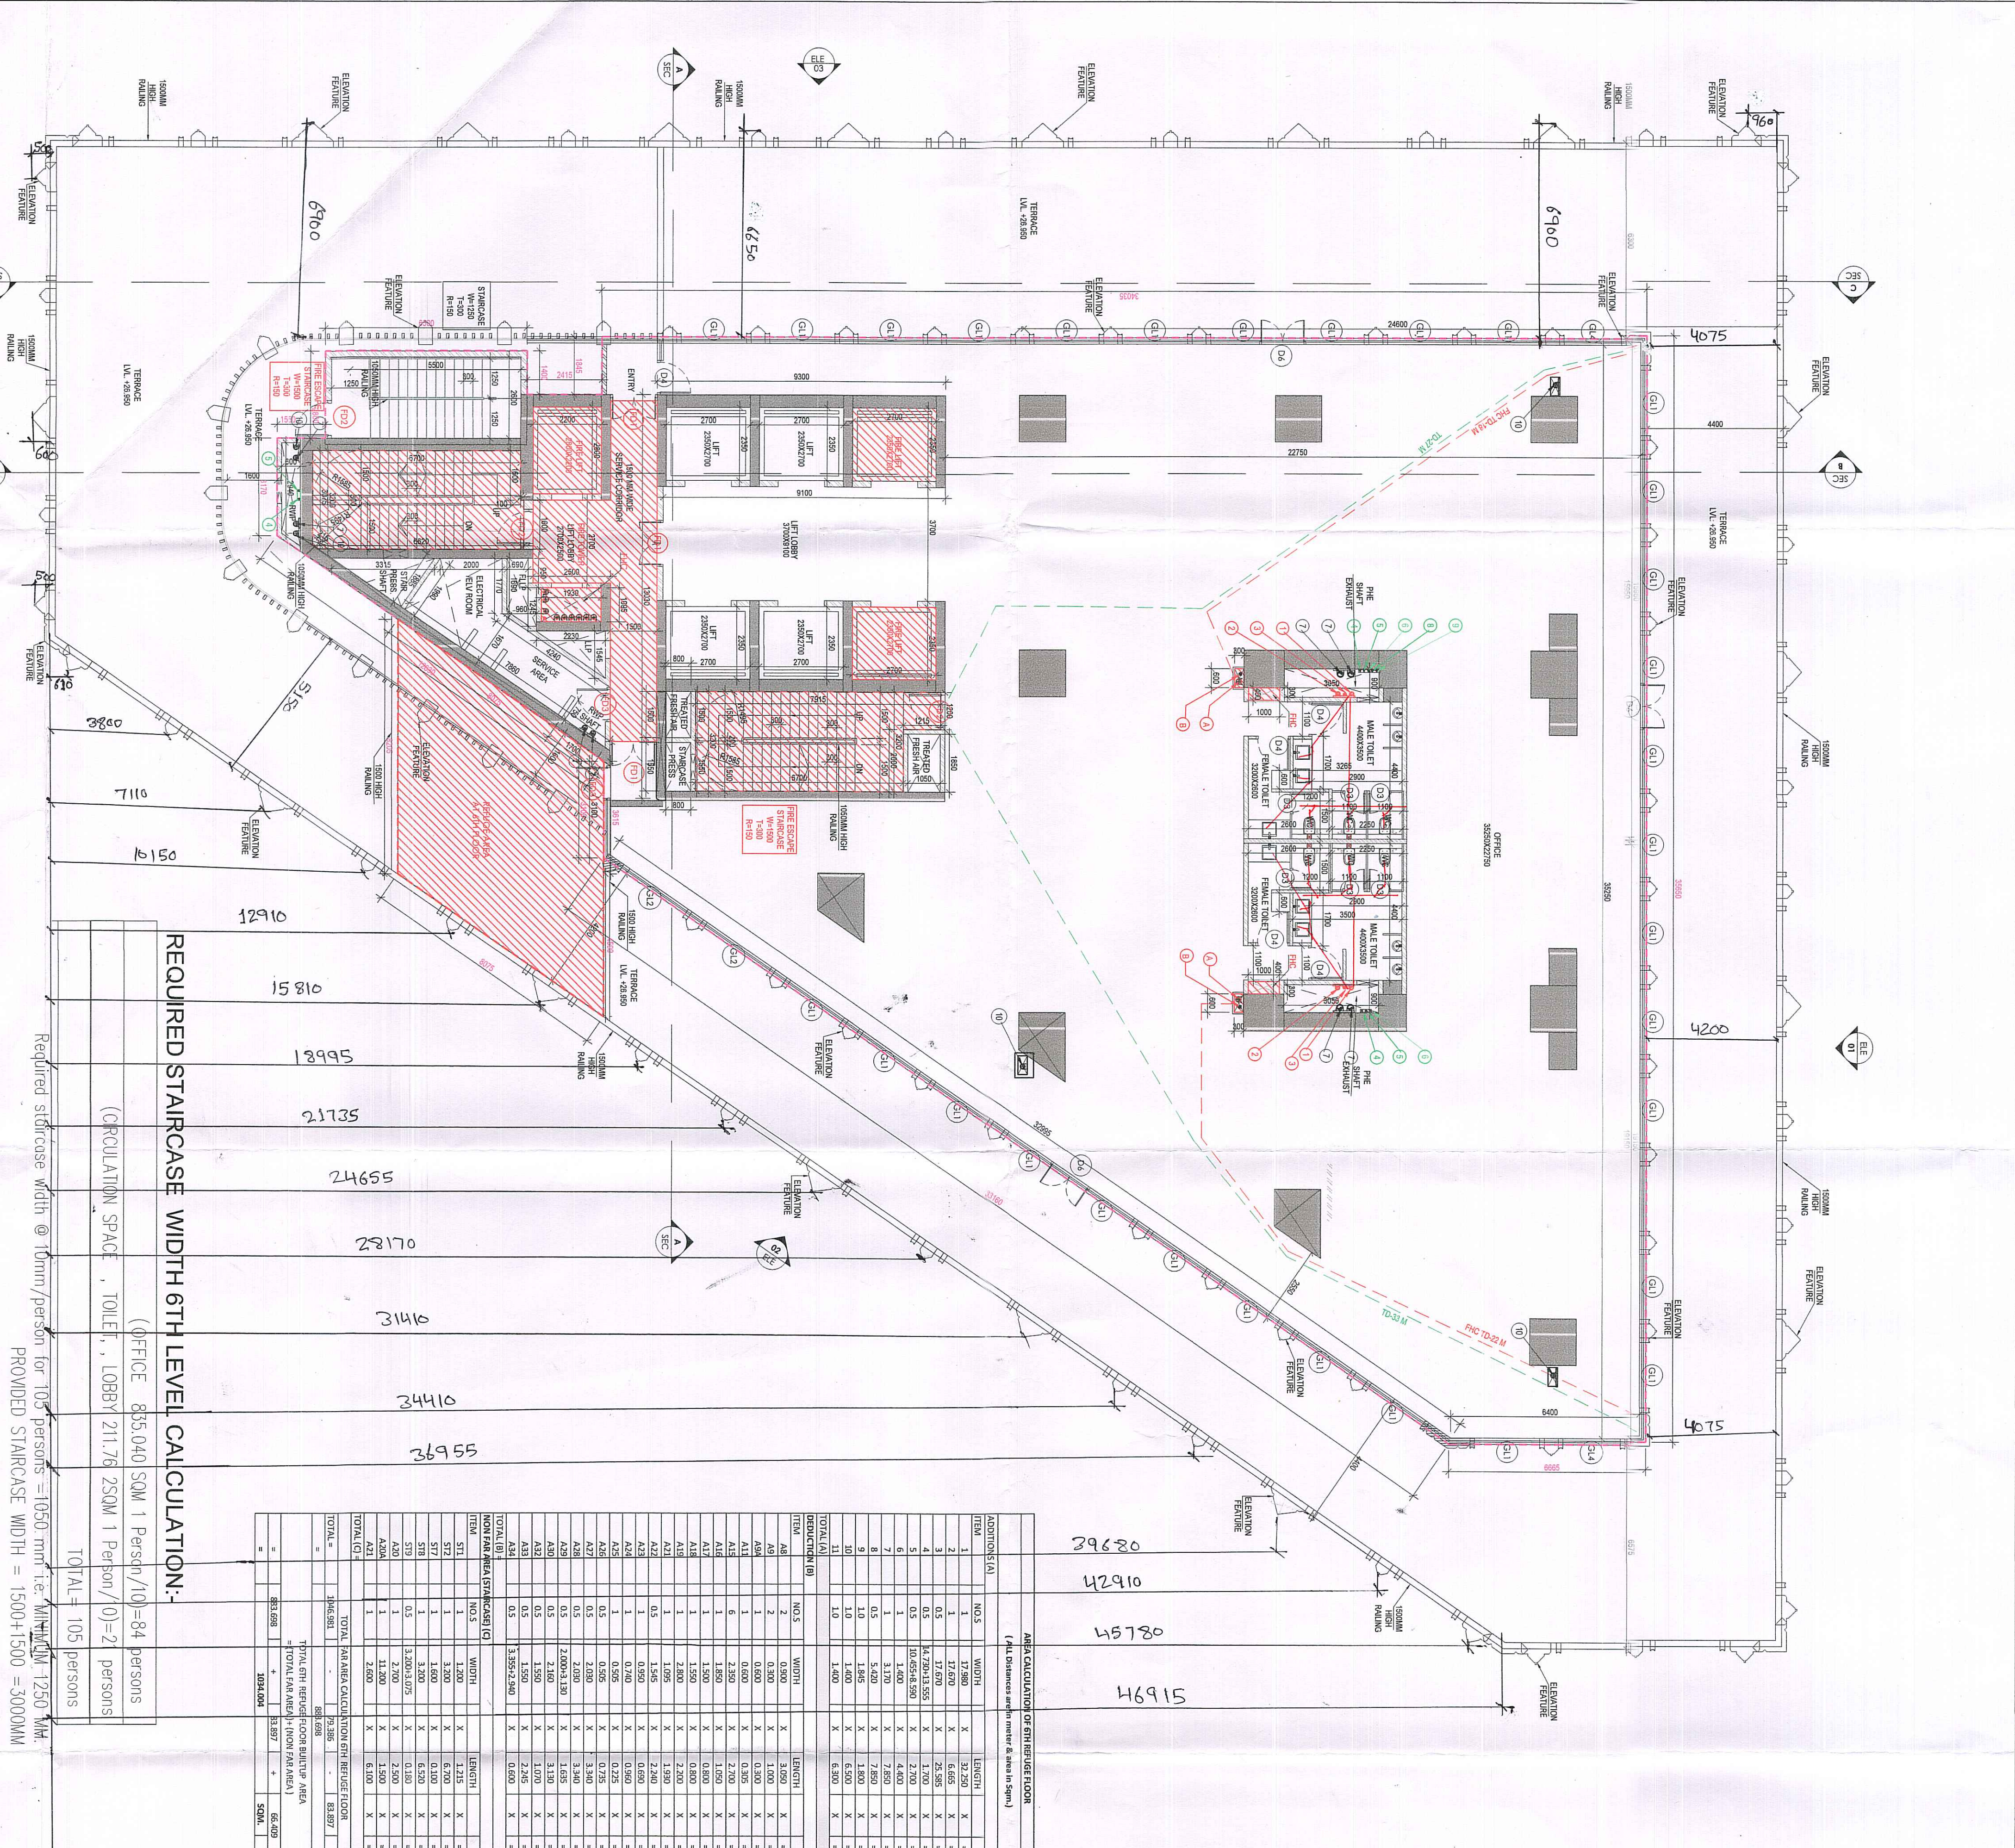


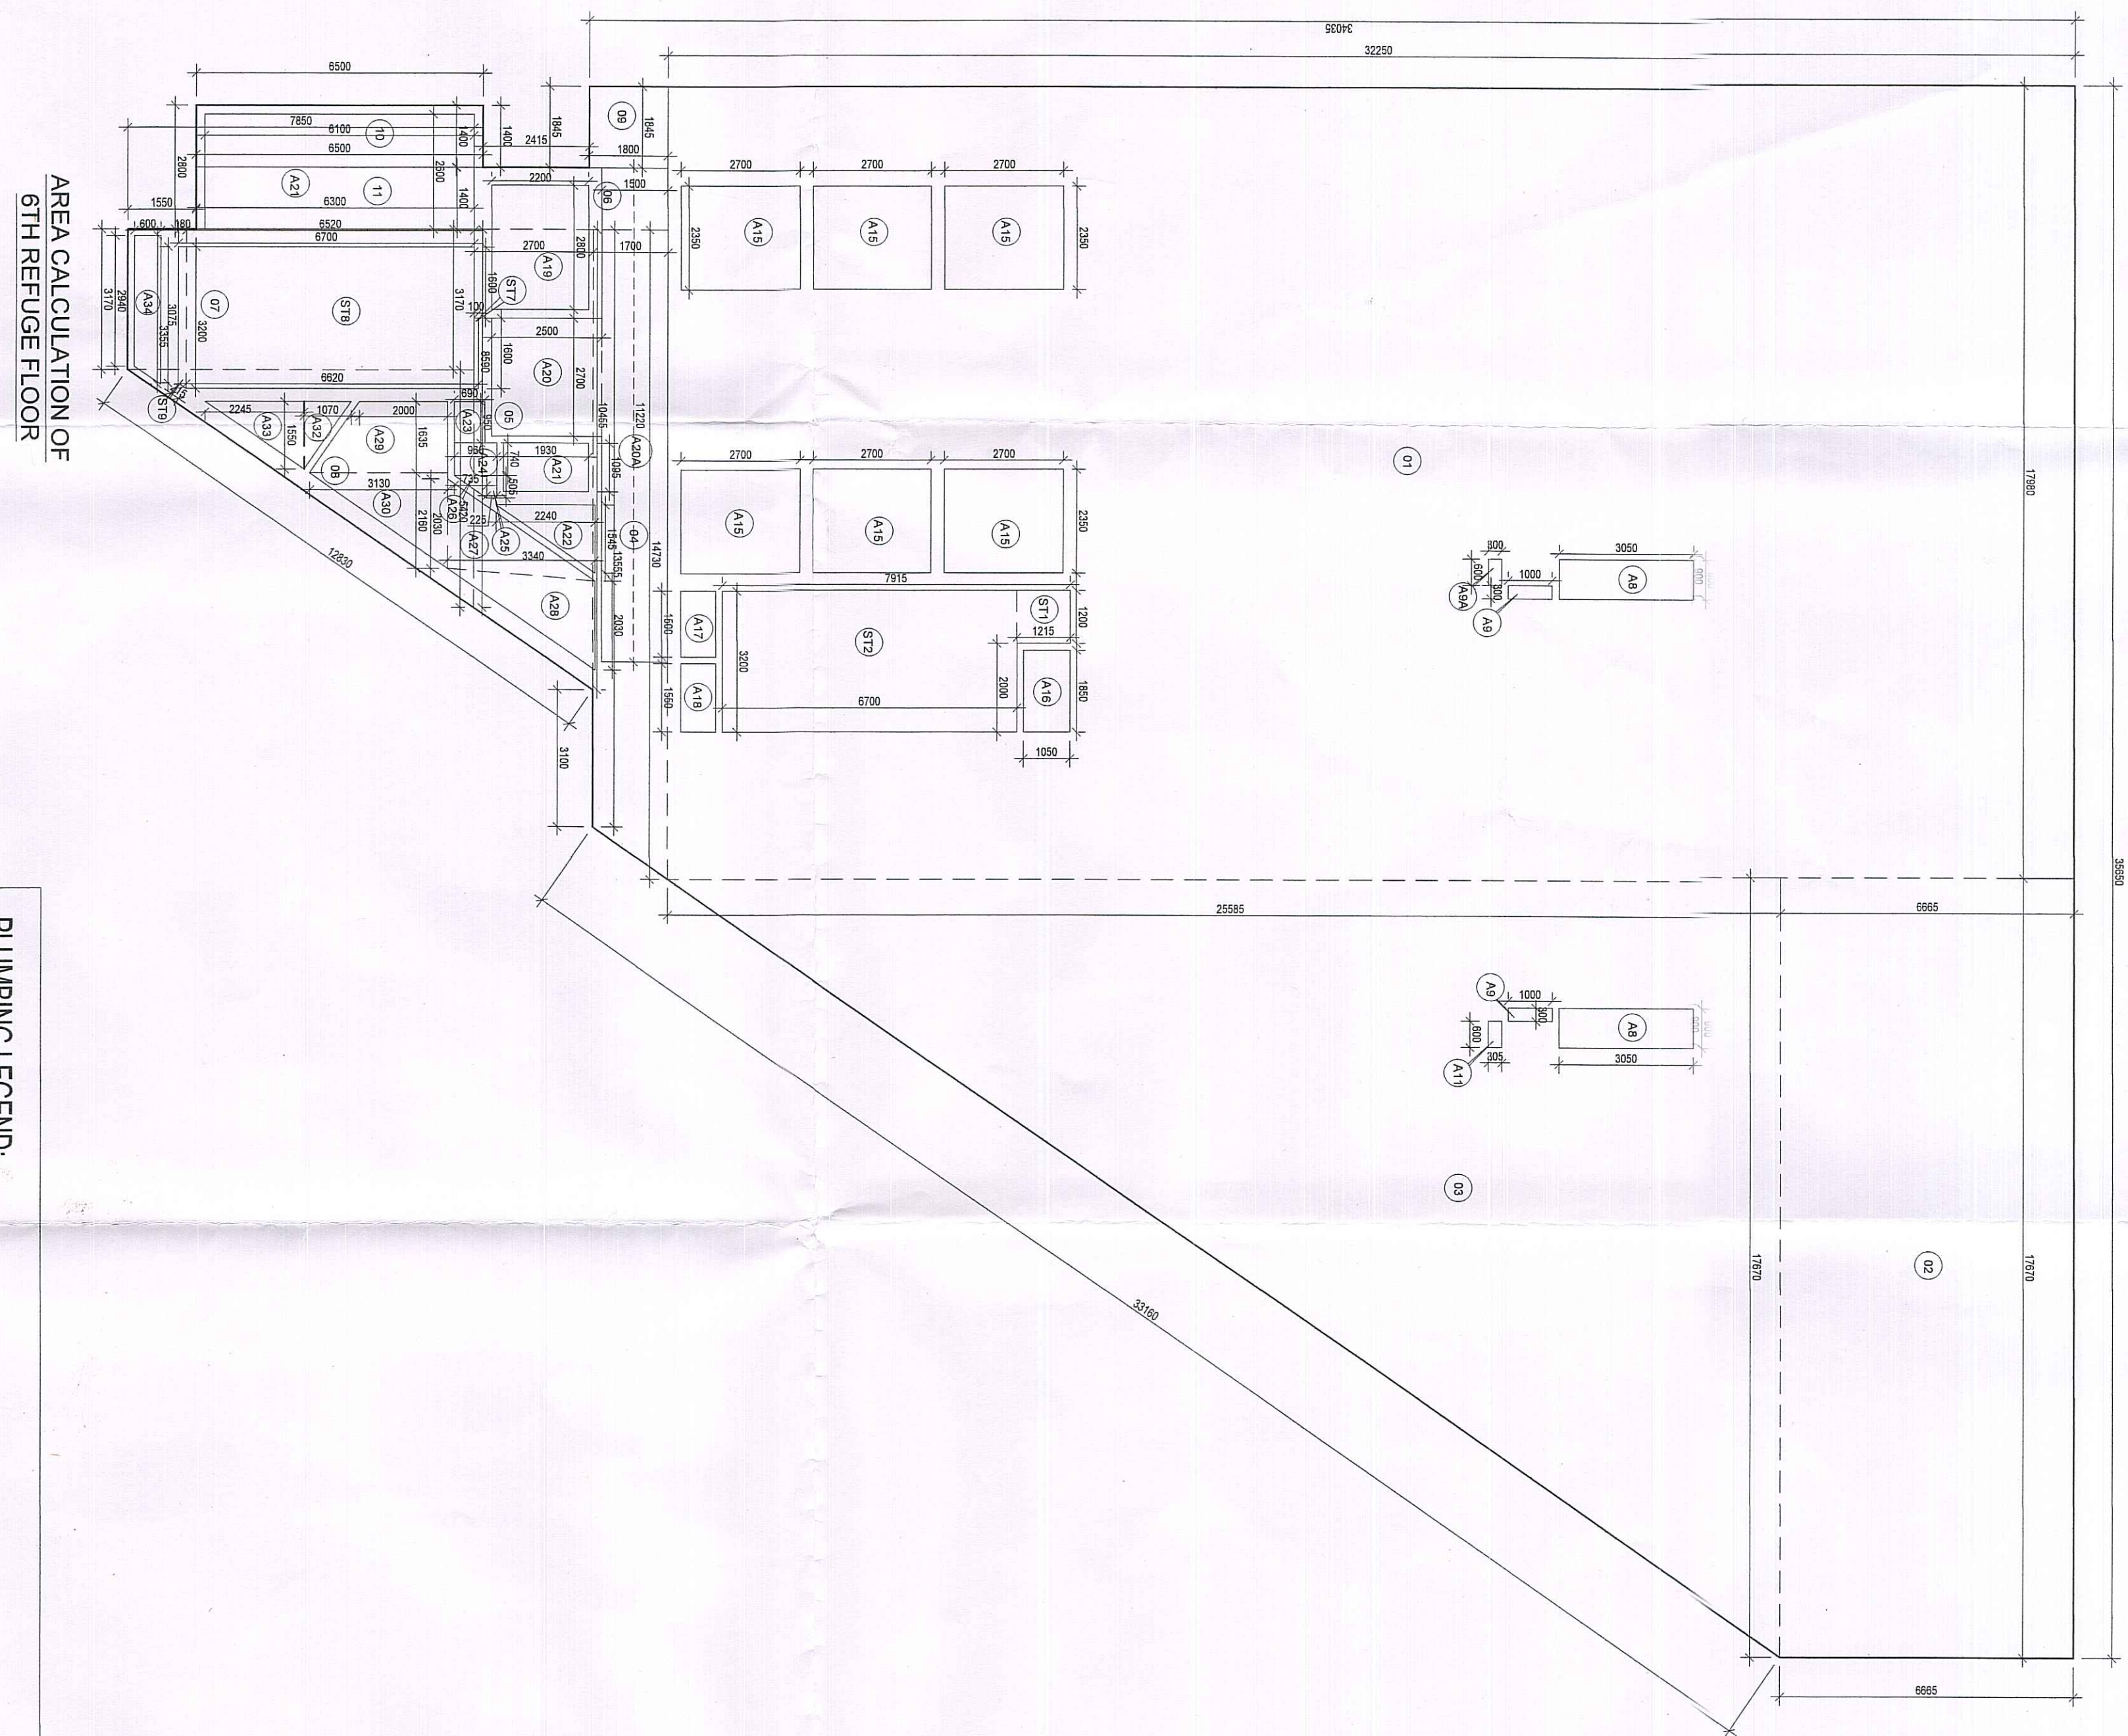

DOOR	NO.	SIZE	LOCATION	DESCRIPTION
D1	1	1100 X 2100	MAIN ENTRANCE	Single Leaf Operable
D2	1	1100 X 2100	MAIN ENTRANCE	Single Leaf Operable
D3	1	1100 X 2100	MAIN ENTRANCE	Single Leaf Operable
D4	1	1100 X 2100	MAIN ENTRANCE	Single Leaf Operable
D5	1	1100 X 2100	MAIN ENTRANCE	Single Leaf Operable
D6	1	1100 X 2100	MAIN ENTRANCE	Single Leaf Operable
D7	1	1100 X 2100	MAIN ENTRANCE	Single Leaf Operable
D8	1	1100 X 2100	MAIN ENTRANCE	Single Leaf Operable
D9	1	1100 X 2100	MAIN ENTRANCE	Single Leaf Operable
D10	1	1100 X 2100	MAIN ENTRANCE	Single Leaf Operable
D11	1	1100 X 2100	MAIN ENTRANCE	Single Leaf Operable
D12	1	1100 X 2100	MAIN ENTRANCE	Single Leaf Operable
D13	1	1100 X 2100	MAIN ENTRANCE	Single Leaf Operable
D14	1	1100 X 2100	MAIN ENTRANCE	Single Leaf Operable
D15	1	1100 X 2100	MAIN ENTRANCE	Single Leaf Operable
D16	1	1100 X 2100	MAIN ENTRANCE	Single Leaf Operable
D17	1	1100 X 2100	MAIN ENTRANCE	Single Leaf Operable
D18	1	1100 X 2100	MAIN ENTRANCE	Single Leaf Operable
D19	1	1100 X 2100	MAIN ENTRANCE	Single Leaf Operable
D20	1	1100 X 2100	MAIN ENTRANCE	Single Leaf Operable

NO.	DESCRIPTION	AREA (SQM)	PERSONS
1	OFFICE	855.040	84
2	COROLLATION SPACE, TOILET, LOBBY	211.78	21
3	TOTAL	1066.82	105

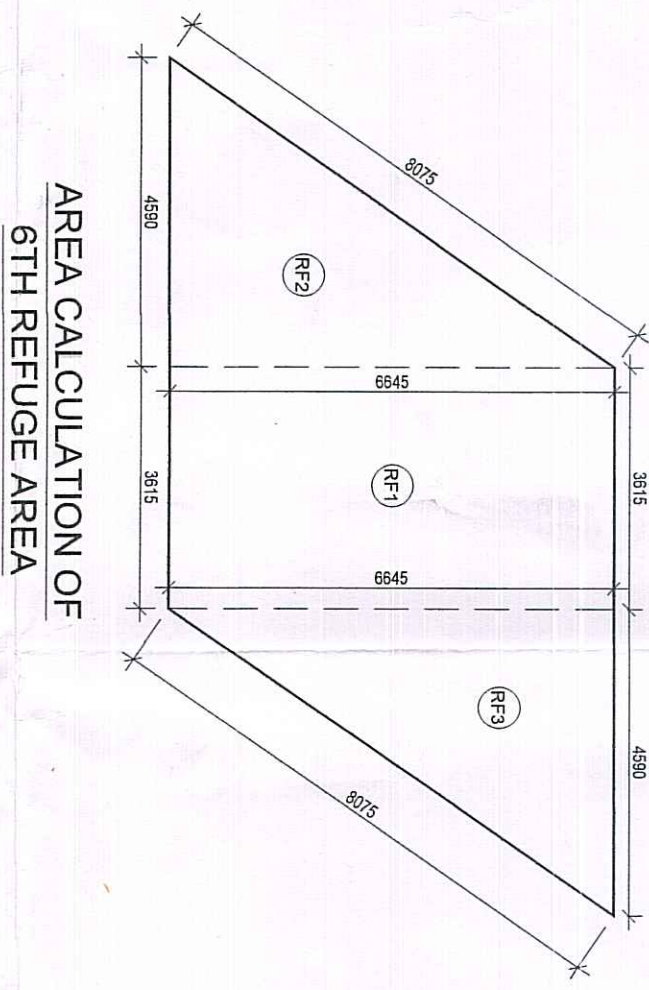

PLUMBING LEGEND:
1 1000 SOL PIPE
2 1000 WASTE PIPE
3 750 ANTI-SIPHONAGE PIPE
4 DOMESTIC WATER SUPPLY PIPE DOWN-TAKE
5 DOMESTIC WATER SUPPLY PIPE DOWN-TAKE
6 FLUSHING WATER SUPPLY PIPE DOWN-TAKE
7 1500 RAIN WATER PIPE
8 DOMESTIC WATER SUPPLY RISER
9 FLUSHING WATER SUPPLY RISER
10 1500 RAIN WATER PIPE FOR BALCONY
11 CLEAN OUT PLUG
12 FLOOR TRAP WITH (1500 SLEEVE OR 150X150MM CUTOUT)
13 FLOOR DRAIN WITH (1250 SLEEVE OR 125X125MM CUTOUT)
14 WC DROP WITH (1500 SLEEVE OR 150X150MM CUTOUT)

S.No.	FIRE FIGHTING LEGEND:
A	1500 M.S FIRE HYDRANT RISER
B	800 M.S DRAIN PIPE
C	1500 M.S SPRINKLER RISER
Ca	1500 M.S SPRINKLER RISER
FHC	FIRE HOSE CABINET

Note:-

ALL FLOOR MECHANICAL VENTILATED LIGHTED & 100% POWER BACKUP. AIR CONDITIONING SYSTEM IS BEING PROVIDED. DG POWER BACKUP IS BEING PROVIDED. TOILET ARE MECHANICAL VENTILATED. ALL LIFTS SHALL HAVE POWER BACKUP. ALL ELECTRICAL INSTALLATION SHALL BE AS PER PROVISION OF RELEVANT CODE. FIRE FIGHTING PROVISIONS WILL BE AS PER RELEVANT CODE PROVISIONS. BASEMENT AREAS SHALL HAVE MECHANICALLY VENTILATED AREAS. ALL TOILETS ARE VENTILATED AS PER HARYANA BUILDING CODE 2017. BUILDINGS HAS AUTOMATIC SPRINKLER SYSTEM WHEREVER REQUIRED BY RELEVANT CODE. BUILDING WILL BE DESIGNED (STRUCTURES) AS PER RELEVANT IS CODES FOR EARTHQUAKE RESISTANCE. SOLAR PANELS OF REQUIRED CAPACITY SHALL BE PROVIDED AS PER HARE MAZONGING NORMS. ALL HANDICAP PLANS WITH RAILINGS. ALL FIRE FIGHTING INSTALLATIONS SHALL BE THE BURNING WATER SUPPLYING SYSTEM SHALL BE PROVIDED AS PER CENTRAL GROUND WATER AUTHORITY NORMS.

PROJECT:-
PROPOSED BUILDING PLAN OF COMMERCIAL COMPLEX SITE AREA 1.196 ACRES (4843.03 SQM) IN SECTOR 28, GURULUGRAM

OWNERS:-
ACQUISITIVE INFRADEVELOPERS PVT. LTD.
WITH LODA DEVELOPERS LIMITED.

OWNERS SEAL & SIGNATURE
SANCTIONED
Vaid Memo No. _____ Date: 21/11/24

ARCHITECT'S SEAL & SIGNATURE
ARCHITECT: [Signature]
BRNC

Scale: 1:100
Drawing No.: FHC-2026
Drawing Title:-
Fire Fighting Plan
Prepared by: [Signature]
Checked by: [Signature]
For Client Approval: [Signature]
Date: 11/11/24