

Note :-

ALL FLOOR MECHANICAL VENTILATED LIGHTED & 100% POWER BACKUP. AIR CONDITIONING SYSTEM IS BEING PROVIDED

DG POWER BACKUP IS BEING PROVIDED. TOILET ARE MECHANICAL VENTILATED. ALL LIFTS SHALL HAVE POWER BACK-UP. ALL ELECTRICAL INSTALLATION SHALL BE AS PER PROVISION OF RELEVANT CODE. FIRE/FIGHTING/SAFETY PROVISIONS WILL BE AS PER RELEVANT CODE PROVISIONS. BASEMENT AREA SHALL HAVE MECHANICALLY VENTILATED AS PER RELEVANT CODE.

ALL TOILETS ARE VENTILATED AS PER HARYANA BUILDING CODE 2017.

BUILDINGS HAS AUTOMATIC SPRINKLER SYSTEM WHEREVER REQUIRED BY RELEVANT CODE. BUILDING WILL BE DESIGNED (STRUCTURES)AS PER RELEVANT

I.S.CODES FOR EARTHQUAKE RESISTANCE. SOLAR PANELS OF REQUIRED CAPACITY SHALL BE PROVIDED AS PER HARE DAIZONING NORMS.

ALL HANDICAP RAMPS WITH RAILING. ALL FIRE FIGHTING INSTALLATIONS SHALL BE AS PER PROVISION OF RELEVANT CODE.

THE RAINWATER HARVESTING SYSTEM SHALL BE PROVIDED AS PER CENTRAL GROUND WATER AUTHORITY NORMS.

PROJECT:

PROPOSED BUILDING PLAN OF COMMERCIAL COMPLEX SITE AREA 1.196 ACRES (4843.046 SQM) IN SECTOR 28, GURUGRAM

OWNER'S

ACQUISITIVE INFRADEVELOPERS PVT. LTD. WITH LODHA DEVELOPERS LIMITED.

OWNER'S SEAL & SIGNATURE

For ACQUISITIVE INFRADEVELOPERS PVT. LTD. Authorized Signatory

ARCHITECT'S SEAL & SIGNATURE

Seal of Architect

Seal of Engineer

Seal of Engineer

MAY-2026

Scale : 1/50

Drawing No. -

Drawing Title:-

SITE PLAN SERVICES


ST-01A

EXISTING BUILDING

EXISTING BUILDING

EXISTING BUILDING

ROAD 18.0M WIDE

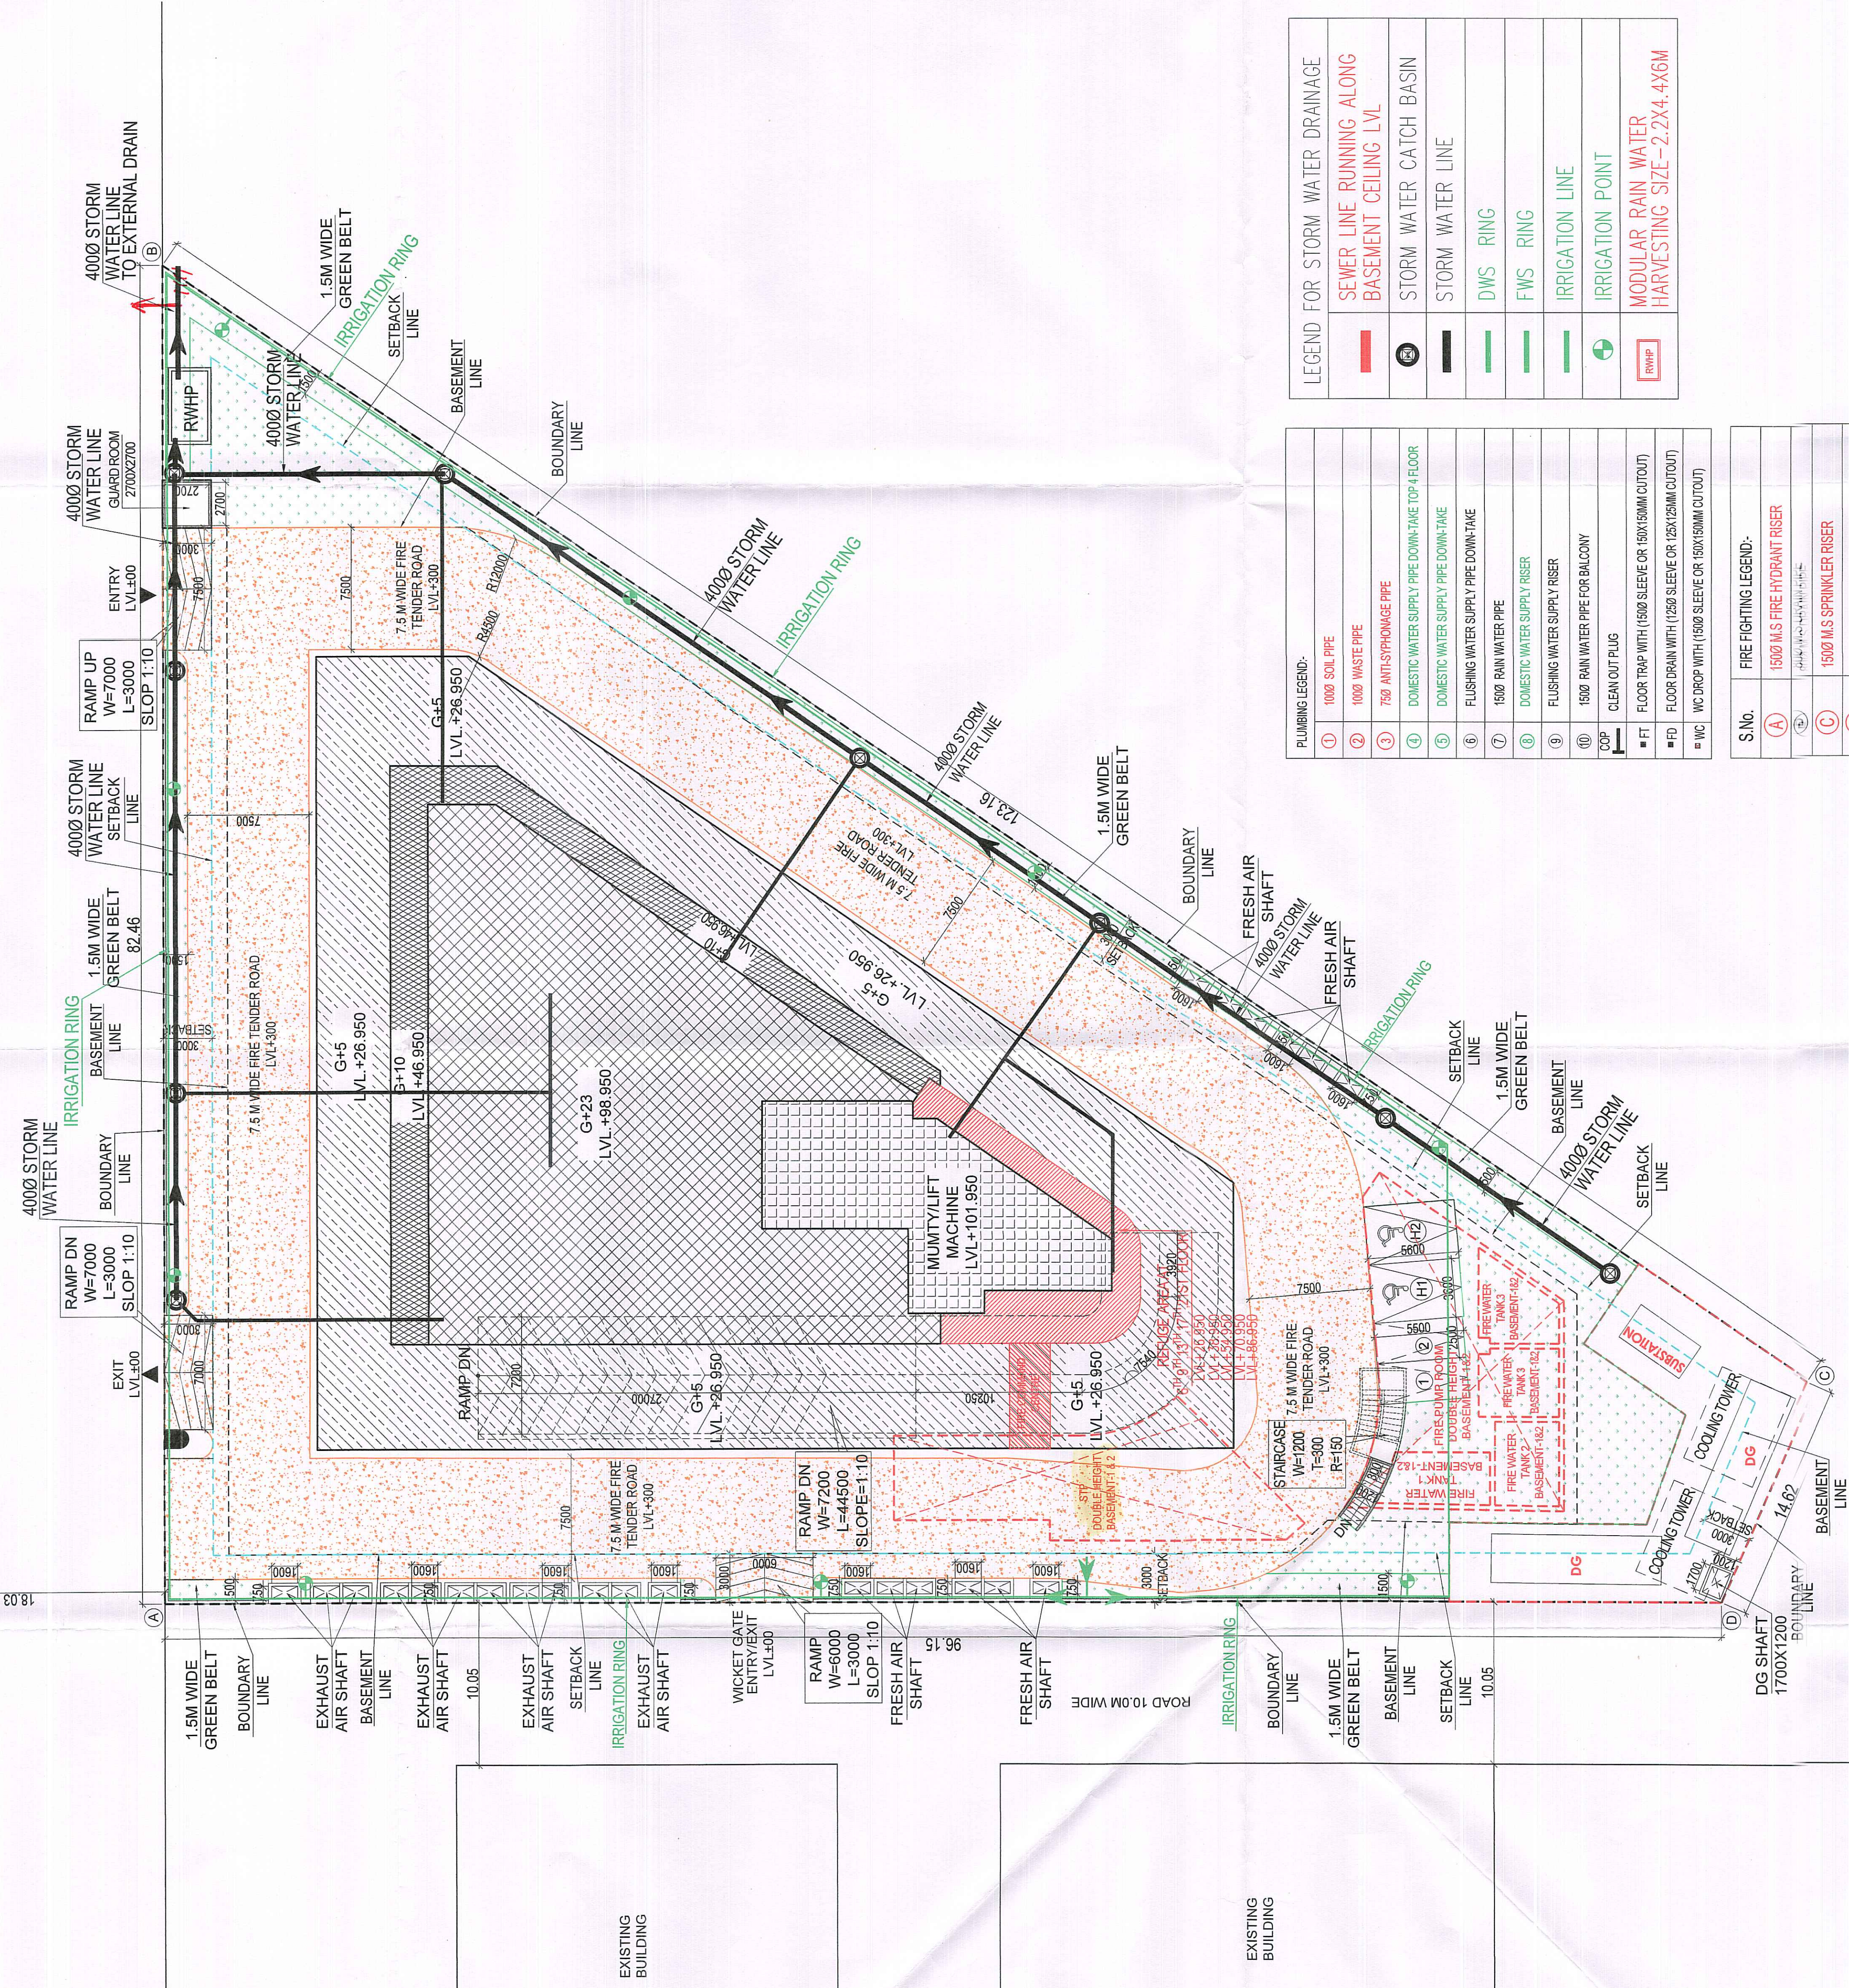

PLUMBING LEGEND:

1	1000 SDR PIPE
2	1000 WASTE PIPE
3	750 ANTI-SIPHONAGE PIPE
4	DOMESTIC WATER SUPPLY PIPE DOWN-TAKE FOR 4 FLOOR
5	DOMESTIC WATER SUPPLY PIPE DOWN-TAKE
6	FLUSHING WATER SUPPLY PIPE DOWN-TAKE
7	1500 RAIN WATER PIPE
8	DOMESTIC WATER SUPPLY RISER
9	FLUSHING WATER SUPPLY RISER
10	1500 RAIN WATER PIPE FOR BALCONY
11	CLEAN OUT PLUG
12	FLOOR TRAP WITH 150MM SLEEVE OR 150MM CUTOFF
13	FLOOR DRAIN WITH 150MM SLEEVE OR 150MM CUTOFF
14	WC DROP WITH 150MM SLEEVE OR 150MM CUTOFF

LEGEND FOR STORM WATER DRAINAGE

1	SEWER LINE RUNNING ALONG BASEMENT CEILING LVL
2	STORM WATER CATCH BASIN
3	STORM WATER LINE
4	DWS RING
5	FWS RING
6	IRRIGATION LINE
7	MODULAR RAIN WATER HARVESTING SIZE-2.2X4.4XGM

PLUMBING LEGEND:

1	1000 SDR PIPE
2	1000 WASTE PIPE
3	750 ANTI-SIPHONAGE PIPE
4	DOMESTIC WATER SUPPLY PIPE DOWN-TAKE FOR 4 FLOOR
5	DOMESTIC WATER SUPPLY PIPE DOWN-TAKE
6	FLUSHING WATER SUPPLY PIPE DOWN-TAKE
7	1500 RAIN WATER PIPE
8	DOMESTIC WATER SUPPLY RISER
9	FLUSHING WATER SUPPLY RISER
10	1500 RAIN WATER PIPE FOR BALCONY
11	CLEAN OUT PLUG
12	FLOOR TRAP WITH 150MM SLEEVE OR 150MM CUTOFF
13	FLOOR DRAIN WITH 150MM SLEEVE OR 150MM CUTOFF
14	WC DROP WITH 150MM SLEEVE OR 150MM CUTOFF

LEGEND FOR STORM WATER DRAINAGE

1	SEWER LINE RUNNING ALONG BASEMENT CEILING LVL
2	STORM WATER CATCH BASIN
3	STORM WATER LINE
4	DWS RING
5	FWS RING
6	IRRIGATION LINE
7	MODULAR RAIN WATER HARVESTING SIZE-2.2X4.4XGM

PLUMBING LEGEND:

1	1000 SDR PIPE
2	1000 WASTE PIPE
3	750 ANTI-SIPHONAGE PIPE
4	DOMESTIC WATER SUPPLY PIPE DOWN-TAKE FOR 4 FLOOR
5	DOMESTIC WATER SUPPLY PIPE DOWN-TAKE
6	FLUSHING WATER SUPPLY PIPE DOWN-TAKE
7	1500 RAIN WATER PIPE
8	DOMESTIC WATER SUPPLY RISER
9	FLUSHING WATER SUPPLY RISER
10	1500 RAIN WATER PIPE FOR BALCONY
11	CLEAN OUT PLUG
12	FLOOR TRAP WITH 150MM SLEEVE OR 150MM CUTOFF
13	FLOOR DRAIN WITH 150MM SLEEVE OR 150MM CUTOFF
14	WC DROP WITH 150MM SLEEVE OR 150MM CUTOFF

LEGEND FOR STORM WATER DRAINAGE

1	SEWER LINE RUNNING ALONG BASEMENT CEILING LVL
2	STORM WATER CATCH BASIN
3	STORM WATER LINE
4	DWS RING
5	FWS RING
6	IRRIGATION LINE
7	MODULAR RAIN WATER HARVESTING SIZE-2.2X4.4XGM

PLUMBING LEGEND:

1	1000 SDR PIPE
2	1000 WASTE PIPE
3	750 ANTI-SIPHONAGE PIPE
4	DOMESTIC WATER SUPPLY PIPE DOWN-TAKE FOR 4 FLOOR
5	DOMESTIC WATER SUPPLY PIPE DOWN-TAKE
6	FLUSHING WATER SUPPLY PIPE DOWN-TAKE
7	1500 RAIN WATER PIPE
8	DOMESTIC WATER SUPPLY RISER
9	FLUSHING WATER SUPPLY RISER
10	1500 RAIN WATER PIPE FOR BALCONY
11	CLEAN OUT PLUG
12	FLOOR TRAP WITH 150MM SLEEVE OR 150MM CUTOFF
13	FLOOR DRAIN WITH 150MM SLEEVE OR 150MM CUTOFF
14	WC DROP WITH 150MM SLEEVE OR 150MM CUTOFF

LEGEND FOR STORM WATER DRAINAGE

1	SEWER LINE RUNNING ALONG BASEMENT CEILING LVL
2	STORM WATER CATCH BASIN
3	STORM WATER LINE
4	DWS RING
5	FWS RING
6	IRRIGATION LINE
7	MODULAR RAIN WATER HARVESTING SIZE-2.2X4.4XGM

