



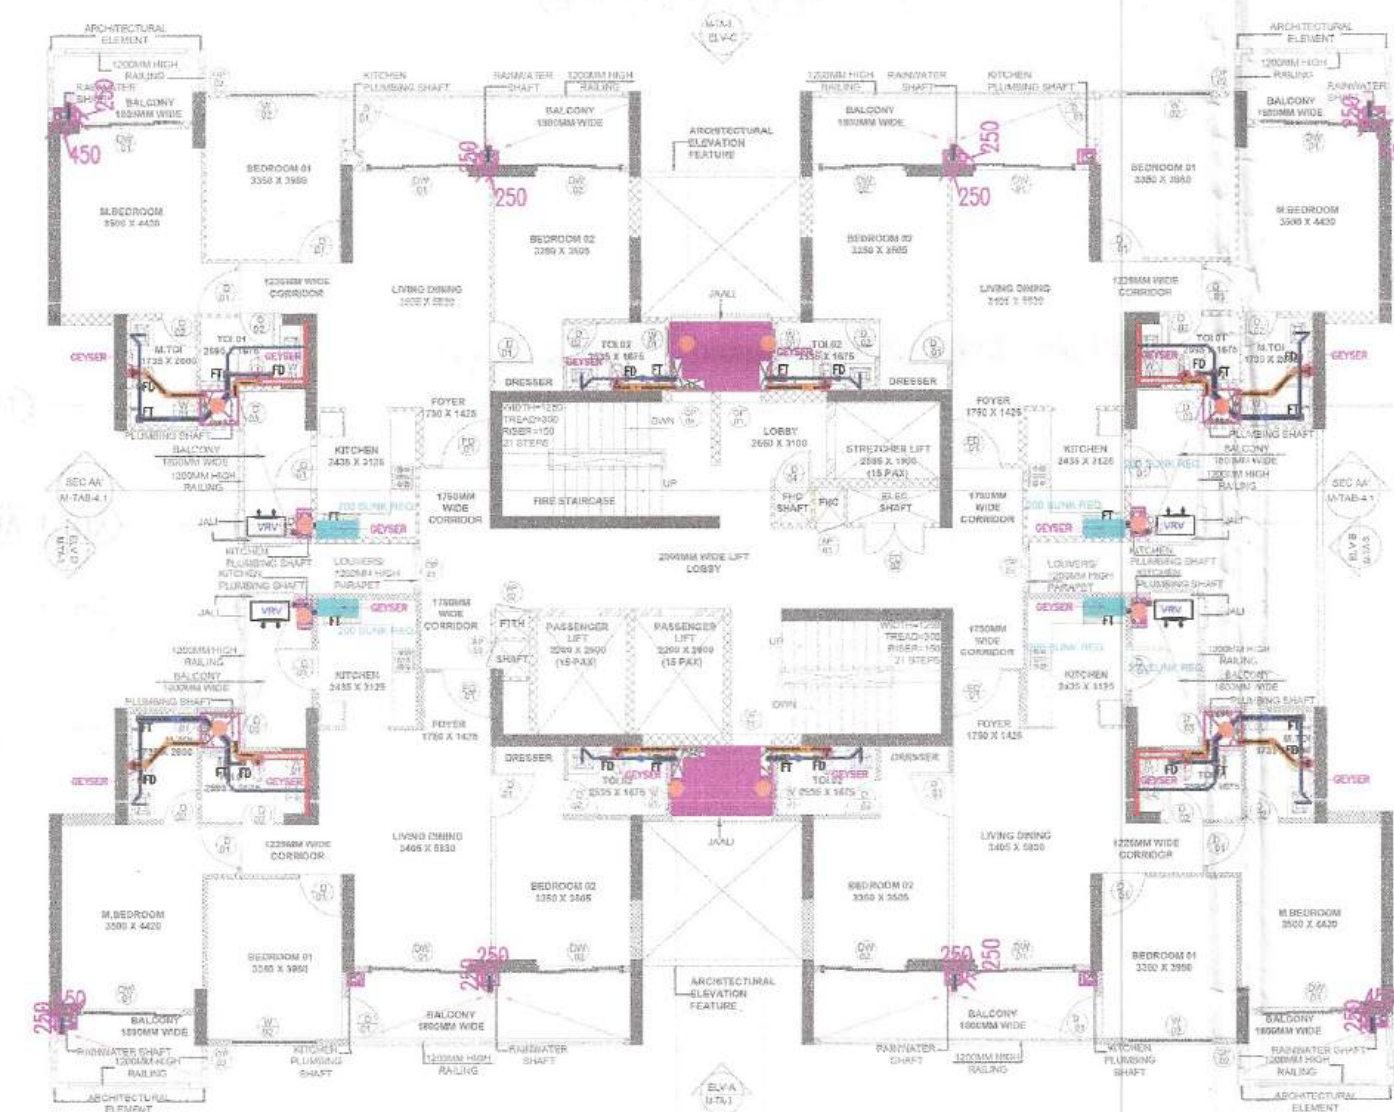

TYPICAL FLOOR (2ND TO 5TH, 8TH TO 9TH, 12TH TO 17TH, 19TH TO 24TH, 28TH & 31ST TO 34TH FLOOR)

WATER SUPPLY LEGEND-	
DWS	DOMESTIC WATER SUPPLY
FWS	FLUSHING WATER SUPPLY
HWS	HOT WATER SUPPLY
DWR	DOMESTIC WATER RISER
FWR	FLUSHING WATER RISER
BWS	BOOSTER WATER SUPPLY
WM	WATER METER

PLUMBING LEGEND & ABBREVIATION-	
1.	H/BV BUTTERFLY VALVE
2.	H/W NON-BELOW VALVE
3.	3/4" Y-TYPE STRAINER
4.	4" AIR RELEASE VALVE
5.	5" PRESSURE REDUCING VALVE
6.	6" PRESSURE REDUCING VALVE
7.	7" PRESSURE REDUCING VALVE
100.	100" PRESSURE REDUCING VALVE

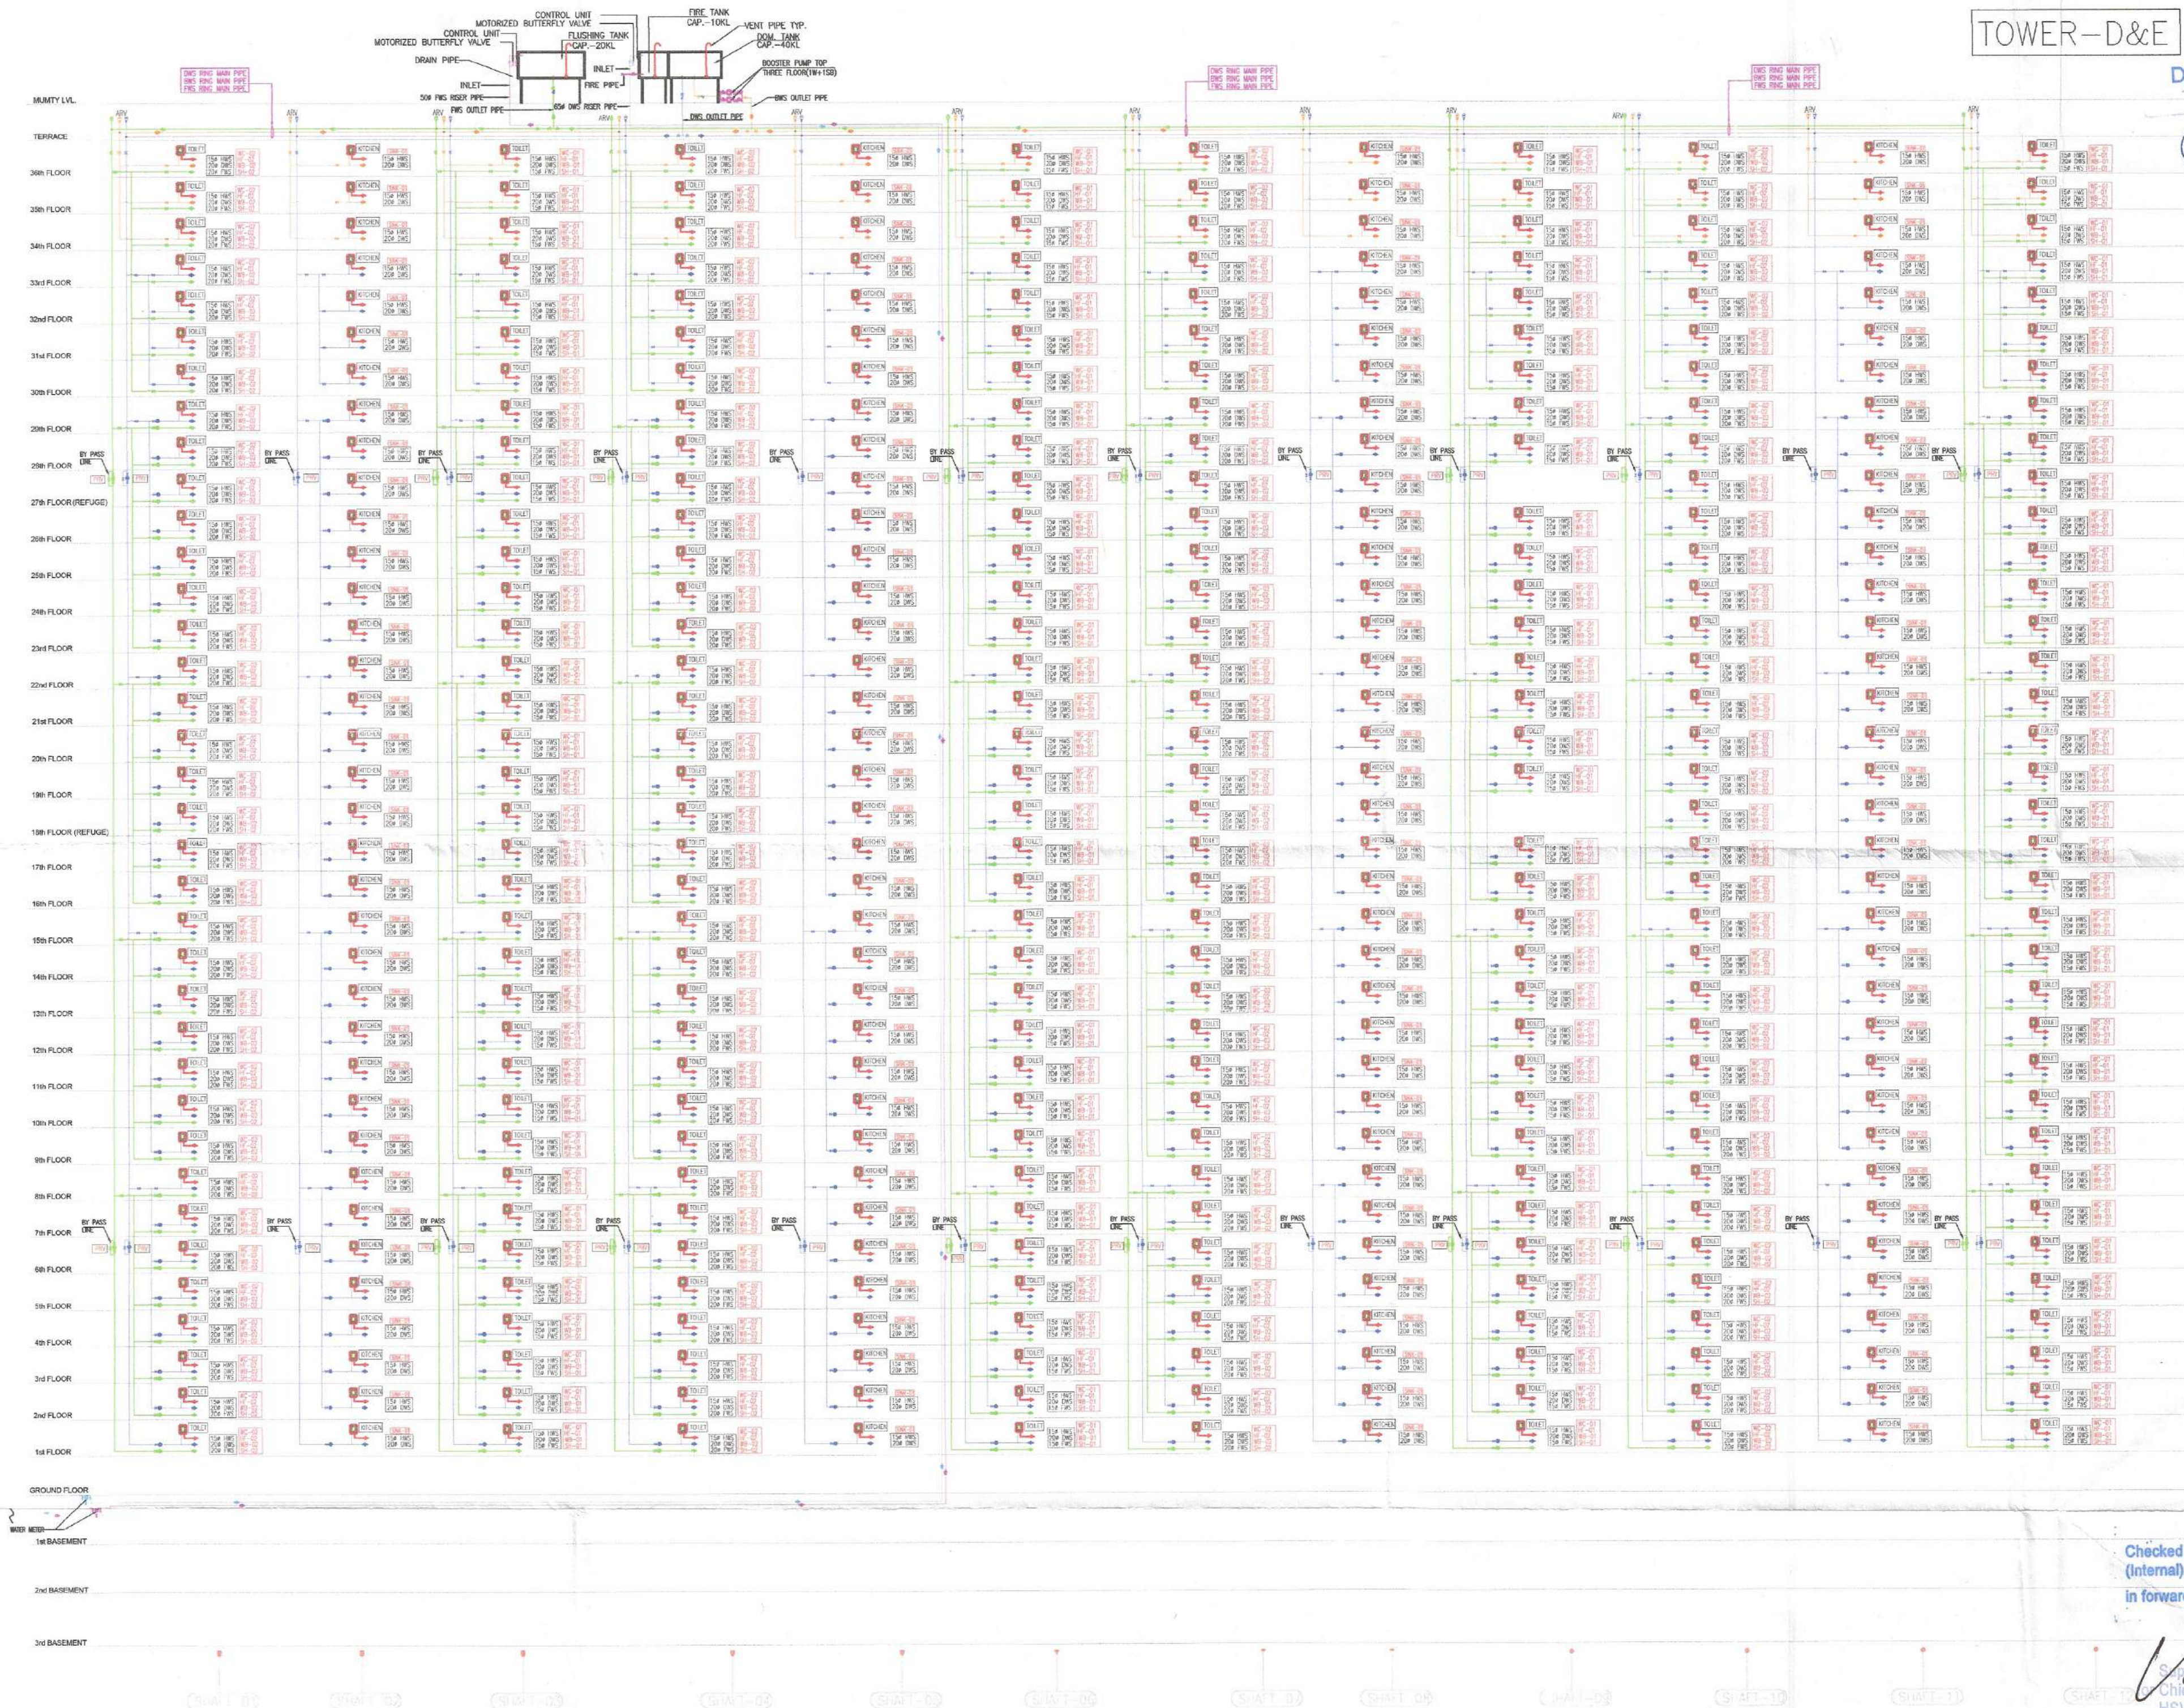

TOWER-D&E

S.T.P. (HQ) Member Secretary B.P.A.C.
 S.T.P. (G) Member B.P.A.C.
 C.T.R. (HR) Chairman B.P.A.C.
 DTP (HQ) JD.
 ATP (HQ) JD.
 DINESH KUMAR PA (HQ)
 JDT (T) MEMBER BPAC

SANCTIONED TO BE READ WITH THIS OFFICE MEMO NO. DATED :

Checked and found ok for Public Health (Internal) Service only subject to compliance in forwarding letter No. 21/2023 dated 21.05.2023
 For BIRLA ESTATES PVT. LTD.
 Authorized Signatory

ENGINEER
 BIRLA ESTATES PVT. LTD.
 ARCHITECTURE COLLECTIVE
 WATERSUPPLY-SLD (TOWER-D&E)
 DRG. NO. M-TDE-SLD
 SCALE: 1/80
 DATE: 20/05/2023
 SHEET: 01/01