



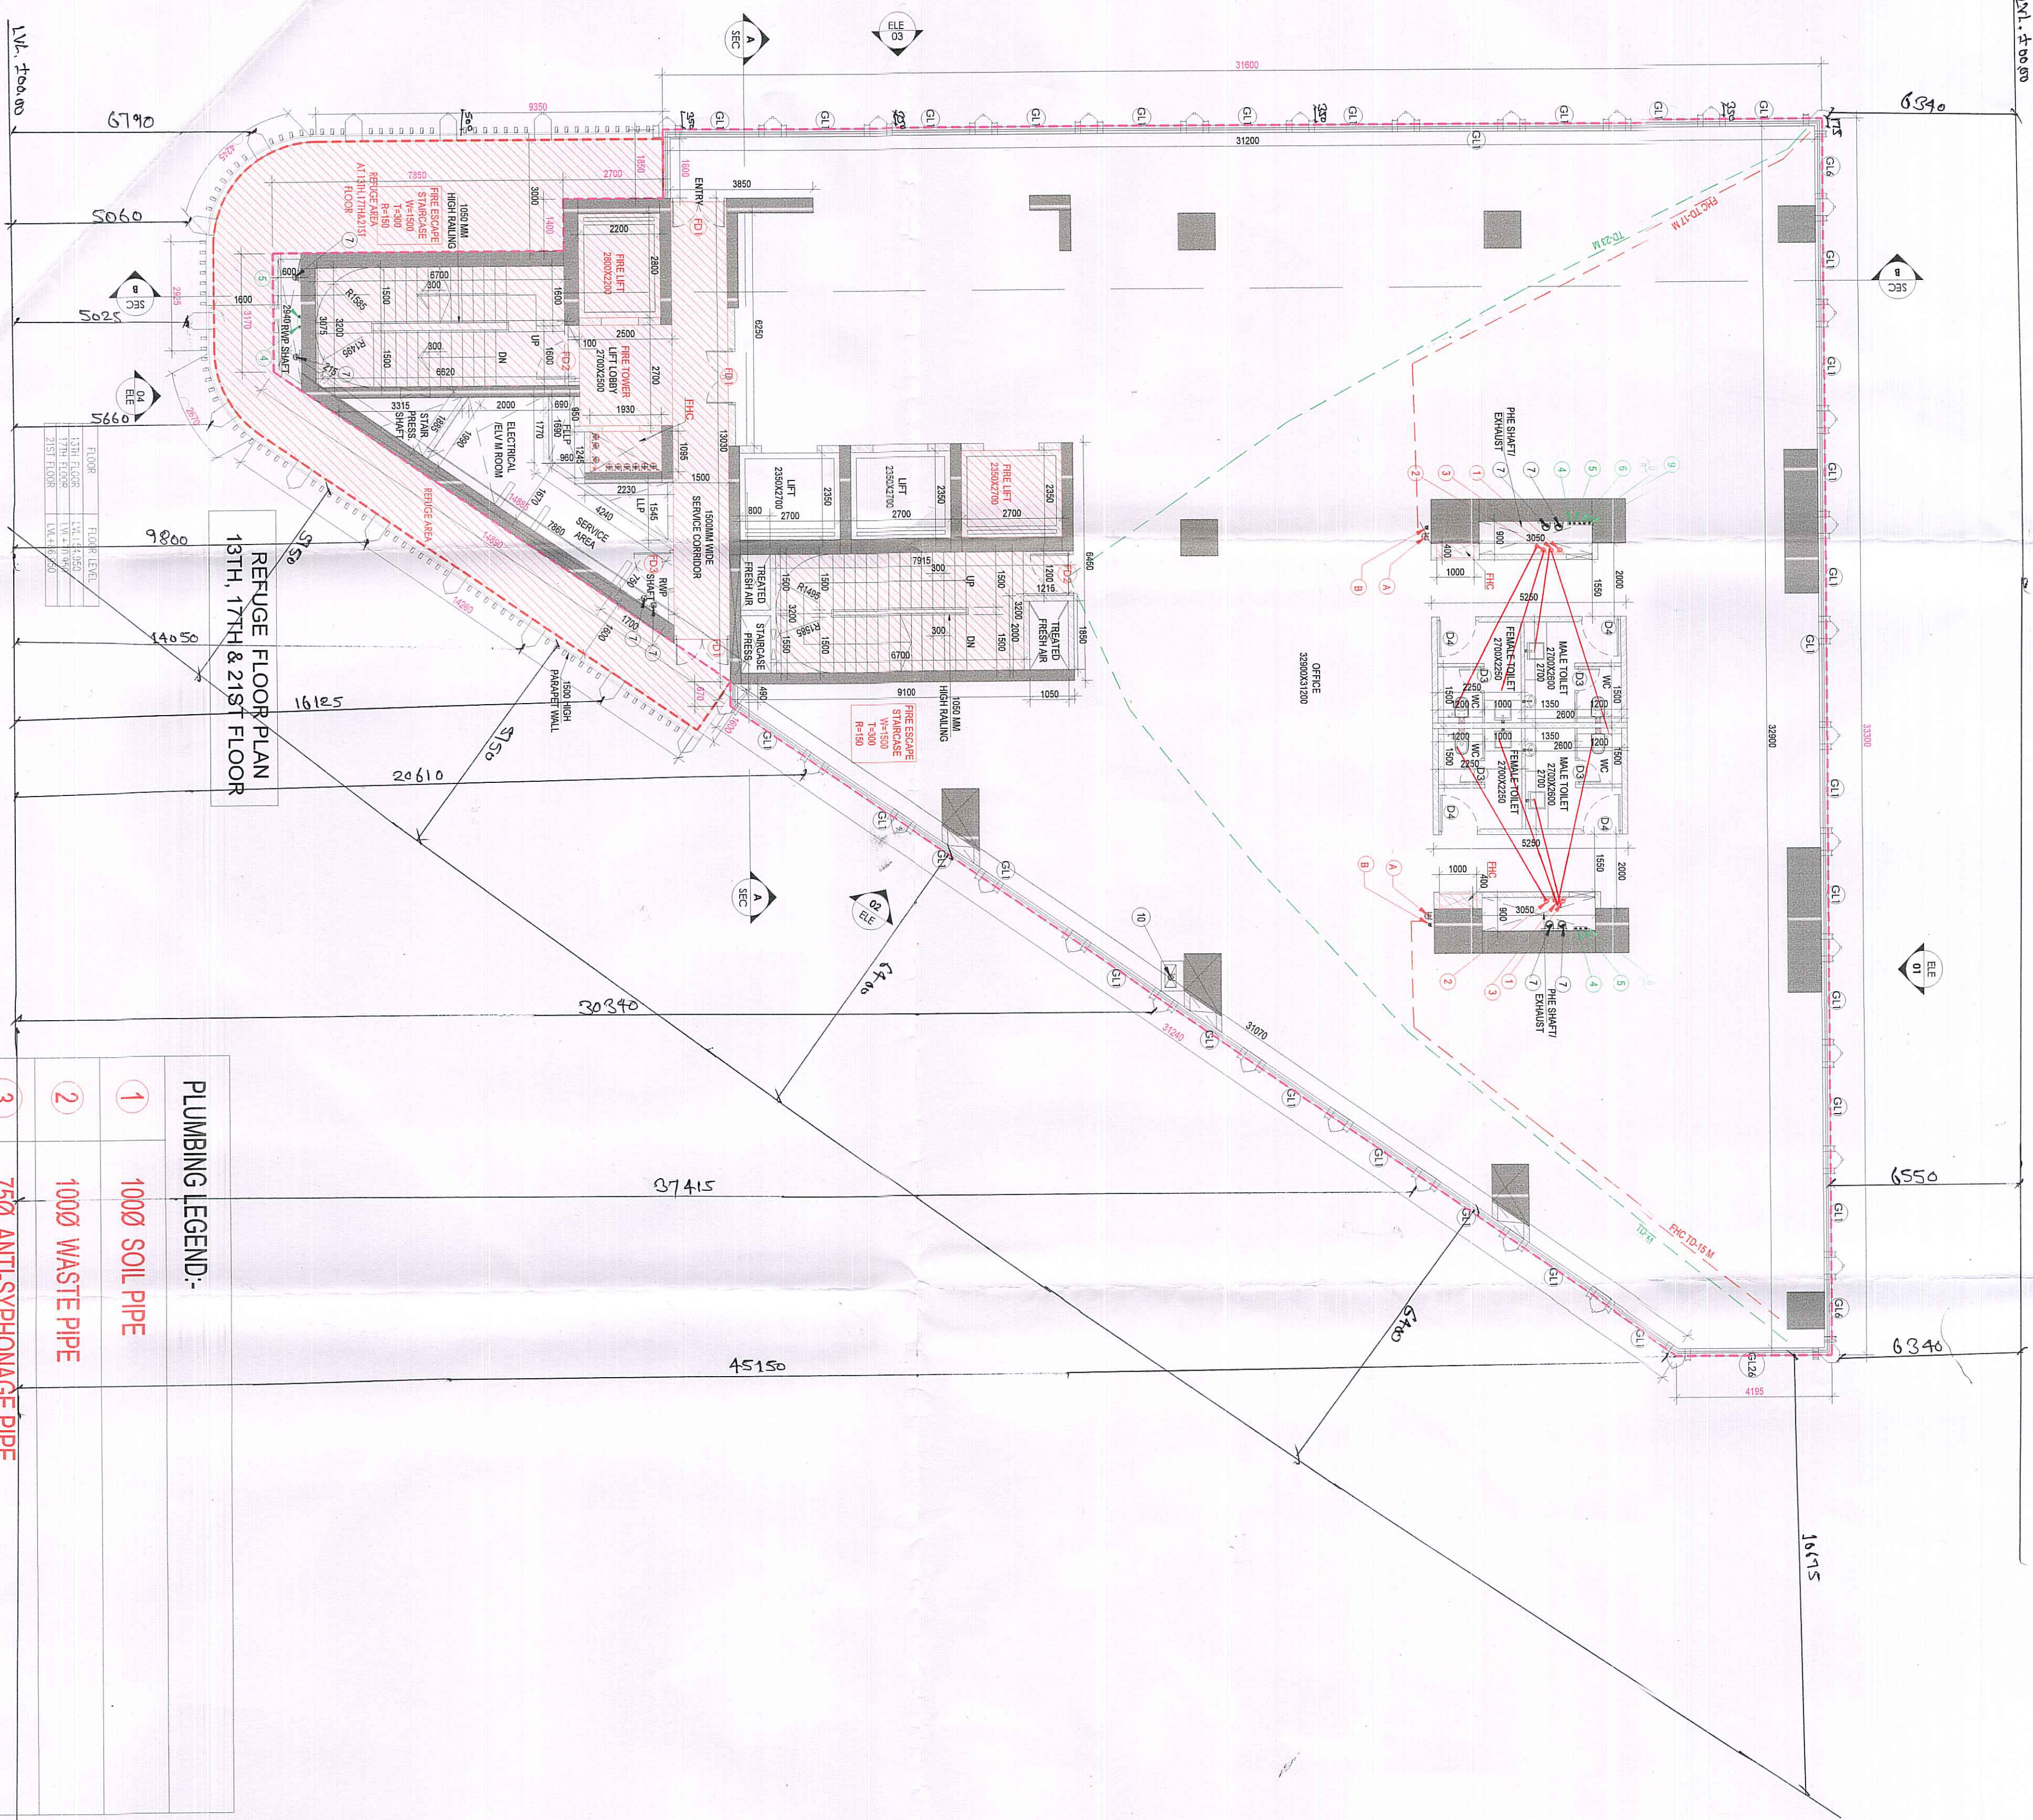

DOORS				DOORWAY	
DOOR	WIDTH	HEIGHT	THICKNESS	DOORWAY	DOORWAY
100	1000	2000	20	MAIN ENTRANCE	DOORWAY
101	1000	2000	20	MAIN ENTRANCE	DOORWAY
102	1000	2000	20	MAIN ENTRANCE	DOORWAY
103	1000	2000	20	MAIN ENTRANCE	DOORWAY
104	1000	2000	20	MAIN ENTRANCE	DOORWAY
105	1000	2000	20	MAIN ENTRANCE	DOORWAY
106	1000	2000	20	MAIN ENTRANCE	DOORWAY
107	1000	2000	20	MAIN ENTRANCE	DOORWAY
108	1000	2000	20	MAIN ENTRANCE	DOORWAY
109	1000	2000	20	MAIN ENTRANCE	DOORWAY
110	1000	2000	20	MAIN ENTRANCE	DOORWAY
111	1000	2000	20	MAIN ENTRANCE	DOORWAY
112	1000	2000	20	MAIN ENTRANCE	DOORWAY
113	1000	2000	20	MAIN ENTRANCE	DOORWAY
114	1000	2000	20	MAIN ENTRANCE	DOORWAY
115	1000	2000	20	MAIN ENTRANCE	DOORWAY
116	1000	2000	20	MAIN ENTRANCE	DOORWAY
117	1000	2000	20	MAIN ENTRANCE	DOORWAY
118	1000	2000	20	MAIN ENTRANCE	DOORWAY
119	1000	2000	20	MAIN ENTRANCE	DOORWAY
120	1000	2000	20	MAIN ENTRANCE	DOORWAY

S.No.	FIRE FIGHTING LEGEND:-
A	1500 M.S FIRE HYDRANT RISER
B	800 M.S DRAIN PIPE
C	1500 M.S SPRINKLER RISER
Ca	1500 M.S SPRINKLER RISER
FHC	FIRE HOSE CABINET

AREA CALCULATION OF
13TH, 17TH & 21ST
REFUGE FLOOR

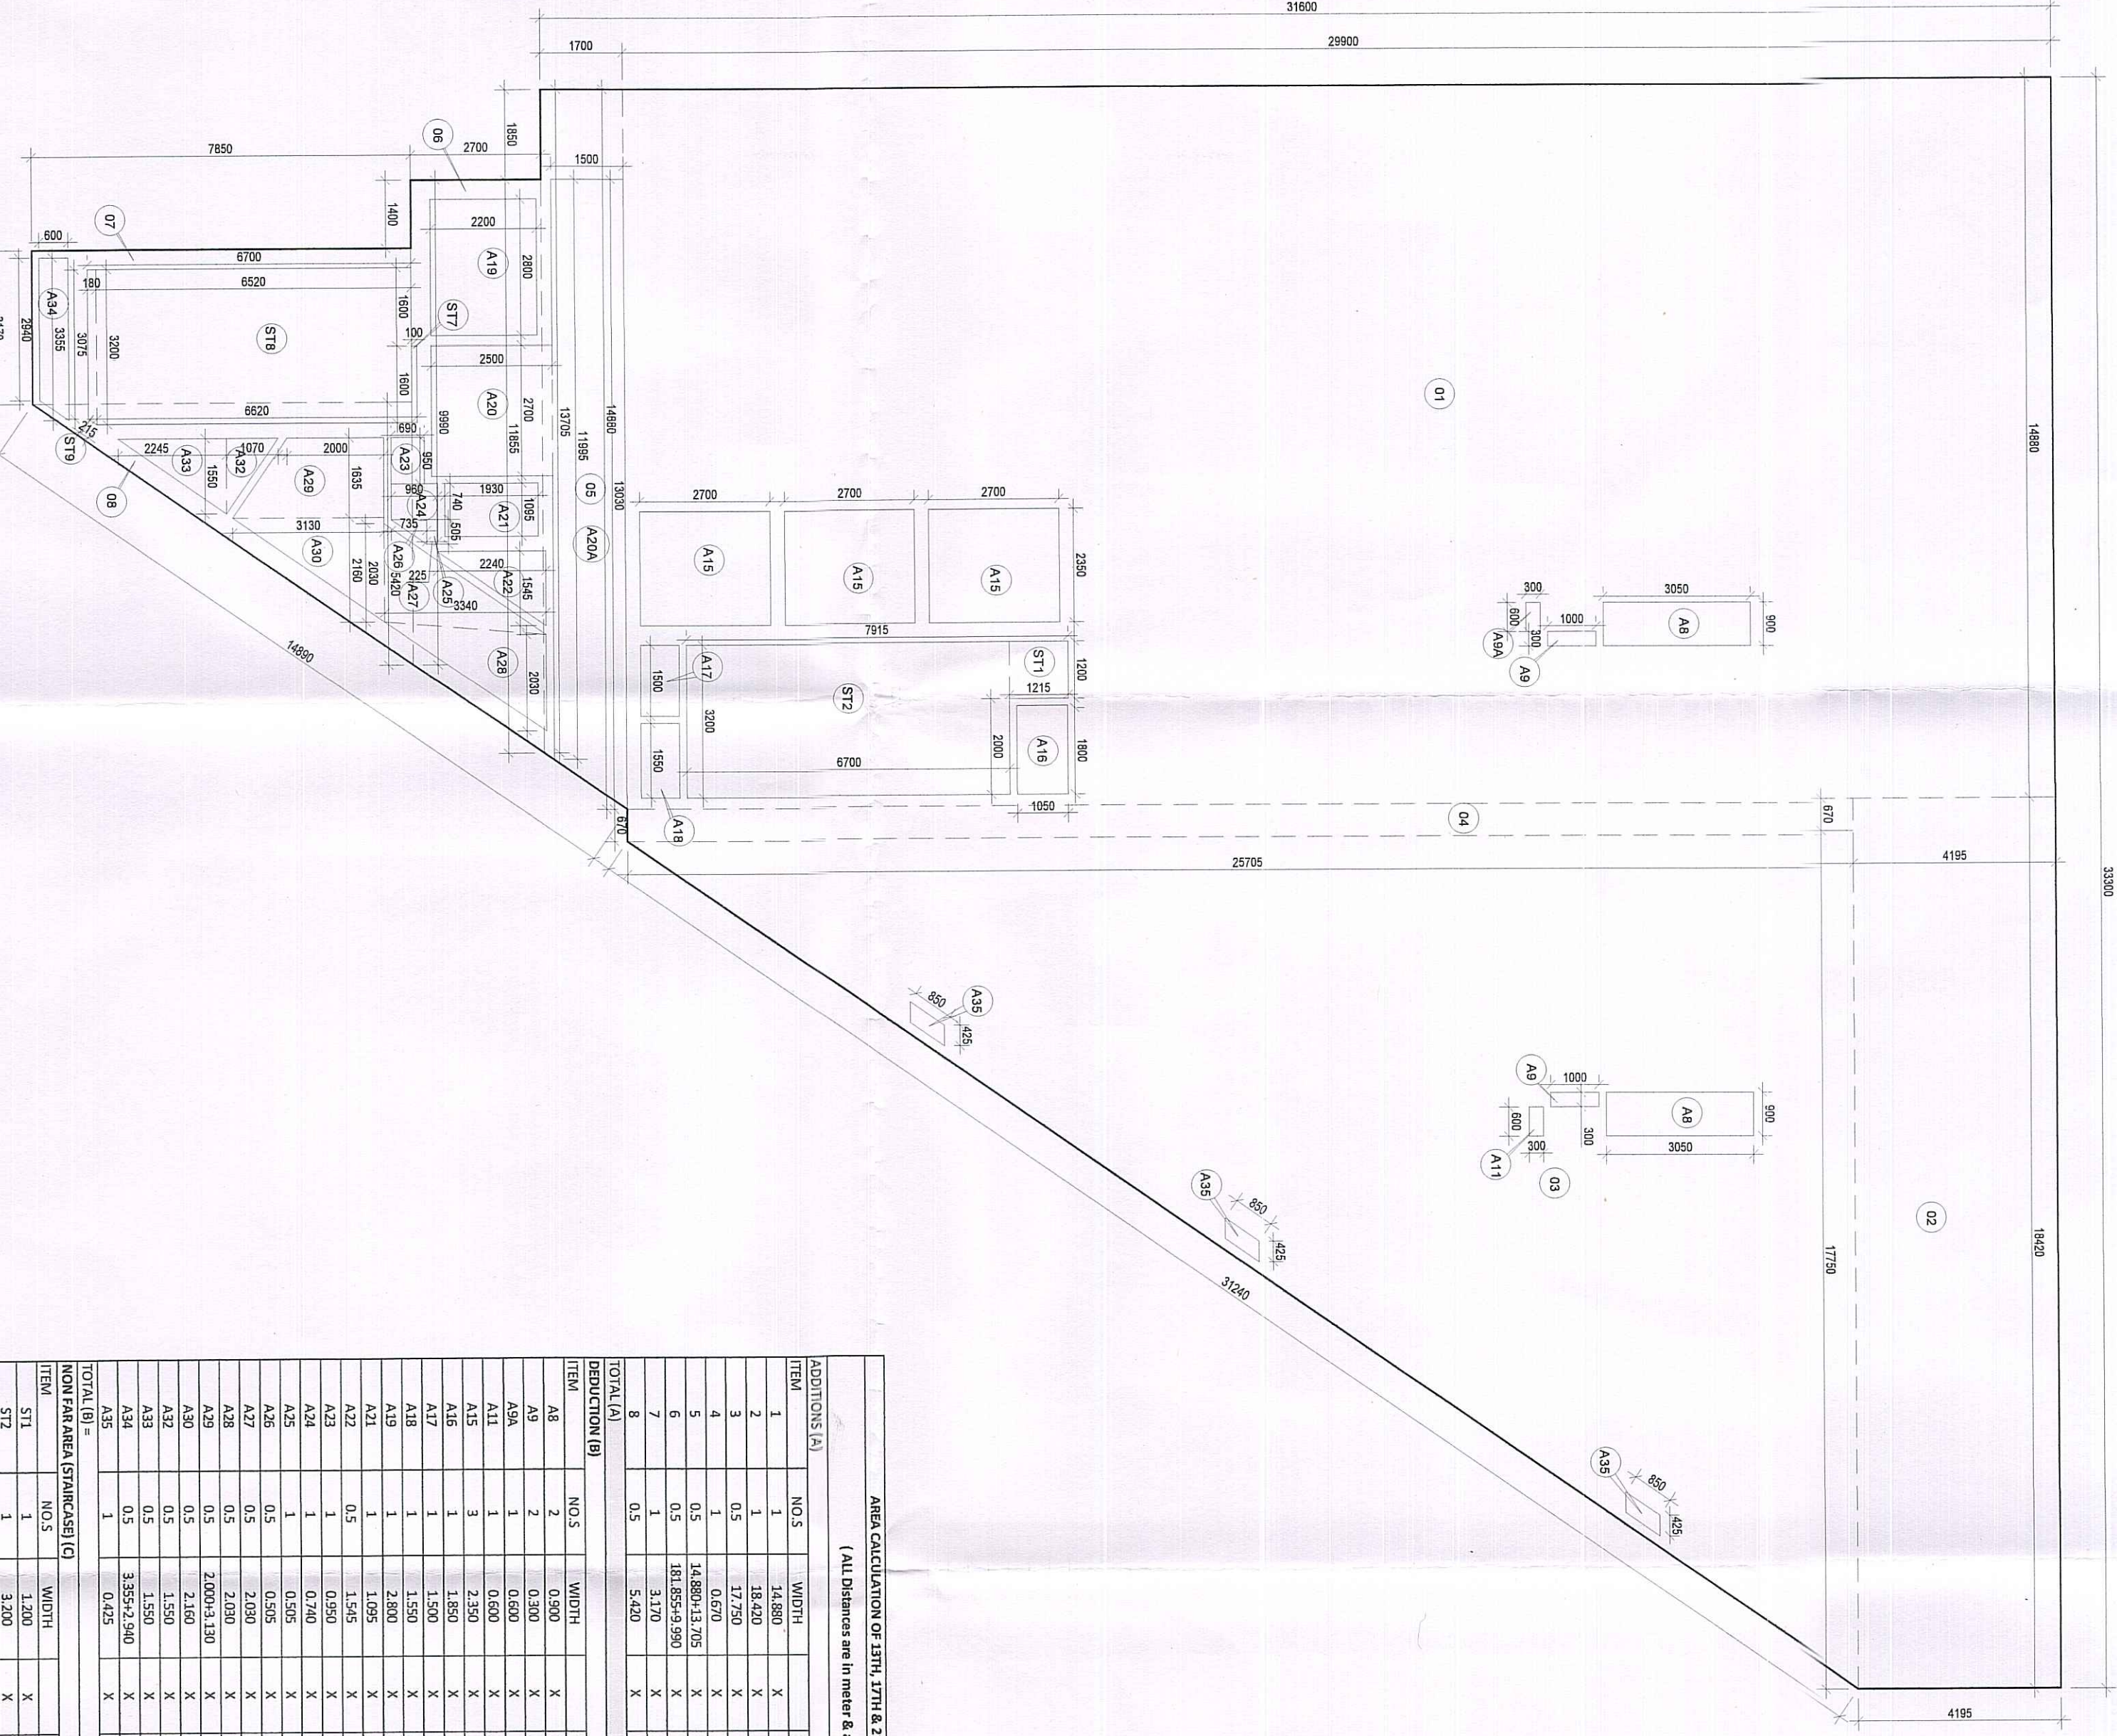

AREA CALCULATION OF 13TH, 17TH & 21ST REFUGE FLOOR			
NO.	DESCRIPTION	AREA (SQ. M)	REMARKS
1	13TH FLOOR	1000.00	
2	17TH FLOOR	1000.00	
3	21ST FLOOR	1000.00	
4	TOTAL	3000.00	

13TH, 17TH & 21ST REFUGE FLOOR AREA			
NO.	DESCRIPTION	AREA (SQ. M)	REMARKS
1	13TH FLOOR	1000.00	
2	17TH FLOOR	1000.00	
3	21ST FLOOR	1000.00	
4	TOTAL	3000.00	

13TH, 17TH & 21ST REFUGE FLOOR AREA			
NO.	DESCRIPTION	AREA (SQ. M)	REMARKS
1	13TH FLOOR	1000.00	
2	17TH FLOOR	1000.00	
3	21ST FLOOR	1000.00	
4	TOTAL	3000.00	

ALL FLOOR MECHANICAL VENTILATED
LIGHTED & 10% POWER BACKUP.
AIR CONDITIONING SYSTEMS BEING PROVIDED
DO POWER BACKUP IS BEING PROVIDED.
TOILET ARE MECHANICAL VENTILATED
ALL LIFT SHALL HAVE MECHANICAL VENTILATION
PER PROVISION OF RELEVANT CODE
FIRE FIGHTING SAFETY PROVISIONS WILL BE
AS PER RELEVANT CODE PROVISIONS.
BASEMENT AREA SHALL HAVE MECHANICAL
VENTILATED AS PER RELEVANT CODE
ALL TOILETS ARE VENTILATED AS PER
HARYANA BUILDING CODE 2017.
BUILDINGS HAS AUTOMATIC SPRINKLER
SYSTEM WHEREVER REQUIRED BY RELEVANT
CODE. BUILDING WILL BE DESIGNED
(STRUCTURES) AS PER RELEVANT
IS CODES FOR EARTHQUAKE RESISTANCE.
SOLAR PANELS OF REQUIRED CAPACITY SHALL
BE PROVIDED AS PER FRAME DRAINING
NORMS.
WATER TANKS CAPACITY WITH RAINING
ALL FIRE FIGHTING INSTALLATIONS SHALL BE
AS PER PROVISION OF RELEVANT CODE
THE RAINWATER HARVESTING SYSTEM SHALL
BE PROVIDED AS PER CENTRAL GROUND
WATER AUTHORITY NORMS.

PROPOSED BUILDING PLAN OF COMMERCIAL
COMPLEX SITE AREA 1.186 ACRES
(4843.03 SQM) IN SECTOR 28, GURURAM

OWNER'S
ACQUISITIVE INFRADEVELOPERS PVT. LTD.
WITH LOUDA DEVELOPERS LIMITED
for Developing Engineers (Pvt)
HARYANA

OWNER'S SEAL
& SIGNATURE
For Kishore Kumar Singh
Authorized Signatory
Kishore Kumar Singh
Member
BPMC

ARCHITECT'S SEAL
& SIGNATURE
Kishore Kumar Singh
Member
BPMC

Scale - 1:100
Drawing No -
TOWER 01
REFUGE FLOOR PLAN
& AREA CALCULATION
1-10
DTP: P. K. Singh
Member
BPMC
DTP: P. K. Singh
Member
BPMC