



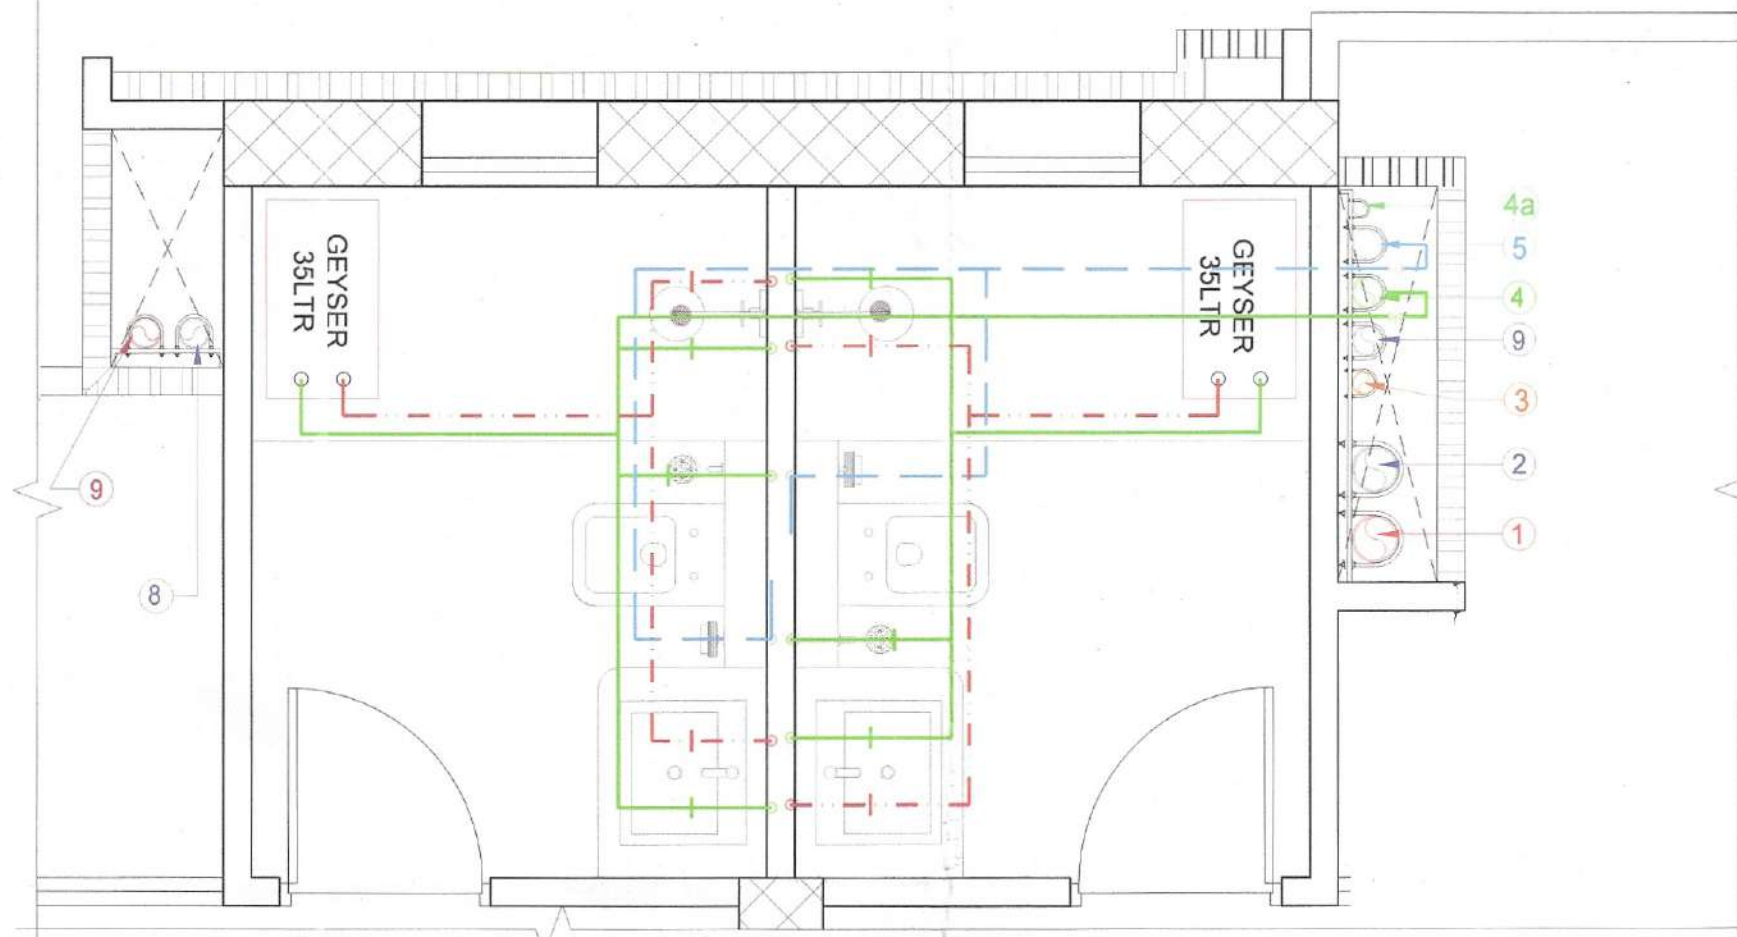


TOILET-T2 & T3 DETAIL FOR
WATER SUPPLY

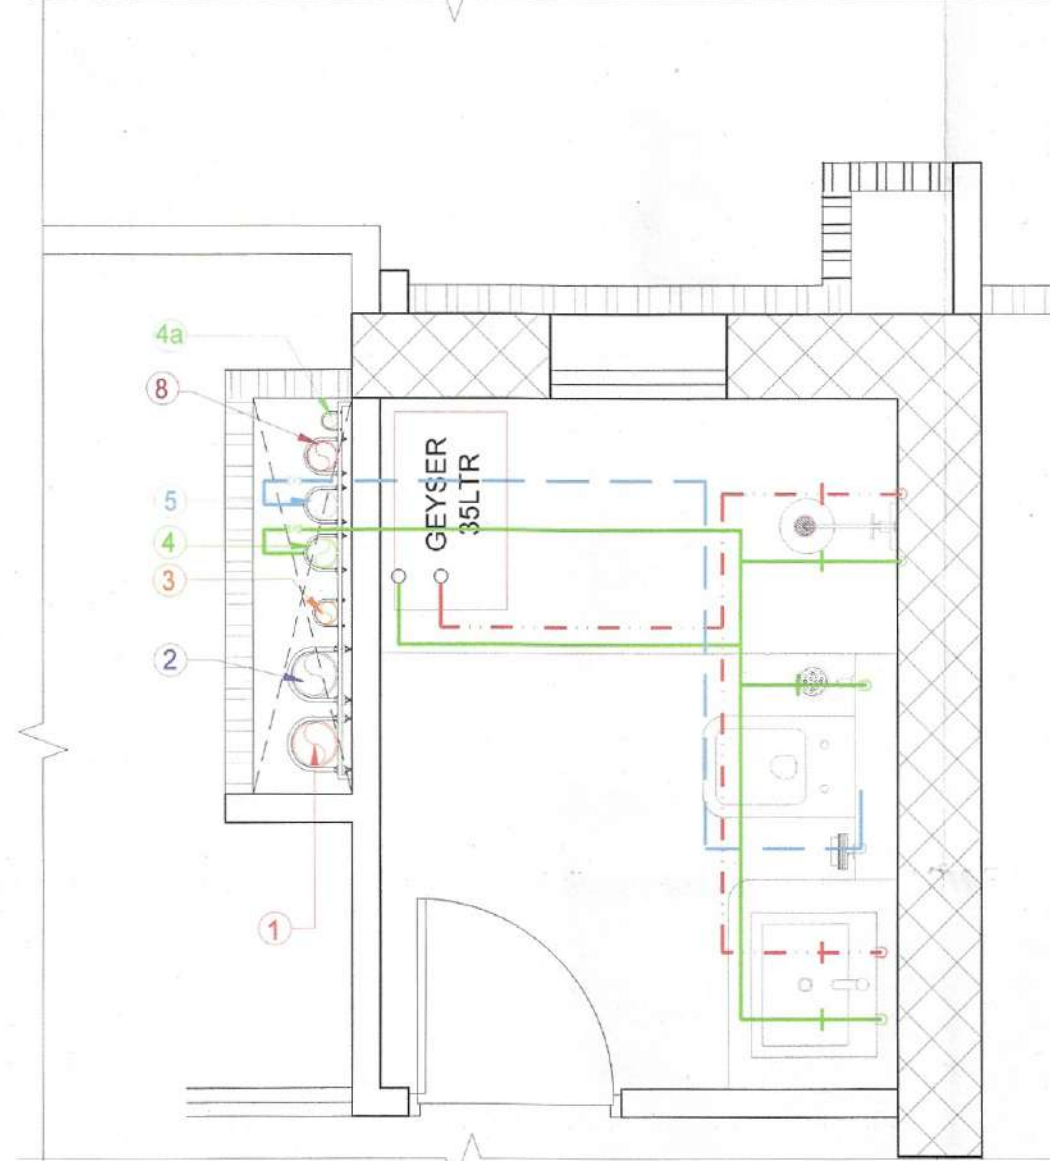


TOILET-T4 DETAIL FOR
WATER SUPPLY




TOILET-T1 DETAIL FOR
WATER SUPPLY

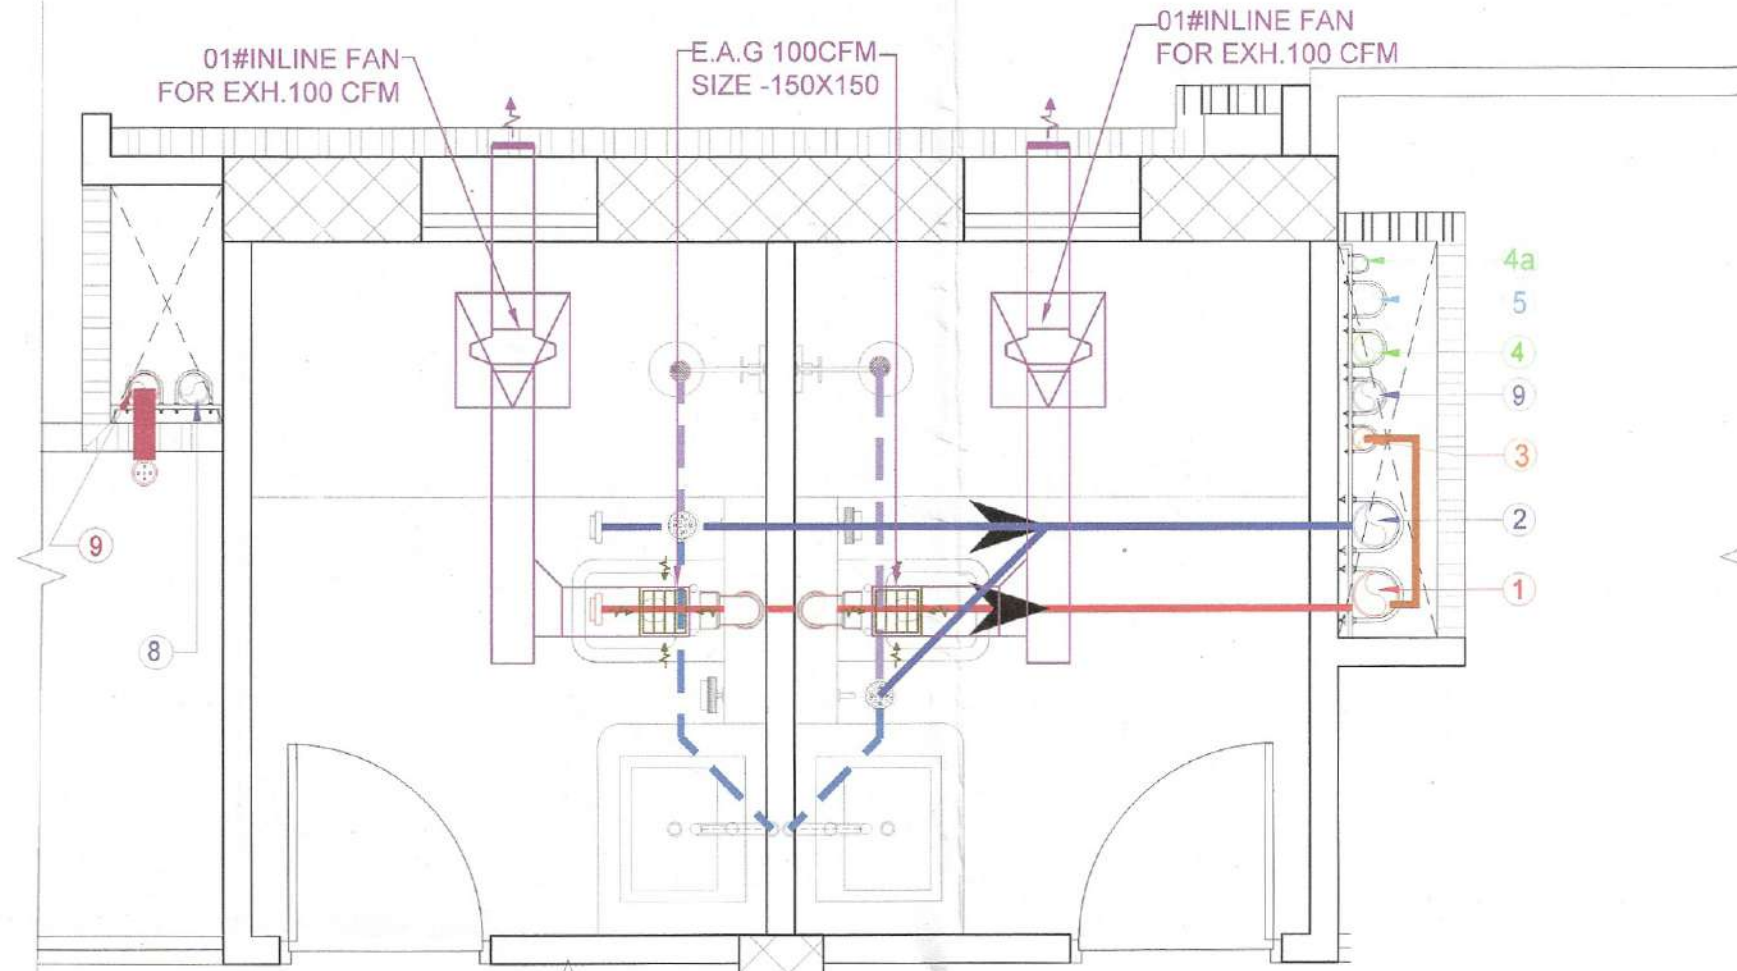

TOILET-T2 & T3 DETAIL FOR
DRAINAGE & VENT SYSTEM

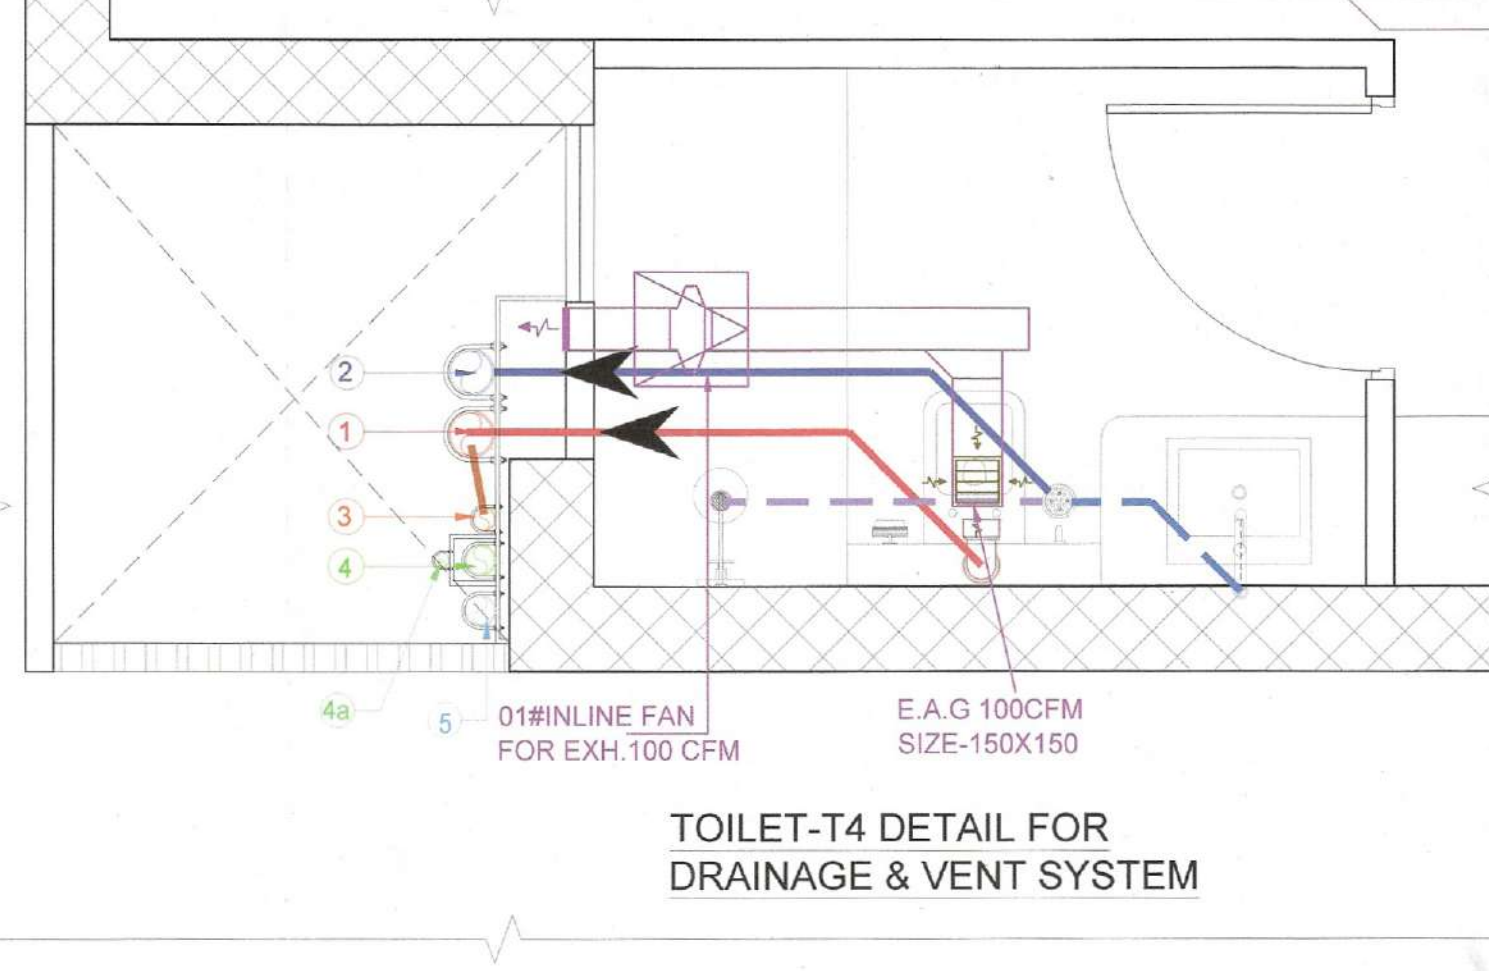

TOILET-T4 DETAIL FOR
DRAINAGE & VENT SYSTEM

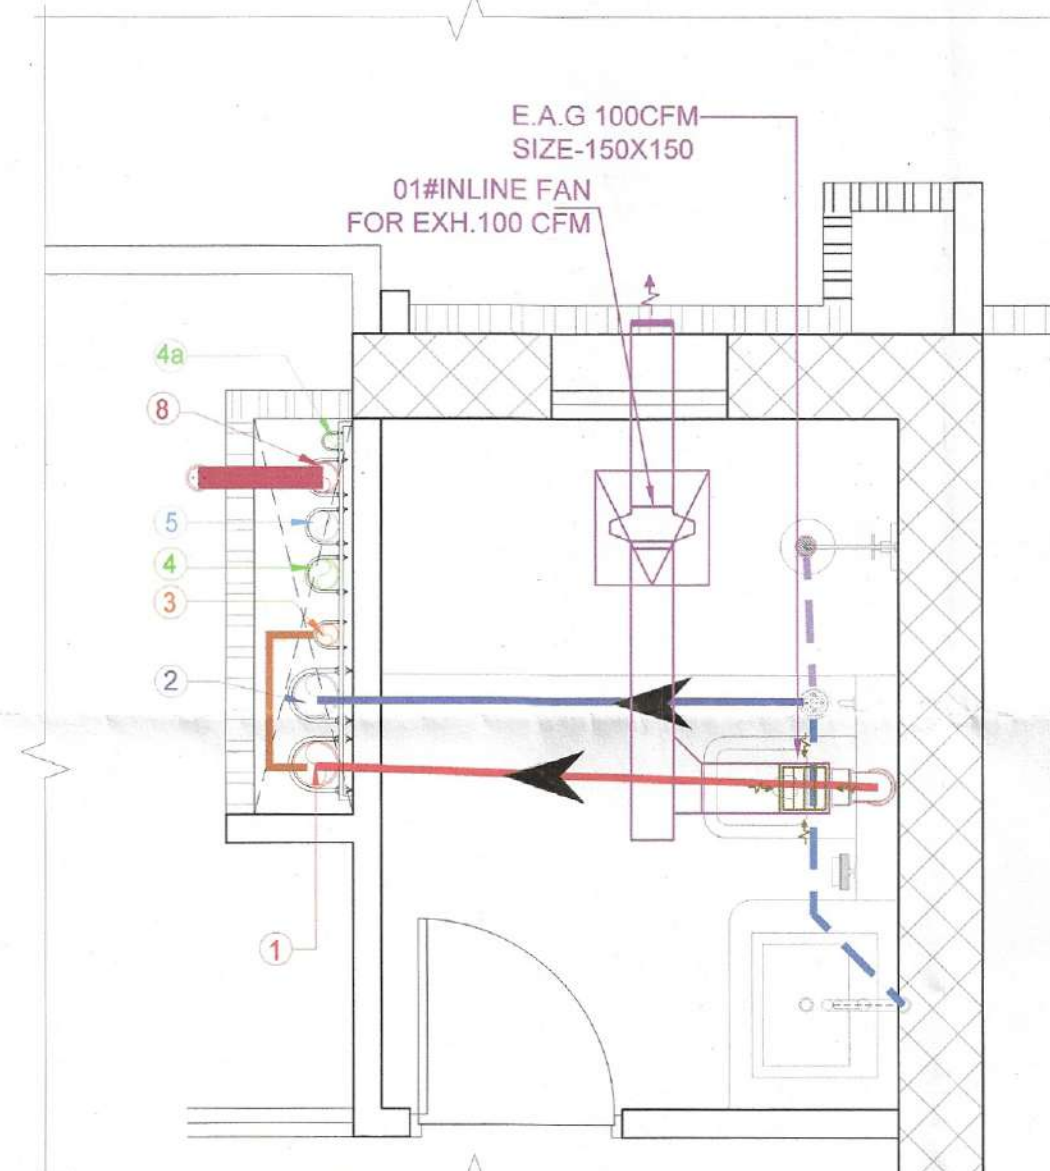

TOILET-T1 DETAIL FOR
DRAINAGE & VENT SYSTEM

PLUMBING LEGEND:

S NO	SYMBOLS	DESCRIPTION
1	1"	100 OD SOIL VERTICAL PIPE
2	2"	100 OD WASTE VERTICAL PIPE
3	3"	750 VENT PIPE VERTICAL PIPE
4	4"	DOMESTIC WATER VERTICAL PIPE
5	4a"	DOMESTIC WATER VERTICAL PIPE TOP 3 FLOOR
6	5"	FLUSHING WATER VERTICAL PIPE
7	6"	DOMESTIC WATER RISER VERTICAL PIPE
8	7"	FLUSHING WATER RISER VERTICAL PIPE
9	8"	110 OD BALCONY VERTICAL DRAIN PIPE
10	9"	110 OD RAIN WATER VERTICAL PIPE
11	10"	100 OD KITCHEN WASTE VERTICAL PIPE
12	11"	110 OD BASEMENT DRAIN VERTICAL PIPE
13	FT	FLOOR TRAP
14	BD	BALCONY DRAIN
15	FD	FLOOR DRAIN
16	GOP	CLEAN OUT PLUG
17	1"	110 OD SOIL PIPE
18	2"	110 OD WASTE PIPE
19	3"	110 OD RAIN WATER PIPE
20	4"	100 OD KITCHEN WASTE PIPE
21	4a"	DOMESTIC WATER SUPPLY PIPE
22	5"	FLUSHING WATER SUPPLY PIPE
23	6"	HOT WATER SUPPLY PIPE
24	7"	40 OD WASTE PIPE
25	8"	50 OD WASTE PIPE
26	9"	75 OD BALCONY PIPE
27	10"	750 VENT PIPE
28	11"	KHURRA
29	FT & WC	CUTOUT SIZE 150mmX150mm
30	REQ.	PLUMBING SHAFT
31	REQ.	LEDGE WALL
32		


Williams S.T.P. (HQ) S.T.P. (G) C.T.P. (HR)
Member Secretary Member Chairman
B.P.A.C. B.P.A.C. B.P.A.C.

DTP (HQ) ATP (HQ)

AD SD PA A.T.P.

DINES KUMAR PA (HQ) JDA (T) MEMBER BPAC

SANCTIONED
TO BE READ WITH THIS OFFICE
MEMO NO.: 47831
DATED: 17/12/2025

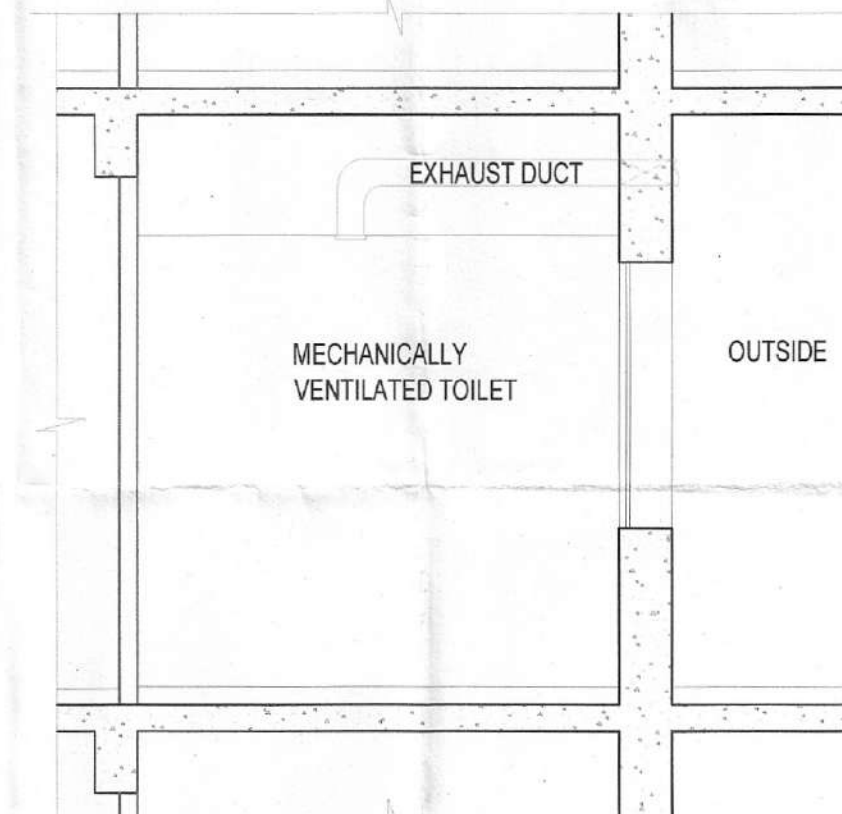

TYPICAL TOILET VENTILATION SECTION

PROJECT:
PROPOSED BUILDING PLANS FOR
RESIDENTIAL COLONY UNDER NEW
INTEGRATED LICENSING
POLICY-2022, AREA MEASURING
20.625 ACRES (LICENSE NO-121 OF
2025 DATED 17.07.2025) IN THE
REVENUE ESTATE OF VILLAGE
SHIKHOPUR IN SECTOR-78,
DISTRICT - GURUGRAM

OWNER:
DVOK BUILDCON LLP
224, 2ND FLOOR, SUNCITY
BUSINESS TOWER, GOLF COURSE
ROAD GURUGRAM, HARYANA


ARCHITECTS:
VASTUKRITI
B-403, 2ND FLOOR, SAFARILANG
ENCLAVE, NEW DELHI-110029
email: vastukriti@gmail.com
tel: 91-11-26161242

OWNER'S SIGNATURE:
DVOK BUILDCON LLP


ARCHITECT'S SIGNATURE:
ROHIT JAIN
Reg. No. CA/88/11424

DRAWING TITLE
'CROWN' TOWER-
KITCHEN & TOILET
DETAILS


DATE: 02.08.2025 DRG. NO.:
SCALE: 1:25 @ A1
DEALT: NEHA 19

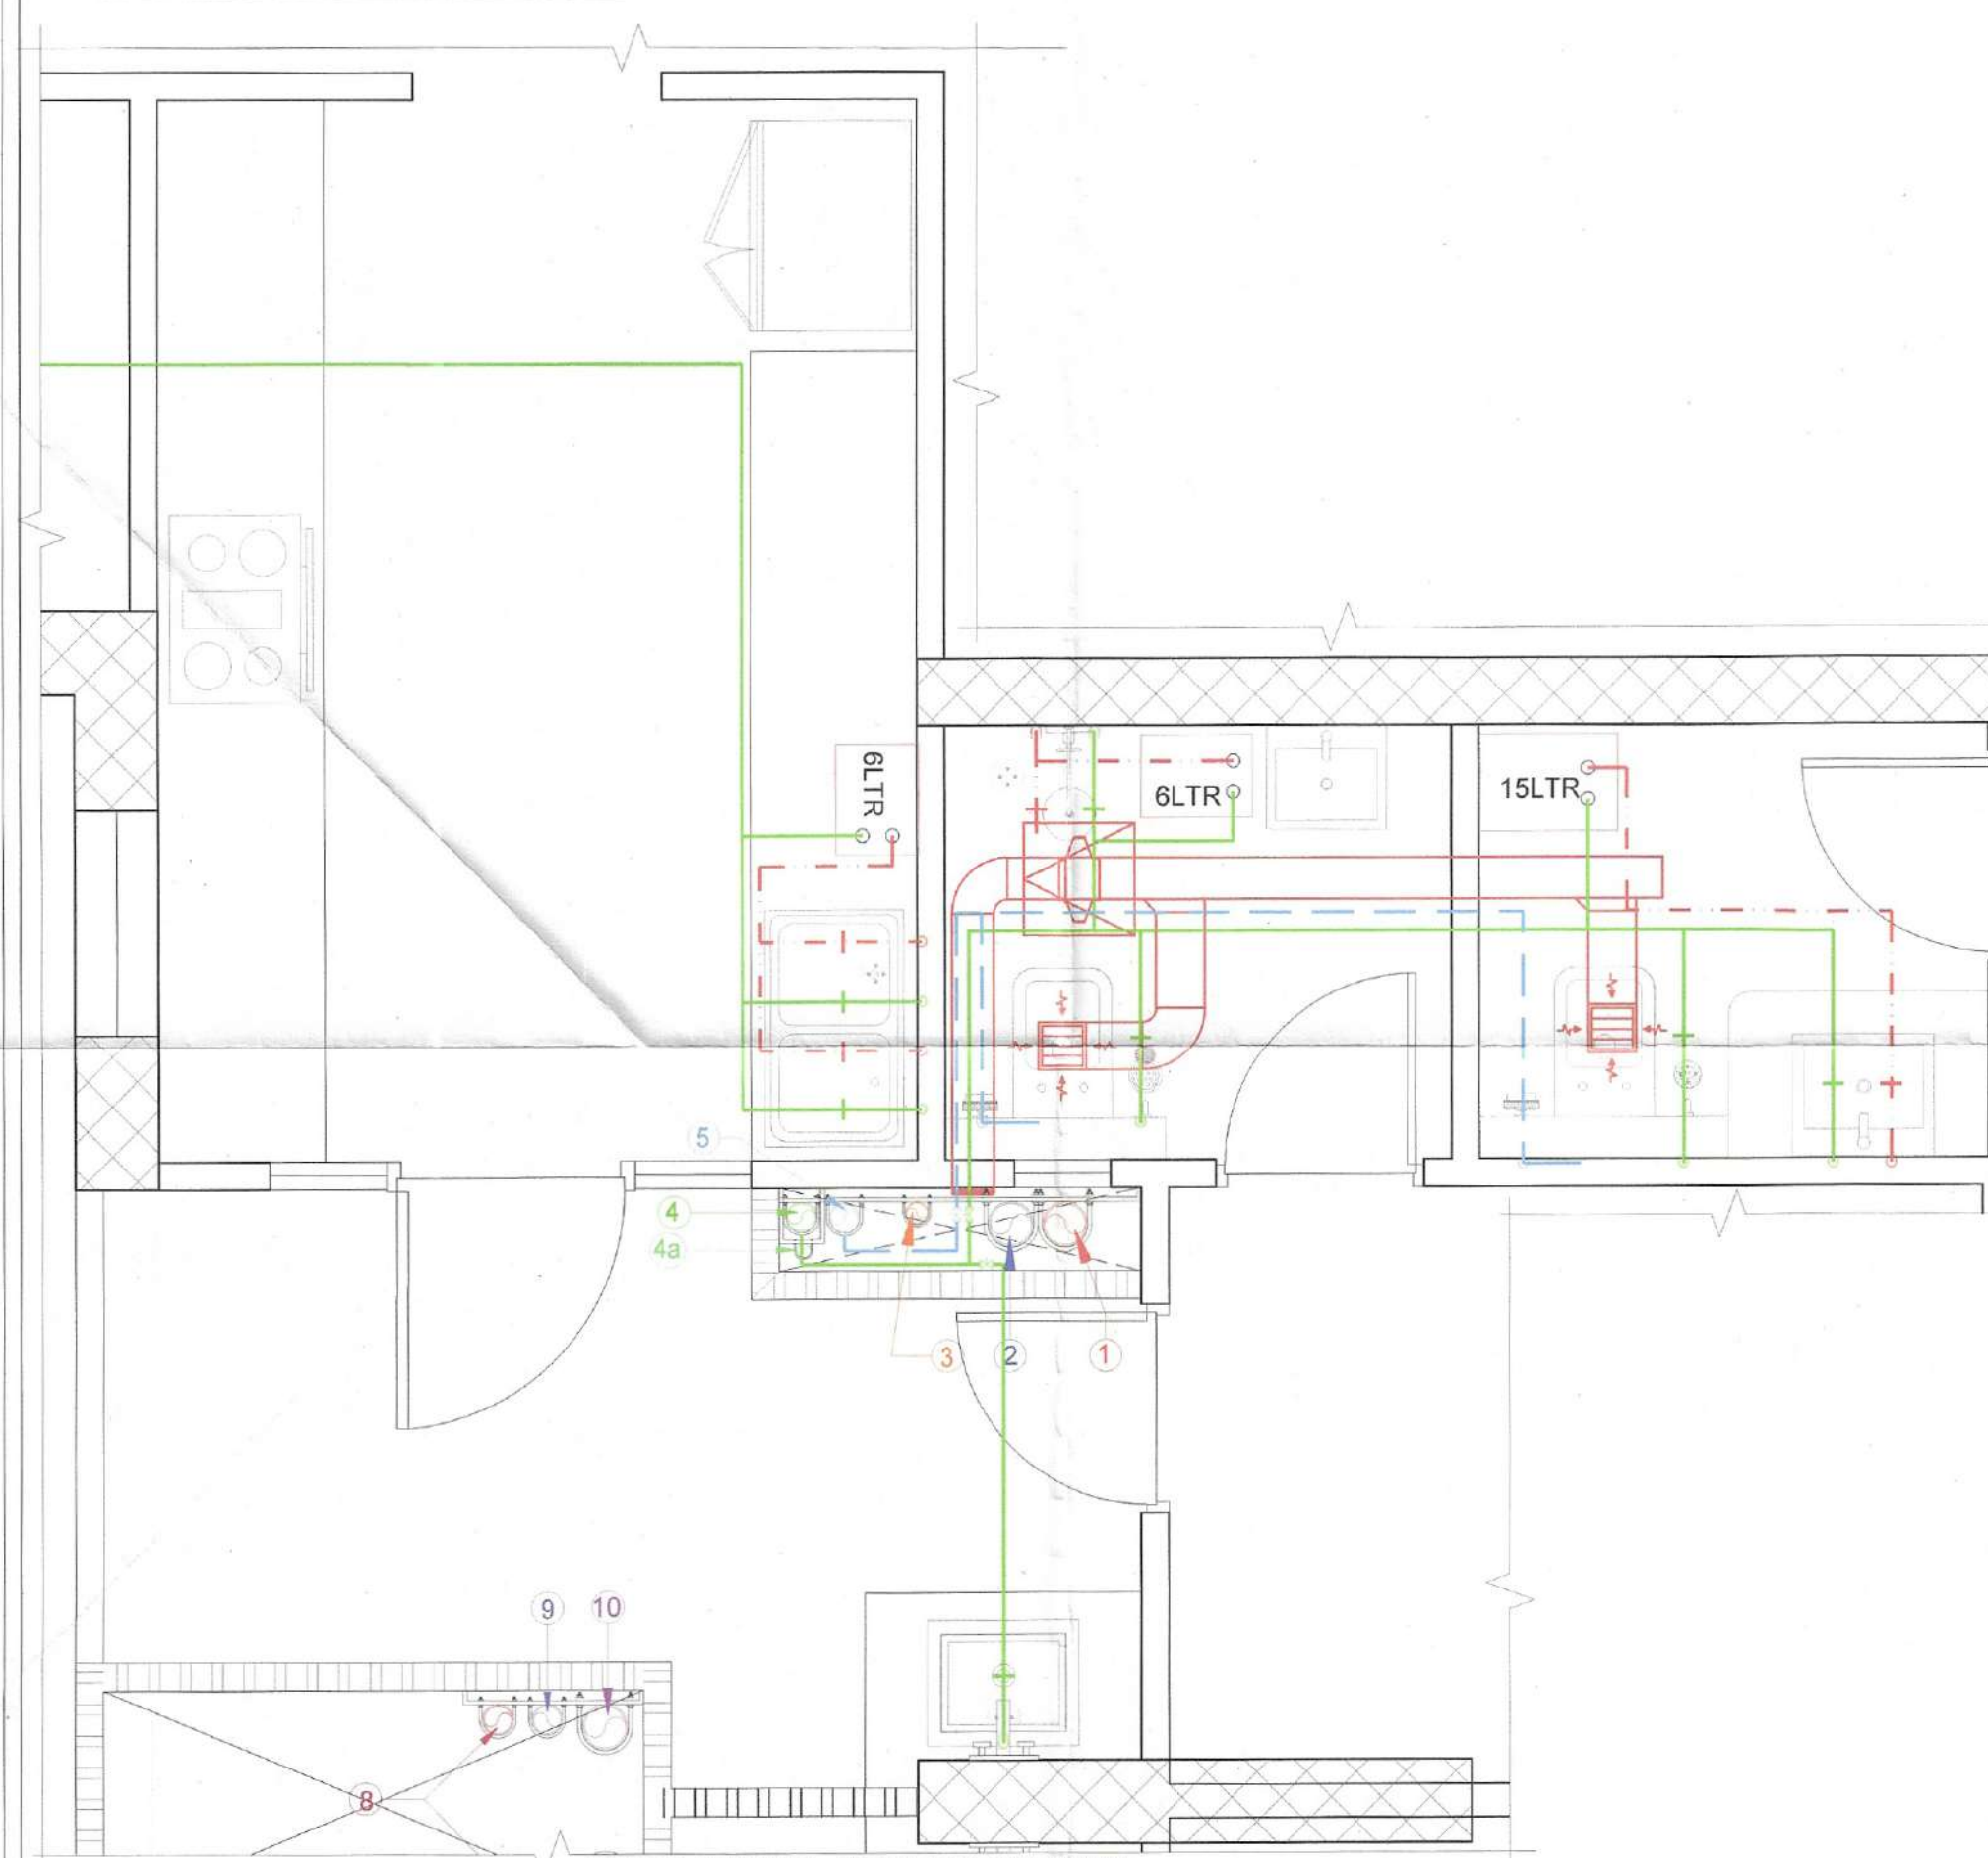

KITCHEN-K1, TOILET-T5 & T6
DETAIL FOR WATER SUPPLY

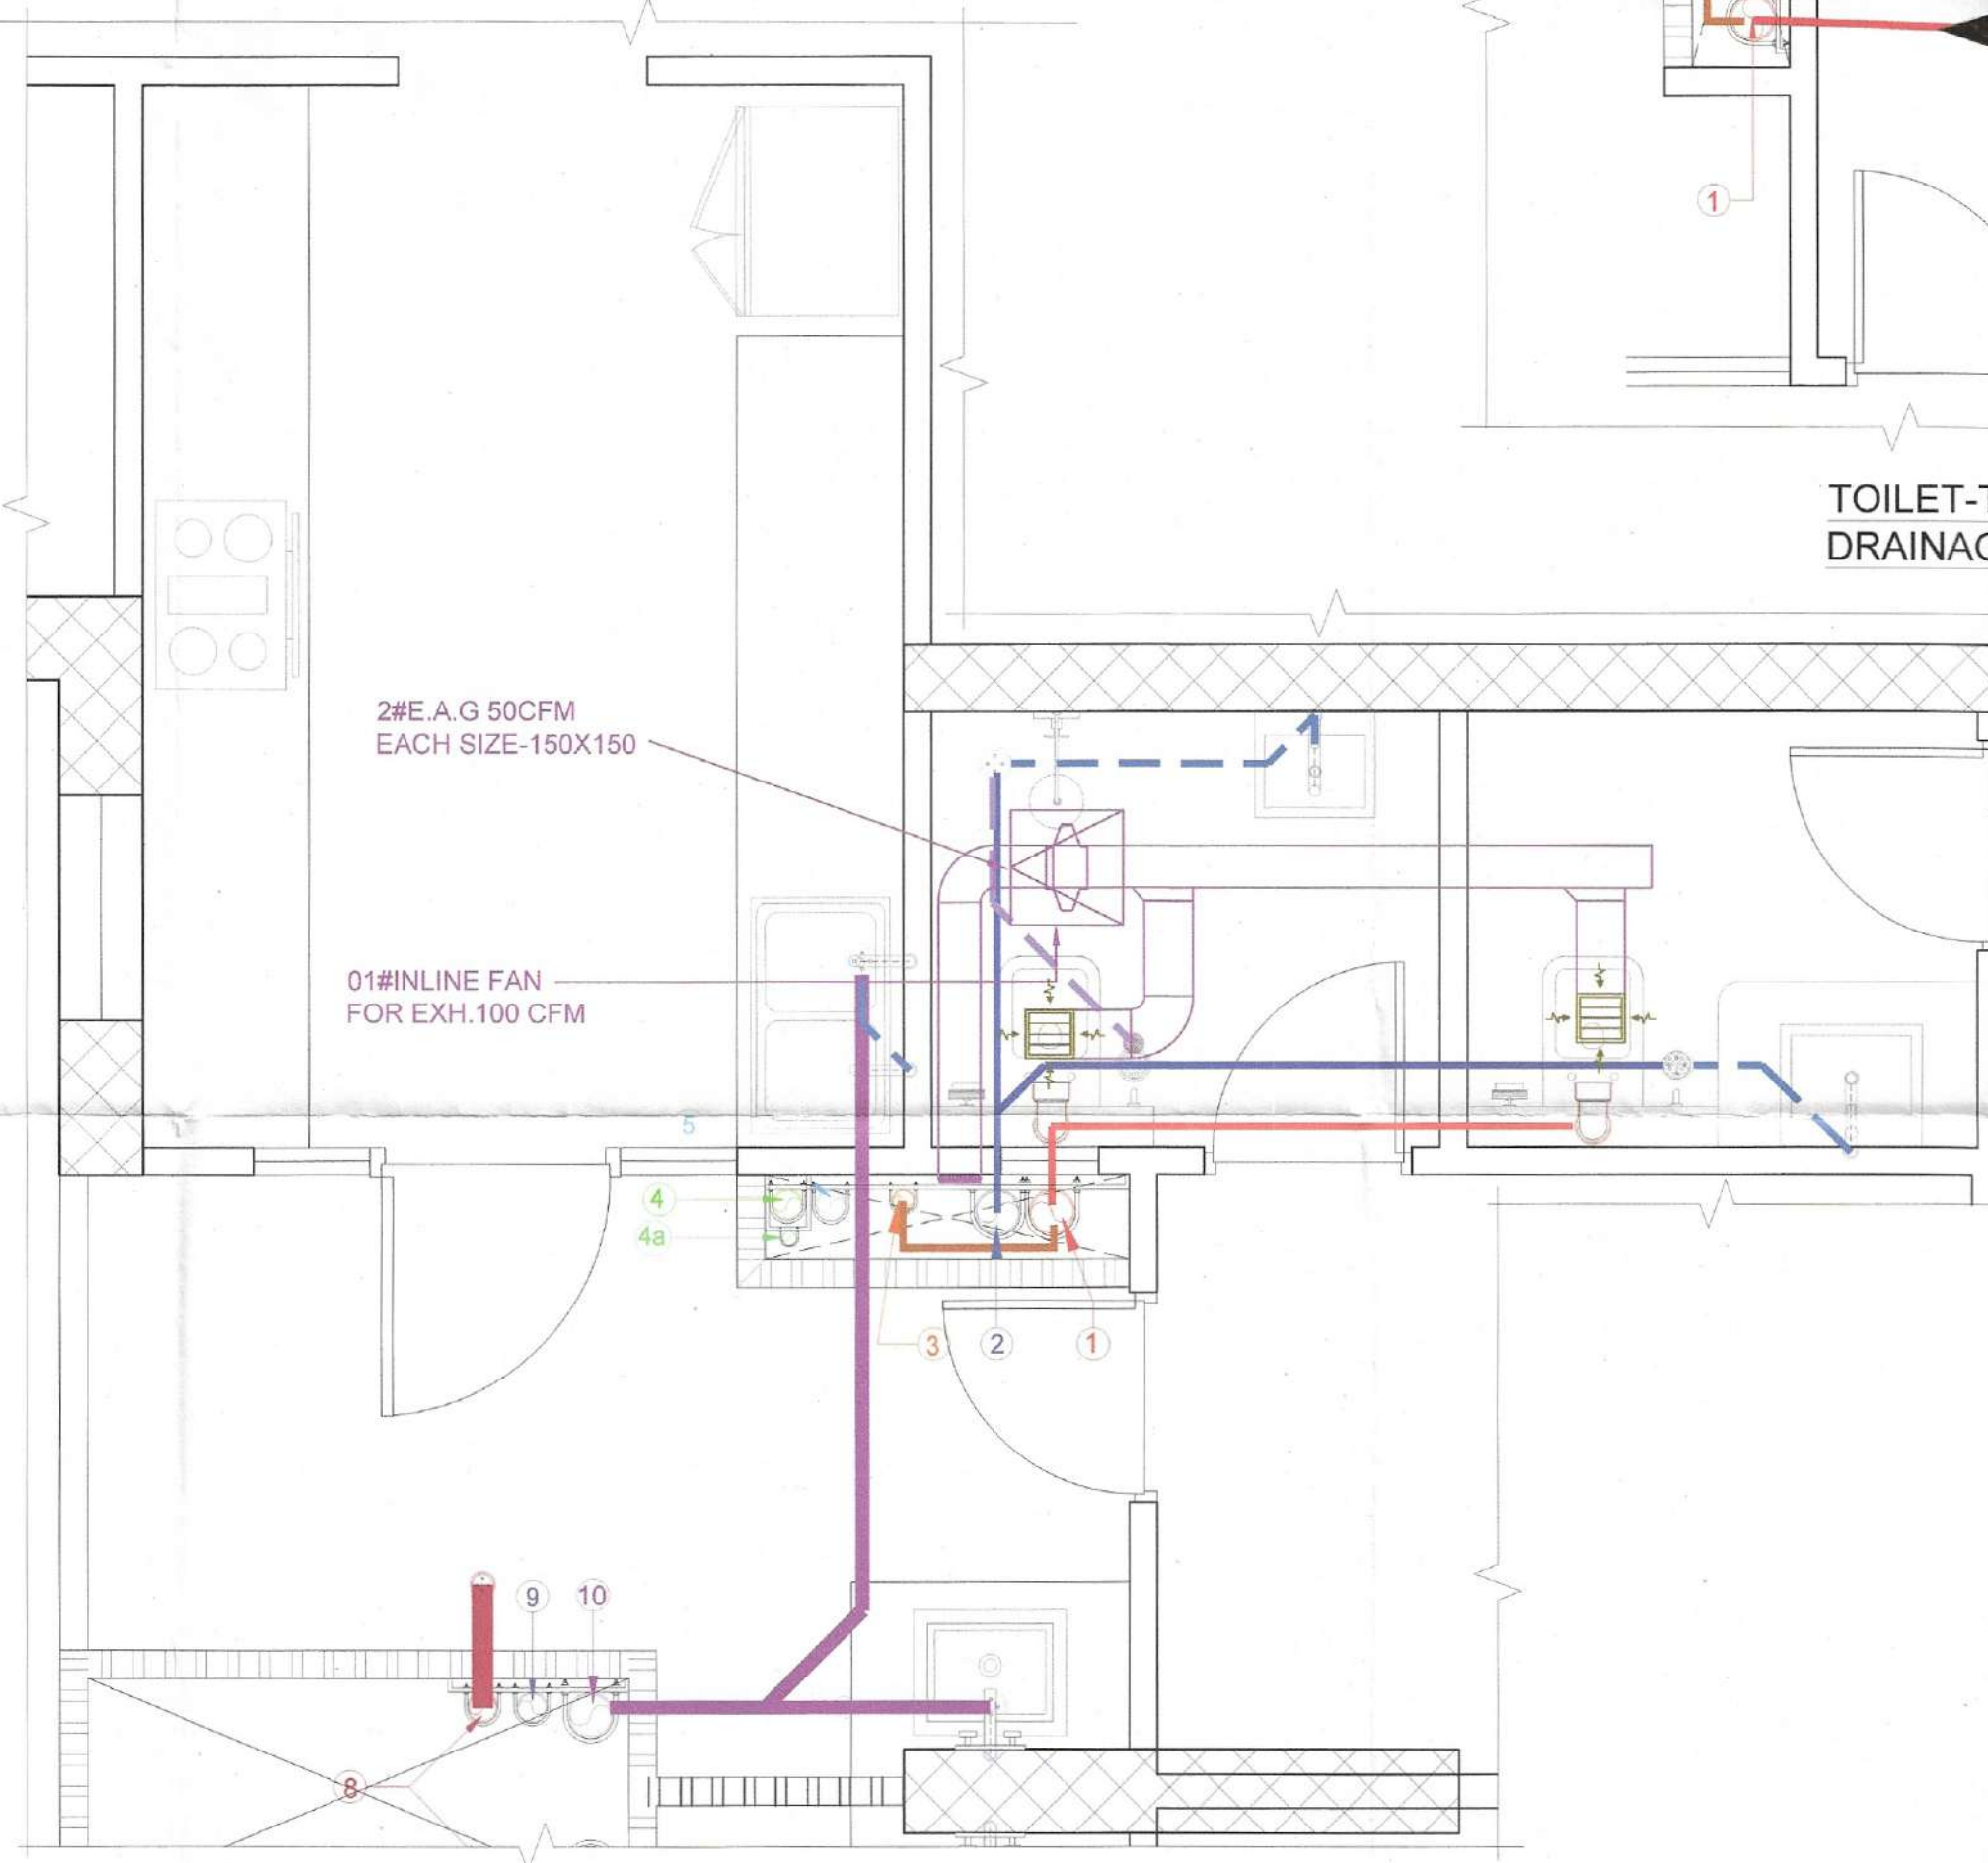

KITCHEN-K1, TOILET-T5 & T6
DETAIL FOR DRAINAGE & VENT SYSTEM

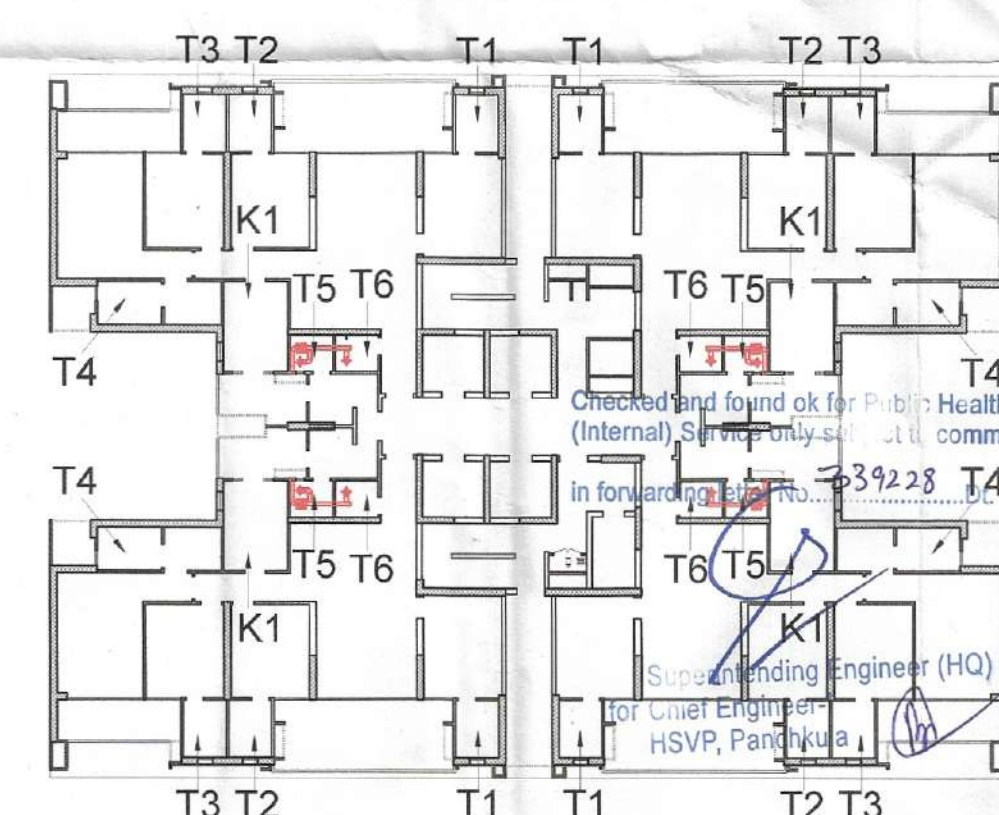

KITCHEN & TOILET DETAILS KEY PLAN