


REVENUE RASTA

24 M WIDE ROAD

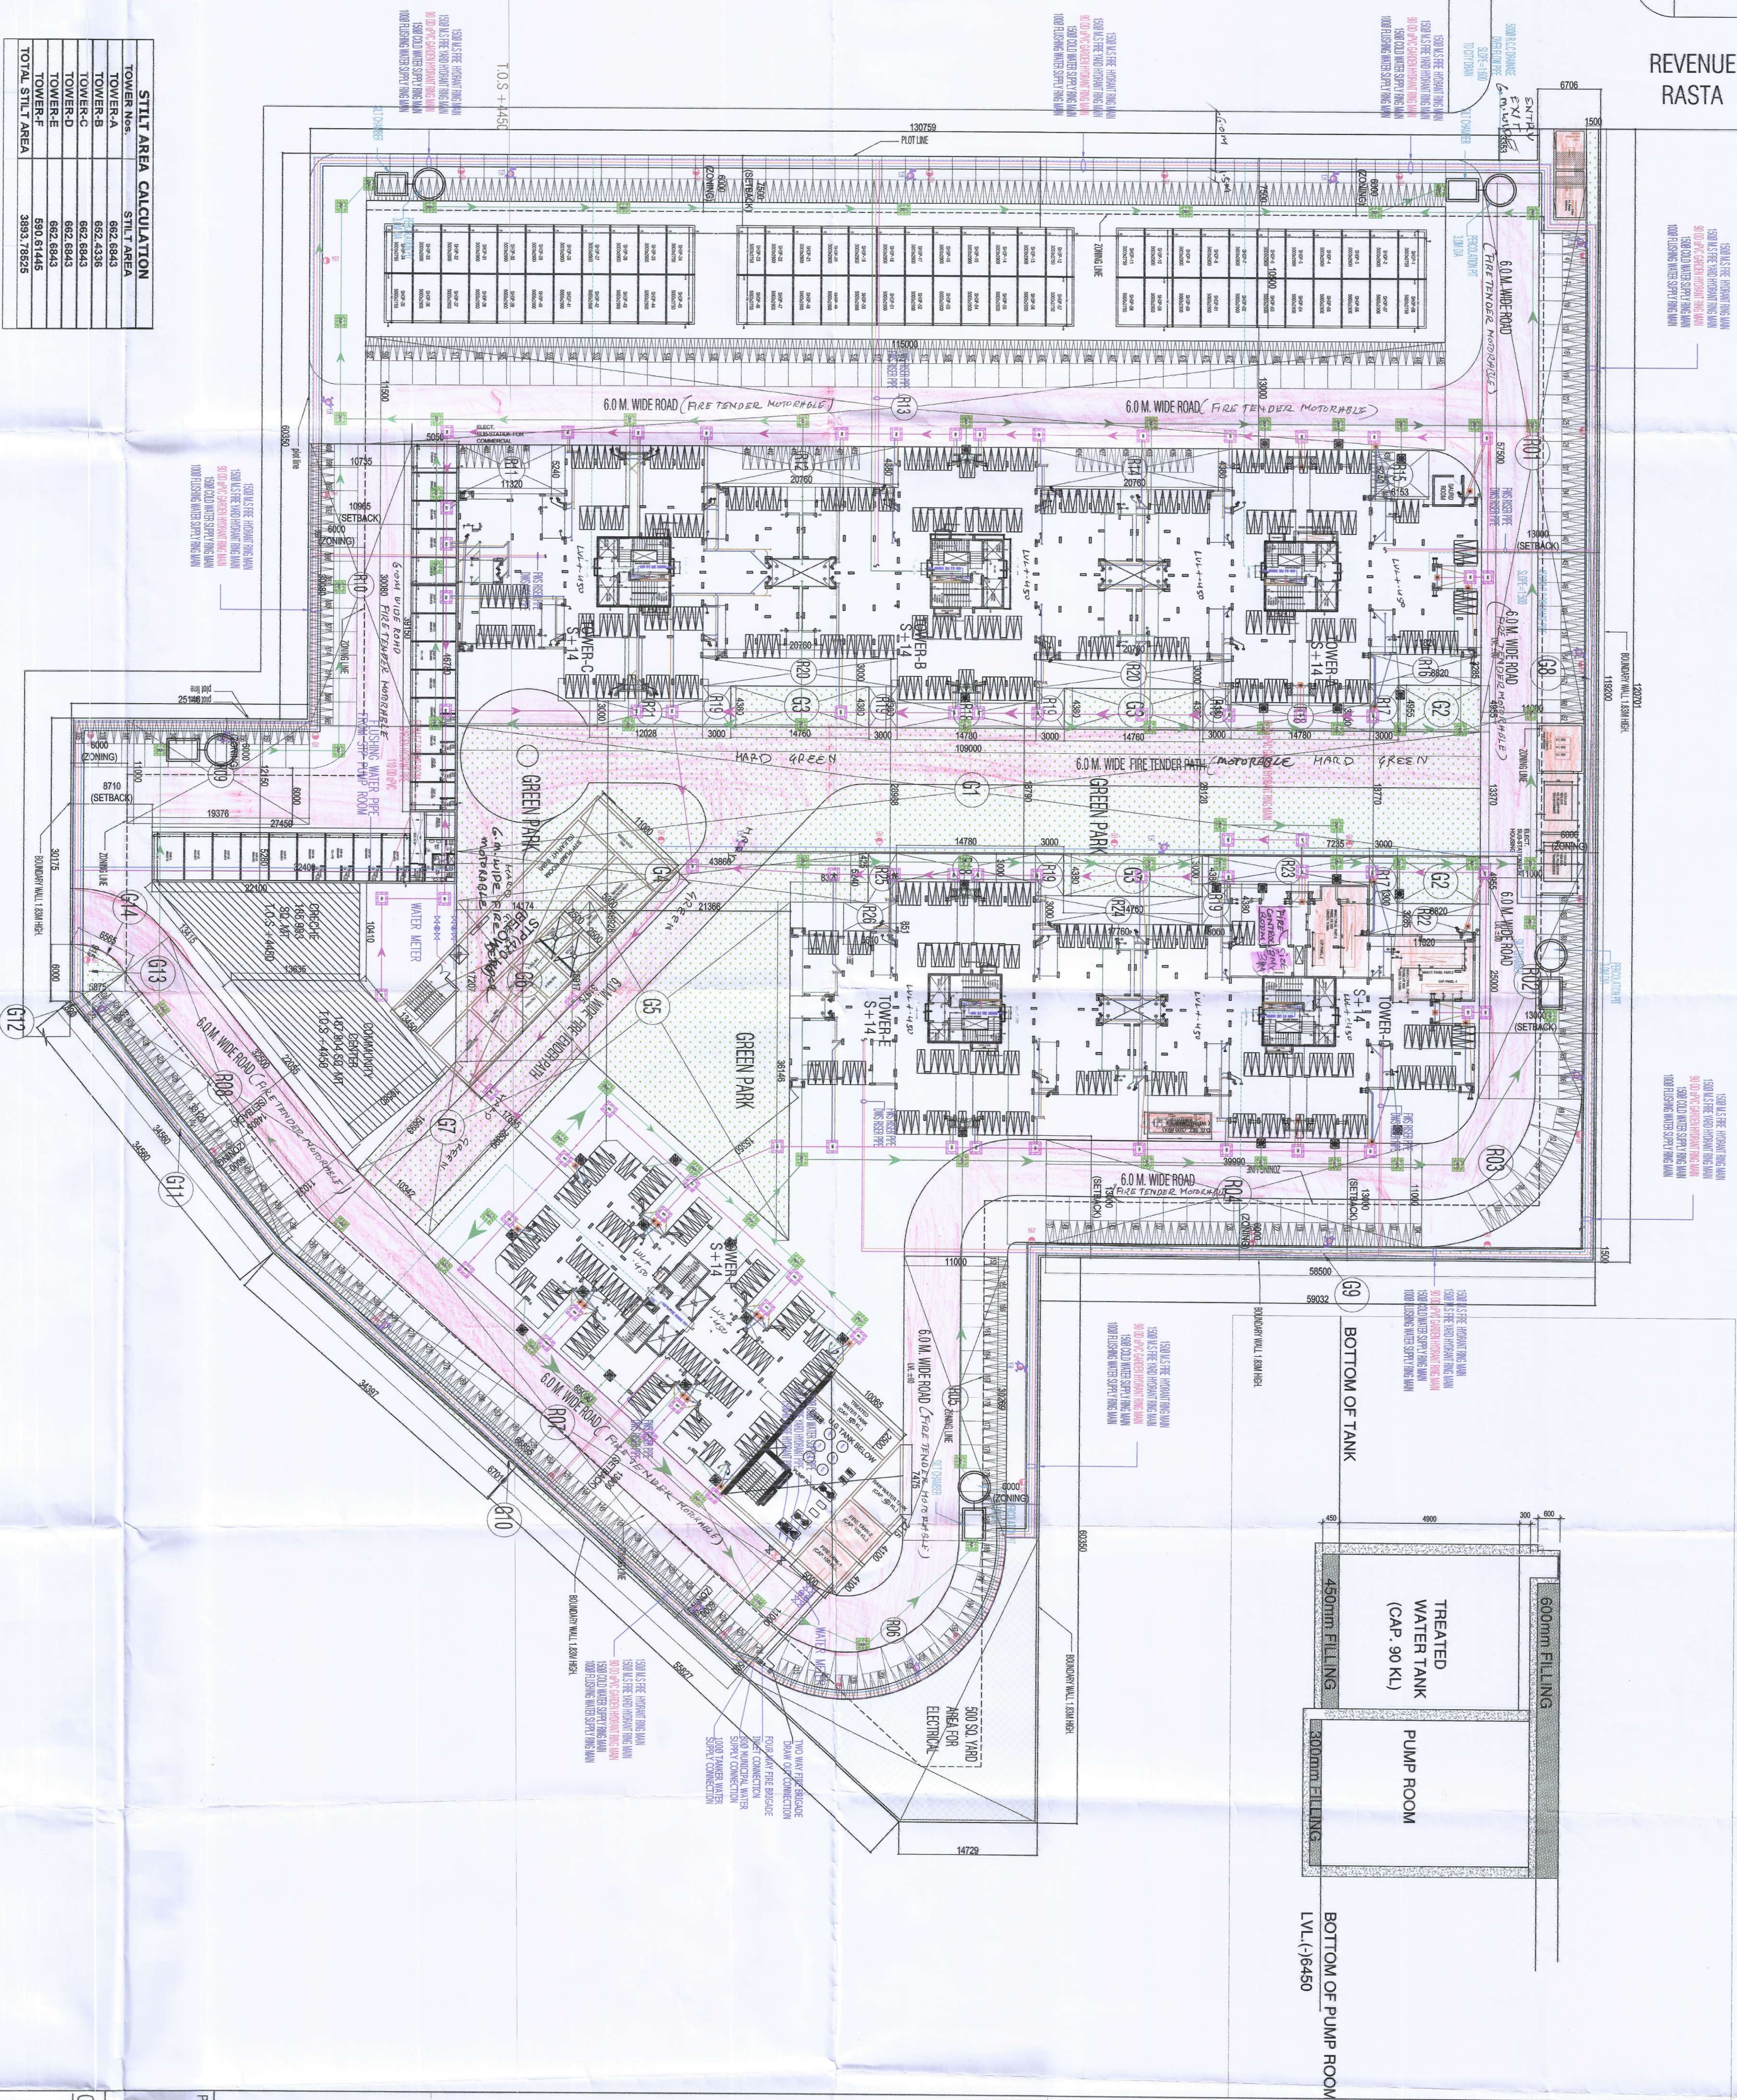

LEGEND FOR PLUMBING	
MH	SEWAGE MANHOLE
DNH	DRAINAGE MANHOLE
	SEWAGE PIPE
	DRAINAGE PIPE
	MUNICIPAL SUPPLY LINE
	COLD WATER SUPPLY LINE
	FRESH WATER SUPPLY LINE
	IRRIGATION LINE
F&C	FIRE BRIDGE CONNECTION
GH	GAS PIPING
BN	BALL VALVE / BUTTERFLY VALVE
N	NON-RETURN VALVE
1500	1500 MM FREE FLOW HOBART PIPE
1500	1500 MM FREE FLOW HOBART PIPE

PRINCIPLE ARCHITECT
difi
DESIGN FORUM INTERNATIONAL
K-47, KILASH COLONY NEW DELHI-110016
PHONE: 011-46550000 FAX: 46550001

CLIENT:
MRA Infrastructure Development LLP in Collaboration with Nani Resorts & Foculture Private Limited

PROJECT NAME AND ADDRESS
PROPOSED AFFORDABLE GROUP HOUSING COLONY FOR AN AREA MEASURING 5.0 ACRES (LICENSE NO. 43 OF 2019 DATED 05.03.2019) IN SECTOR 108 GUJARAGRAM NAINI SAR URBAN COMPLEX

DRAWING TITLE:
STILL FLOOR PLAN & PARKING AREA CALCULATIONS

OWNERS SIGNATURE
ARCHITECT'S SIGNATURE

1 STILL FLOOR PLAN & PARKING AREA CALCULATIONS
Scale:1:300