


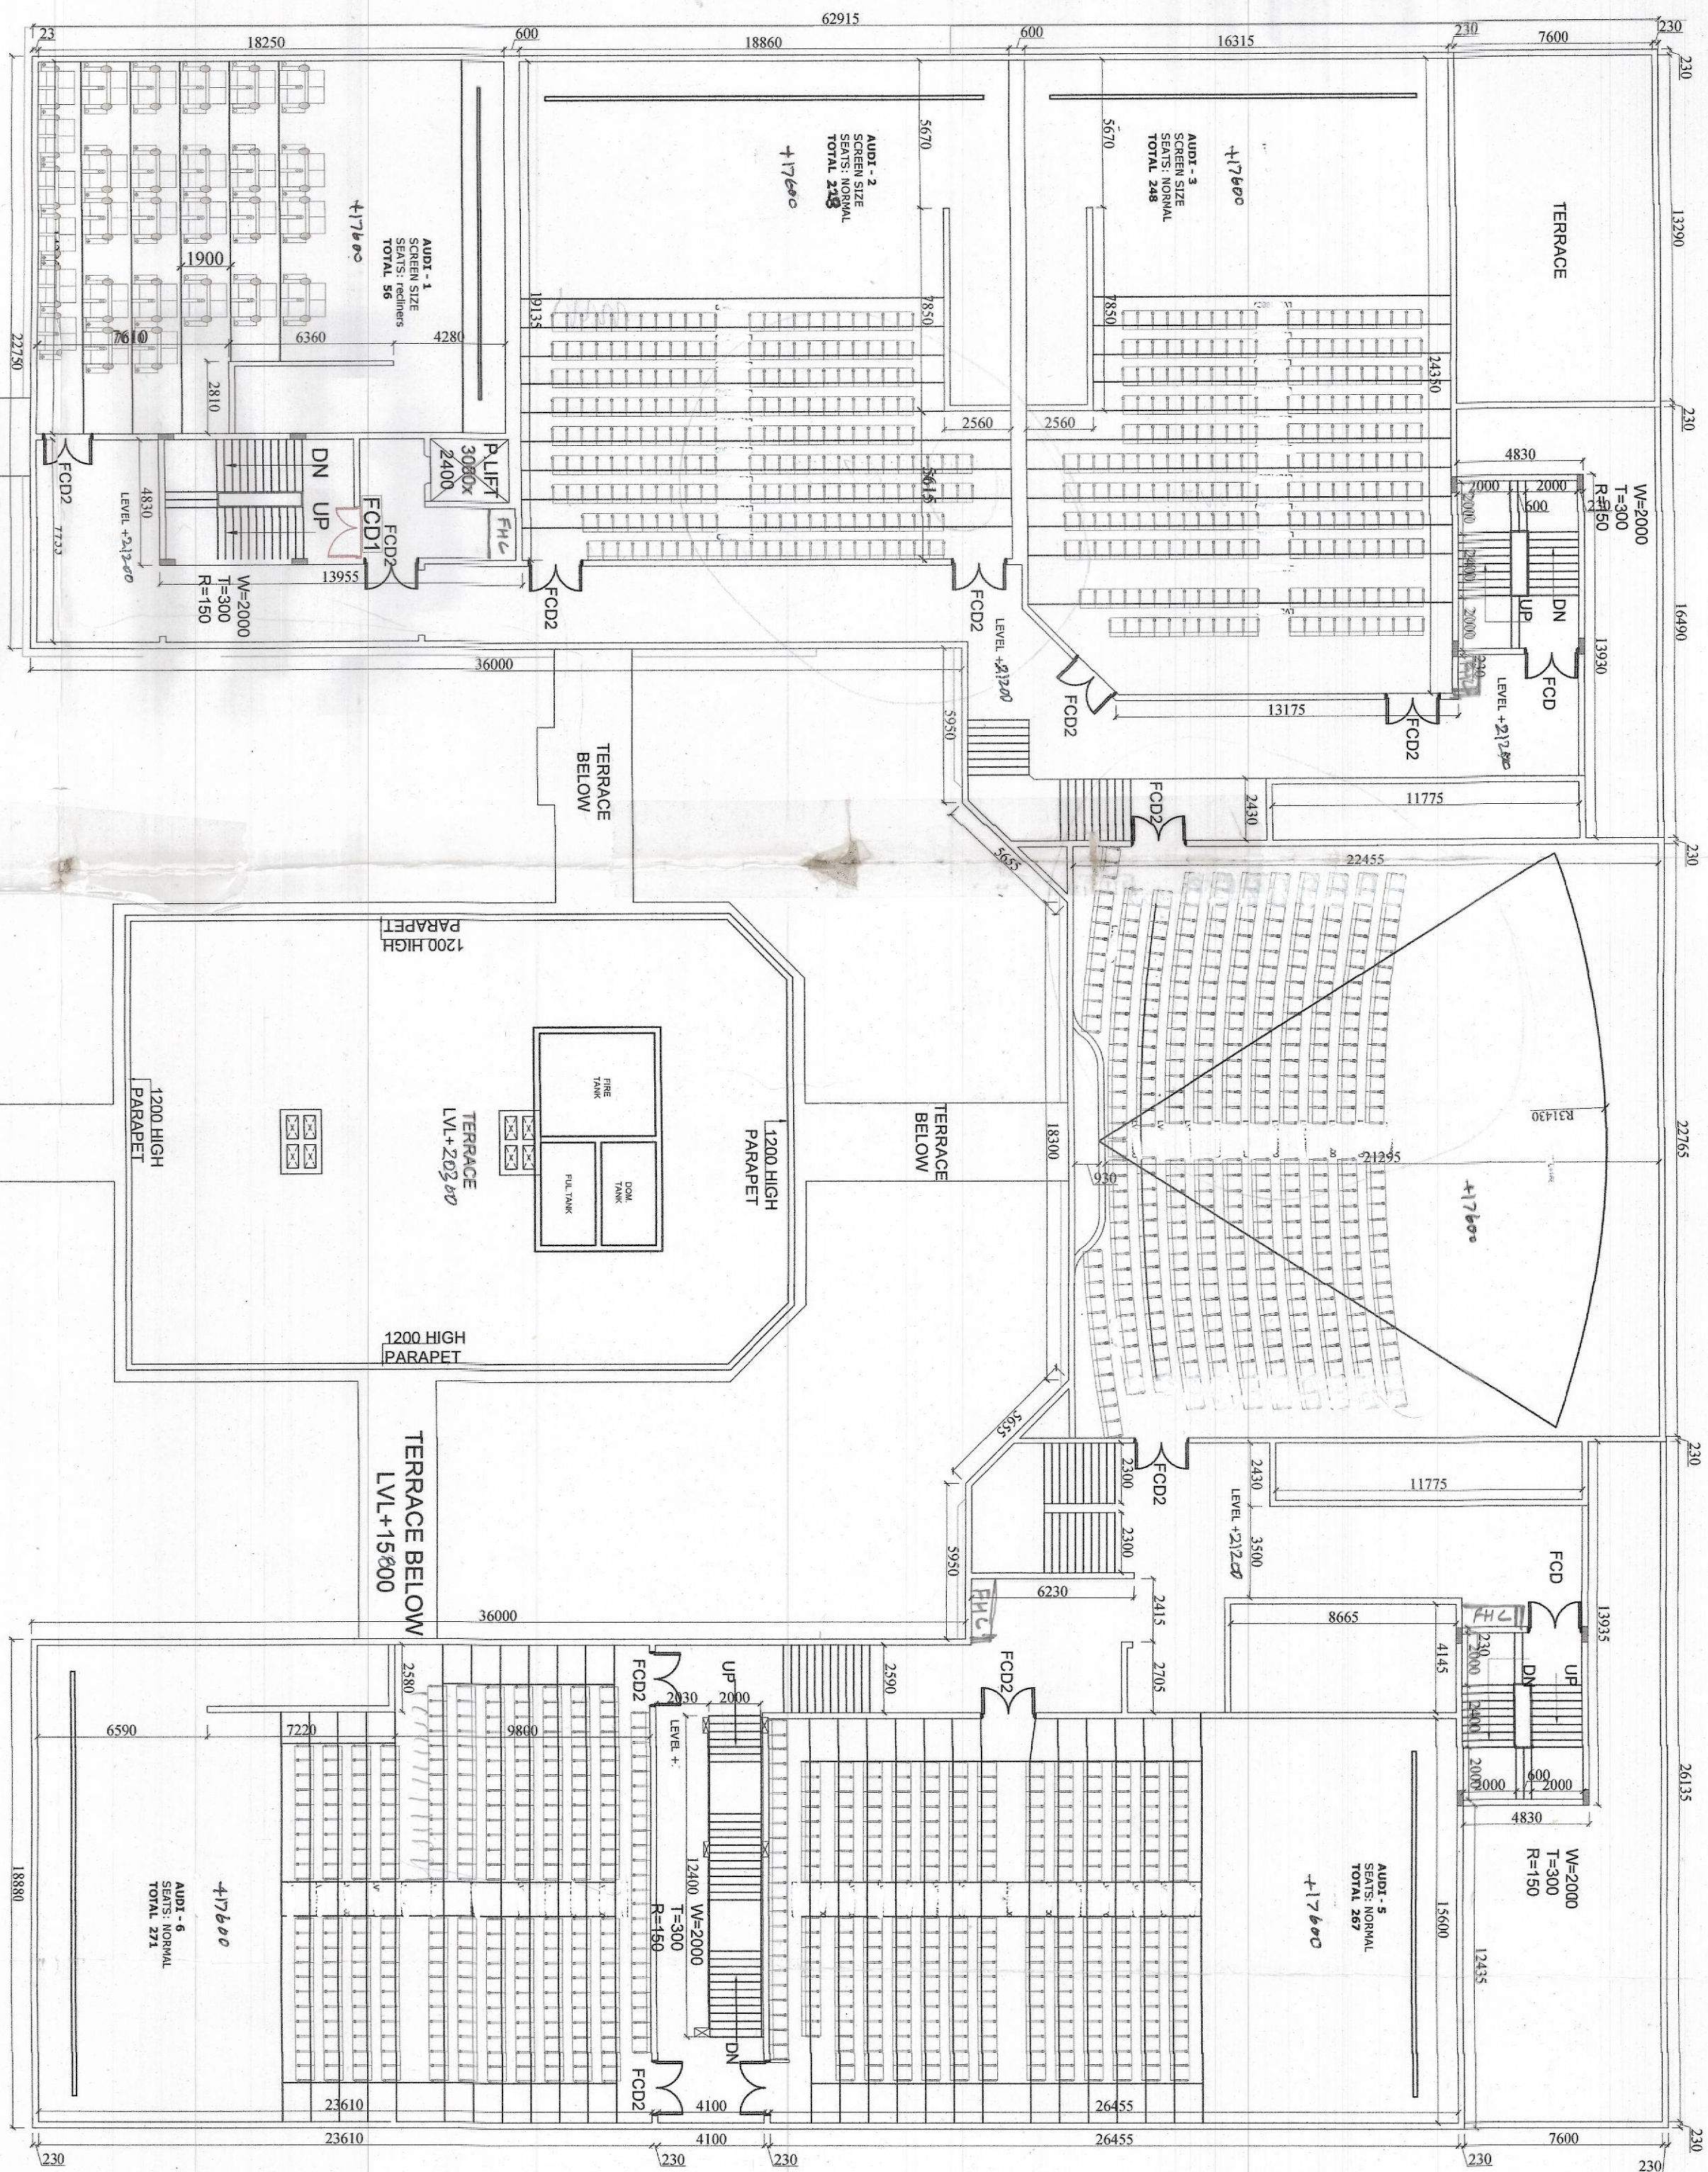

LEGEND FOR VERTICAL PIPES FOR BLOCK-1&2

SYMBOL	DESCRIPTION
1	1000 SOIL AND VENT PIPE
2	1000 WASTE AND VENT PIPE
3	COLD WATER SUPPLY D/TAKE
4	COLD WATER SUPPLY RISER
5	FMS WATER SUPPLY RISER
6	FMS WATER SUPPLY D/TAKE
7	100mmOD UPVC RAIN WATER PIPE
8	160mmOD UPVC RAIN WATER PIPE

HORIZONTAL PIPE CONNECTIONS SHALL BE AS FOLLOWS.

FROM WASH BASIN TO FT	320 PIPE
FROM BATH TAB TO FT	400 PIPE
FROM FD TO FT	500 PIPE
FROM FT TO VERTICAL STACK	1000 PIPE
FROM WC TO VERTICAL STACK	1000 PIPE

BLOCK-1 DOORS & WINDOWS SCHEDULE

S.NO.	TYPE	WIDTH	HEIGHT	CILL LVL	LINTL LVL
1.	D	2000	3000	-	3000
2.	D1	1000	2400	-	2400
3.	D2	750	2100	-	2100
4.	FCD	2000	2400	-	2400
5.	FCD1	1500	2400	-	2400
6.	FCD2	2100	2400	-	2400
7.	G01	4155	BEAM BOTTOM	-	BEAM BOTTOM
8.	G02	3970	BEAM BOTTOM	-	BEAM BOTTOM
9.	G03	2850	BEAM BOTTOM	-	BEAM BOTTOM
10.	G04	4755	BEAM BOTTOM	-	BEAM BOTTOM
11.	G05	4810	BEAM BOTTOM	-	BEAM BOTTOM
12.	G06	11200	BEAM BOTTOM	-	BEAM BOTTOM


BLOCK-2 DOORS & WINDOWS SCHEDULE

S.NO.	TYPE	WIDTH	HEIGHT	CILL LVL	LINTL LVL
1.	G01	6185	BEAM BOTTOM	-	BEAM BOTTOM
2.	G02	6415	BEAM BOTTOM	-	BEAM BOTTOM
3.	G03	4300	BEAM BOTTOM	-	BEAM BOTTOM
4.	G04	6885	BEAM BOTTOM	-	BEAM BOTTOM
5.	G05	5715	BEAM BOTTOM	-	BEAM BOTTOM
6.	G06	6015	BEAM BOTTOM	-	BEAM BOTTOM
7.	G07	7200	BEAM BOTTOM	-	BEAM BOTTOM
8.	G08	7200	BEAM BOTTOM	-	BEAM BOTTOM
9.	D1	900	2100	-	2100
10.	D2	750	2100	-	2100
11.	D3	1000	2400	-	2400
12.	FCD1	2000	2400	-	2400
13.	FCD2	2000	2400	-	2400
14.	W	1000	900	-	2400
15.	W1	1500	2400	-	2400
16.	W2	1500	2400	-	2400
17.	DW1	1800	2400	-	2400
18.	DW2	1800	2400	-	2400
19.	DW3	2500	2400	-	2400
20.	DW4	2000	2400	-	2400
21.	DW5	2000	2400	-	2400

- NOTES/LEGEND-**
1. ALL DIMENSIONS ARE IN MILLIMETRES
 2. DIMENSIONS ARE TO BE READ AND NOT TO BE SCALED
 3. THE CONTRACTOR MUST VERIFY ALL DIMENSIONS ON SITE AND REFER RELEVANT STRUCTURAL AND OTHER CONSULTANTS DRAWINGS BEFORE COMMENCING ANY WORK OR PREPARING ANY SHOP DRAWINGS AND IN CASE ANY DISCREPANCY IS NOTICED THE SAME SHALL BE BROUGHT TO THE NOTICE OF ARCHITECT AND CLARIFIED BEFORE EXECUTION OF WORK

FOURTH FLOOR

BLOCK-01

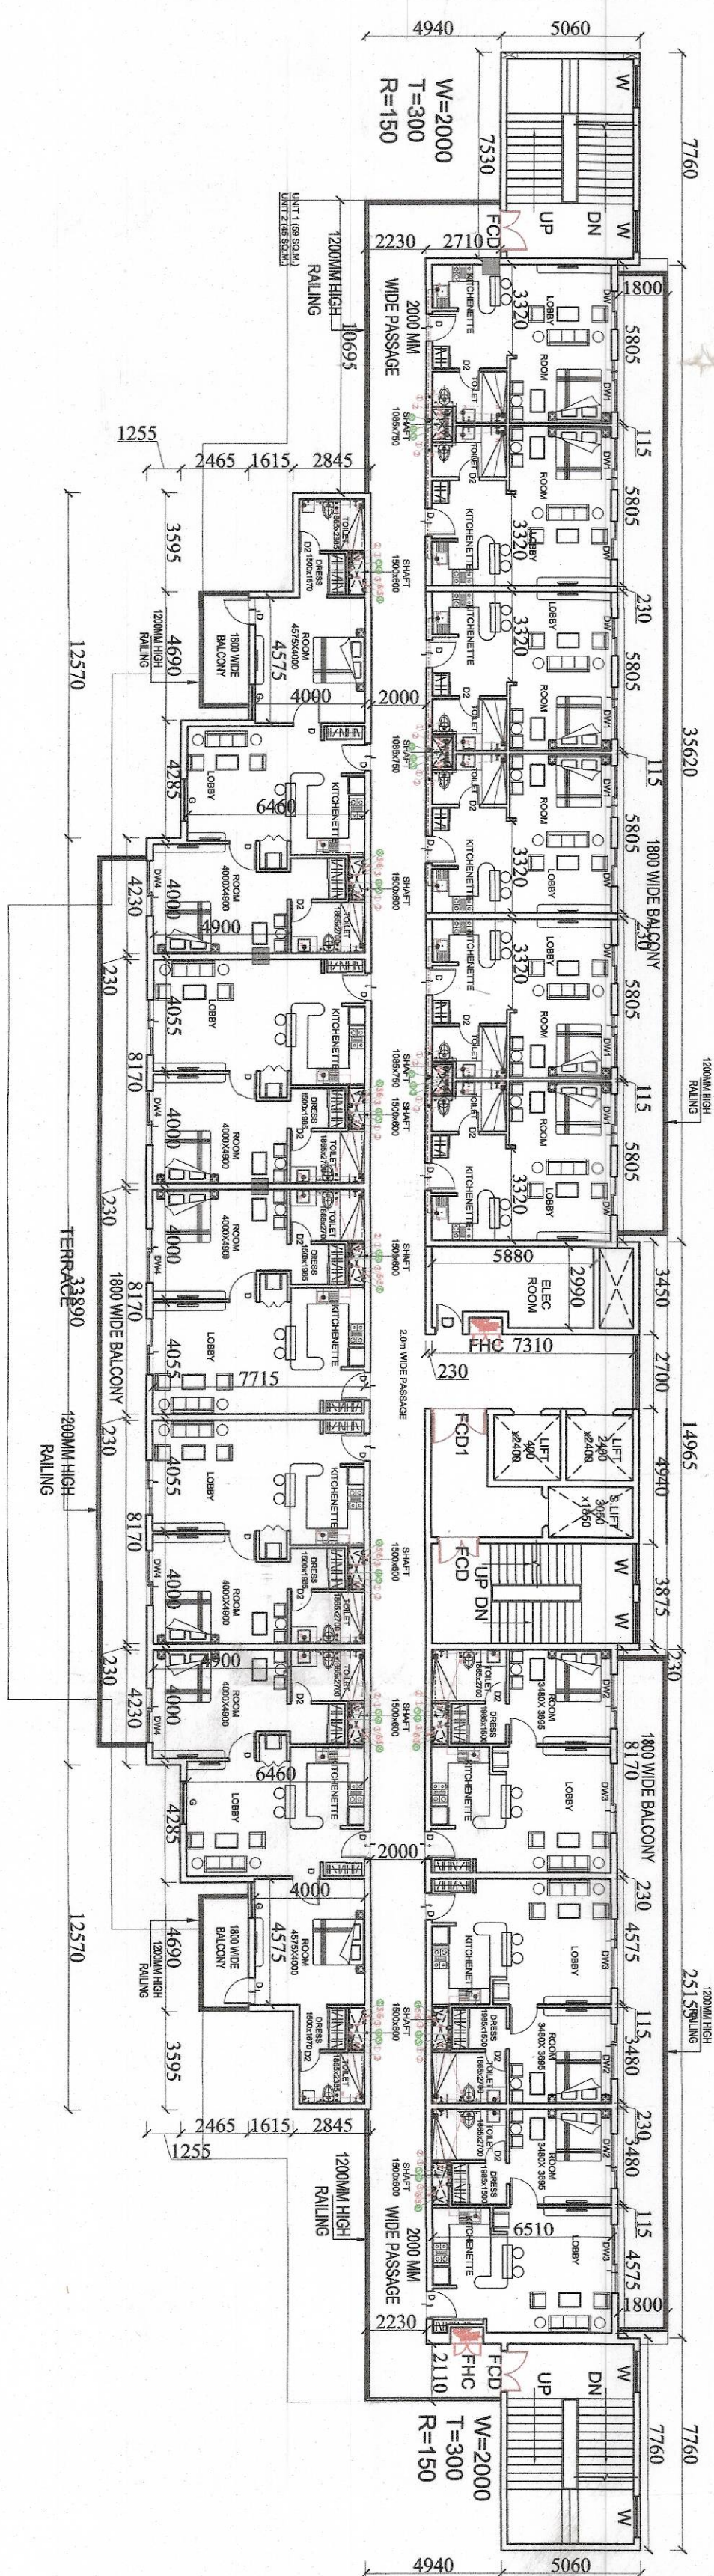

BLOCK-02

PROJECT TITLE: Commercial Area Measuring 0.075 Acres (Licence NO.57 of 2012 Dated 06/02/2012) in siteloc Licence Commercial Colony area Measuring 2.55 Acres (Licence NO. 31 of 2011 Dated 06/04/2011 and Area Measuring 2.7975 Acres Licence NO. 42 of 2011 Dated 13/05/2011) Total 5.7125 acres in Sector - 42 Gurgaon Manesar urban complex being Developed by Bestech India Pvt. Ltd.

OWNER: BESTECH INDIA PVT. LTD GURGAON, HARYANA

OWNERS SIGN: [Signature]

ARCHITECTS SIGN: [Signature]

ARCHITECTS: Sagar Kumar A.I.Y.S. (C.A.93/1330) P. No. 1, Safdarjung Enclave, New Delhi - 110025

CHIEF ARCHITECT: Taylor India LLP GLOBAL ARCHITECTS & MASTER PLANNERS A 1/54 Lower Ground Floor Safdarjung Enclave New Delhi - 110029 Tel: + 91 - 11 - 26177793 Fax: + 91 - 11 - 26197974

SUBMISSION DRAWING

DRAWING TITLE: FOURTH FLOOR PLAN

ISSUE DATE: 15-09-2018

SCALE: 1:300

REV. NO.: 01

CHECK BY: S.K.

DATE: 15-09-2018

APPROVED BY: [Signature]