

LEGEND FOR VERTICAL PIPES FOR BLOCK-1 & 2

SYMBOL	DESCRIPTION
1	1000 SOL AND VENT PIPE
2	1000 WASTE AND VENT PIPE
3	COLD WATER SUPPLY DRAINAGE
4	COLD WATER SUPPLY RISER
5	FMS WATER SUPPLY RISER
6	FMS WATER SUPPLY DRAINAGE
7	110mm Ø UP/C RAIN WATER PIPE
8	100mm Ø UP/C RAIN WATER PIPE

HORIZONTAL PIPE CONNECTIONS SHALL BE AS FOLLOWS.

FROM WASH BASIN TO FT	320 PIPE
FROM BATH TAB TO FT	400 PIPE
FROM FD TO FT	500 PIPE
FROM FT TO VERTICAL STACK	1000 PIPE
FROM WC TO VERTICAL STACK	1000 PIPE

NOTES/ LEGEND-


1. ALL DIMENSIONS ARE IN MILLIMETRES
2. DIMENSIONS ARE TO BE READ AND NOT TO BE SCALED
3. THE CONTRACTOR MUST VERIFY ALL DIMENSIONS ON SITE AND REFER RELEVANT STRUCTURAL AND OTHER CONSULTANTS DRAWINGS BEFORE COMMENCING ANY WORK OR PREPARING ANY SHOP DRAWINGS AND IN CASE ANY DISCREPANCY IS NOTICED THE SAME SHALL BE BROUGHT TO THE NOTICE OF ARCHITECT AND CLARIFIED BEFORE EXECUTION OF WORK
4. BUILDING ARE FULL SPRINKLER

Checked and Approved for the Client
Authorizing Engineer
Date: 11/05/2018
Signature: [Signature]
Stamp: [Stamp]

Checked and Approved for the Architect
Authorizing Engineer
Date: 11/05/2018
Signature: [Signature]
Stamp: [Stamp]

S.NO	TYPE	WIDTH	HEIGHT	CALL LVL	UNIT LVL
1	GD	618	2400	-	2400
2	GD	600	2400	-	2400
3	GD	4300	2400	-	2400
4	GD	688	2400	-	2400
5	GD	5715	2400	-	2400
6	GD	6015	2400	-	2400
7	GD	7200	2400	-	2400
8	D	900	2400	-	2400
9	D	900	2400	-	2400
10	D	750	2100	-	2400
11	D	750	2100	-	2400
12	FCO	1500	2400	-	2400
13	FCO	2000	2400	-	2400
14	V	1500	900	-	2400
15	V	600	900	-	2400
16	V	1500	1500	-	2400
17	DW	1580	2400	-	2400
18	DW	1580	2400	-	2400
19	DW	1580	2400	-	2400
20	DW	2520	2400	-	2400
21	DW	2500	2400	-	2400

S.NO	TYPE	WIDTH	HEIGHT	CALL LVL	UNIT LVL
1	D	2000	3000	-	3000
2	D	1000	2400	-	2400
3	D	750	2100	-	2100
4	FCO	2000	2400	-	2400
5	FCO	1500	2400	-	2400
6	FCO	2100	2400	-	2400
7	GD	4155	2400	-	2400
8	GD	3870	2400	-	2400
9	GD	2820	2400	-	2400
10	GD	4785	2400	-	2400
11	GD	4810	2400	-	2400
12	GD	11200	2400	-	2400

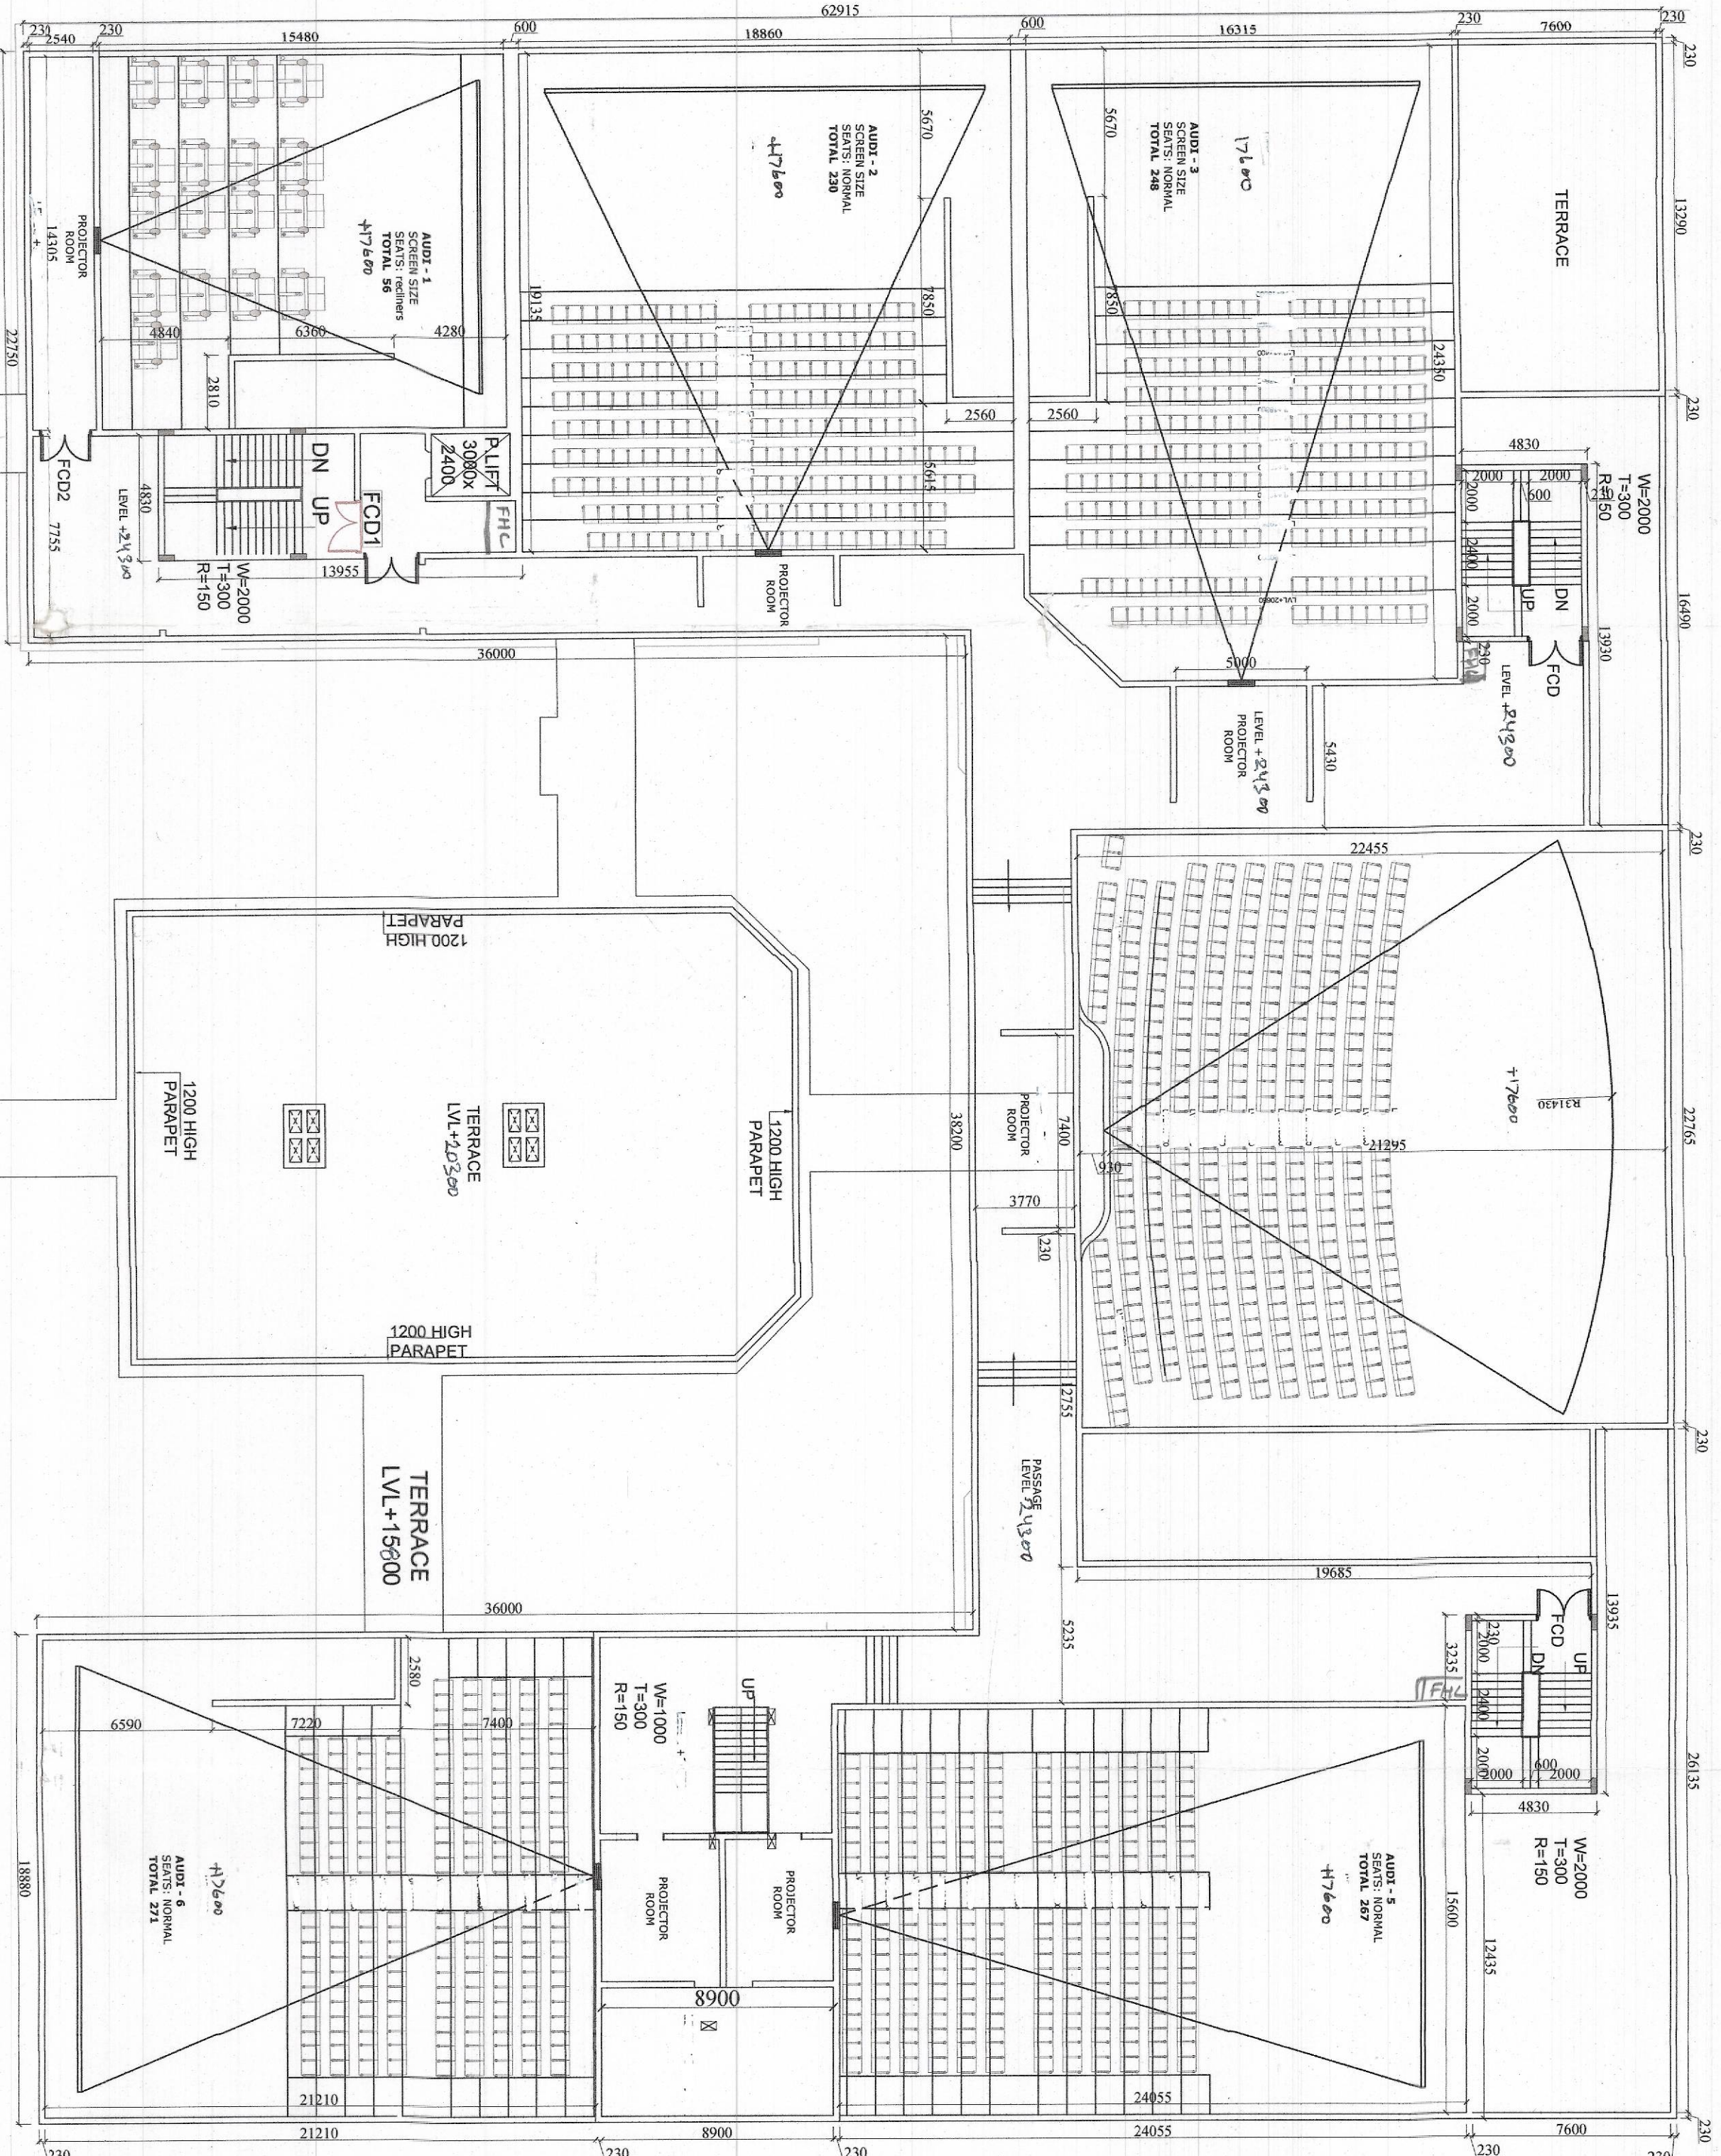


5th FLOOR FLOOR

BLOCK-01

TYPICAL FLOOR PLAN
(4TH TO 9TH FLOOR)

BLOCK-02

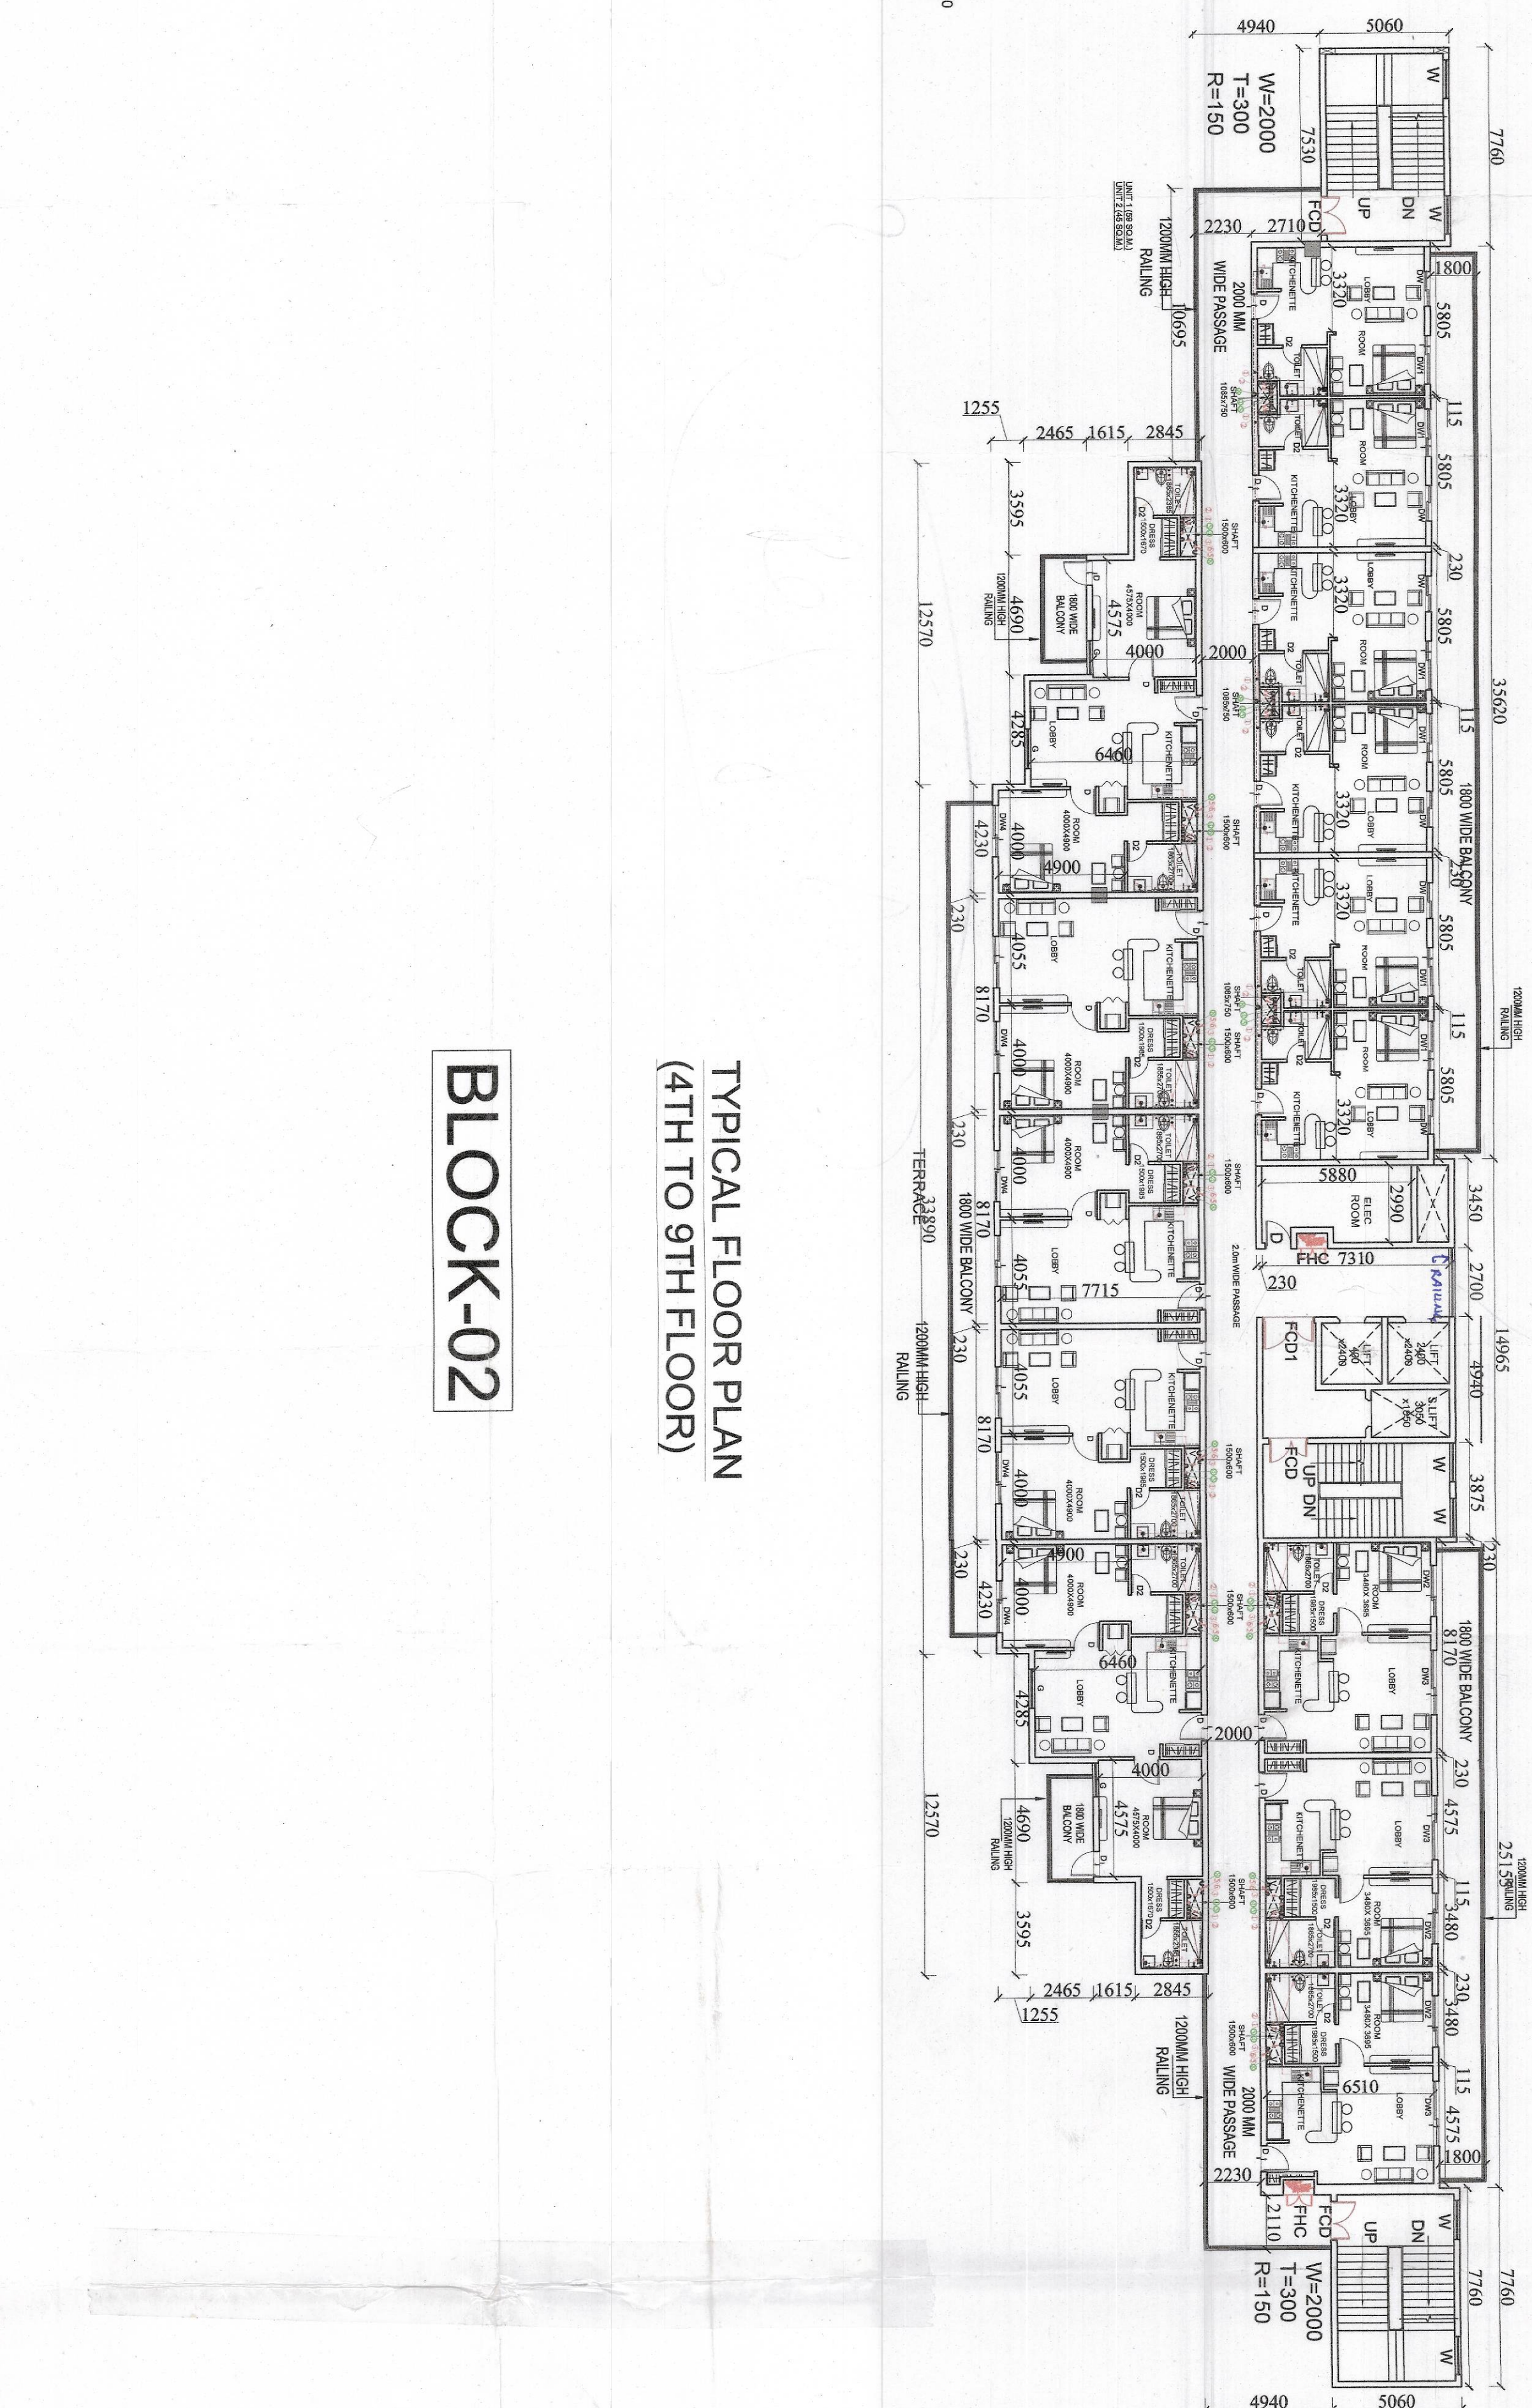

BESTECH INDIA PVT. LTD
GURGAON, HARYANA

OWNERS SIGN:

ARCHITECTS SIGN:

Sapna Kaur
Architect
New Delhi, India

ARCHITECTS:
Chapman Taylor India LLP
GLOBAL ARCHITECTS & MASTER PLANNERS
A/154, Lower Ground Floor, Saketpuri, Engage
New Delhi - 110029
Tel: + 91 - 11 - 26177973
Fax: + 91 - 11 - 26197974

SUBMISSION DRAWING

DRAWING TITLE	NORTH
FIFTH FLOOR PLAN	
ISSUE DATE	REV. NO.
15-09-2018	10
CHECK BY	DRAWN BY
SCALE	SHEET NO.
1:300	ARSEC-20/COM/206
	APP BY