


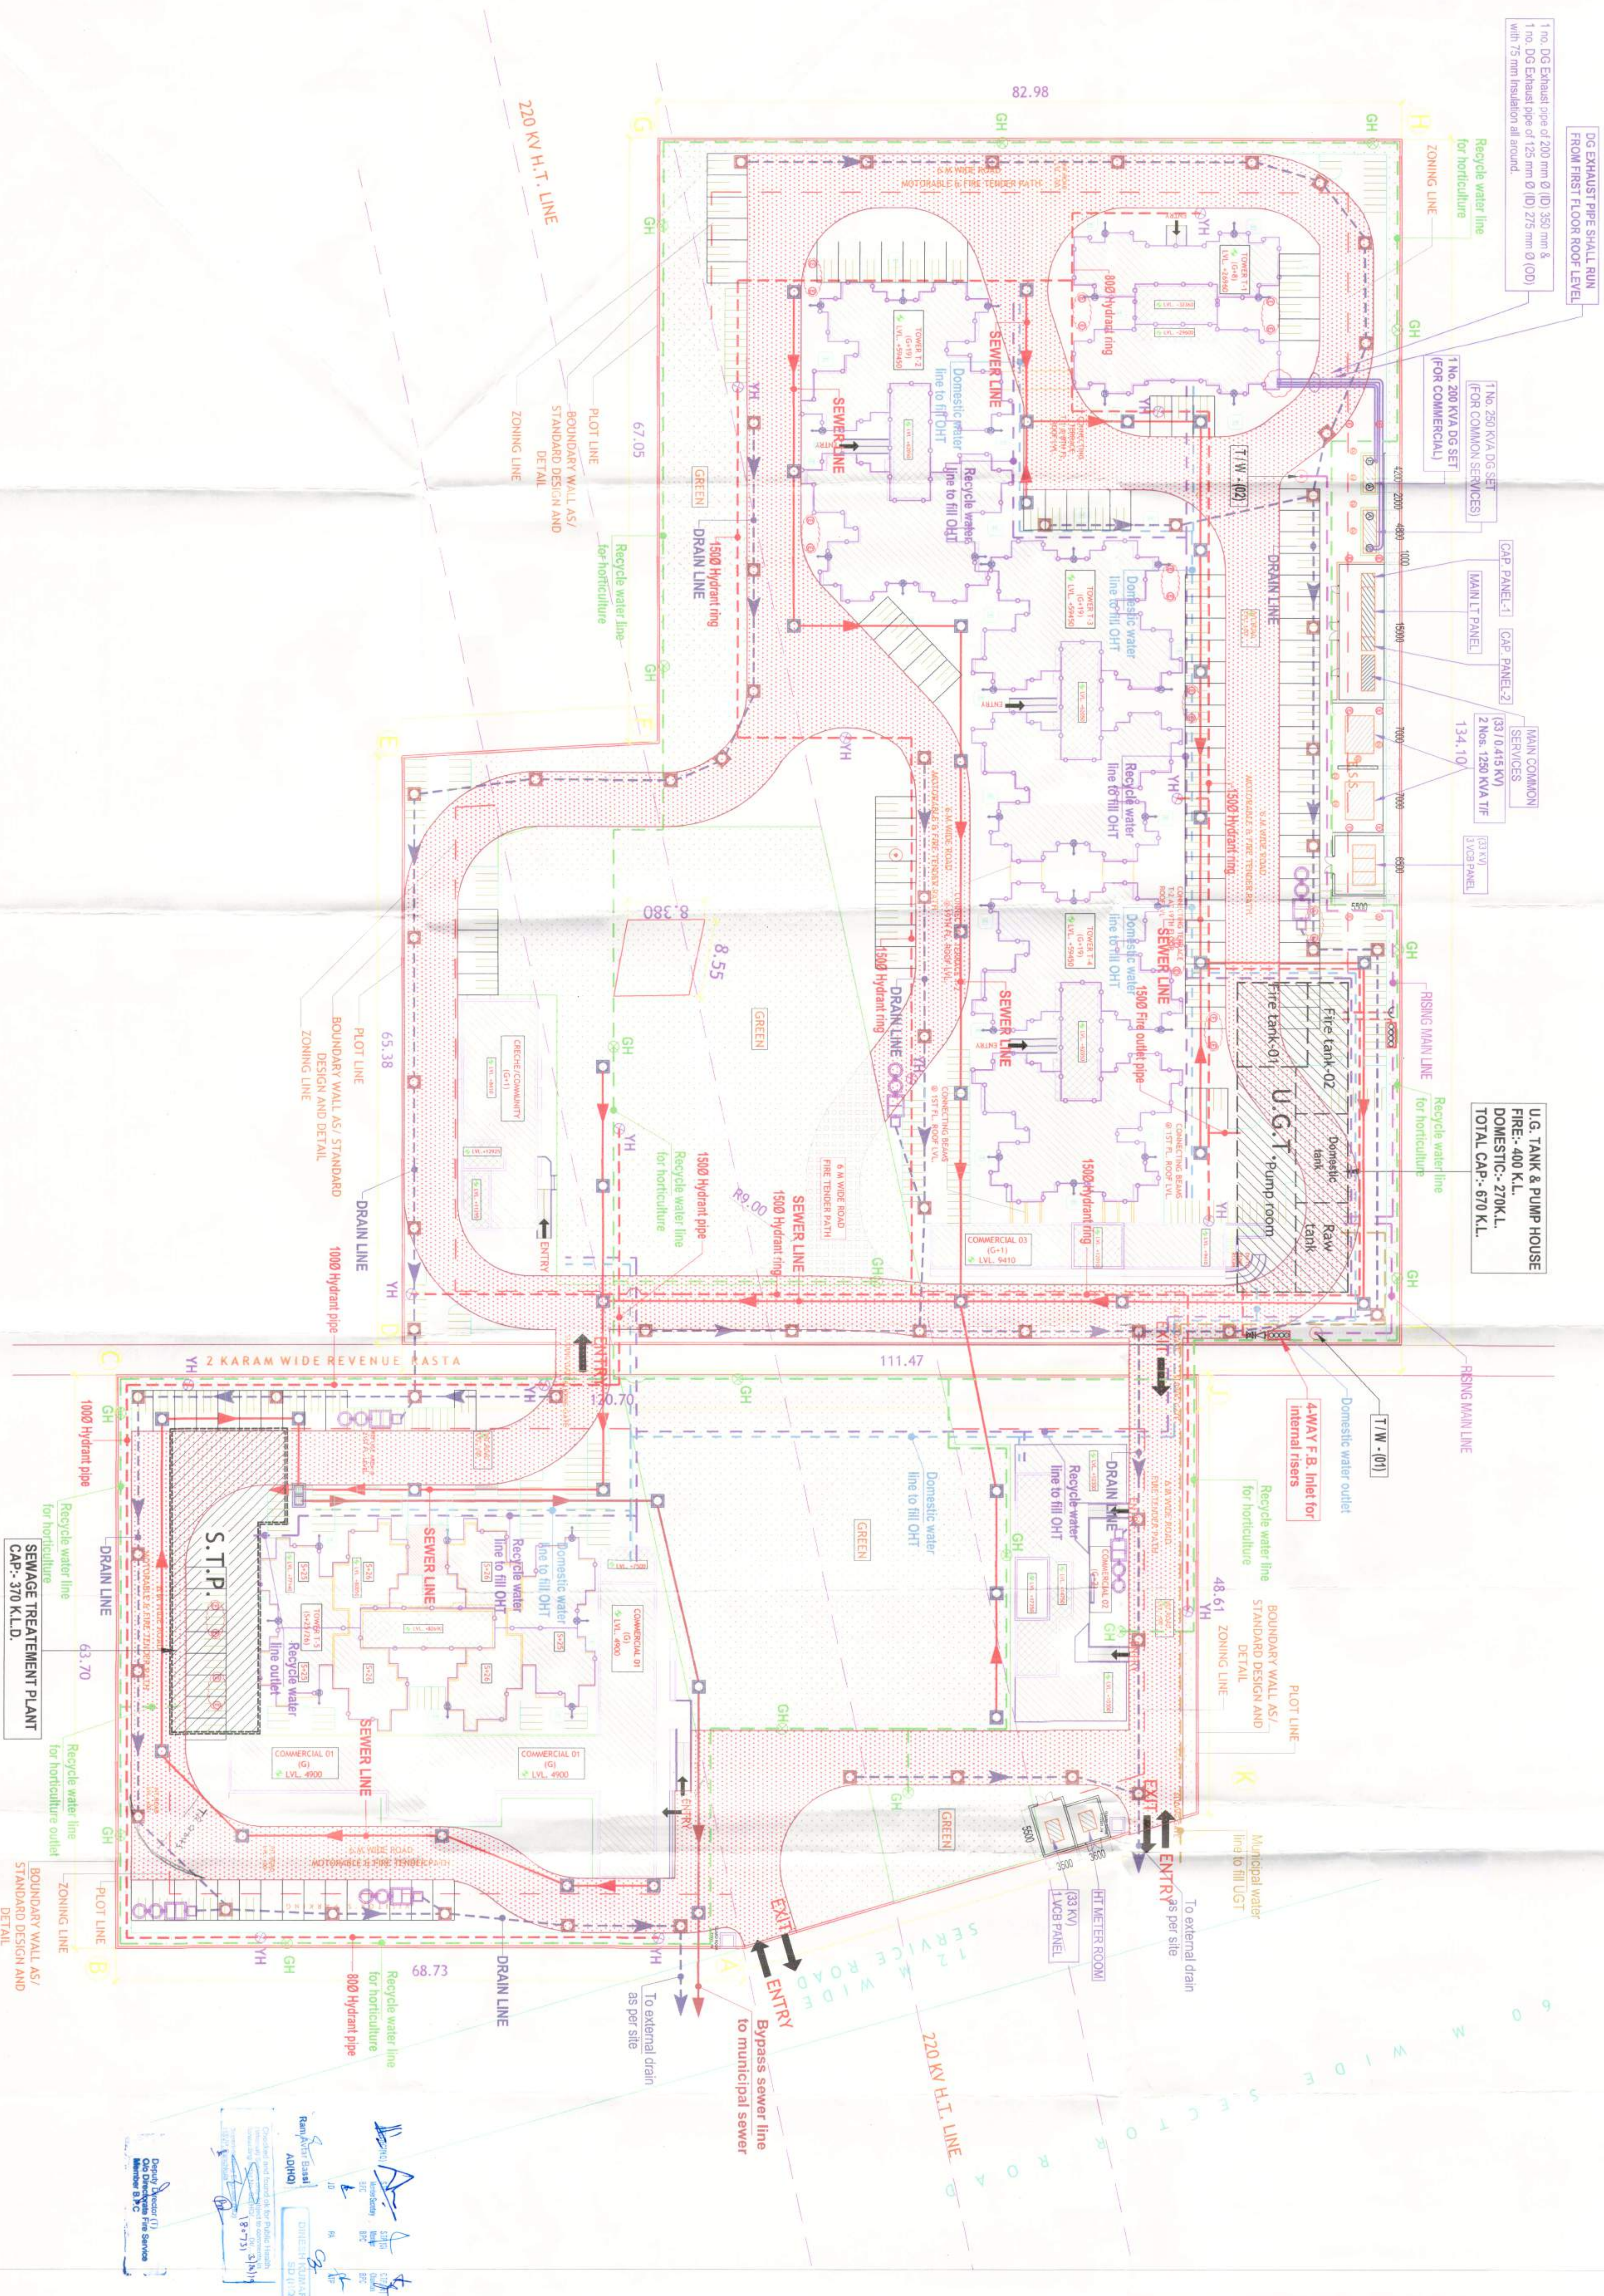

LEGEND :	
S. No.	DESCRIPTION
1.	M.H.
2.	SEWER LINE
3.	BYPASS SEWER LINE
4.	C.P.
5.	UNDER GROUND DRAIN
6.	DOMESTIC WATER LINE TO FILL OHT
7.	RECYCLE WATER LINE TO FILL OHT
8.	RECYCLE WATER SUPPLY PIPE LINE
9.	DOMESTIC WATER SUPPLY PIPE LINE
10.	MUNICIPAL WATER SUPPLY PIPE LINE
11.	PROPOSED TUBE WELL
12.	GARDEN HYDRANT
13.	RAIN WATER HARVESTING

SUBMISSION DRAWING

CLIENT
M/S. SIGNATURE GLOBAL INDIA PRIVATE LIMITED
28 Sector 17, Phase 1, Gurgaon, Haryana
28 Sector 17, Phase 1, Gurgaon, Haryana

PROJECT TITLE
PROPOSED BUILDING PLAN OF AFFORDABLE GROUP HOUSING
COLONY FOR AN AREA MEASURING 5.00 ACRES (TENCE NO.
MAHESAR URBAN COMPLEX BEING DEVELOPED BY MAHESAR
SAME LAND HOLDING COMPANY ONE PVT. LTD. AND OTHERS IN
COLLABORATION WITH SIGNATURE GLOBAL INDIA PVT. LTD.

CONSUMER ENGINEERING SERVICES PVT. LTD.
Date: 20/09/2019
By: [Signature]
For: [Signature]

R.K. & ASSOCIATES
Architects & Engineers
R.K. & ASSOCIATES
28 Sector 17, Phase 1, Gurgaon, Haryana
28 Sector 17, Phase 1, Gurgaon, Haryana

NNC DESIGN INTERNATIONAL
Architects & Engineers
NNC DESIGN INTERNATIONAL
28 Sector 17, Phase 1, Gurgaon, Haryana
28 Sector 17, Phase 1, Gurgaon, Haryana

OWNERS SIGNATURE
[Signature]
[Signature]

ARCHITECT'S SIGNATURE
[Signature]
[Signature]

SITE PLAN
SERVICES CO-ORDINATION PLAN
03

SCALE : 1:450
DATE : SEPT 2019