 


Chief Electrical Inspector,  
to Govt. Paryaya, Chandigarh



CONTINUED TO DRAWING NO. CP-2/PH-3/KCB/EU/SLD-03 08.10.2014 R-5




$\delta$	$\eta$	$\epsilon$	$\xi$	$\zeta$	$\theta$	$\varphi$	$\chi$
26°	04	02F	06	03	05	03	06
36°	03	03	03	03	03	03	03

[illegible][illegible]

$\Delta E$	NO	$\Delta E$	NO	$\Delta E$	NO	$\Delta E$	NO	$\Delta E$	NO
$\Delta E$	NO	$\Delta E$	NO	$\Delta E$	NO	$\Delta E$	NO	$\Delta E$	NO

Sami



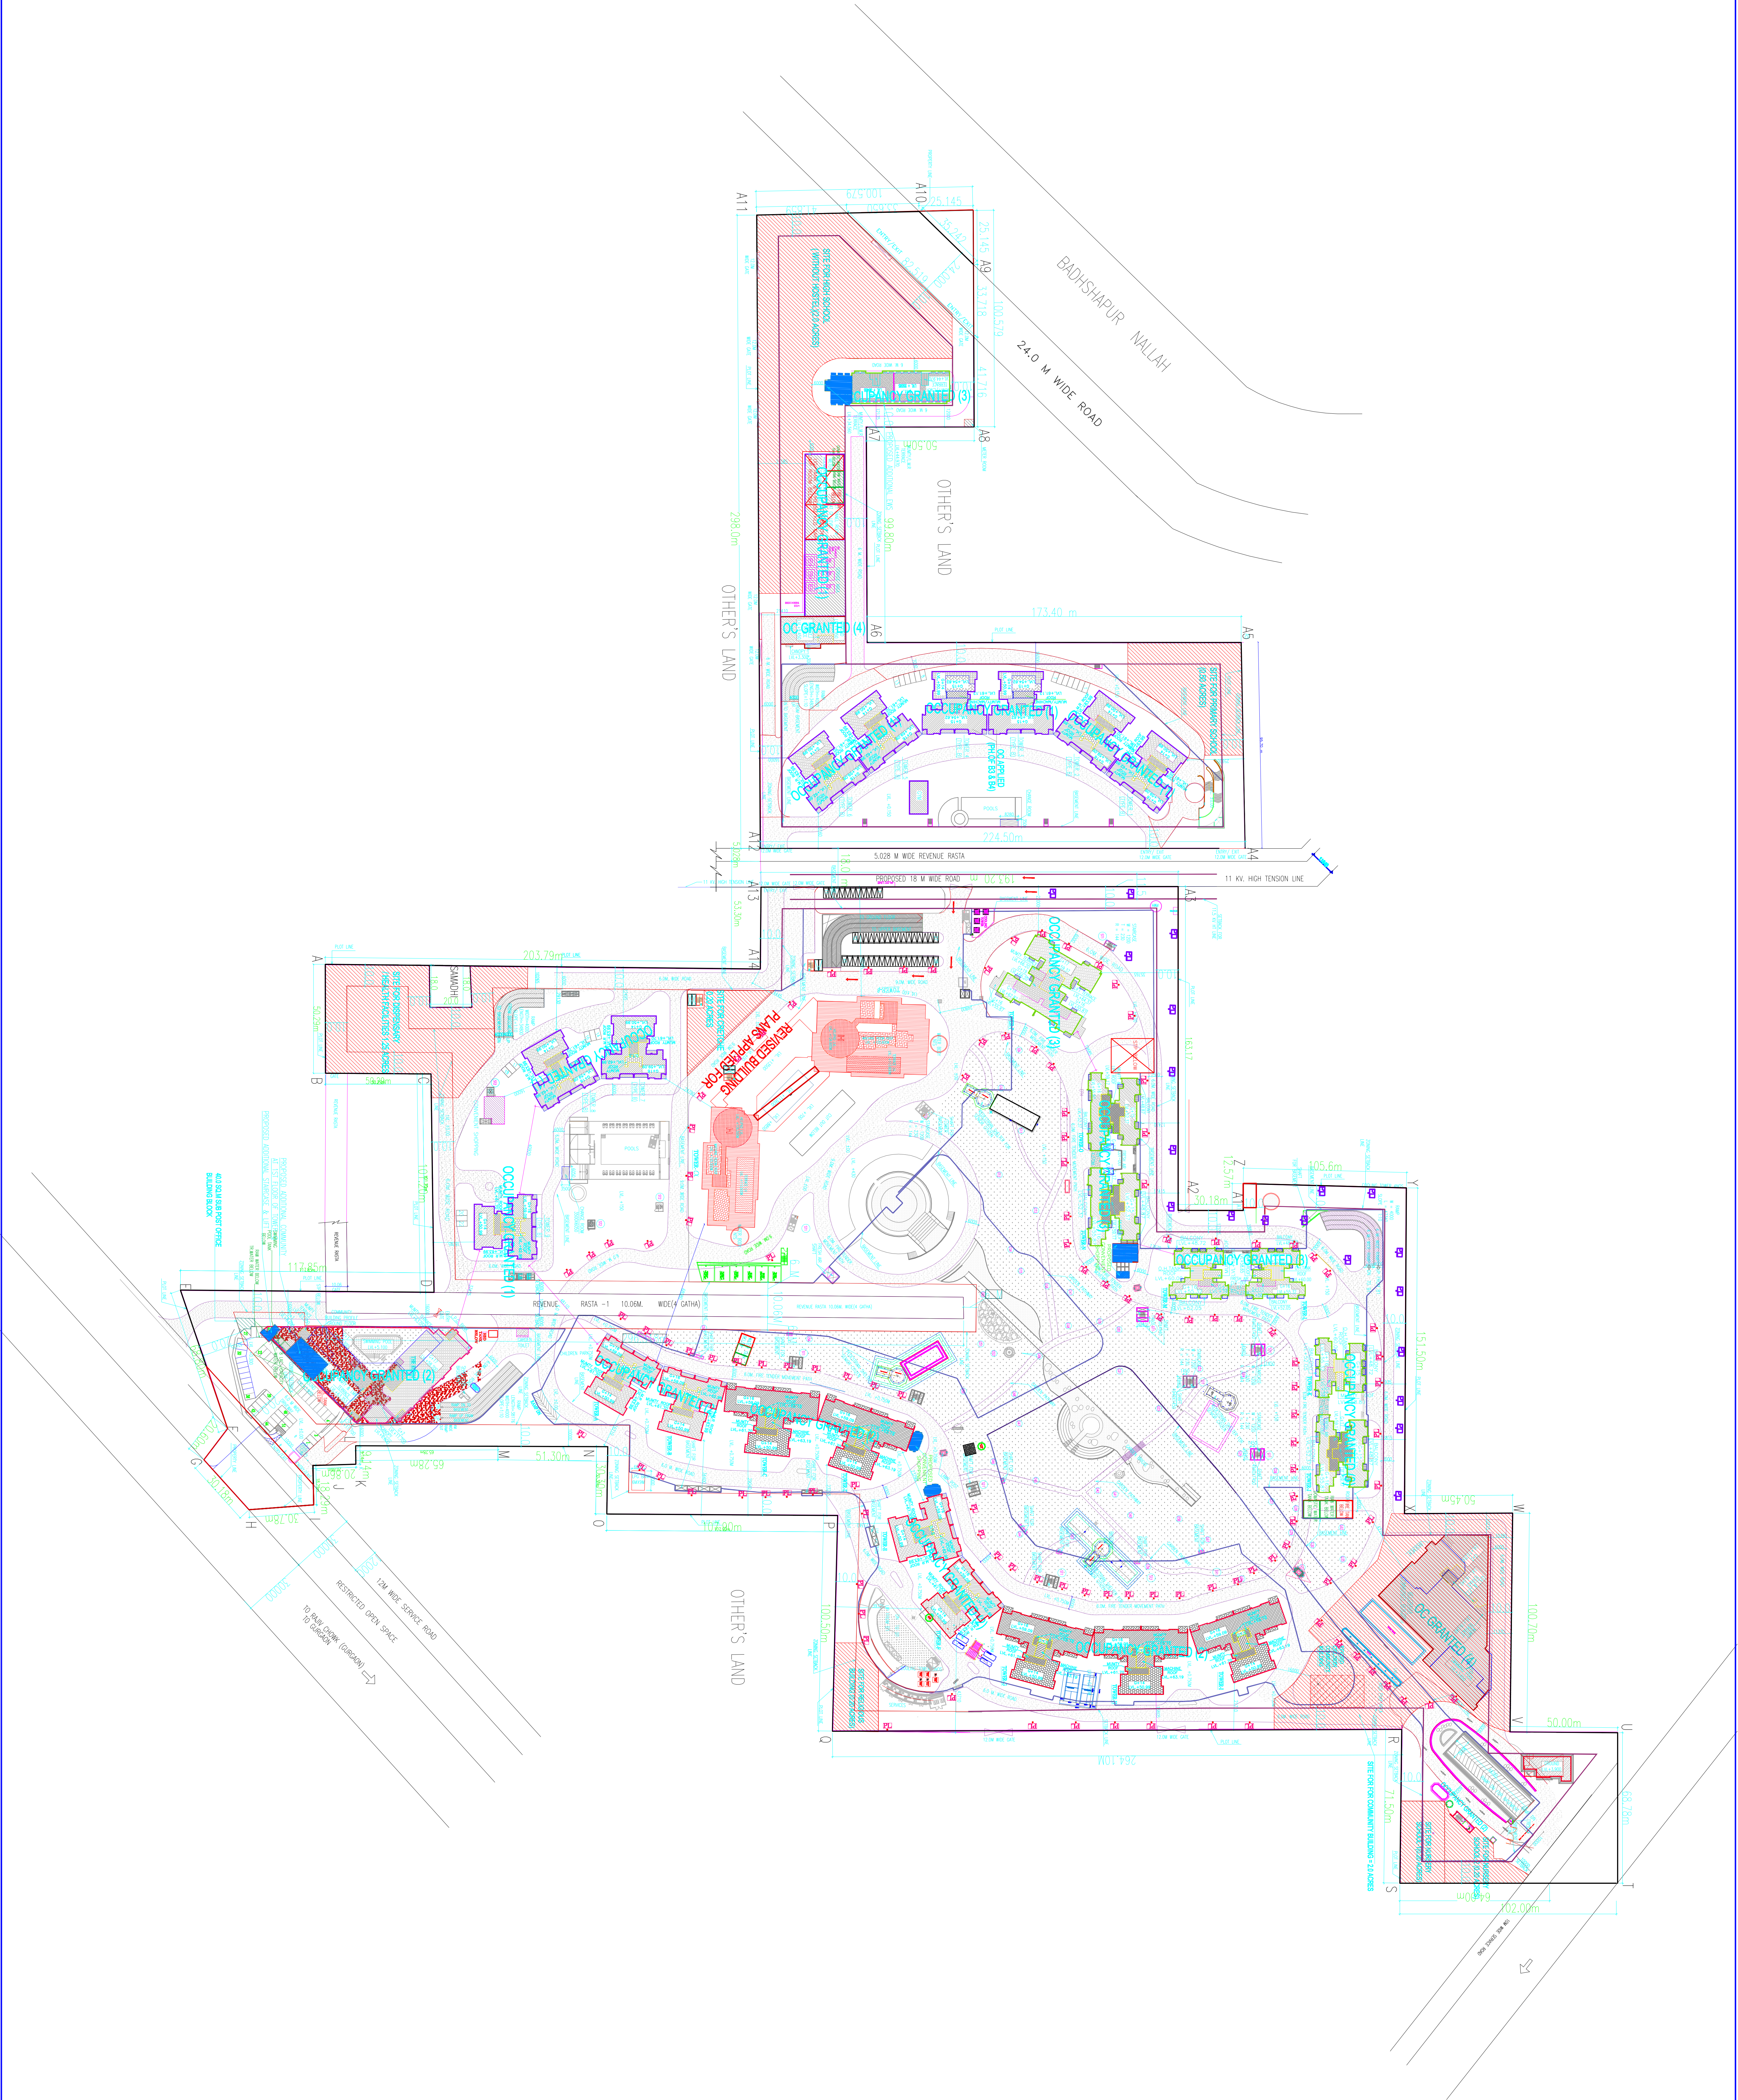

LEGEND	
S.NO.	SYMBOL DESCRIPTION
01	PL POLE LIGHT

Project:-

REVISED BUILDING PLANS OF TOWER-ALFA & BETA, CHILDREN COMMUNITY BUILDING AND PROPOSED FOUR CONVENIENT SHOPPING ,PART EWS BUILDING, ADDITIONAL COMMUNITY, AT 1ST FLOOR OF TOWER-Q OF GROUP HOUSING SCHEME SANCTIONED VIDE LICENSE NO. 2 OF 1995, 35 TO 37 OF 1996 AND 117-119 OF 2004 (MEASURING 47.418 ACRES) IN SECTOR-48, GURGAON BEING DEVELOPED BY M/S SWETA ESTATES PVT. LTD.

Client:-

SWETA ESTATES PVT. LTD.

ARCHITECT'S SEAL & SIGNATURE	OWNER'S SEAL & SIGNATURE
------------------------------	--------------------------

DRAWING TITLE:-	DRAWING NO:-
-----------------	--------------

SCALE : NTS



SITE PLAN WITH POLE LIGHT

ST-PL 01

CENTRAL PARK-II