


200ø Sewer Line Surface  
 Domestic Water Supply 80ø  
 Flushing Water Supply 80ø  
 300mm dia Storm Water Line Rain Pipe  
 150ø MS Fire Risk

LEGEND FOR DRAINAGE

SYMBOL	DESCRIPTION
	80ø FLUSHING SUPPLY LINE
	80ø COLD WATER SUPPLY LINE
	SEWERAGE TREATMENT PLANT
	S.W. PIPE
	MANHOLE 900X900MM
	GARDEN IRRIGANT
	DRAINAGE LINE
	RAIN WATER HARVESTING PIT
	DRAINAGE MANHOLE 800X900

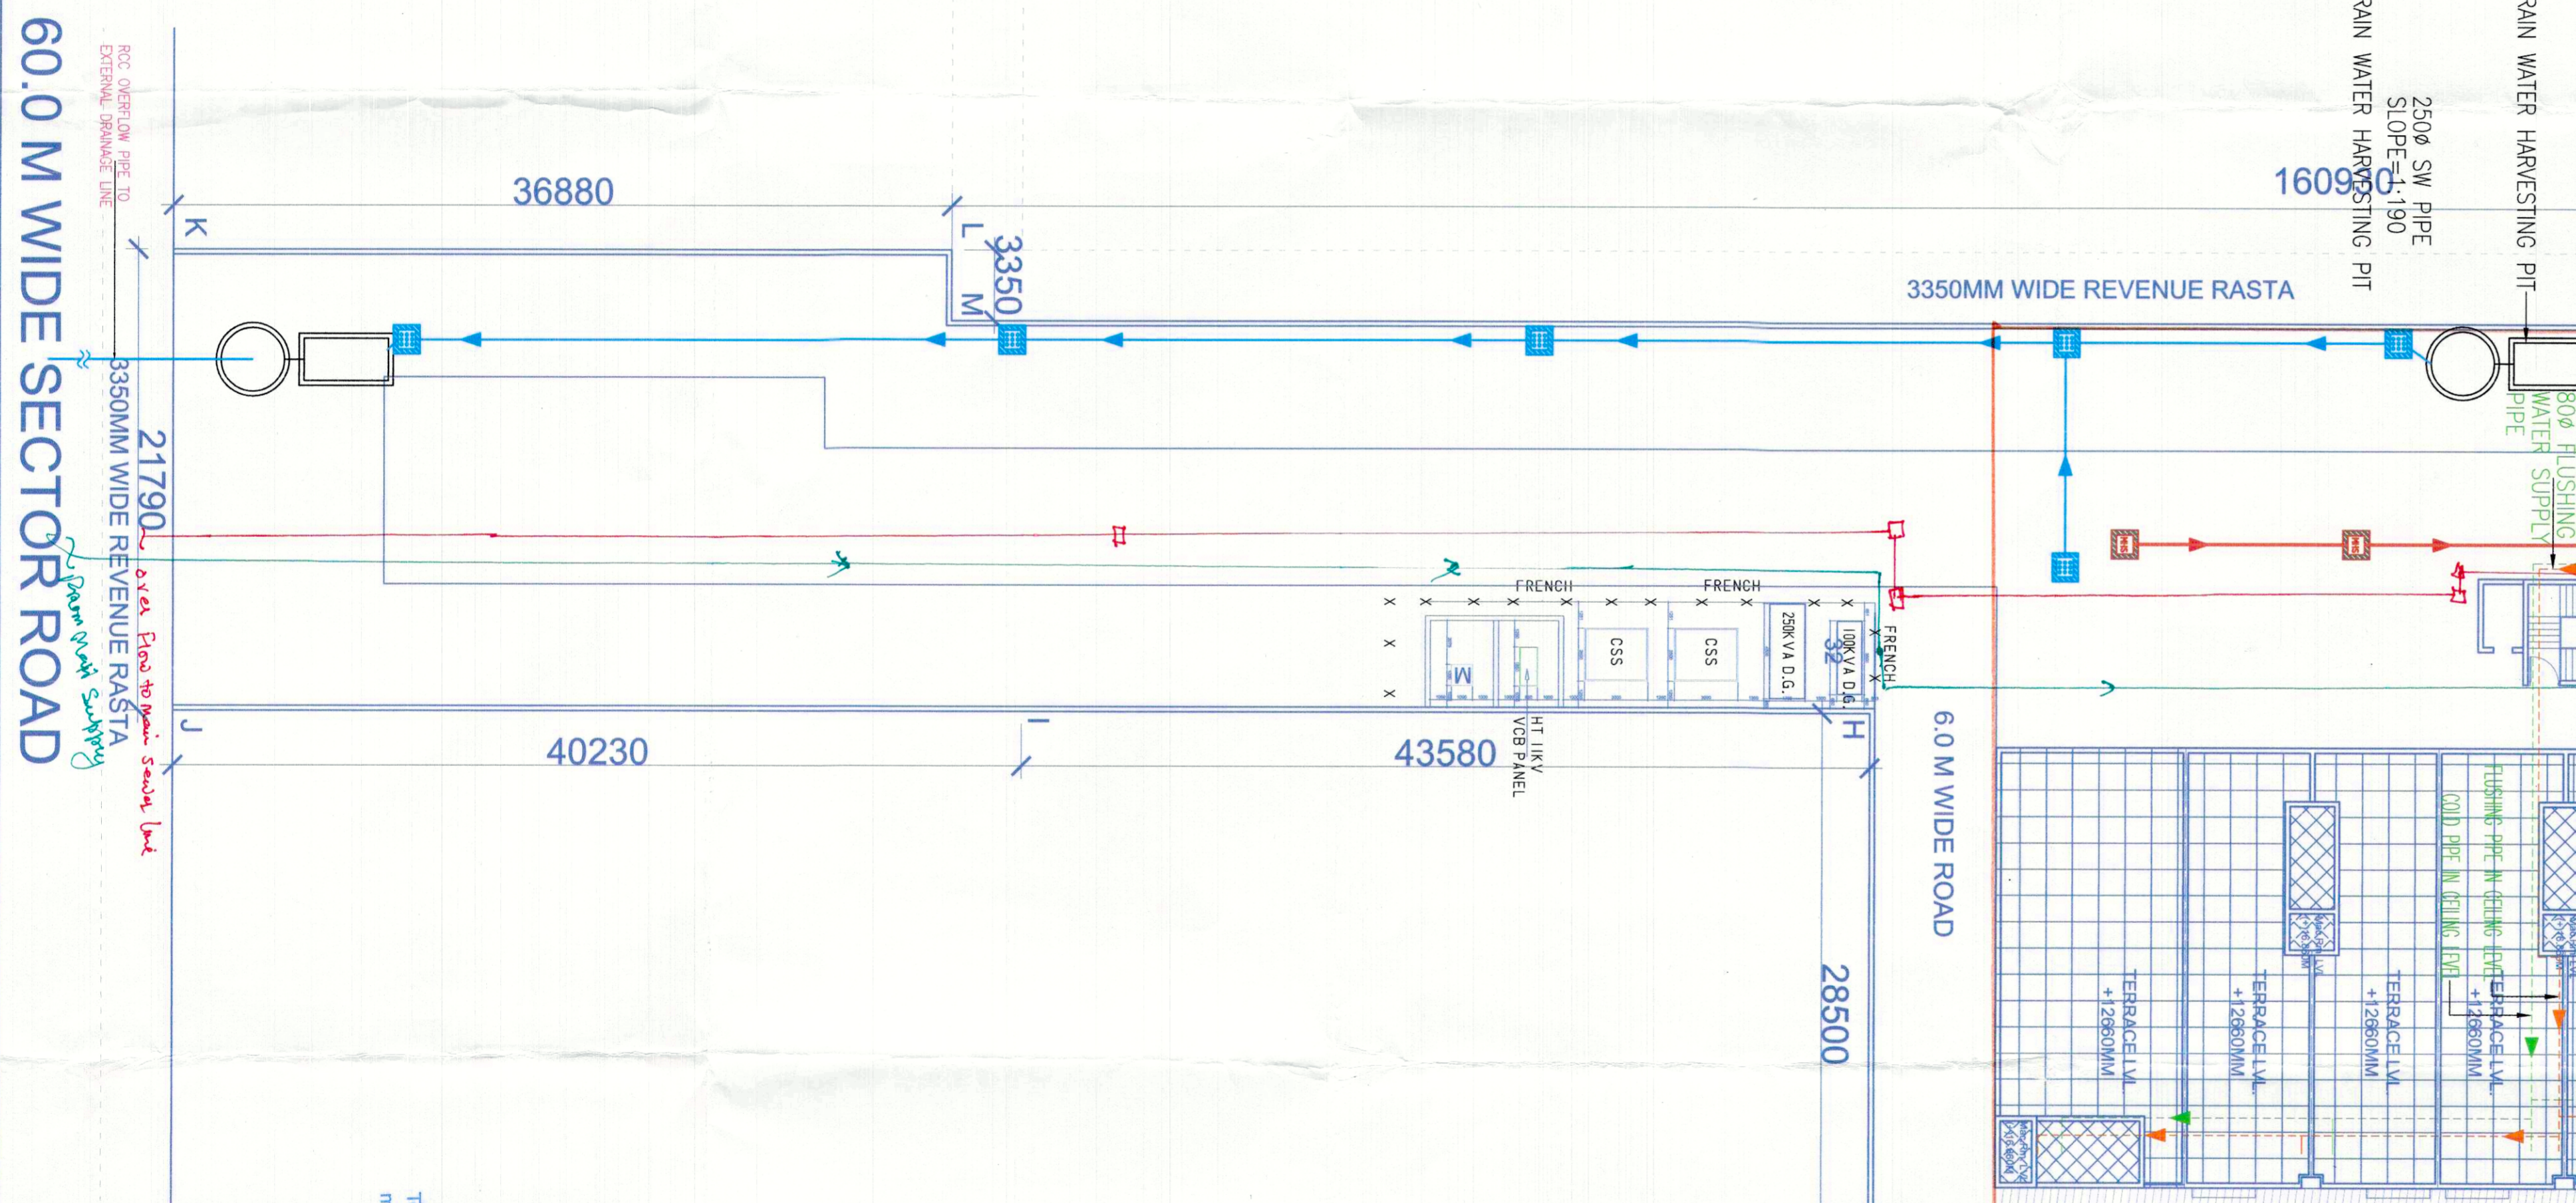

Checked and found ok for Public Health.  
 (Internal Service only subject to comments in forwarding letter No. SE/10/.../2016/11/16  
 S.D. Superintending Engineer (HO)  
 HUDA, Faridabad.

D. P. PAKRASHI  
 Public Secretary  
 Member & J.C.  
 Chairman B.P.C.

C. T. P. (H)  
 Chairman B.P.C.

To be read in conjunction with  
 memo no. 27934 dated 27/12/16

SANCTIONED

<b>JOB TITLE</b>	
BUILDING PLAN OF COMMERCIAL COLONY ON THE LAND MEASURING 2.725 ACRES IN SECTOR 79 FARIDABAD HARYANA M/s SUNRAV'S INFRASTRUCTURE PVT. LTD.	
<b>Architects</b>	
AAKRITI CONSTRUCTION CONSULTANT Architects, Engineers & Int. Designers SCF 218, First Floor, HUDA Market, Sector-9 Faridabad -121004 Ph. NO:- 0-9212209774, 0-99999104030	
<b>SHEET TITLE</b>	
SERVICES SITE PLAN	
north	
<b>deal by</b>	
scale 1:400	
date Aug-2016	
<b>Owners Sign.</b>	
Architects Sign.	
Aakriti Construction Consultants Pvt. Ltd. Faridabad, Haryana	