



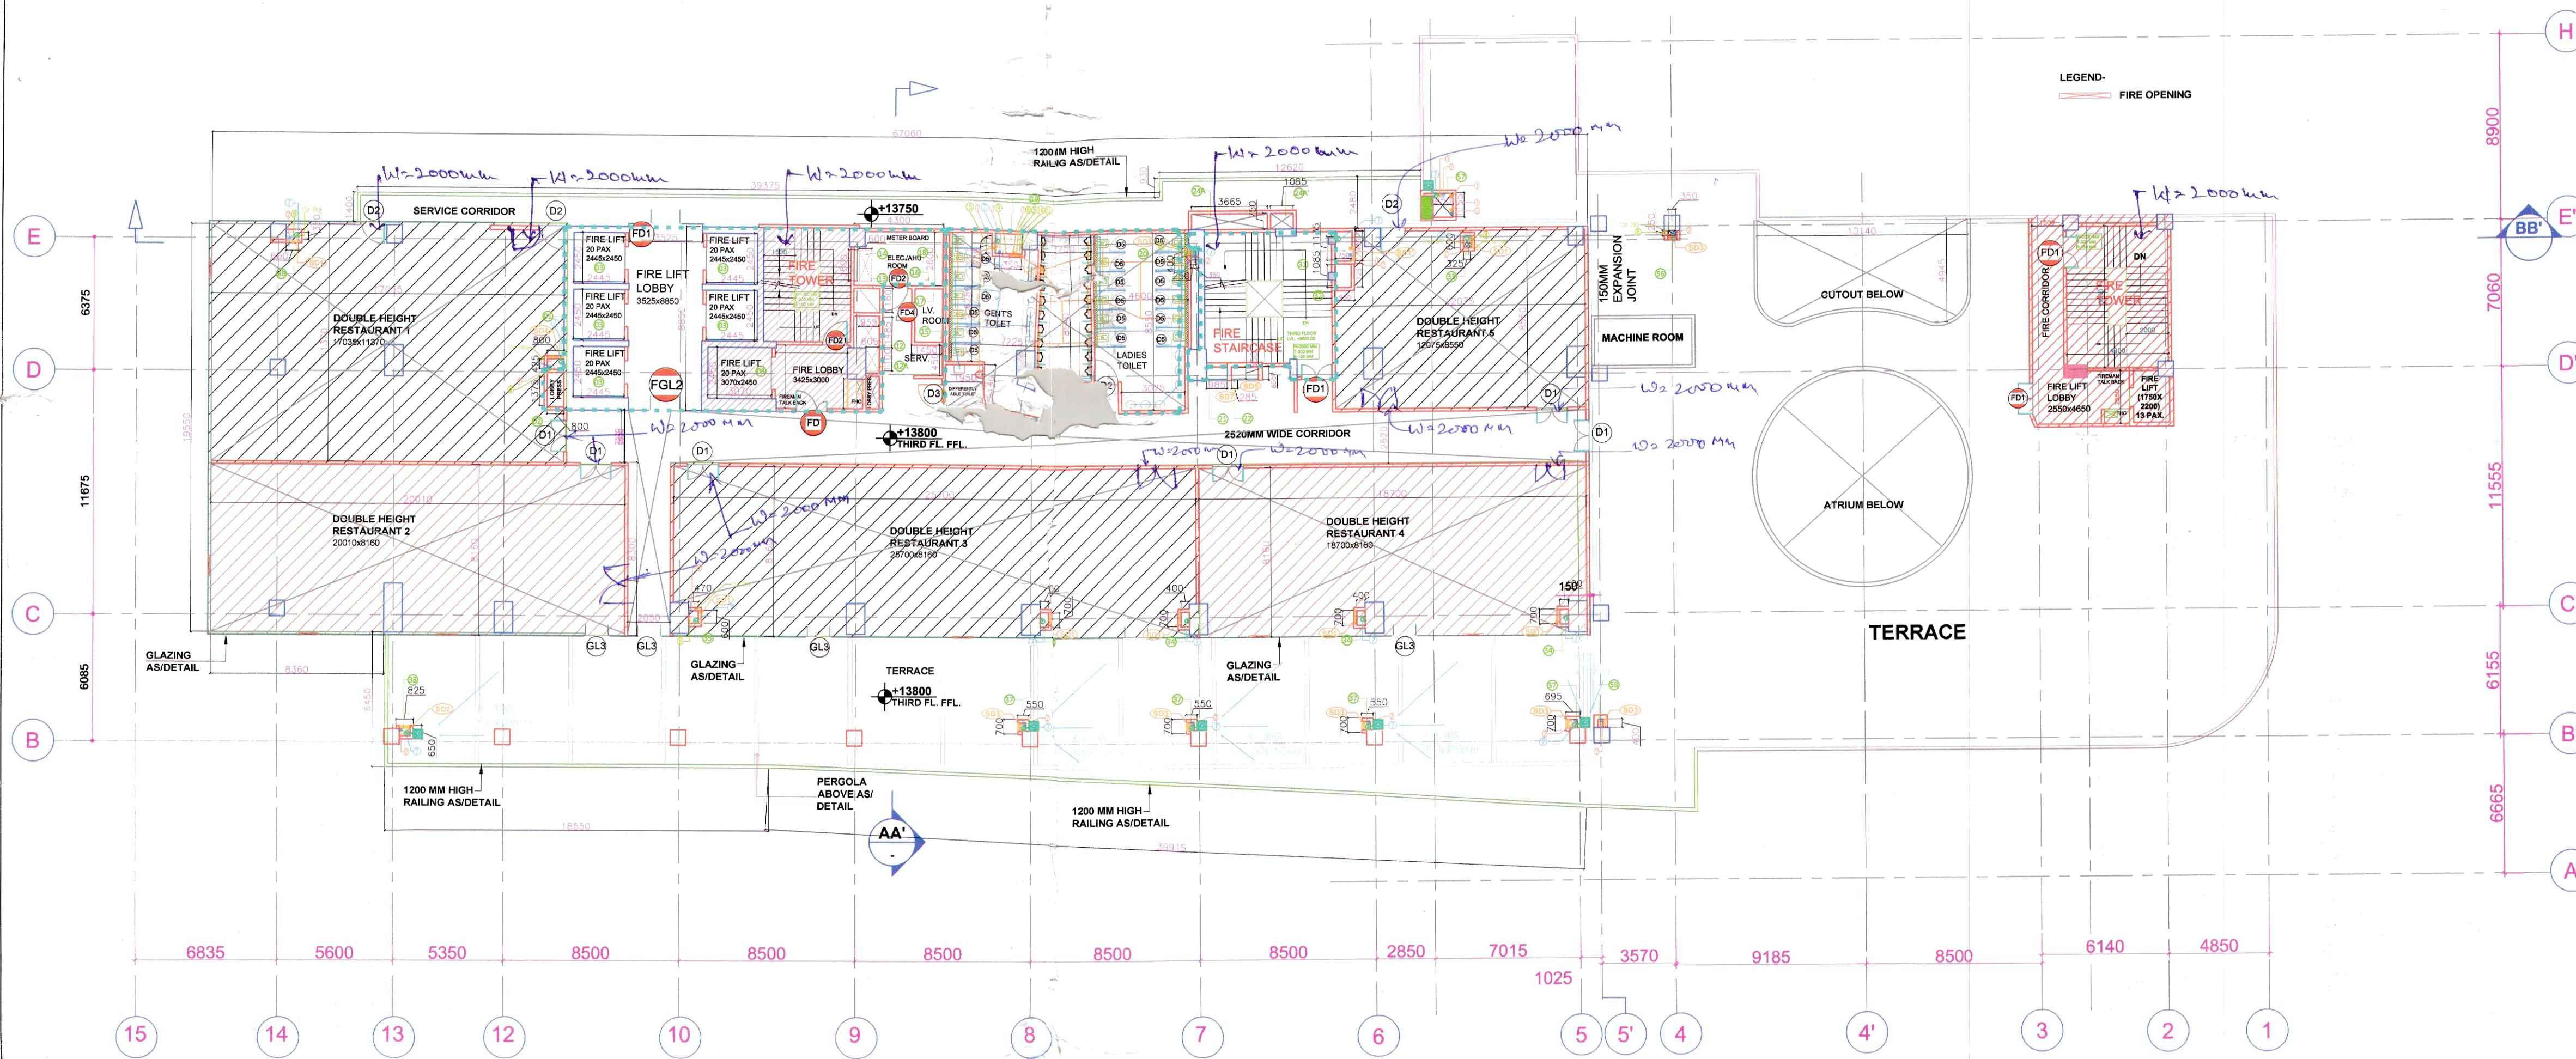

LEGEND	
1	110 ØØ SWR PVC SOIL & VENT PIPE
2	110 ØØ SWR PVC WASTE & VENT PIPE
3	DWS DN. TAKE PIPE (DOMESTIC) 100 TO 120 FLOOR
4	FWS DN. TAKE PIPE (DOMESTIC)
5	500 DWS RISER TO O.H.T. FILLING TANK
6	500 FWS RISER TO O.H.T. FILLING TANK
7	100 ØØ UPVC RAIN WATER PIPE
8	DWS RISER PIPE SHOPS & RESTAURANT
9	1000 DRAIN PIPE
10	DWS DN. TAKE PIPE (DOMESTIC) 110 TO 50 FLOOR
11	DWS DN. TAKE PIPE (DOMESTIC) 100 TO 100 FLOOR
12	DWS DN. TAKE PIPE (DOMESTIC) 100 TO GROUND FLOOR
13	FWS DN. TAKE PIPE (DOMESTIC) 100 TO 100 FLOOR
14	FWS DN. TAKE PIPE (DOMESTIC) 100 TO GROUND FLOOR
15	100 ØØ UPVC RAIN WATER PIPE
16	100 ØØ UPVC RAIN WATER PIPE
17	100 ØØ UPVC RAIN WATER PIPE
100	100 ØØ UPVC RAIN WATER PIPE

THIRD FLOOR PLAN
Scale: 1:200

NON FAR AREA

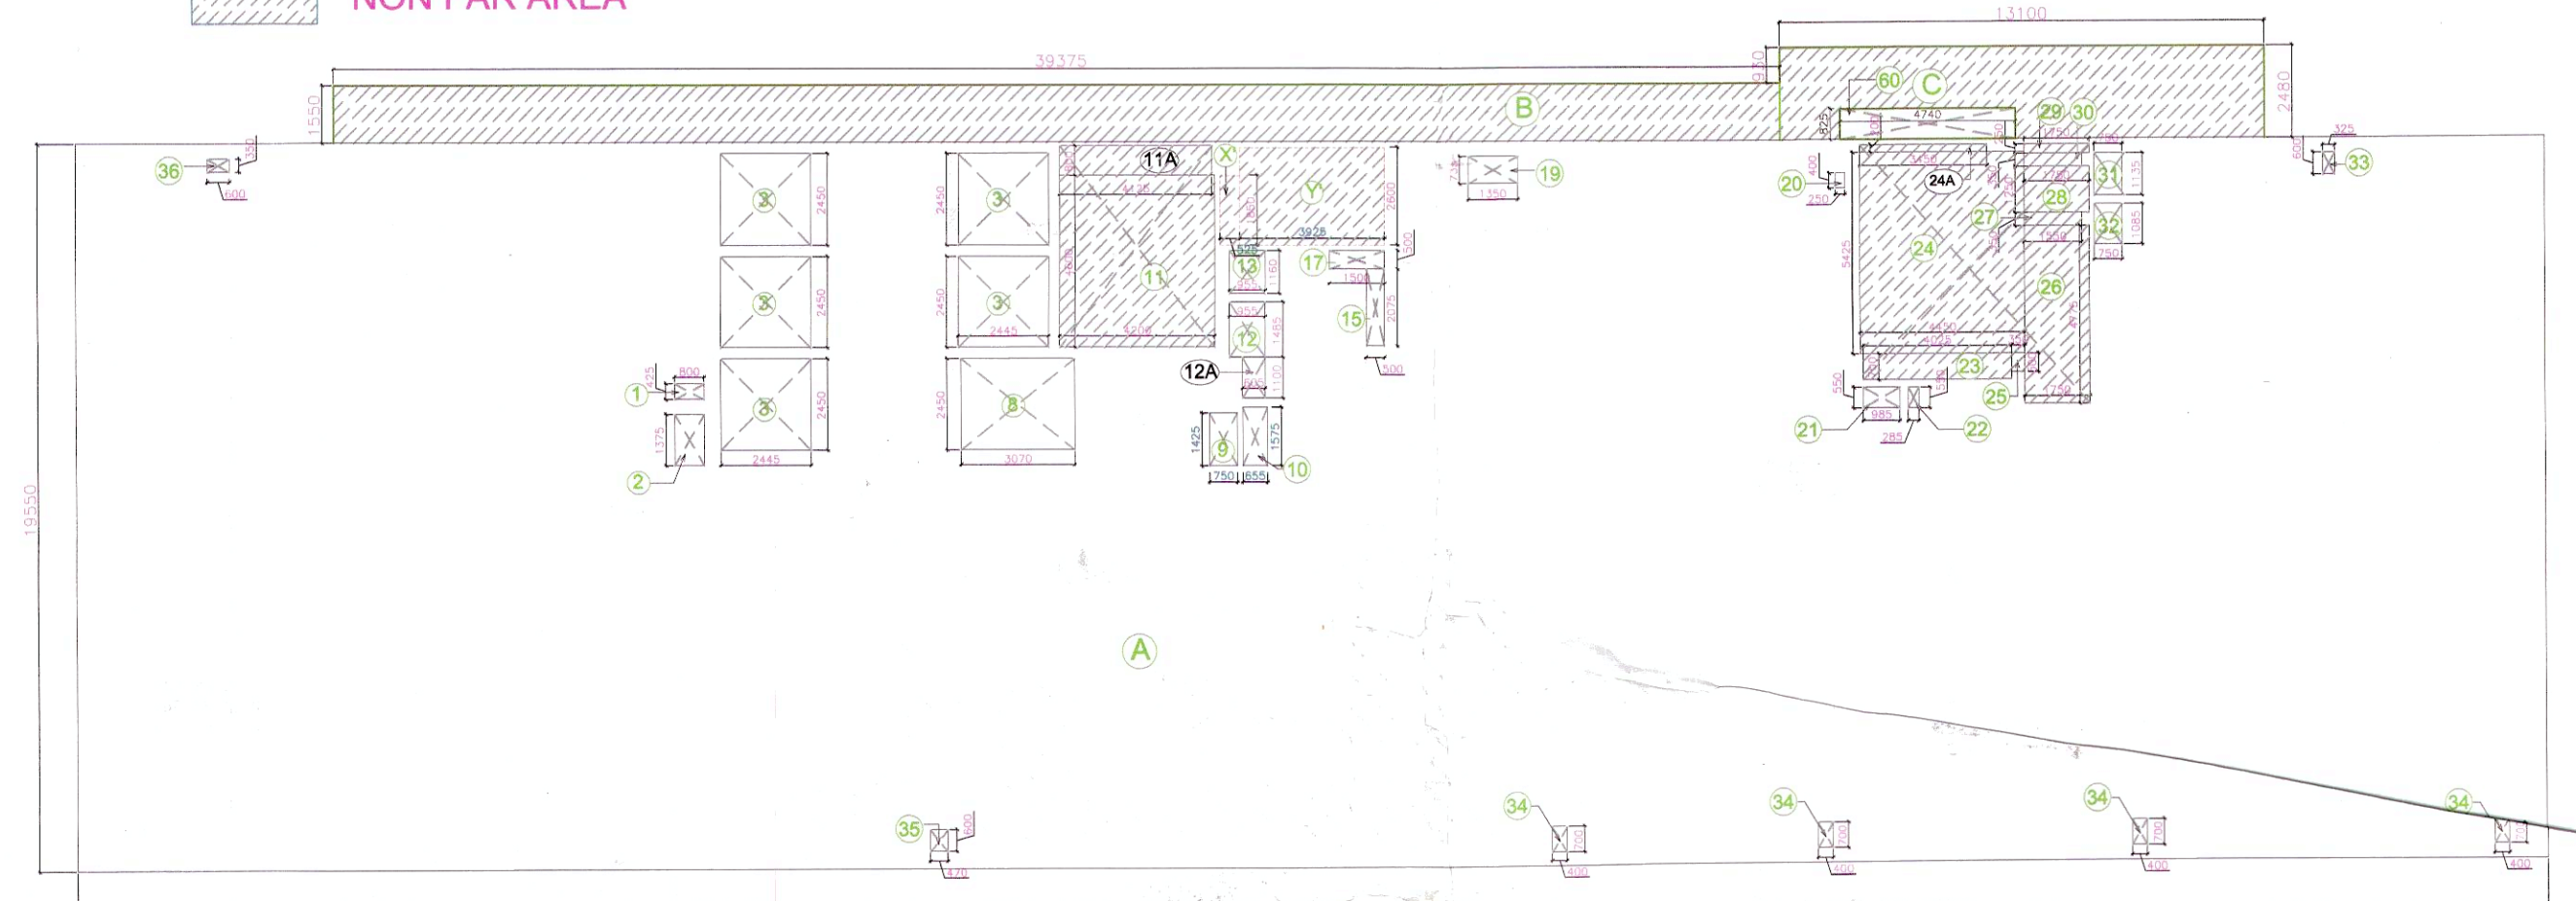

AREA PLAN (THIRD FLOOR)
Scale: 1:200

SCHEDULE OF OPENINGS

OPNG	WIDTH	CLEAR HEIGHT	CILL. LVL	LINTEL LEVEL
FD	1200	2400	-----	2400
FD1	1500	2400	-----	2400
FD2	1500	2400	-----	2400
FD4	1500	2400	-----	2400
D2	1050	2400	-----	2400
D3	1200	2400	-----	2400
D5	750	2100	-----	2100
FGL2	1500	2400	-----	-----
FGL3	3000	2400	-----	-----
V1	1500	600	2775	3375

SCHEDULE OF OPENINGS

OPNG	GF. QTY	WIDTH	CLEAR HEIGHT	CILL. LVL	LINTEL LEVEL
FD	1	1200	2400	-----	2400
FD1	2	1500	2400	-----	2400
D1	2	1500	2400	-----	2400
D2	3	1200	2400	-----	2400
D3	1	1200	2400	-----	2400
D4	1	900	2400	-----	2400
GL1	1	3000	2400	-----	-----
GL2	1	1500	2400	-----	-----

AREA CHART (Third Floor)

AREA	LENGTH	WIDTH	QTY	AREA
A) Area				
A	67.040 X	19.550	1 =	1310.632
B	39.375 X	1.550	1 =	61.031
C	13.100 X	2.480	1 =	32.488
Total area (sqm)				1404.151
B) Deductions				
1	0.800 X	0.425	1 =	0.340
2	0.800 X	1.375	1 =	1.100
3	2.445 X	2.450	5 =	29.951
8	3.070 X	2.450	1 =	7.522
9	0.750 X	1.425	1 =	1.069
10	0.655 X	1.575	1 =	1.032
12	0.955 X	1.485	1 =	1.418
12A	0.605 X	1.100	1 =	0.665
13	0.955 X	1.160	1 =	1.108
15	0.500 X	2.075	1 =	1.038
17	1.500 X	0.500	1 =	0.750
19	1.350 X	0.735	1 =	0.992
20	0.250 X	0.400	1 =	0.100
21	0.985 X	0.550	1 =	0.542
22	0.285 X	0.550	1 =	0.157
31	0.750 X	1.135	1 =	0.851
32	0.750 X	1.085	1 =	0.814
33	0.325 X	0.600	1 =	0.195
34	0.400 X	0.700	4 =	1.120
35	0.470 X	0.600	1 =	0.282
36	0.600 X	0.350	1 =	0.210
60	4.740 X	0.825	1 =	3.911
Total area (sqm)				55.165
C) Non FAR Area				
B	39.375 X	1.550	1 =	61.031
C	13.100 X	2.480	1 =	32.488
X	0.525 X	1.850	1 =	0.971
Y	3.925 X	2.600	1 =	10.205
11	4.200 X	4.600	1 =	19.320
11A	4.125 X	0.800	1 =	3.300
23	4.025 X	0.700	1 =	2.818
24	4.450 X	5.425	1 =	24.141
24A	3.450 X	0.200	1 =	0.690
25	0.350 X	0.500	1 =	0.175
26	1.750 X	4.775	1 =	8.356
27	1.550 X	0.350	1 =	0.543
28	1.750 X	1.250	1 =	2.188
29	1.750 X	0.250	1 =	0.438
30	1.550 X	0.350	1 =	0.543
Total area (sqm)				167.206
Total FAR area (sqm)				1181.780

A.D.F.O. (HQ)
DFS PKL
Member B.P.C.
Architect (HQ)

Checked and found ok for Public Health
(Internal) Service only subject to community in forwarding letter No. 38(110) D. 1/06/18
Superintending Engineer (HO)
HUDA, Panchkula

(RAM AVTAR BASSI)
A.D.
This is a PROVISIONAL APPROVED BUILDING PLAN
only for purpose of inviting
objection from the general public

Architect (HQ)
Directorate of Town and Country Planning,
Haryana, Chandigarh

CUTOUT OPENING SCHEDULE

S.NO	CUTOUT SIZE	NOS	DESCRIPTION
01	800 X 425	01	PLUMBING SHAFT
02	800 X 1375	01	LOBBY PRESS
03	2445 X 2450	05	PASS. FIRE LIFT SHAFT
08	3070 X 2450	01	SER. FIRE LIFT SHAFT
09	600 X 300	01	FHC SHAFT
10	1105 X 700	01	LOBBY PRESS
12	955 X 1485	01	HVAC SHAFT
12A	605 X 1100	01	HVAC SHAFT
13	955 X 1180	01	STAIR PRESS
14	600 X 1500	01	ELECTRICAL SHAFT
15	200 X 2045	01	LV SHAFT
16	1300 X 230	01	ELECTRICAL SHAFT
17	1000 X 200	01	LV SHAFT
18	200 X 1240	01	ELECTRICAL SHAFT
19	1350 X 735	01	PLUMBING SHAFT
20	250 X 400	01	PLUMBING SHAFT
21	985 X 550	01	ELECTRICAL SHAFT
22	285 X 550	01	FHC SHAFT
24A	3665 X 750	01	EXHAUST SHAFT
24A'	1085 X 750	01	COOLING TOWER SHAFT
31	800 X 1135	01	PLUMBING SHAFT
32	750 X 1085	01	STAIR PRESS
33	325 X 800	01	PLUMBING SHAFT
34	400 X 700	04	RWP SHAFT
35	470 X 800	01	PLUMBING SHAFT
36	600 X 550	01	PLUMBING SHAFT
37	200 X 400	04	PLUMBING SHAFT
38	525 X 350	01	PLUMBING SHAFT
56	400 X 250	01	PLUMBING SHAFT
57	1800 X 600	01	PLUMBING SHAFT
58	250 X 400	01	PLUMBING SHAFT

- NOTE:
- BUILDING IS FULLY AIR CONDITIONED & ALL BASEMENTS ARE MECHANICALLY VENTILATED AS PER NBC NORMS.
 - BUILDING IS FULLY SPRINKLERED AS PER NBC.
 - ALL DIMENSIONS AND LEVELS MARKED IN PLANS ARE IN MM.

Signatures:

Architect: *[Signature]*
ROHIT K. GULATI
ARCHITECT
CA/98/23842

Authorised Signatory: *[Signature]*
SHRIMAYA BUILDCON PVT. LTD.

Client: M/S SHRIMAYA BUILDCON PVT. LTD. & OTHERS.

Project Name: REVISED BUILDING PLAN FOR TOWER - C OF ADDITIONAL LICENSE AREA MEASURING 0.16625 ACRE (LICENSE NO - 83 OF 2014 DATED 09/08/2014) IN ALREADY LICENSED AREA OF COMMERCIAL COLONY MEASURING 8.237 ACRE (LICENSE NO. 102 OF 2008 DATED 15.05.2008) TOTAL AREA MEASURING 8.39325 ACRES IN SECTOR -109, GURGAON MANESAR URBAN COMPLEX BEING DEVELOPED BY SHIV SHAKTI ESTATES PVT. LTD. IN COLLABORATION WITH SHRIMAYA BUILDCON PVT. LTD.

Dr. title: THIRD FLOOR PLAN

North:-	Dealt by:	Revision Number:	Code:
		RO	
Checked by:	Issued For:	SANCTION	Scale: 1:200
Verified by:	Drawing Number:	NR-05	Date: 22-08-2017

Correction by me
[Signature]