
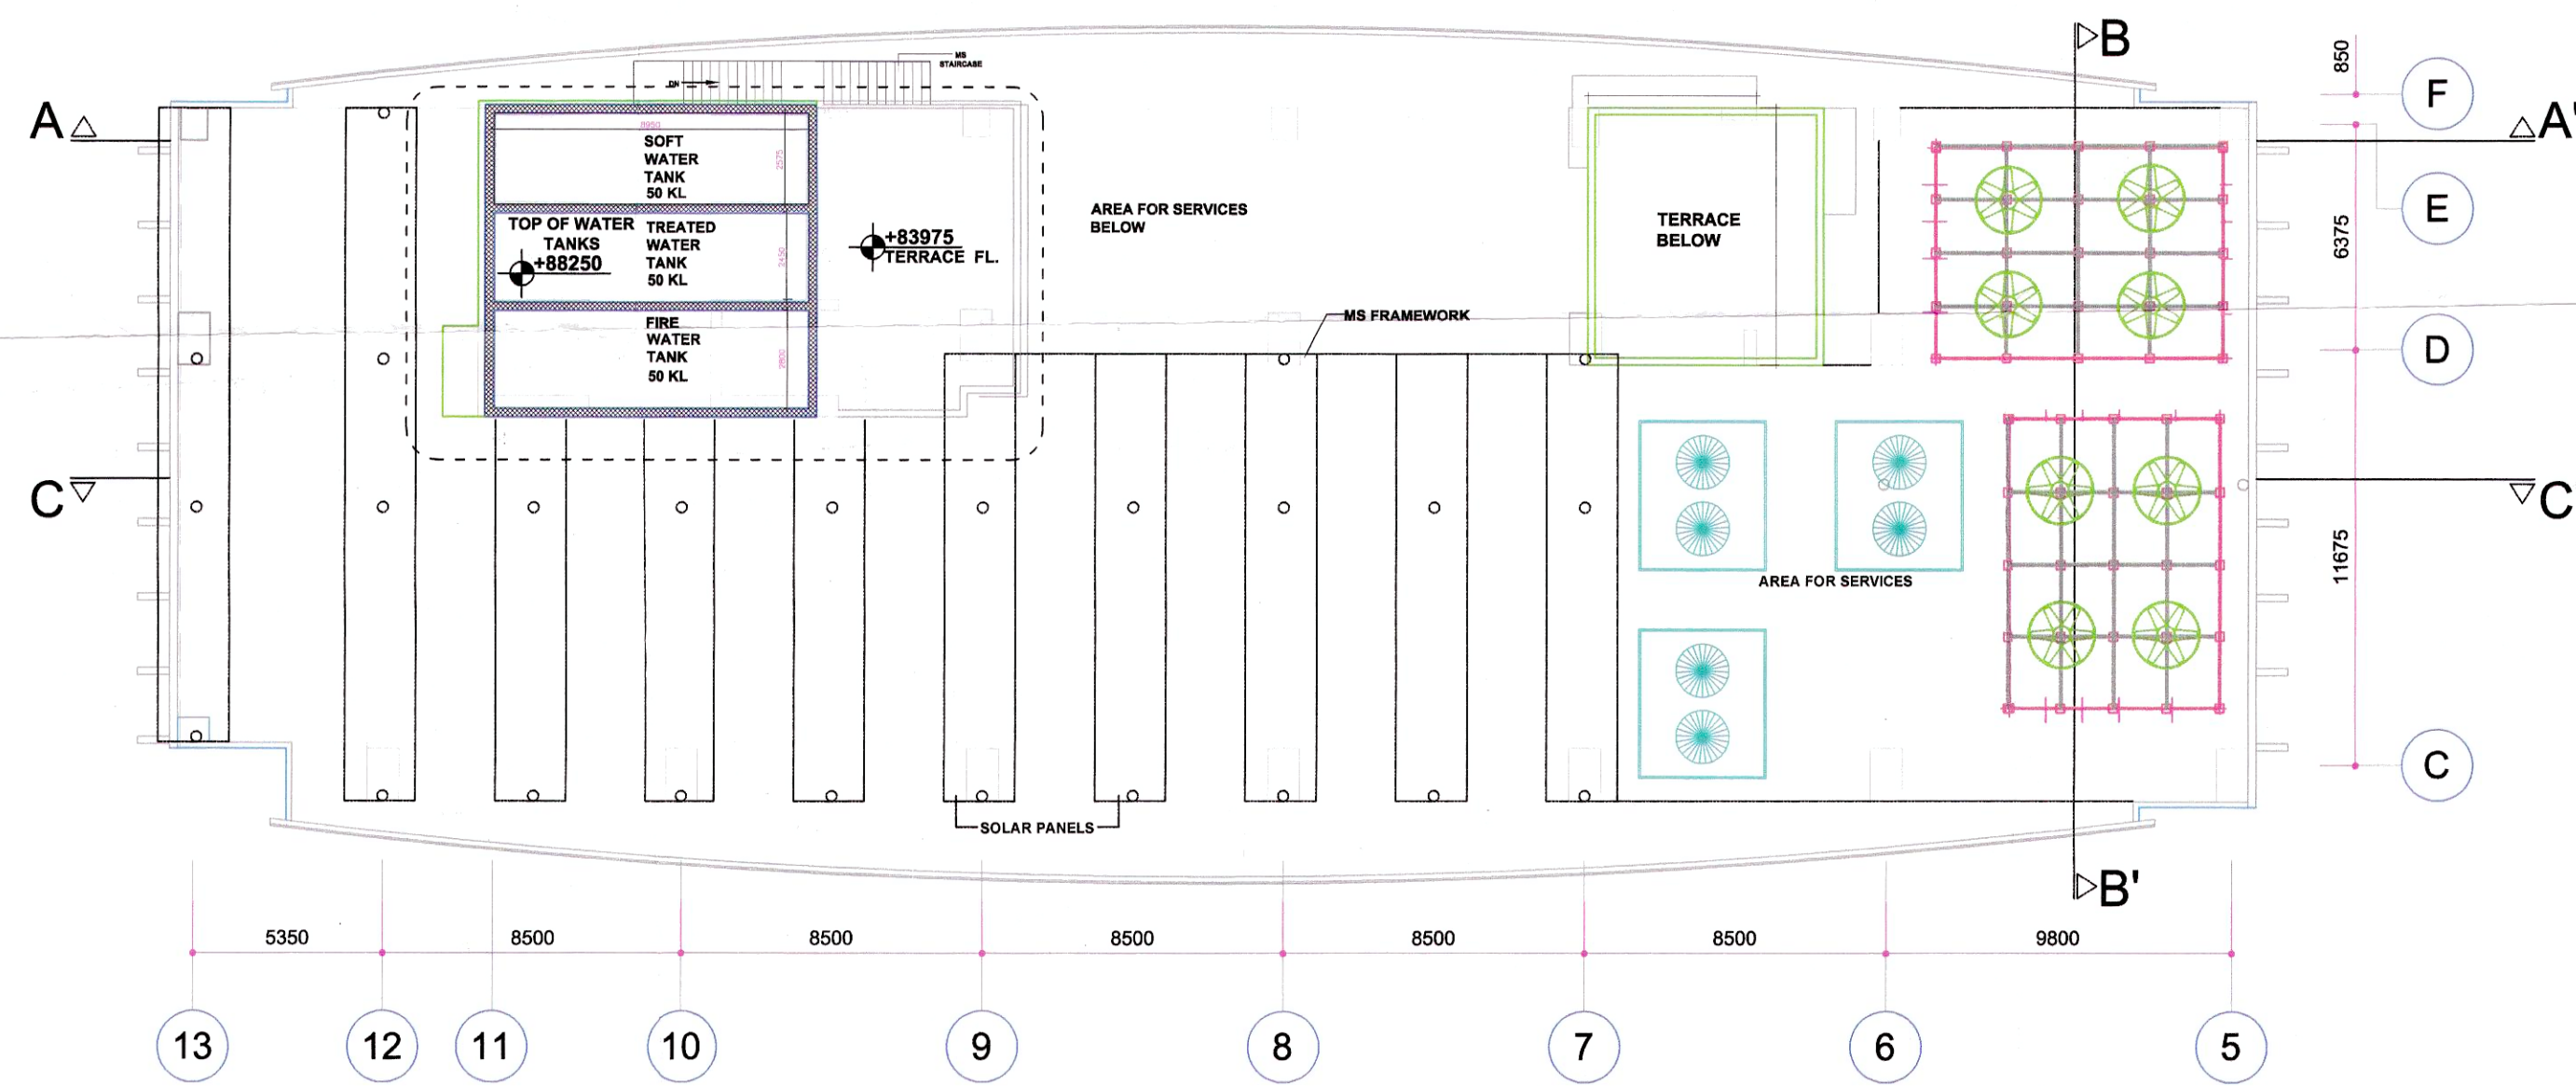
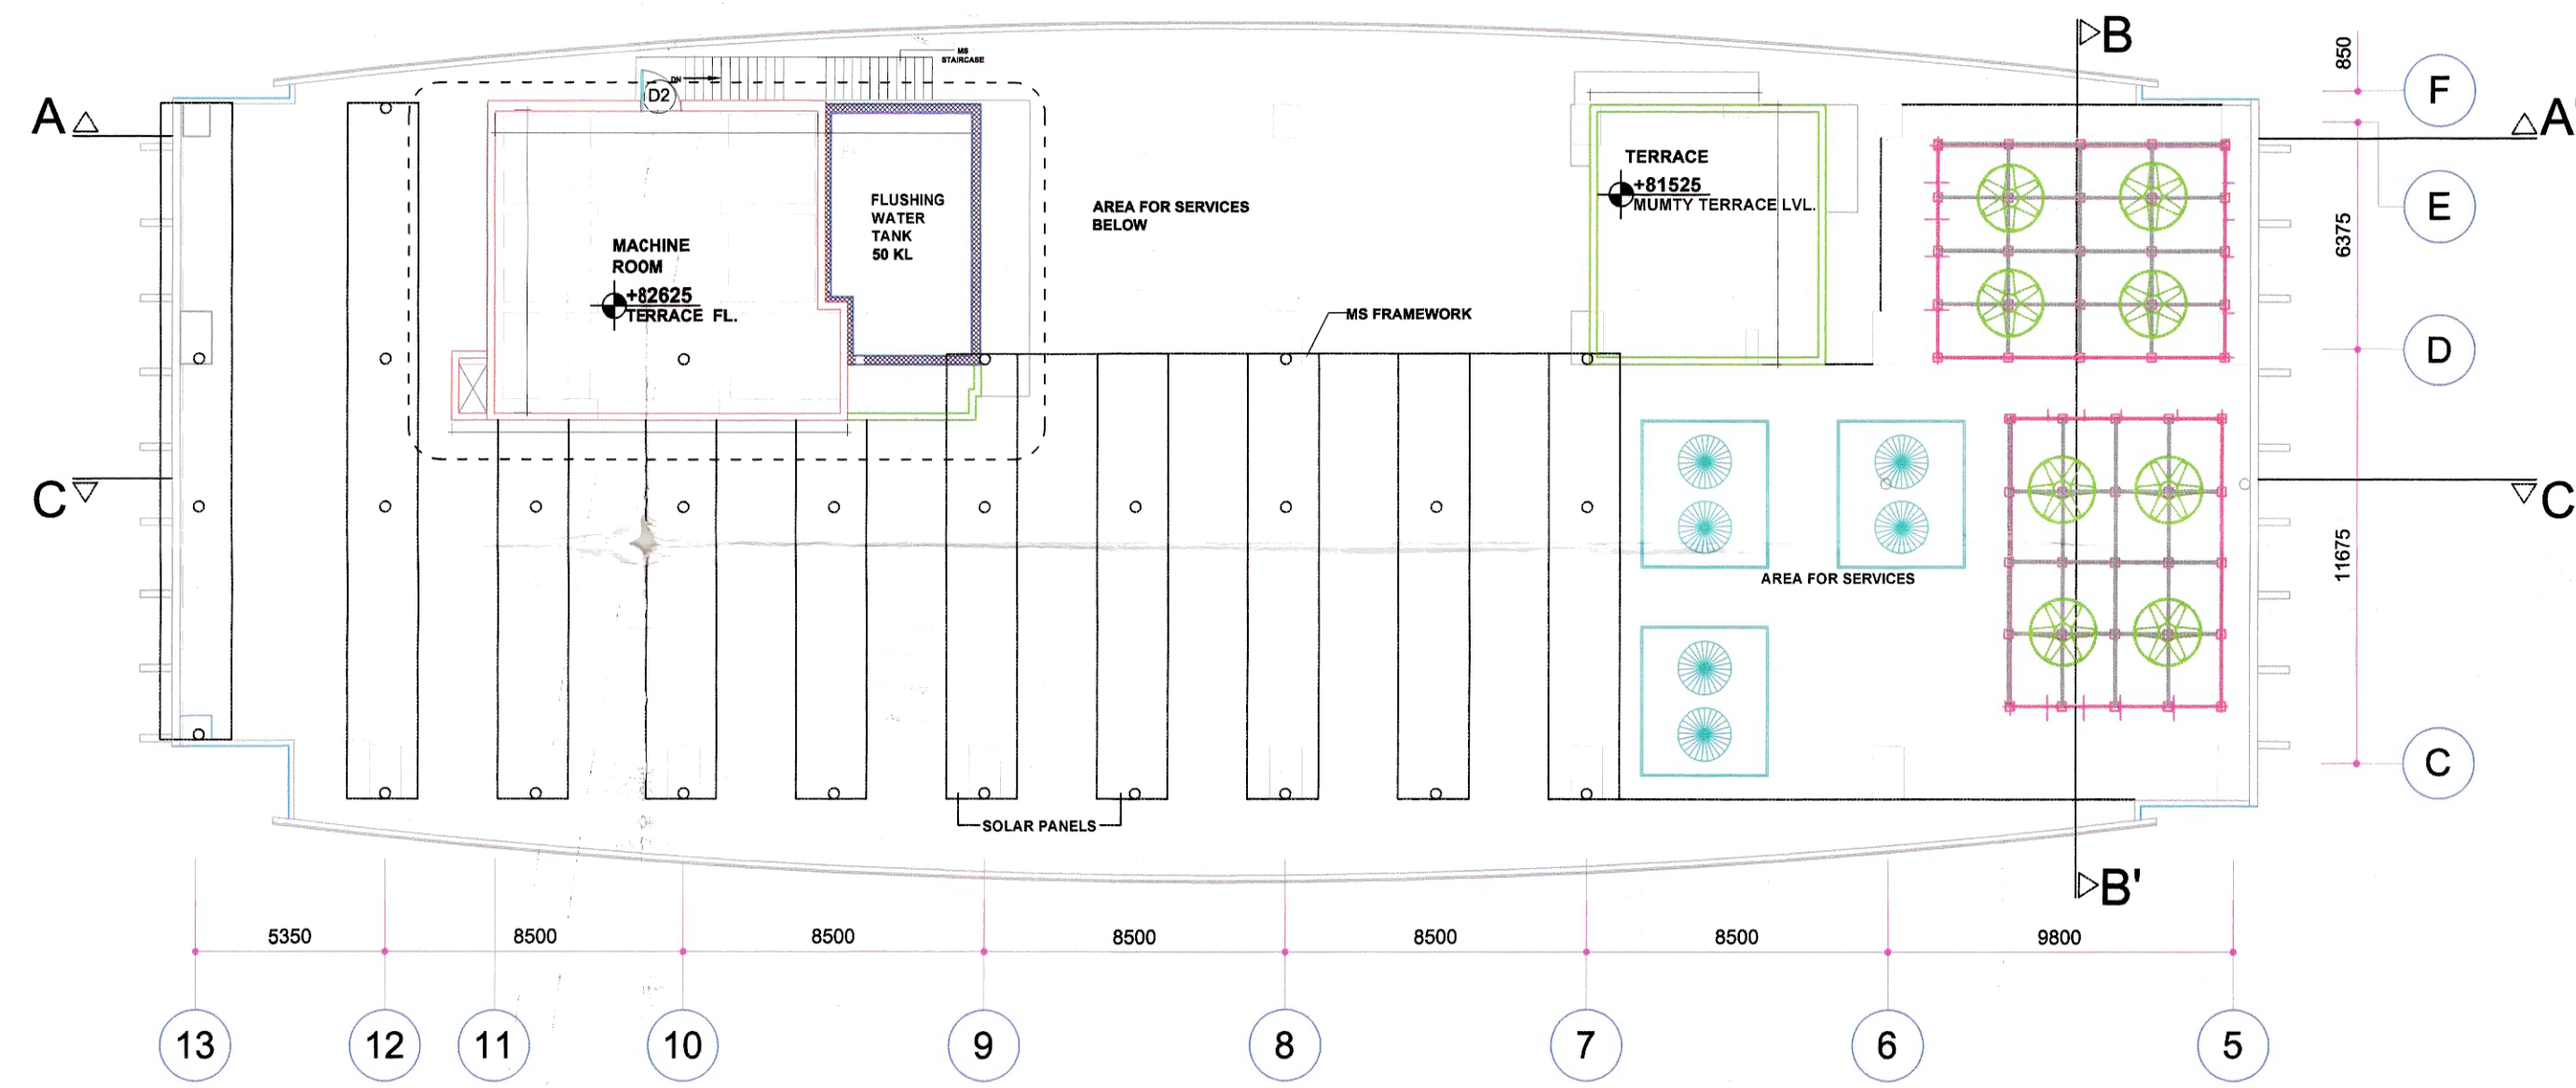


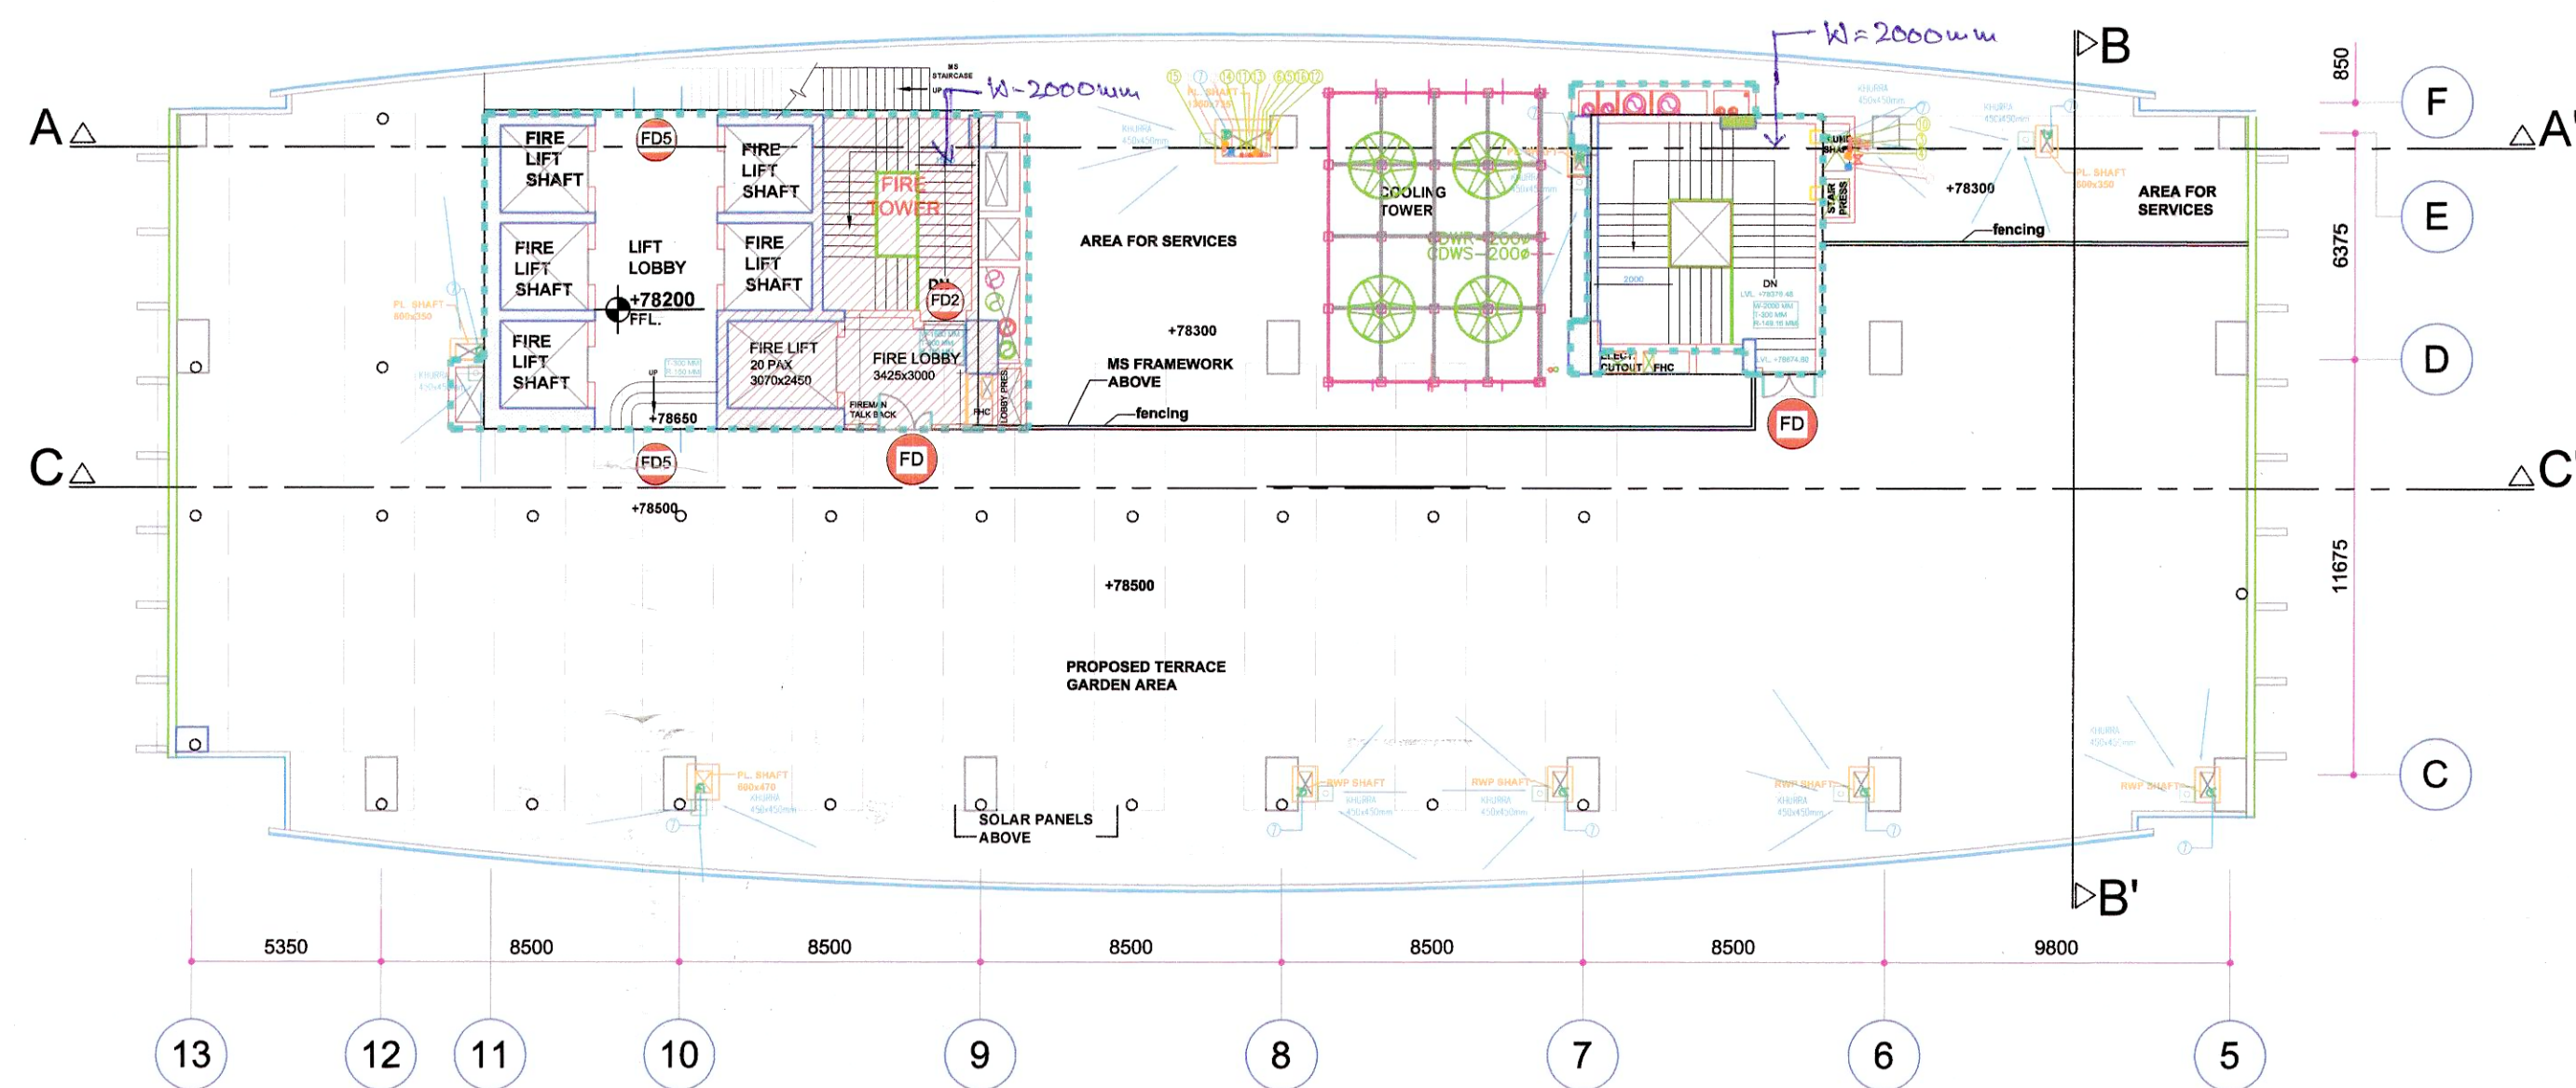

Architect (HQ)
A.D.F.O. (HQ)
DFS P.K.L.
Member B.P.C.

Checked and found ok for Public Health
only for purpose of inviting
objection from the general public

Superintending Engineer (HQ)
HUDA, Panchkula.

Architect (HQ)
Directorate of Town and Country Planning,
Haryana, Chandigarh

(RAM AVTAR BASSI)
A.D.

01/06/18

OPNG	WIDTH	CLEAR HEIGHT	CILL. LVL.	INT'L. LEVEL
FD	1500	2400	—	2400
FD1	1500	2400	—	2400
FD2	1200	2400	—	2400
FD4	900	2400	—	2400
FD5	1500	2400	—	2400
FD	1500	2400	—	2400
D2	1050	2400	—	2400
D3	1200	2400	—	2400
D4	900	2400	—	2400
D1	1500	2400	—	2400

NOTE: ALL LEVELS ARE FROM PFL LVL.

OPNG	WIDTH	CLEAR HEIGHT	CILL. LVL.	INT'L. LEVEL
S01	600	800	1900	2800
S01'	675	800	1900	2800
S02	525	800	1900	2800
S03	400	800	1900	2800
S04	800	800	1900	2800
S05	1400	2100	300	2400
S06	1500	2100	300	2400
S07	1000	2550	300	2950

NOTE: ALL LEVELS ARE FROM PFL LVL.

S.NO.	CUTOUT SIZE	NOS	DESCRIPTION
01	800 X 425	01	PLUMBING SHAFT
02	800 X 1275	01	LOBBY PRESS
03	2440 X 2450	05	PASS. FIRE LIFT SHAFT
06	3070 X 2450	01	SEER. FIRE LIFT SHAFT
09	800 X 300	01	PVC SHAFT
10	1105 X 750	01	LOBBY PRESS
12	955 X 1485	01	HVAC SHAFT
12A	805 X 1150	01	HVAC SHAFT
13	955 X 1150	01	STAIR PRESS
14	600 X 1500	01	ELECTRICAL SHAFT
15	200 X 2045	01	LV SHAFT
16	1300 X 230	01	ELECTRICAL SHAFT
17	1000 X 300	01	LV SHAFT
18	200 X 1240	01	ELECTRICAL SHAFT
19	1390 X 735	01	PLUMBING SHAFT
20	250 X 400	01	PLUMBING SHAFT
21	955 X 595	01	ELECTRICAL SHAFT
22	285 X 595	01	PVC SHAFT
24A	3055 X 750	01	DOWNST. SHAFT
24A'	1085 X 750	01	COOLING TOWER SHAFT
31	800 X 1135	01	PLUMBING SHAFT
32	750 X 1085	01	STAIR PRESS
33	325 X 600	01	PLUMBING SHAFT
34	400 X 700	04	RWP SHAFT
35	470 X 600	01	PLUMBING SHAFT

LEGEND
① 110.00 SWR PVC SOIL & VENT PIPE
② 110.00 SWR PVC WASTE & VENT PIPE
③ CWS DN. TAKE PIPE (DOMESTIC) 100 TO 12th FLOOR
④ FWS DN. TAKE PIPE (DOMESTIC)
⑤ 500 DWS RISER TO D.H.T. FILLING TANK
⑥ 500 FWS RISER TO D.H.T. FILLING TANK
⑦ 150.00 UPVC RAIN WATER PIPE
⑧ DWS RISER PIPE SHOPS & RESTAURANT
⑨ 1000 DRAIN PIPE
⑩ CWS DN. TAKE PIPE (DOMESTIC) 11th TO 5th FLOOR
⑪ CWS DN. TAKE PIPE (DOMESTIC) 10th TO 10th FLOOR
⑫ CWS DN. TAKE PIPE (DOMESTIC) 9th TO GROUND FLOOR
⑬ FWS DN. TAKE PIPE (DOMESTIC) 10th TO 10th FLOOR
⑭ FWS DN. TAKE PIPE (DOMESTIC) 9th TO GROUND FLOOR
⑮ 550.00 FWS WATER RISER TO D.H.T. FILLING TANK FROM PUMP ROOM
⑯ 550.00 FWS WATER RISER TO D.H.T. FILLING TANK FROM S.T.P.
⑰ CIP DRAIN POINT (CUTOUT 150x150mm)
CIP CLEAN OUT PLUG
FWS FLUSHING WATER SUPPLY
DWS DOMESTIC WATER SUPPLY

- NOTE:
- BUILDING IS FULLY AIR CONDITIONED & ALL BASEMENTS ARE MECHANICALLY VENTILATED AS PER NBC NORMS.
 - BUILDING IS FULLY SPRINKLERED AS PER NBC.
 - ALL DIMENSIONS AND LEVELS MARKED IN PLANS ARE IN MM.

Signatures:

Architect: *[Signature]* SHRIMAYA BUILDCON PVT. LTD.
On: *[Signature]* Authorised Signatory

Client: M/S SHRIMAYA BUILDCON PVT. LTD. & OTHERS.

Project Name: REVISED BUILDING PLAN FOR TOWER - C OF ADDITIONAL LICENSE AREA MEASURING 0.15625 ACRE (LICENSE NO. -83 OF 2014 DATED 09/09/2014) IN ALREADY LICENSED AREA OF COMMERCIAL COLONY MEASURING 8.237 ACRE (LICENSE NO. 102 OF 2008 DATED 15.05.2008) TOTAL AREA MEASURING 8.39325 ACRE IN SECTOR -109, GURGAON MANESAR URBAN COMPLEX BEING DEVELOPED BY SHIV SHAKTI ESTATES PVT. LTD. IN COLLABORATION WITH SHRIMAYA BUILDCON PVT. LTD.

Org. Title: TERRACE FLOOR PLAN

North:-	Dealt by:	Revision Number:	Code:
		RO	
Checked by:	Issued For:	Scale:	
	SANCTION	1:200	
Verified by:	Drawing Number:	Date:	
	AR-14	22-08-2017	

Correction by me
[Signature]