

Note :-

1. BUILDING WILL BE DESIGNED (STRUCTURES) AS PER RELEVANT IS CODES FOR EARTH QUAKE RESISTANCE.

2. TOILETS WILL NATURAL VENTILATION WILL HAVE MECHANICAL VENTILATION

LEGEND:-

Project:

PROPOSED GROUP HOUSING MEASURING 10.43125 ACRES (LICENCE NO. 65 OF 2013 DATED 20-07-2013) & (LICENCE NO. 119 OF 2012 DATED 06.12.2012) IN SECTOR-99, GURGAON MANESAR URBAN COMPLEX BEING DEVELOPED BY PLANET EARTH ESTATES PVT. LTD.

Associate Architects

RISMS
ARCHITECTS

RSMS ARCHITECTS PVT. LTD.
69,Nora Niwas, Bhawani Kunj
(Behind D2), Vasant Kunj,
New Delhi-110070.
Tel.: 011-26898616, 26898617
www.rsms-arch.com

Checked & Approved for
(Internal) By
(External) By
Signature
Date
12/12/14

Signature
Date
12/12/14

ARCHITECT'S SEAL
& SIGNATURE

OWNER'S SEAL
& SIGNATURE



For Planet Earth Estates Pvt. Ltd.
Authorised Signatory

DECEMBER.2013

Scale : 1:100

N

Drawing Title:-


Drawing No:-

TERRACE & WATER TANK
& ROOF PLAN


Block-02

Block-K

VATIKA -
SOVEREIGN PARK

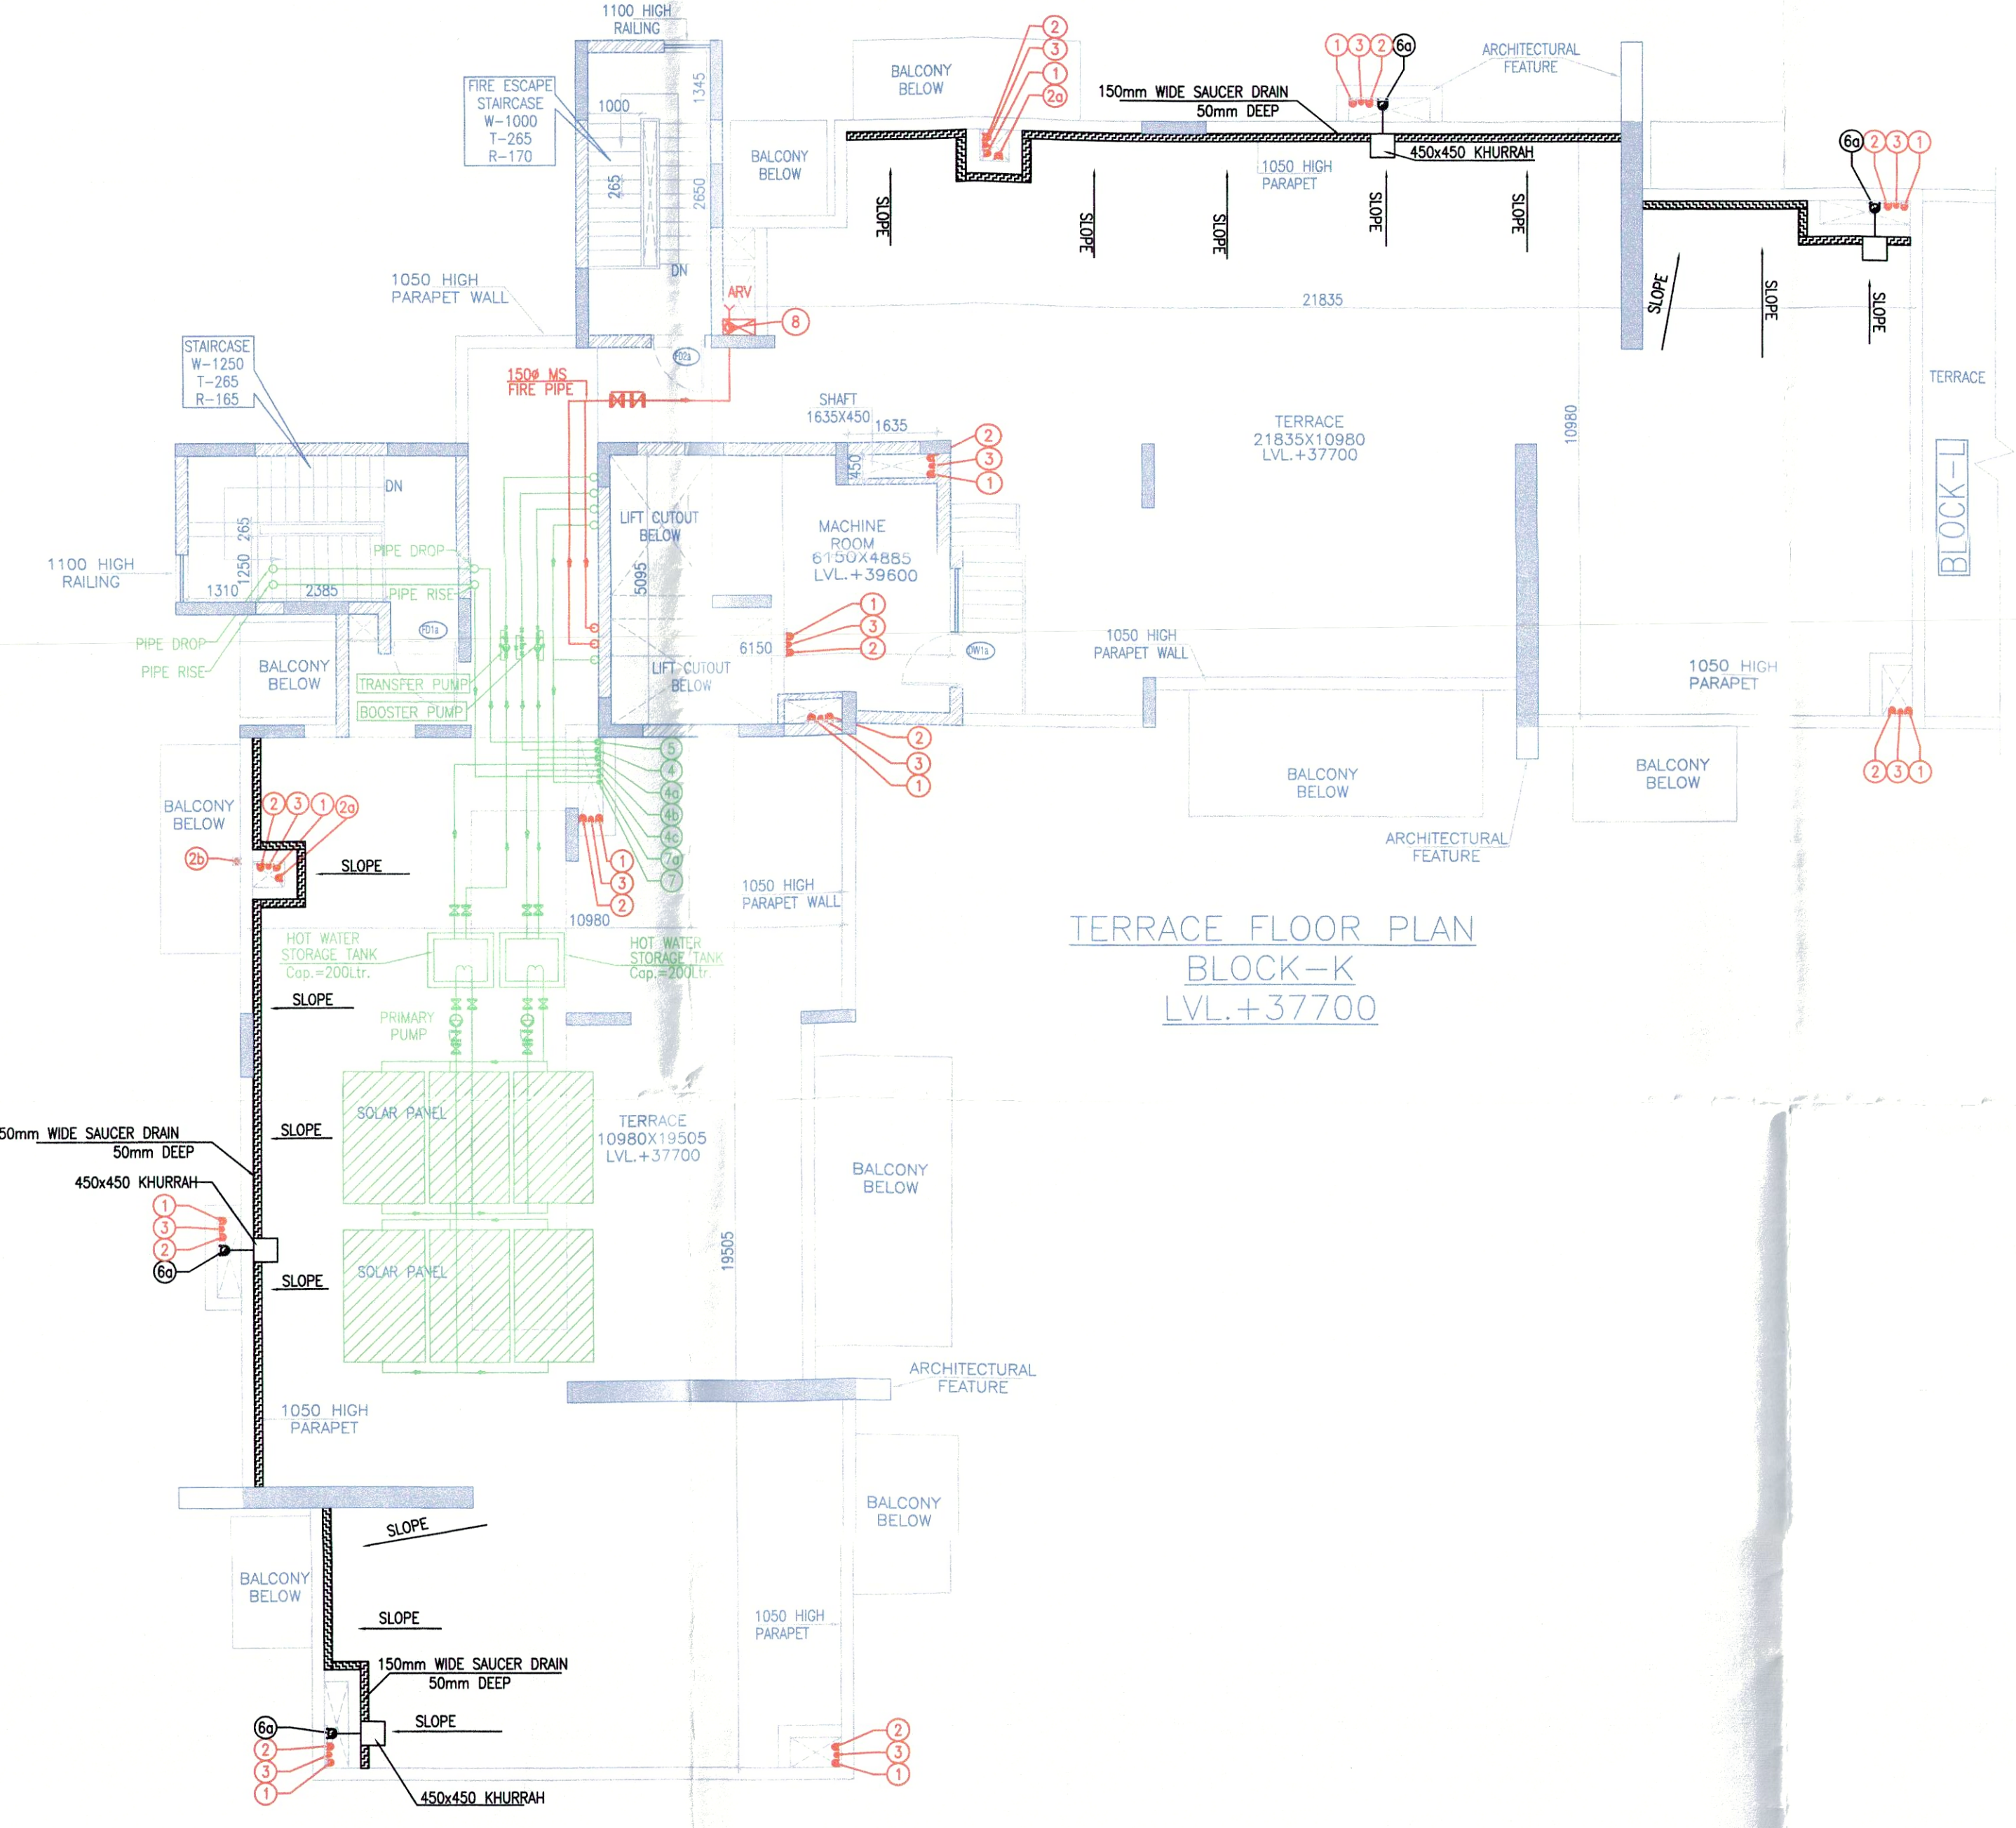

TERRACE FLOOR PLAN
BLOCK-K
LVL.+37700

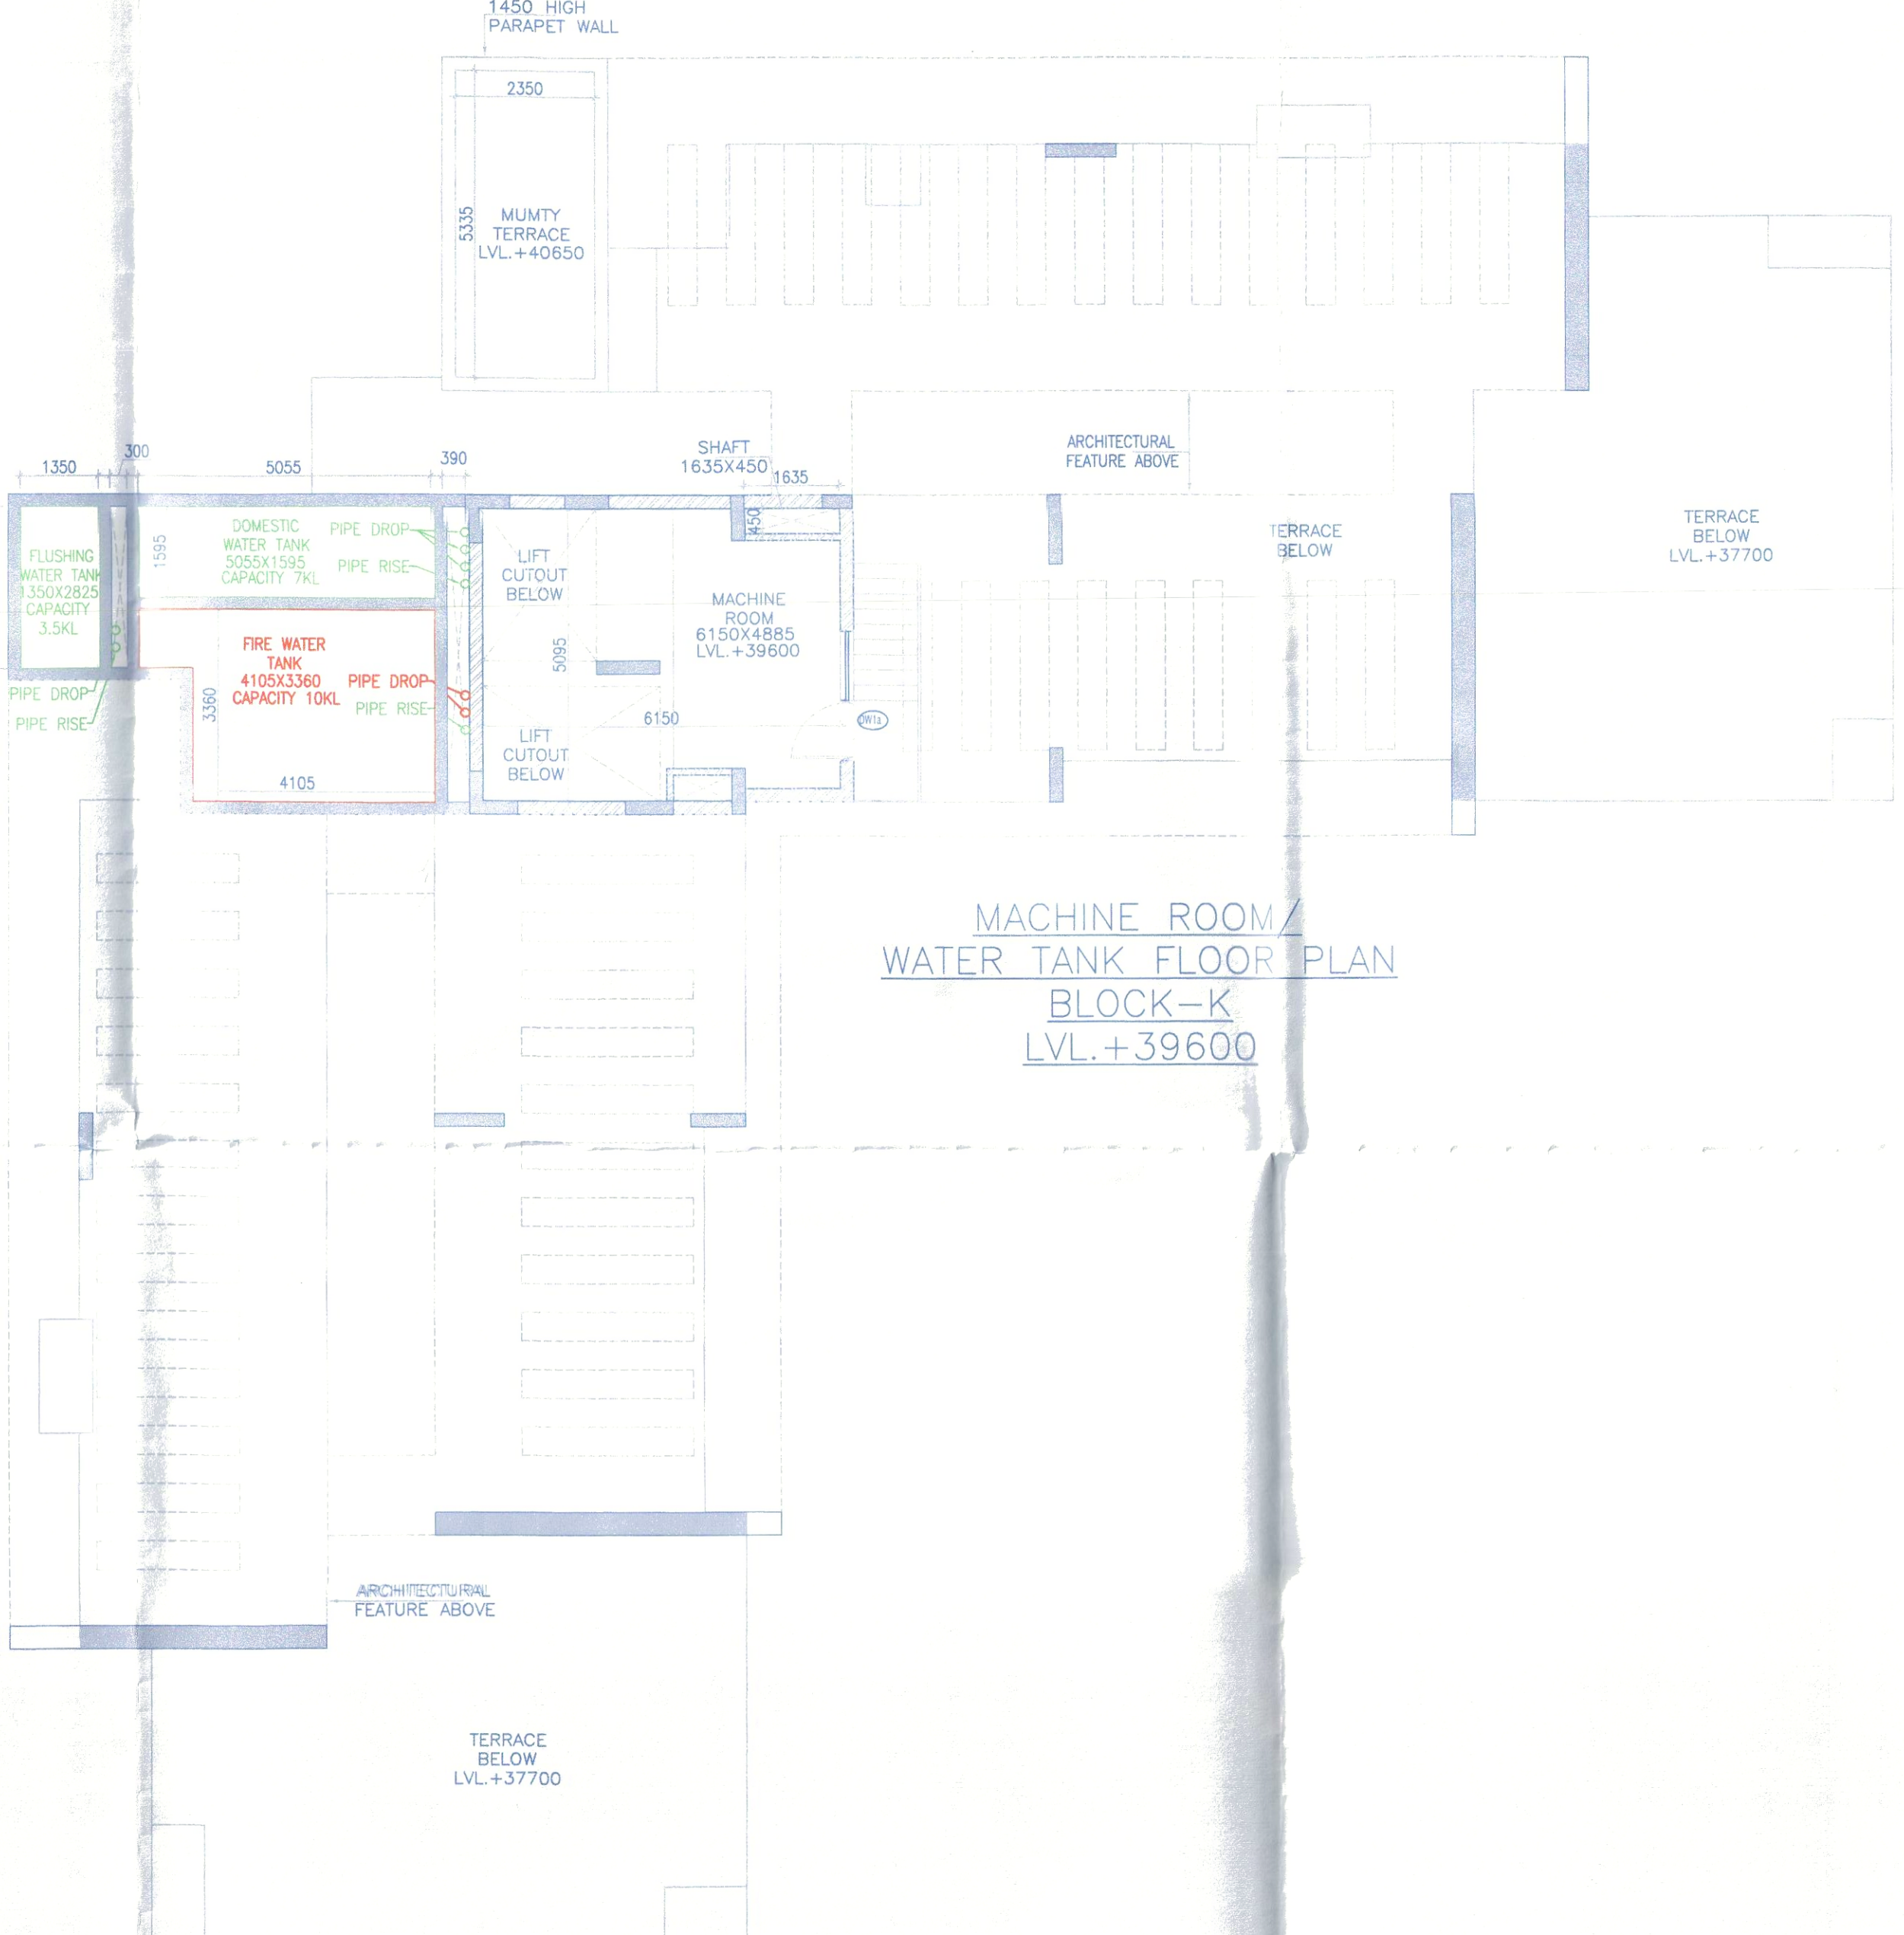

MACHINE ROOM /
WATER TANK FLOOR PLAN
BLOCK-K
LVL.+39600

LEGEND FOR VERTICAL PIPES:-	
①	100Ø SOIL & VENT PIPE
②	100Ø WASTE & VENT PIPE
③	100Ø WASTE PIPE FOR KITCHEN
④	100Ø UTILITY DRAIN PIPE
⑤	75Ø ANTISYPHONAGE VENT PIPE
⑥	COLD WATER SUPPLY(DOMESTIC) FOR LOW ZONE
⑦	COLD WATER SUPPLY(DOMESTIC) FOR UPPER ZONE
⑧	HOT WATER SUPPLY FOR LOWER FLOOR(KITCHEN)
⑨	HOT WATER SUPPLY FOR UPPER FLOOR(KITCHEN)
⑩	COLD WATER SUPPLY(FLUSHING)
⑪	75Ø BALCONY RAIN WATER PIPE
⑫	150Ø RAIN WATER PIPE
⑬	50Ø DOMESTIC WATER RISER
⑭	40Ø FLUSHING WATER RISER
⑮	150Ø M.S FIRE PIPE
⑯	80Ø M.S DRAIN PIPE
⑰	150Ø M.S SPRINKLER RISER
FHC	FIRE HOSE CABINET



ROOF PLAN
TOWER-K
LVL.+43150