
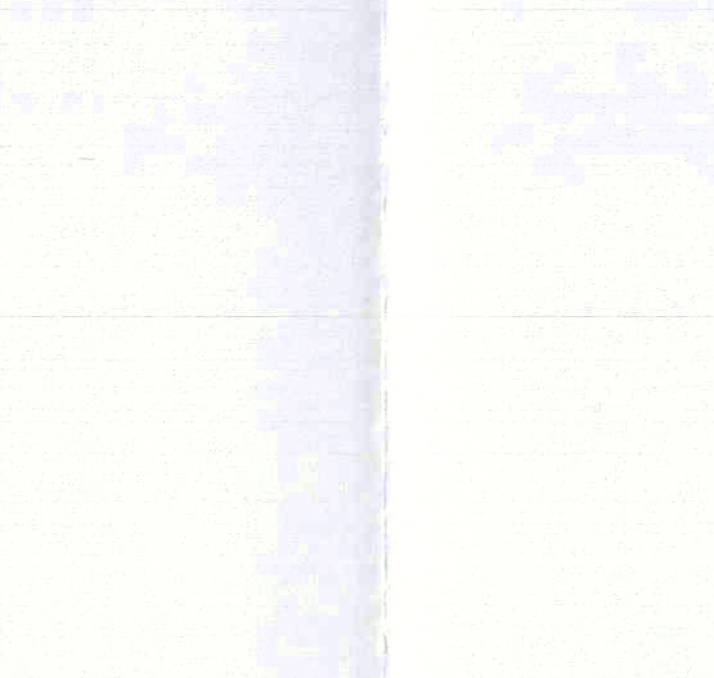
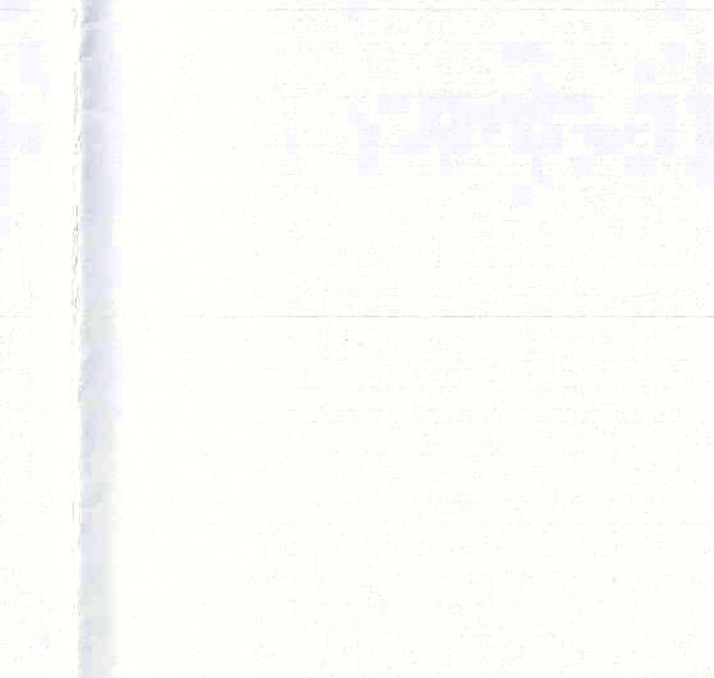
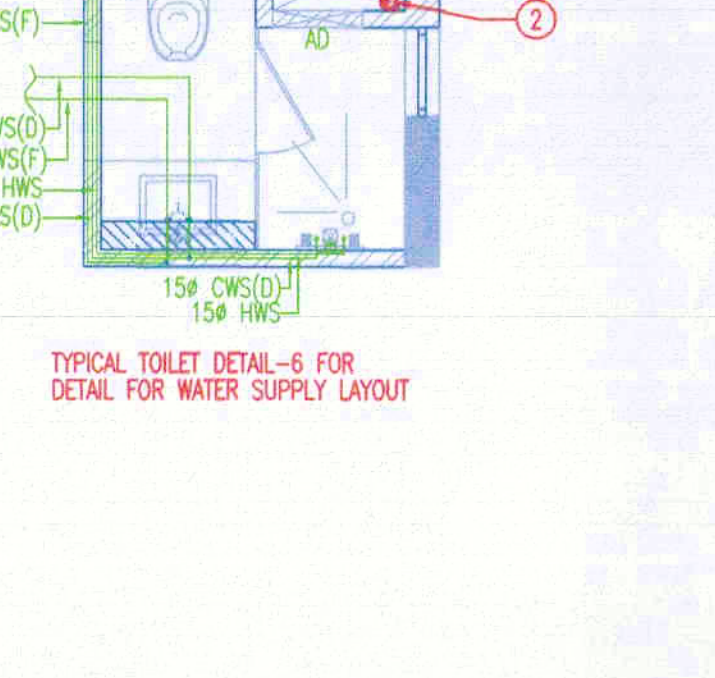
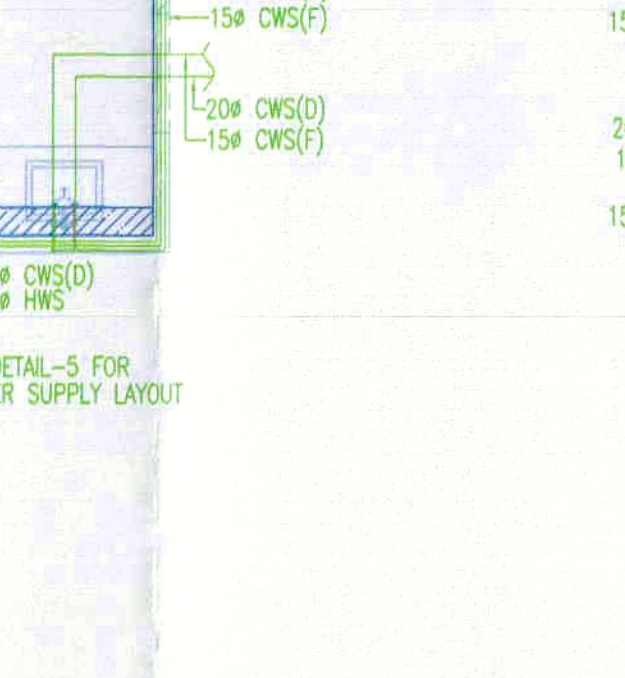
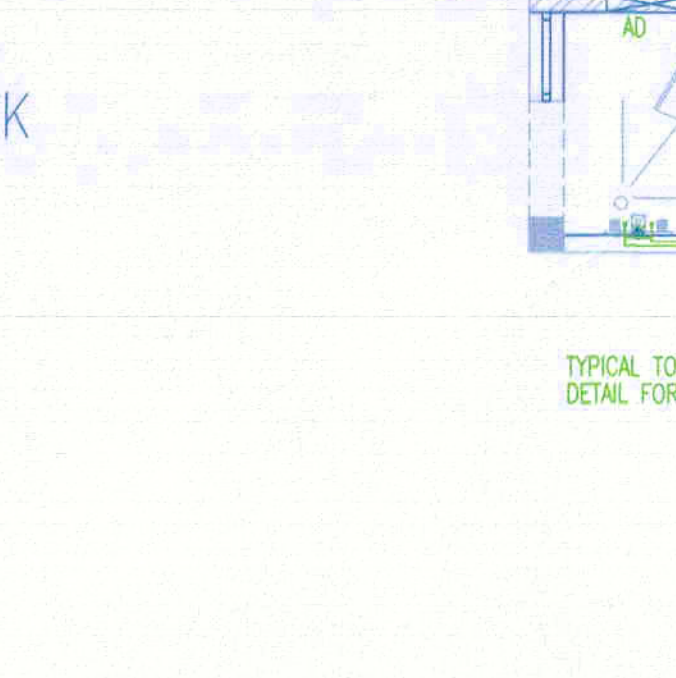
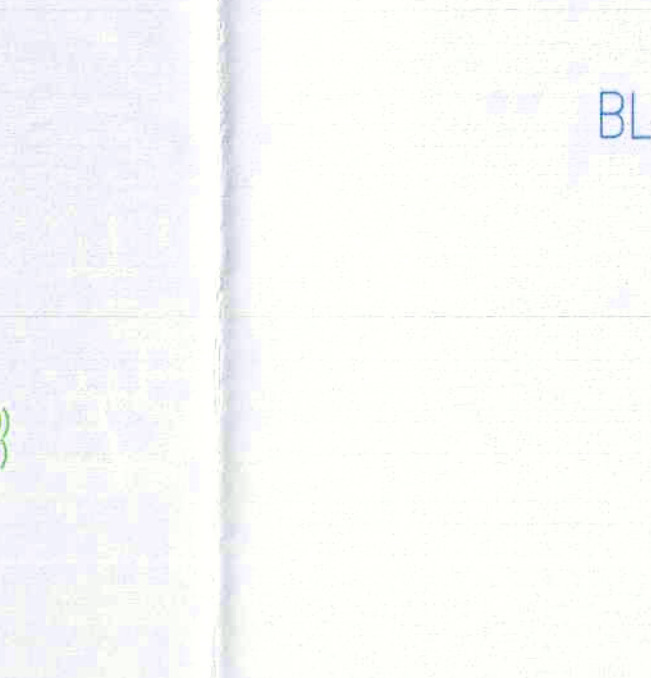
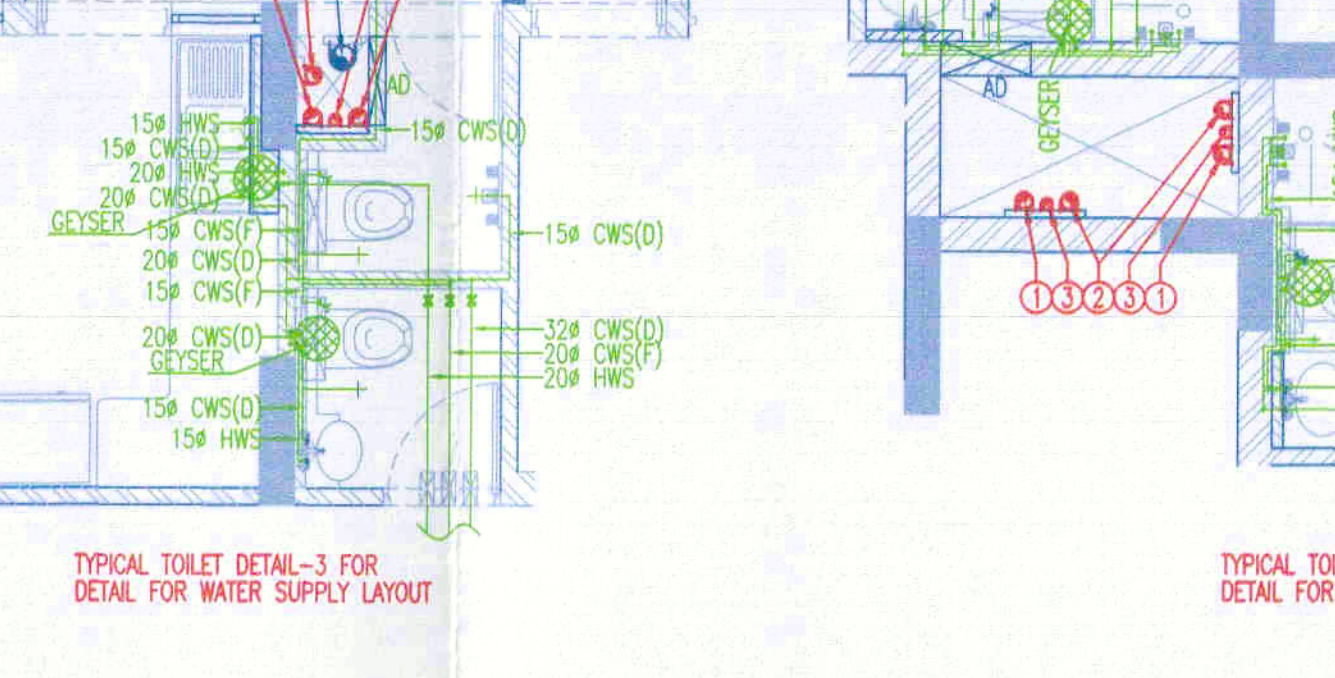
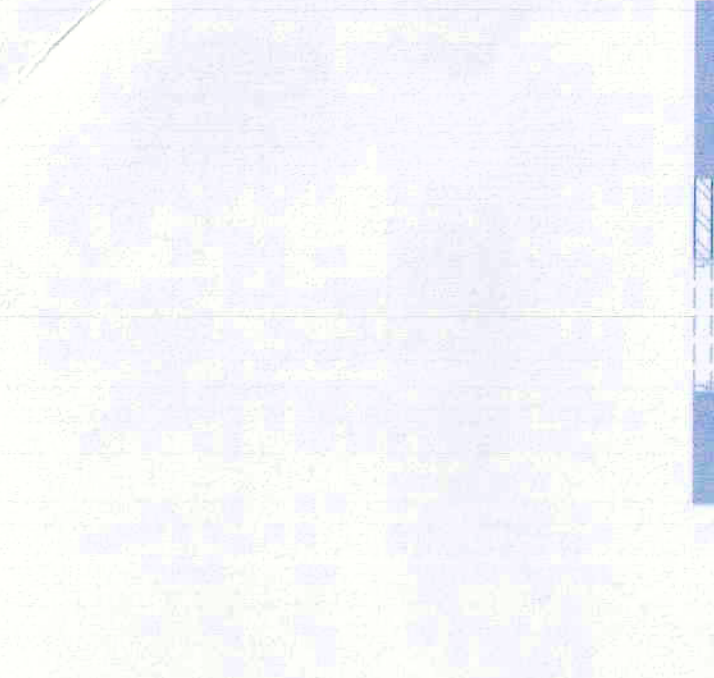
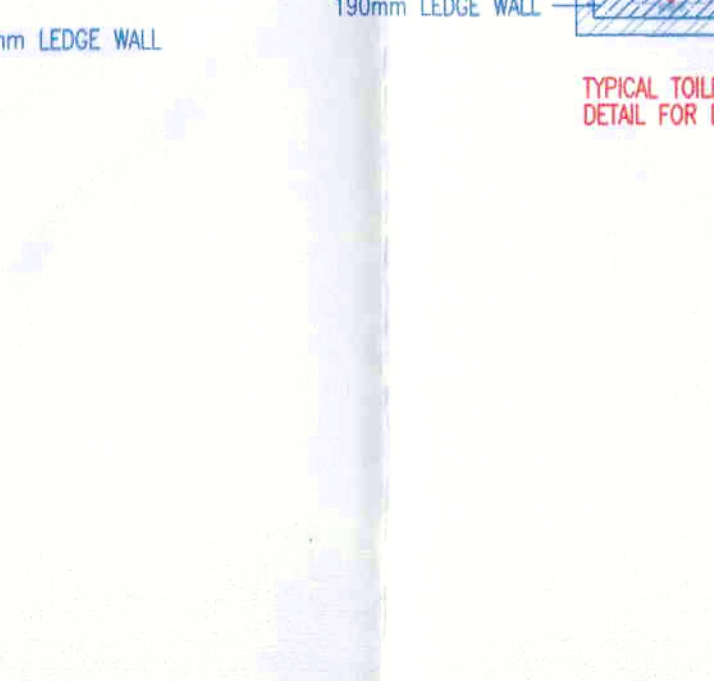
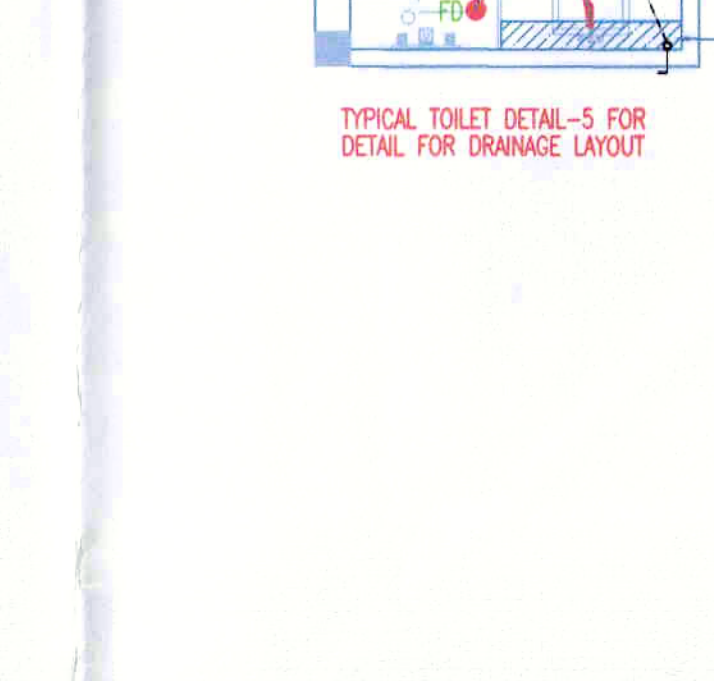
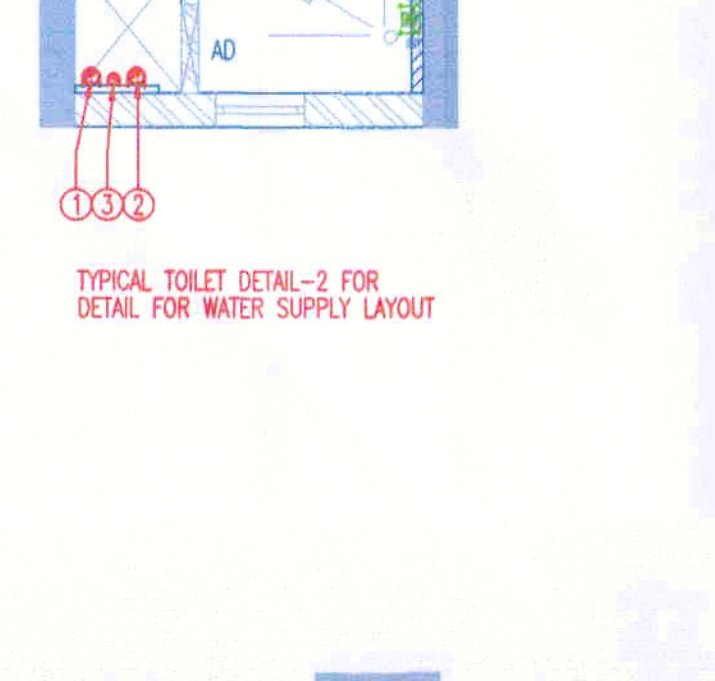
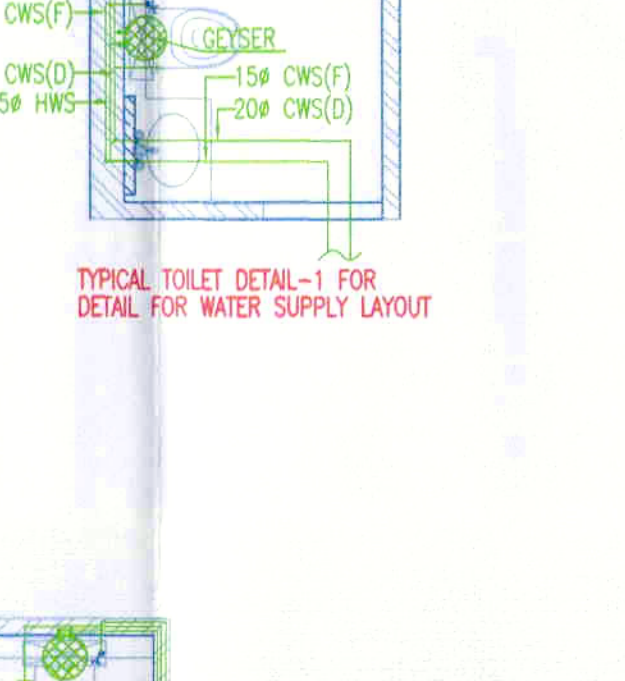
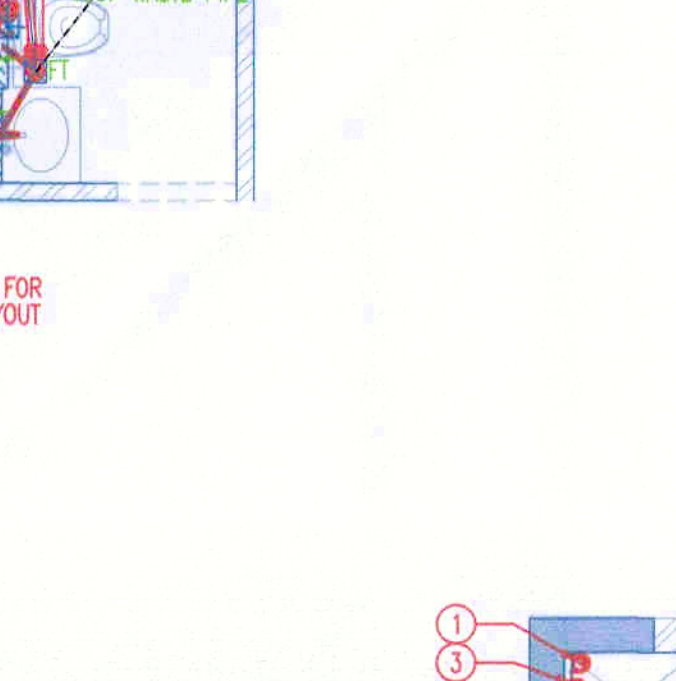
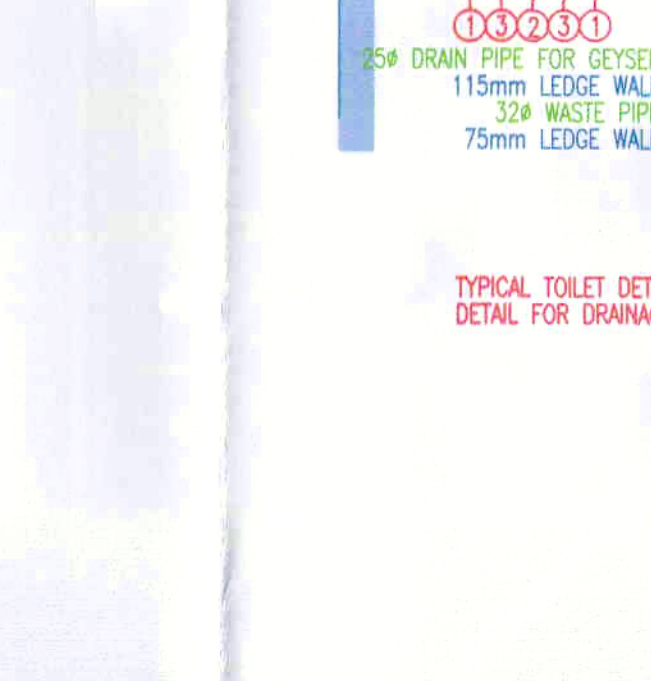
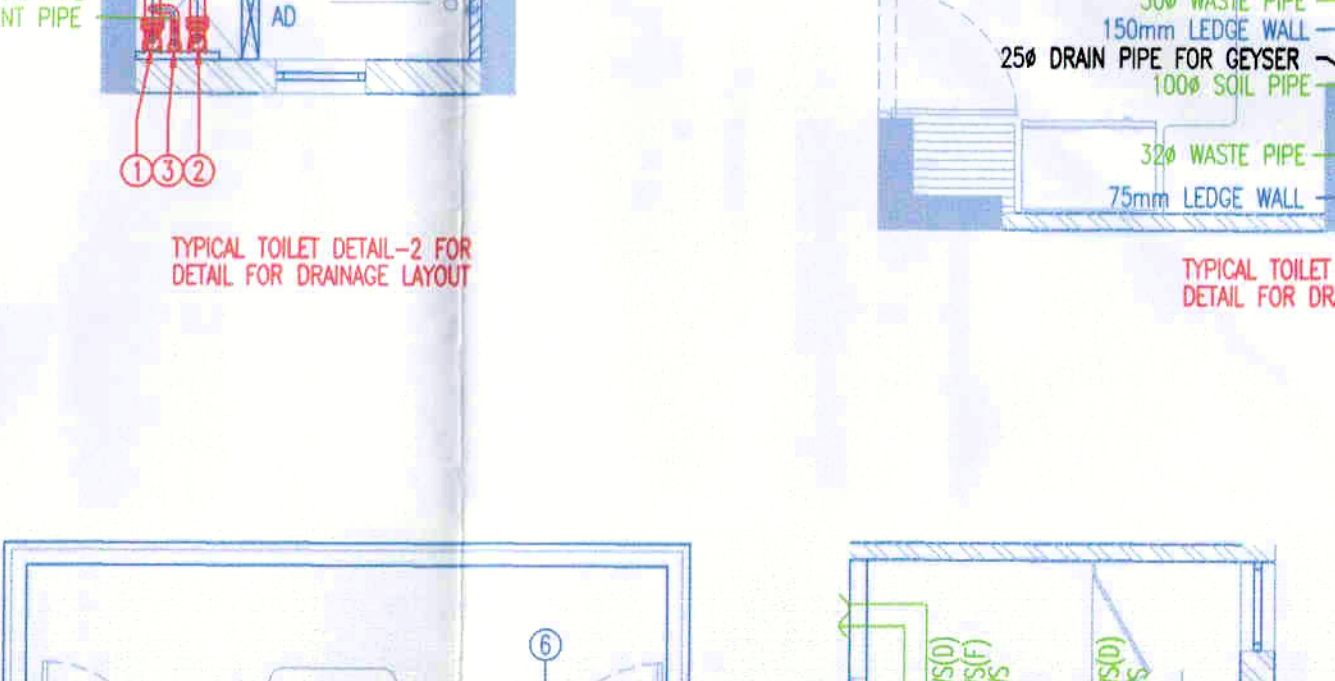
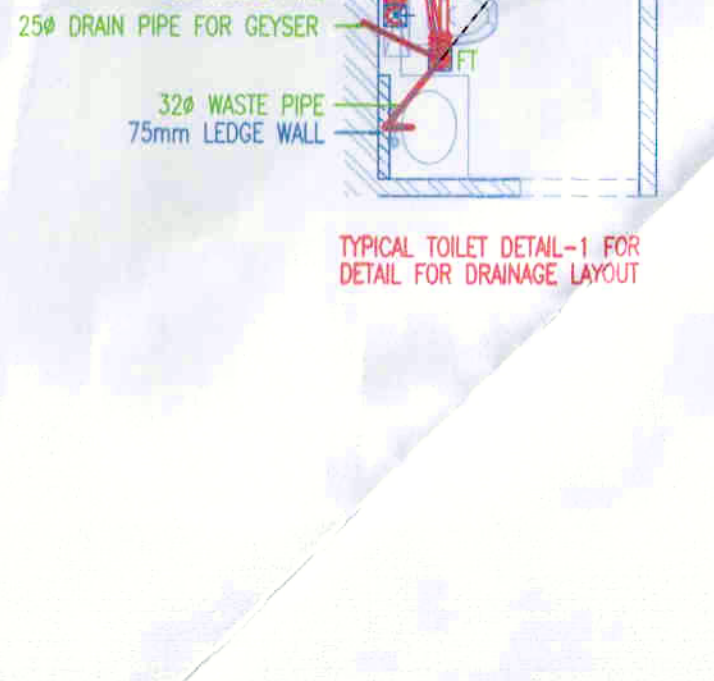
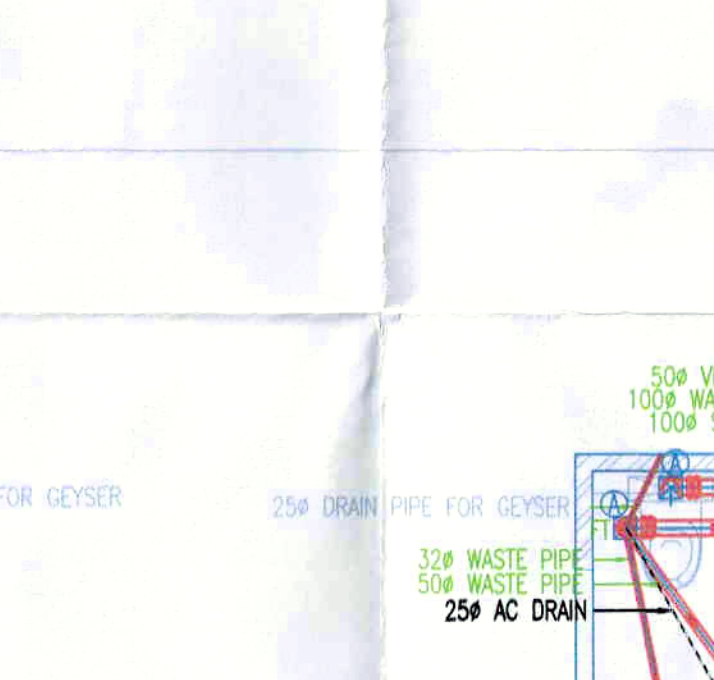
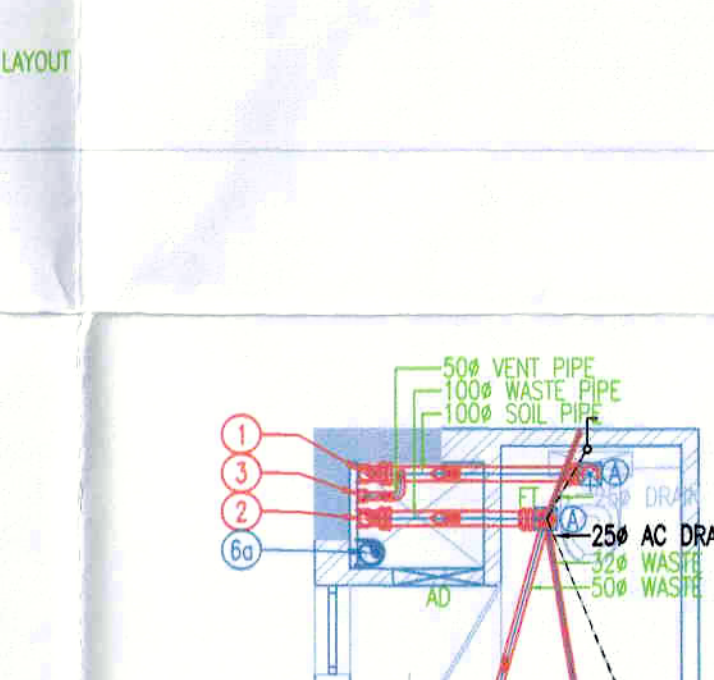
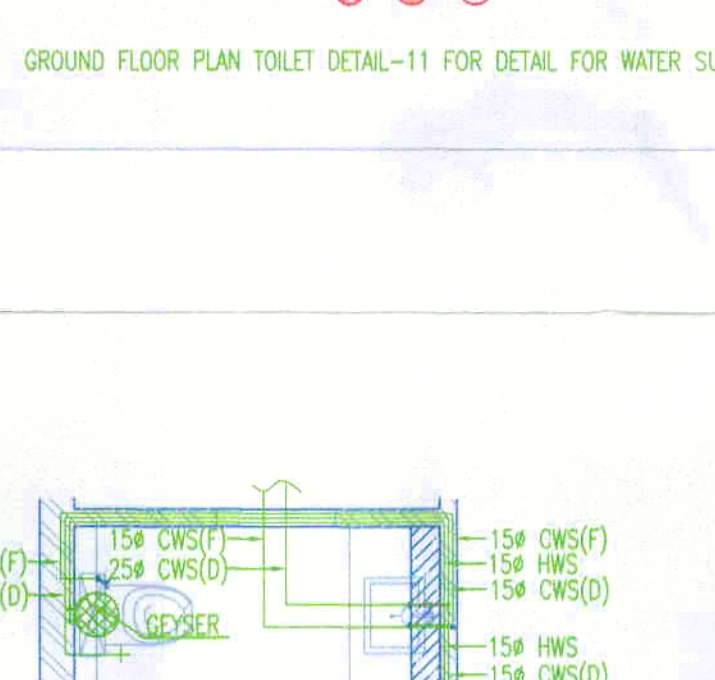
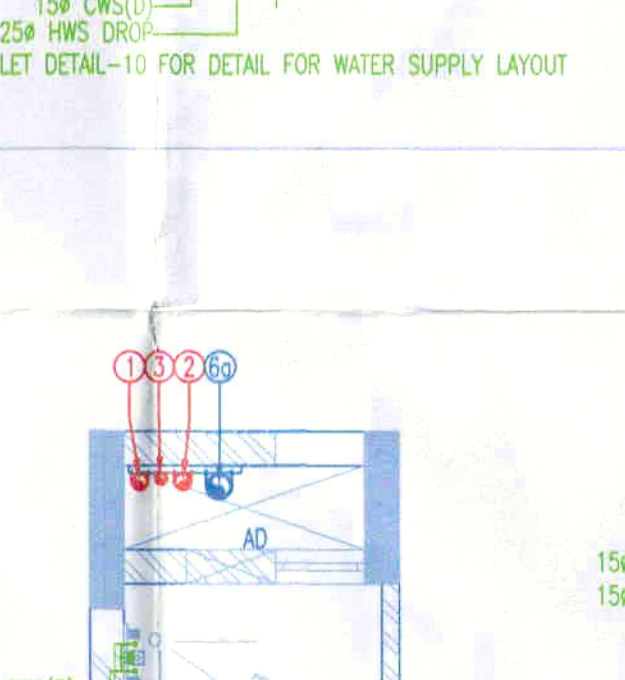
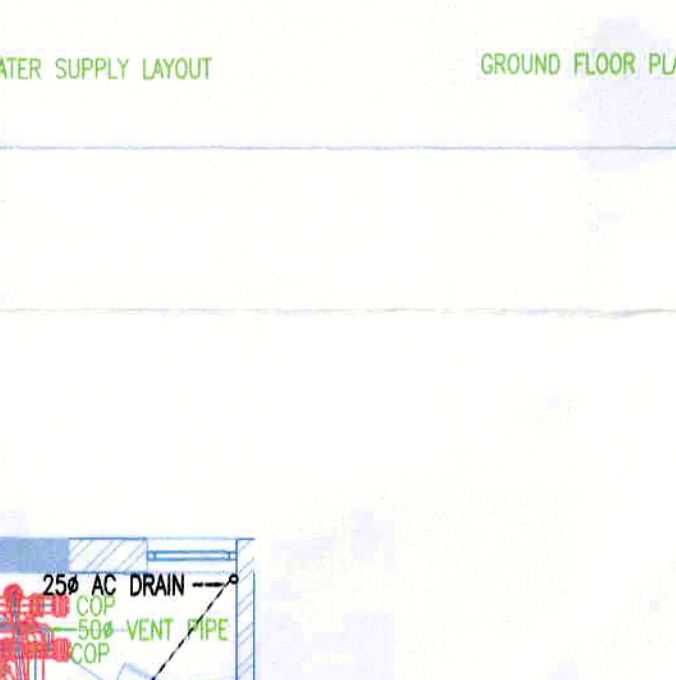
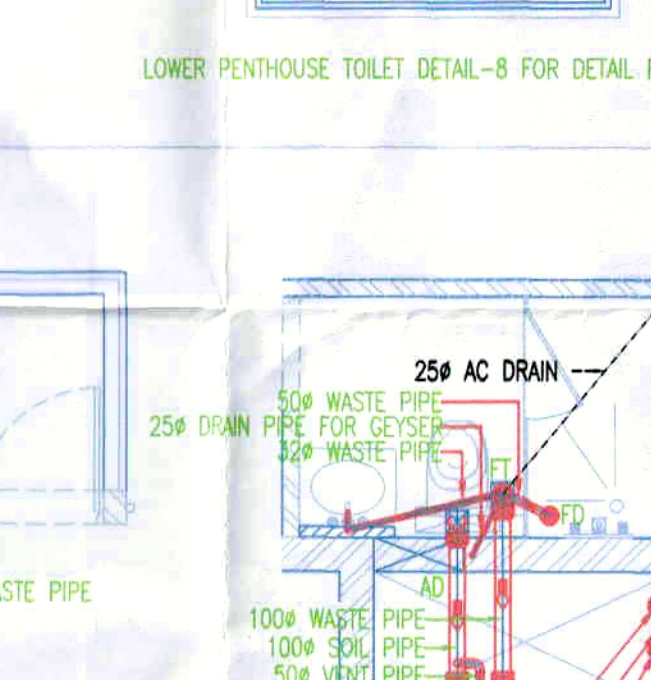
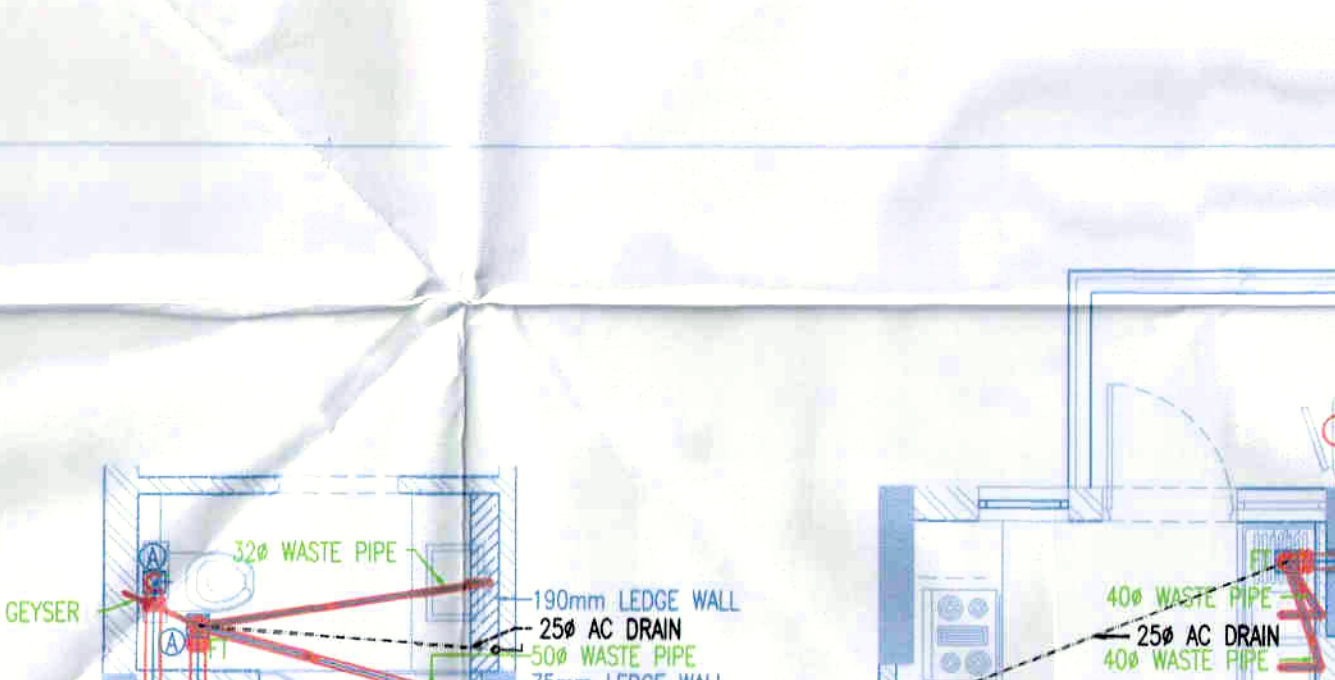
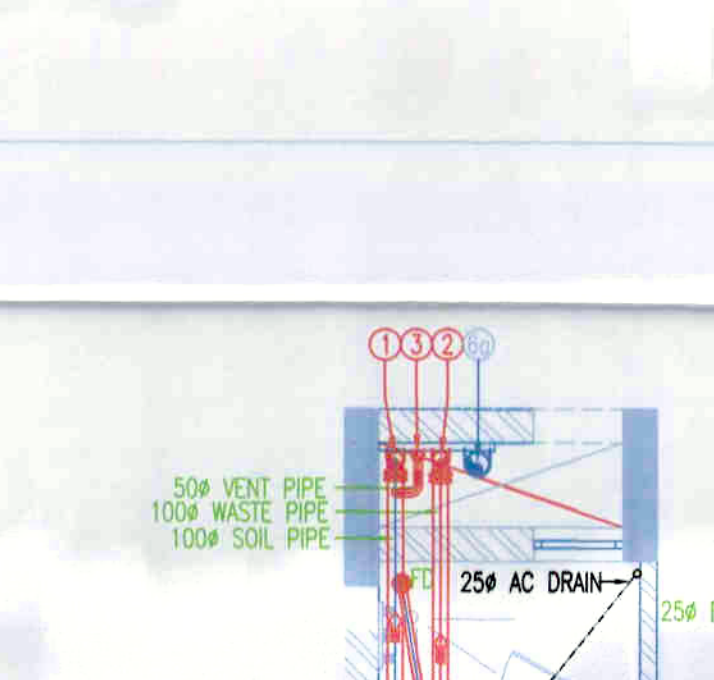
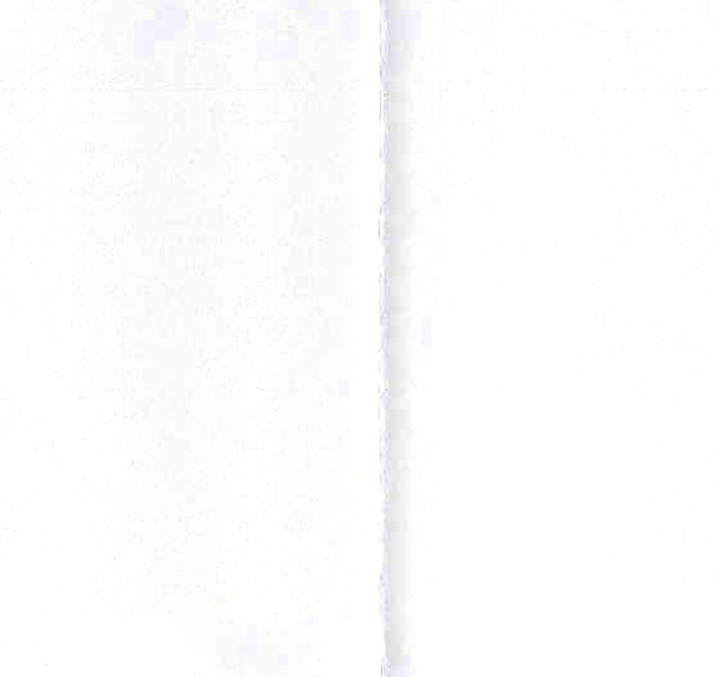
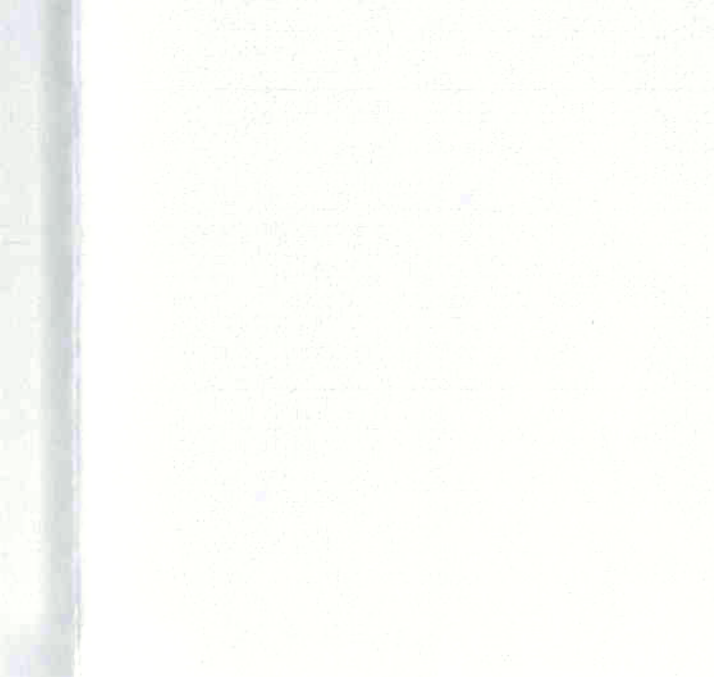
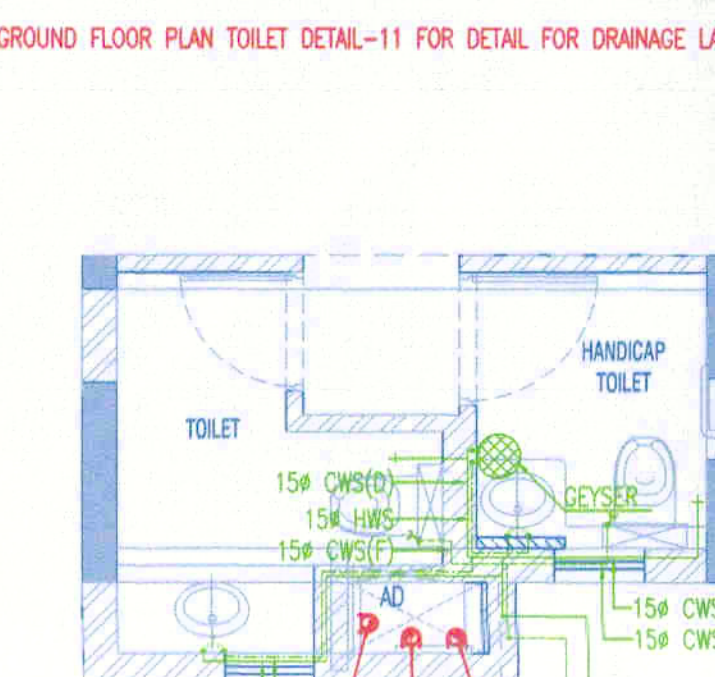
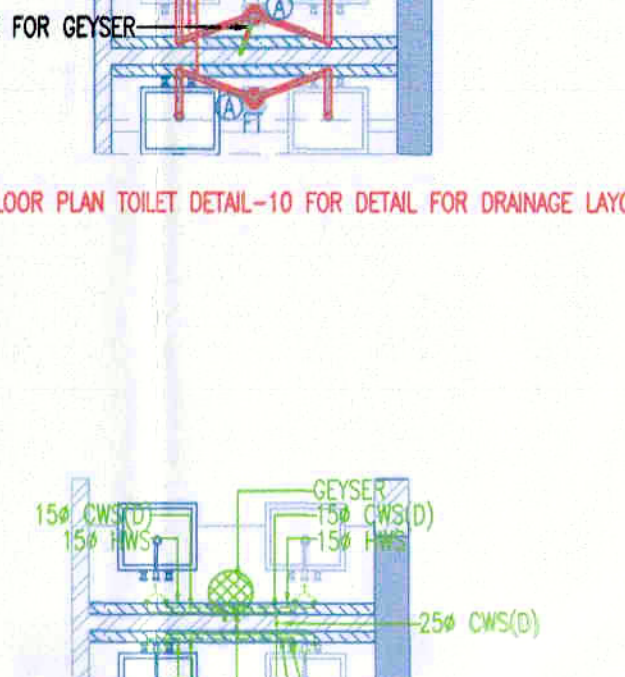
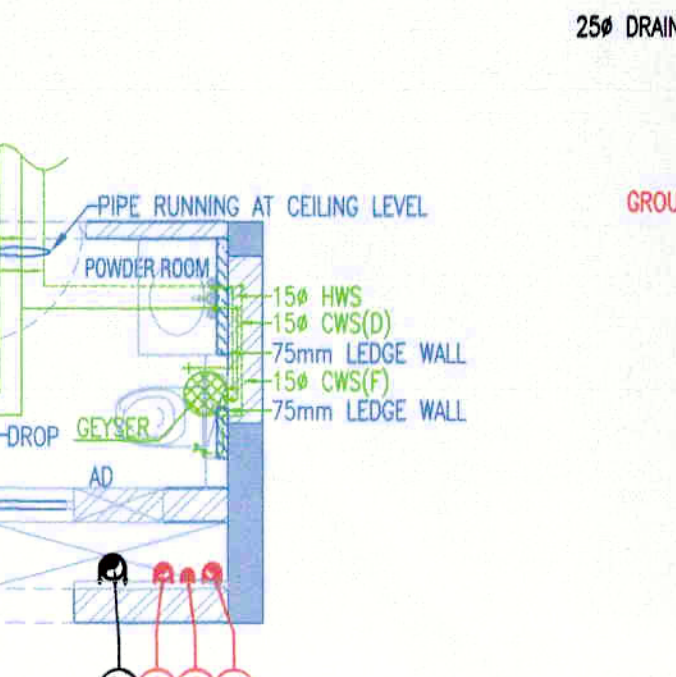
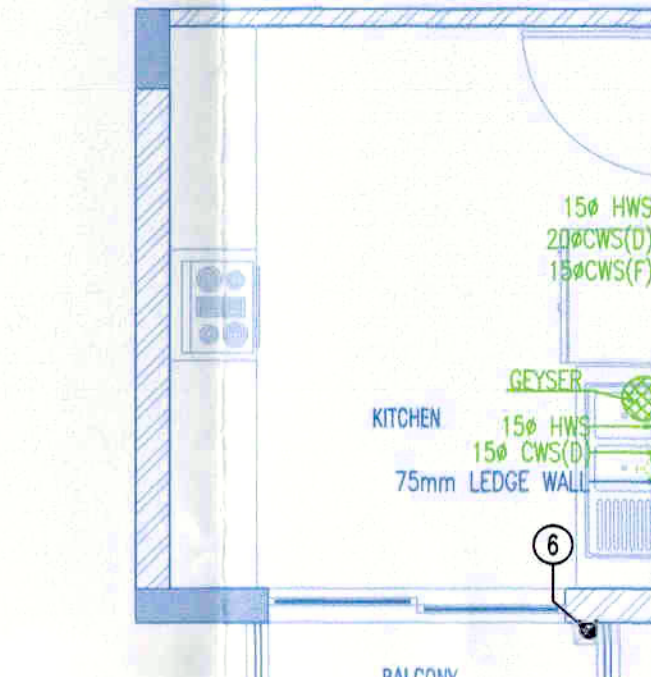
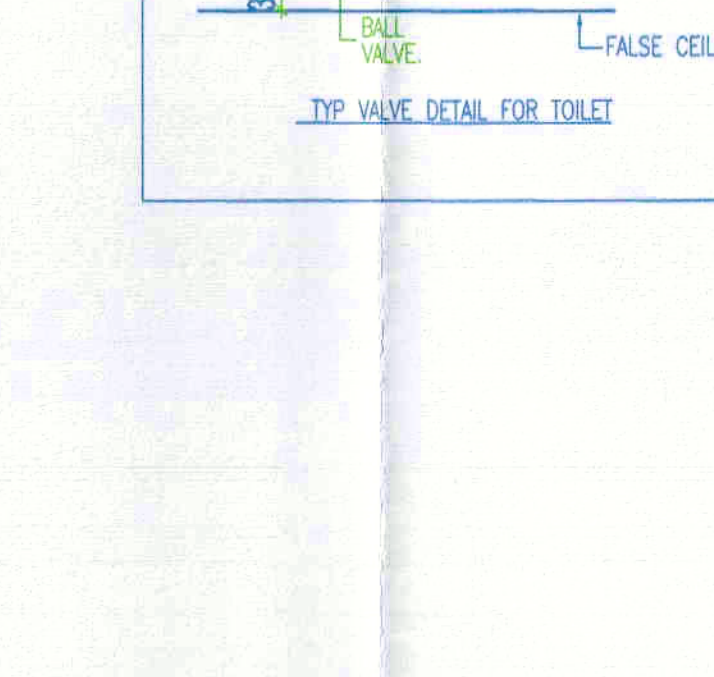
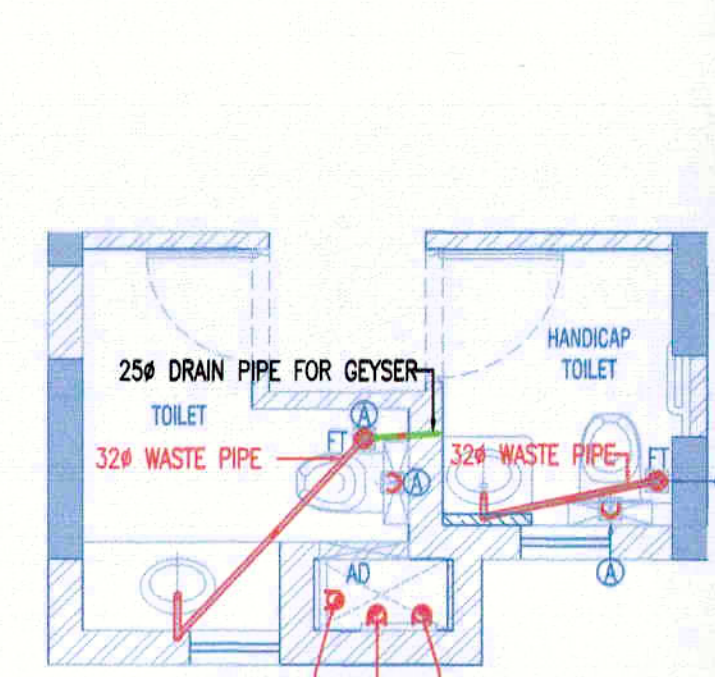
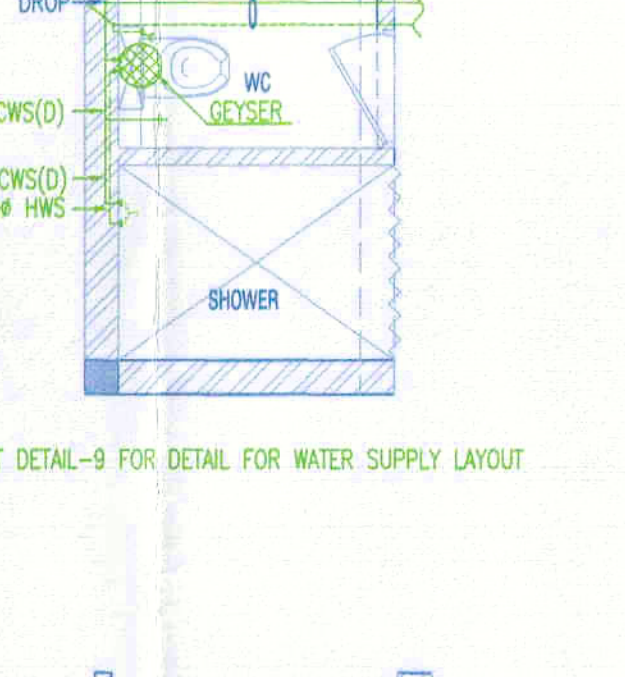
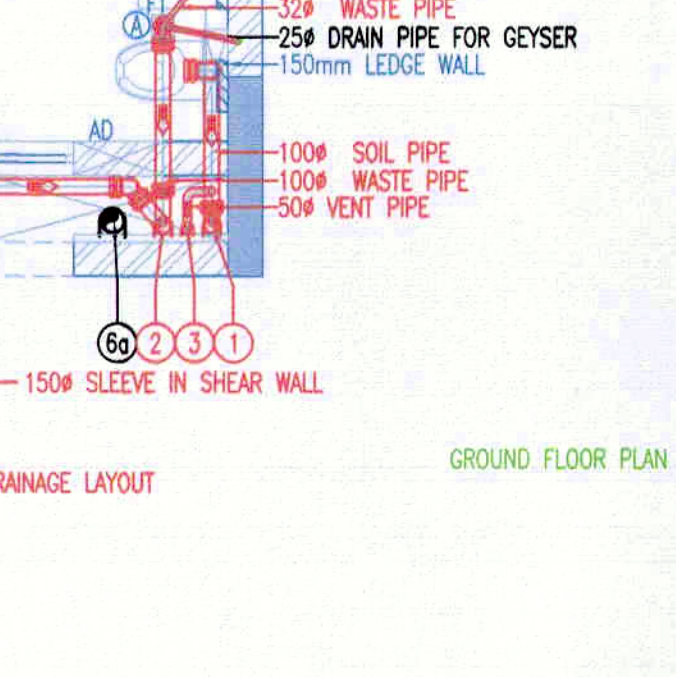
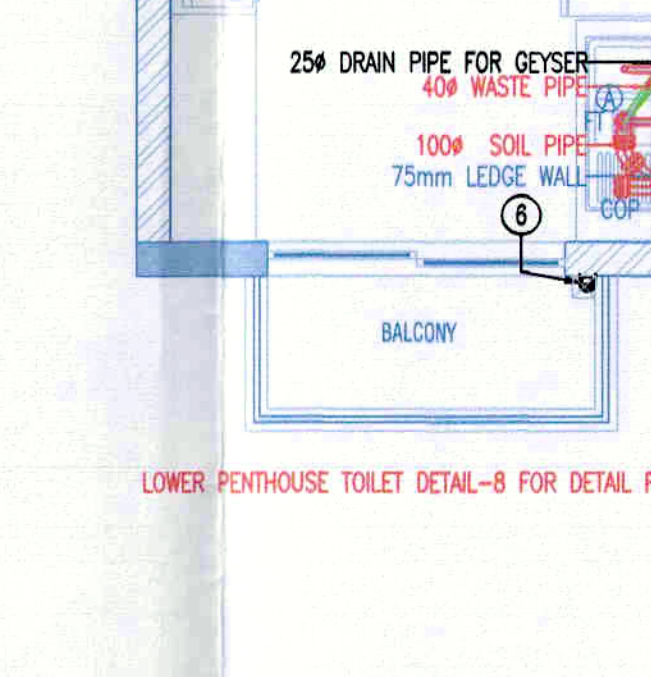
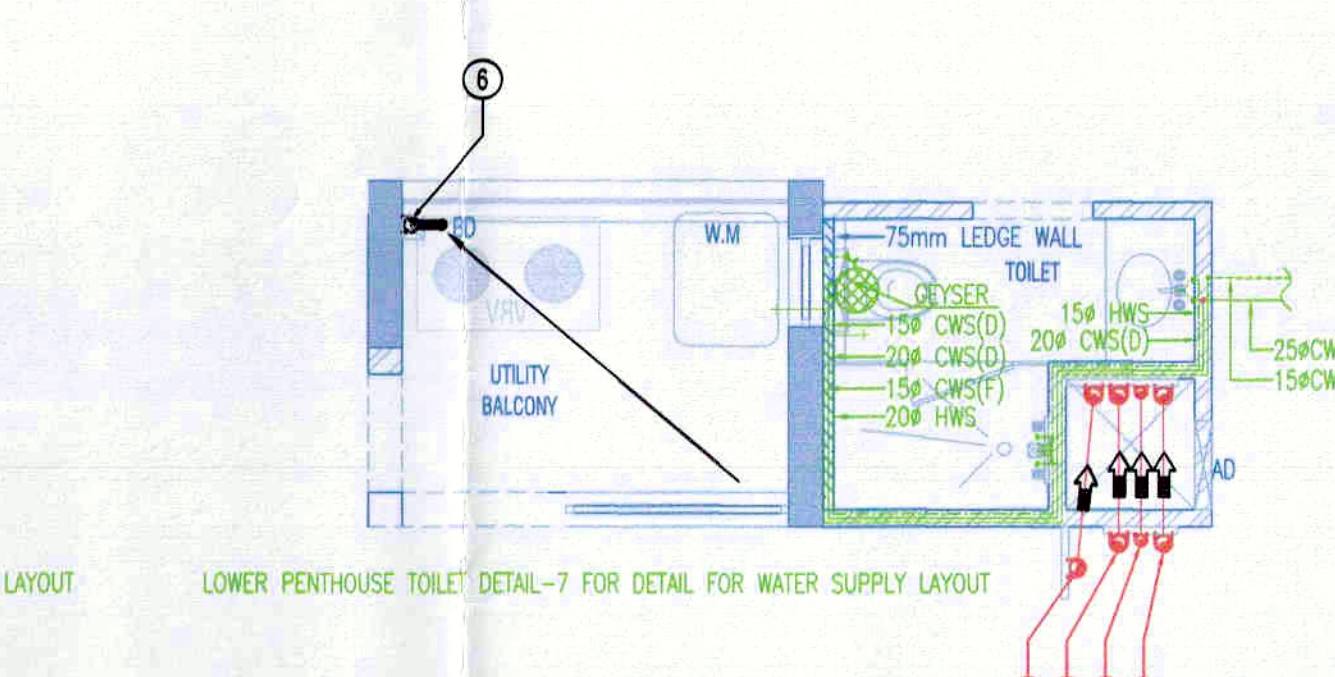
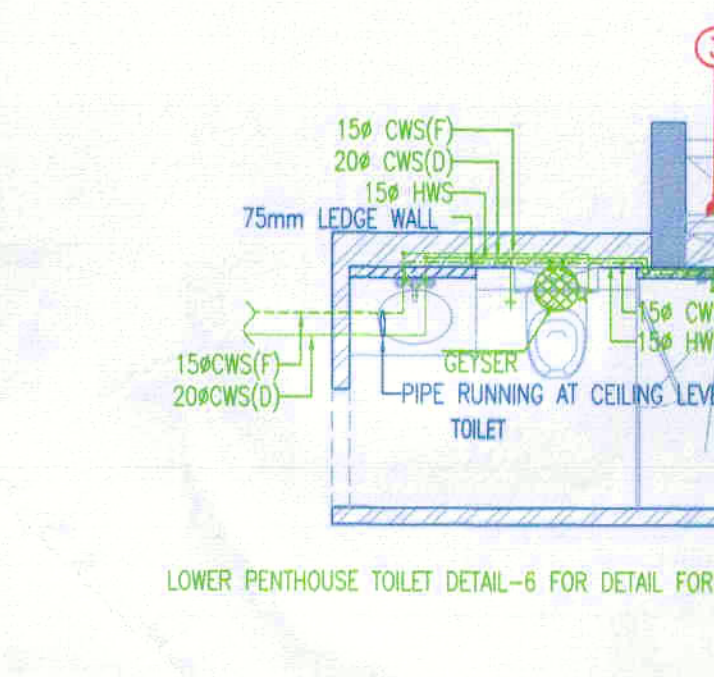
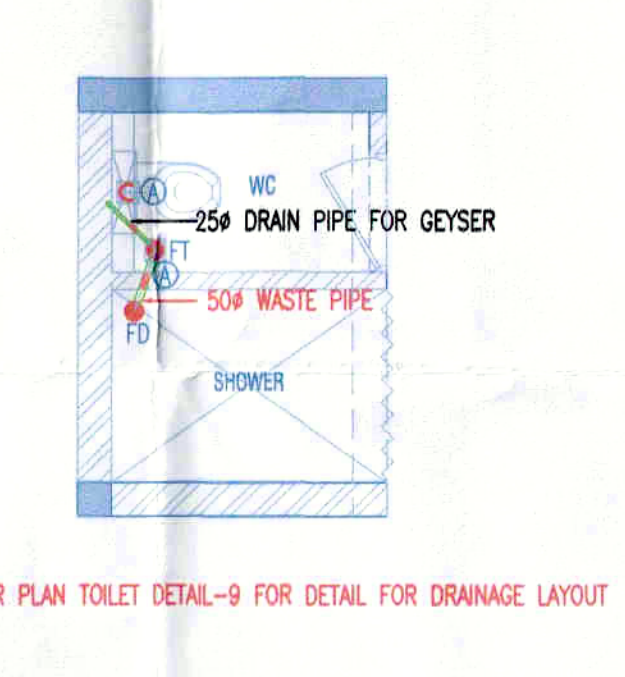
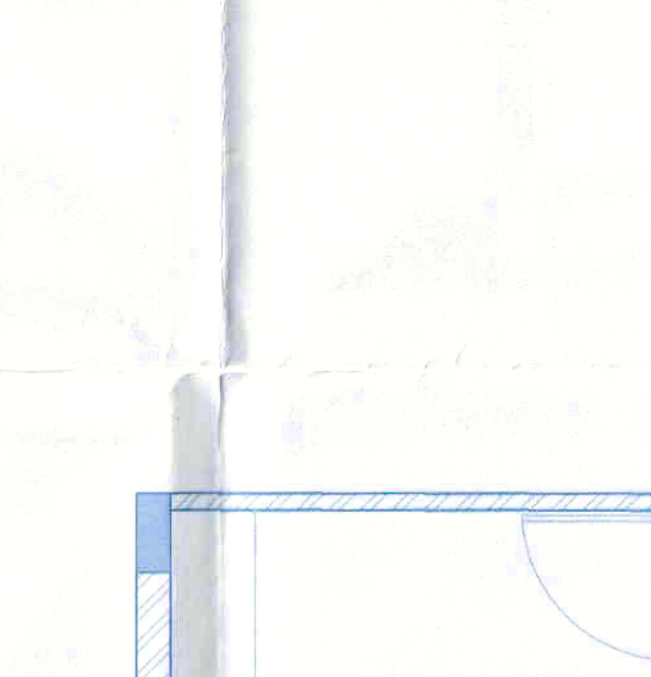
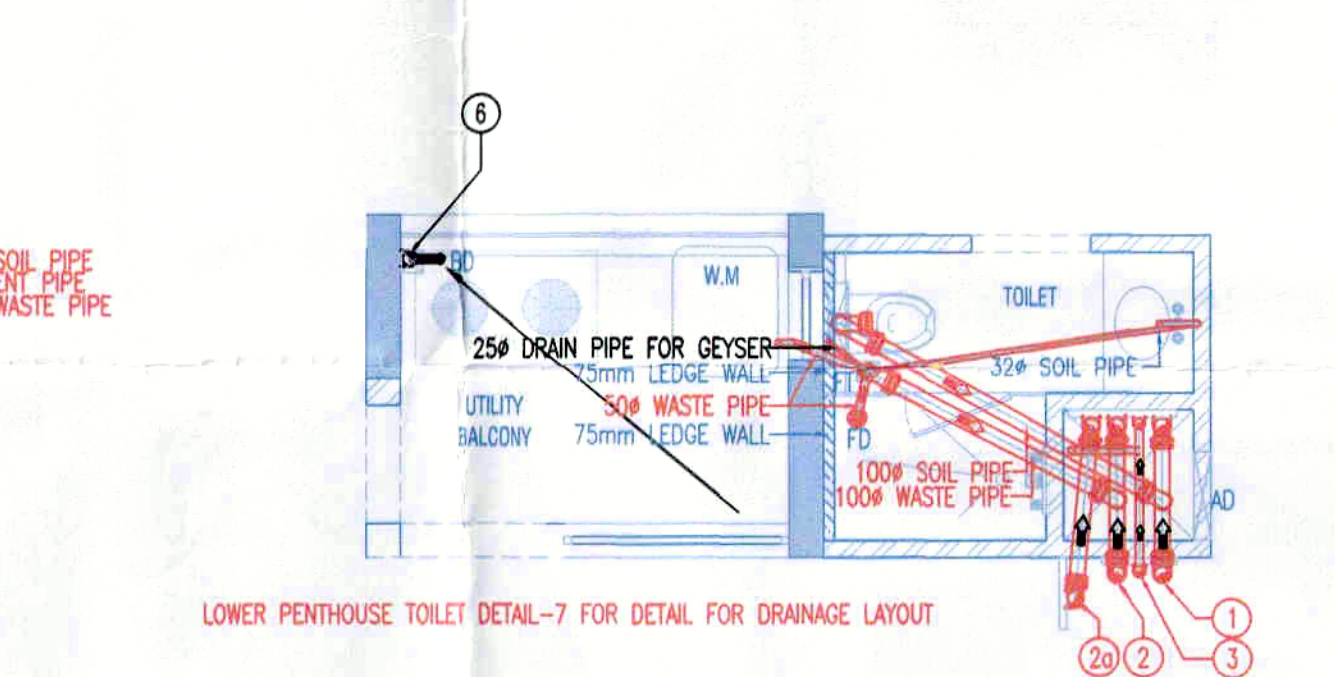
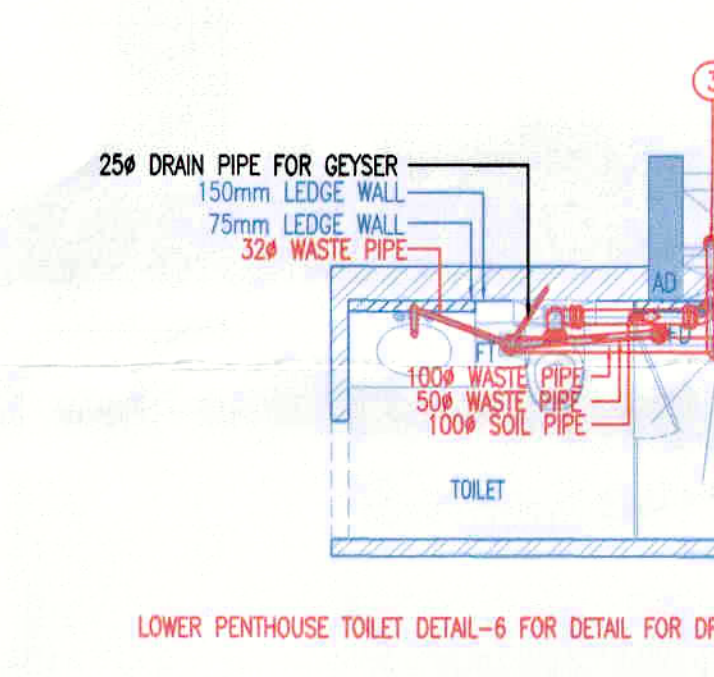
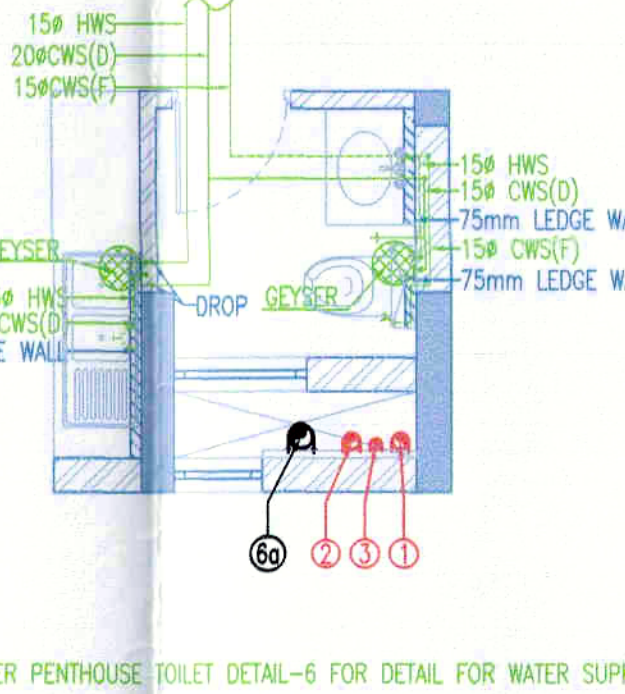
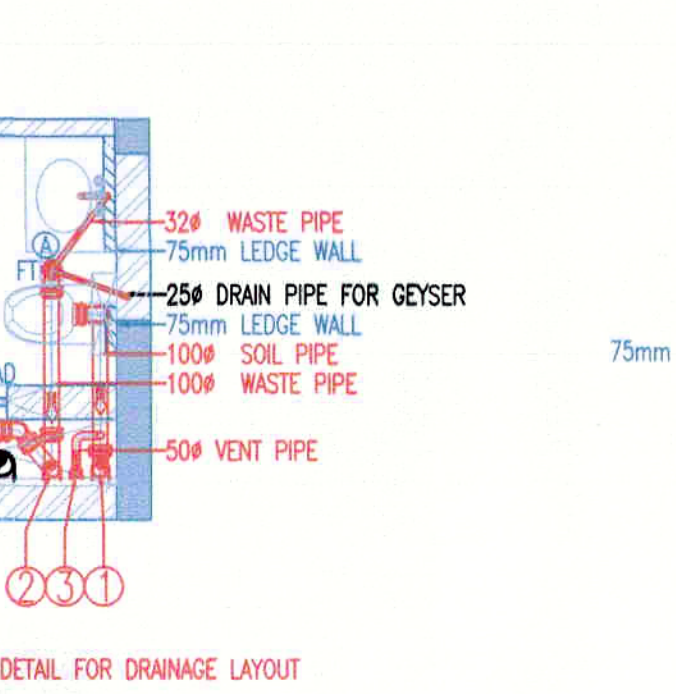
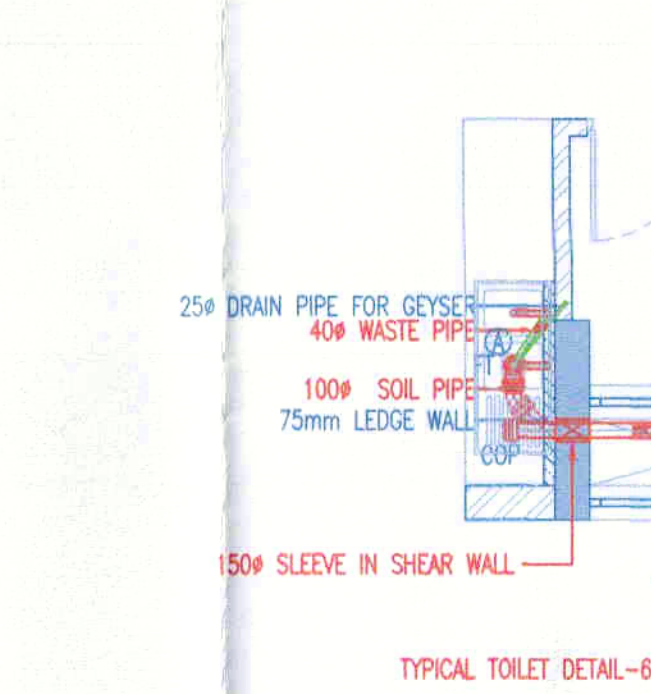
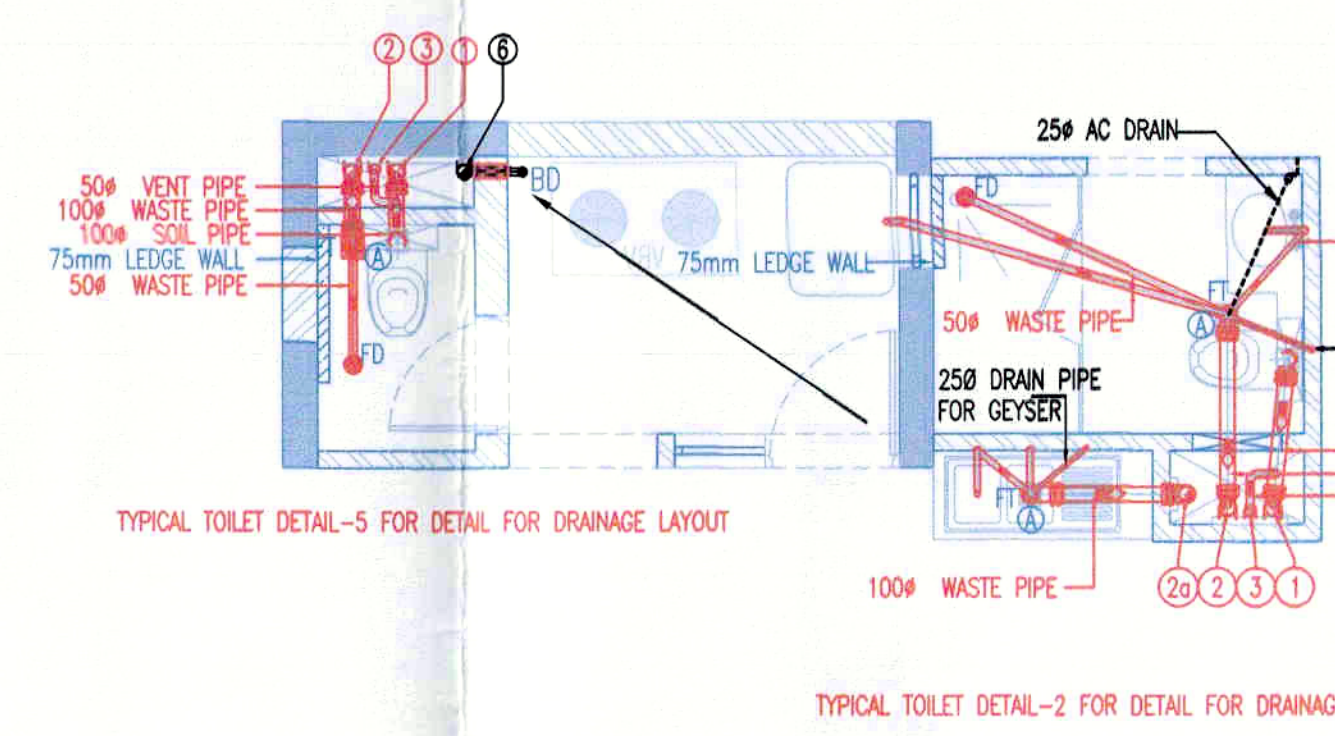
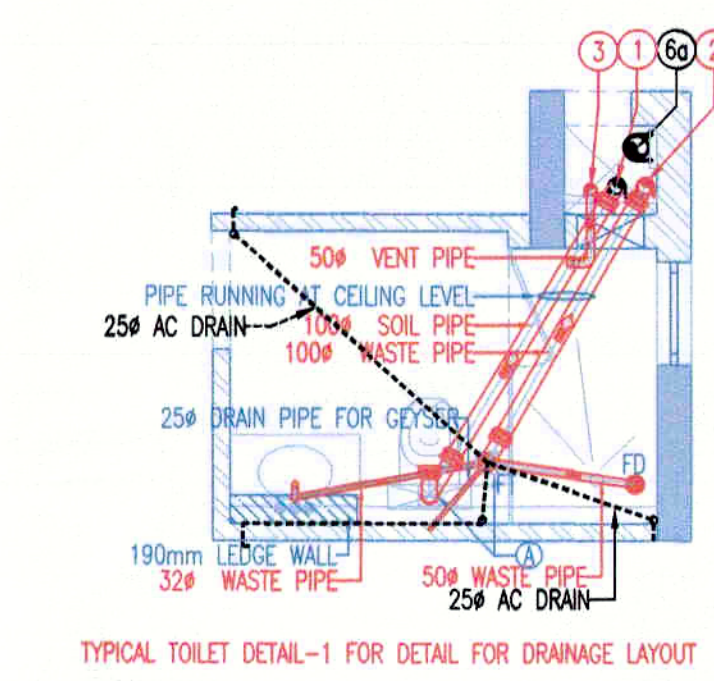
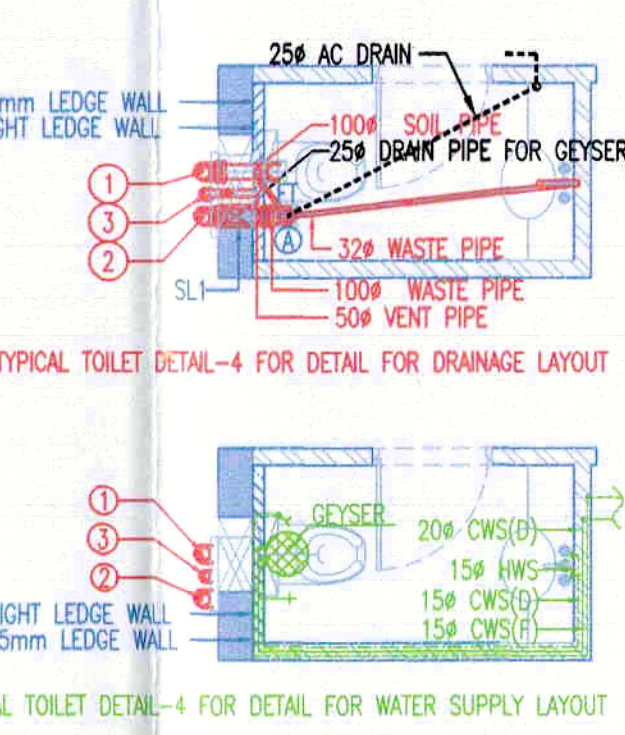
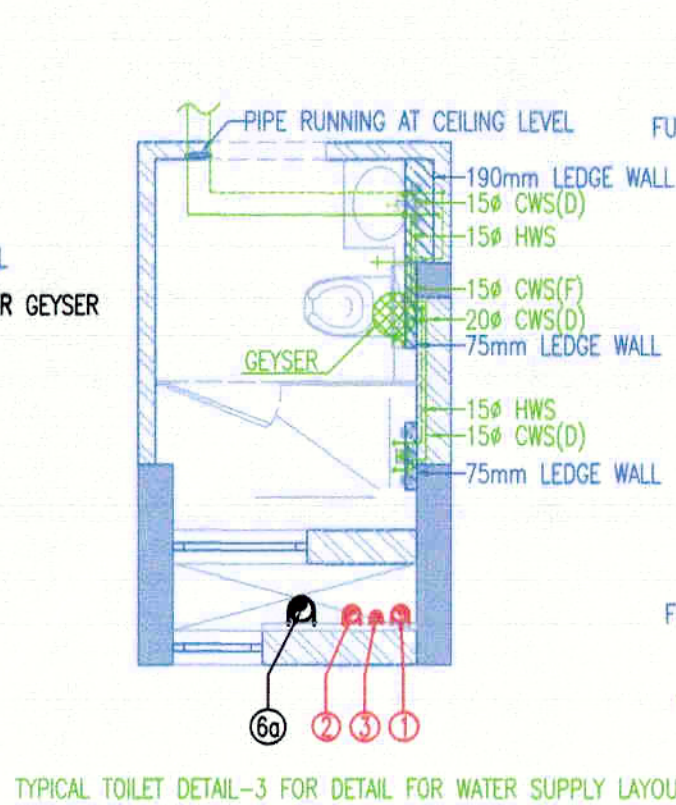
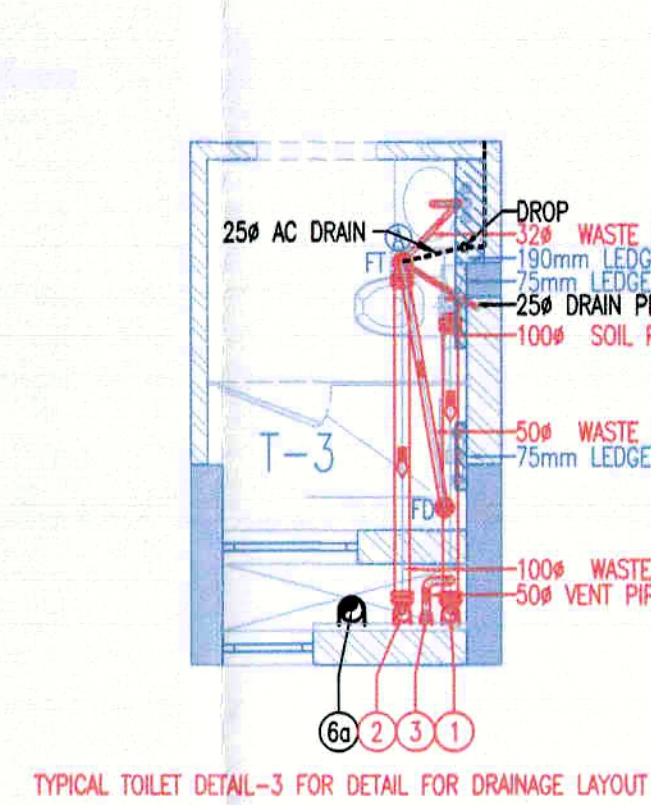
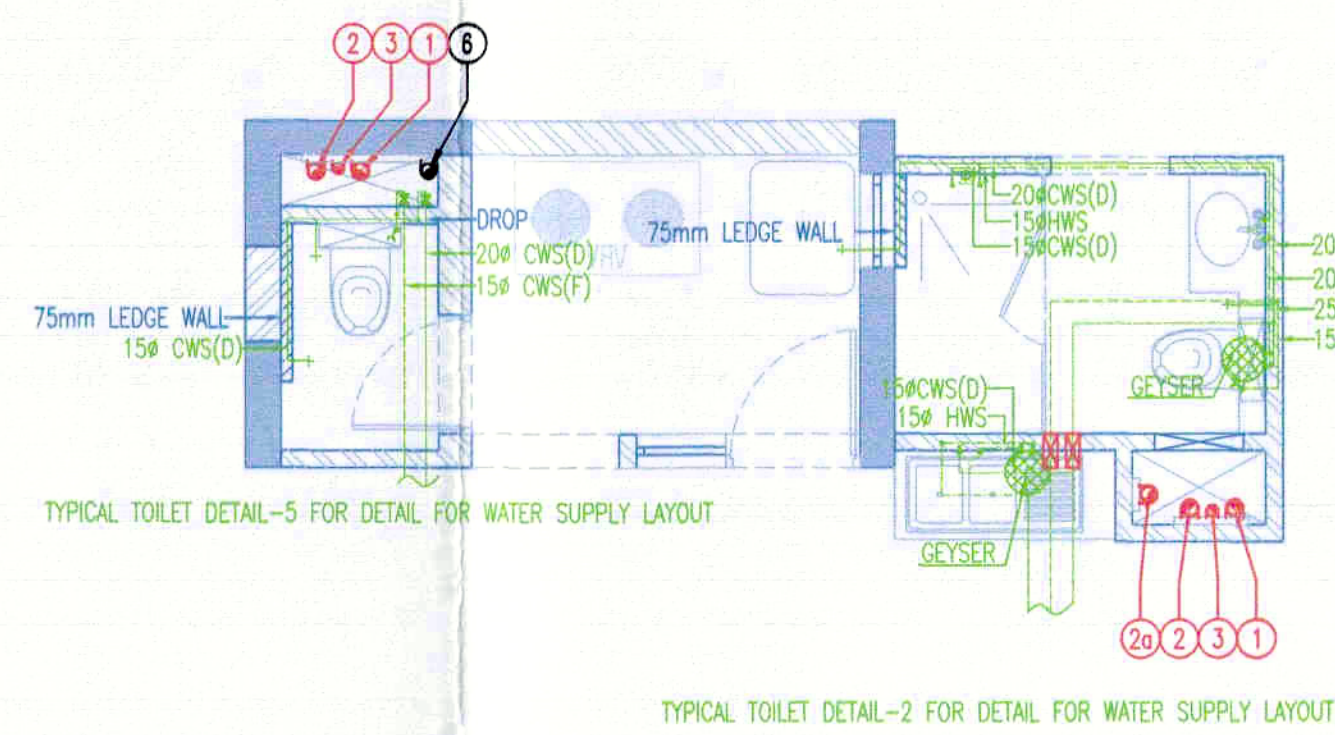


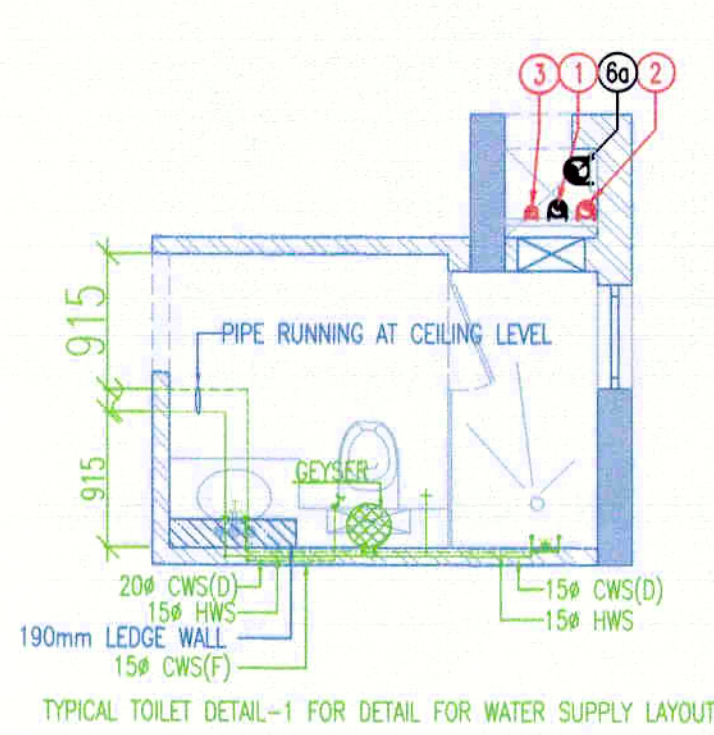


LEGEND FOR VERTICAL PIPES:-

- ① 100mm SOIL & VENT PIPE
- ② 100mm WASTE & VENT PIPE
- ③ 100mm WASTE PIPE FOR KITCHEN
- ④ 75mm ANTISIPHONAGE VENT PIPE
- ⑤ COLD WATER SUPPLY(DOMESTIC) FOR LOWER ZONE
- ⑥ COLD WATER SUPPLY(DOMESTIC) FOR UPPER ZONE
- ⑦ HOT WATER SUPPLY FOR LOWER ZONE(KITCHEN)
- ⑧ HOT WATER SUPPLY FOR UPPER ZONE(KITCHEN)
- ⑨ COLD WATER SUPPLY(FLUSHING)
- ⑩ 100mm BALCONY RAIN WATER PIPE
- ⑪ 150mm RAIN WATER PIPE
- ⑫ 65mm DOMESTIC WATER RISER
- ⑬ 50mm FLUSHING WATER RISER
- ⑭ CUTOFF 150x150
- ⑮ 50mm SLEEVE
- ⑯ 65mm SLEEVE
- ⑰ 150mm M.S FIRE PIPE
- ⑱ 80mm M.S DRAIN PIPE
- ⑲ 150mm M.S SPRINKLER RISER
- FHC FIRE HOSE CABINET

LEGEND

SYMBOL	DESCRIPTION
—	SOIL PIPE
—	WASTE PIPE
CWS	COLD WATER SUPPLY(DOMESTIC)
CWS(F)	COLD WATER SUPPLY(FLUSHING)
HWS	HOT WATER SUPPLY
FT	FLOOR TRAP 100x100mm
FD	FLOOR DRAIN 100x50mm
UT	URINAL TRAP 100x100mm
COP	CLEAN OUT PLUG
—	BALL VALVE

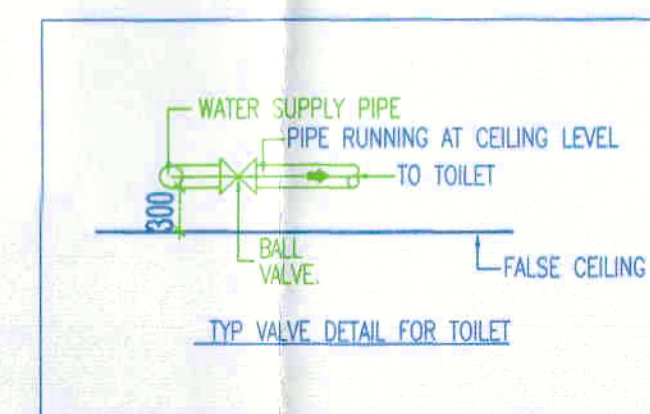

Note:-

1. BUILDING WILL BE DESIGNED (STRUCTURES) AS PER RELEVANT IS CODES FOR EARTH QUAKE RESISTANCE.
2. TOILETS WILL NATURAL VENTILATION WILL HAVE MECHANICAL VENTILATION

LEGEND:-

Project:

PROPOSED GROUP HOUSING MEASURING 10.43125 ACRES (LICENCE NO. 65 OF 2013 DATED 20-07-2013) & (LICENCE NO. 119 OF 2012 DATED 06.12.2012) IN SECTOR-99, GURGAON MANESAR URBAN COMPLEX BEING DEVELOPED BY PLANET EARTH ESTATES PVT. LTD.

Associate Architects

RSMS ARCHITECTS

RSMS ARCHITECTS PVT. LTD.
69, Nora Niwas Bhawani Kunj
(Behind D2), Vasant Kunj,
New Delhi-110070.
Tel.: 011-26898616, 26898617
www.rsms-arch.com

ARCHITECT'S SEAL & SIGNATURE

OWNER'S SEAL & SIGNATURE

For Planet Earth Estates Pvt. Ltd.
Authorised Signatory

DECEMBER.2013 Scale : 1:50

Drawing Title:-

TOILET DETAIL OF ALL TOWER & BLOCK

Drawing No:-

T-01

TOILET DETAIL

VATIKA - SOVEREIGN PARK