
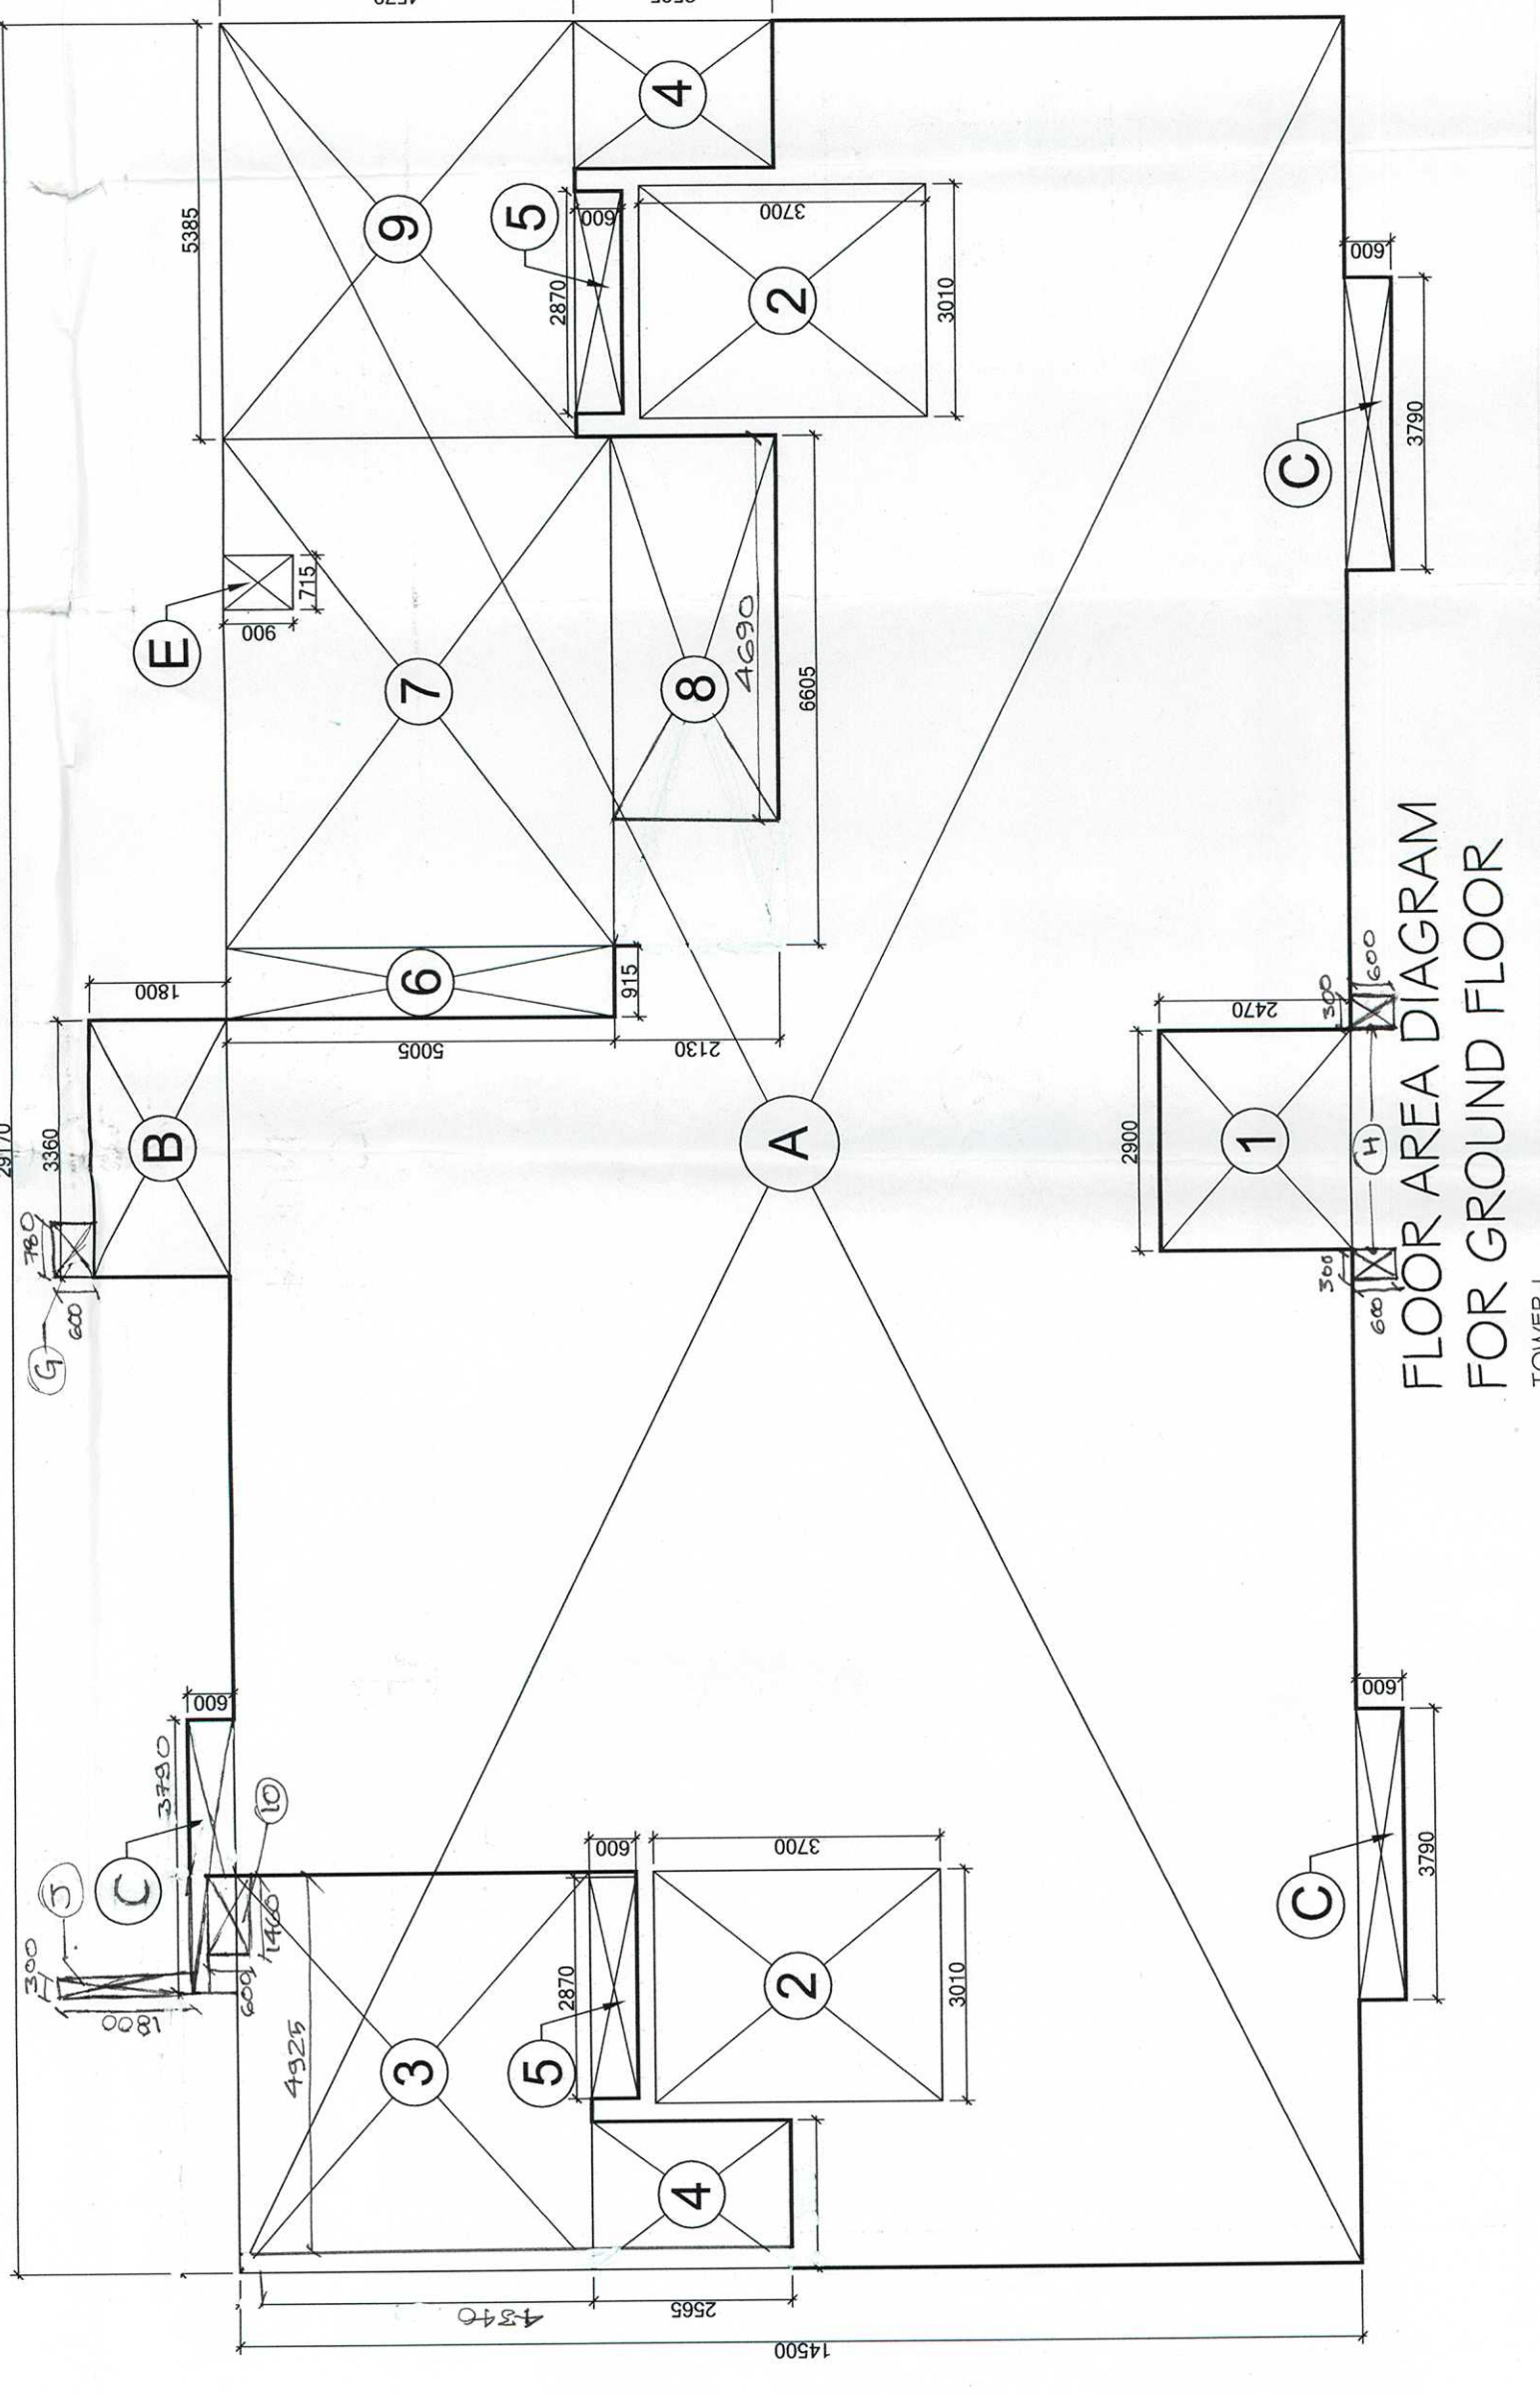
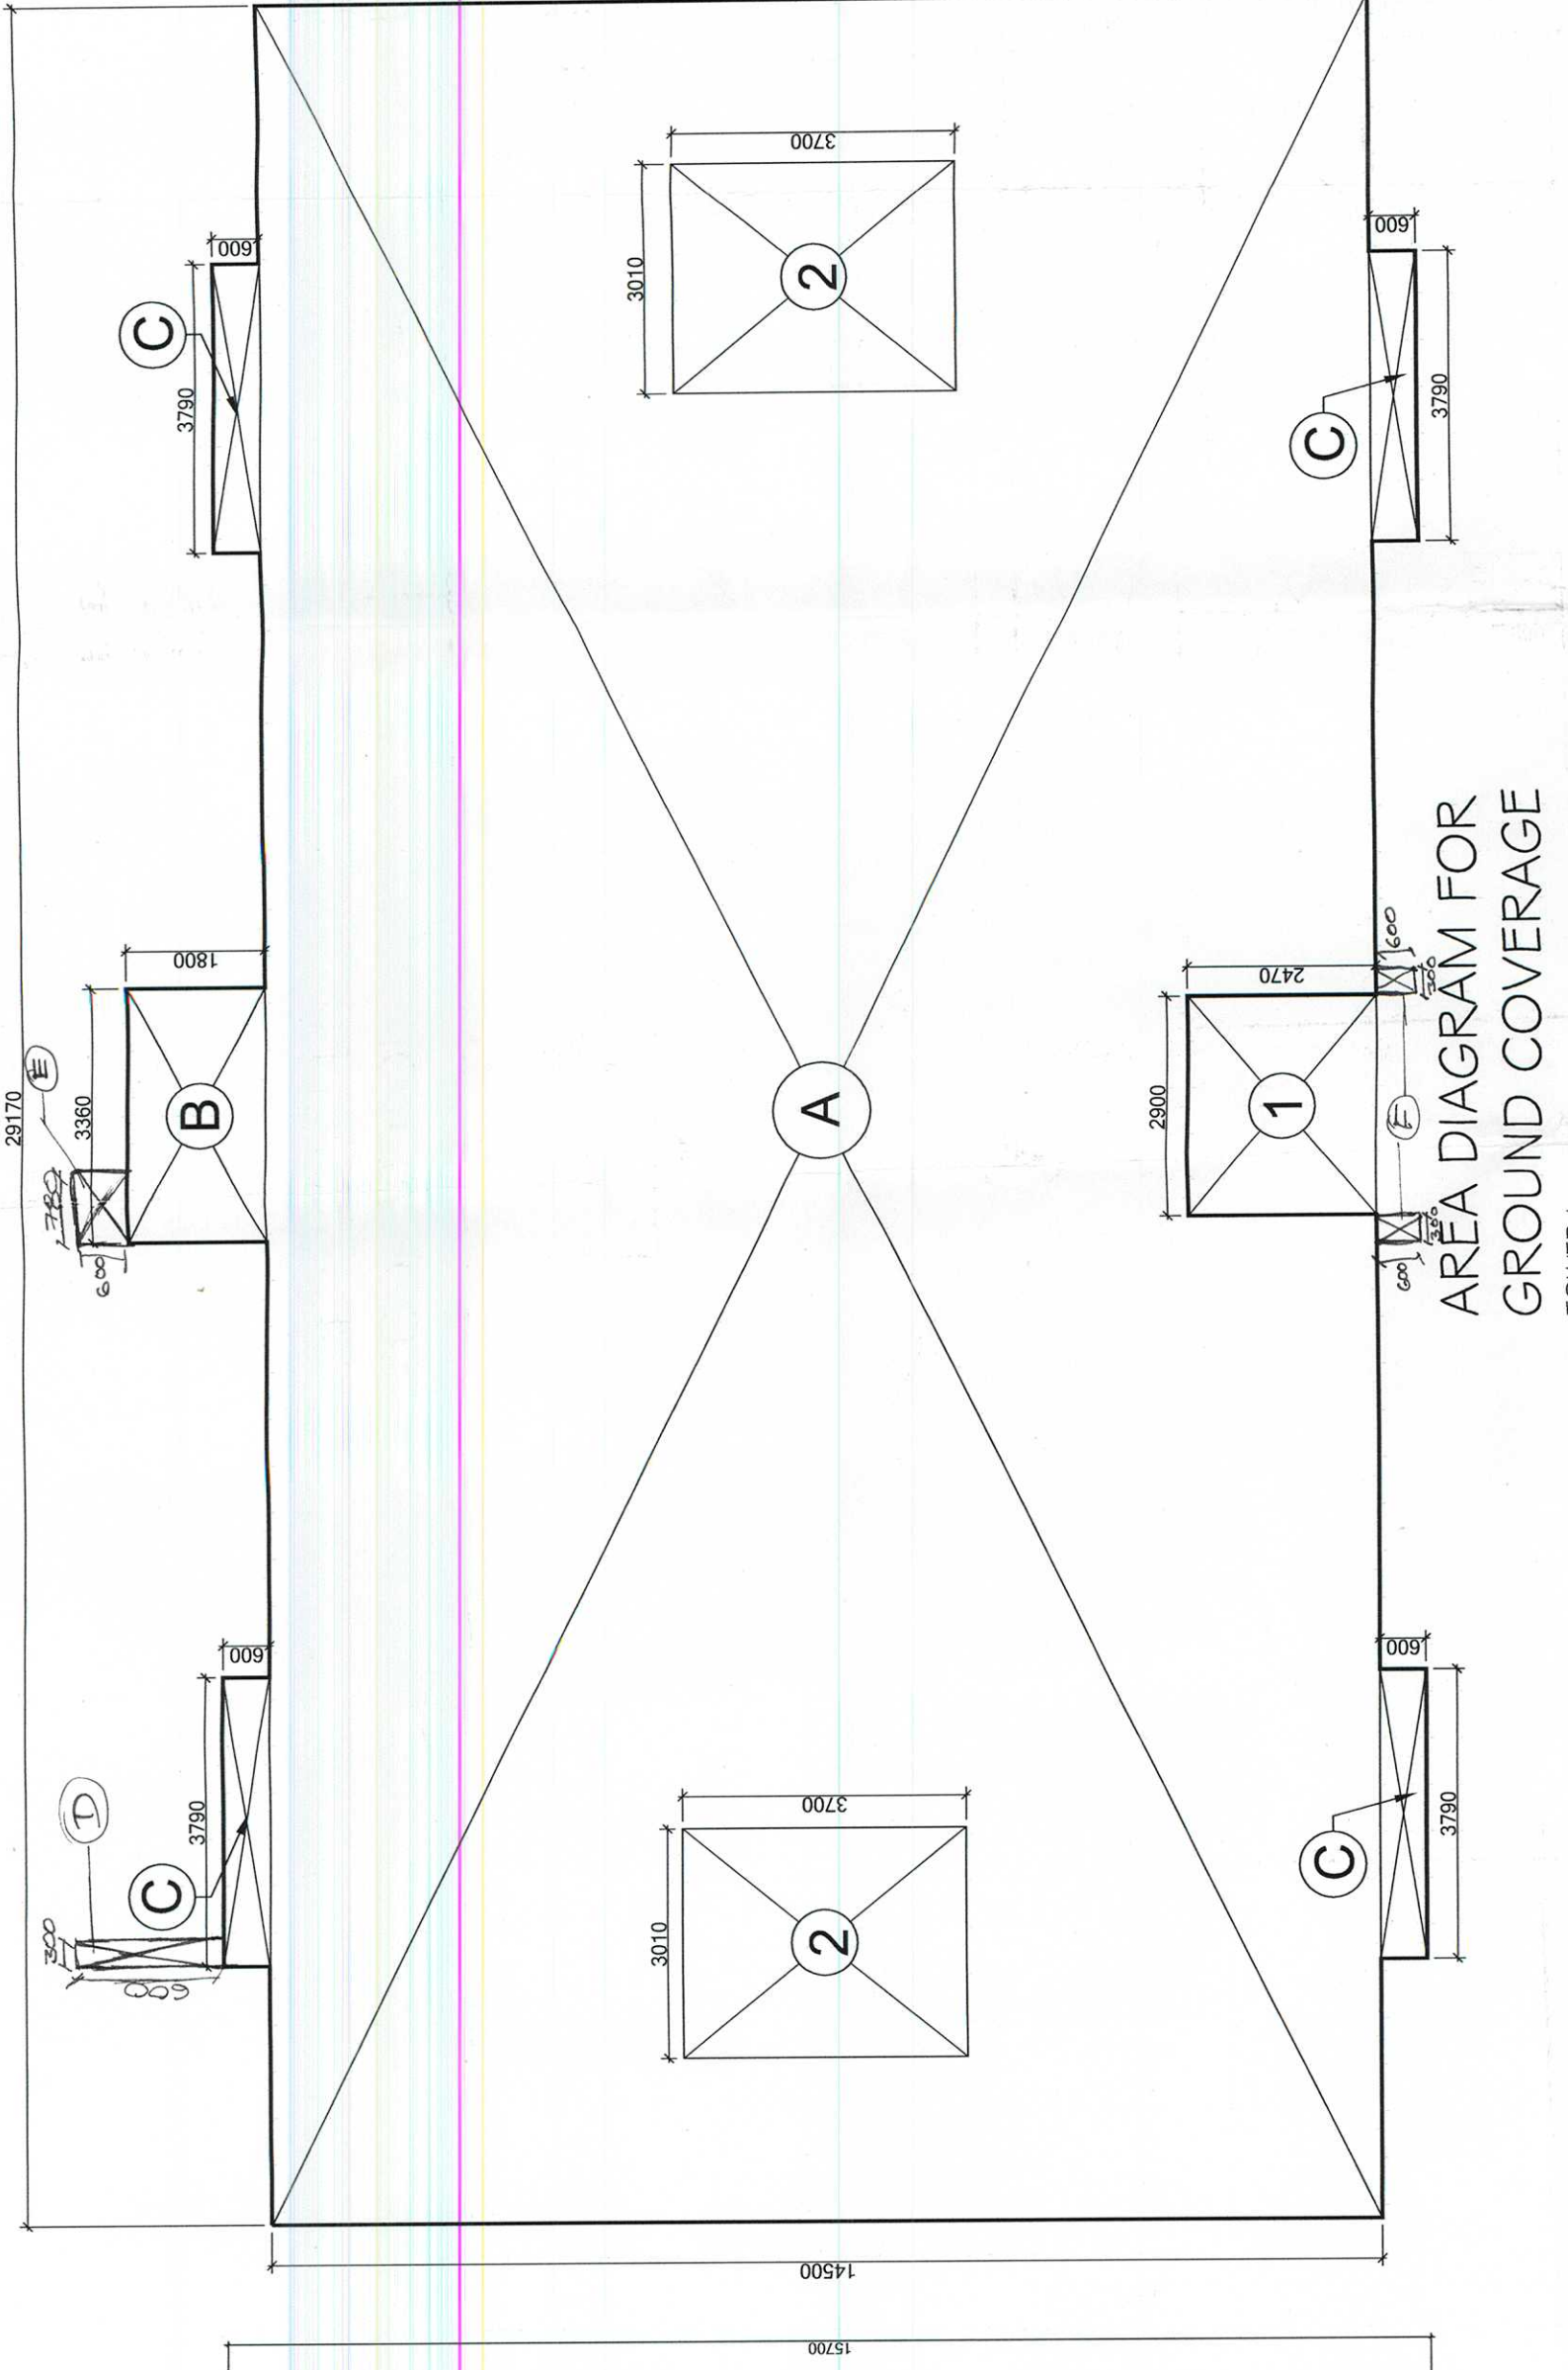
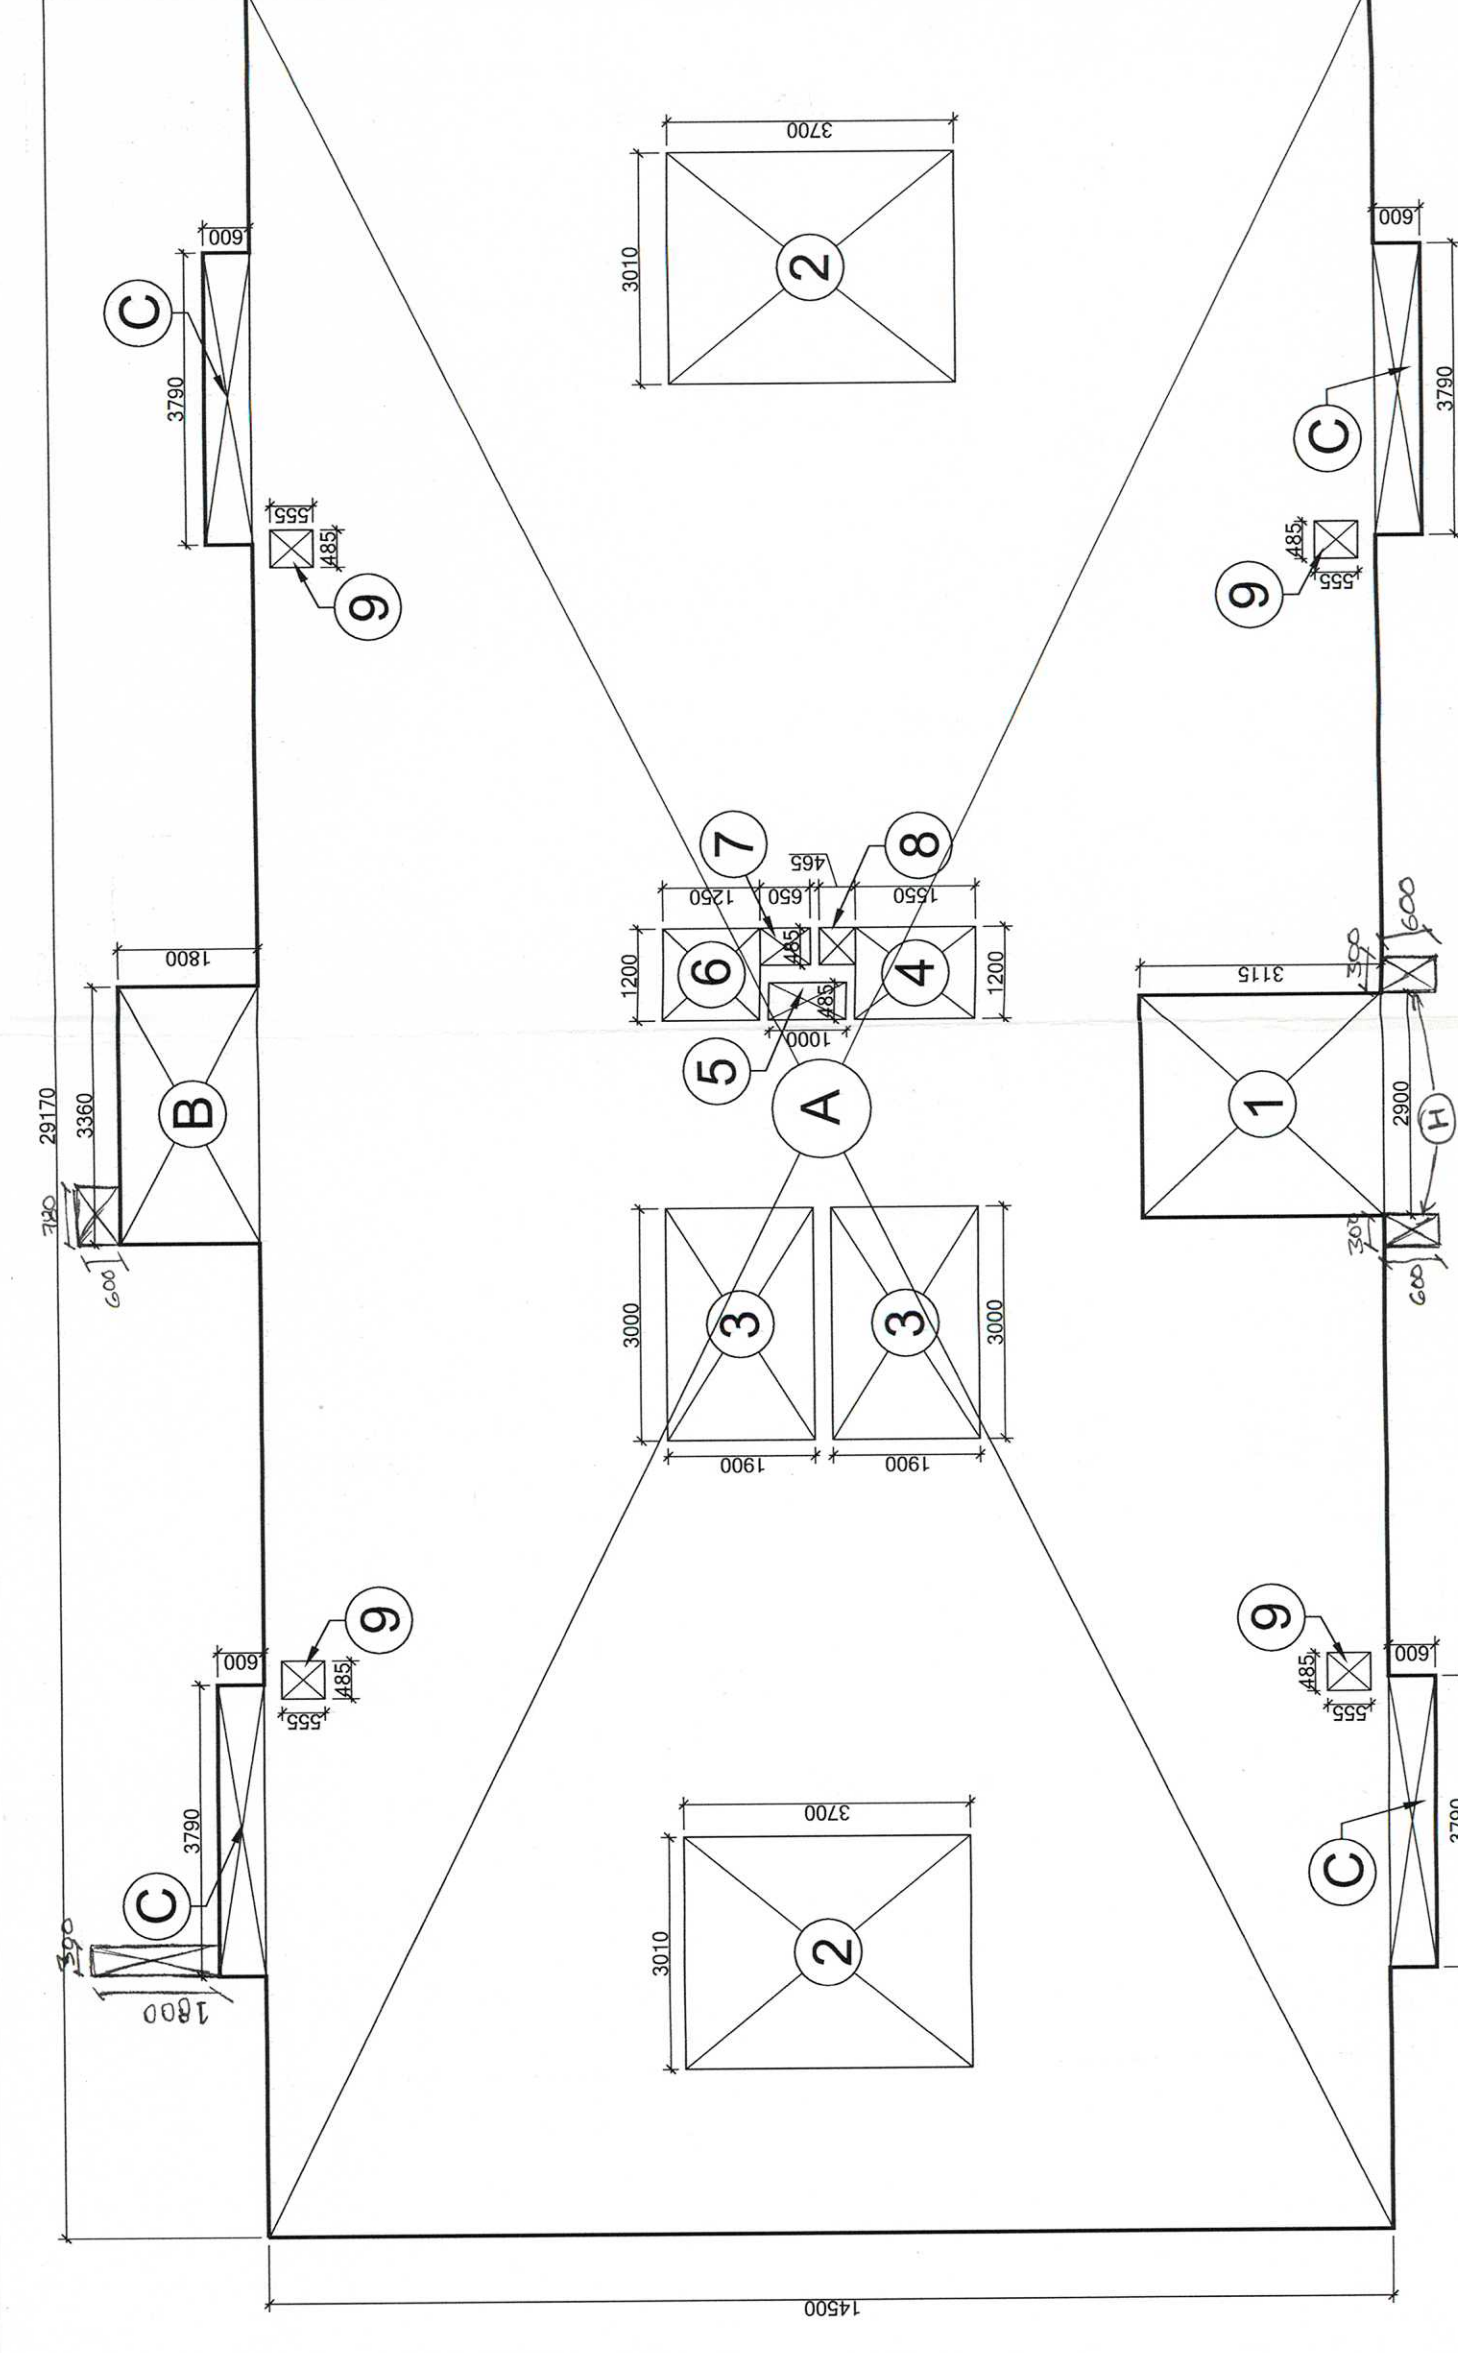
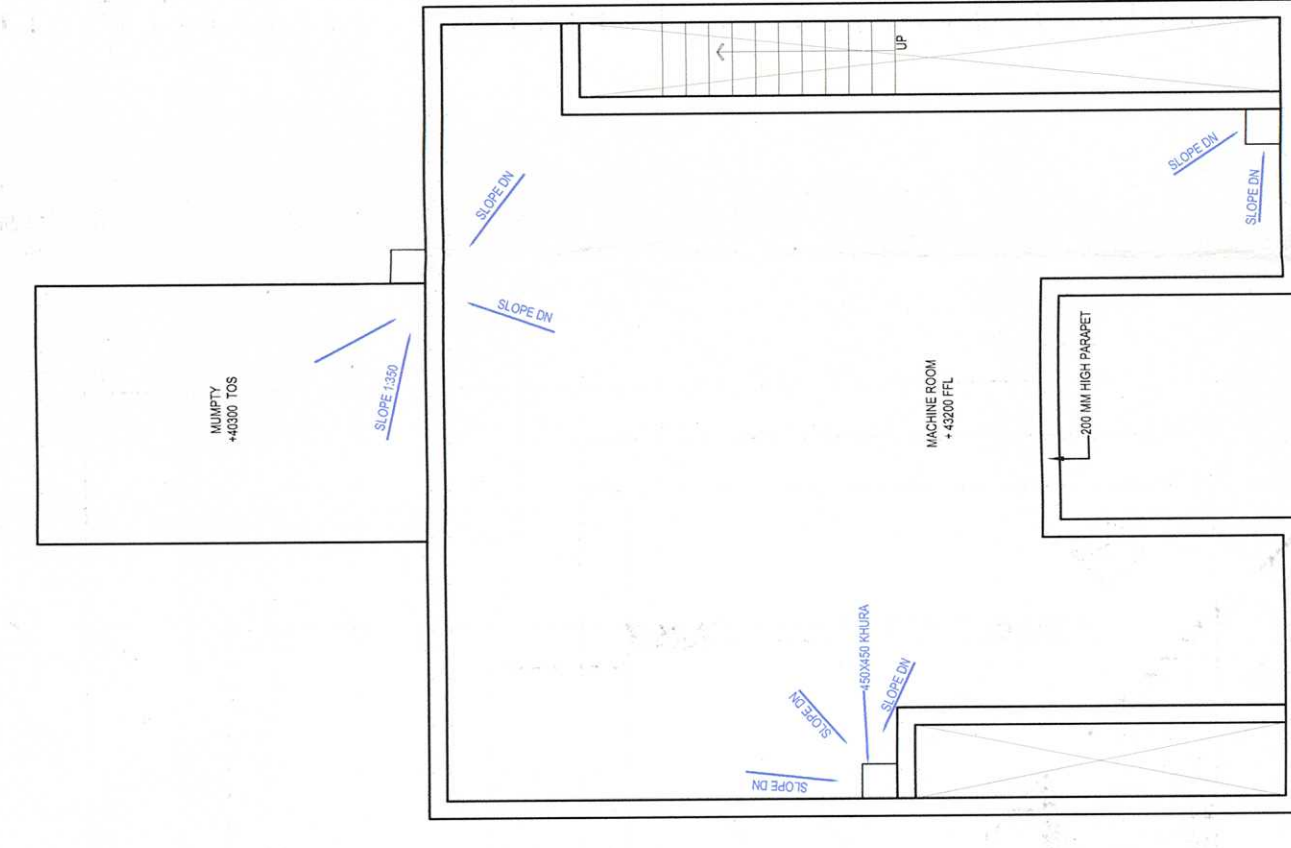
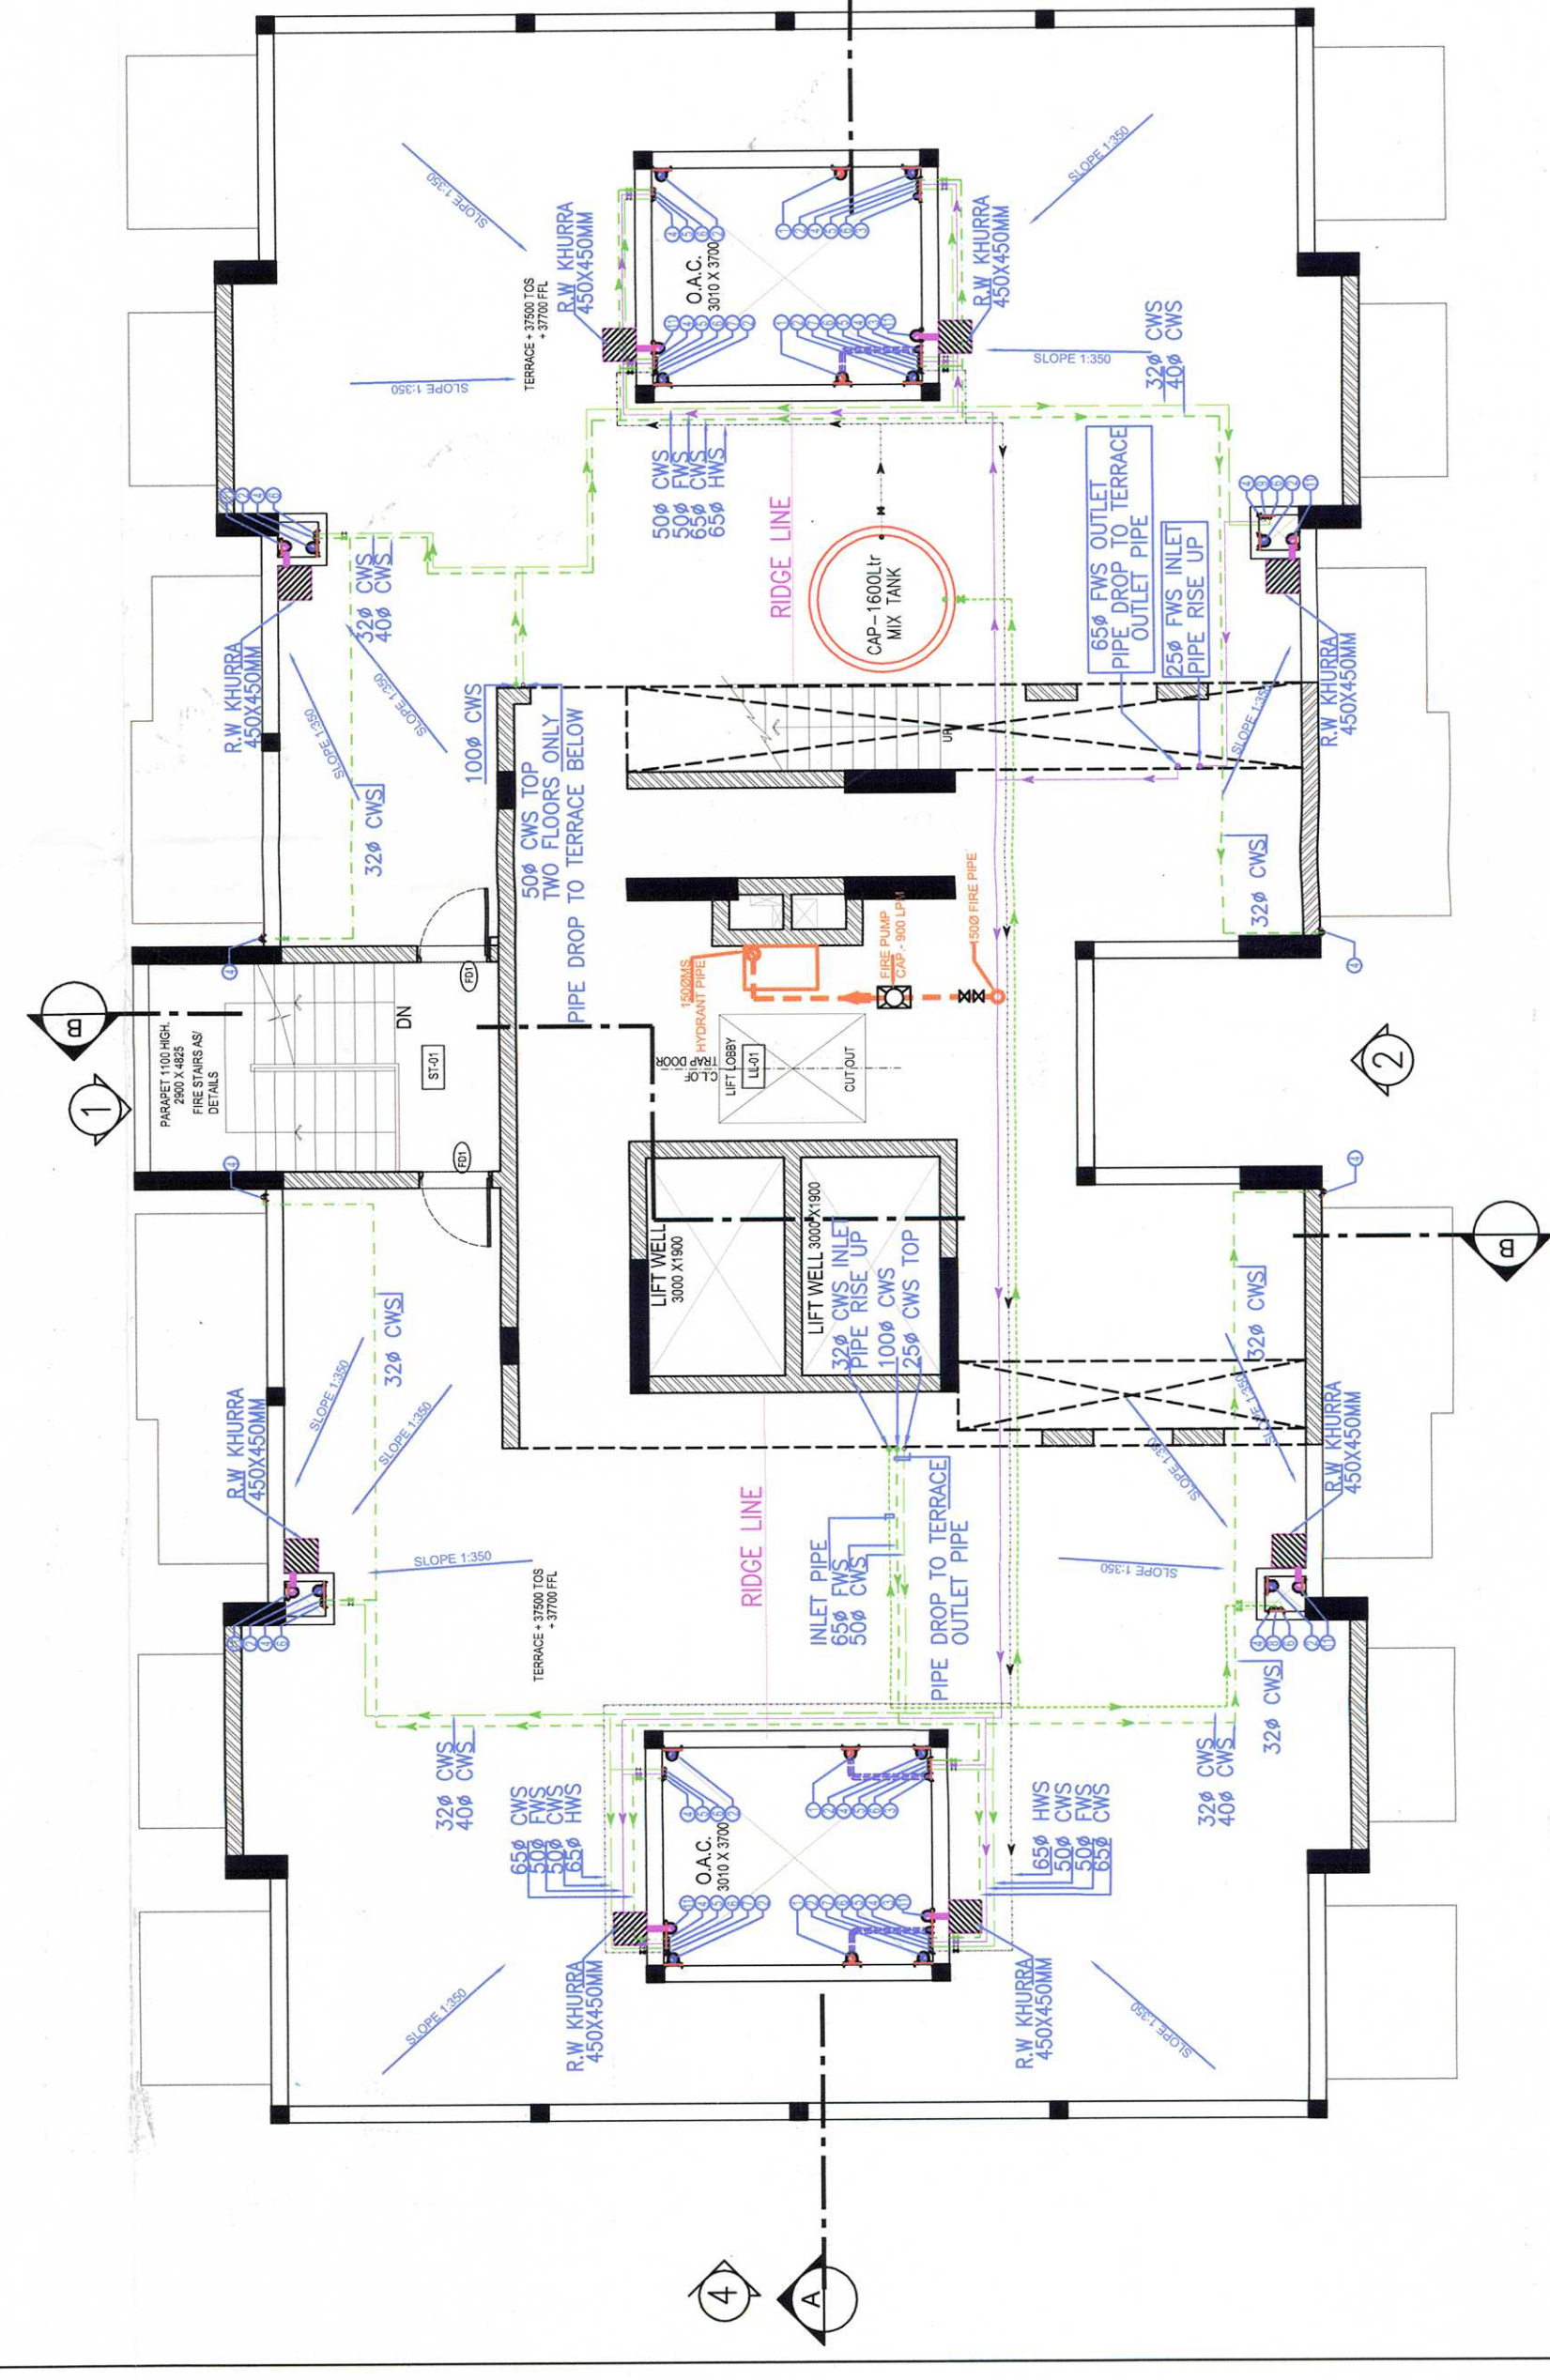
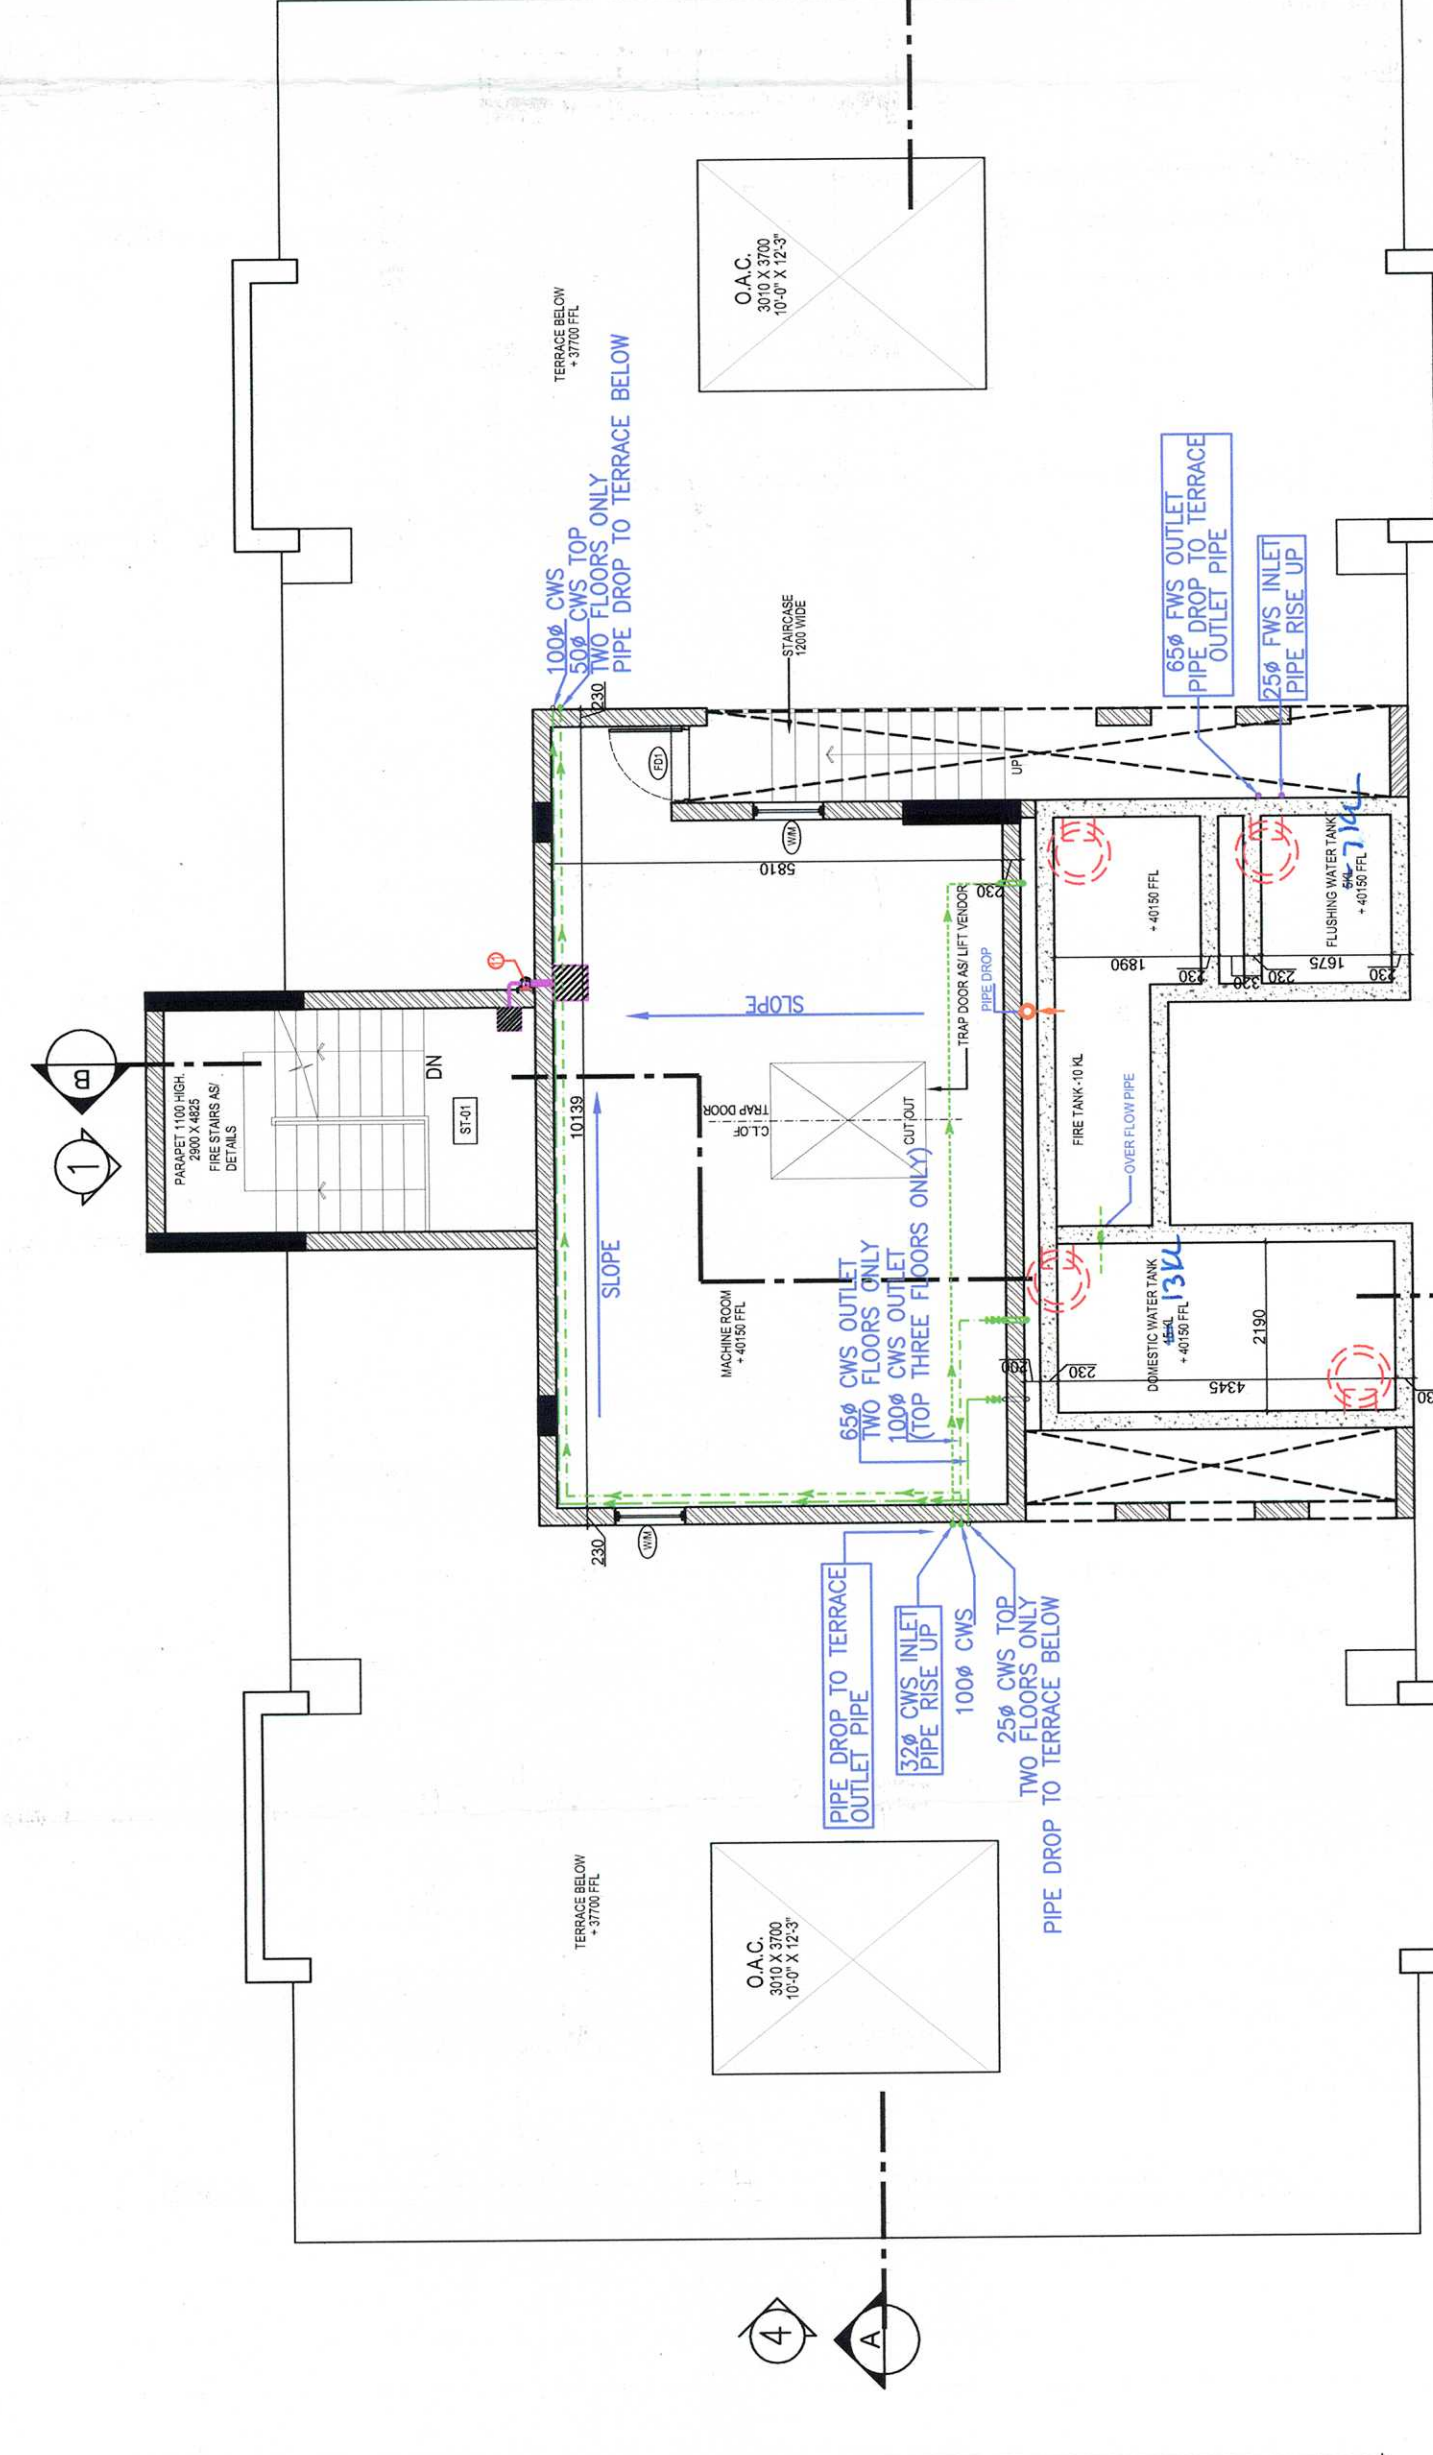
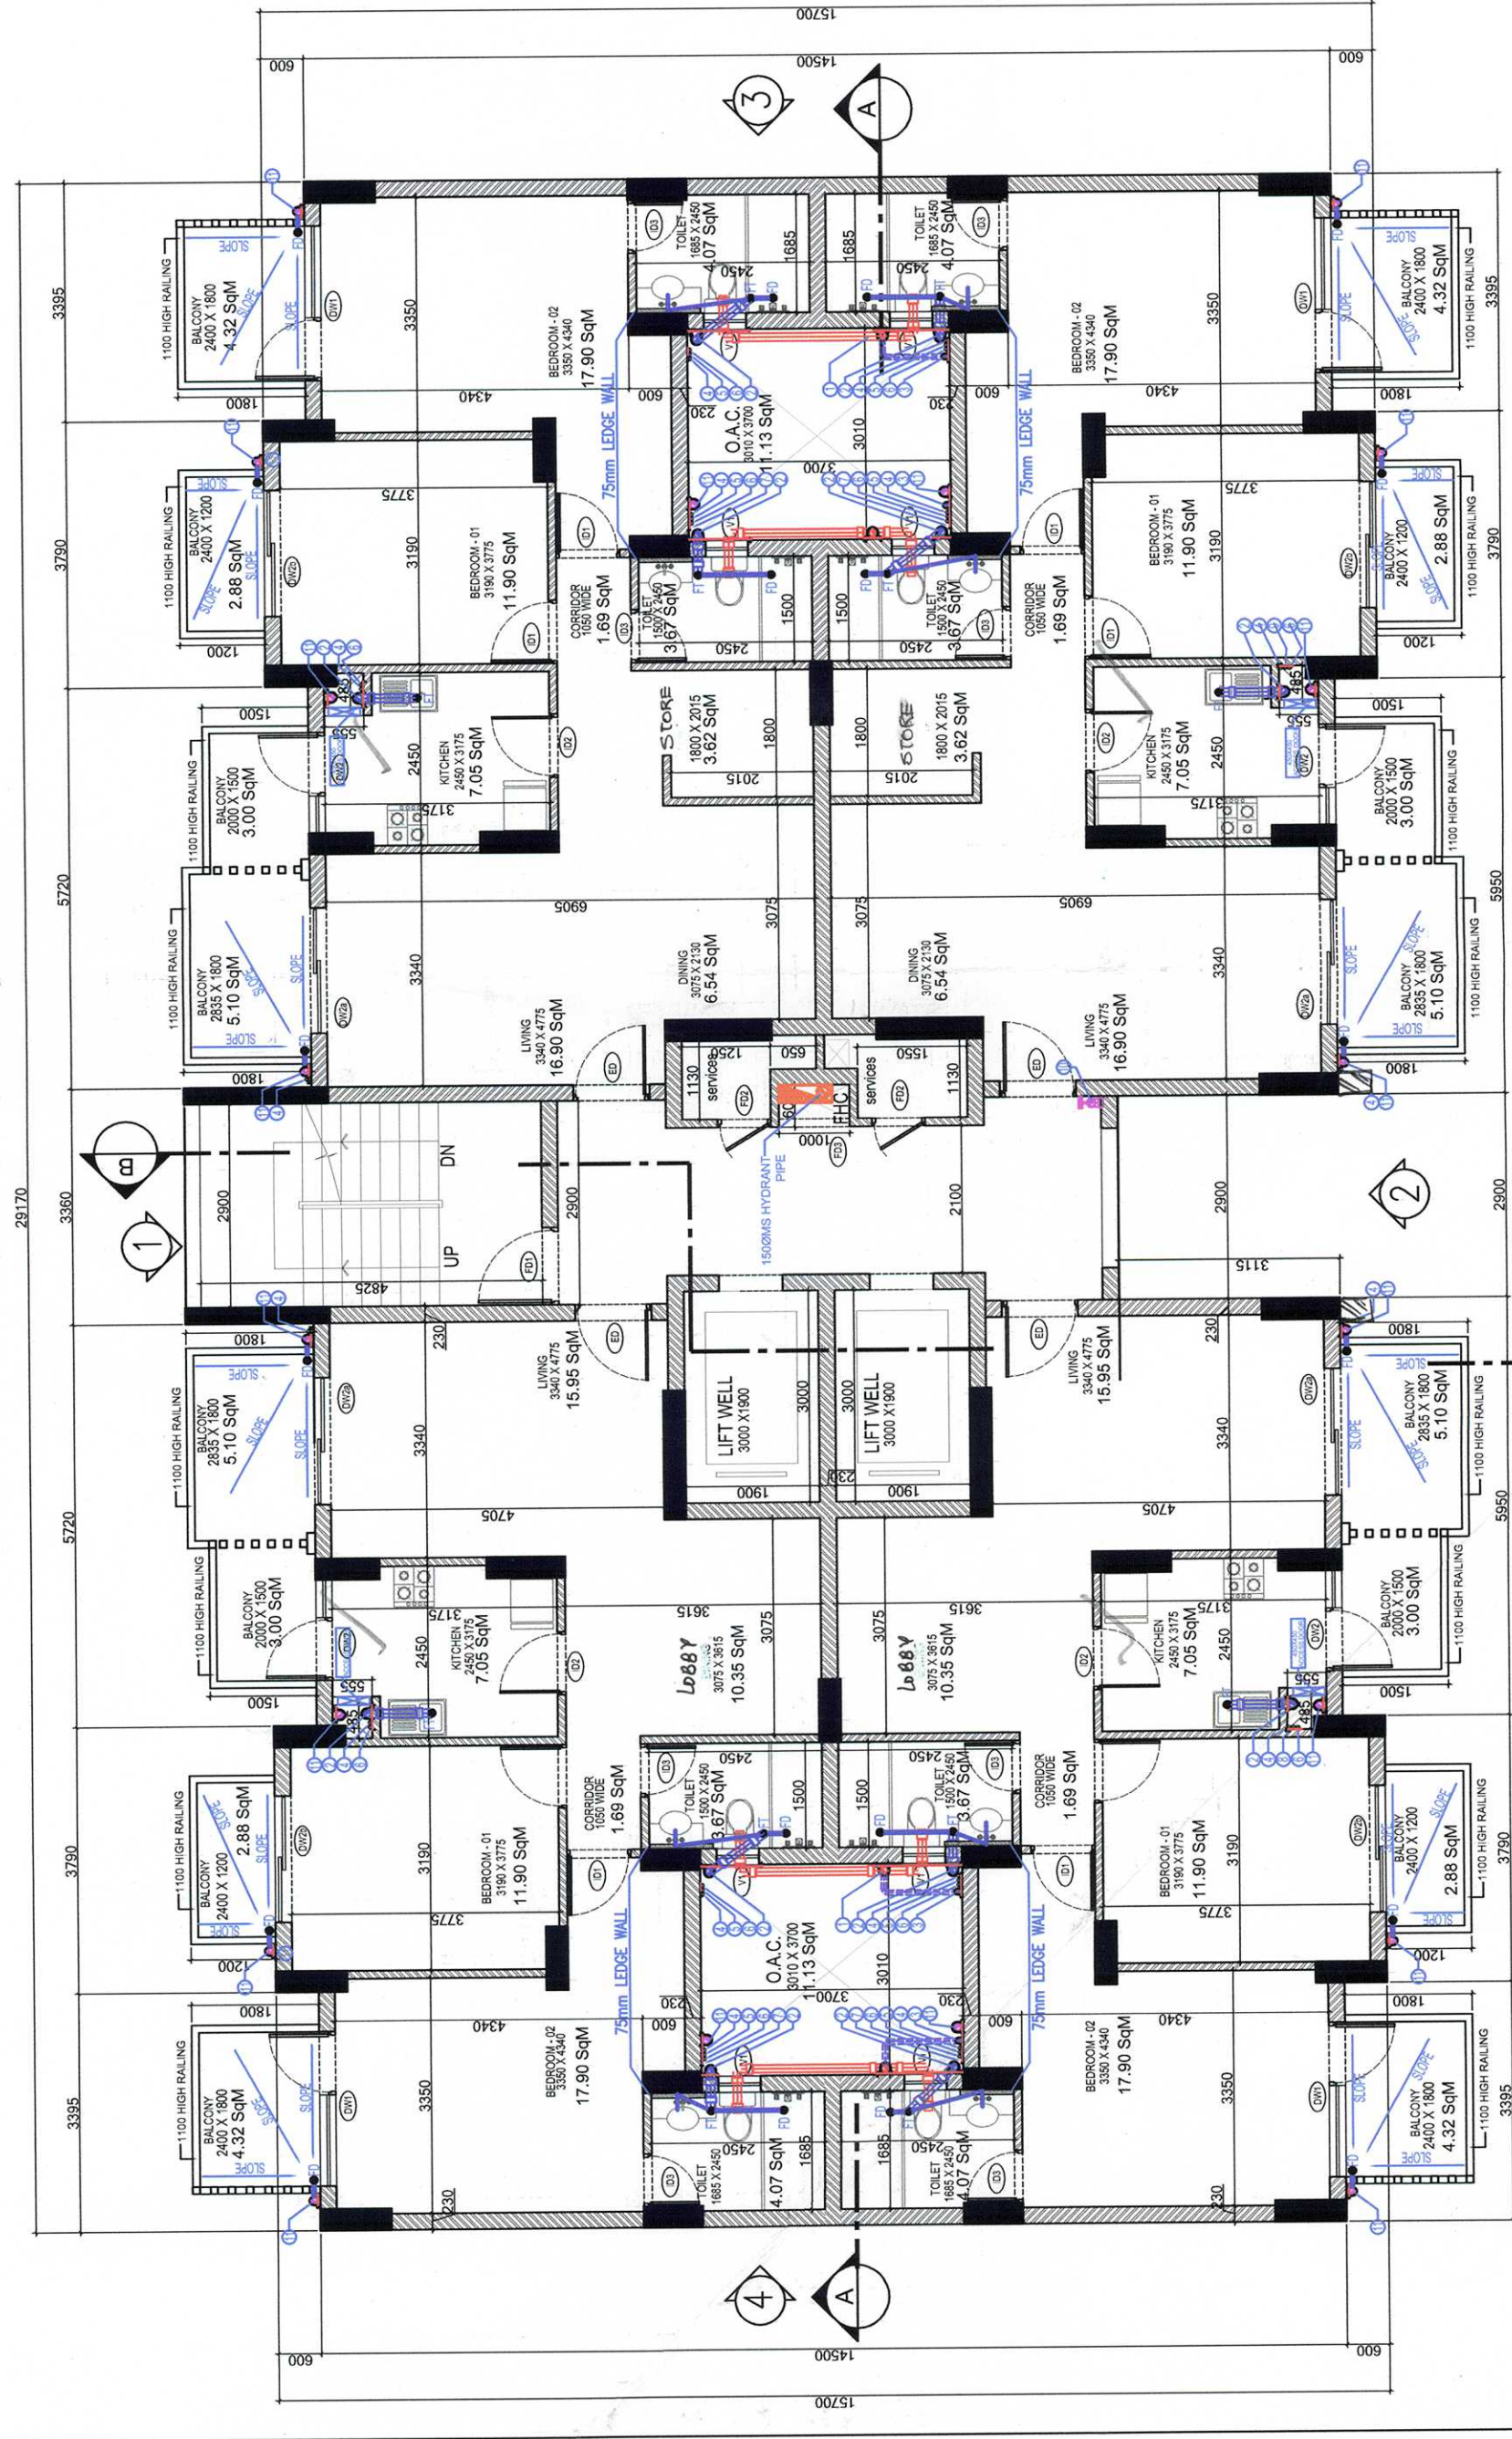
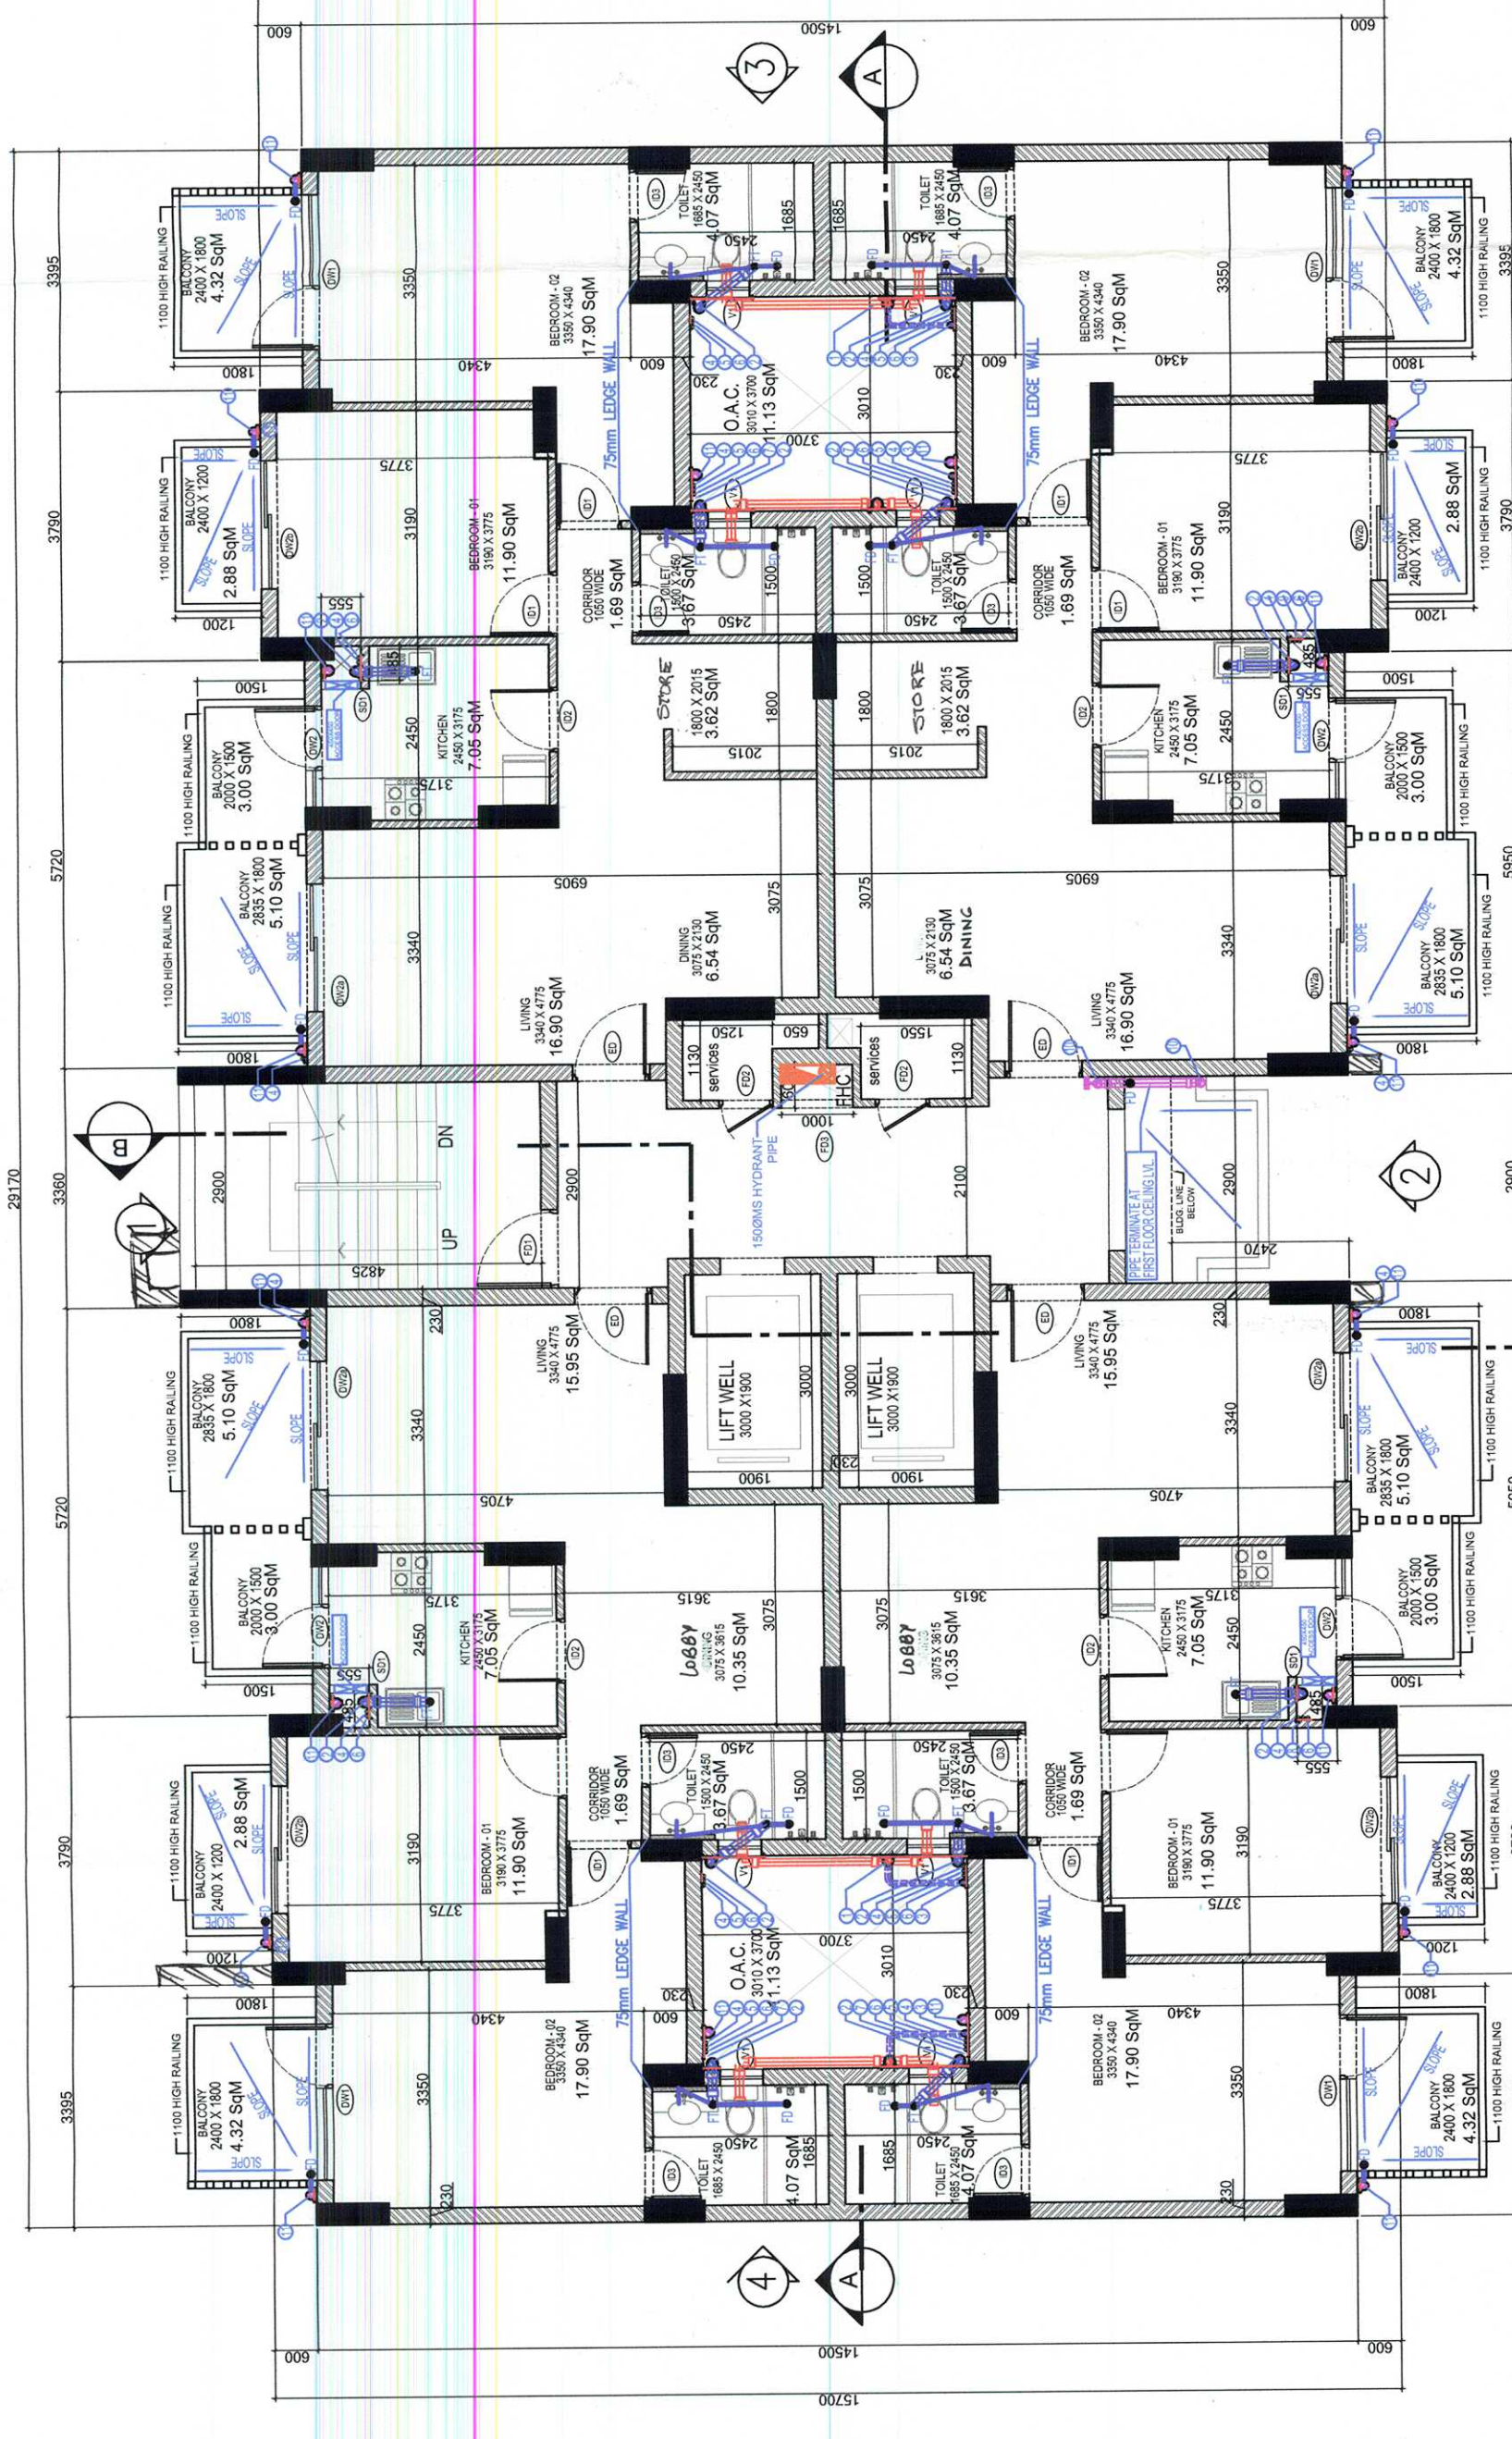


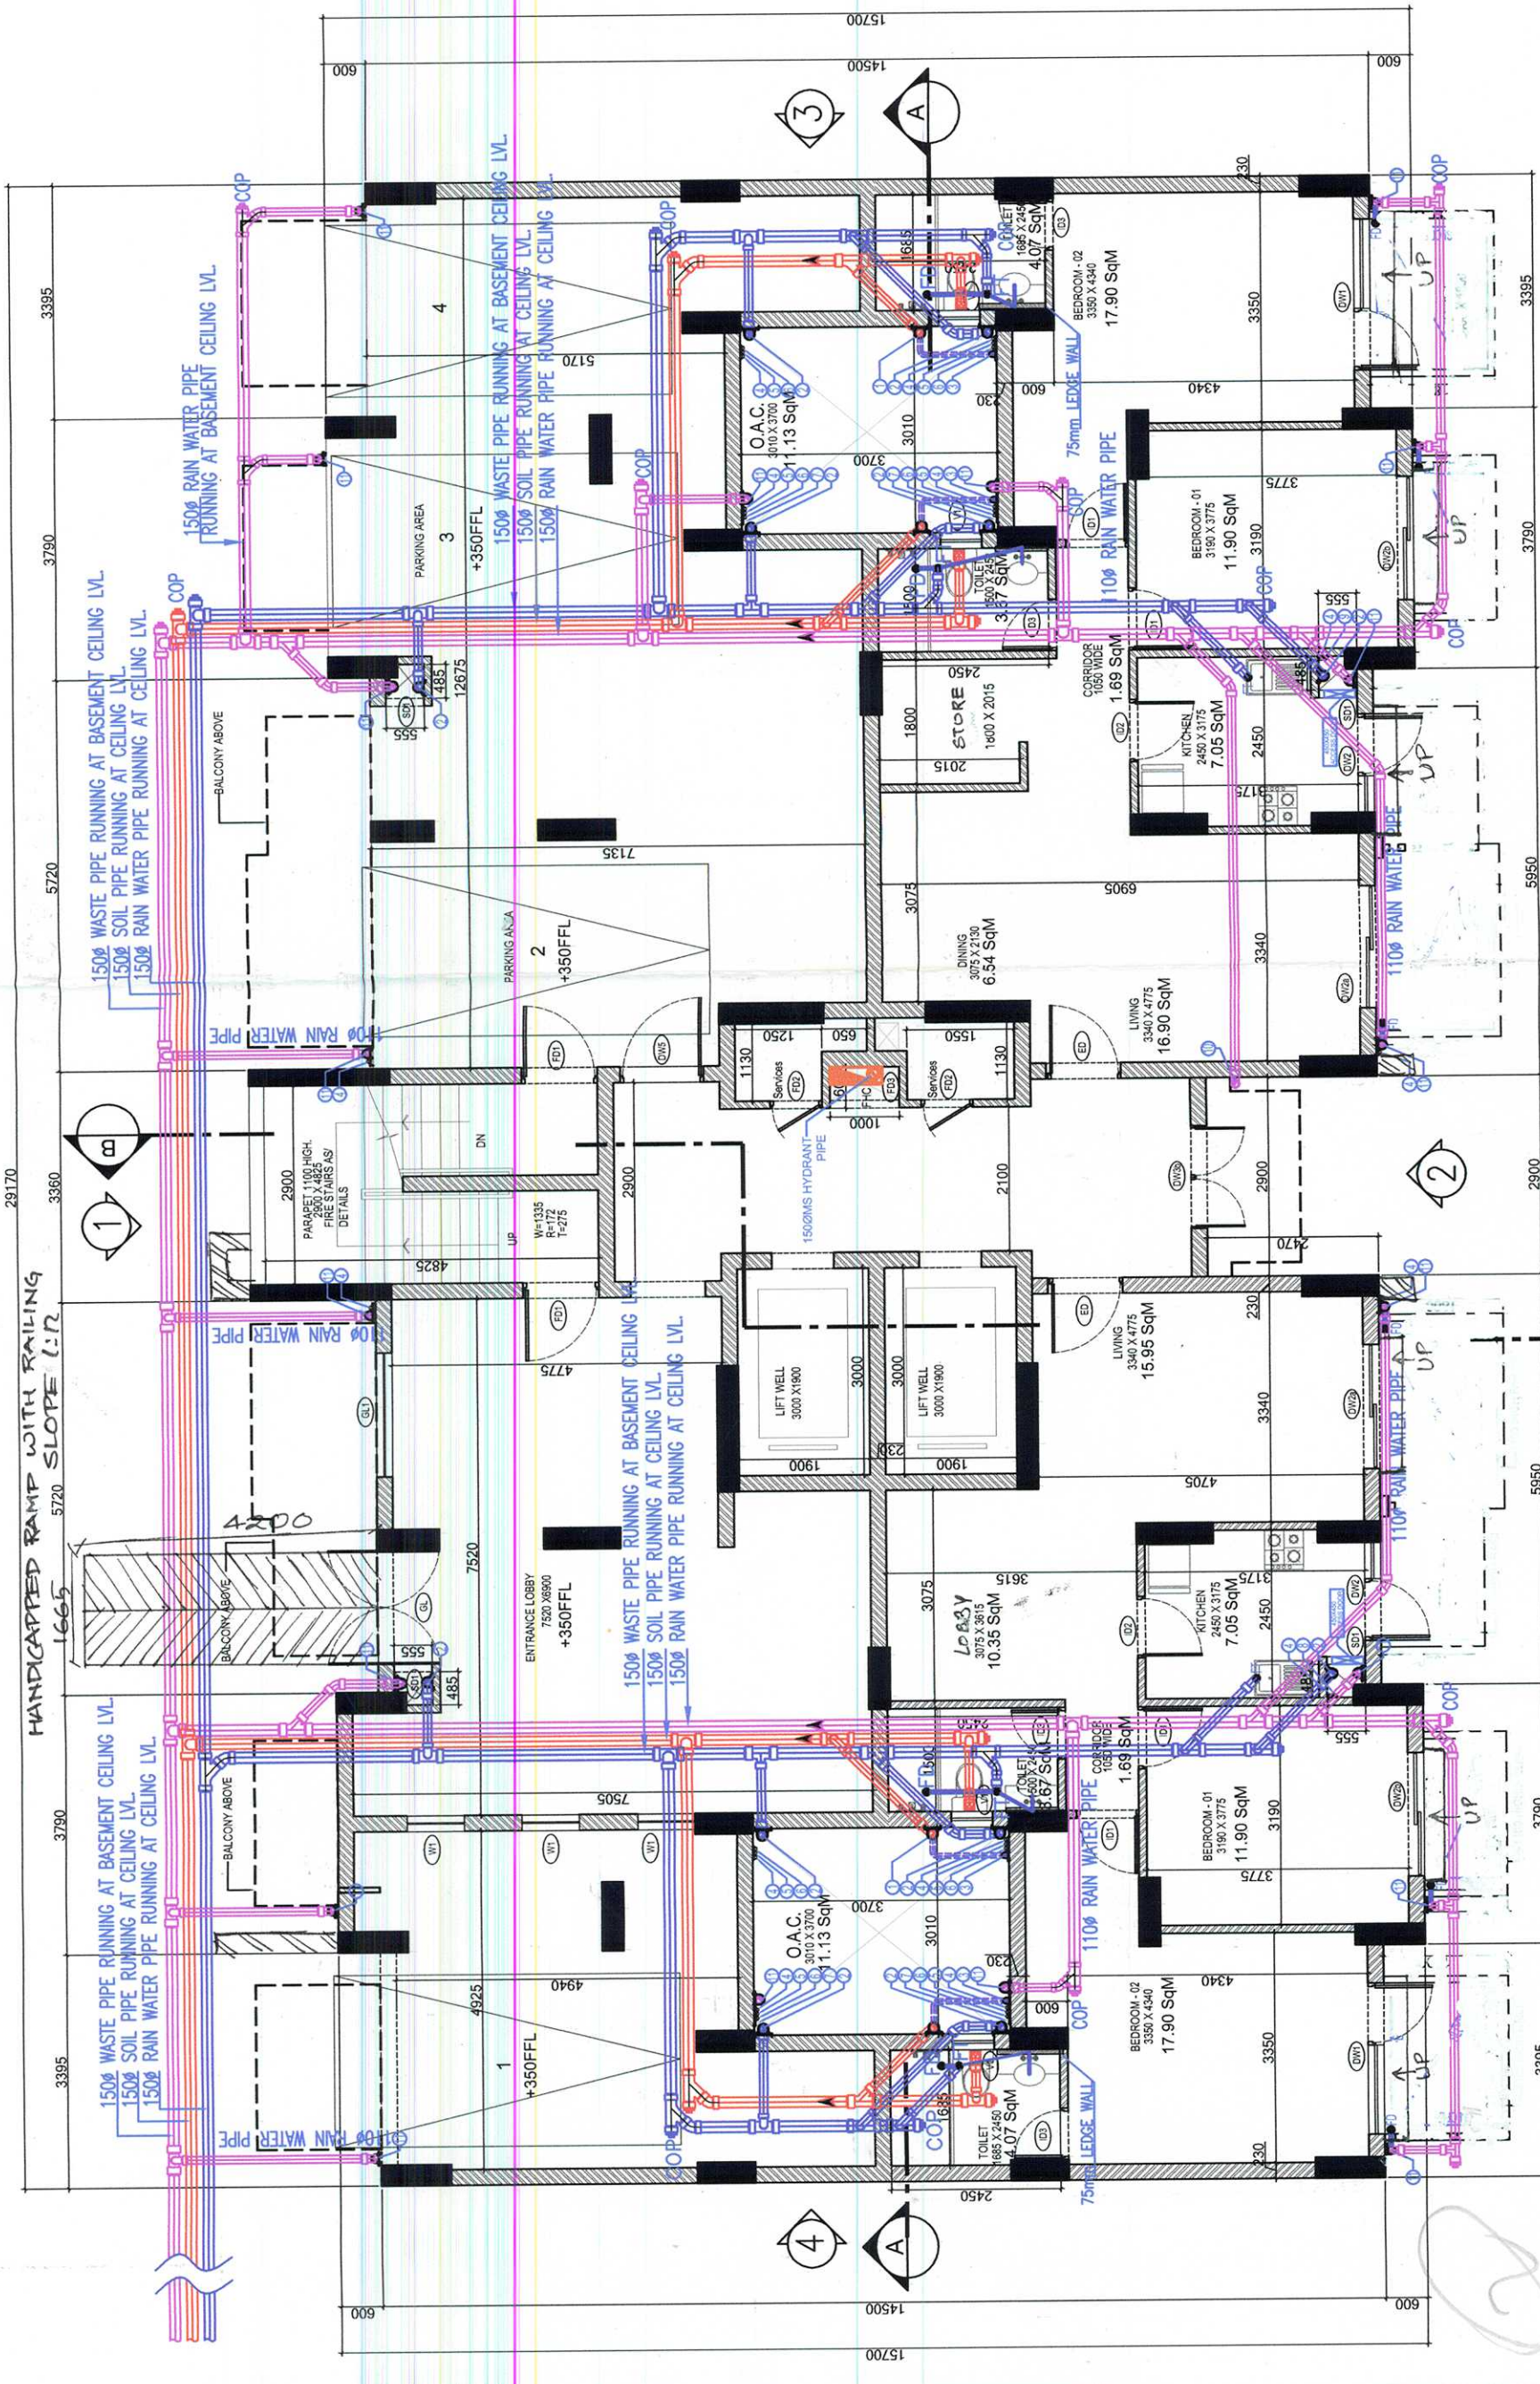

S/NO	LEGEND	GROUND/ENTRANCE	COL. UNITS	UNITS	WALL (MM)	HEIGHT (MM)
1	DIVX3	1	2550	1500	2550	2550
2	DIVX3	1	2550	1500	2550	2550
3	G1	400	2550	1800	2150	2150
4	W1	400	2550	835	2150	2150
5	DIVX3	1	2550	1500	2550	2550
6	DIVX3	1	2550	1500	2550	2550
7	DIVX3	100	2550	1800	2450	2450
8	DIVX3	100	2550	1800	2450	2450
9	DIVX3	100	2550	1800	2450	2450
10	S11	1500	2875	555	1625	1600
11	D1	1	2100	900	2100	2100
12	D1	1	2100	900	2100	2100
13	D1	1	2100	750	2100	2100
14	EP	1	2100	1100	2100	2100
15	EP	1	1650	2100	1100	2100
16	F02	1	2100	750	2100	2100
17	F02	1	2100	750	2100	2100
18	F05	100	2100	900	2000	2000

RAIN WATER PIPE	
WASTE WATER PIPE	
SOIL PIPE	
ANTI SYPHONAGE PIPE	
FIRE SPRINKLER PIPE	
WATER SUPPLY DOWN FACE PIPE	
HOT WATER SUPPLY PIPS	
COLD WATER SUPPLY PIPES	

[illegible][illegible]

B&B CASCADING DOWN FOR GROUND FLOOR (POWER 1)					
NO.	CORR.	LONGIT.	BREATHING	NO.	ANALOGICAL
		20.150m	POSITION		
A		0.00	0.00	1	422.665
B		0.00	0.00	2	6.948
C		0.00	0.00	3	1.020
D		0.70	0.10	4	5.644
E		0.00	0.00	5	1.020
F		5.505	0.10	1	1.020
G		0.00	0.00	2	1.020
H		0.00	0.00	3	1.020
I		0.00	0.00	4	1.020
J		0.00	0.00	5	1.020
TOTAL LOGISTICS					438.627
1		2.300	0.00	1	7.143
2		1.000	0.00	2	21.774
3		1.000	0.00	3	1.020
4		1.000	0.00	4	4.532
5		1.000	0.00	5	1.020
6		2.050	0.00	1	4.646
7		1.000	0.00	2	1.020
8		1.000	0.00	3	31.051

[illegible]

Notes
◦ Dimensions are not to be scaled. ◦ Dimensions are not to be scaled. ◦ All Dimensions Are in MM ◦ All windows & ventilators are openable ◦ All walls are 230/115 thk. Brick Wall

LEGEND FOR PLUMBING	
(1)	110 ØD ØPVC SOIL & VENT PIPE
(2)	110 ØD ØPVC WASTE & VENT PIPE
(3)	75W ANTISIPHONAGE PIPE
(4)	DOMESTIC WATER SUPPLY LINE PIPE
(5)	FLUSHING WATER SUPPLY LINE PIPE
(6)	DOMESTIC WATER SUPPLY LINE PIPE (DOMESTIC CONNECTIONS ONLY)
(7)	SOLAR PANEL LINE TAKE PIPE
(8)	35W ØPVC WATER SUPPLY RISER (DOMESTIC)
(9)	35W ØPVC WATER SUPPLY RISER (FLUSHING)
(10)	110 ØD ØPVC RAIN WATER PIPE FOR BALCONY
(11)	110 ØPVC RAIN WATER PIPE FOR TERRACE
(12)	DRAIN CONNECTION

DOOR WINDOW SCHAULE						
S/N	LEGEND	CIL (MM)	UNTEL (MM)	UNTEL (MM)	HEIGHT (MM)	
GROUND-INTERIOR LOBBY						
1	DW3x6	2550	2550	1550	2550	
2	DW3x6	2550	2550	1650	2550	
3	GL1	400	2550	2550	2150	
4	GL1	400	2550	835	2150	
5	GL1	400	2550	835	2150	
6	DW1	1000	2100	2150/2550/2550	2150	
7	DW2x6	100	2550	2100	2450	
8	DW2x6	100	2550	2100	2450	
9	DW2x6	100	2550	2100	2450	
10	SD1	1550	2575	555	1525	
11	IO1	2100	900	2100	2100	
12	IO1	2100	900	2100	2100	
13	IO3	2100	750	2100	2100	
14	FD	2100	1100	2100	2100	
15	FD1	1550	2100	2100	2100	
16	FD1	1550	2100	2100	2100	
17	FD2	2100	750	2100	2100	
18	FD3	100	2100	2000	2000	

RAIN WATER PIPE	
WASTE WATER PIPE	
SOIL PIPE	
ANTI SIFONAGE PIPE	
FIRE SPRINKLER PIPE	
WATER SUPPLY DOWN FACE PIPE	
HOT WATER SUPPLY PIPE	
COLD WATER SUPPLY PIPES	

[illegible]

Architect's Signature *L.No. 252 of 08.11.20*
L.No. 50 of 05.06.20
Manish K. Bagga L.No. 63 of 19
 Manish K. Bagga Architect
 Council of Architecture
 Registration No. CA/9518628
 Total

Architects
Arcop Associates Pvt. Ltd.
Plot No-36, Sector-32, Gurgaon.
HARYANA - 122001

INDIA
Ph.: +91-124-4595500 , 4371200
Fax: +91-124-4595550

Clients:
M/s Selene Constructions
F-60, Malhotra Building, II Floor,
Cannaught Place, New Delhi-110001
& Vinodhvaal Land Development Ltd.

Job Title BUILDING PLAN OF
REVISED/ GROUP HOUSING AT
SECTOR-103, FALLING IN REVENUE
ESTATE OF VILLAGE DAULATABAD
THESIL & DIST GIRGAON HARYANA

Drawing Title	GROUND FLOOR, TYPICAL FLOOR TERRACE FLOOR PLAN WITH AREA DIAGRAM - TOWER L
---------------	--

	Drawing No.
Job No.	AR-A-38
Drawn	Checked
Date	Scale
	Revisions