


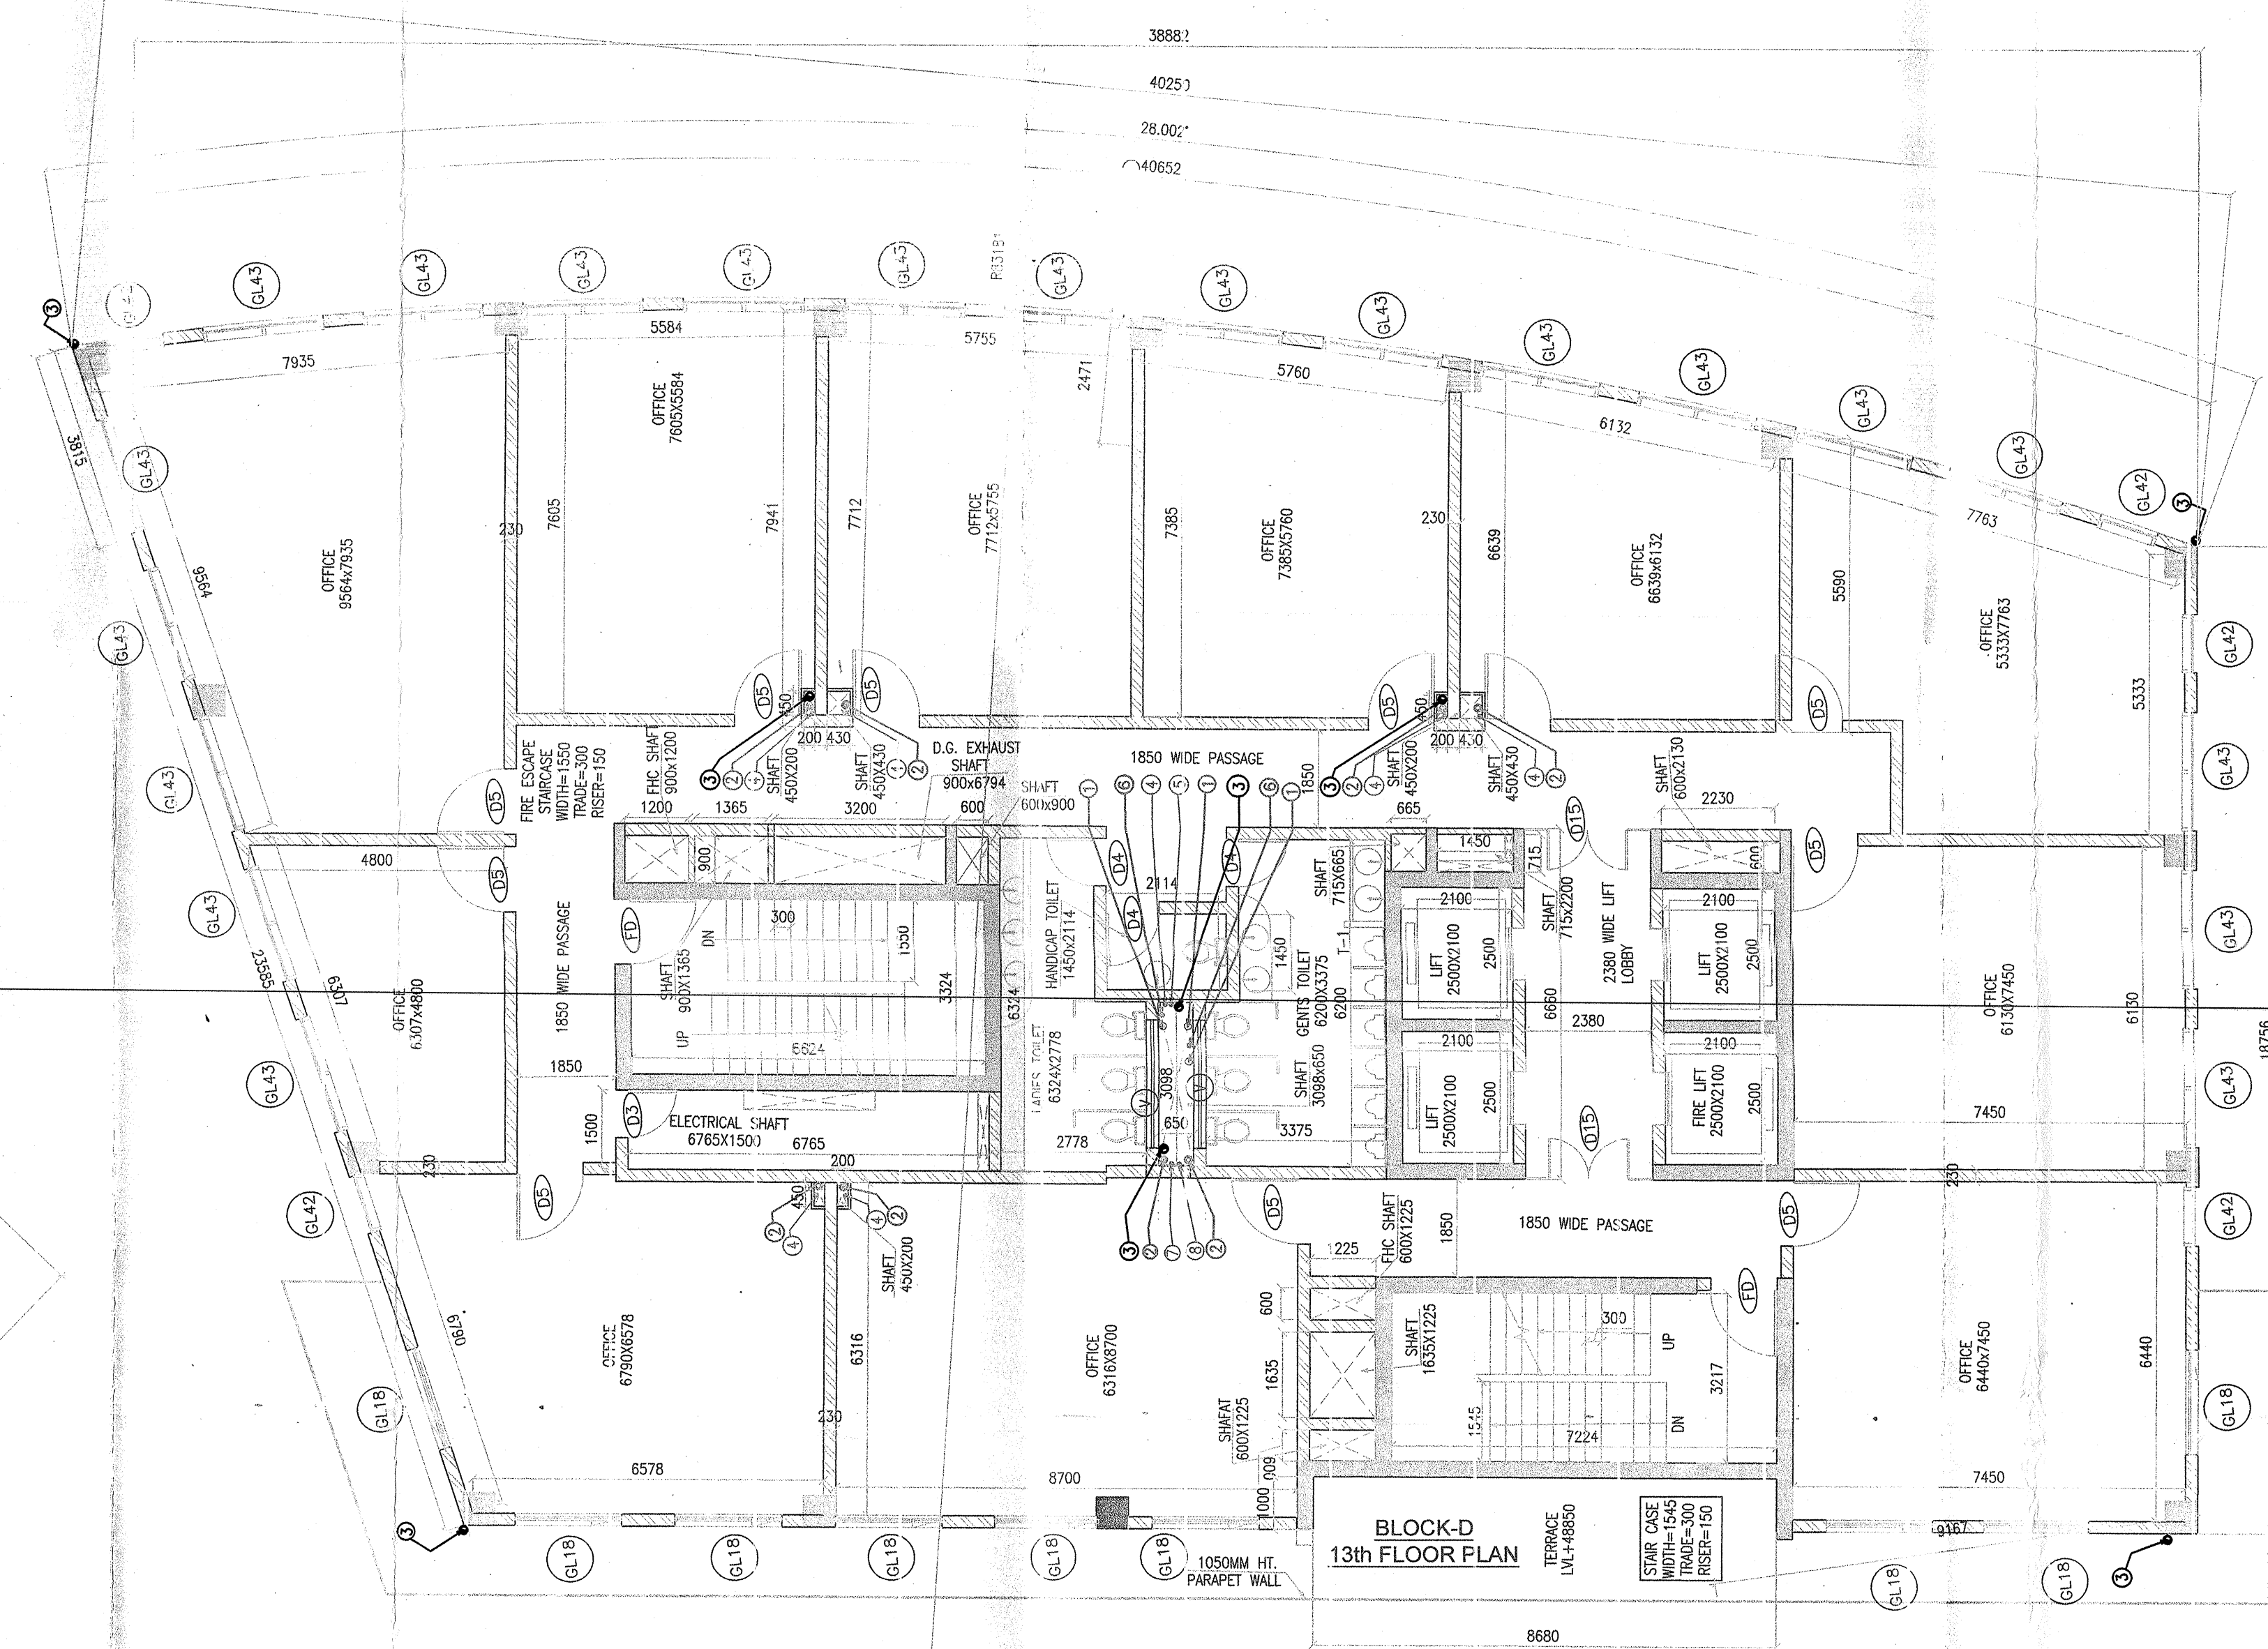

(BLOCK-D)
12th FLOOR PLAN
LEVEL +45250



Note:-

1. BUILDING WILL BE DESIGNED (STRUCTURES) AS PER RELEVANT IS CODES FOR EARTH QUAKE RESISTANCE.
2. THE BUILDING COMPLY WITH FIRE NORMS

LEGEND:-

SYM.	DESCRIPTION
①	100# SOIL & VENT PIPE
②	100# WASTE & VENT PIPE
③	150# RAIN WATER PIPE
④	100# RAIN WATER PIPE
⑤	80x6.5x4.6# DOMESTIC WATER SUPPLY
⑥	80x6.5x4.6# FLUSHING WATER SUPPLY
⑦	75# ANTI-SIPHONAGE PIPE
⑧	50# DOMESTIC WATER TANK FILLING
⑨	40# DOMESTIC WATER TANK FILLING
⑩	KHURRA 450X450

Project:-

PROPOSED COMMERCIAL COLONY AREA MEASURING 2.961 ACRES. (LICENCE NO. 110 OF 2010 DATED 29-12-2010) IN SECTOR-82-A, GURGAON MANESAR URBAN COMPLEX BEING DEVELOPED BY SH. TEJPAL S/O SH. BADAM SINGH AND SMT. SAKUNTALA DEVI W/O SH. TEJPAL IN COLLABORATION WITH M/S VATIKA LTD.

Associate Architects

RSMS
ARCHITECTS

RSMS ARCHITECTS PVT. LTD.
69,Nora Niwas Bhawani Kunj
(Behind D2), Vasant Kunj,
New Delhi-110070.
Tel.: 011-26898613, 26898617
www.rsms-arch.com


(Signatures of Project Team Members)

AD JD PA ATP

Checked and found ok for Public Health
Internal Circulation only subject to comments in
forwarding letter No. SMD/2010, D. 5.5.1.1

ARCHITECT'S SEAL
& SIGNATURE

OWNER'S SEAL
& SIGNATURE

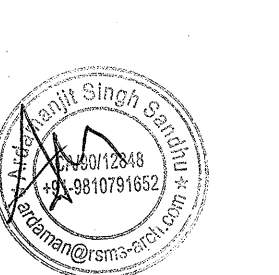

For Vatik Limited
Authorized Signatory

JULY-2011 Scale : 1:100
Drawing Title:-
12TH & 13TH
FLOOR PLAN
(BLOCK-D)
Drawing No:-
D-04