


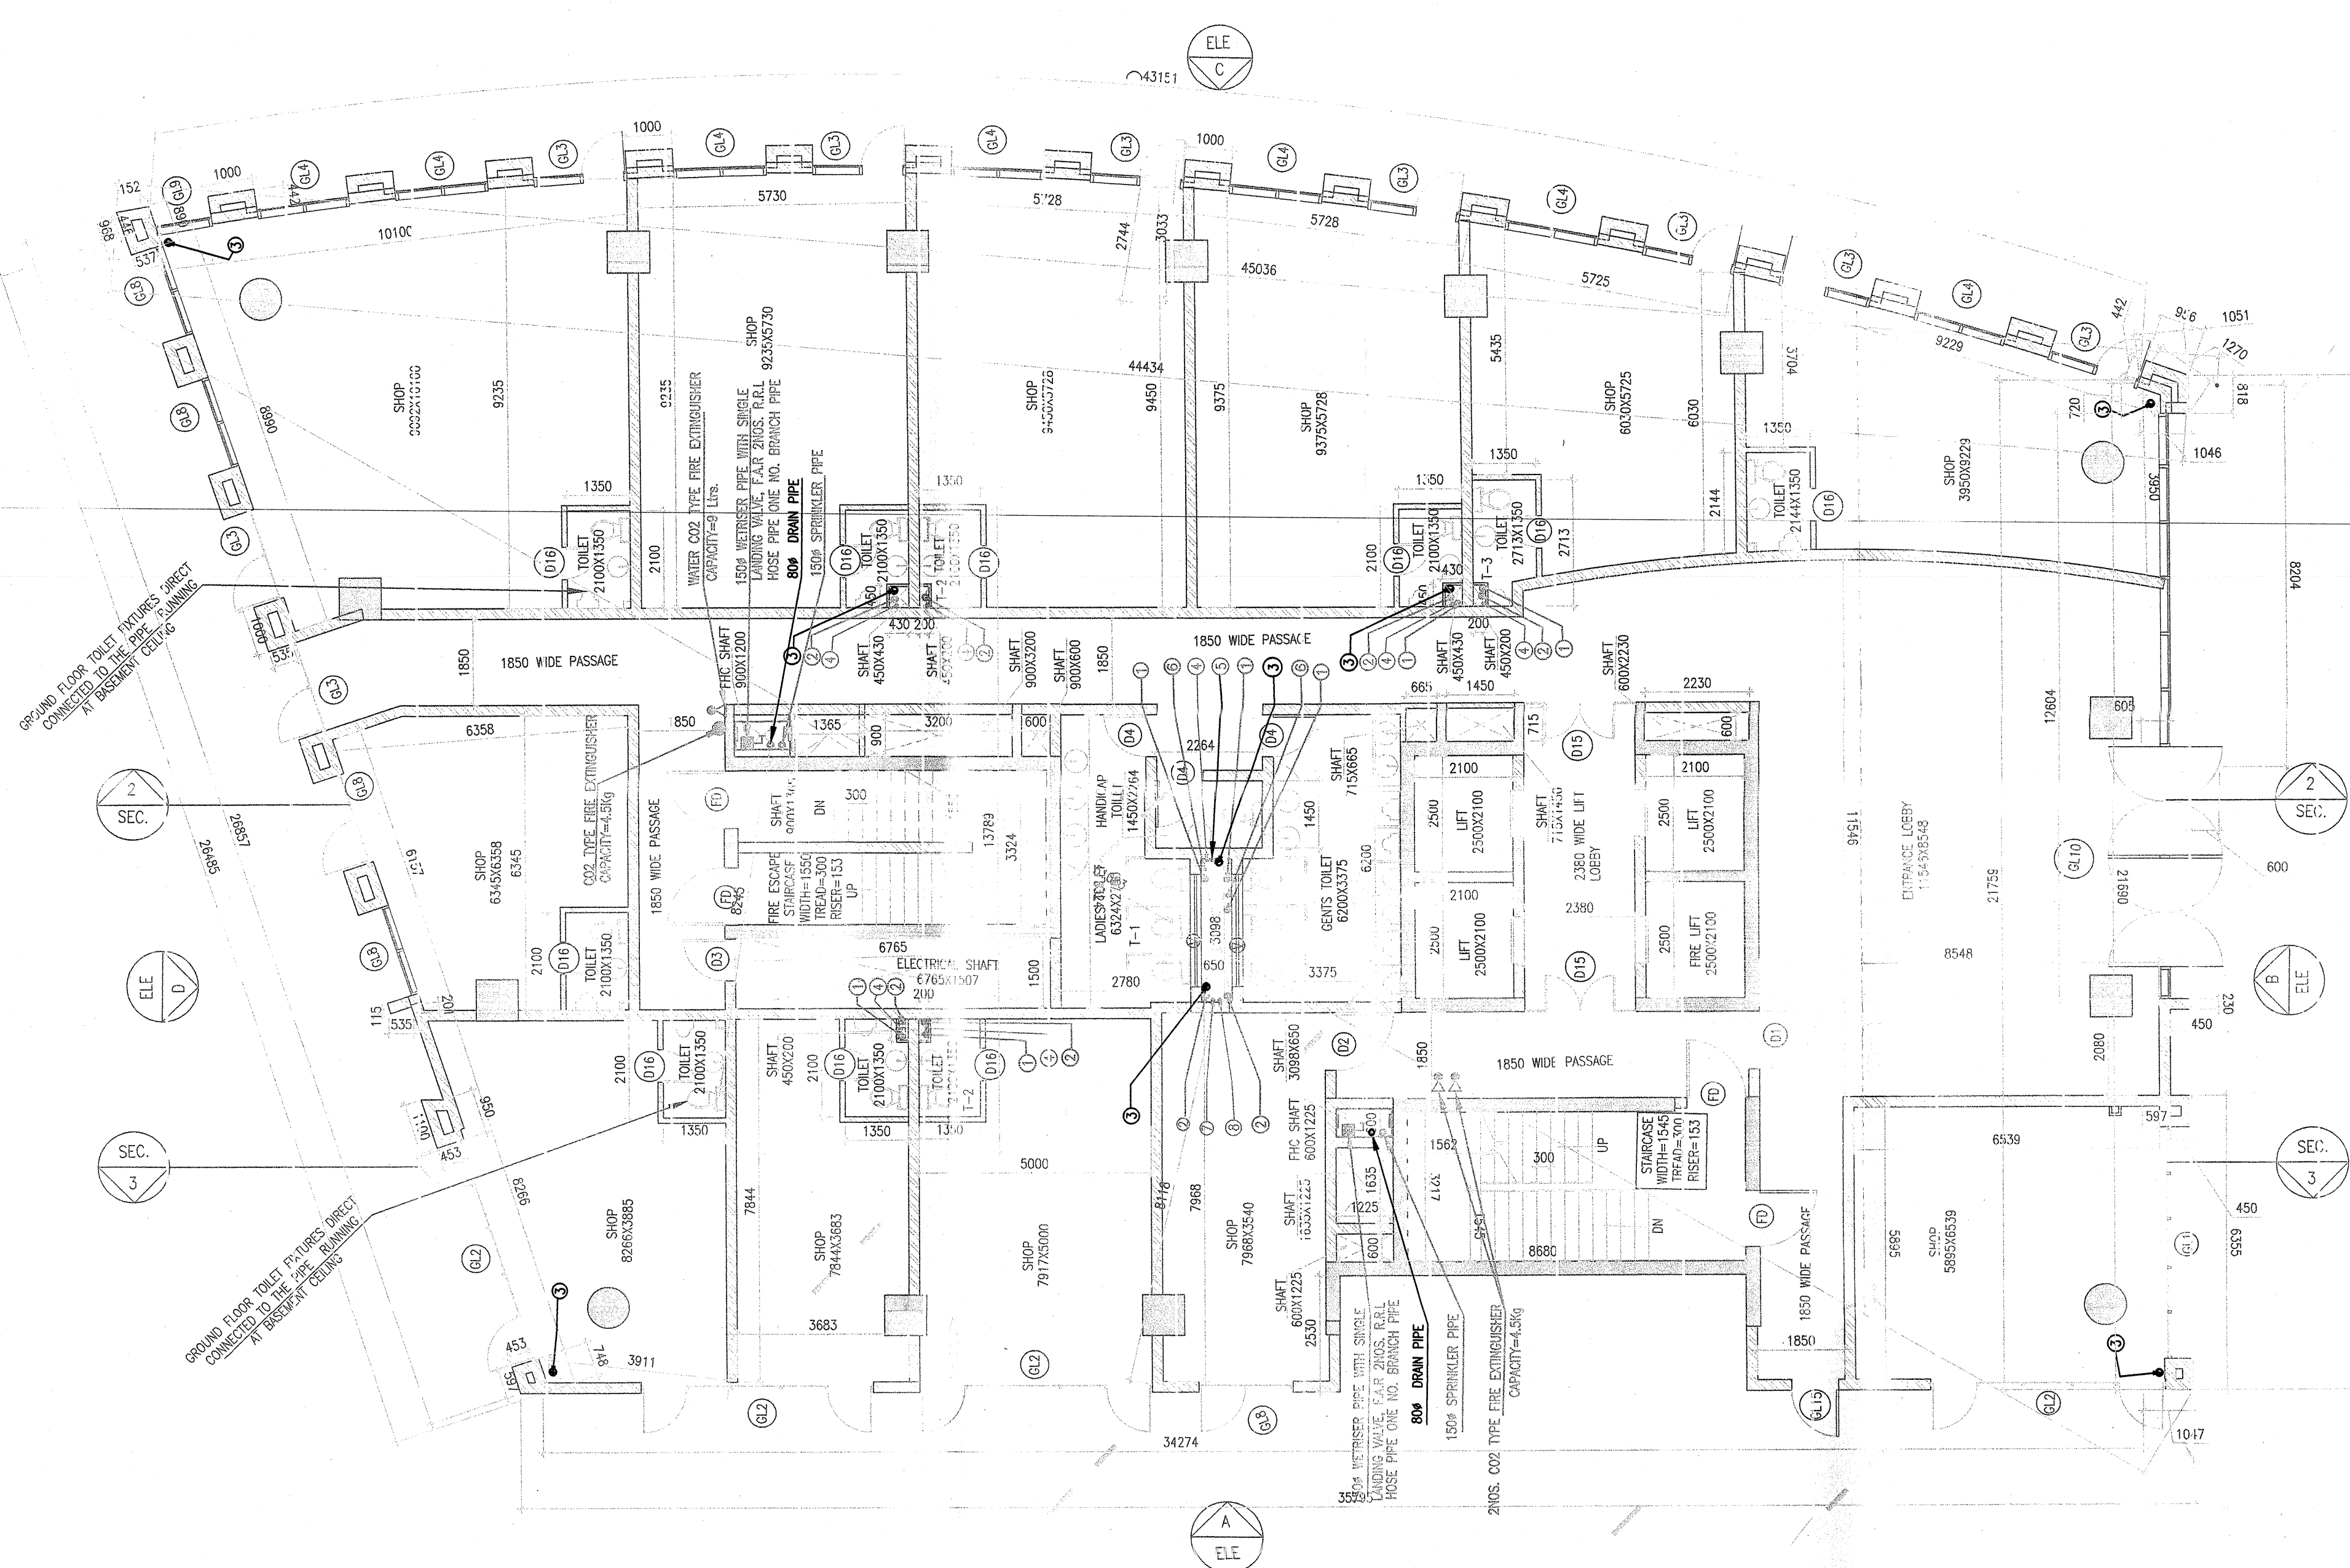


(BLOCK-D)
GROUND FLOOR PLAN

DOORS / WINDOWS SCHEDULE FOR OFFICE TOWER			
TYPE	SIZE	ALL LV. BUILDING	REMARKS
D1	1240x2120	-	D
D2	1040x2120	-	D
D3	1240x2120	-	D
D4	1040x2120	-	D
D5	1240x2120	-	D
D6	1040x3065	-	D
D7	940x2120	-	D
D8	740x2120	-	D
D9	740x2120	-	D
D10	1040x4240	-	D
D11	780x2120	-	D
D12	4024x2120	-	D
D13	1840x2120	-	D
D14	1540x2120	-	D
D15	500x9225	-	D
D16	2000x9225	-	D
D17	2000x9225	-	D
D18	1693x9225	-	D
D19	1510x9225	-	D
D20	1980x9225	-	D
D21	1600x9225	-	D
D22	1300x9100	-	D
D23	1190x9225	-	D
D24	1190x9225	-	D
D25	2000x1800	-	D
D26	1500x3325	-	D
D27	1500x3325	-	D
D28	1500x3325	-	D
D29	1500x3325	-	D
D30	7540x9225	-	D
D31	1102x9225	-	D
D32	7910x3325	-	D
D33	2500x2600	-	D
D34	2400x1500	-	D

Note :-
1. BUILDING WILL BE DESIGNED (STRUCTURES) AS PER RELEVANT IS CODES FOR EARTH QUAKE RESISTANCE.
2. THE BUILDING COMPLY WITH FIRE NORMS

LEGEND :-	
SYM.	DESCRIPTION
①	100mm SOIL & VENT PIPE
②	100mm WASTE & VENT PIPE
③	150mm RAIN WATER PIPE
④	100mm RAIN WATER PIPE
⑤	80mm, 65mm, 40mm DOMESTIC WATER SUPPLY
⑥	80mm, 65mm, 40mm FLUSHING WATER SUPPLY
⑦	75mm ANTISIPHONAGE PIPE
⑧	50mm DOMESTIC WATER TANK FILLING
⑨	40mm DOMESTIC WATER TANK FILLING
⑩	KHURRA 450X450

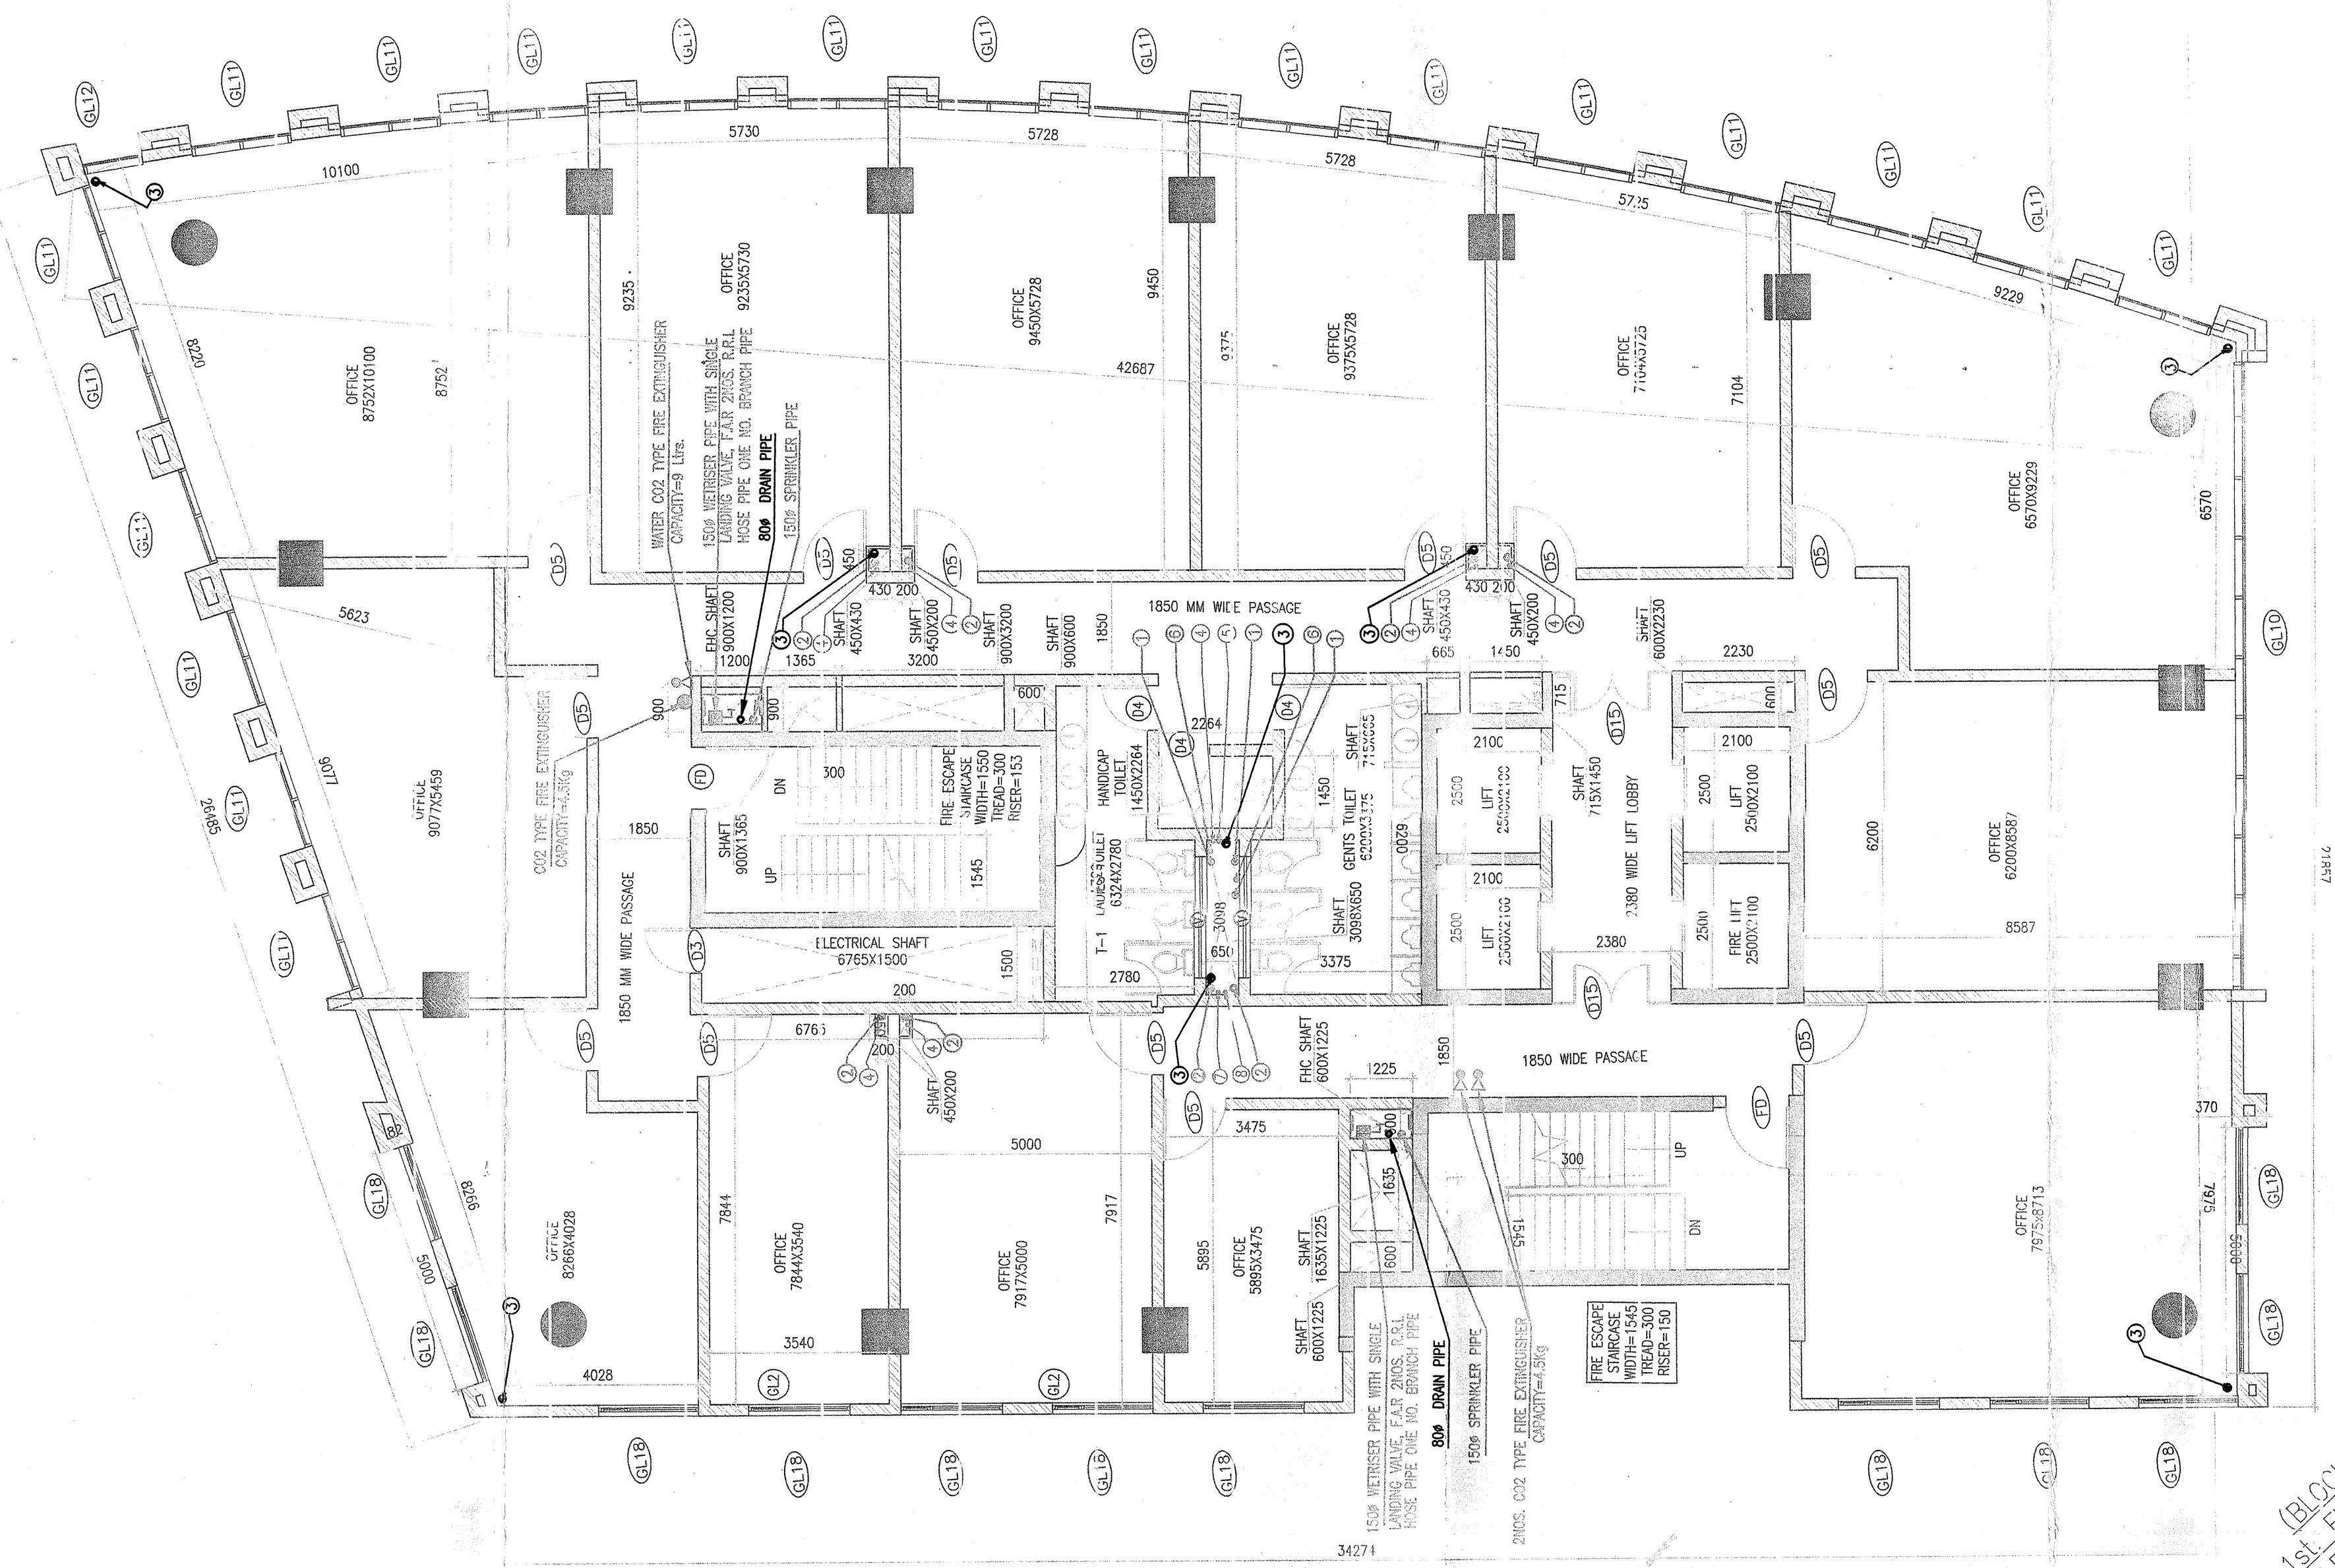

(BLOCK-D)
GROUND FLOOR PLAN

LEGEND FOR FIRE FIGHTING	
F.H.C	FIRE HOSE CABINET
⊗	PENDENT TYPE SPRINKLER MINIMUM INLET 20mm
⊙	CO2 TYPE FIRE EXTINGUISHER CAPACITY=4.5kg
⊕	UPRIGHT TYPE SPRINKLER MINIMUM INLET 20mm

Project:
PROPOSED COMMERCIAL COLONY AREA MEASURING 2.961 ACRES. (LICENCE NO. 110 OF 2010 DATED 29-12-2010) IN SECTOR-82-A, GURGAON MANESAR URBAN COMPLEX BEING DEVELOPED BY SH. TEJPAL S/O SH. BADAM SINGH AND SMT. SAKUNTALA DEVI W/O SH. TEJPAL IN COLLABORATION WITH M/S VATIKA LTD.

Associate Architects
RSMS ARCHITECTS
RSMS ARCHITECTS PVT. LTD.
69, Nara Niwas, Bhawani Kunj (Behind D2), Vasant Kunj, New Delhi-110070.
Tel.: 011-26898613, 26898617
www.rsms-arch.com

Architects:
D.P. (HQ) S. P. (G) C.T.P. (H)
S. P. (G) S. P. (G) S. P. (G)
S. P. (G) S. P. (G) S. P. (G)

Check and Sound on for Public Health:
Internal Services only subject to comments in forwarding letter No. SEP/01/21, Dt. 12-1-21

Supervising Engineer:
ARCHITECT'S SEAL & SIGNATURE
OWNER'S SEAL & SIGNATURE

For VATIKA LIMITED
Authorised Signatory

JULY-2011 Scale : 1:100 Drawing Title:- GROUND & 1st FLOOR PLAN (BLOCK-D) Drawing No:- D-01