
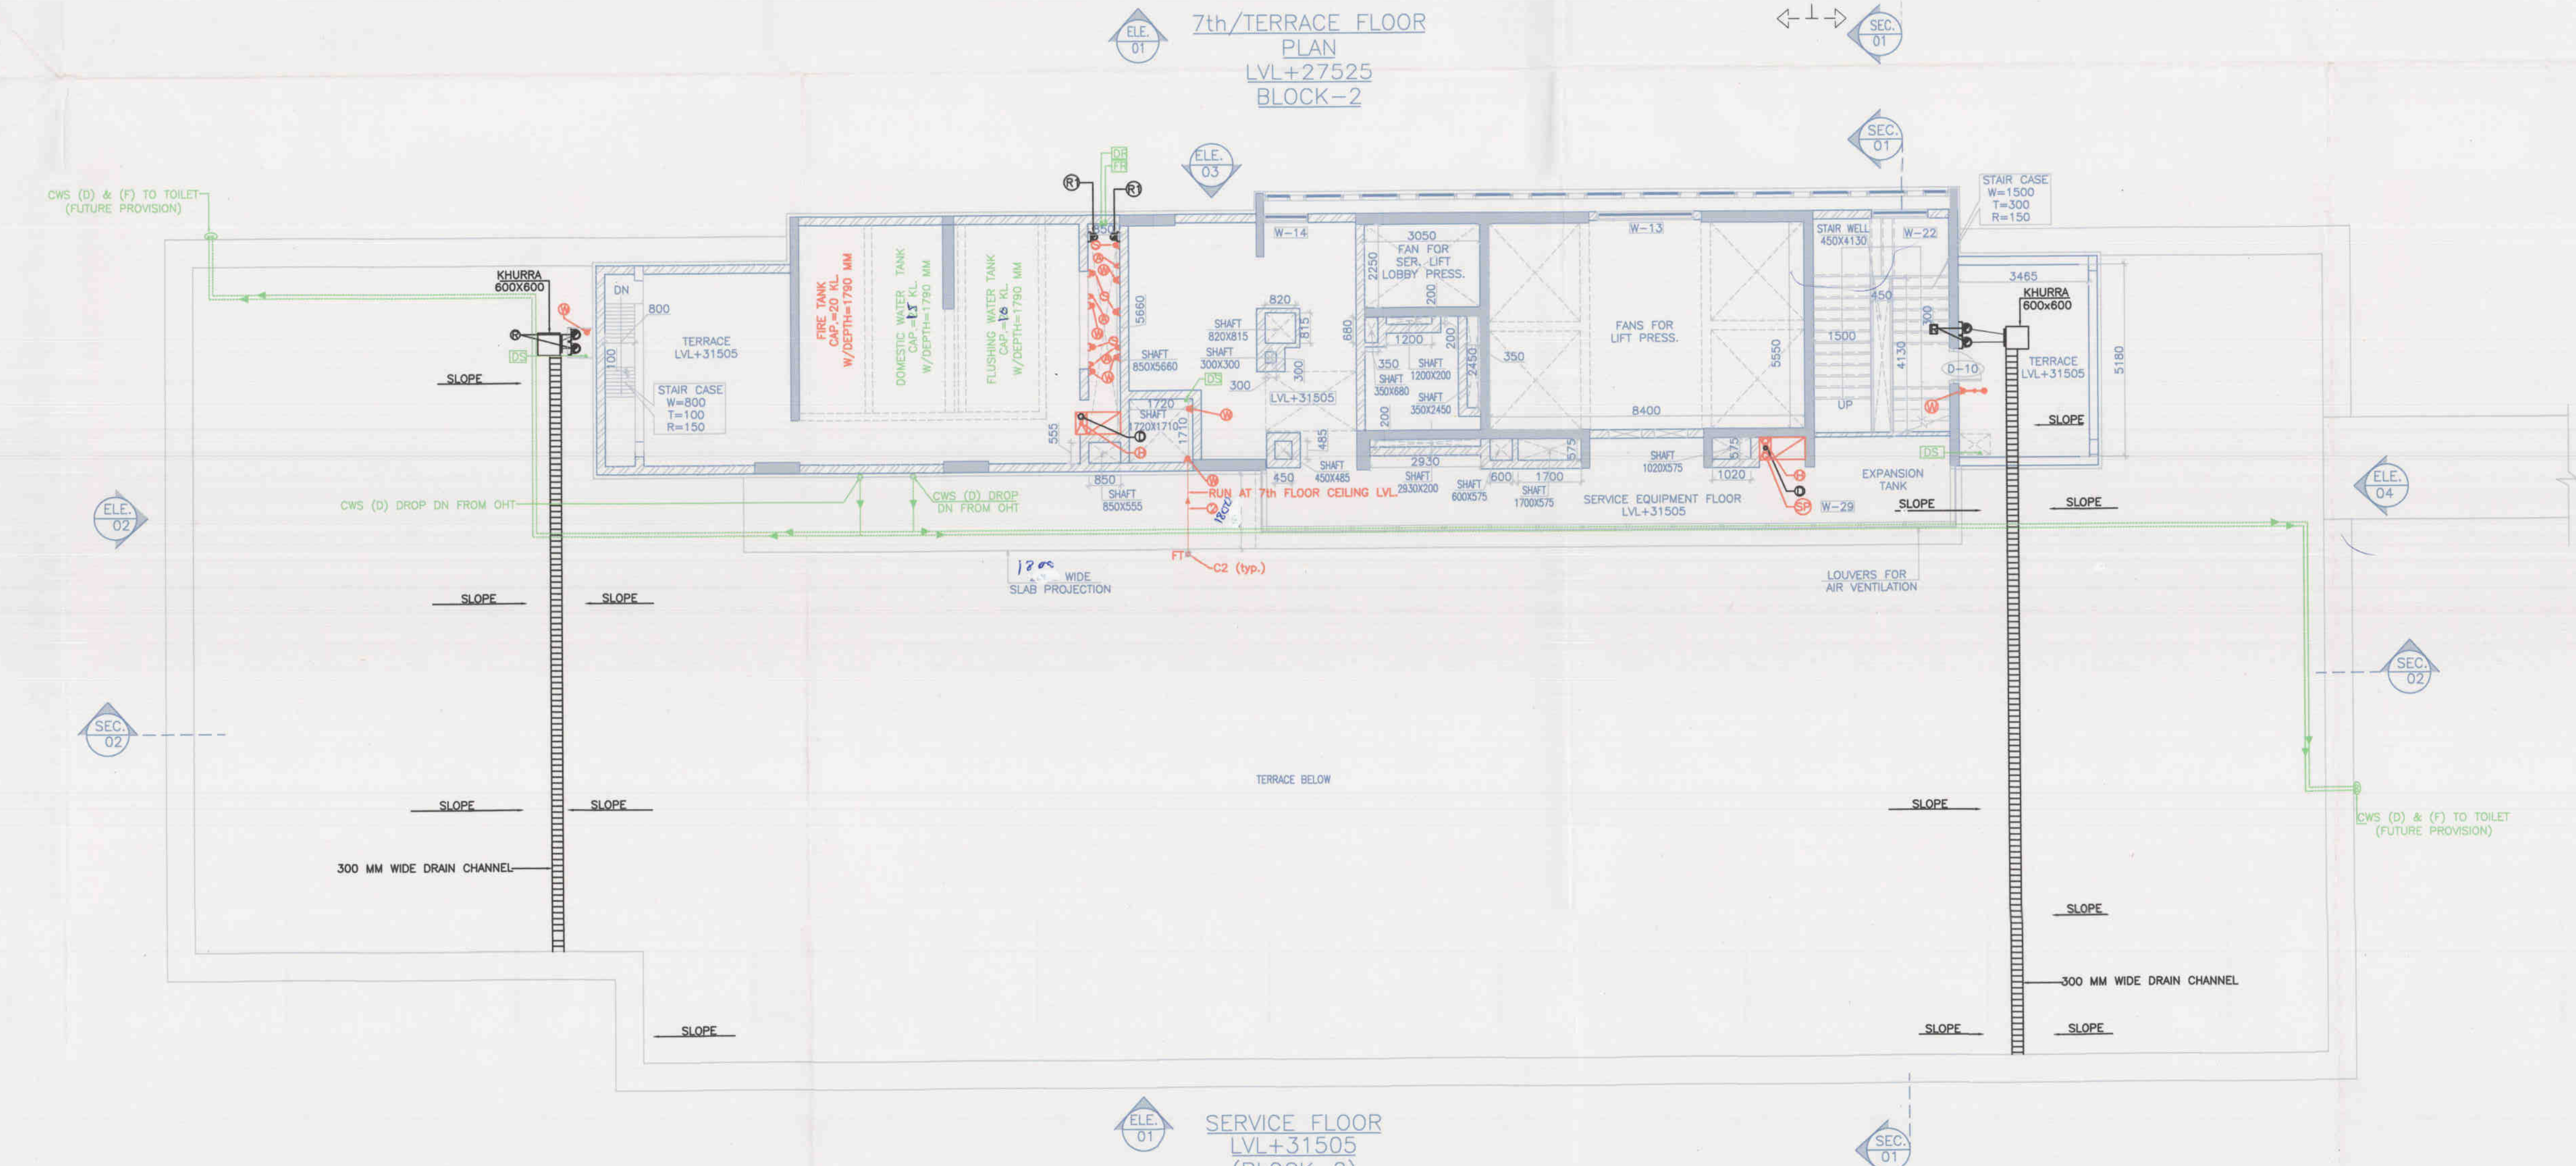


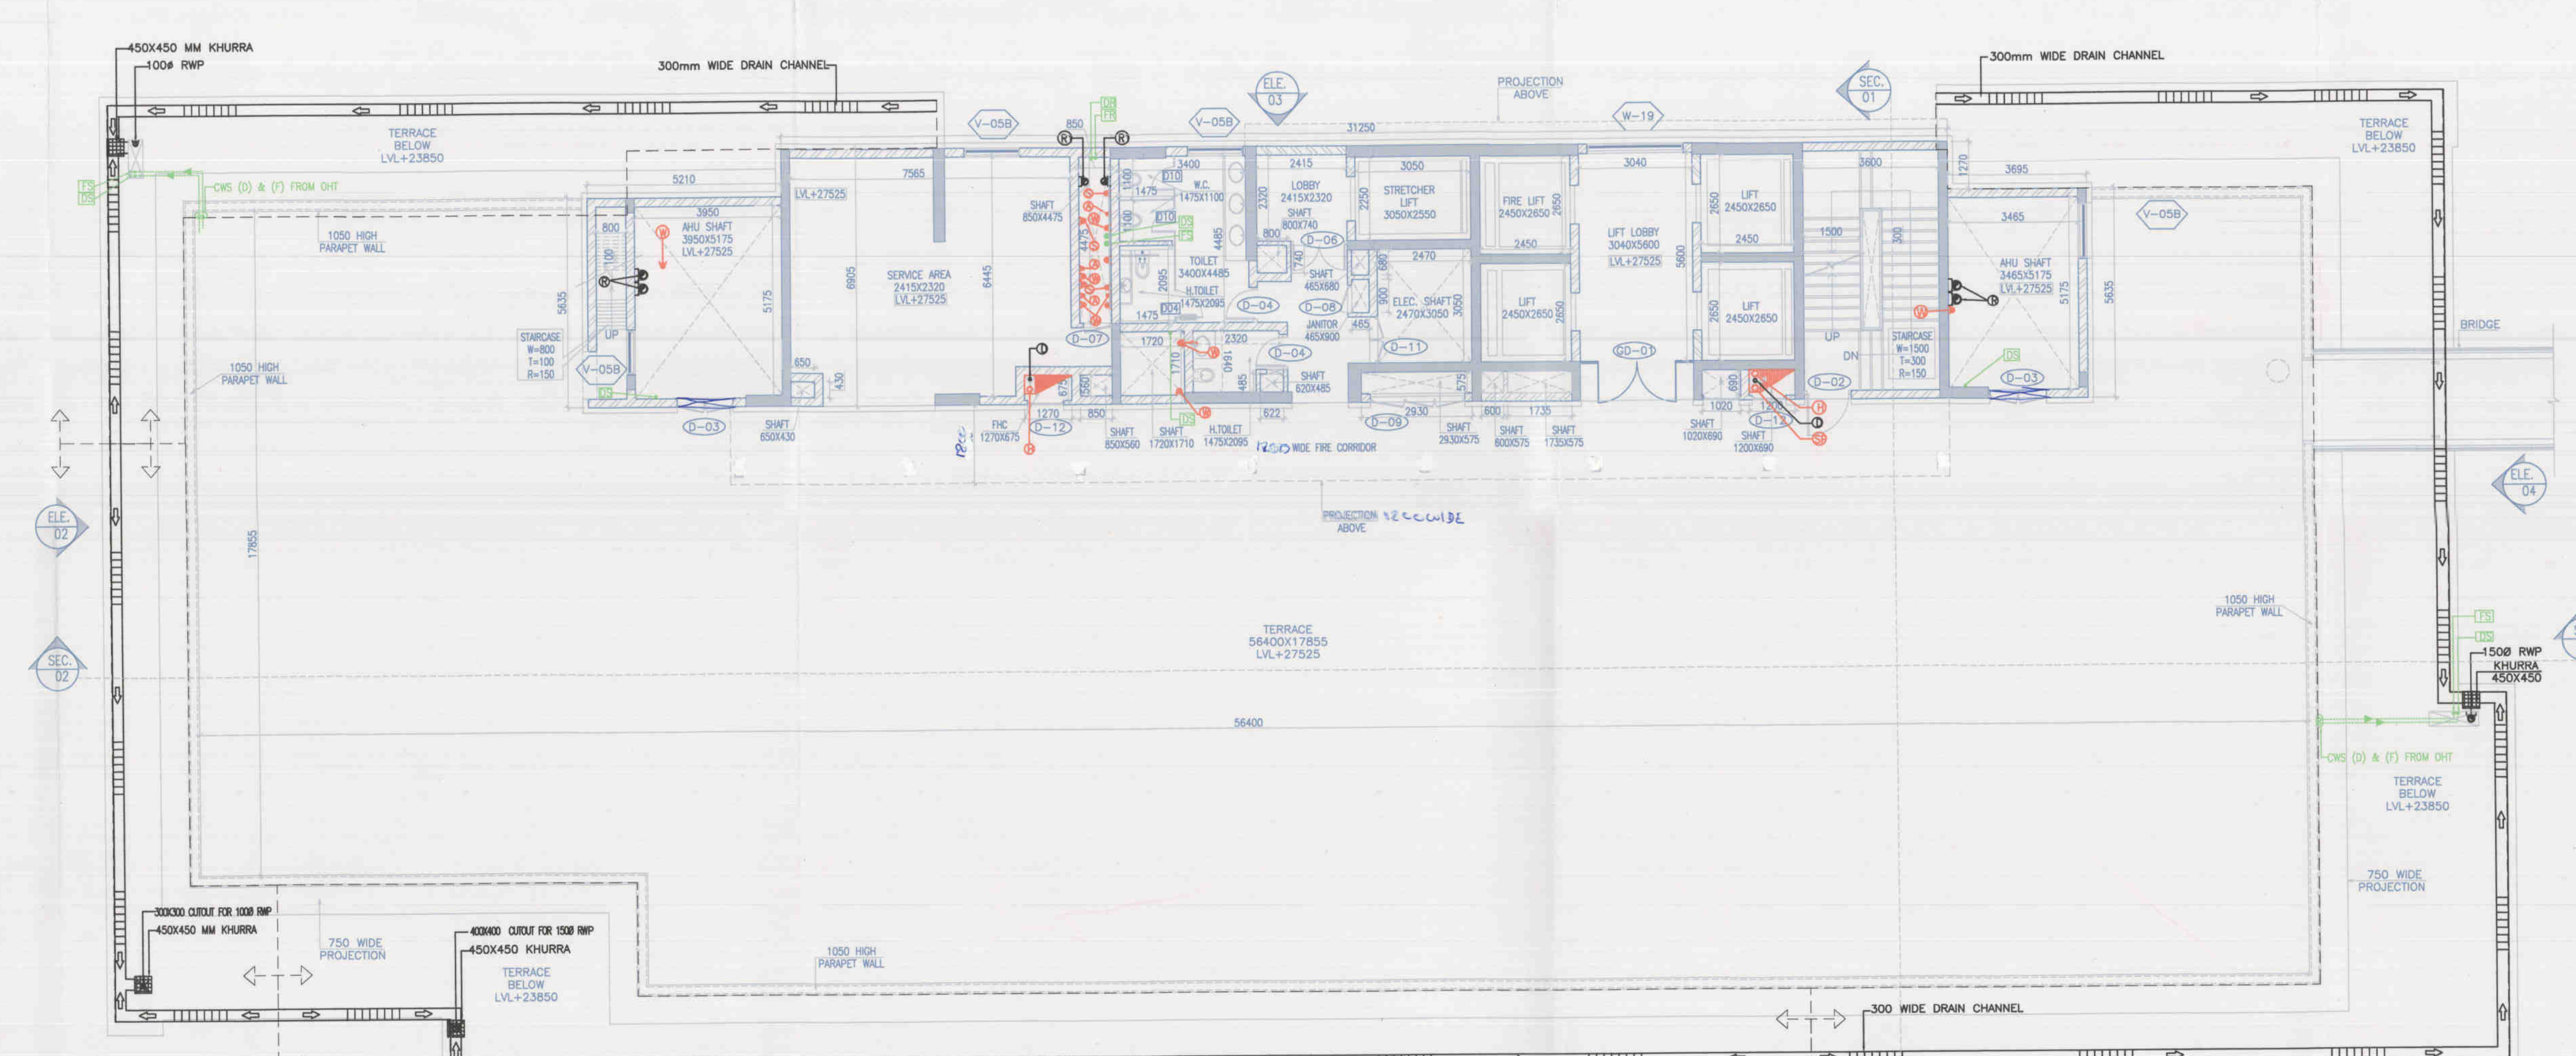

Note:-

1. BUILDING WILL BE DESIGNED (STRUCTURES) AS PER RELEVANT IS CODES FOR EARTH QUAKE RESISTANCE.

2. BUILDING IS HAS AUTOMATIC SPRINKLER SYSTEM ON ALL FLOORS.

LEGEND:-

LEGEND:- FIRE

	FHC	FIRE HOSE CABINET
	150H	150mm HYDRANT PIPE
	80D	80mm DRAIN PIPE
	150S	150mm SPRINKLER PIPE

LEGEND:-

	150S	150mm SOIL PIPE H.C.I.P
	100W	100mm WASTE & VENT PIPE H.C.I.P
	75A	75mm A.S. PIPE H.C.I.P
	200R	200mm RAIN WATER PIPE
	150R	150mm RAIN WATER PIPE
	100S	100mm SOIL PIPE
	100W	100mm WASTE PIPE M.C.I
	75W	75mm WASTE PIPE M.C.I
	50W	50mm WASTE PIPE M.C.I
	50S	50mm SOIL/WASTE PIPE M.C.I
	FR	FLUSHING RISER TO OHT
	DR	DOMESTIC RISER TO OHT
	DS	DOMESTIC DROP PIPE
	FS	FLUSHING DROP PIPE

Project:

PROPOSED BUILDING PLAN OF COMMERCIAL COLONY SITE MEASURING 12.13125 ACRES (LICENSE NO-05 OF 2015 DATED 6-8-2015) IN SECTOR-16 GURGAON MANESAR URBAN COMPLEX BEING DEVELOPED BY SH. KESHAV DUTT AND OTHERS IN COLABORATION WITH CALDER DEVELOPERS PVT LTD (LC.2895)

Associate Architects

RISMS ARCHITECTS

RSMS ARCHITECTS PVT. LTD.
69, Nora Niwas, Bhawani Kunj (Behind D2), Vasant Kunj, New Delhi-110070.
Tel.: 011-26898616, 26898617
www.rsms-arch.com

Checked and signed for Public (General) Service only subject to the following conditions: SE/10/S25-31/19

Supervising Engineer (HQ) IITD, Panchsala

ARCHITECT'S SEAL & SIGNATURE

OWNER'S SEAL & SIGNATURE

For Calder Developers Private Limited

Authorized Signatory

MAY-2015, Scale: 1:100

Drawing Title:- 6th FLOOR, 7th/TERRACE FLOOR & SERVICE FLOOR PLAN (BLOCK-2)

Drawing No:- B2-03