
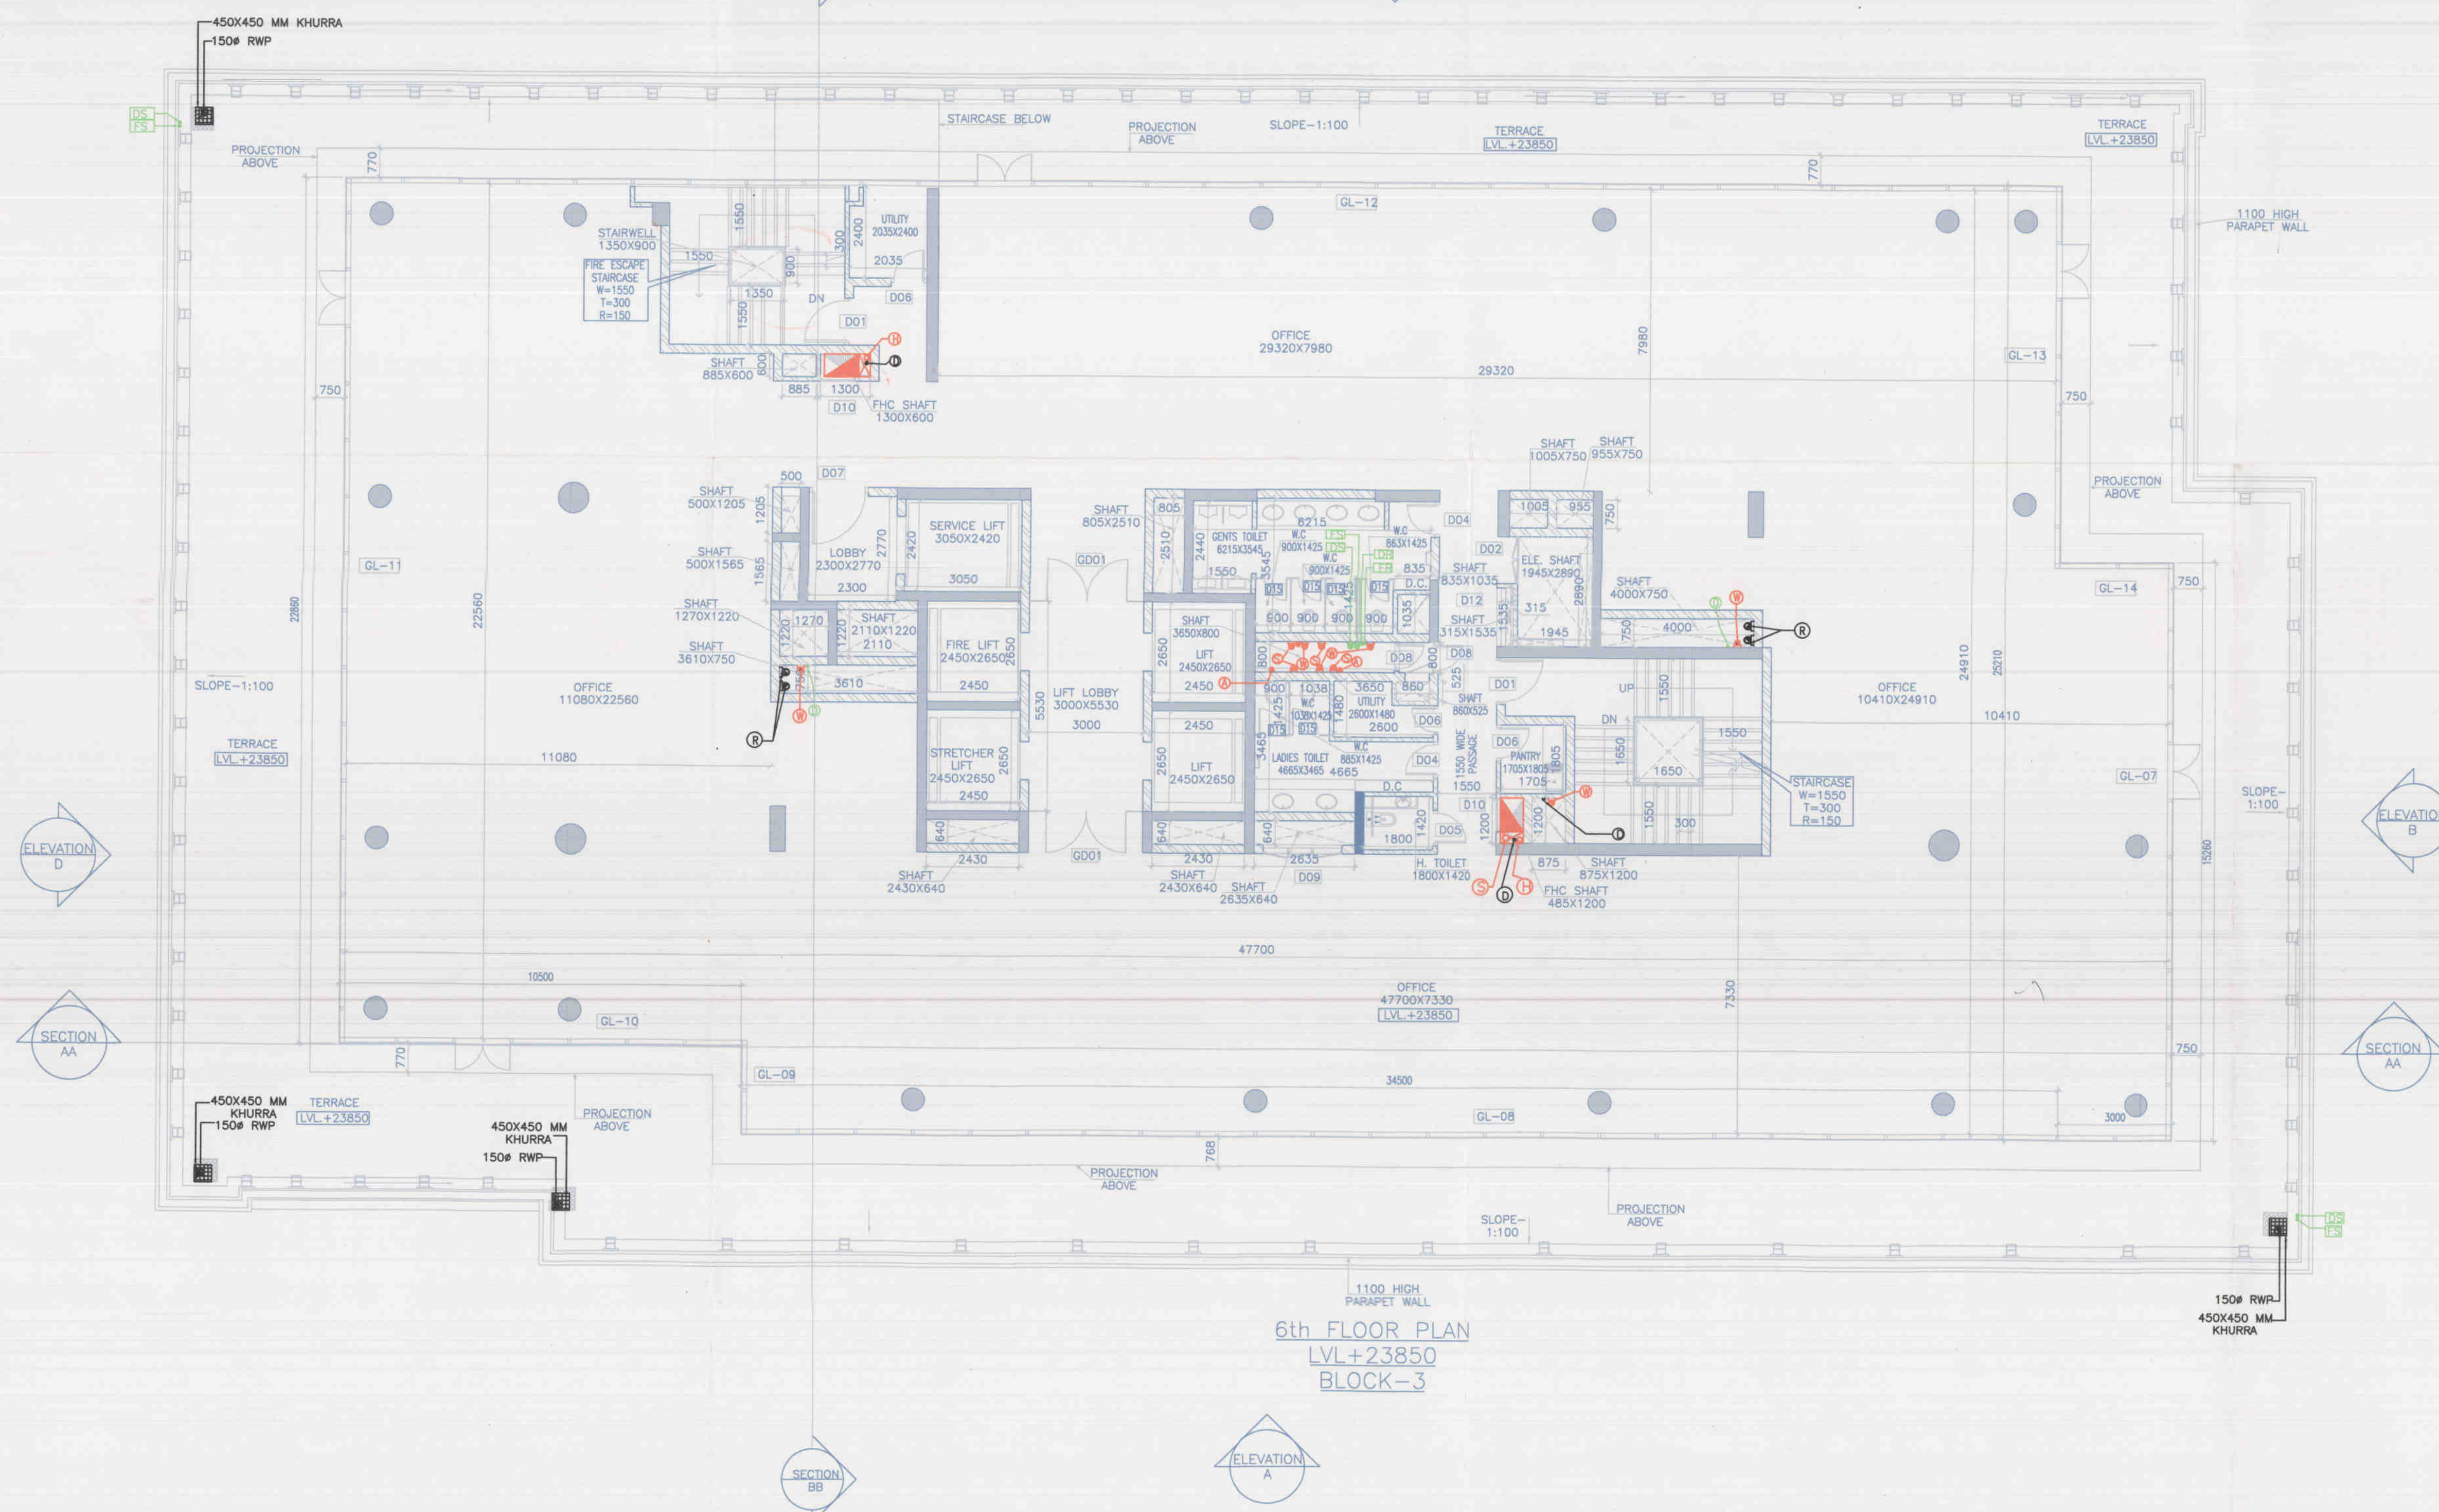


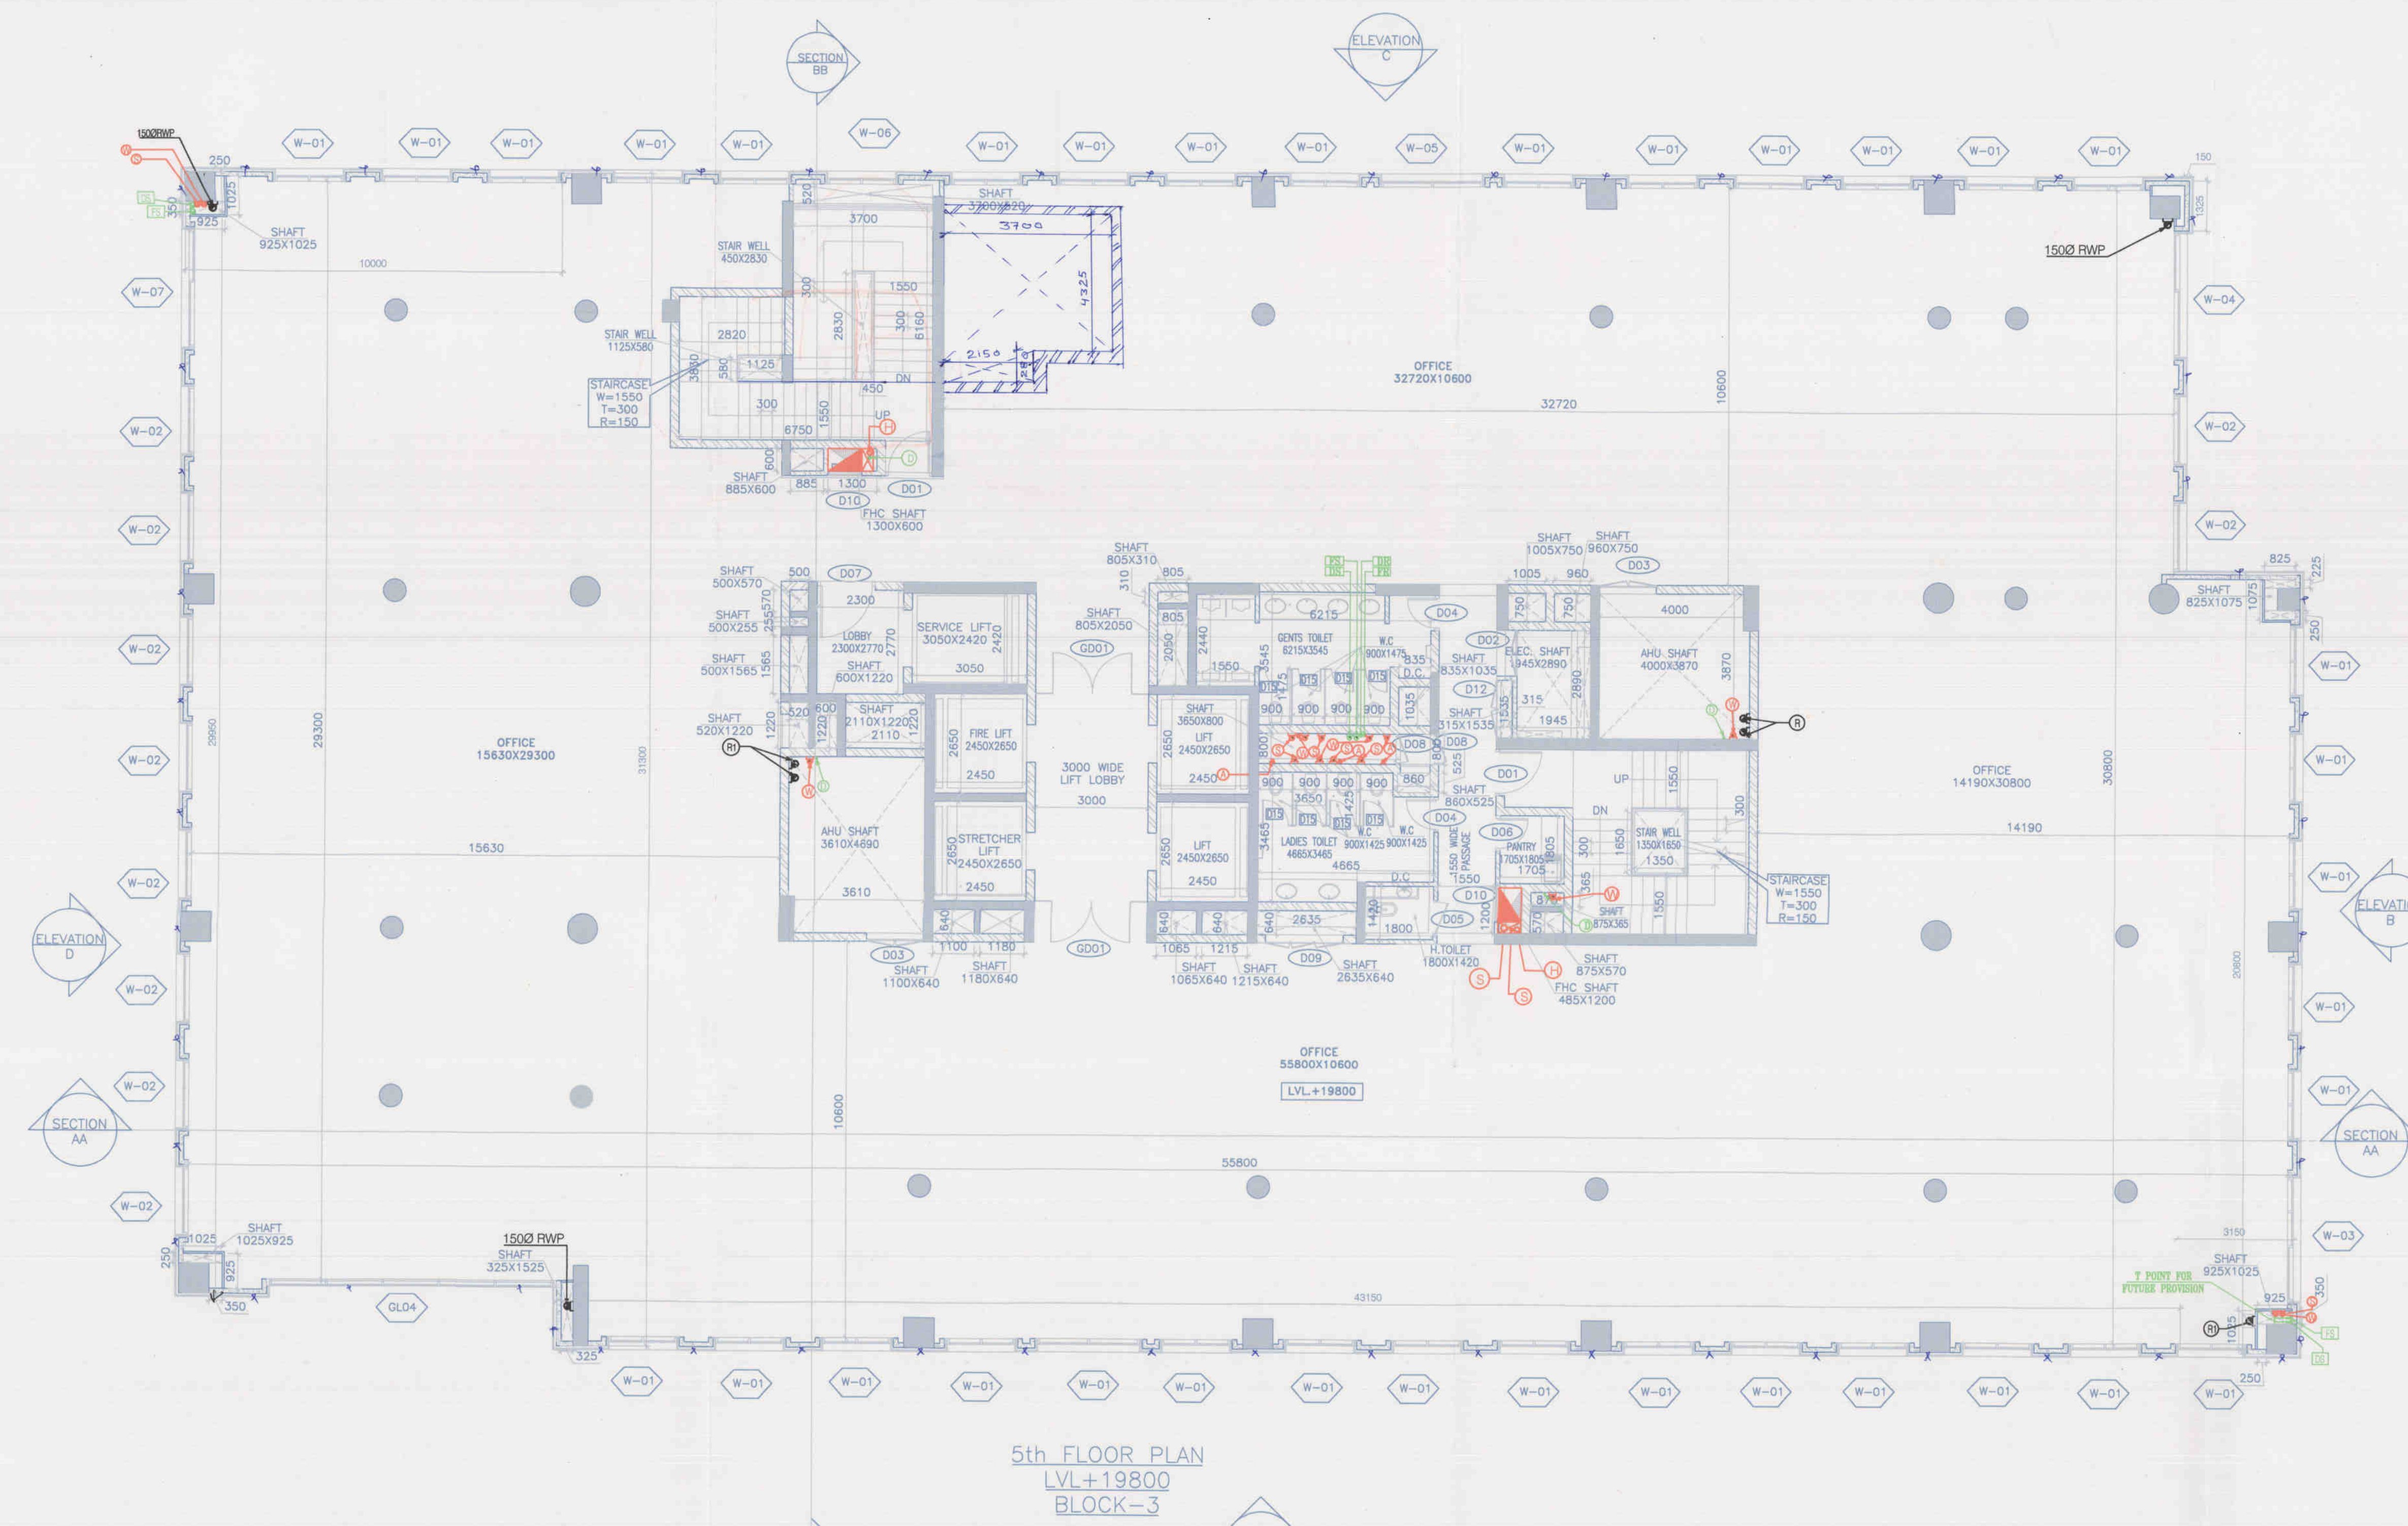

BLOCK - 3
DOOR WINDOW SCHEDULE

OPENING NO.	LOCATION	ROUGH OPENING	FINISHED OPENING
		WIDTH x HEIGHT	WIDTH x HEIGHT
D01	STAIRCASE	1240 x 1240	1200 x 1200
D02	ELECTRICAL	1240 x 1240	1200 x 1200
D03	STAIR	1540 x 1540	1500 x 1500
D04	STAIR	940 x 940	900 x 900
D05	STAIR	840 x 840	800 x 800
D06	STAIR	1540 x 1540	1500 x 1500
D07	LOBBY	1540 x 1540	1500 x 1500
D08	STAIR	840 x 840	800 x 800
D09	STAIR	2100 x 2100	2080 x 2080
D10	STAIR	840 x 840	800 x 800
D11	STAIR	1240 x 1240	1200 x 1200
D12	STAIR	1575 x 1575	1535 x 1535
D13	STAIR	1240 x 1240	1200 x 1200
D14	STAIR	1340 x 1340	1300 x 1300
D001	STAIRCASE	2140 x 2140	2080 x 2080

OPENING NO.	LOCATION	ROUGH OPENING	FINISHED OPENING
		WIDTH x HEIGHT	WIDTH x HEIGHT
CW-01	STAIR	7350 x 7350	7510 x 7200
CW-02	STAIR	7350 x 7350	7510 x 7200
CW-03	STAIR	7350 x 7350	7510 x 7200
CW-04	STAIR	7350 x 7350	7510 x 7200
CW-05	STAIR	7350 x 7350	7510 x 7200
CW-06	STAIR	7350 x 7350	7510 x 7200
CW-07	STAIR	7350 x 7350	7510 x 7200
CW-08	STAIR	7350 x 7350	7510 x 7200
CW-09	STAIR	7350 x 7350	7510 x 7200
CW-10	STAIR	7350 x 7350	7510 x 7200
CW-11	STAIR	7350 x 7350	7510 x 7200
CW-12	STAIR	7350 x 7350	7510 x 7200
CW-13	STAIR	7350 x 7350	7510 x 7200
CW-14	STAIR	7350 x 7350	7510 x 7200
CW-15	STAIR	7350 x 7350	7510 x 7200
CW-16	STAIR	7350 x 7350	7510 x 7200
CW-17	STAIR	7350 x 7350	7510 x 7200
CW-18	STAIR	7350 x 7350	7510 x 7200
CW-19	STAIR	7350 x 7350	7510 x 7200
CW-20	STAIR	7350 x 7350	7510 x 7200

Note:-
1. BUILDING WILL BE DESIGNED (STRUCTURES) AS PER RELEVANT IS CODES FOR EARTH QUAKE RESISTANCE
2. BUILDING IS HAS AUTOMATIC SPRINKLER SYSTEM ON ALL FLOORS.

LEGEND:-

FD FLOOR DRAIN
63mm uPVC WASTE PIPE
MT MULTI TRAP-110x63/75mm
FT FLOOR TRAP-110x63/75mm

1500 SOIL PIPE H.C.I.P
1000 WASTE & VENT PIPE H.C.I.P
750 A.S.PIPE H.C.I.P
2000 RAIN WATER PIPE
1500 RAIN WATER PIPE
1000 SOIL PIPE H.C.I.P
1000 WASTE PIPE H.C.I.P
800 WASTE PIPE H.C.I.P
750 WASTE PIPE H.C.I.P
400 SOIL/WASTE PIPE H.C.I.P

FD FLUSHING RISER TO OHT
MT DOMESTIC RISER TO OHT
DS DOMESTIC DROP PIPE
FS FLUSHING DROP PIPE

CUTOUT SIZE 150x150 FOR (FD, FT & UT)
CUTOUT SIZE 200x200
CUTOUT SIZE 75x75 FOR (WB, SINK & URINAL)

Project:
PROPOSED BUILDING PLAN OF
COMMERCIAL COLONY SITE MEASURING
12.13125 ACRES/LICENSE NO-05 OF
2015 DATED 6-8-2015)IN SECTOR-16
GURGAON MANESAR URBAN COMPLEX
BEING DEVELOPED BY SH.KESHAV DUTT
AND OTHERS IN COLABORATION WITH
CALDER DEVELOPERS PVT LTD(LC.2895)

Associate Architects

RISMS ARCHITECTS

RSMS ARCHITECTS PVT. LTD.
69,Nora Niwas Bhawani Kunj
(Behind D2), Vasant Kunj,
New Delhi-110070.
Tel.:011-26898616,26898617
www.rsms-arch.com

Checked and Bound by Public Health
(Internal) Surveyors to comments in
in forwarding letter to the S.D.
S.D. (Public Health)
Surat, Gujarat

(RAMANVAR BASNI) A.D.
(BALWANT SINGH) S.D.

ARCHITECT'S SEAL & SIGNATURE
OWNER'S SEAL & SIGNATURE

For Calder Developers Private Limited
Signature

AUG.-2014, Scale : 1:100
Drawing Title:-
5TH & 6TH FLOOR PLAN
(BLOCK-3)
Drawing No:-
B3-03