


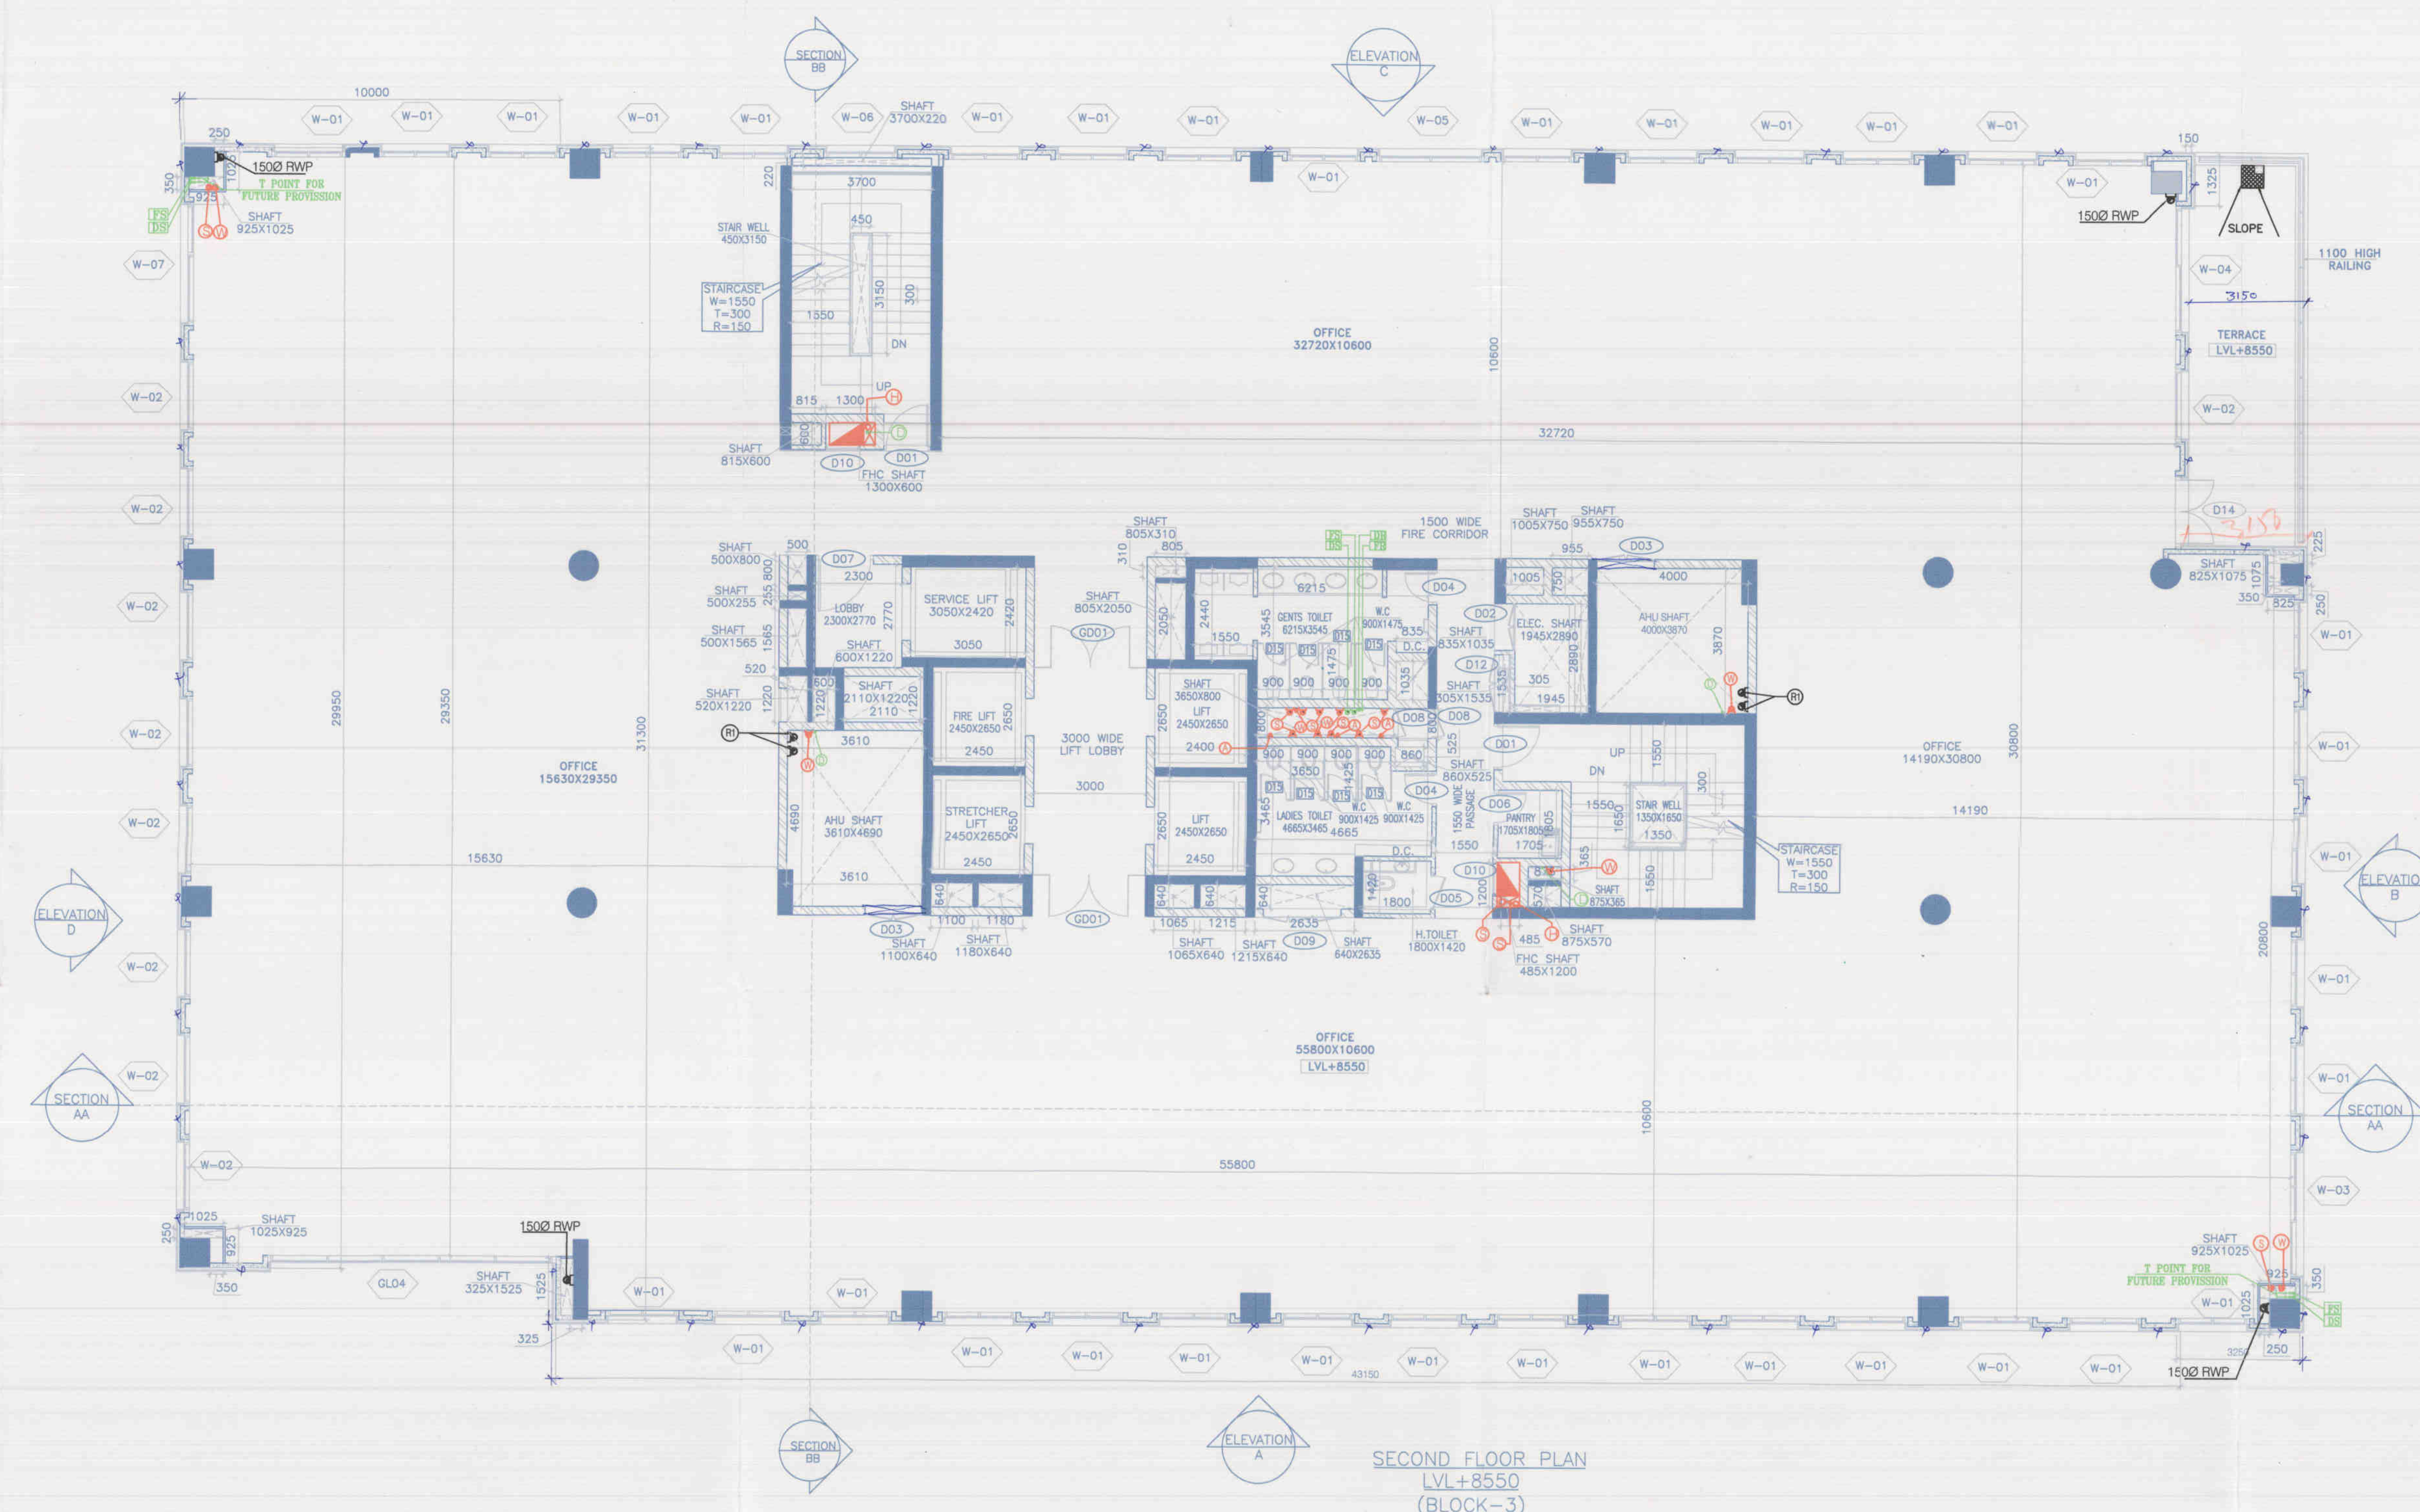

SECOND FLOOR PLAN
LVL-8550
(BLOCK-3)

BLOCK-3
DOOR WINDOW SCHEDULE

OPENING NO.	LOCATION	ROUGH OPENING	FINISHED OPENING
		WIDTH SILL LINTEL	WIDTH SILL LINTEL
D01	STAIRCASE	1240	2160 1200 2150
D02	ELECTRICAL	1240	2160 1200 2150
D03	WALL	1540	2160 1500 2150
D04	WALL	940	2160 900 2150
D05	WALL	940	2160 900 2150
D06	WALL	1040	2160 1000 2150
D07	WALL	1540	2160 1500 2150
D08	WALL	840	2160 800 2150
D09	WALL	2100	2160 2060 2150
D10	WALL	840	2160 800 2150
D11	WALL	1240	2160 1200 2150
D12	WALL	1575	2160 1535 2150
D13	WALL	1240	2160 1200 2150
D14	WALL	1940	2160 1900 2150
D001	WALL	2140	2460 2100 2450

OPENING NO.	LOCATION	ROUGH OPENING	FINISHED OPENING
		WIDTH SILL LINTEL	WIDTH SILL LINTEL
CW-01	WALL	7350	7510 7200 7500
CW-02	WALL	7350	7510 7200 7500
CW-03	WALL	7350	7510 7200 7500
CW-04	WALL	7350	7510 7200 7500
CW-05	WALL	7350	7510 7200 7500
CW-06	WALL	7350	7510 7200 7500
CW-07	WALL	7350	7510 7200 7500
CW-08	WALL	7350	7510 7200 7500
CW-09	WALL	7350	7510 7200 7500
CW-10	WALL	7350	7510 7200 7500
CW-11	WALL	7350	7510 7200 7500
CW-12	WALL	7350	7510 7200 7500
CW-13	WALL	7350	7510 7200 7500
CW-14	WALL	7350	7510 7200 7500
CW-15	WALL	7350	7510 7200 7500
CW-16	WALL	7350	7510 7200 7500
CW-17	WALL	7350	7510 7200 7500
CW-18	WALL	7350	7510 7200 7500
CW-19	WALL	7350	7510 7200 7500
CW-20	WALL	7350	7510 7200 7500

SYMBOL	DESCRIPTION
FD	FLOOR DRAIN
WT	WASTE TRAP
PT	PUMP TRAP
1000	1000mm UPVC WASTE PIPE
1500	1500mm UPVC WASTE PIPE
2000	2000mm UPVC WASTE PIPE
2500	2500mm UPVC WASTE PIPE
3000	3000mm UPVC WASTE PIPE
3500	3500mm UPVC WASTE PIPE
4000	4000mm UPVC WASTE PIPE
4500	4500mm UPVC WASTE PIPE
5000	5000mm UPVC WASTE PIPE
5500	5500mm UPVC WASTE PIPE
6000	6000mm UPVC WASTE PIPE
6500	6500mm UPVC WASTE PIPE
7000	7000mm UPVC WASTE PIPE
7500	7500mm UPVC WASTE PIPE
8000	8000mm UPVC WASTE PIPE
8500	8500mm UPVC WASTE PIPE
9000	9000mm UPVC WASTE PIPE
9500	9500mm UPVC WASTE PIPE
10000	10000mm UPVC WASTE PIPE
10500	10500mm UPVC WASTE PIPE
11000	11000mm UPVC WASTE PIPE
11500	11500mm UPVC WASTE PIPE
12000	12000mm UPVC WASTE PIPE
12500	12500mm UPVC WASTE PIPE
13000	13000mm UPVC WASTE PIPE
13500	13500mm UPVC WASTE PIPE
14000	14000mm UPVC WASTE PIPE
14500	14500mm UPVC WASTE PIPE
15000	15000mm UPVC WASTE PIPE
15500	15500mm UPVC WASTE PIPE
16000	16000mm UPVC WASTE PIPE
16500	16500mm UPVC WASTE PIPE
17000	17000mm UPVC WASTE PIPE
17500	17500mm UPVC WASTE PIPE
18000	18000mm UPVC WASTE PIPE
18500	18500mm UPVC WASTE PIPE
19000	19000mm UPVC WASTE PIPE
19500	19500mm UPVC WASTE PIPE
20000	20000mm UPVC WASTE PIPE

Note:-
1. BUILDING WILL BE DESIGNED (STRUCTURES)
AS PER RELEVANT IS CODES FOR EARTH QUAKE
RESISTANCE.
2. BUILDING IS HAS AUTOMATIC
SPRINKLER SYSTEM ON ALL FLOORS.

LEGEND:-

Project:
PROPOSED BUILDING PLAN OF
COMMERCIAL COLONY SITE MEASURING
12.13125 ACRES(LICENSE NO-05 OF
2015 DATED 6-8-2015)IN SECTOR-16
GURGAON MANESAR URBAN COMPLEX
BEING DEVELOPED BY SH.KESHAV DUTT
AND OTHERS IN COLABORATION WITH
CALDER DEVELOPERS PVT LTD(LC.2895)

Associate Architects

RISIMIS
ARCHITECTS

RSMS ARCHITECTS PVT. LTD.
69,Nora Niwas Bhawani Kunj
(Behind D2), Vasant Kunj,
New Delhi-110070.
Tel.: 011-26898616,26898617
www.rsms-arch.com

Checked and signed off for
(Owner) service only sub.
By: *[Signature]* Date: *[Date]*
Superintending Engineer
(Municipal Corporation)
[Signature]

(RAM AYTAZ BASSI)
A.D.

(BALWANT SINGH)
S.D.

ARCHITECT'S SEAL
& SIGNATURE

OWNER'S SEAL
& SIGNATURE

For Calder Developers Private Limited
[Signature]
Authorized Signatory

AUG.-2014. Scale : 1:100
Drawing Title:-
3RD TO 4TH FLOOR PLAN
(BLOCK-3)

Drawing No:-
B3-02