

Note:-

1. BUILDING WILL BE DESIGNED (STRUCTURES)
AS PER RELEVANT IS CODES FOR
EARTH QUAKE RESISTANCE.

2. BUILDING IS HAS AUTOMATIC
SPRINKLER SYSTEM ON ALL FLOORS.

LEGEND:-

FD	FLOOR DRAIN
MT	MULTI TRAP-110x63/75mm
FT	FLOOR TRAP-110x63/75mm

- ⑤ 150# SOIL PIPE (H.C.P.)
⑥ 100# WASTE & VENT PIPE (H.C.P.)
⑦ 75# A.S. PIPE (H.C.P.)
⑧ 200# RAIN WATER PIPE
⑨ 150# RAIN WATER PIPE
⑩ 100# SOIL PIPE H.C.I.
⑪ 100# WASTE PIPE H.C.I.
⑫ 75# WASTE PIPE H.C.I.
⑬ 50# WASTE PIPE H.C.I.
⑭ 50# SOIL/WASTE PIPE H.C.I.

- FR FLUSHING RISER TO OHT
DR DOMESTIC RISER TO OHT
DS DOMESTIC DROP PIPE
FS FLUSHING DROP PIPE
① OUTLET SIZE 150x150 FOR (FD, FT & UT)
② OUTLET SIZE 200x200
③ OUTLET SIZE 75x75 FOR (WB, SINK & URINAL)



SIZE
SYSTEM
DIAGRAM

BLOCK -5

DOOR WINDOW SCHEDULE

OPENING NO.	LOCATION	WIDTH	DEPTH	FINISHED OPENING	FINISHED OPENING
				WIDTH	DEPTH
D01	STAIRCASE	1240	2160	1200	2150
D02	ELECTRICAL	1240	2160	1200	2150
D03	STAIR	1240	2160	1200	2150
D04	TOILET	1000	2160	1000	2150
D05	HANDICAP	1000	2160	1000	2150
D06	PANTRY	1040	2160	1000	2150
D07	LAVATORY	1540	2160	1500	2150
D08	STAIRCASE	840	2160	800	2150
D09	STAIRCASE	2100	2160	2050	2150
D10	STAIR	940	2160	900	2150
D11	LIFT	1240	2160	1200	2150
D12	STAIRCASE	1575	2160	1530	2150
D13	STAIRCASE	1240	2160	1200	2150
D14	STAIRCASE	1540	2160	1500	2150
D15	STAIRCASE	2140	2160	2100	2150

OPENING NO.	LOCATION	WIDTH	DEPTH	FINISHED OPENING	FINISHED OPENING
				WIDTH	DEPTH
GL-01	STAIRCASE	7350	7510	7250	7500
GL-02	STAIRCASE	7350	7510	7250	7500
GL-03	STAIRCASE	7350	7510	7250	7500
GL-04	STAIRCASE	7350	7510	7250	7500
GL-05	STAIRCASE	7350	7510	7250	7500
GL-06	STAIRCASE	7350	7510	7250	7500
GL-07	STAIRCASE	7350	7510	7250	7500
GL-08	STAIRCASE	7350	7510	7250	7500
GL-09	STAIRCASE	7350	7510	7250	7500
GL-10	STAIRCASE	7350	7510	7250	7500
GL-11	STAIRCASE	7350	7510	7250	7500
GL-12	STAIRCASE	7350	7510	7250	7500
GL-13	STAIRCASE	7350	7510	7250	7500
GL-14	STAIRCASE	7350	7510	7250	7500
GL-15	STAIRCASE	7350	7510	7250	7500

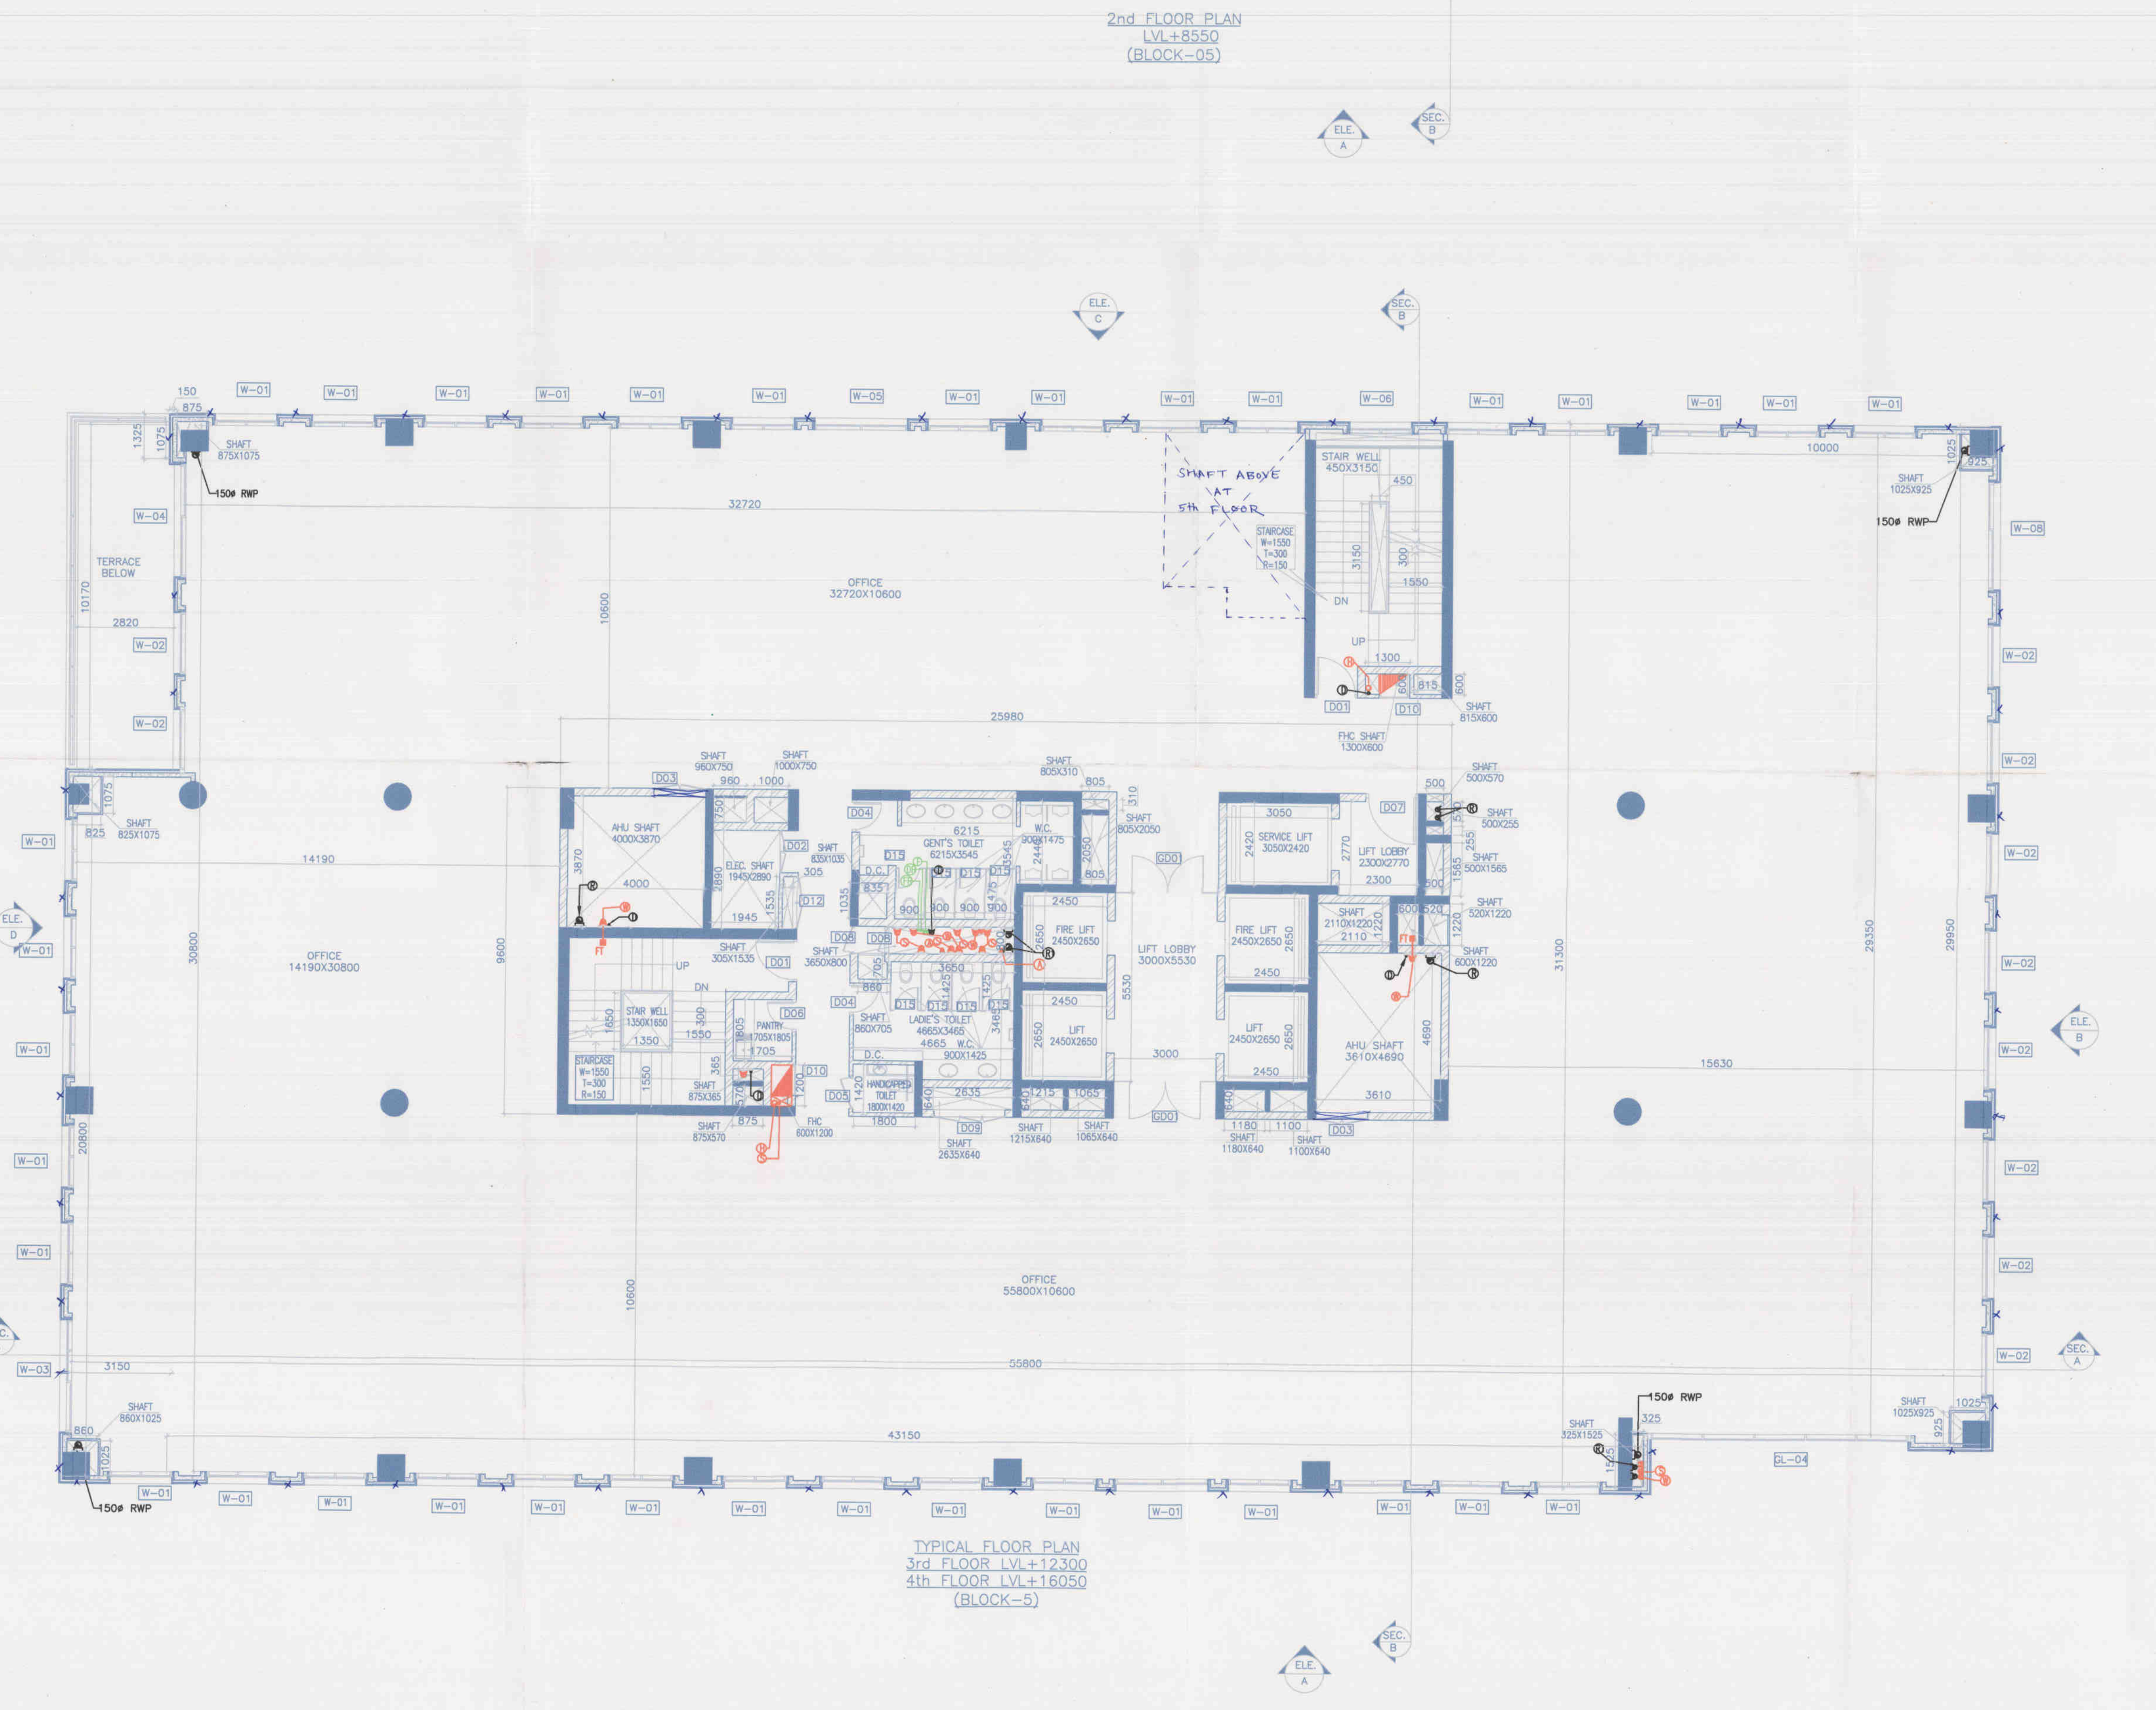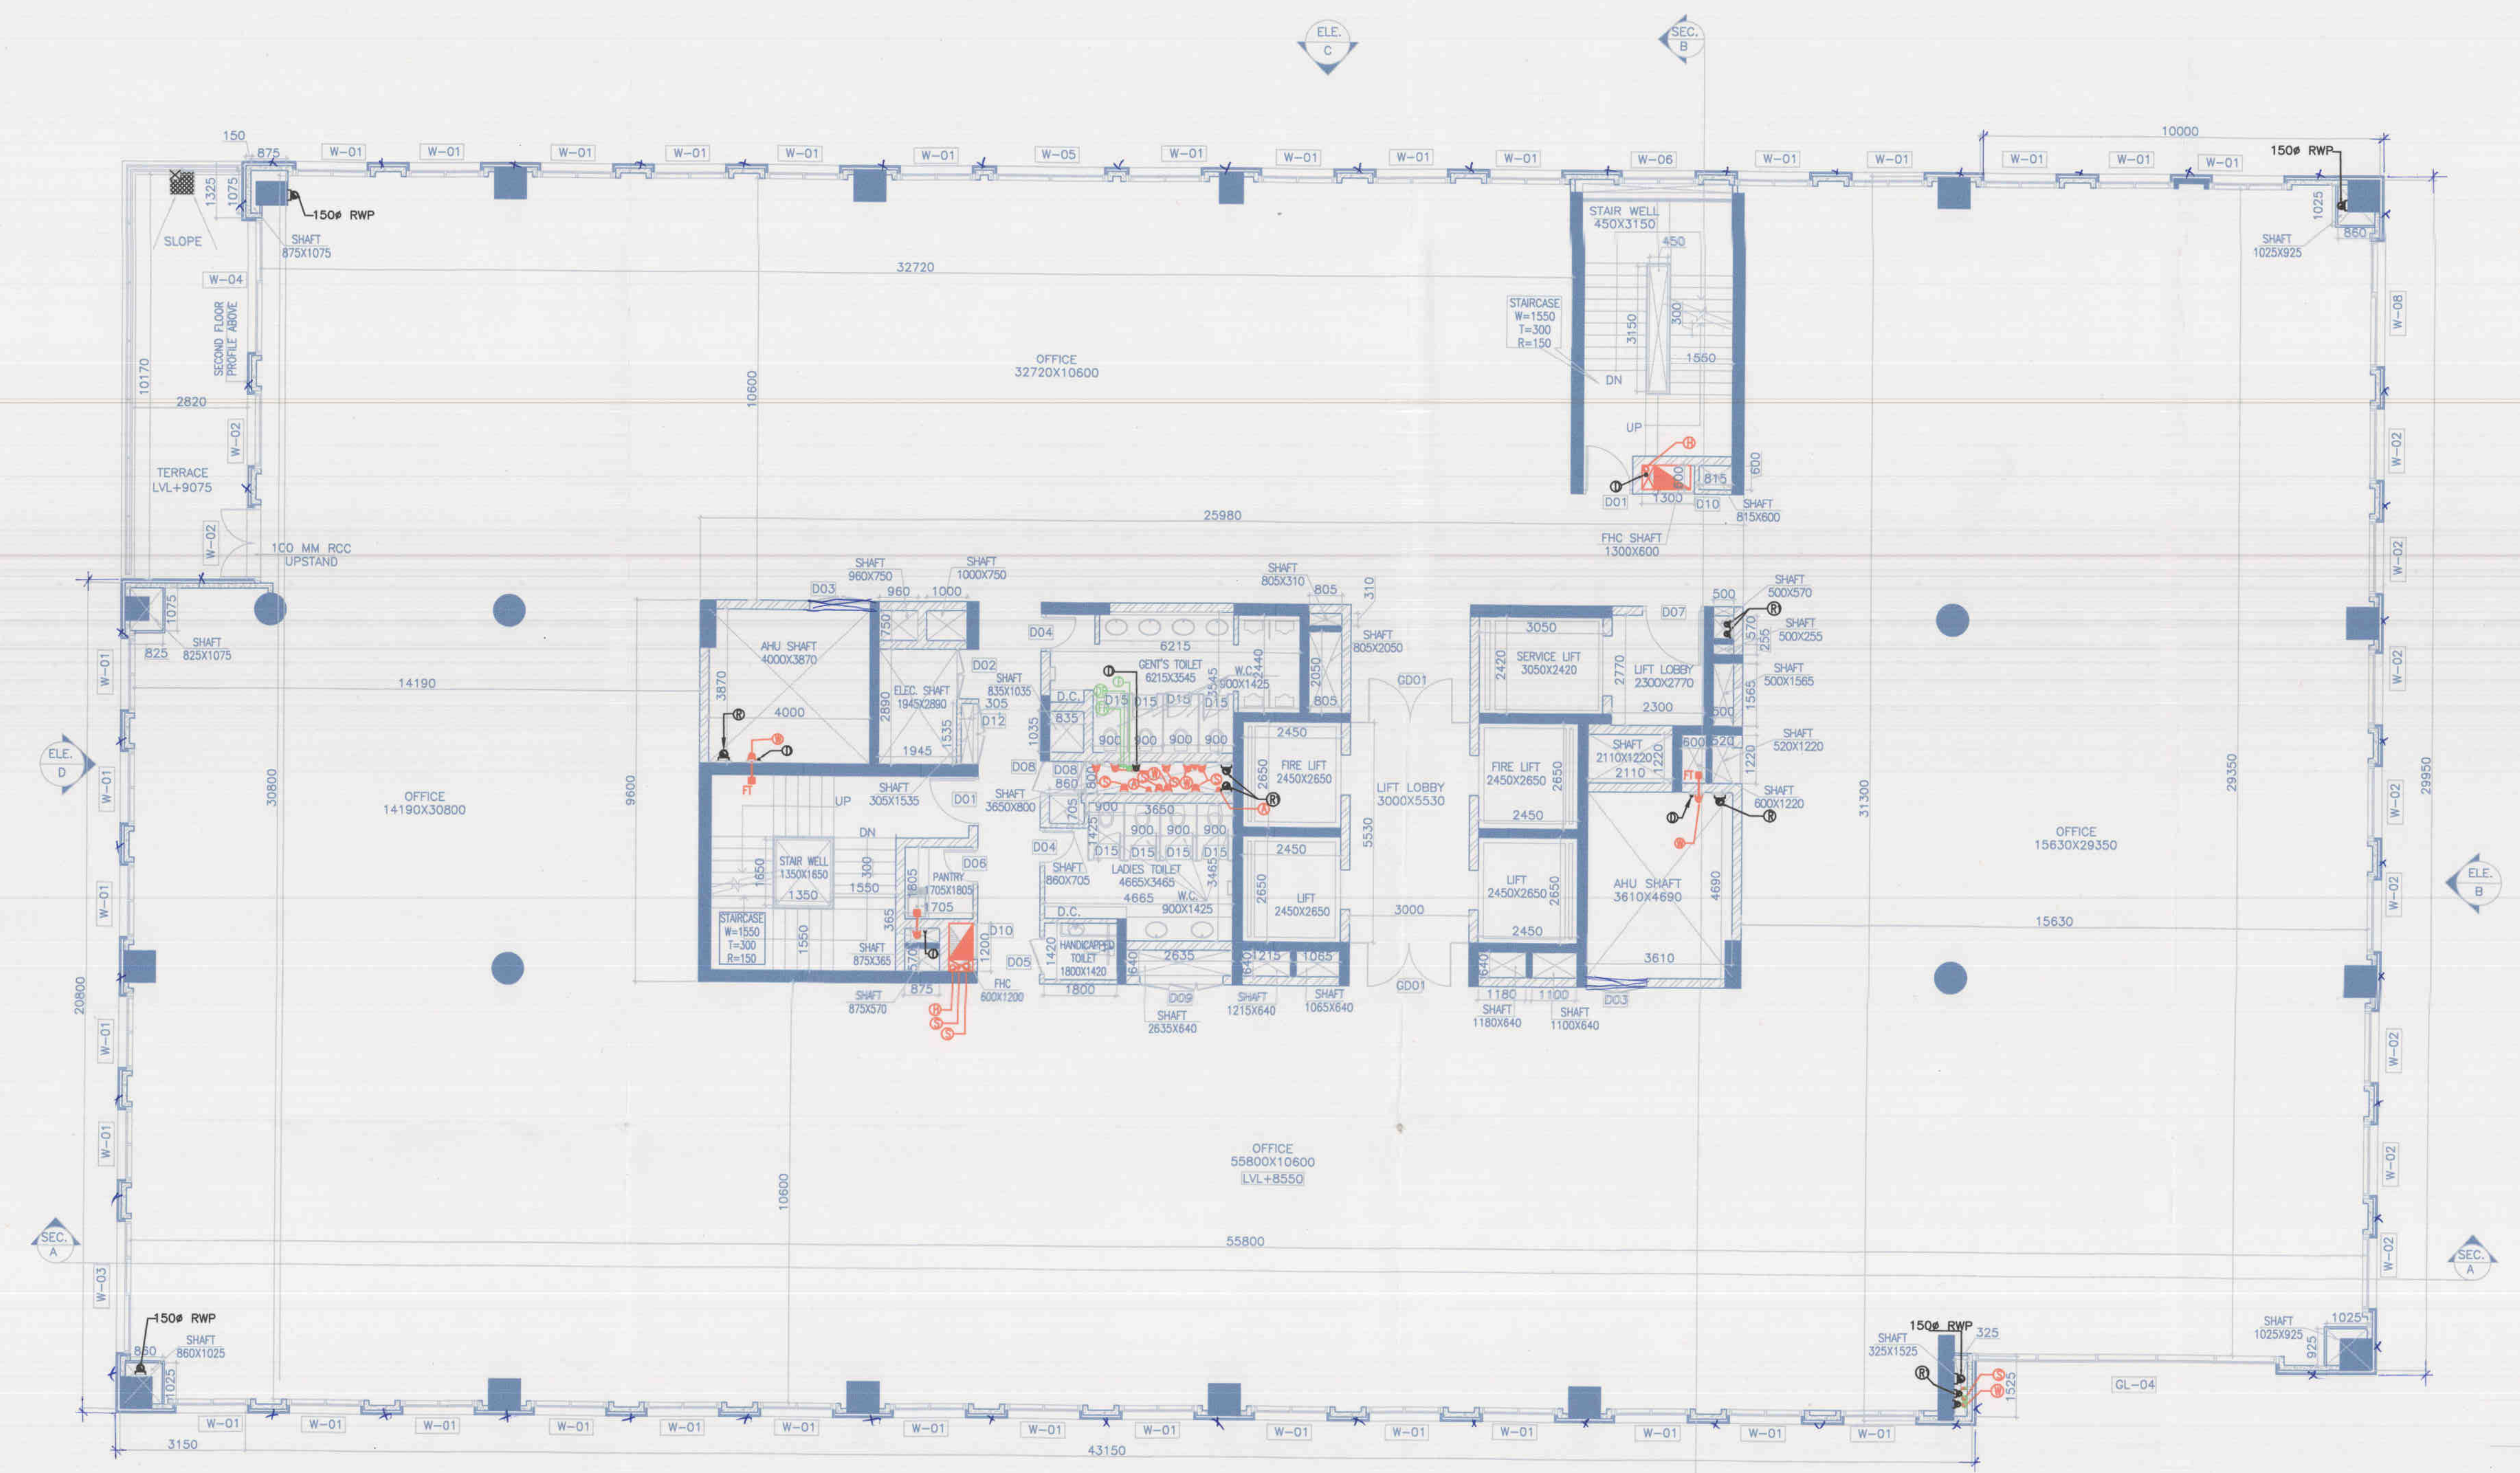

Project:
PROPOSED BUILDING PLAN OF
COMMERCIAL COLONY SITE MEASURING
12.13125 ACRES/LICENSE NO-05 OF
2015 DATED 6-8-2015/IN SECTOR-16
GURGAON MANESAR URBAN COMPLEX
BEING DEVELOPED BY SH.KESHAV DUTT
AND OTHERS IN COLABORATION WITH
CALDER DEVELOPERS PVT LTD(LC.2895)

Associate Architects

RSMS
ARCHITECTS

RSMS ARCHITECTS PVT. LTD.
69,Nora Niwas Bhawani Kunj
(Behind D2), Vasant Kunj,
New Delhi-110070.
Tel.: 011-26898616,26898617
www.rsms-arch.com

Checked and found ok for Health
Service only as per comments in
drawing letter No. 10/20/2015
Superintending Engineer
Public Health

(RAM AVATAR BASI) A.D.
(BALWANT SINGH) S.D.

ARCHITECT'S SEAL & SIGNATURE
OWNER'S SEAL & SIGNATURE
For Calder Developers Private Limited
Authorized Signatory

MAY-2015. Scale : 1:100
Drawing Title:-
2nd,3rd & 4th FLOOR PLAN
Drawing No:-
BS-02
(BLOCK-05)