
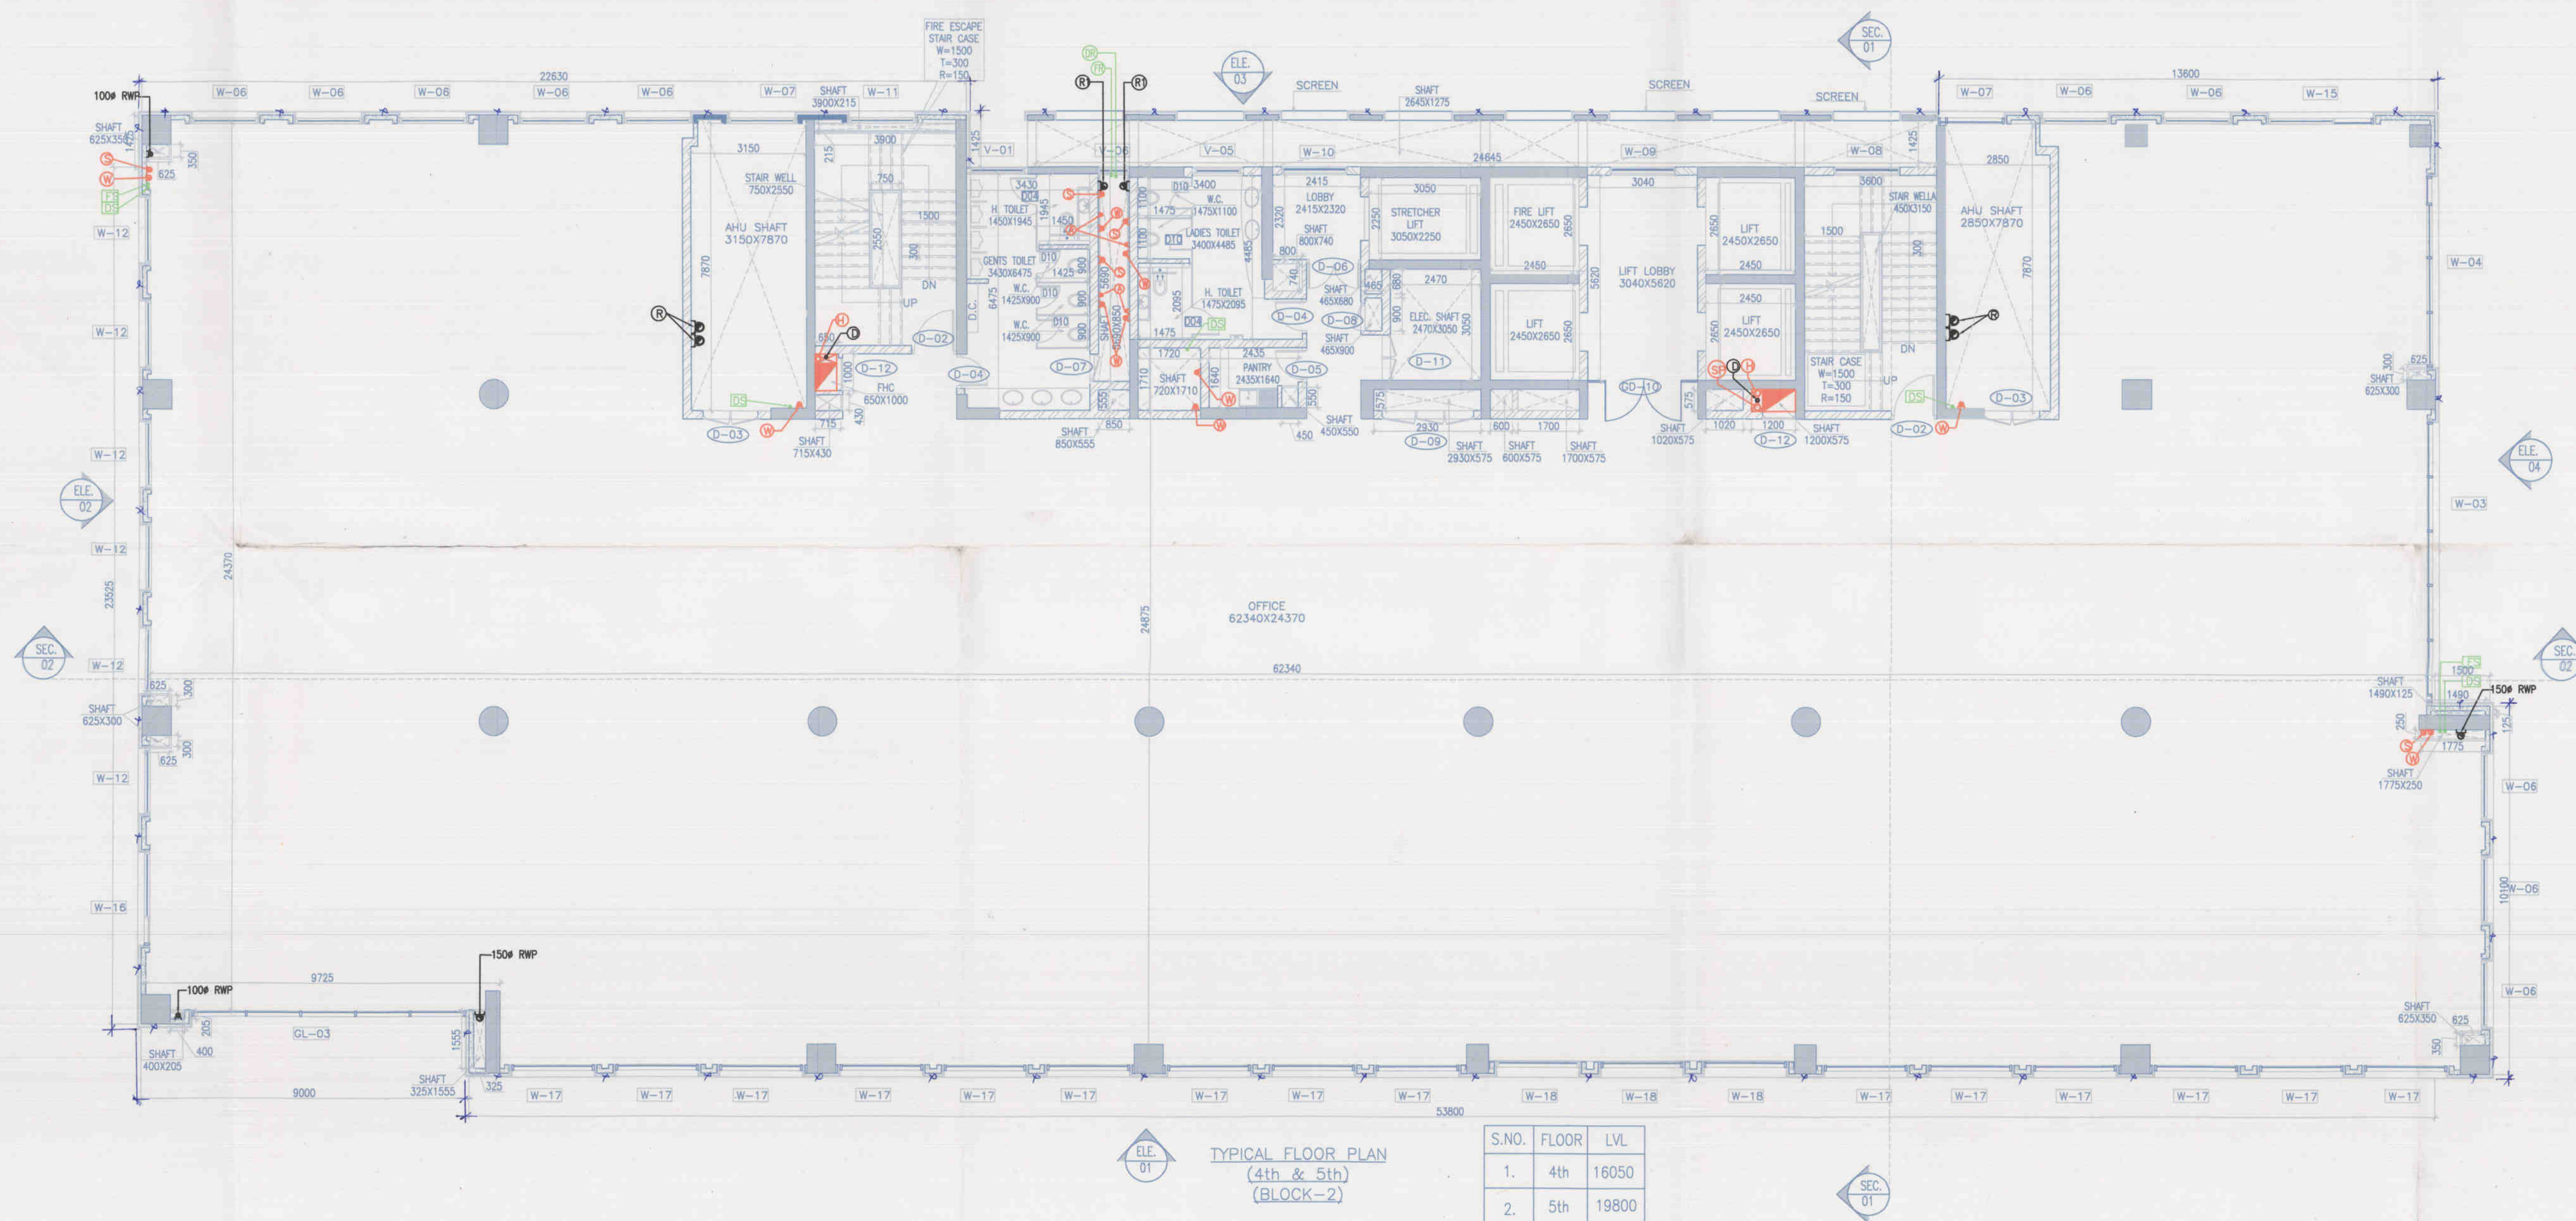


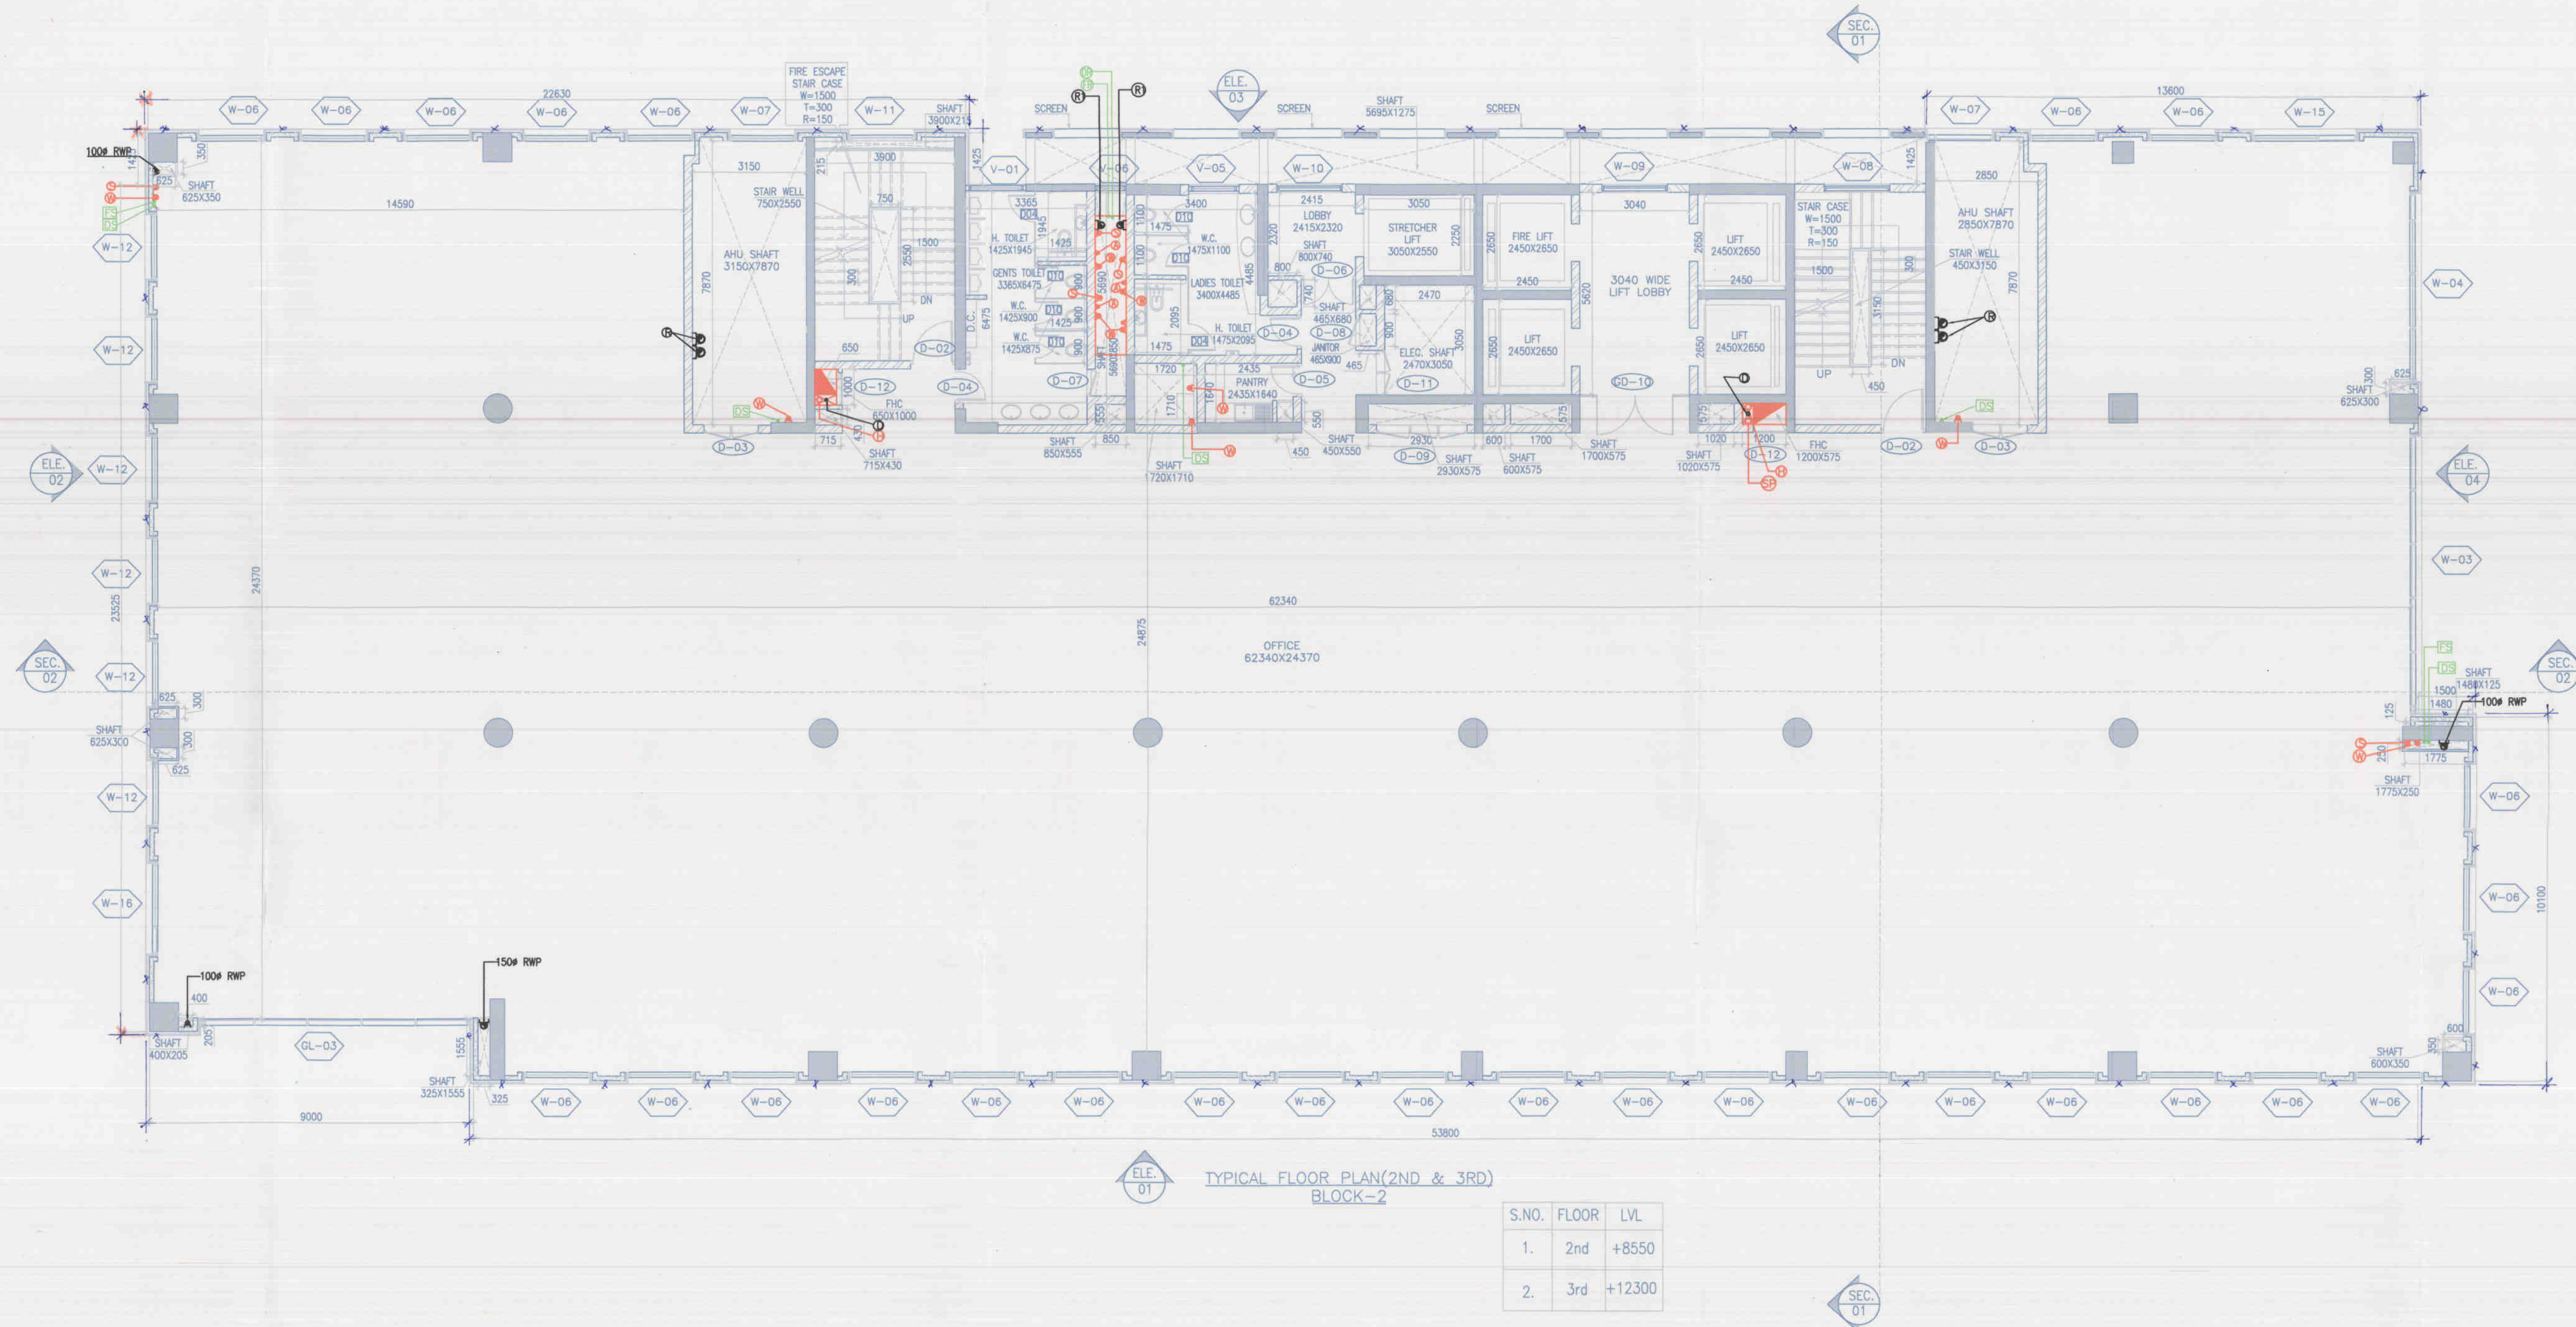

Note:-

1. BUILDING WILL BE DESIGNED (STRUCTURES) AS PER RELEVANT IS CODES FOR EARTH QUAKE RESISTANCE.

2. BUILDING IS HAS AUTOMATIC SPRINKLER SYSTEM ON ALL FLOORS.

LEGEND:-

LEGEND:- FIRE

	FIRE HOSE CABINET
	150mm HYDRANT PIPE
	80mm DRAIN PIPE
	150mm SPRINKLER PIPE

	150mm SOIL PIPE H.C.I.P
	100mm WASTE & VENT PIPE H.C.I.P
	75mm A.S. PIPE H.C.I.P
	200mm RAIN WATER PIPE
	150mm RAIN WATER PIPE
	100mm SOIL PIPE
	100mm WASTE PIPE H.C.I.
	75mm WASTE PIPE H.C.I.
	50mm WASTE PIPE H.C.I.
	50mm SOIL/WASTE PIPE H.C.I.
	FLUSHING RISER TO OHT
	DOMESTIC RISER TO OHT
	DOMESTIC DROP PIPE
	FLUSHING DROP PIPE

Project:

PROPOSED BUILDING PLAN OF COMMERCIAL COLONY SITE MEASURING 12.13125 ACRES (LICENSE NO-05 OF 2015 DATED 6-8-2015) IN SECTOR-16 GURGAON MANESAR URBAN COMPLEX BEING DEVELOPED BY SH. KESHAV DUTT AND OTHERS IN COLABORATION WITH CALDER DEVELOPERS PVT LTD (LC.2895)

Associate Architects

RISMS
ARCHITECTS

RSMS ARCHITECTS PVT. LTD.
69, Nora Niwas, Bhawani Kunj
(Behind D2), Vasant Kunj,
New Delhi-110070.
Tel.: 011-26898616, 26898617
www.rsms-arch.com

Checked and Approved by: Public (1)
(Internal Services) subject to be in forwarding No. 525 571/15
Superintending Engineer (H.O.)
D.D.A., Gurgaon

(RAM AVTAR BASSI)
A.D.

(BALWANT SINGH)
S.D.

ARCHITECT'S SEAL & SIGNATURE

OWNER'S SEAL & SIGNATURE



For Calder Developers Private Limited
Authorized Signatory

MAY-2015.

Scale : 1:100

Drawing Title:-

2nd TO 5th FLOOR PLAN
(BLOCK-2)

Drawing No:-

B2-02