


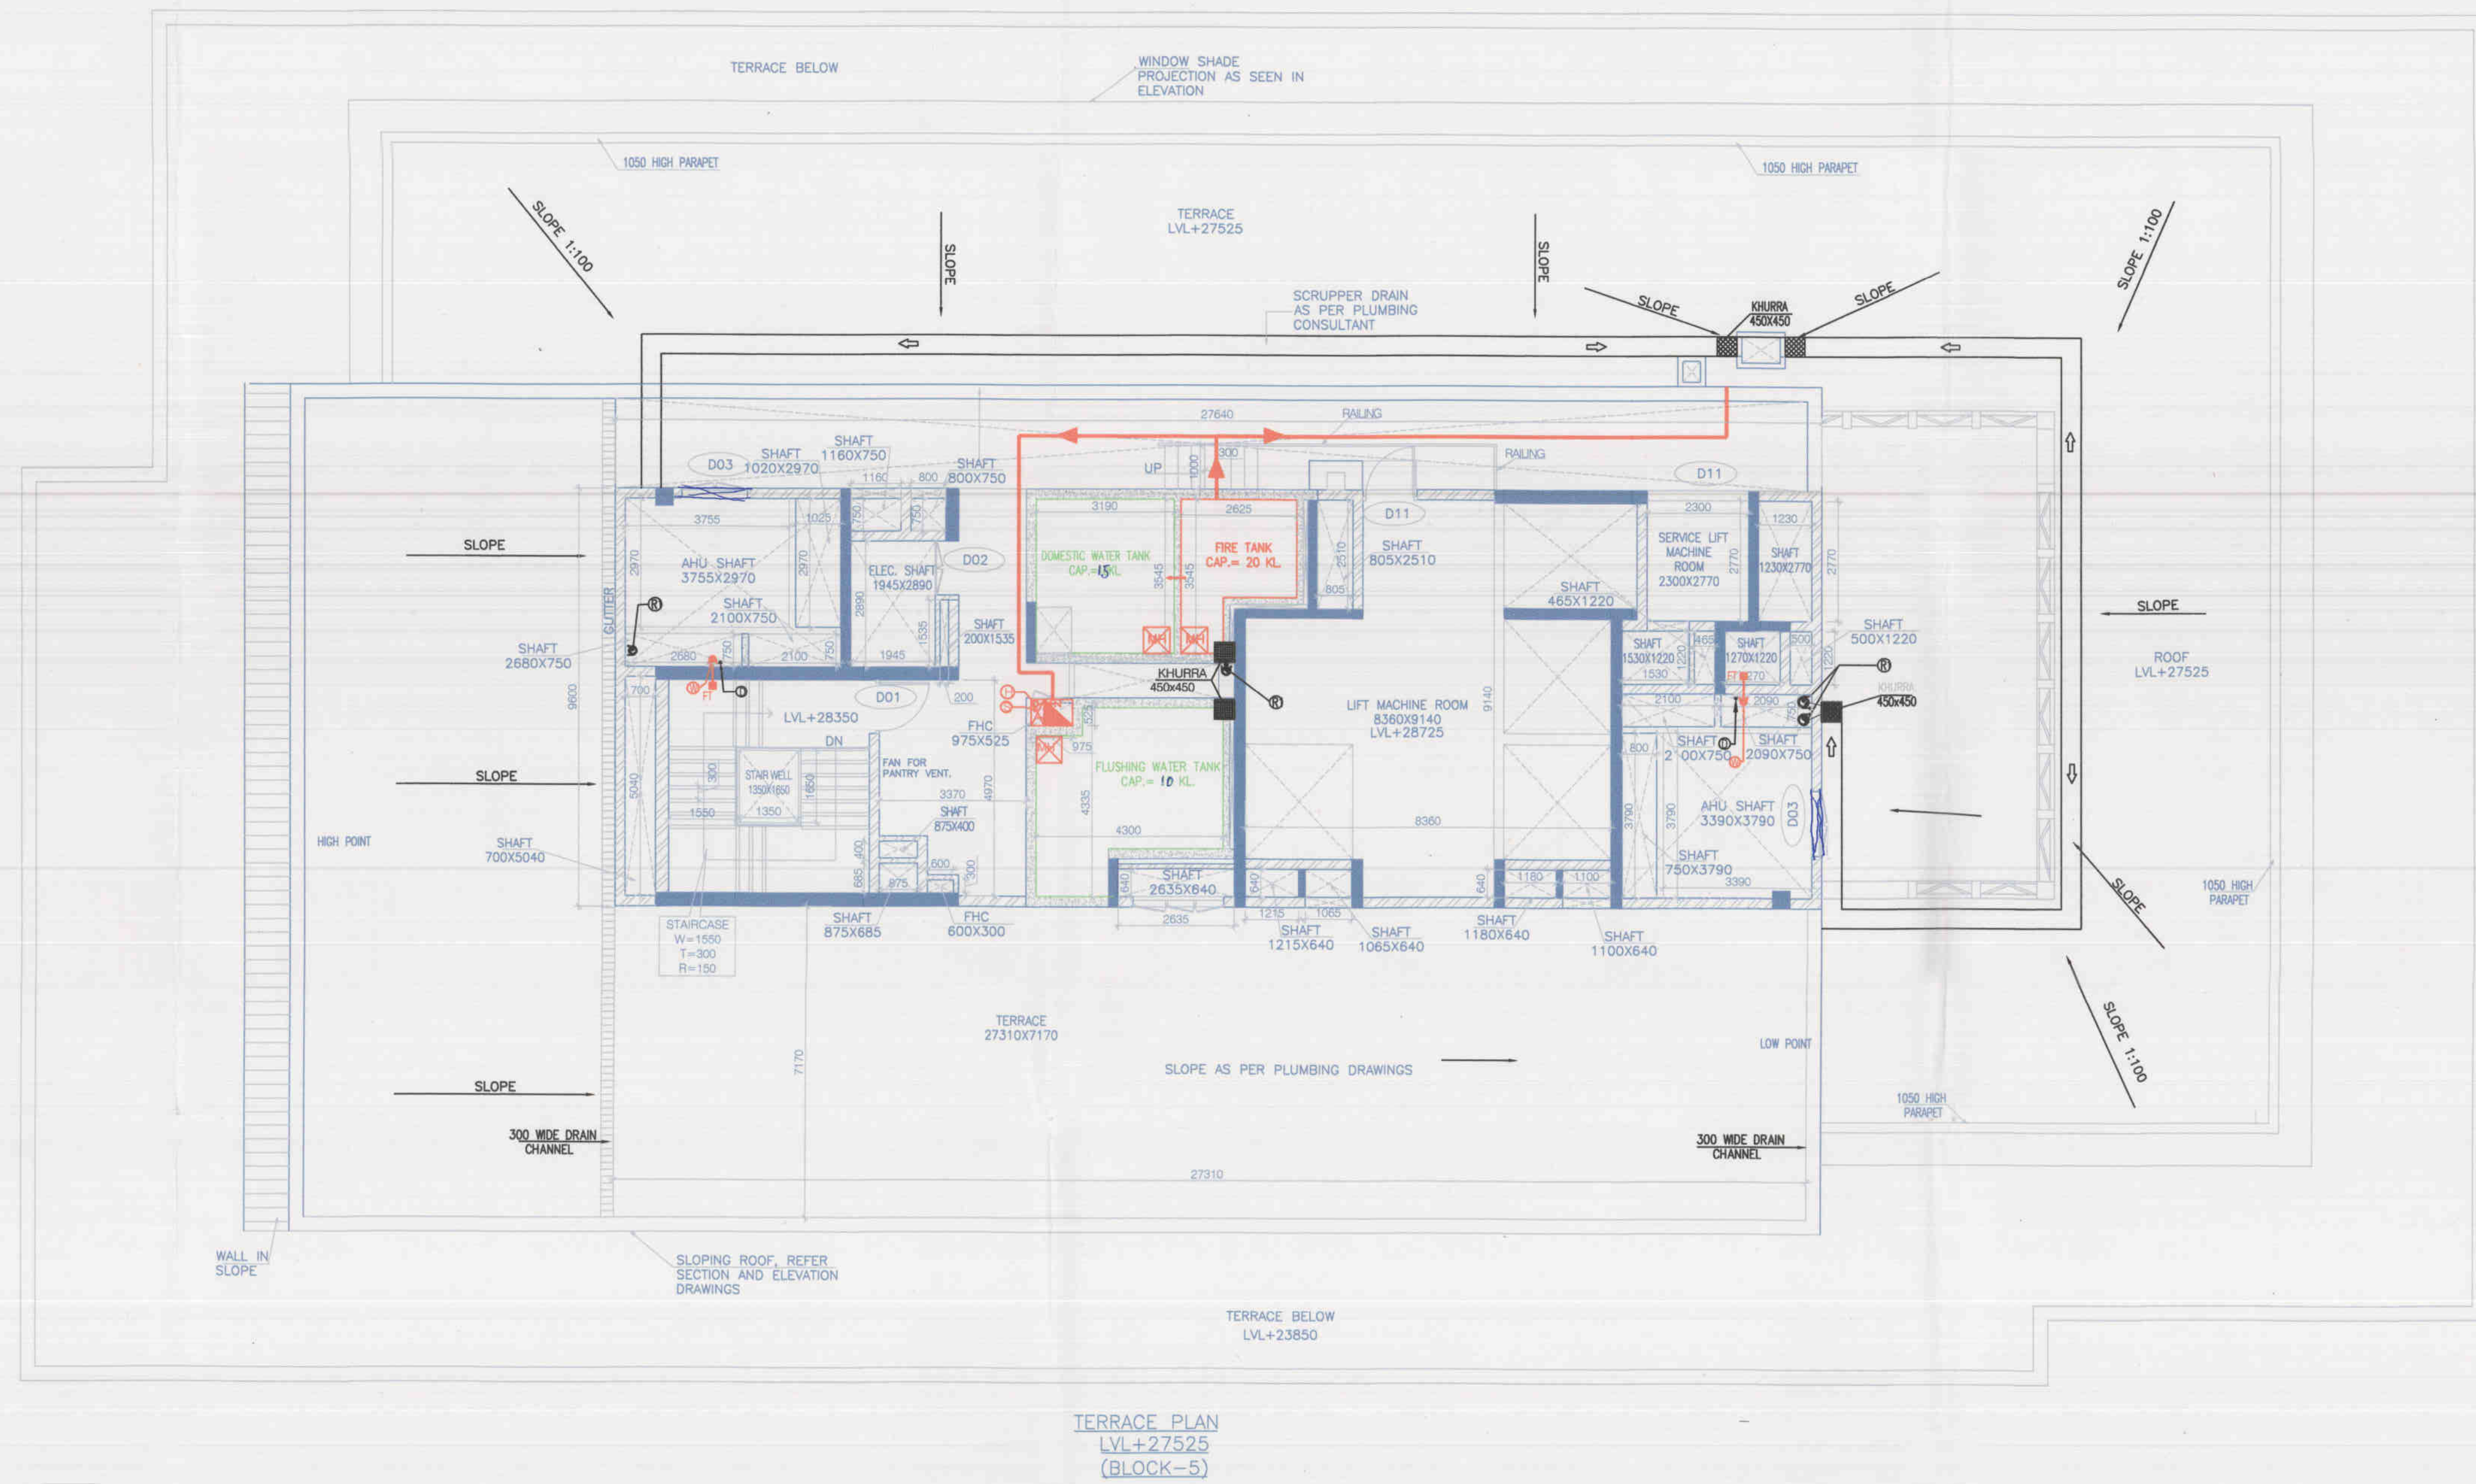

**BLOCK -5
DOOR WINDOW SCHEDULE**

OPENING NO.	LOCATION	ROUGH OPENING WIDTH SILL	FINISHED OPENING WIDTH SILL	ROUGH OPENING HEIGHT SILL	FINISHED OPENING HEIGHT SILL
D01	STAIRCASE	1240	2160	1200	2150
D02	ELECTRICAL	1240	2160	1200	2150
D03	AHU	1540	2160	1500	2150
D04	TOILET	1000	2160	900	2150
D05	WASHROOM	1000	2160	900	2150
D06	PAINTRY	1040	2160	1000	2150
D07	LOBBY	1540	2160	1500	2150
D08	FLUORINE	840	2160	800	2150
D09	ELV. ROOM	2100	2160	2060	2150
D10	PHC	940	2160	900	2150
D11	LAR	1240	2160	1200	2150
D12	W.C. COLLECTOR	1575	2160	1535	2150
D13	STAIRCASE	1240	2160	1200	2150
D14	OFFICE	1540	2160	1500	2150
D201	STAIRCASE	2140	2460	2100	2450
D15	W.C.	750	2100	750	2100

OPENING NO.	LOCATION	ROUGH OPENING WIDTH SILL	FINISHED OPENING WIDTH SILL	ROUGH OPENING HEIGHT SILL	FINISHED OPENING HEIGHT SILL
GL-01	STAIRCASE	7350	7510	7200	7500
GL-02	PAUL OFFICE	7350	7510	7200	7500
GL-02A	PAUL OFFICE	7350	7510	7200	7500
GL-03	PAUL OFFICE	7350	7510	7200	7500
GL-04	PAUL OFFICE	8700	7510	8550	7500
GL-05	PAUL OFFICE	7350	7510	7200	7500
GL-06	OFFICE	7350	7510	7200	7500
GL-07	REAR	7350	7510	7200	7500
GL-08	OFFICE	REFER PLAN	3075	REFER PLAN	3065
GL-08A	STAIRCASE	7350	7575	7200	7565
W-01	OFFICE	1950	3010	1800	3000
W-02	OFFICE	1950	3010	1800	3000
W-03	OFFICE	3450	3010	3300	3000
W-04	OFFICE	3450	3010	3300	3000
W-05	OFFICE	2850	3010	2700	3000
W-06	STAIRCASE	1950	3010	1800	3000



Note :-

- BUILDING WILL BE DESIGNED (STRUCTURES) AS PER RELEVANT IS CODES FOR EARTH QUAKE RESISTANCE.
- BUILDING IS HAS AUTOMATIC SPRINKLER SYSTEM ON ALL FLOORS.

LEGEND :-

FD	FLOOR DRAIN
MT	63mm UPVC WASTE PIPE
MT	MULTI TRAP-110x63/75mm
FT	FLOOR TRAP-110x63/75mm

1500	1500 SOIL PIPE H.C.I.P
1000	1000 WASTE & VENT PIPE H.C.I.P
750	750 AS PIPE H.C.I.P
2000	2000 RAIN WATER PIPE
1500	1500 RAIN WATER PIPE
1000	1000 SOIL PIPE
1000	1000 WASTE PIPE
750	750 WASTE PIPE
750	750 WASTE PIPE
1500	1500 SOIL/WASTE PIPE

FR	FLUSHING RISER TO OHT	] SIZE SYSTEM DIAGRAM
DR	DOMESTIC RISER TO OHT	
DS	DOMESTIC DROP PIPE	
FS	FLUSHING DROP PIPE	
11	OUTLET SIZE 150x150 FOR (FD & UT)	
2	OUTLET SIZE 200x200	
25	OUTLET SIZE 75x75 FOR (WB.SINK & URINAL)	

Project:

PROPOSED BUILDING PLAN OF COMMERCIAL COLONY SITE MEASURING 12.13125 ACRES(LICENSE NO-05 OF 2015 DATED 6-8-2015)IN SECTOR-16 GURGAON MANESAR URBAN COMPLEX BEING DEVELOPED BY SH.KESHAV DUTT AND OTHERS IN COLABORATION WITH CALDER DEVELOPERS PVT LTD(LC.2895)

Associate Architects



RSMS ARCHITECTS PVT. LTD.
69,Nora Niwas Bhawani Kunj (Behind D2), Vasant Kunj, New Delhi-110070.
Tel.: 011-26898616,26898617
www.rsms-arch.com

Checked and found ok for P&T (General) Section only subject to forwarding letter No. SE/HR/535/10/15

Superintending Engineer (HO) BUDA, Punjab

(BALWANT SINGH) S.D.

ARCHITECT'S SEAL & SIGNATURE

OWNER'S SEAL & SIGNATURE

For Calder Developers Private Limited

Authorized Signatory

MAY-2015, Scale : 1:100

Drawing Title:-
TERRACE PLAN & LMR ROOF PLAN (BLOCK-5)

Drawing No:-
BS-04