
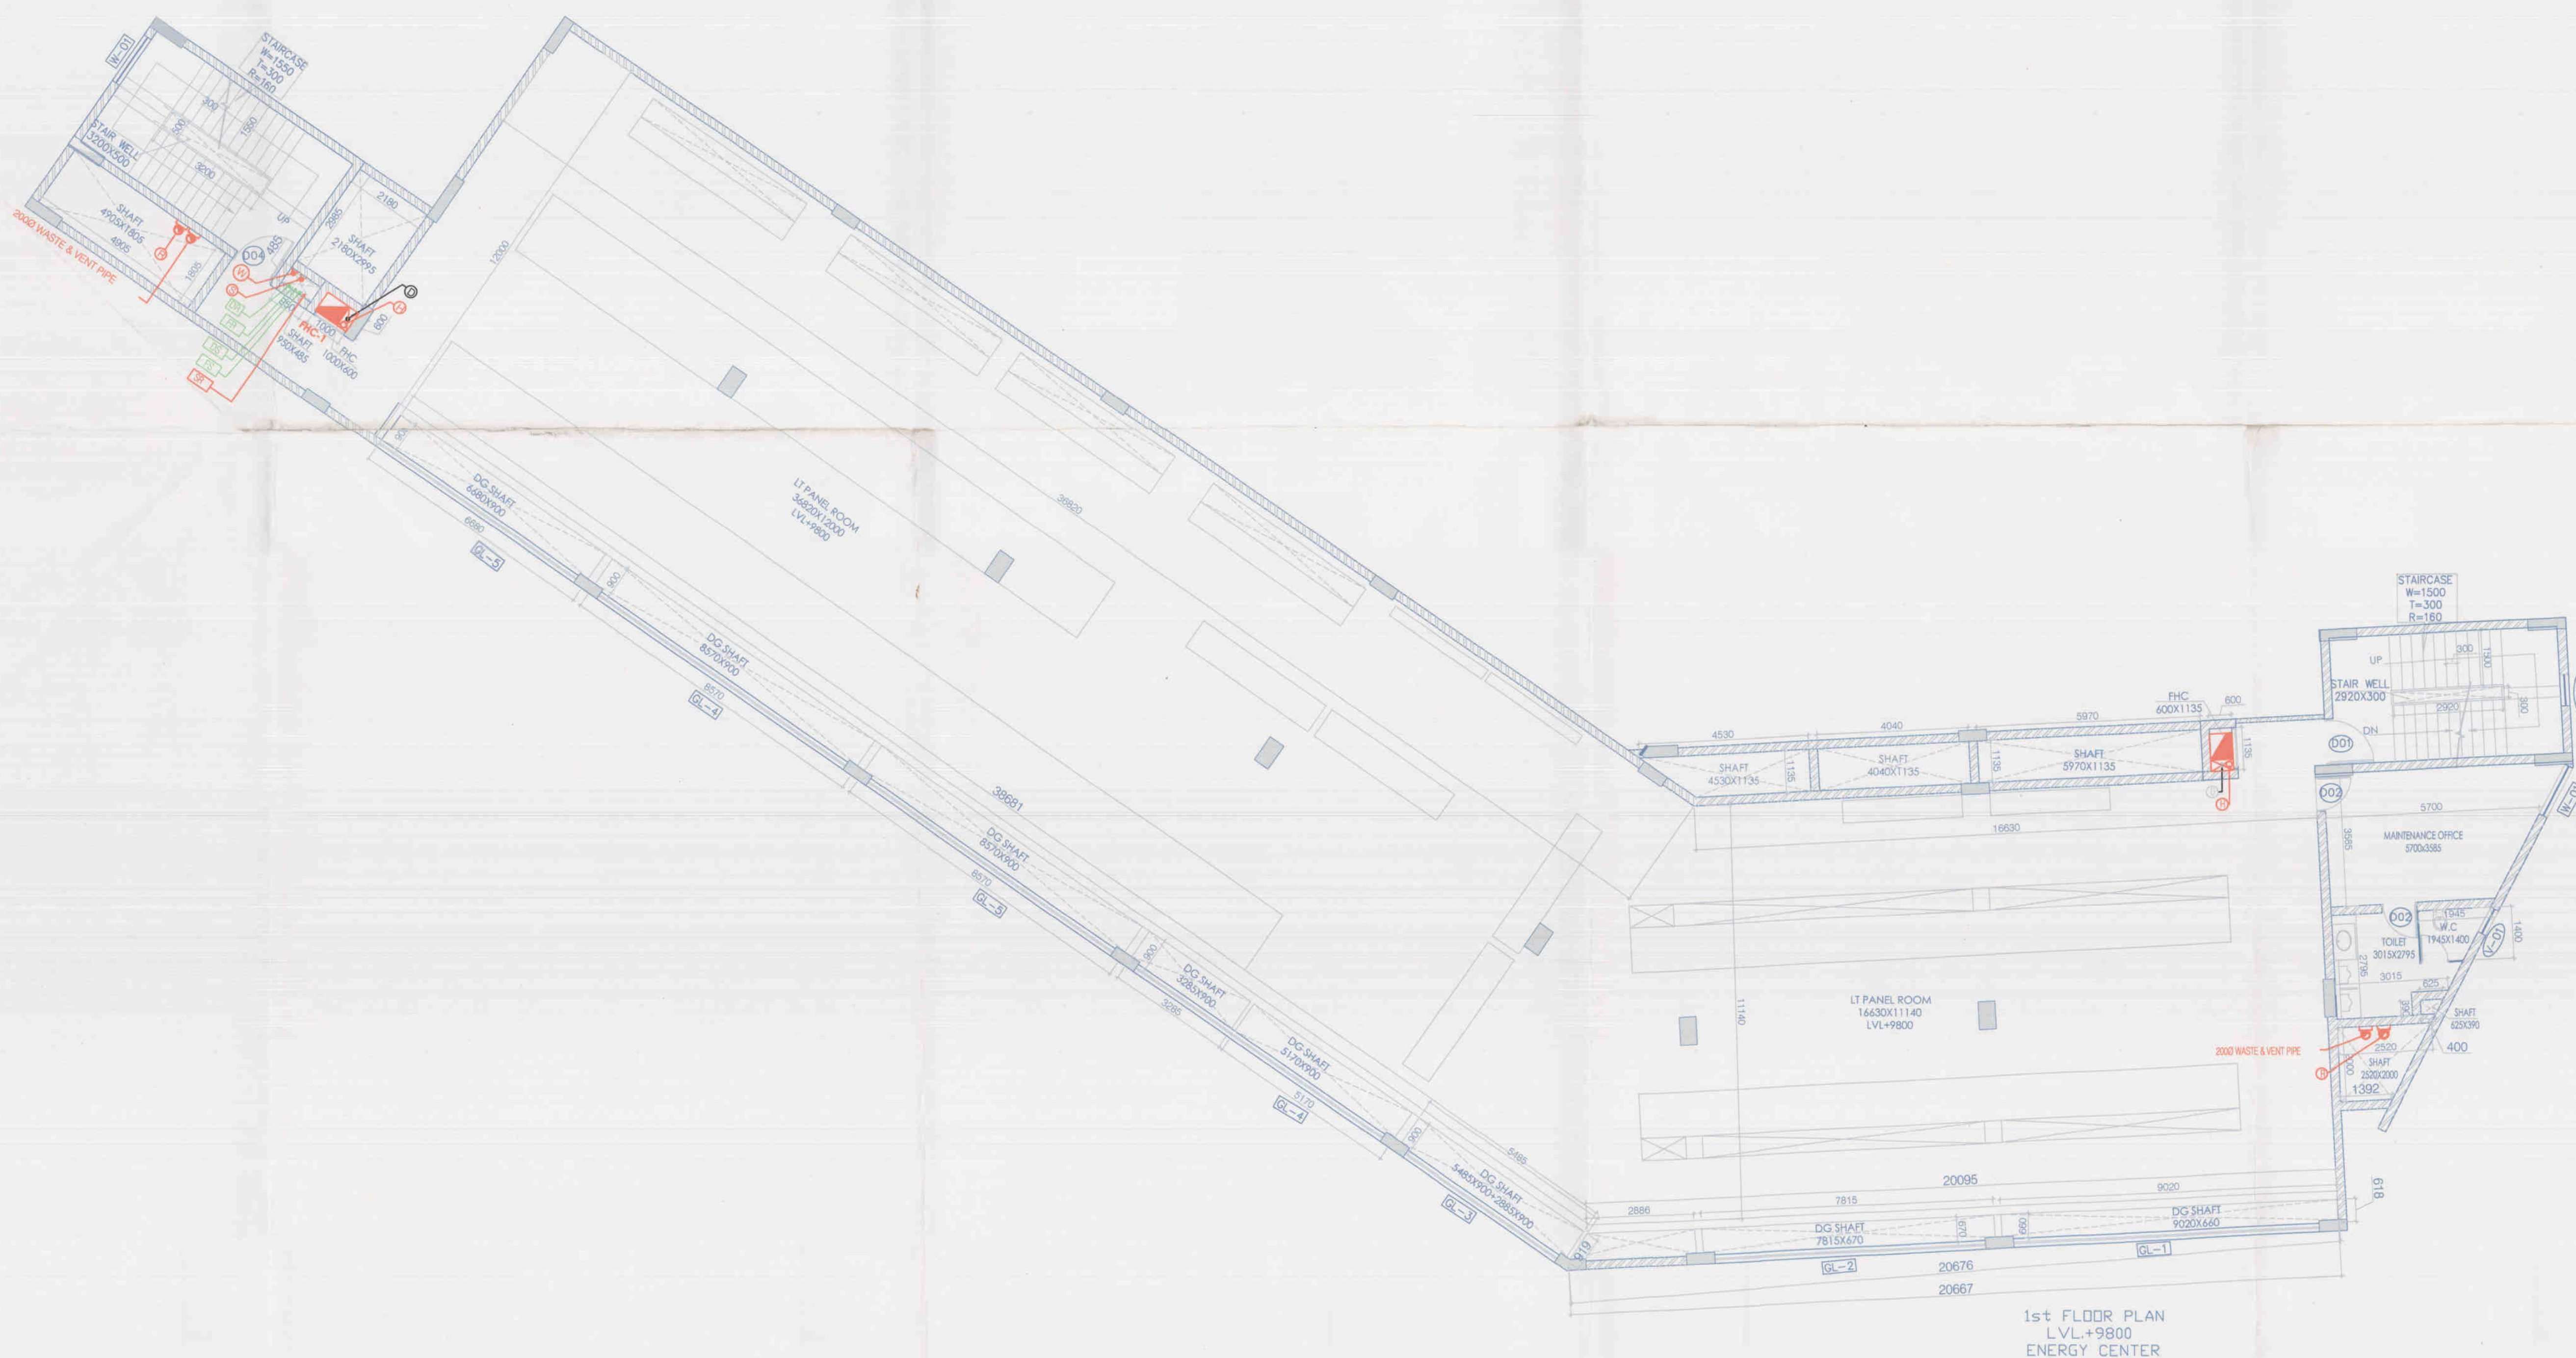


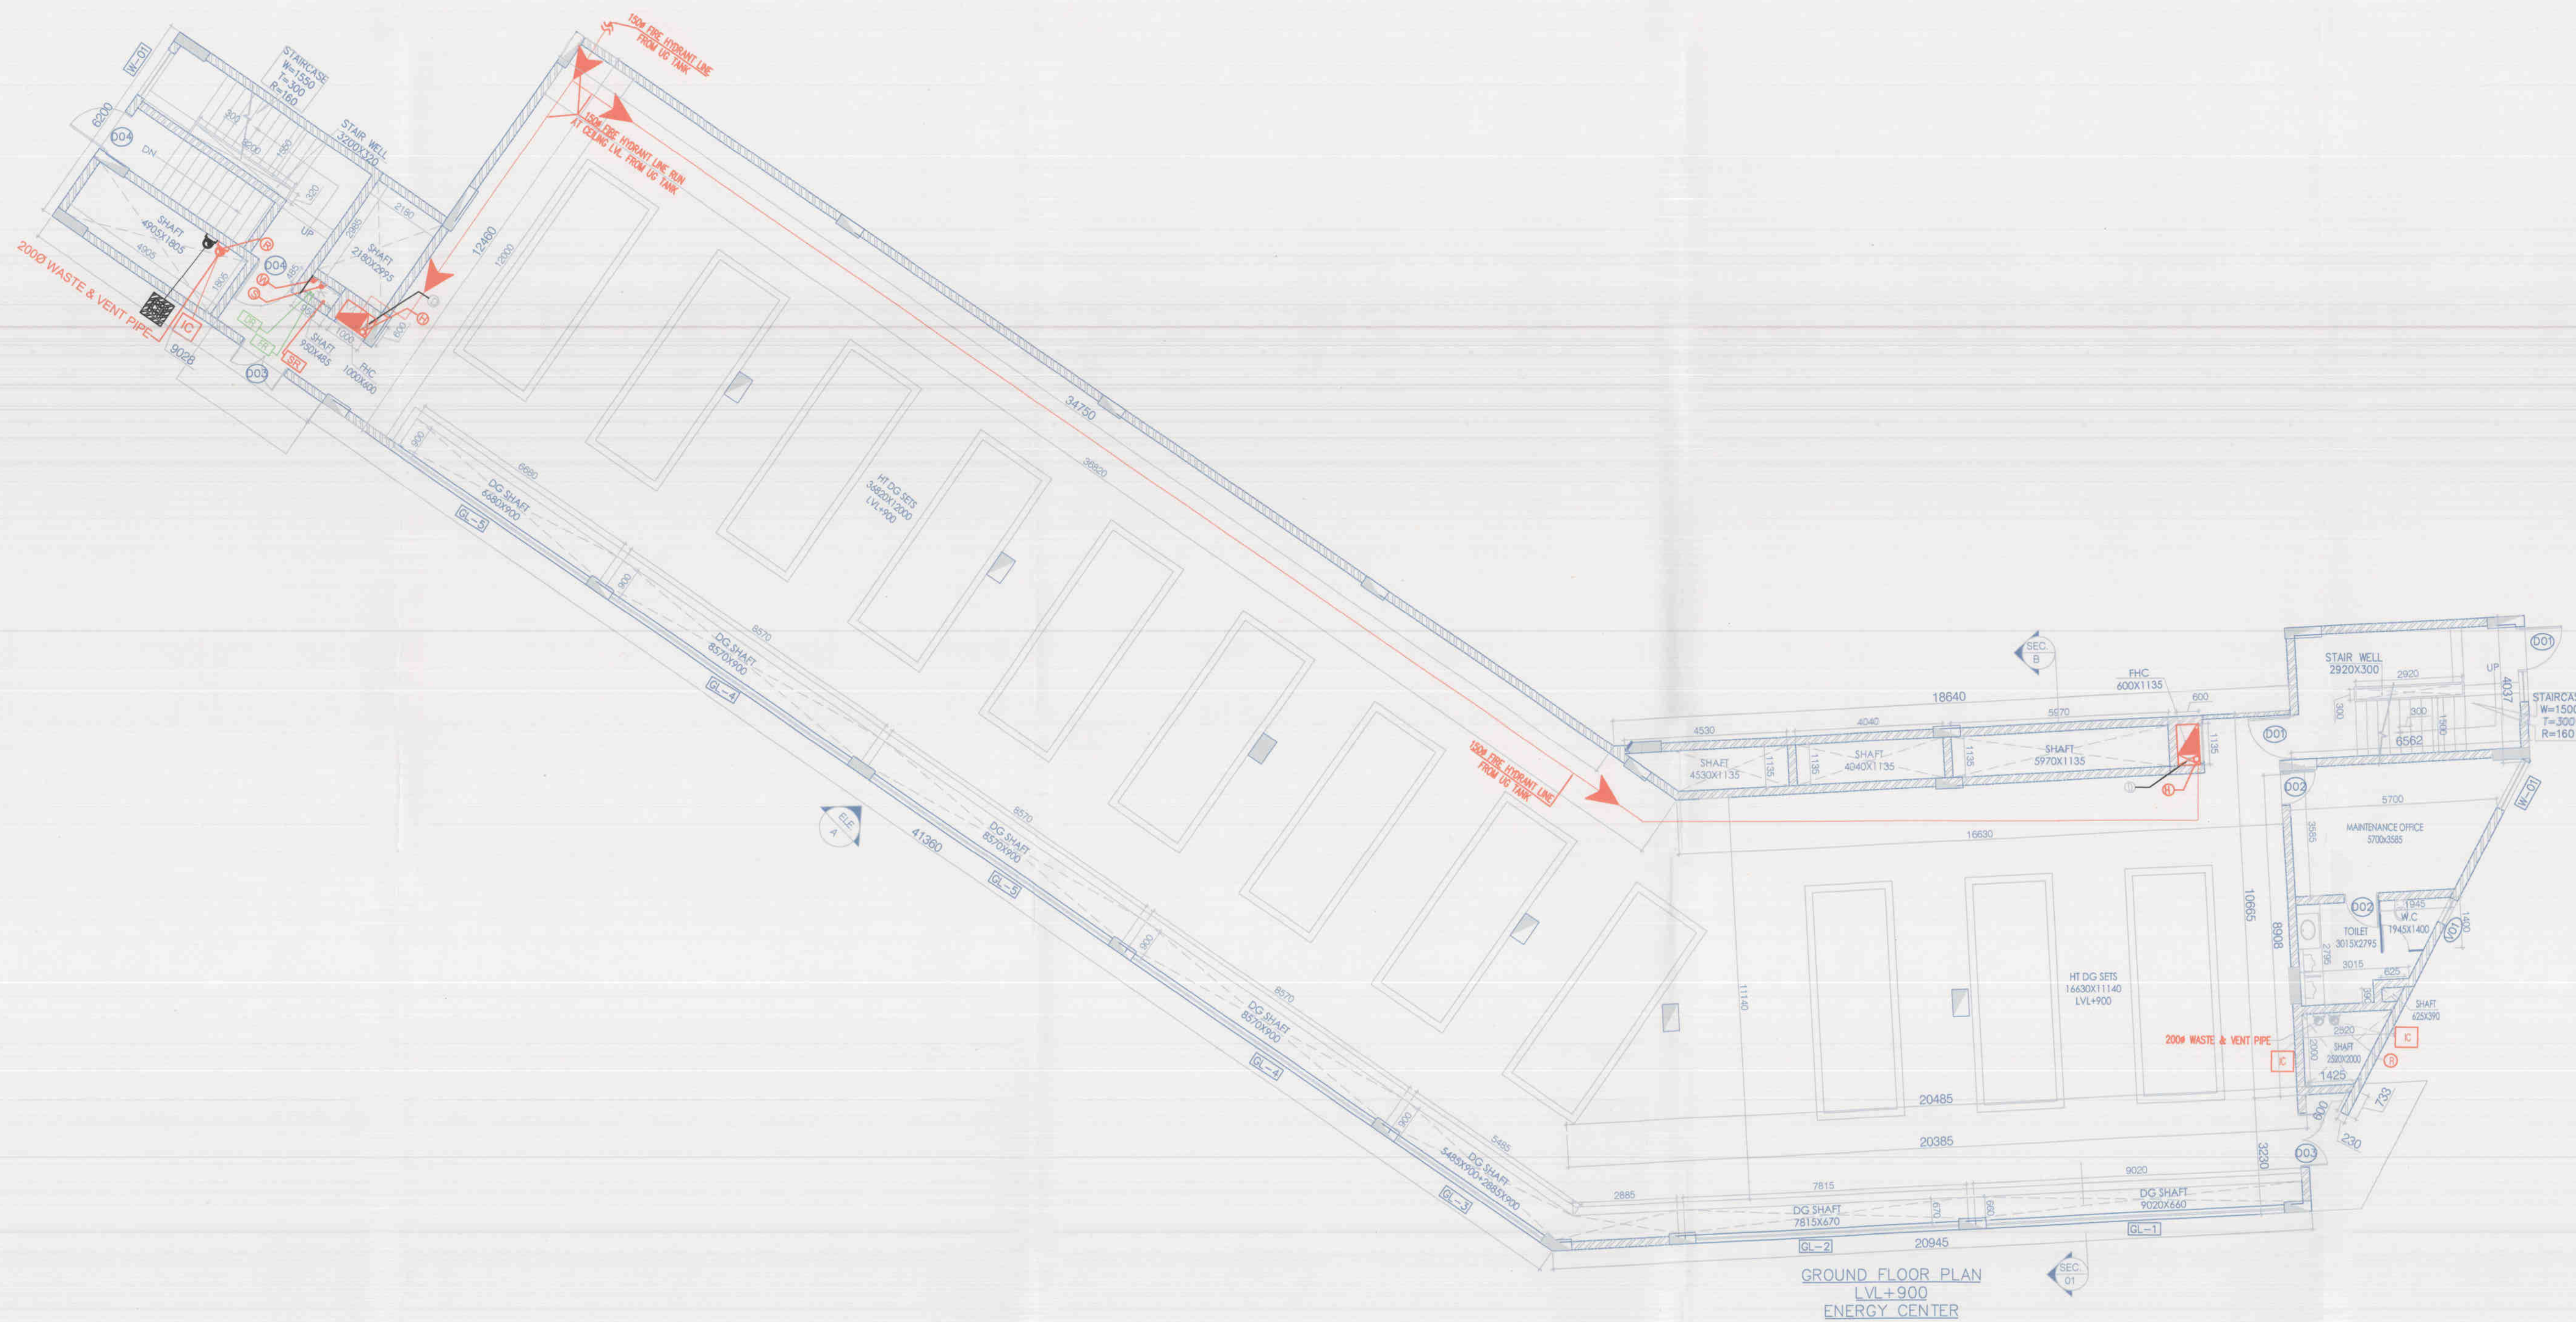

Note :-

1. BUILDING WILL BE DESIGNED (STRUCTURES) AS PER RELEVANT IS CODES FOR EARTH QUAKE RESISTANCE.
2. BUILDING IS HAS AUTOMATIC SPRINKLER SYSTEM ON ALL FLOORS.

LEGEND :-

LEGEND:- FIRE	
	FIRE HOSE CABINET
	1500mm HYDRANT PIPE
	800mm DRAIN PIPE

	1000 SOIL & VENT PIPE
	1000 WASTE & VENT PIPE
	2000 WASTE & VENT PIPE
	1000 SOIL PIPE
	1000 WASTE PIPE
	500 WASTE PIPE
	500 SOIL/WASTE PIPE
	200 WASTE PIPE
	SOFT WATER RISER
	FLUSHING RISER TO OHT
	DOMESTIC RISER TO OHT
	DOMESTIC DROP PIPE
	FLUSHING DROP PIPE
	FLOOR DRAIN
	FLOOR TRAP
	CLEAN OUT PLUG
	CUTOUT SIZE 150x150 FOR (FD, FT & UT)
	CUTOUT SIZE 150x150 FOR (FD, FT & UT)

Project:
PROPOSED BUILDING PLAN OF
COMMERCIAL COLONY SITE MEASURING
12.13125 ACRES(LICENSE NO-05 OF
2015 DATED 6-8-2015)IN SECTOR-16
GURGAON MANESAR URBAN COMPLEX
BEING DEVELOPED BY SH.KESHAV DUTT
AND OTHERS IN COLABORATION WITH
CALDER DEVELOPERS PVT LTD(LC.2895)
Associate Architects

RISMS
ARCHITECTS

RMS ARCHITECTS PVT. LTD.
69,Nora Niwas Bhowani Kunj
(Behind D2), Vasant Kunj,
New Delhi-110070.
Tel.:011-26898616,26898617
www.rsms-arch.com

D.L. Singh
S.D.

Checked and found ok for Public Health
(Internal) Service only subject to comments
in forwarding letter No. 1347/1348/1349/1350
Superintending Engineer (H.O.)
HUDA, Faridkot

(RAM AVTAR BANSI)
A.D.

(BALWANT SINGH)
S.D.

ARCHITECT'S SEAL
& SIGNATURE

OWNER'S SEAL
& SIGNATURE

(RAM AVTAR BANSI)
A.D.

(BALWANT SINGH)
S.D.

MAY-2015.

Scale : 1:100

Drawing Title:-

GROUND FLOOR &
1st FLOOR PLAN
ENERGY CENTER

Drawing No:-

EN-01