
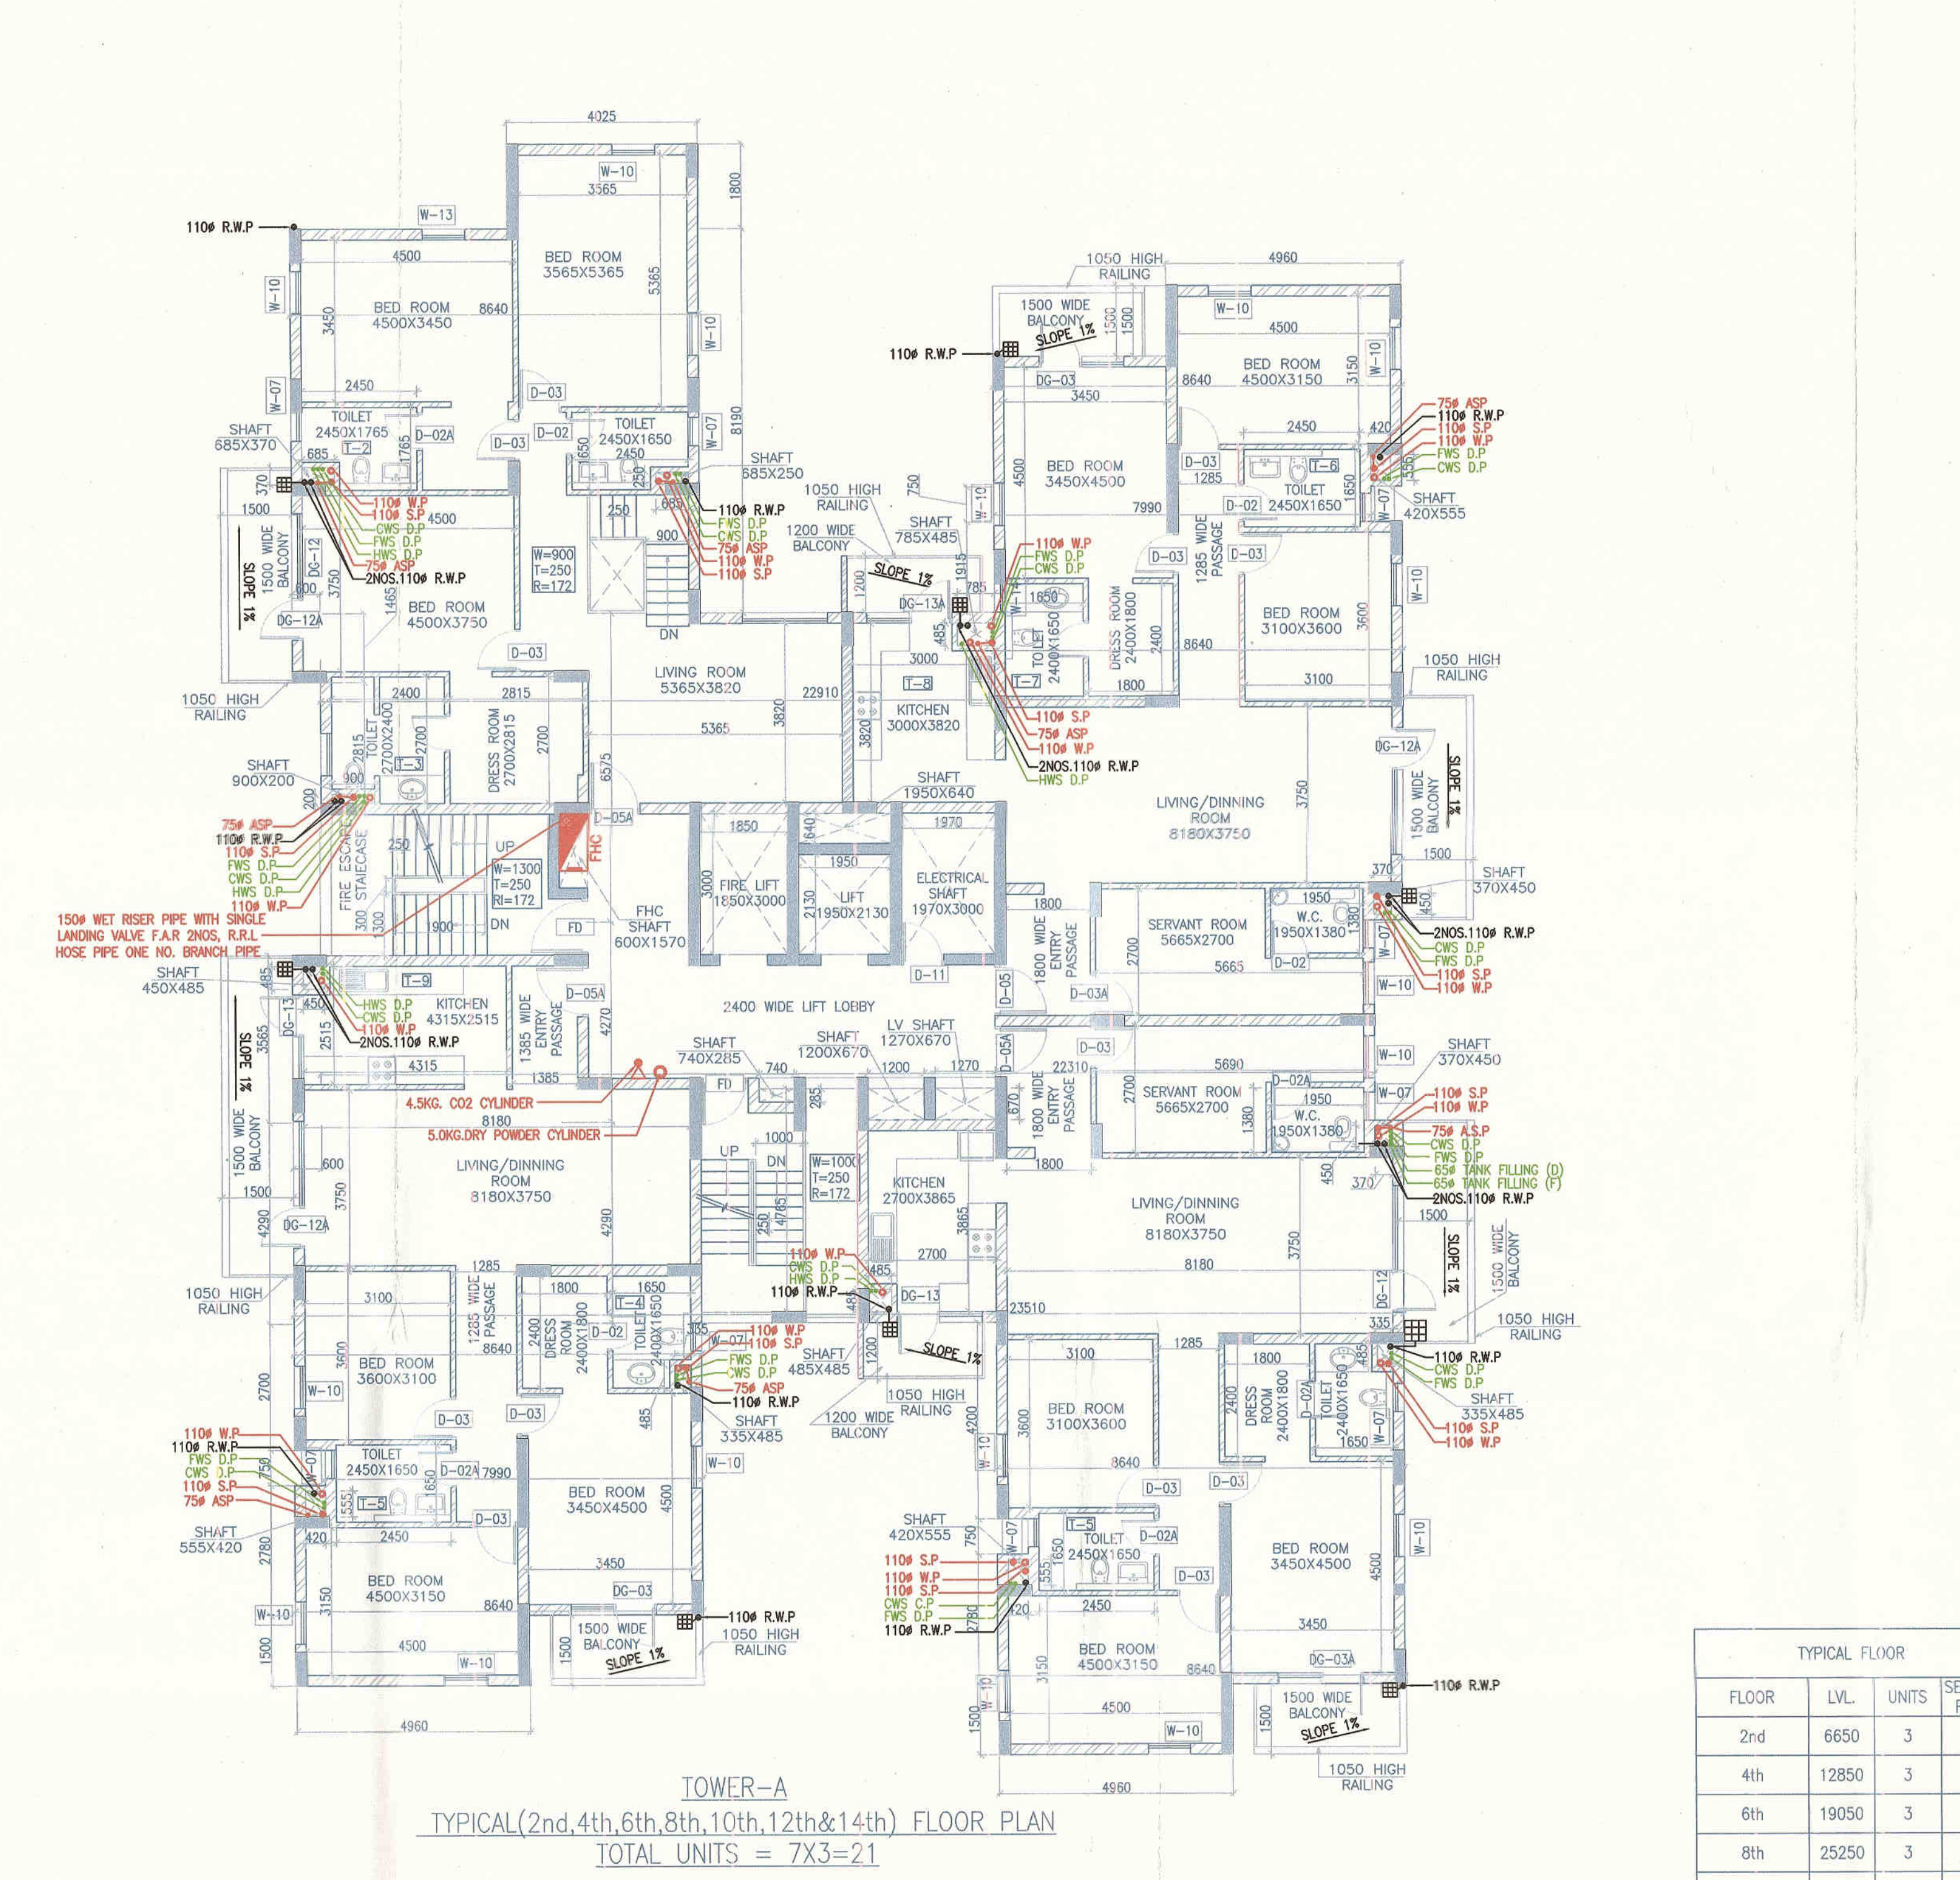


Note :-
 1. BUILDING WILL BE DESIGNED (STRUCTURES) AS PER RELEVANT IS CODES FOR EARTH QUAKE RESISTANCE.
 2. THE BUILDING COMPLY WITH FIRE NORMS

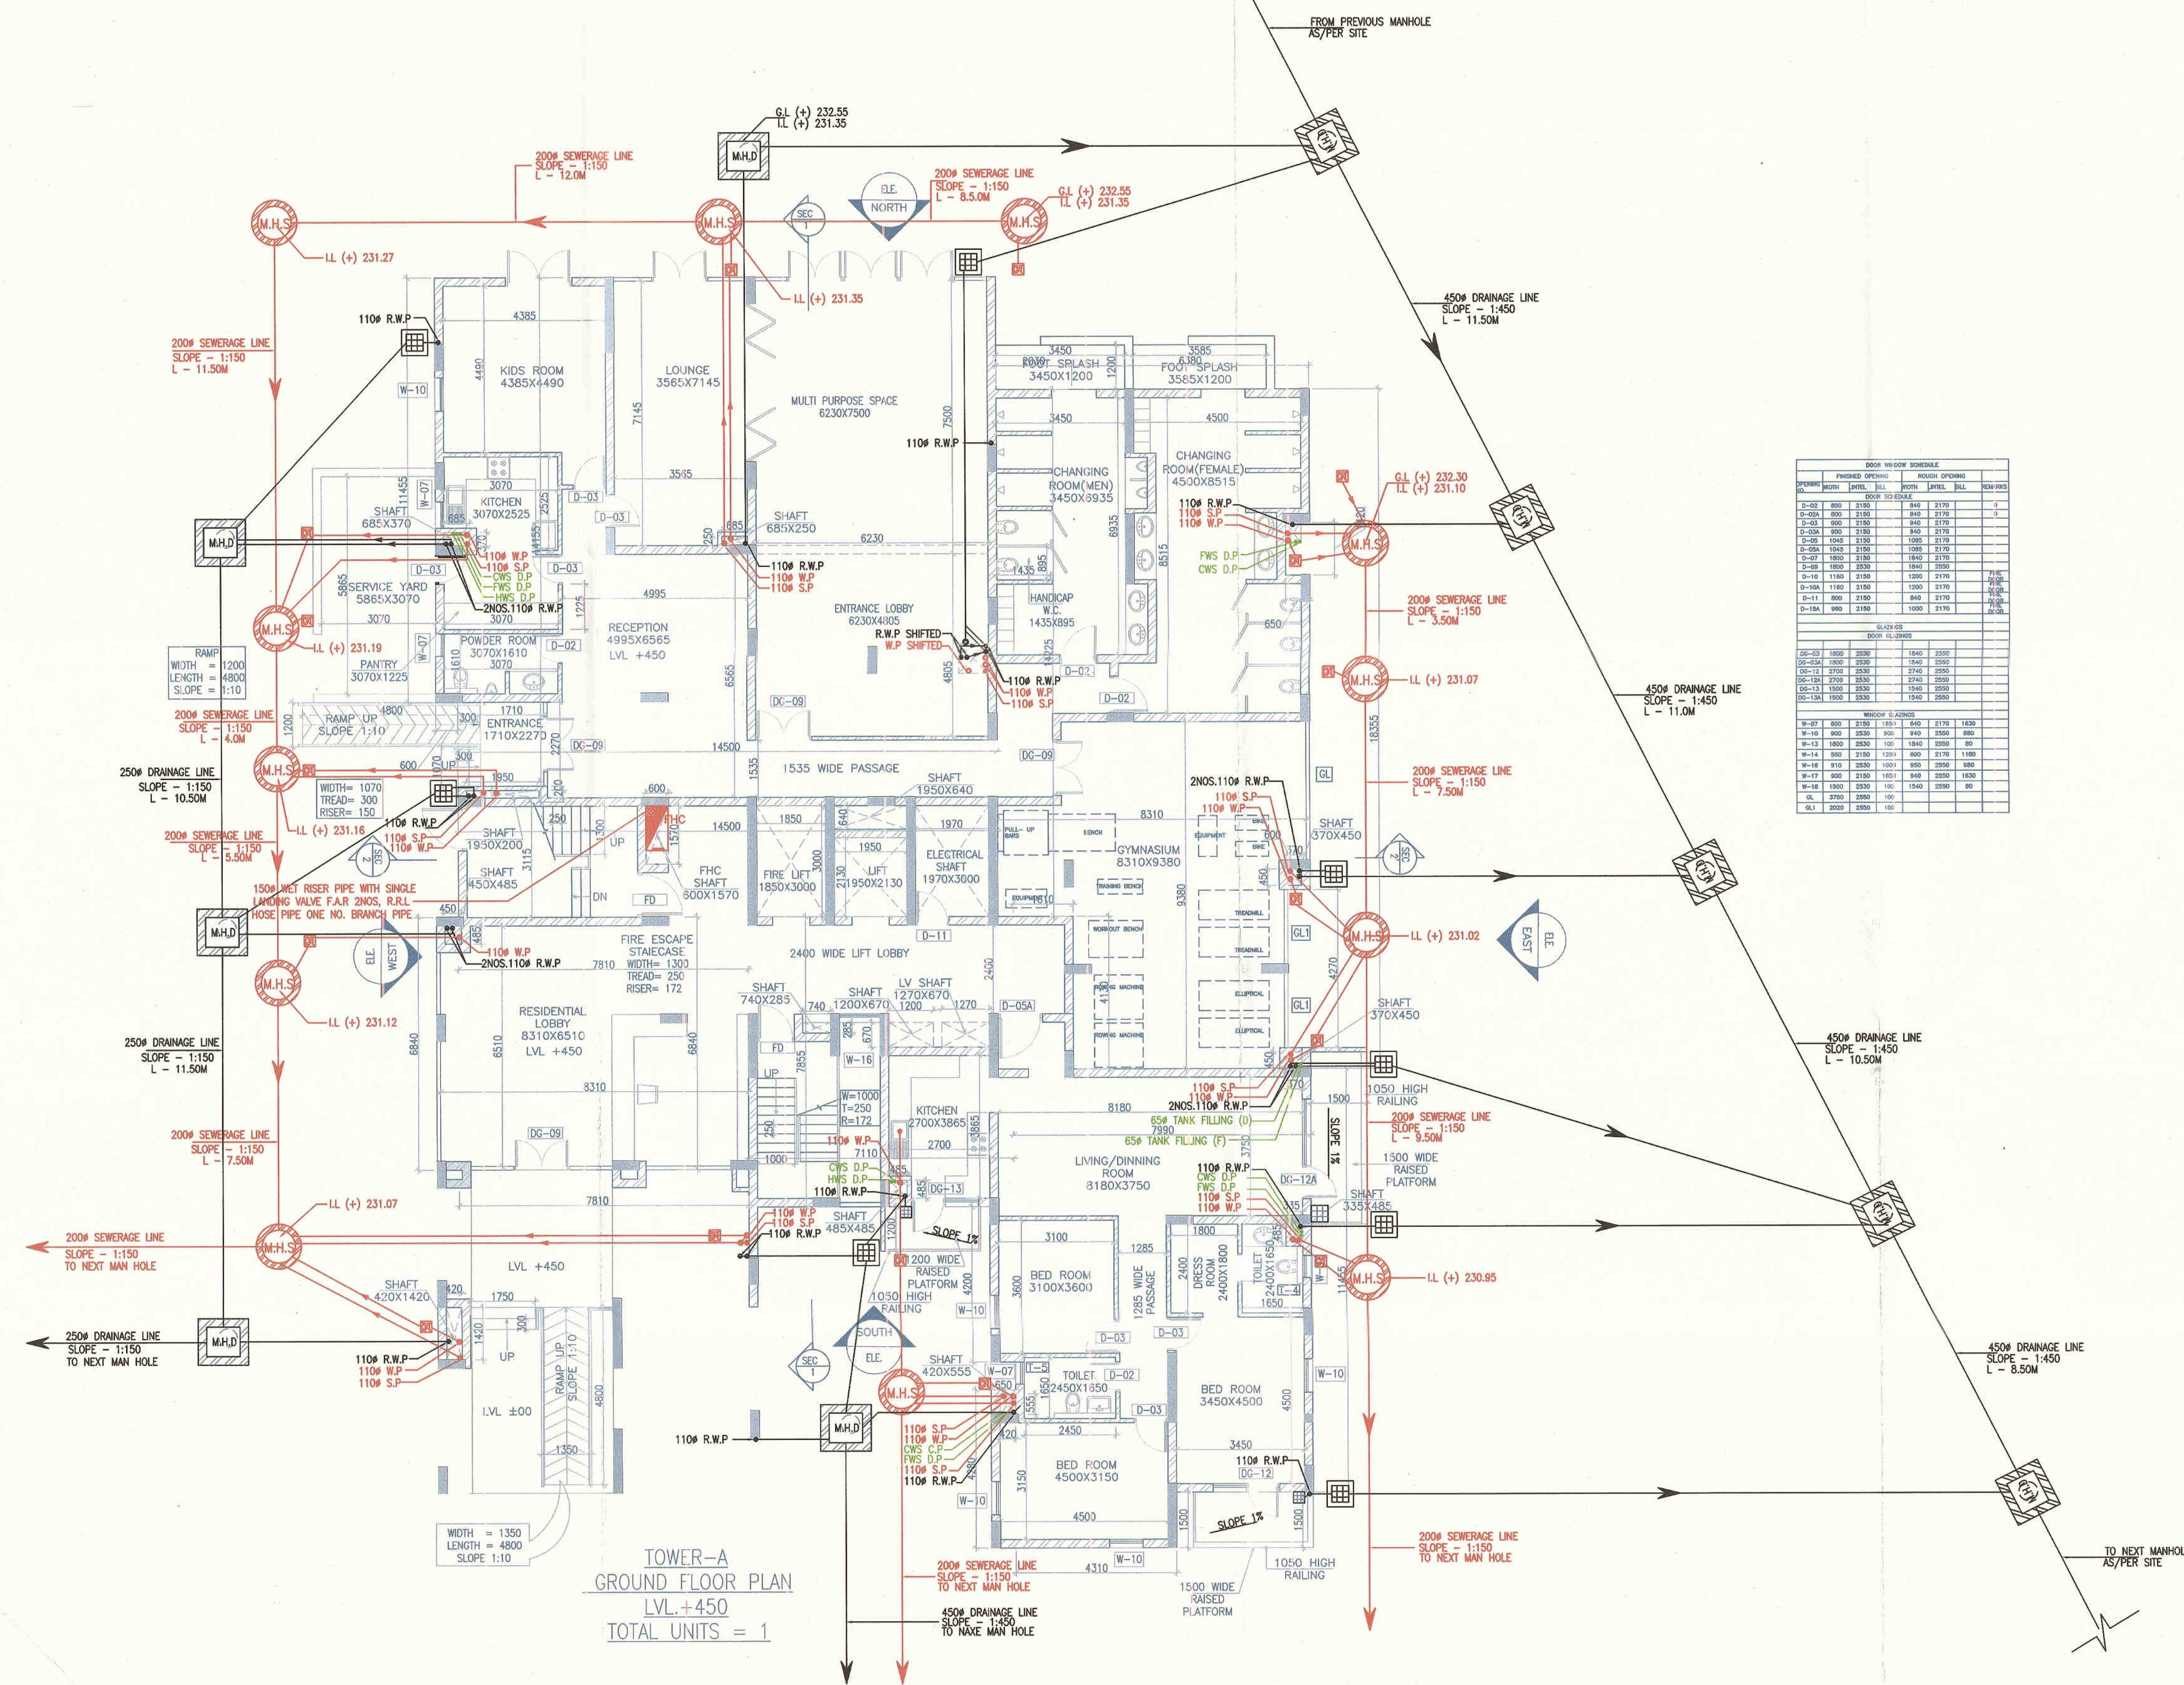

LEGEND :-




S.NO.	SYMBOL	DESCRIPTION
1.	[Symbol]	CO2 CYLINDER 4.5KG. CAP.
2.	[Symbol]	FIRE HOSE CABINET (2000MM)
3.	[Symbol]	CHECK / NON-RETURN VALVE
4.	[Symbol]	BUTTER FLY VALVE
5.	[Symbol]	MANUAL SPRINKLER
6.	[Symbol]	SMALL TYPE SPRINKLER
7.	[Symbol]	SMALL TYPE SPRINKLER

LEGEND FOR PLUMBING SYSTEM

S.NO.	SYMBOL	DESCRIPTION
1.	[Symbol]	100MM SOIL PIPE
2.	[Symbol]	100MM WASTE PIPE
3.	[Symbol]	100MM FLOOR TRAP
4.	[Symbol]	COLD WATER SUPPLY (DOWN TAKE)
5.	[Symbol]	FLUSHING WATER SUPPLY (DOWN TAKE)
6.	[Symbol]	FLUSHING WATER SUPPLY (DOWN TAKE)
7.	[Symbol]	100MM WATER PIPE
8.	[Symbol]	100MM WATER PIPE
9.	[Symbol]	100MM WATER PIPE
10.	[Symbol]	100MM WATER PIPE
11.	[Symbol]	100MM WATER PIPE
12.	[Symbol]	100MM WATER PIPE
13.	[Symbol]	100MM WATER PIPE
14.	[Symbol]	100MM WATER PIPE
15.	[Symbol]	100MM WATER PIPE
16.	[Symbol]	100MM WATER PIPE
17.	[Symbol]	100MM WATER PIPE

TYPICAL FLOOR

FLOOR	LVL.	UNITS	SERVANT ROOM
2nd	6650	3	2
4th	12850	3	2
6th	19050	3	2
8th	25250	3	2
10th	31450	3	2
12th	37650	3	2
14th	43850	3	2
TOTAL UNITS		21	14

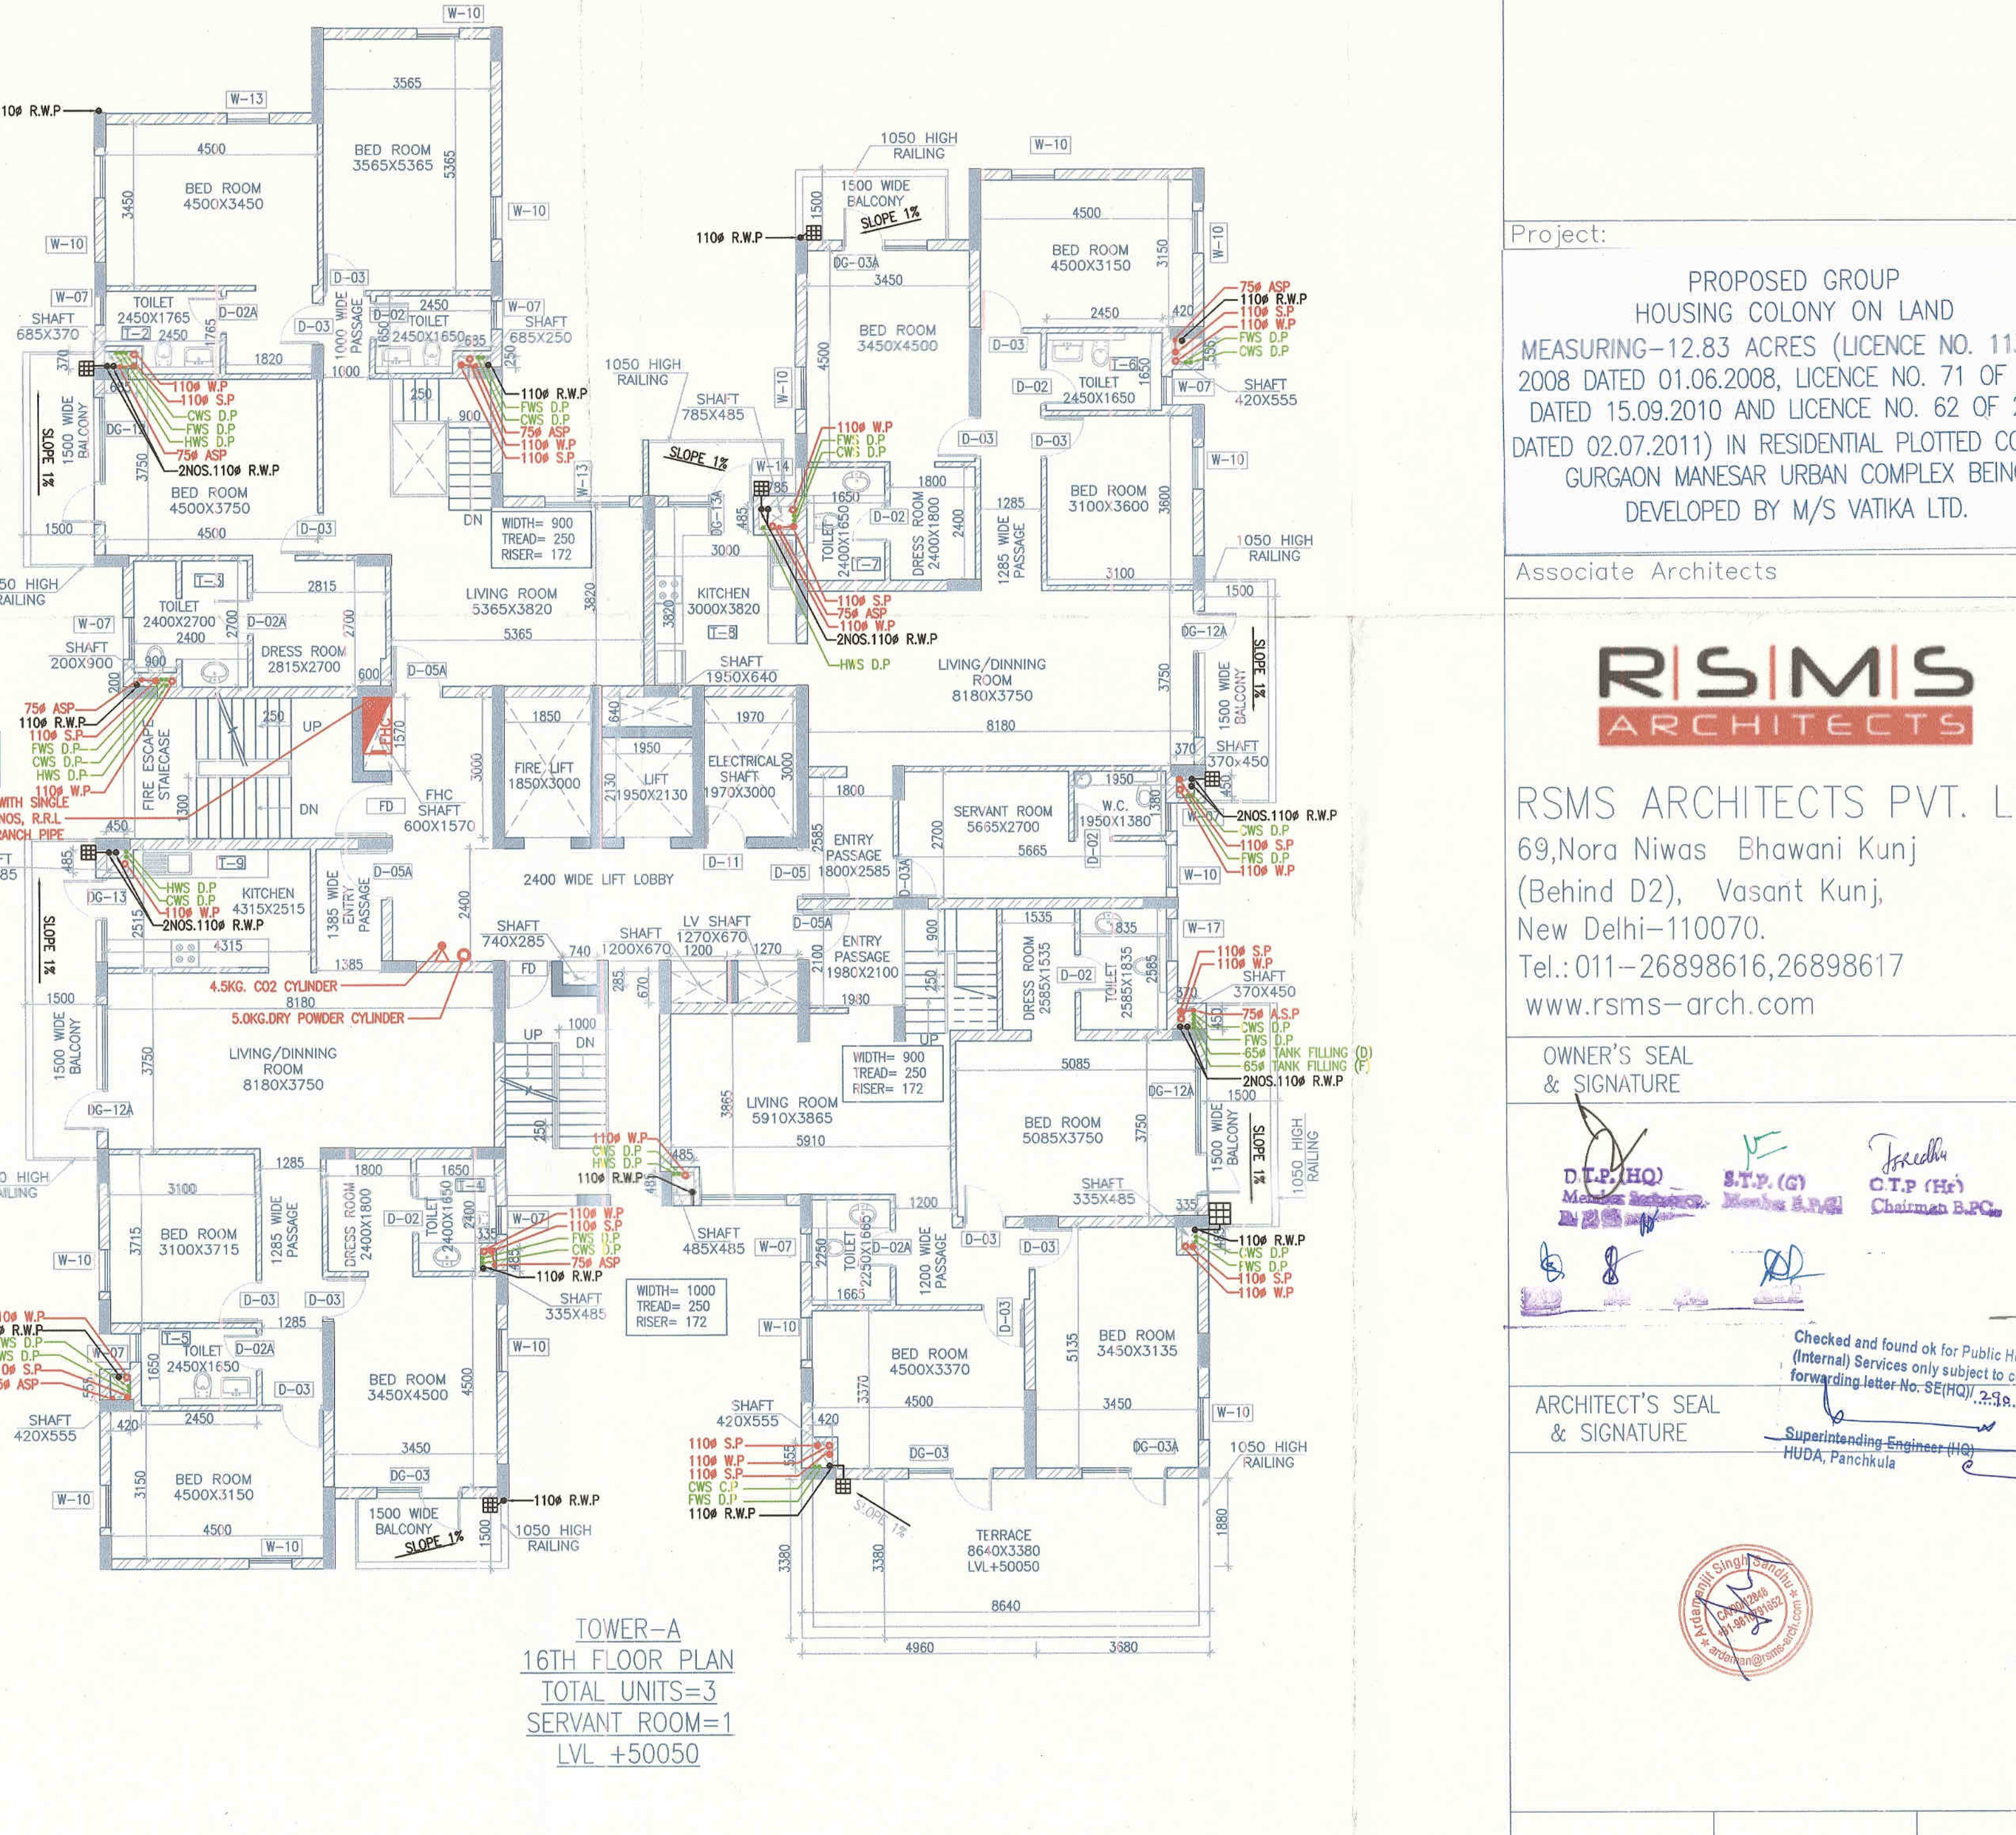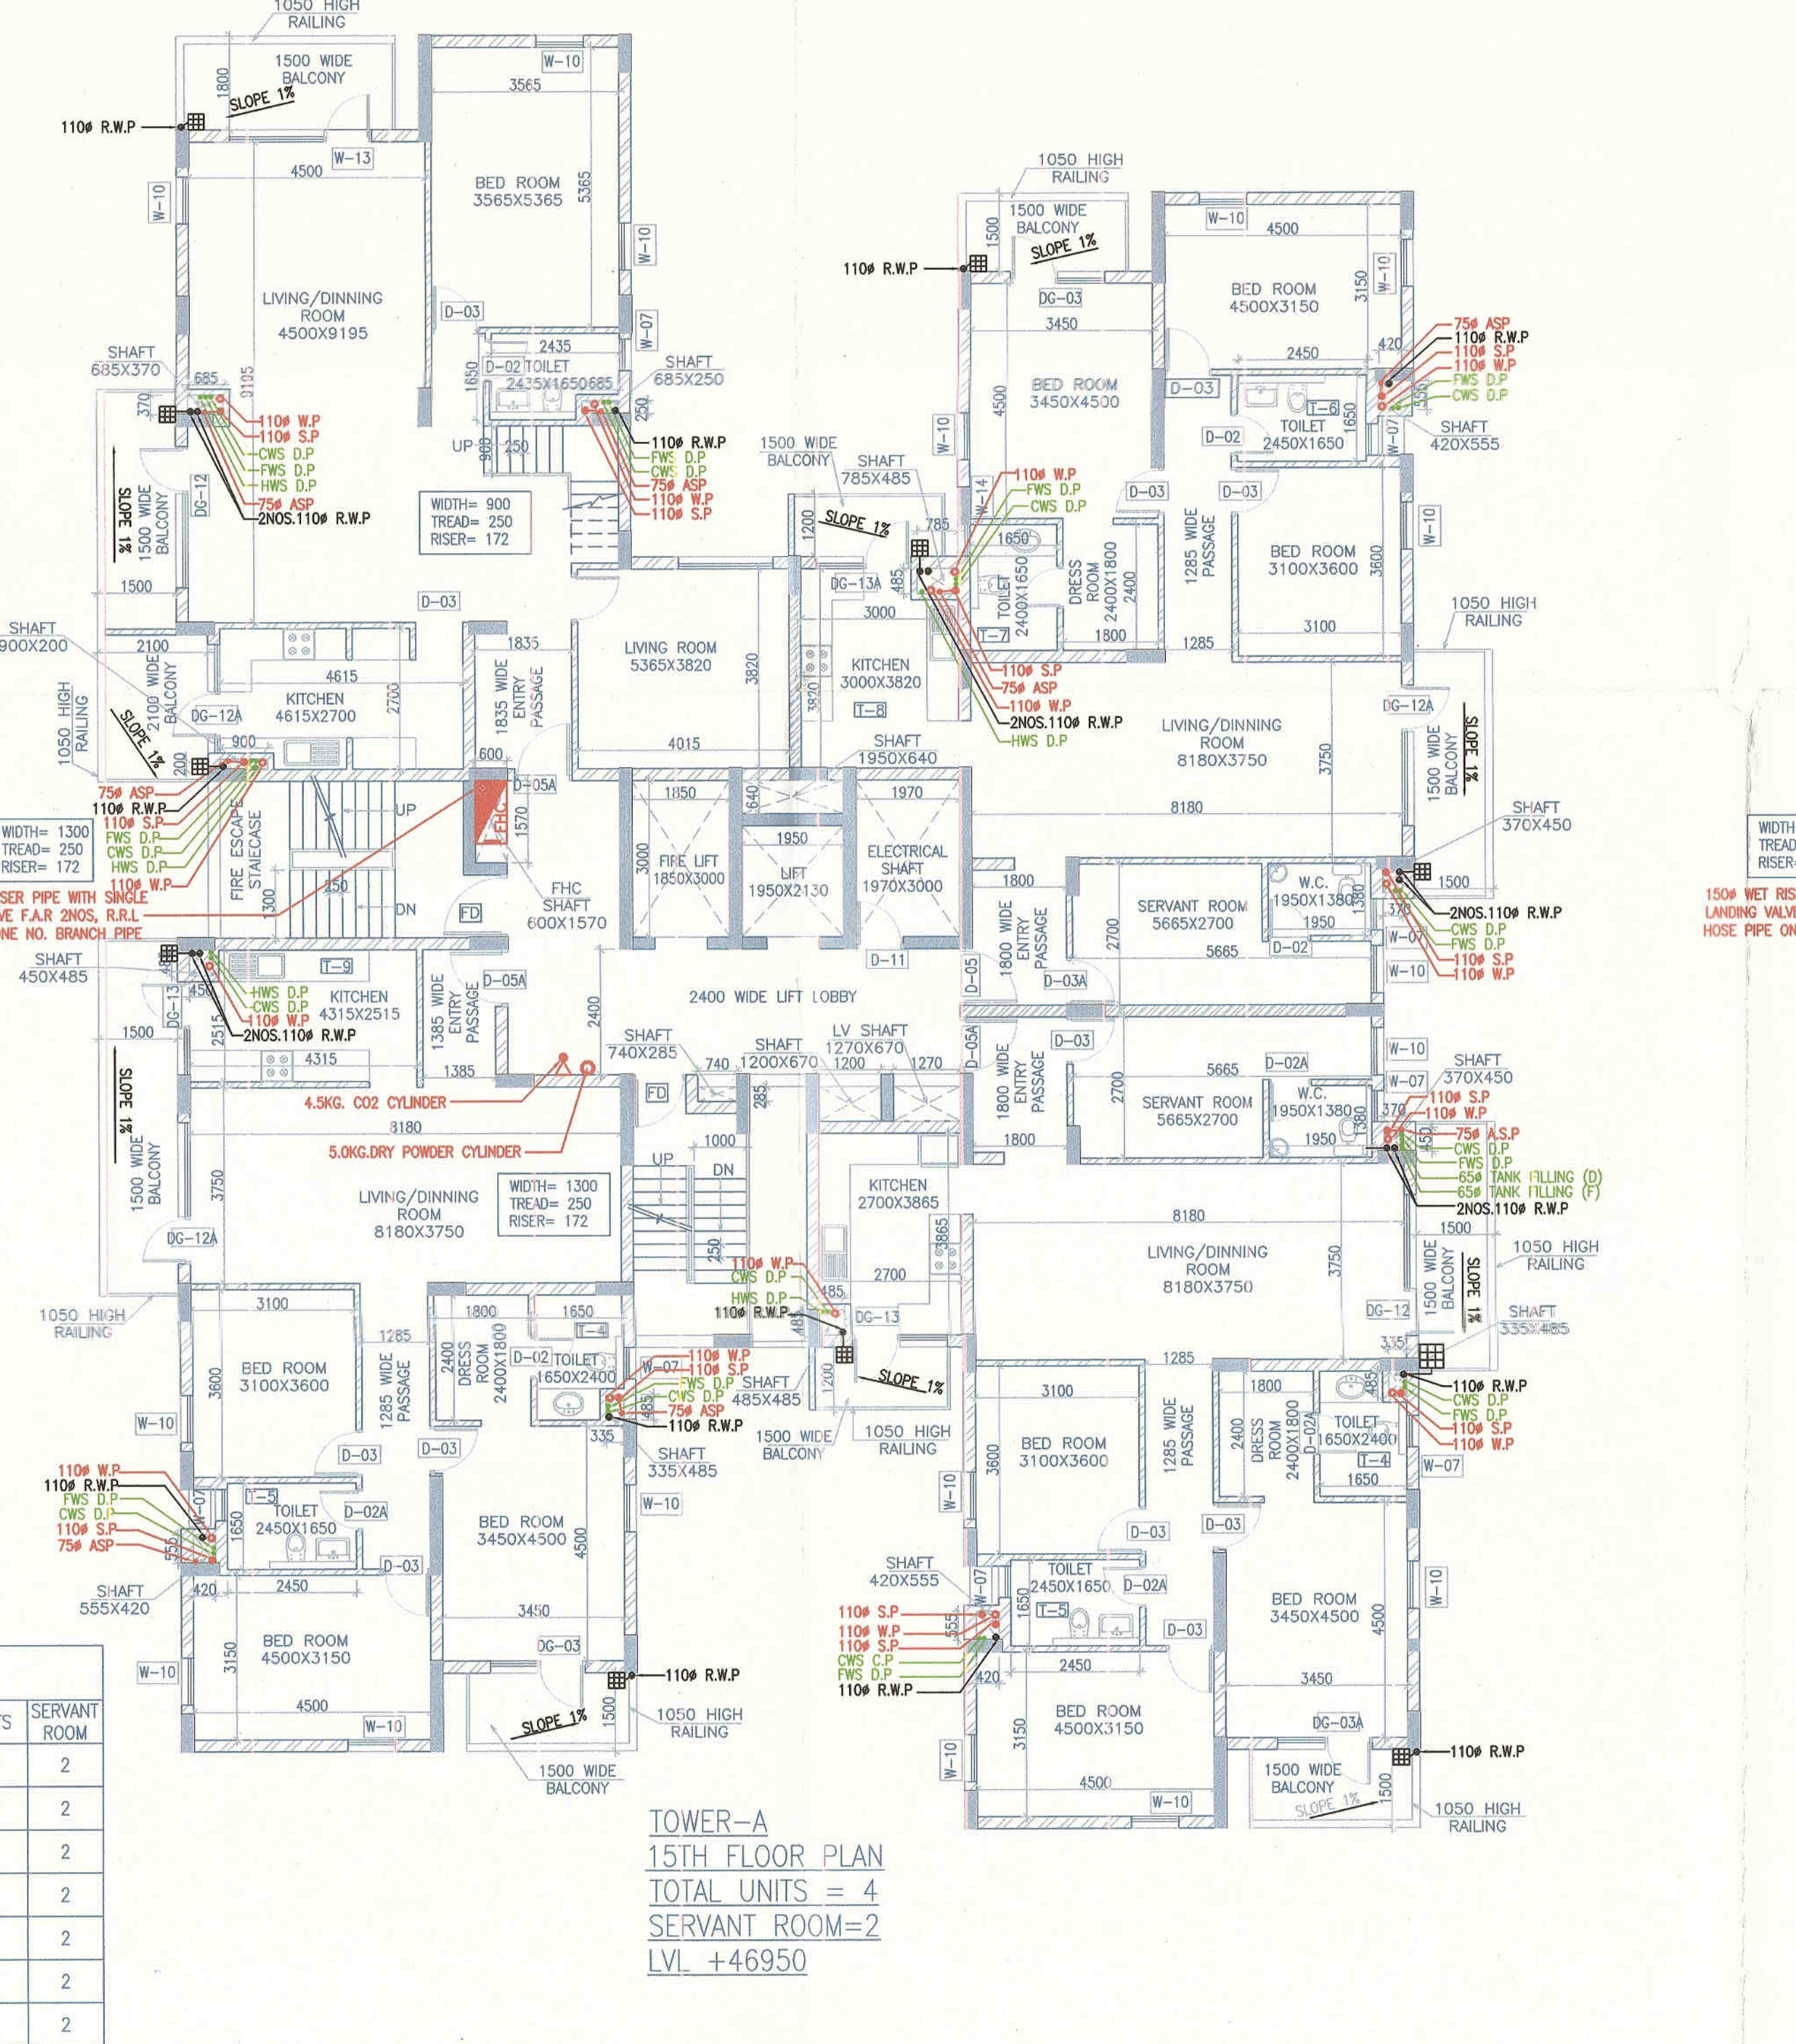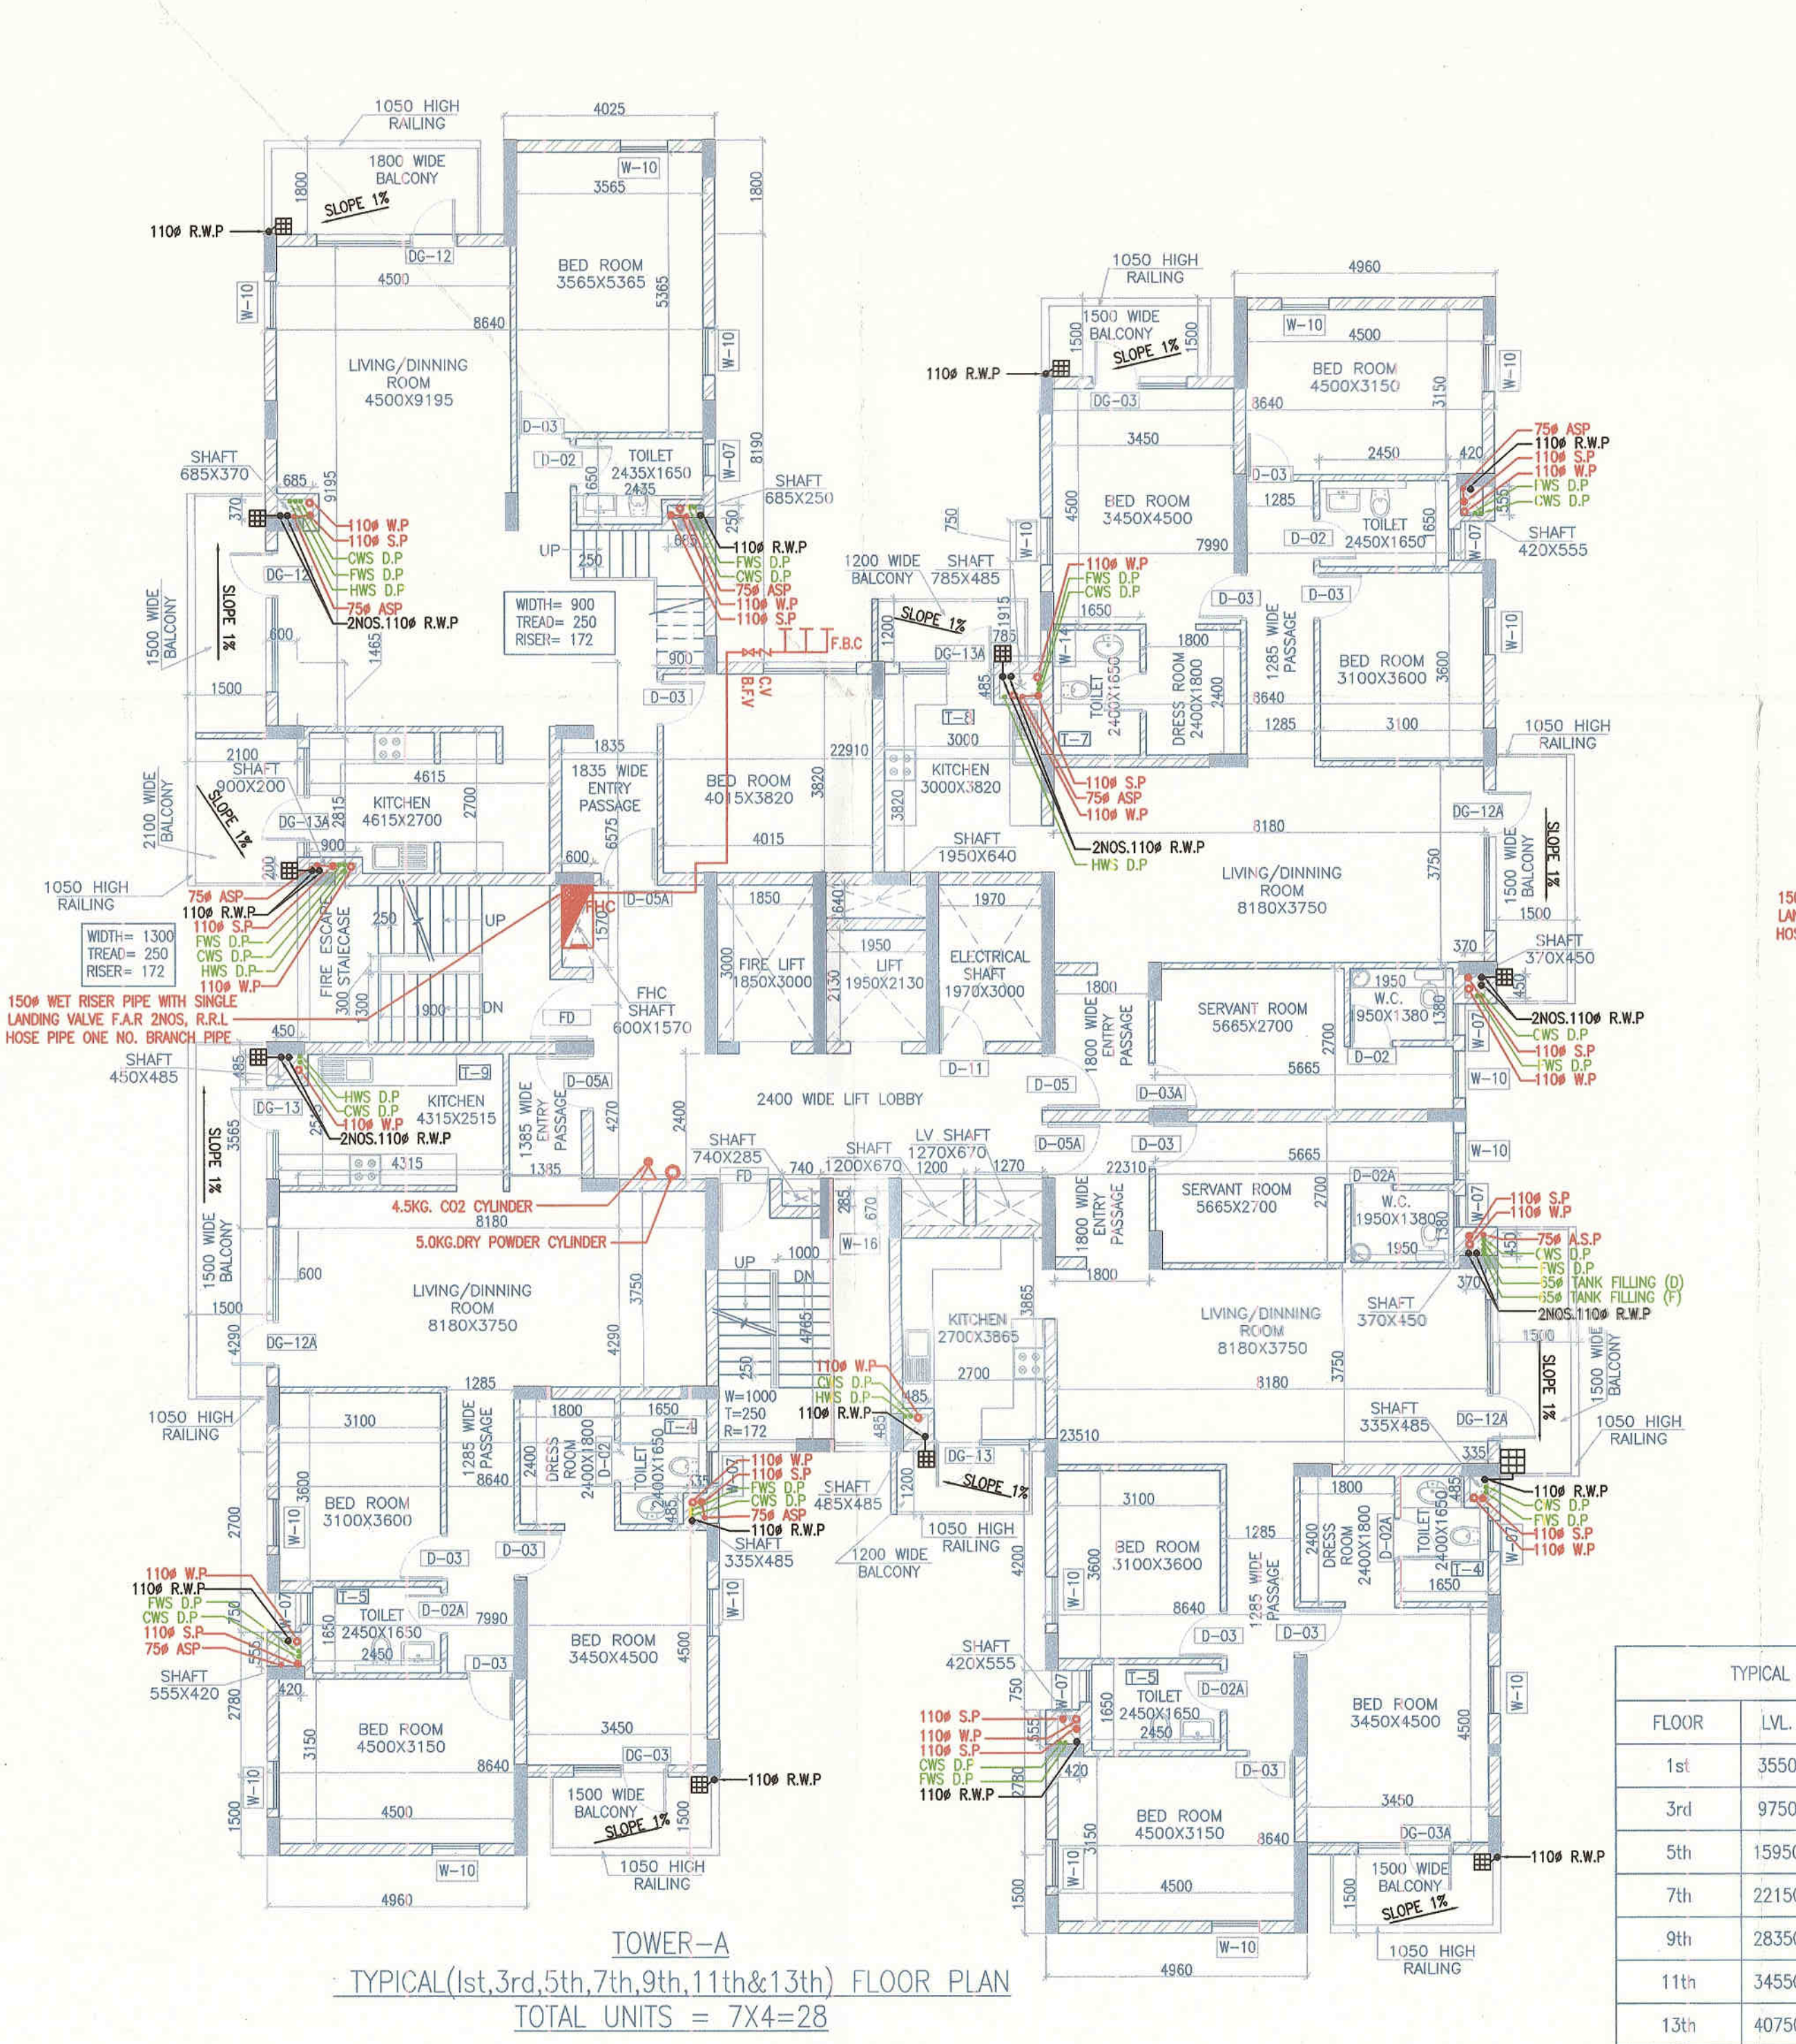

Project:
 PROPOSED GROUP
 HOUSING COLONY ON LAND
 MEASURING-12.83 ACRES (LICENCE NO. 113 OF 2008 DATED 01.06.2008, LICENCE NO. 71 OF 2010 DATED 15.09.2010 AND LICENCE NO. 62 OF 2011 DATED 02.07.2011) IN RESIDENTIAL PLOTTED COLONY, GURGAON MANESAR URBAN COMPLEX BEING DEVELOPED BY M/S VATIKA LTD.



RISMS ARCHITECTS PVT. LTD.
 69, Nora Niwas Bhawanij Kunj
 (Behind D2), Vasant Kunj,
 New Delhi-110070.
 Tel: 011-26898616, 26898617
 www.risms-arch.com

OWNER'S SEAL & SIGNATURE
 [Signature]
 [Stamp]

ARCHITECT'S SEAL & SIGNATURE
 [Signature]
 [Stamp]

SEP.2011 Scale : 1:100
 Drawing Title:-
 GROUND FLOOR, TYPICAL (1st, 3rd, 5th, 7th, 9th, 11th & 13th) FLOOR, TYPICAL (2nd, 4th, 6th, 8th, 10th, 12th & 14th) FLOOR, 15th FLOOR & 16th FLOOR PLAN (TOWER-A)

Drawing No:-
 A-01