


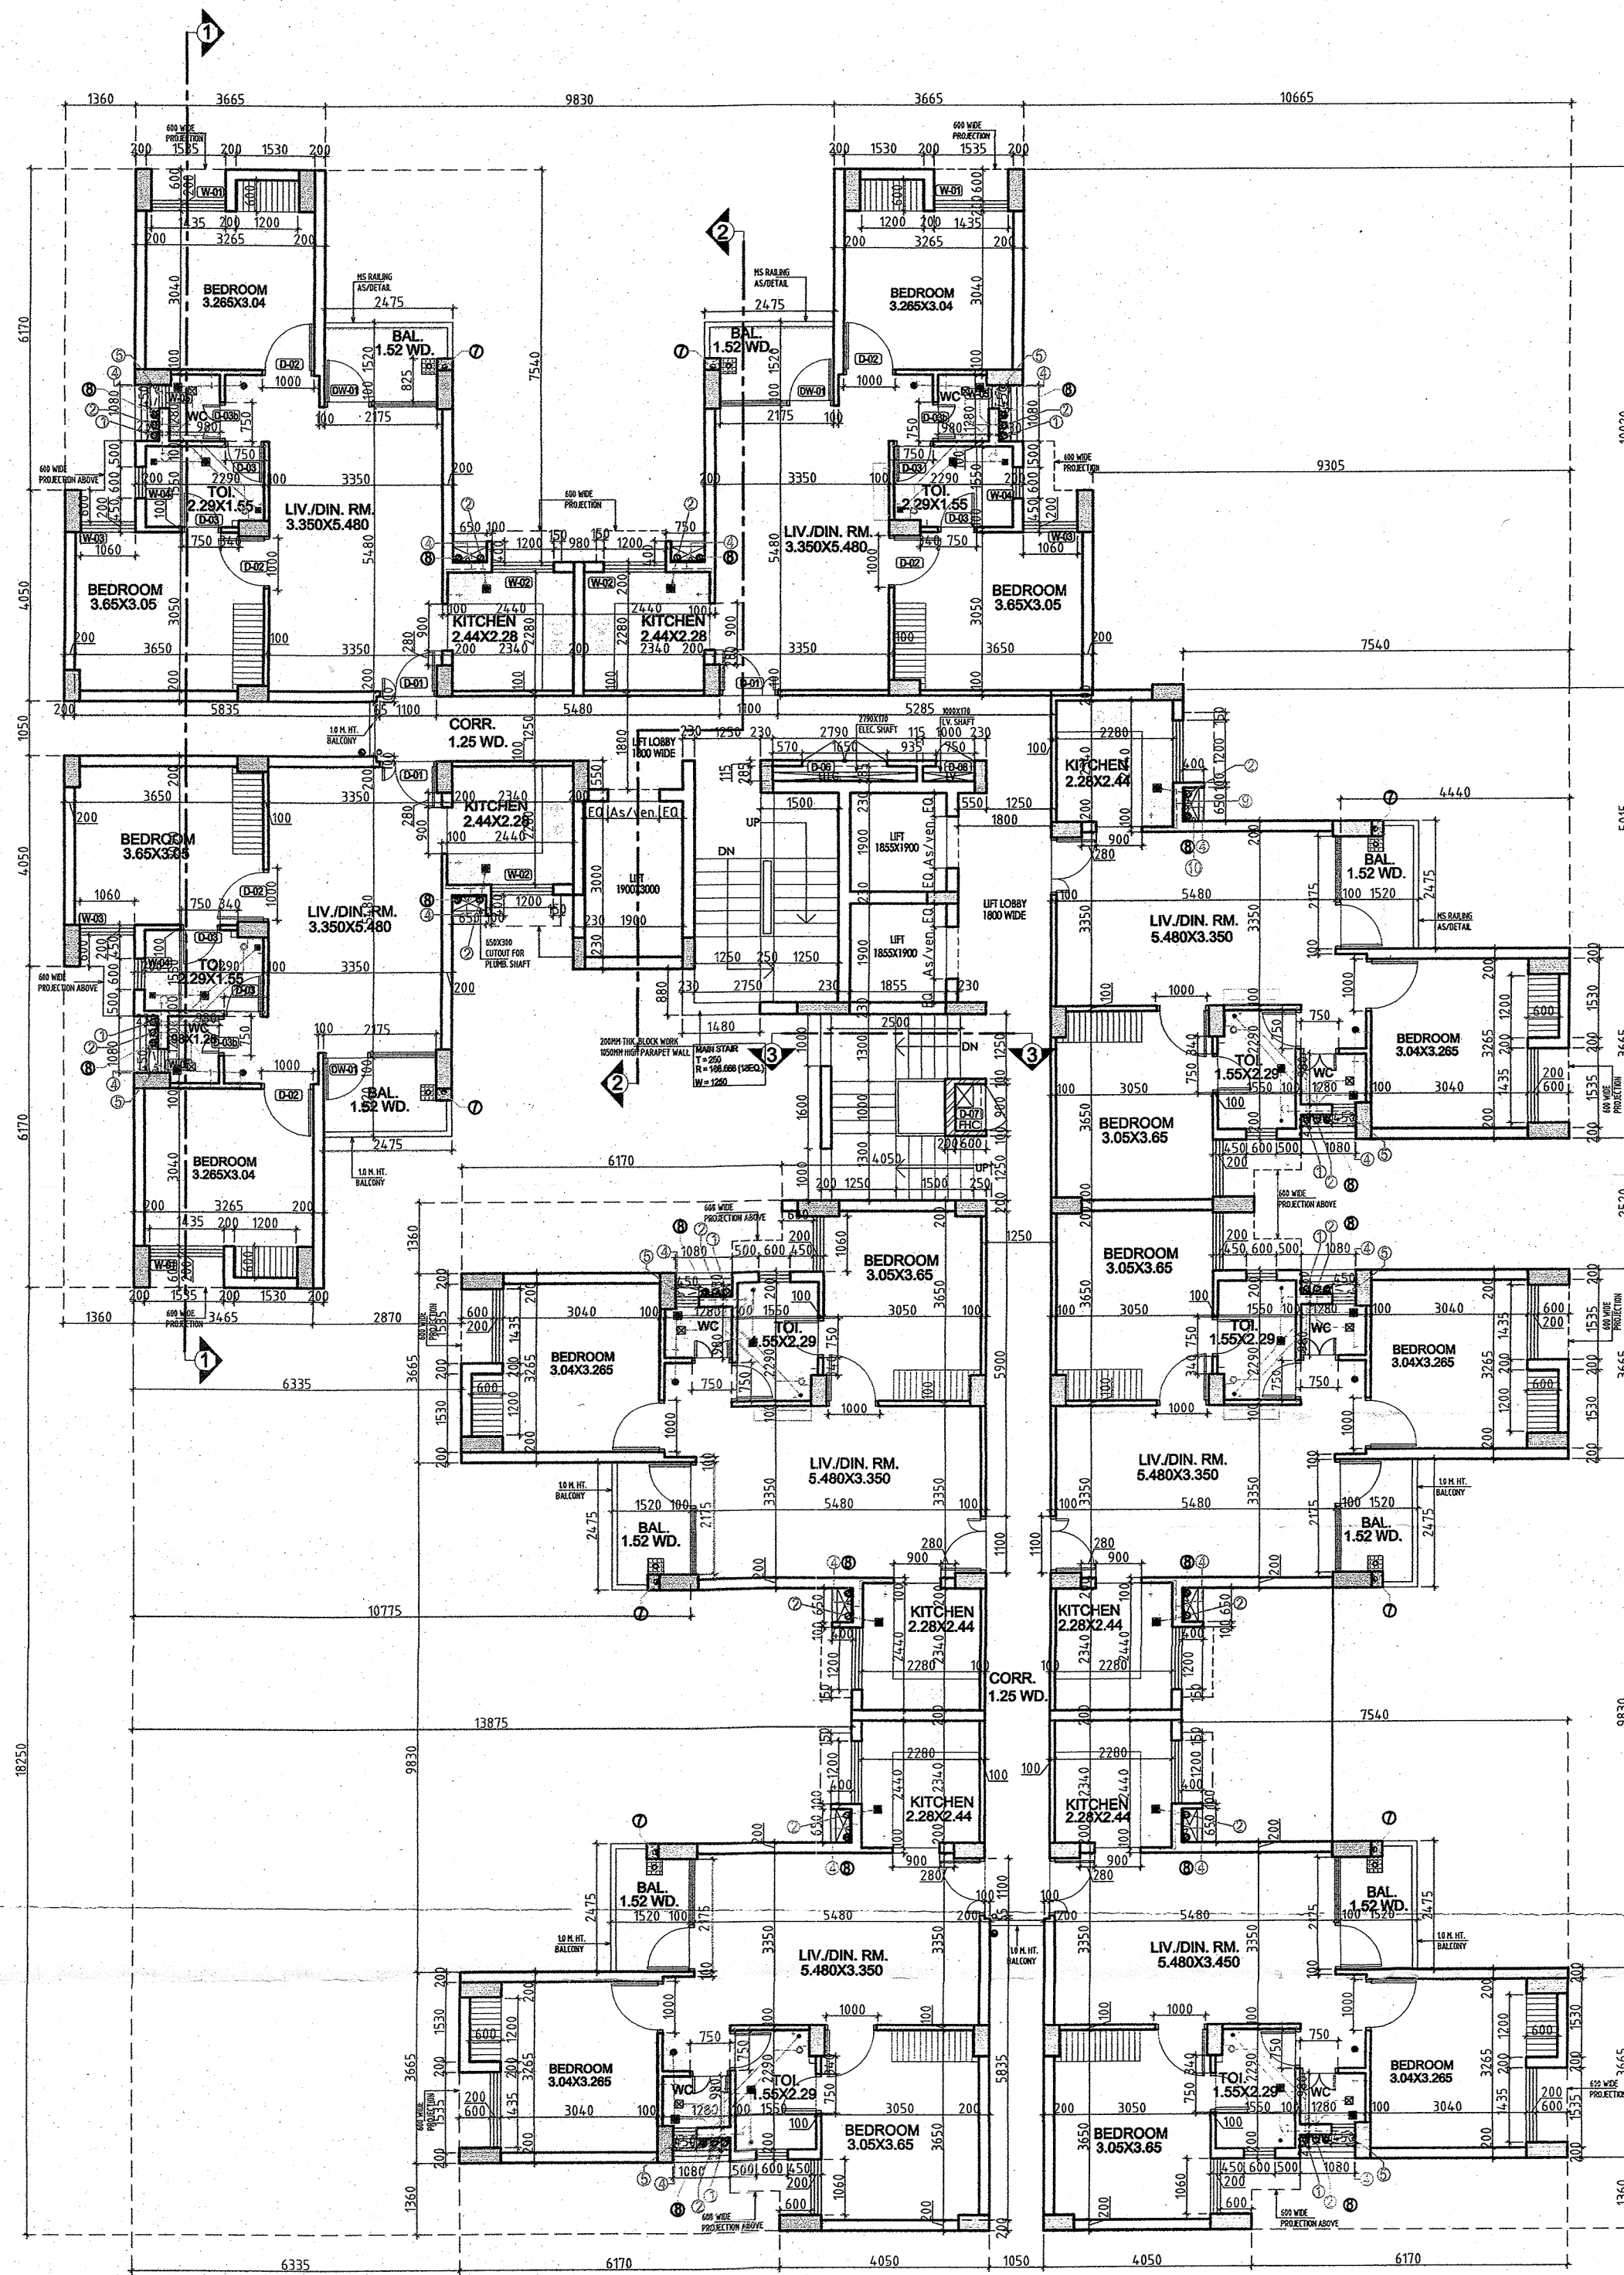

PLUMBING LEGEND:-

① 110Ø SOIL & VENT PIPE
② 110Ø WASTE & VENT PIPE
③ DWS DNTAKE PIPE
④ FWS DNTAKE PIPE
⑤ 75Ø RAIN WATER PIPE FOR BALCONY
⑥ 110Ø RAIN WATER PIPE FOR TERRACE
⑦ FWS RISER PIPE
⑧ DWS RISER PIPE
DWS = DOMESTIC WATER SUPPLY
FWS = FLUSHING WATER SUPPLY
→ FWS PIPE
→ HWS PIPE
→ DWS PIPE
→ WASTE PIPE
→ SOIL PIPE

DOOR/WINDOW SCHEDULE

TYPE	SIZE(C.M.O)	SPACE	SILL LVL	LIN. LVL
D-01	1100X2100	LIVING DINING	-	2100
D-02	1000X2100	BED ROOM	-	2100
D-03	750X2100	TOILET	-	2100
D-03a	900X2100	DRIVER ROOM	-	2100
D-03b	750X2100	W.C. SHAF	-	2100
D-04	1100X2100	ENTRANCE LOBBY	-	2100
D-05	1000X2100	ELEC. & FIRE ROOM	-	2100
D-06	1650X2100	ELEC.SHAFT(BIK-A,B)	-	2100
D-07	1000X2100	FHC.SHAFT (BIK-A,B)	-	2100
D-08	750X2100	LV.SHAFT (BIK-A,B)	-	2100
D-09	900X2100	FHC.SHAFT (BIK-C&D)	-	2100
D-10	1000X2100	ELEC.SHAFT (BIK-C&D)	-	2100
D-11	500X2100	LV.SHAFT (BIK-C&D)	-	2100
DW-01	2175X2400	BALCONY	450	2400
SD-01	1100X2100	TERRACE LOBBY	-	2100
SD-02	1000X2100	MACHINE ROOM	-	2100
W-01	1435X1950	BED ROOM	450	2400
W-02	1200X1600	KITCHEN	950	2400
W-03	1060X1950	BED ROOM	450	2400
W-05	600X1200	TOILET	1200	2400
W-04	450X900	WC	1500	2400
W-08	1435X1500	ENTRANCE LOBBY	900	2400
SW-01	1000X1200	MACHINE ROOM	900	2100



**ARMY WELFARE
HOUSING ORGANISATION**

PROJECT:

**AWHO
UNDER JAI JAWAN YOJNA
IN SECTOR-7
HOUSING COMPLEX
AT BAHADURGARH**

**ARCHITECTS :-
GARG & ASSOCIATES
ARCHITECTS, ENGINEERS, PLANNERS
46, REGAL BUILDING CONN. PLACE
NEW DELHI - 110001.
PHONE :- 011-23742808 , 23742509.**

SHEET TITLE		north
TYP. FL. PLAN (1st to 10th Floor Plan) BLOCK-A & B		
dealt by:-Kuldeep	drg.no	
scale 1:100	06	
date Aug-2017		
Owners Sign.		

(RD Singhal)
Col (Retd)
Project Director
AWHO, Bahadurgarh

Architects Sign.

Garg & Associates
46, Regal Building, Connaught Place,
New Delhi-110001
GAGAN GARG-CA/99/25499
Ph. No. 9811225455

**1st to 10th Floor Plan
(Block-A & B)**