


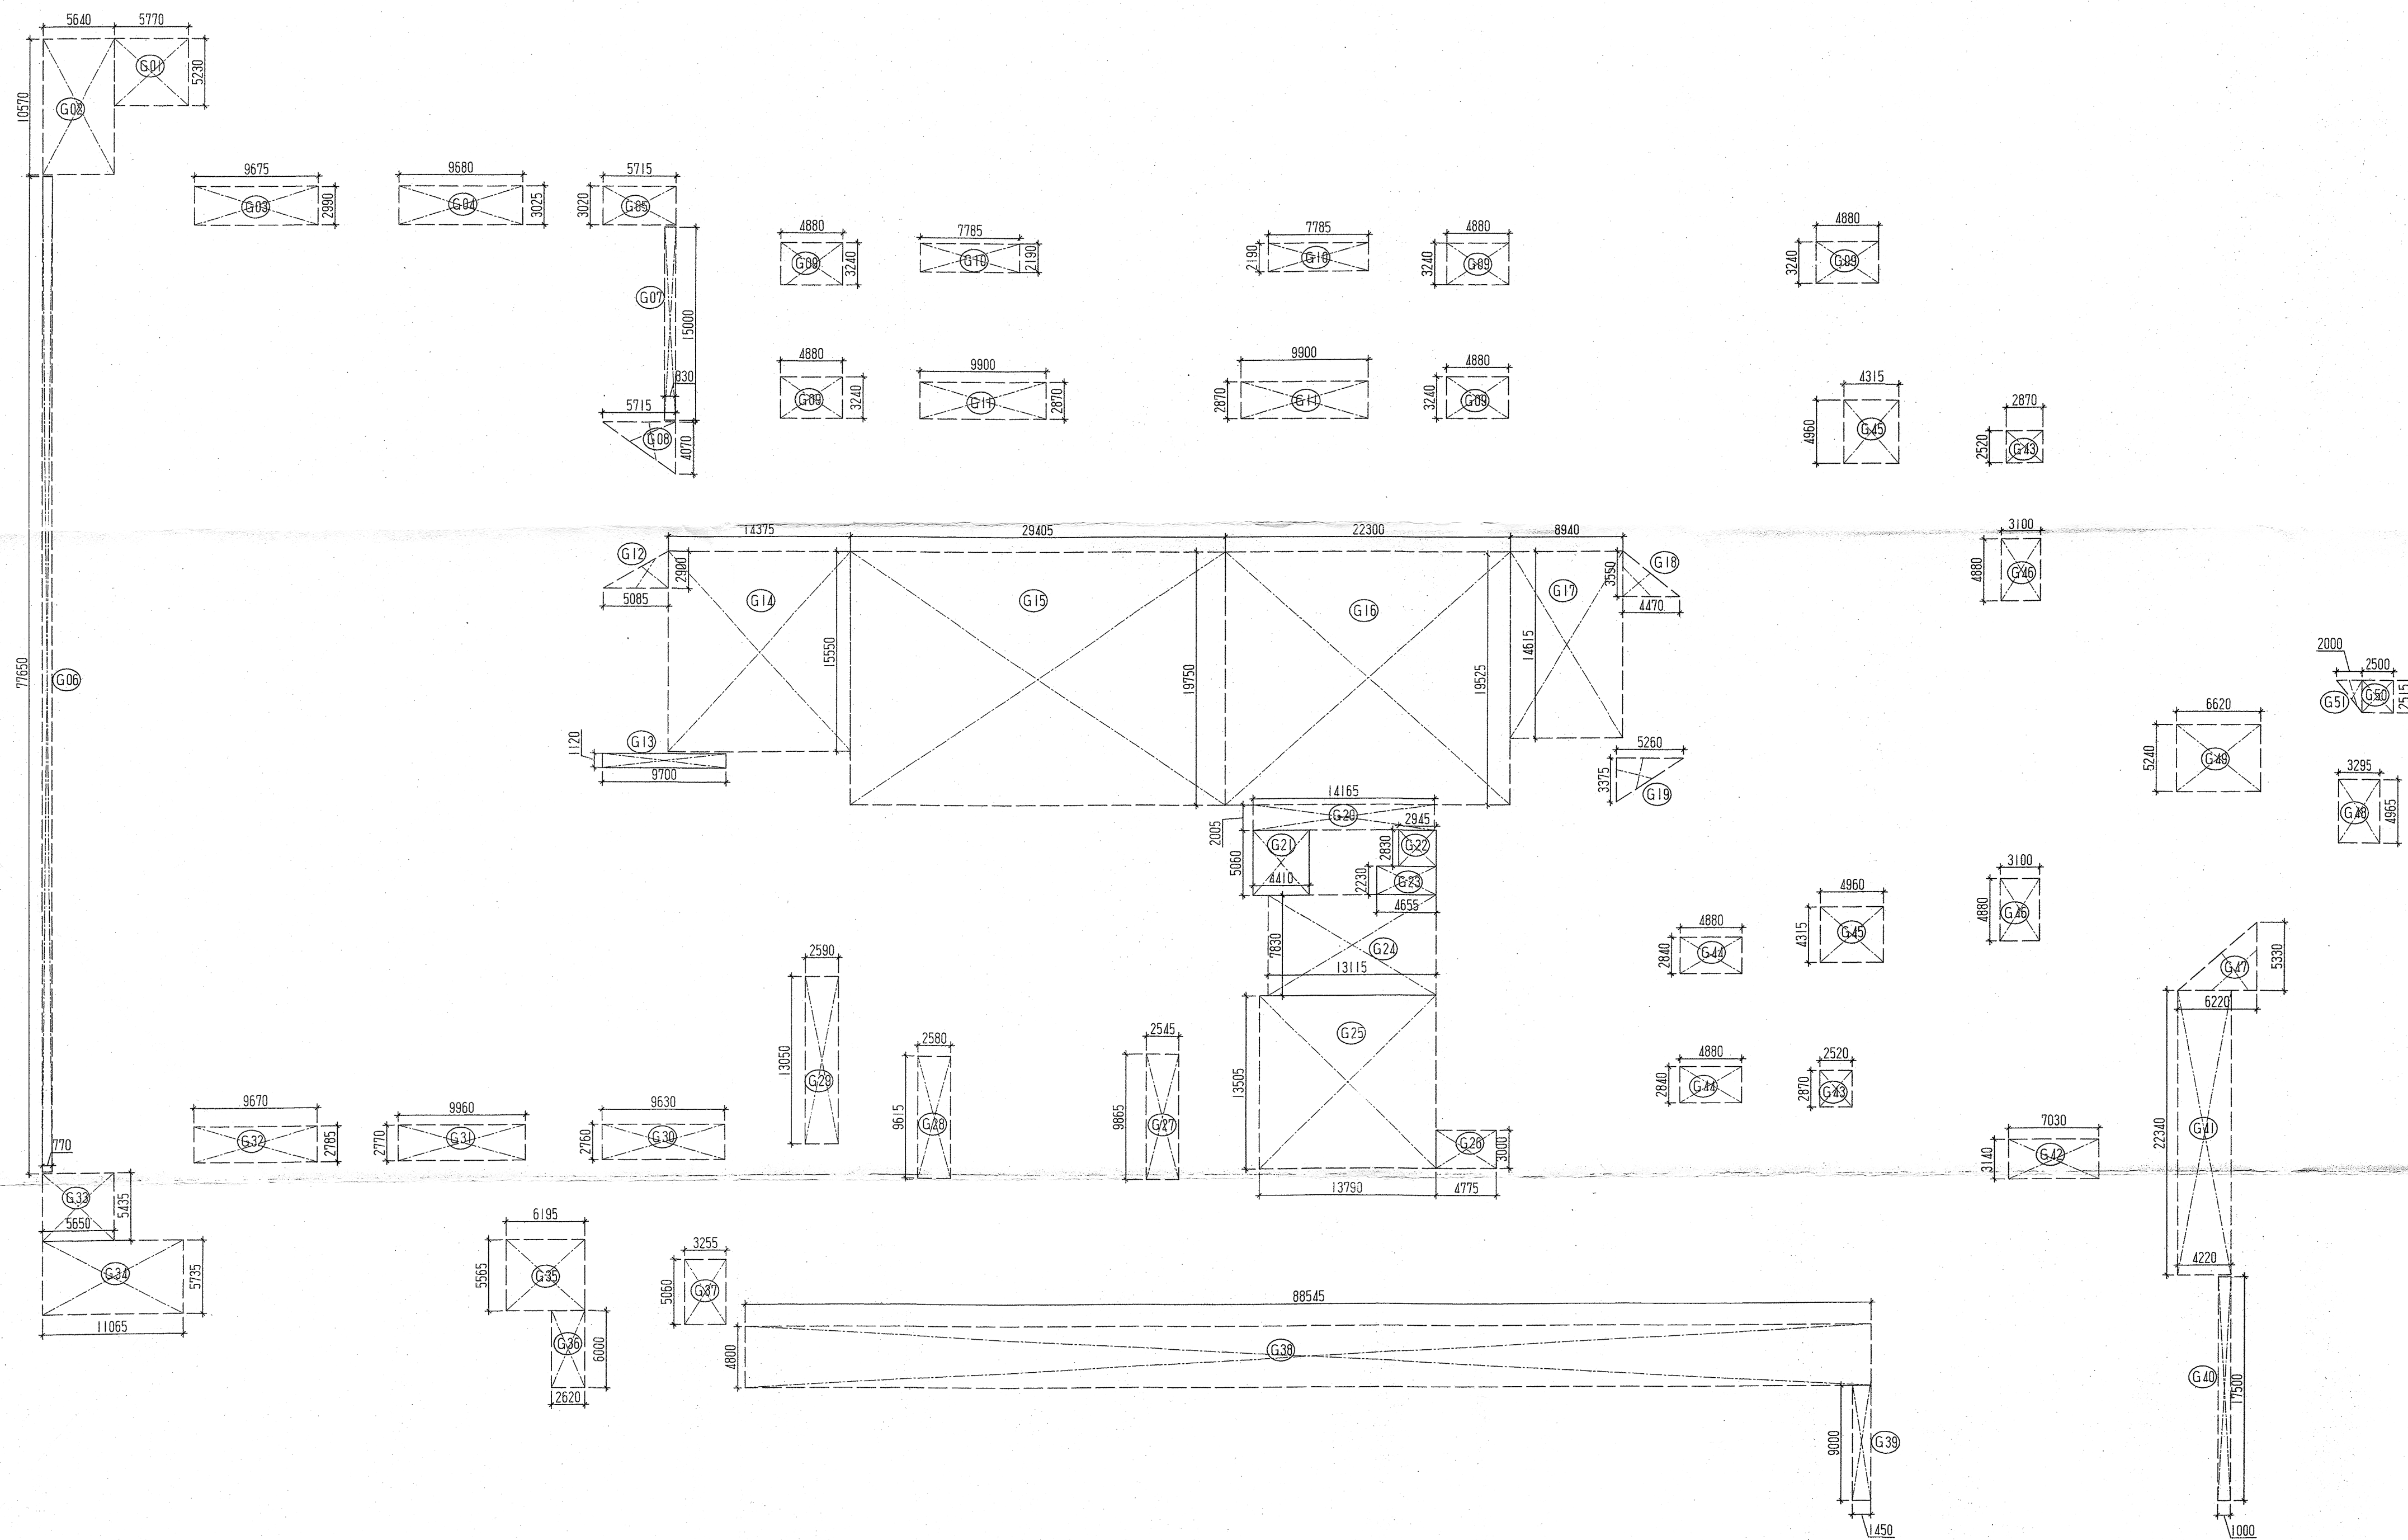

S.NO.	Length	X	Width	NO OF Pocket	AREA
1	5.770	X	5.230	1	30.177 SQM.
2	5.640	X	10.570	1	59.615 SQM.
3	9.675	X	2.990	1	28.928 SQM.
4	9.680	X	3.025	1	29.282 SQM.
5	5.715	X	3.020	1	17.259 SQM.
6	0.770	X	77.650	1	59.791 SQM.
7	0.830	X	15.000	1	12.450 SQM.
8	5.715	X	4.070	1/2	11.630 SQM.
9	4.880	X	3.240	1	79.056 SQM.
10	7.785	X	2.190	1	34.098 SQM.
11	9.900	X	2.870	1	56.826 SQM.
12	5.085	X	2.900	1	7.373 SQM.
13	9.700	X	1.120	1	10.864 SQM.
14	14.375	X	15.550	1	223.531 SQM.
15	29.405	X	19.750	1	580.749 SQM.
16	22.300	X	19.525	1	435.408 SQM.
17	8.940	X	14.615	1	130.658 SQM.
18	4.470	X	3.550	1/2	7.934 SQM.
19	5.260	X	3.375	1/2	8.876 SQM.
20	14.165	X	2.005	1	28.401 SQM.
21	4.410	X	5.060	1	22.315 SQM.
22	2.945	X	2.830	1	8.334 SQM.
23	4.655	X	2.230	1	10.381 SQM.
24	13.115	X	7.830	1	102.690 SQM.
25	13.790	X	13.505	1	186.234 SQM.
26	4.775	X	3.000	1	14.325 SQM.
27	2.545	X	9.865	1	25.106 SQM.
28	2.580	X	9.615	1	24.807 SQM.
29	2.590	X	13.050	1	33.800 SQM.
30	9.630	X	2.760	1	26.579 SQM.
31	9.960	X	2.770	1	27.589 SQM.
32	9.670	X	2.785	1	26.931 SQM.
33	5.650	X	5.435	1	30.708 SQM.
34	11.065	X	5.735	1	63.458 SQM.
35	6.195	X	5.565	1	34.475 SQM.
36	2.620	X	6.000	1	15.720 SQM.
37	3.255	X	5.060	1	16.470 SQM.
38	88.545	X	4.800	1	425.016 SQM.
39	1.450	X	9.000	1	13.050 SQM.
40	1.000	X	17.500	1	17.500 SQM.
41	4.220	X	22.340	1	94.275 SQM.
42	7.030	X	3.140	1	22.074 SQM.
43	2.520	X	2.870	2	14.465 SQM.
44	4.880	X	2.840	2	27.718 SQM.
45	4.960	X	4.315	2	42.805 SQM.
46	3.100	X	4.880	2	30.256 SQM.
47	6.220	X	5.330	1/2	16.576 SQM.
48	3.295	X	4.965	1	16.360 SQM.
49	6.620	X	5.240	1	34.689 SQM.
50	2.500	X	2.515	1	6.288 SQM.
51	2.000	X	2.515	1/2	2.515 SQM.
52	3.000	X	5.500	1	16.500 SQM.
TOTAL					3302.914 SQM.

Notes:
 Structural Stability: The buildings have been designed and will be constructed in accordance with the latest Edition of National Building Code of India & prevailing relevant Codes of Bureau of Indian Standard for Structural Stability of Buildings to sustain impact of Earthquake in Zone IV.
 Rain Water harvesting shall have to be provided as per provision code 8.1(3) of haryana building code 2017
 Provision of roof top solar photo voltaic power plant shall have to be provided as per provision of code 8.2 of haryana building code 2017
 Provision of energy conservation building code shall have to be provided as per provision of code 9.1 of haryana building code 2017
 Provision / Facilities for differently abled person shall have to be provided as per provision of code 9.1 of haryana building code 2017
 A burglar alarm & related gridnets should be installed at suitable place & shown on the building plan clearly

CLIENT:

ARMY WELFARE HOUSING ORGANISATION

PROJECT:

AWHO
UNDER JAI JAWAN YOJNA
IN SECTOR-7
HOUSING COMPLEX
AT BHADURGARH

ARCHITECTS:-

GARG & ASSOCIATES
 ARCHITECTS, ENGINEERS, PLANNERS
 46, REGAL BUILDING CONN. PLACE
 NEW DELHI - 110001
 PHONE :- 011- 23742808 , 23742509 .

SHEET TITLE

GREEN AREA DETAIL

dealt by:-Sanjay

scale 1:300

date Aug-2017

Owners Sign.

Architects Sign.

(RD Singhal)
 Col (Retd)
 Project Director
 AWHO, Bahadurgarh

Architects Sign.

Garg & Associates
 46, Regal Building, Connaught Place,
 New Delhi-110001
 GARG-GARG-CA/99/25499
 Ph. No. 9811225455

