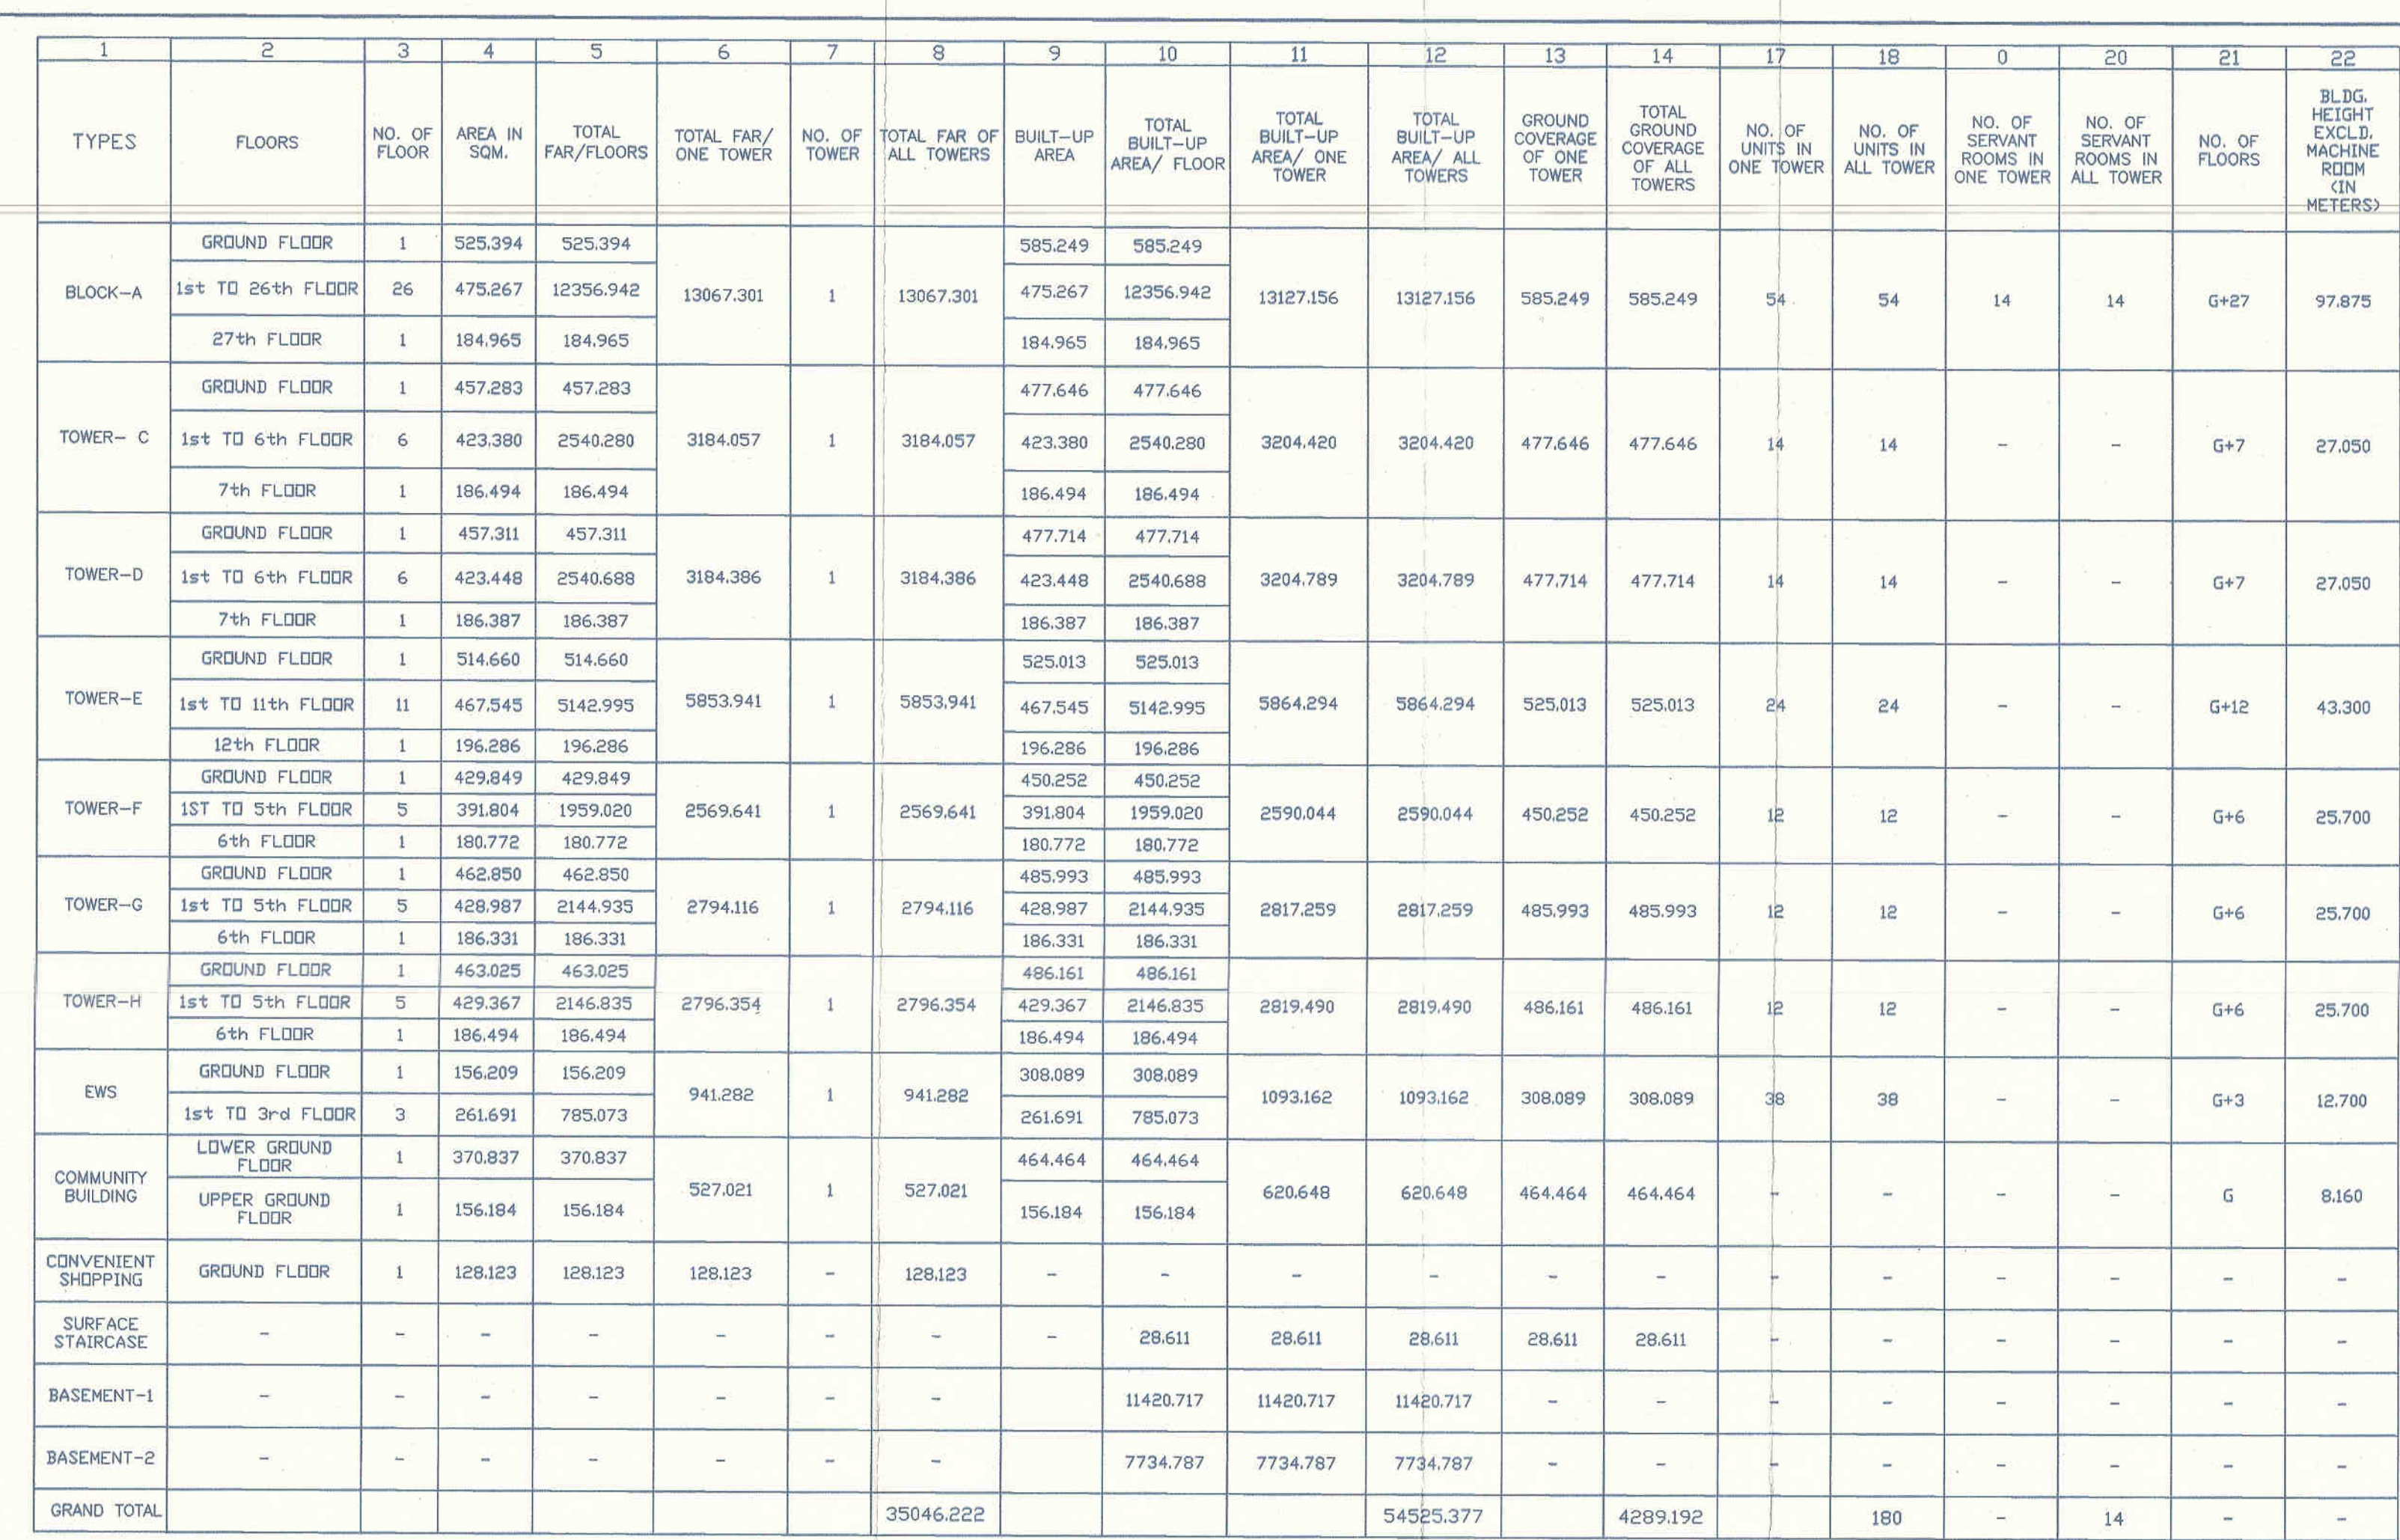


[illegible]

Project:
PROPOSED GROUP HOUSING SCHEME MEASURING
7.50 ACRES FALLING IN THE RESIDENTIAL
PLOTTED COLONY MEASURING 393.538 ACRES
(LICENSE NO. 113 OF 2008 DATED
01.06.2008, LICENSE NO. 71 OF 2010 DATED
15.09.2010 & LICENSE NO.62 OF 2011 DATED
05.07.2011) IN SECTOR-81,82,82-A,83 & 85,
GURGAON MANASAR URBAN COMPLEX BEING
DEVELOPED BY VATIKA LTD. AND OTHERS

RSMS
ARCHITECTS

RSMS ARCHITECTS PVT. LTD
69, Nora Niwas Bhawani Kunj
(Behind D2), Vasant Kunj,
New Delhi-110070.
Tel.: 011-26898616, 26898617
www.rsms-arch.com

id ok for Public Health
only subject to comments in
No. 123, Dt. 2-14-13

ARCHITECT'S SEAL & SIGNATURE		OWNER'S SEAL & SIGNATURE	
		For M/S VATIKA LIMITED  Authorized Signatory	
JAN 2013.	Scale :1:300		
Drawing Title:- SITE PLAN (FIRE & WATER SUPPLY SCHEME)		Drawing No:- ST-01	