

Note:-

- 1. BUILDING WILL BE DESIGNED (STRUCTURES) AS PER RELEVANT IS CODES FOR EARTH QUAKE RESISTANCE.
- 2. BUILDING IS HAS AUTOMATIC SPRINKLER SYSTEM ON ALL FLOORS.

LEGEND:-

| S.NO. | DESCRIPTION                              | LEGEND |
|-------|------------------------------------------|--------|
| 1.    | 1500 SOIL & VENT PIPE                    | ①      |
| 2.    | 1000 WASTE & VENT PIPE                   | ②      |
| 3.    | 750 ANTI SYPHONAGE VENT PIPE             | ③      |
| 4.    | 1000 RAIN WATER PIPE                     | ④      |
| 5.    | 1500 RAIN WATER PIPE                     | ⑤      |
| 6.    | FLUSHING WATER SUPPLY (G+10H/FLOOR)      | ⑥      |
| 7.    | FLUSHING WATER SUPPLY (11H+22nd FLOOR)   | ⑦      |
| 8.    | FLUSHING WATER SUPPLY (ABOVE 22nd FLOOR) | ⑧      |

| S.NO. | DESCRIPTION                              | LEGEND |
|-------|------------------------------------------|--------|
| 9.    | DOMESTIC WATER SUPPLY (G+10H/FLOOR)      | ⑨      |
| 10.   | DOMESTIC WATER SUPPLY (11H+22nd FLOOR)   | ⑩      |
| 11.   | DOMESTIC WATER SUPPLY (ABOVE 22nd FLOOR) | ⑪      |
| 12.   | HOT WATER SUPPLY (G+10H/FLOOR)           | ⑫      |
| 13.   | HOT WATER SUPPLY (11H+22nd FLOOR)        | ⑬      |
| 14.   | HOT WATER SUPPLY (ABOVE 22nd FLOOR)      | ⑭      |
| 15.   | FLUSHING WATER SUPPLY TO O.H.T.          | ⑮      |
| 16.   | DOMESTIC WATER SUPPLY TO O.H.T.          | ⑯      |

| S.NO. | DESCRIPTION            | LEGEND |
|-------|------------------------|--------|
| 17.   | 110 OD UPVC SOIL PIPE  | ⑰      |
| 18.   | 40 OD UPVC WASTE PIPE  | ⑱      |
| 19.   | 90 OD UPVC WASTE PIPE  | ⑲      |
| 20.   | 110 OD UPVC WASTE PIPE | ⑳      |
| 21.   | FIRE HOSE CABINET      | FHC    |

Project:  
PROPOSED GROUP HOUSING SCHEME MEASURING 7.50 ACRES FALLING IN THE RESIDENTIAL PLOTTED COLONY MEASURING 393.538 ACRES (LICENSE NO. 113 OF 2008 DATED 01.06.2008) LICENSE NO. 71 OF 2010 DATED 15.09.2010 & LICENSE NO.62 OF 2011 DATED 05.07.2011) IN SECTOR-81.82.82-A83 & 85, GURGAON MANESAR URBAN COMPLEX BEING DEVELOPED BY VATIKA LTD. AND OTHERS  
Associate Architects

RISIMIS

ARCHITECTS

RSMS ARCHITECTS PVT. LTD.

69, Nara Niwas Bhawanij Kunj  
(Behind D2), Vasant Kunj,  
New Delhi-110070.  
Tel:-011-26898616, 26898617  
www.rsisms-arch.com

Checked and Found ok for Public Health  
Dr. Anand K. Singh  
Public Health Engineer  
18.5.13, 18.5.13  
18.5.13

LP  
DTP/MS  
B.P.C.

Tejash  
Chakraborty  
B.P.C.

MS  
B.P.C.

MS  
B.P.C.

MS  
B.P.C.

MS  
B.P.C.

OWNER'S SEAL & SIGNATURE

For MS VATIKA LIMITED  
Authorized Signatory

ARCHITECT'S SEAL & SIGNATURE

ARCHITECT'S SEAL & SIGNATURE


JAN 2013.

Scale : 1:200

Drawing Title:-  
BASEMENT-2 FLOOR PLAN

Drawing No:-  
BA-02

MSD SW/0001

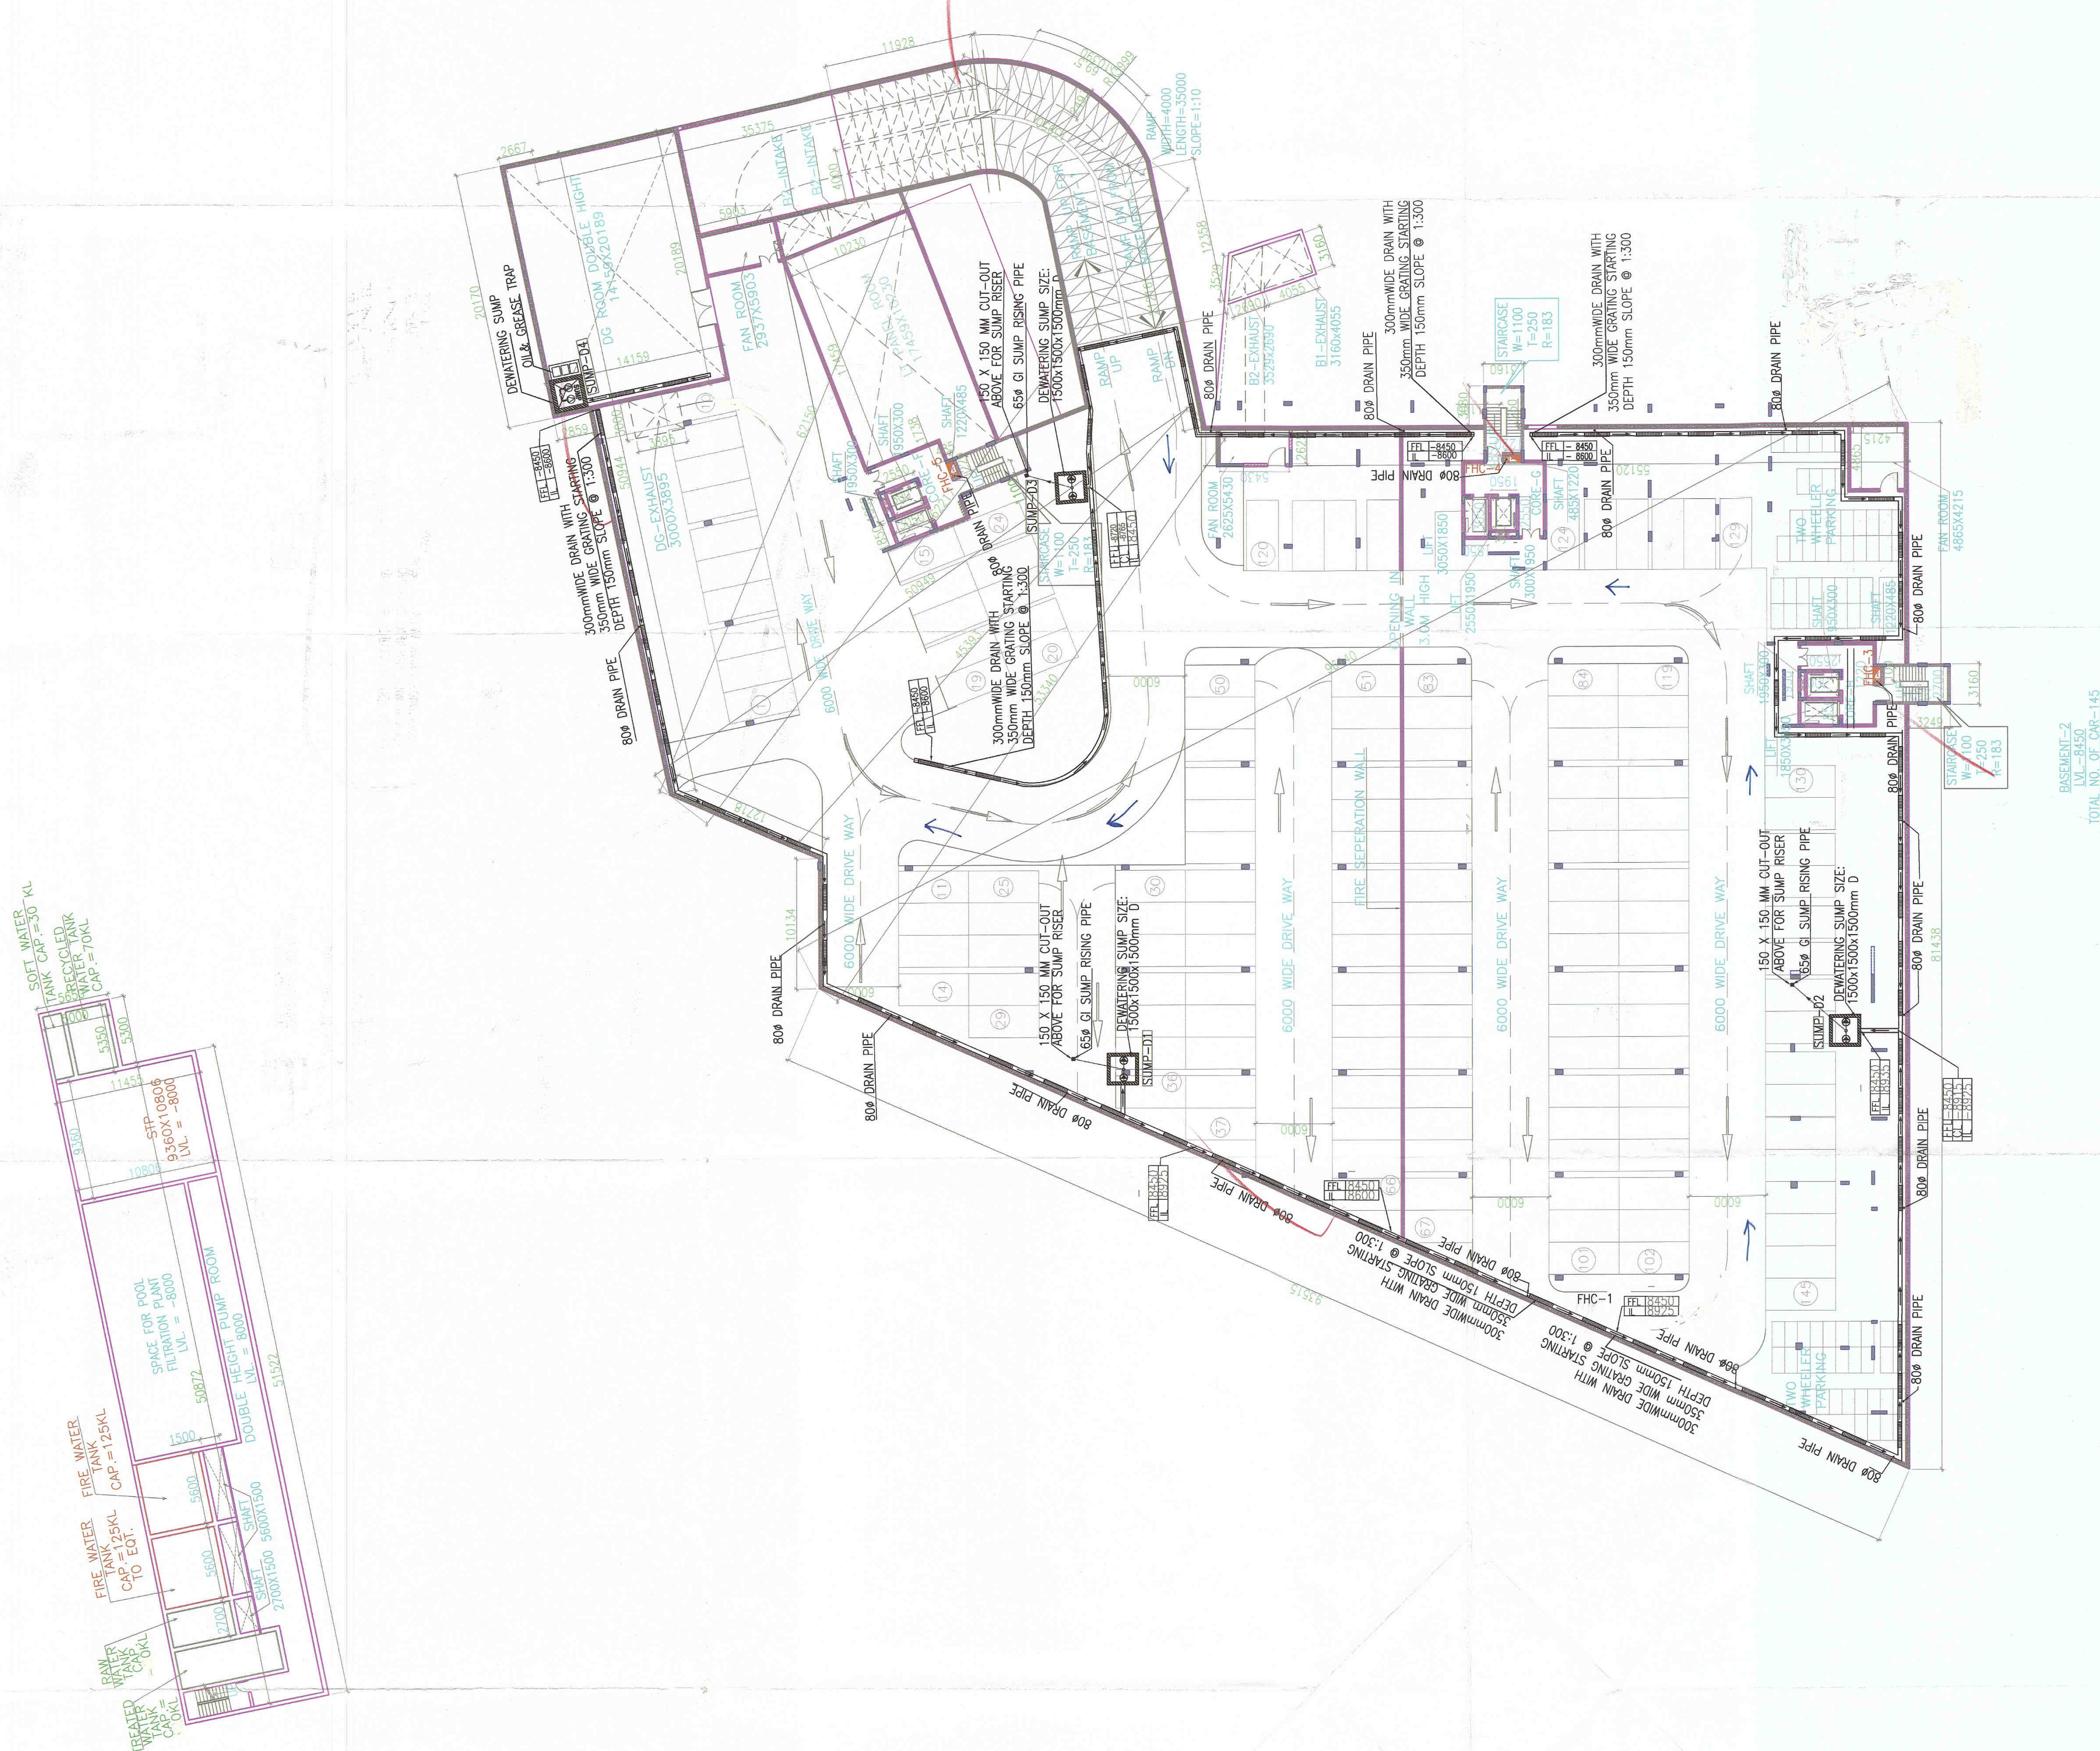

BASEMENT-2  
LVL = -8.500  
TOTAL NO. OF CHN = 145