

Note :-

1. BUILDING WILL BE DESIGNED (STRUCTURES) AS PER RELEVANT IS CODES FOR EARTH QUAKE RESISTANCE.
2. BUILDING IS HAS AUTOMATIC SPRINKLER SYSTEM ON ALL FLOORS.

LEGEND :-

Project:

PROPOSED GROUP HOUSING SCHEME MEASURING 7.50 ACRES FALLING IN THE RESIDENTIAL PLOTTED COLONY MEASURING 393.538 ACRES (LICENCE NO. 113 OF 2008 DATED 01.06.2008, LICENSE NO. 71 OF 2010 DATED 15.09.2010 & LICENSE NO.62 OF 2011 DATED 05.07.2011) IN SECTOR-81,82,82-A&B & 85, CURGAON MANESAR URBAN COMPLEX BEING DEVELOPED BY VATIKA LTD. AND OTHERS

Associate Architects

RISIMS
ARCHITECTS

RSMS ARCHITECTS PVT. LTD.
69,Nora Niwas Bhawani Kunj
(Behind D2), Vasant Kunj,
New Delhi-110070.
Tel.:011-26898616,26898617
www.rsms-arch.com

Checked and signed off for Public Work
As per Services only subject to company's
writing letter No. 18303/183

[Signature]
183

[Signatures]
D.T.P. (D) Member Secretary B.P.C. A1
S.T.P. (D) Member Secretary B.P.C. A1
For M/S VATIKA LIMITED
Authorized Signatory

ARCHITECT'S SEAL & SIGNATURE



OWNER'S SEAL & SIGNATURE

For M/S VATIKA LIMITED
Authorized Signatory

JAN 2013.

Scale : 1:300

Drawing Title:-

SITE PLAN
IRRIGATION SUPPLY

Drawing No:-

ST-02

VATIKA


24 MTR SECTOR ROAD

12.0 MTR SERVICE ROAD

60 MTR SECTOR ROAD

12.0 MTR SERVICE ROAD

24 MTR SECTOR ROAD

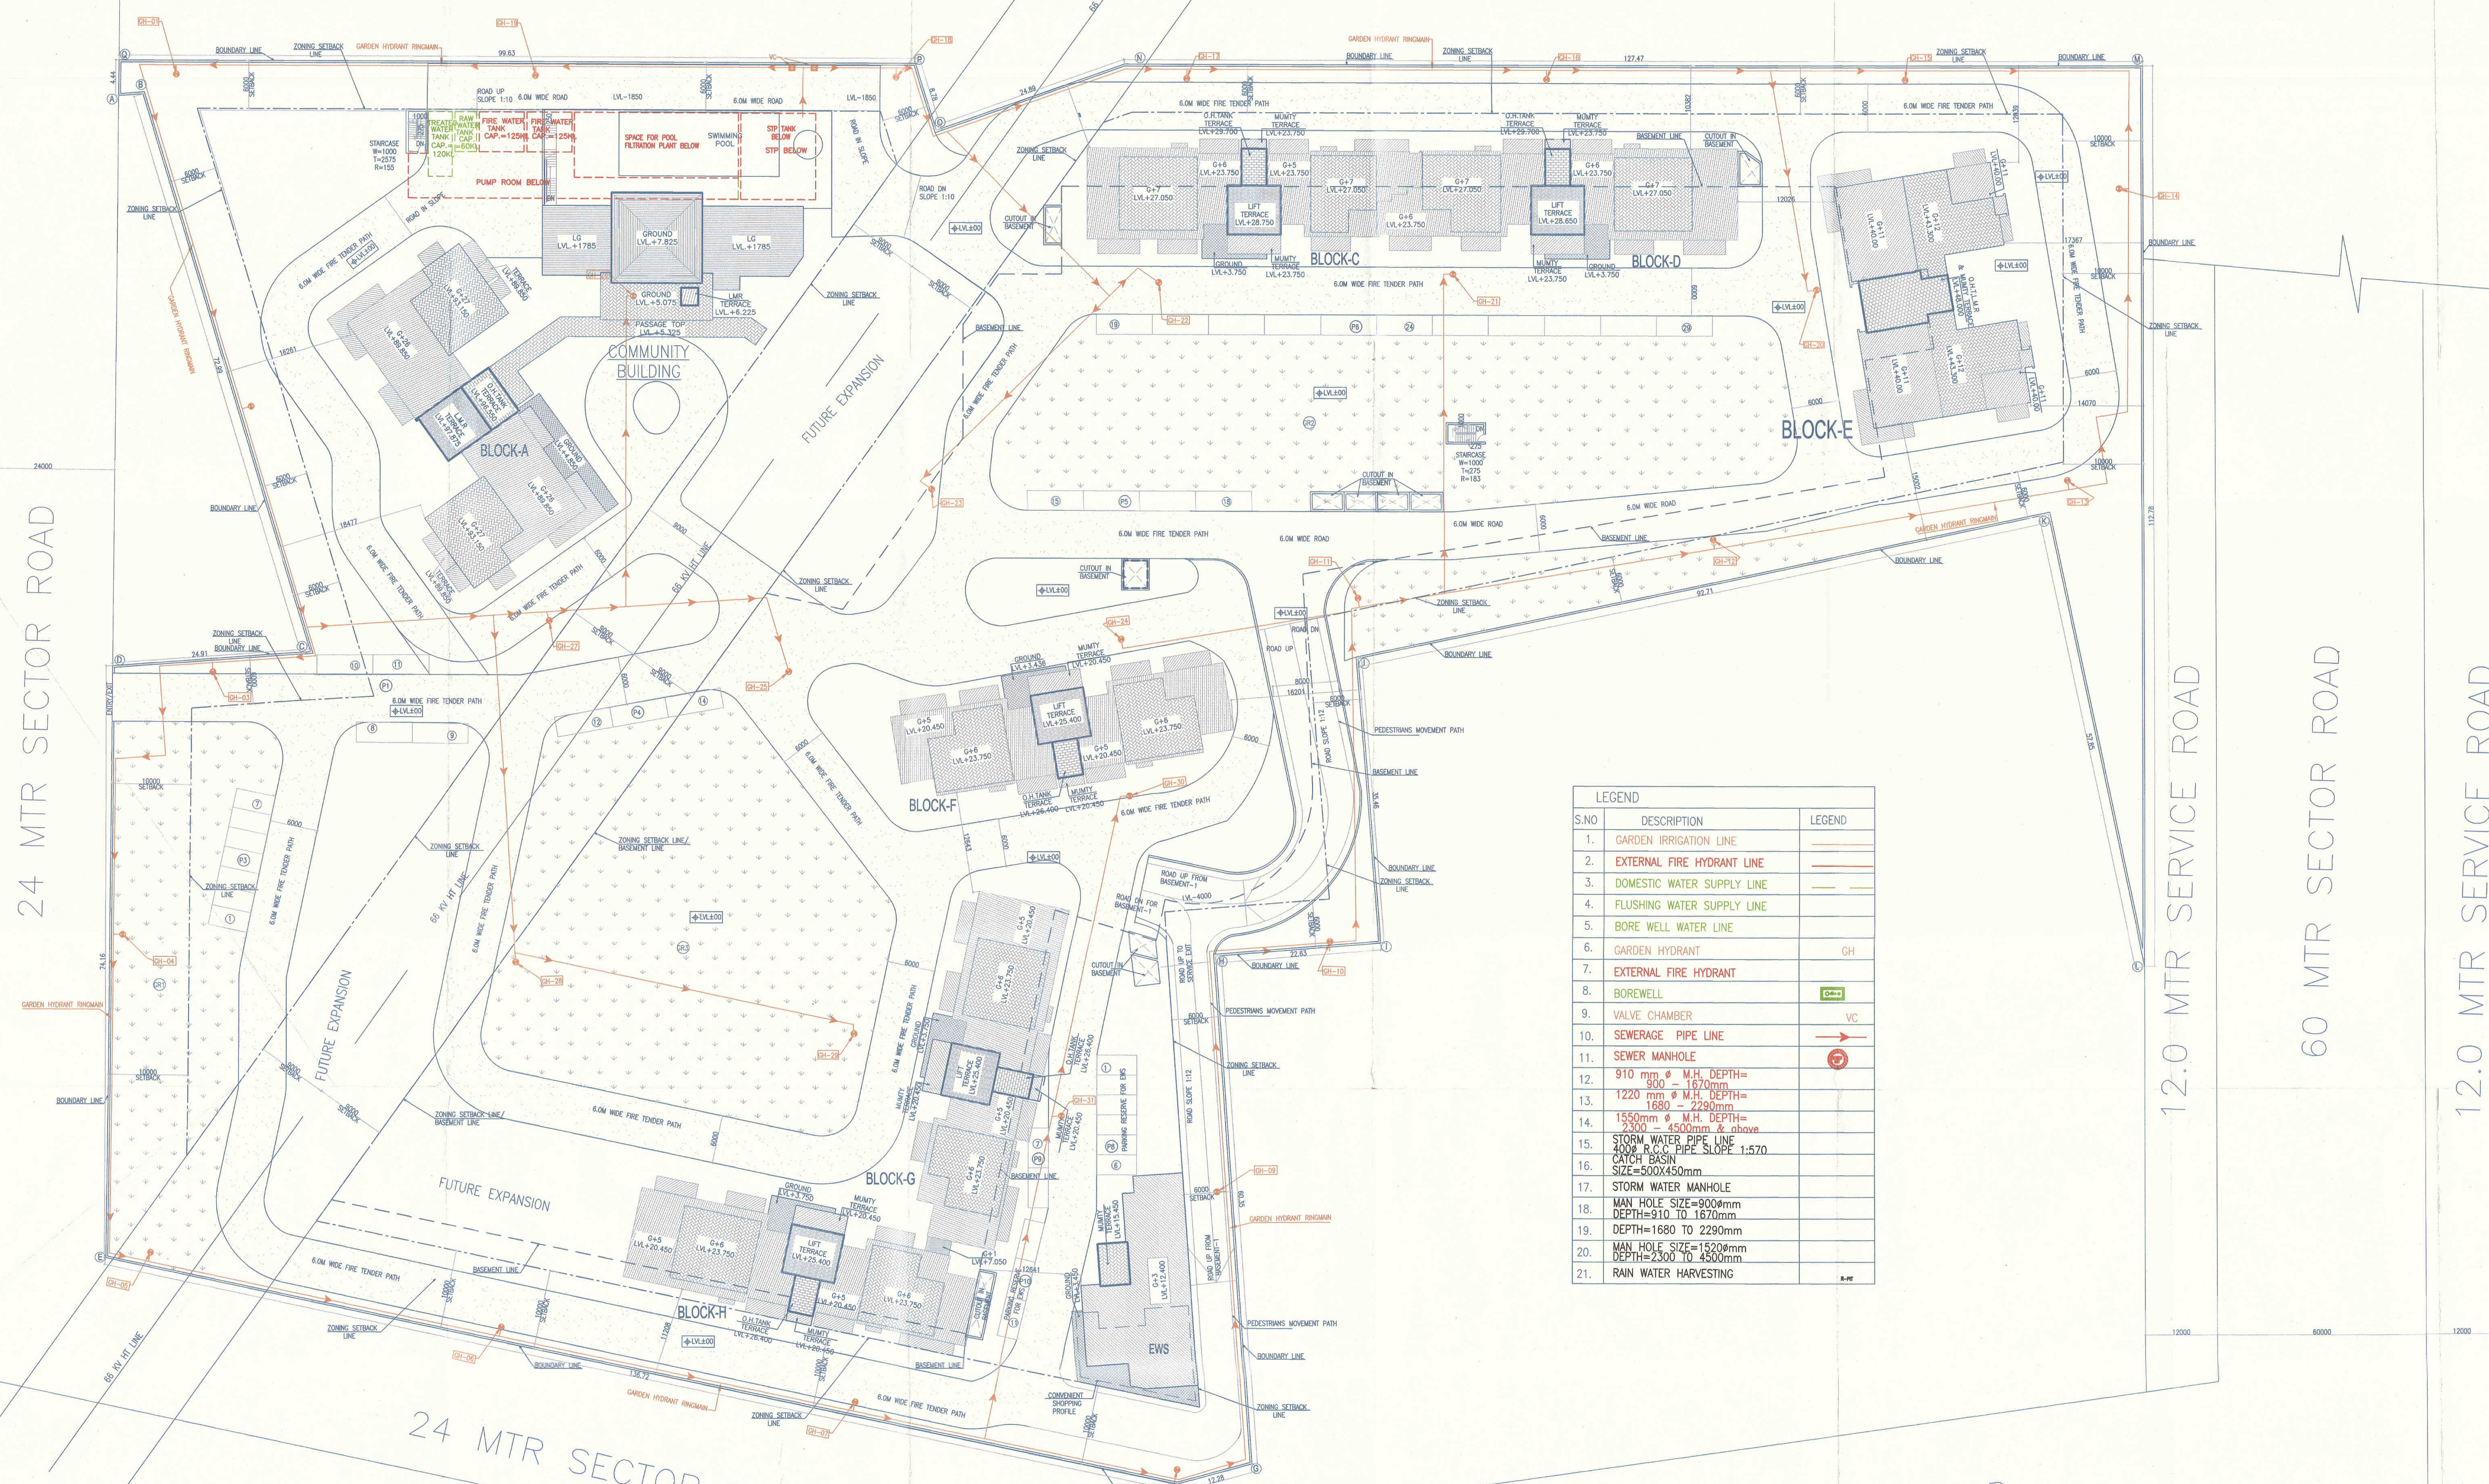

S.NO	DESCRIPTION	LEGEND
1.	GARDEN IRRIGATION LINE	---
2.	EXTERNAL FIRE HYDRANT LINE	---
3.	DOMESTIC WATER SUPPLY LINE	---
4.	FLUSHING WATER SUPPLY LINE	---
5.	BORE WELL WATER LINE	---
6.	GARDEN HYDRANT	GH
7.	EXTERNAL FIRE HYDRANT	---
8.	BOREWELL	GW
9.	VALVE CHAMBER	VC
10.	SEWERAGE PIPE LINE	---
11.	SEWER MANHOLE	SM
12.	910 mm Ø M.H. DEPTH= 800 - 1670mm	---
13.	1220 mm Ø M.H. DEPTH= 1680 - 2290mm	---
14.	1550mm Ø M.H. DEPTH= 2300 - 4500mm & above	---
15.	STORM WATER PIPE LINE 400R R.C.C PIPE SLOPE 1:570	---
16.	CATCH BASIN SIZE=500X450mm	---
17.	STORM WATER MANHOLE	---
18.	MAN HOLE SIZE=900mm DEPTH=910 TO 1670mm	---
19.	DEPTH=1680 TO 2290mm	---
20.	MAN HOLE SIZE=1520mm DEPTH=2300 TO 4500mm	---
21.	RAIN WATER HARVESTING	---